
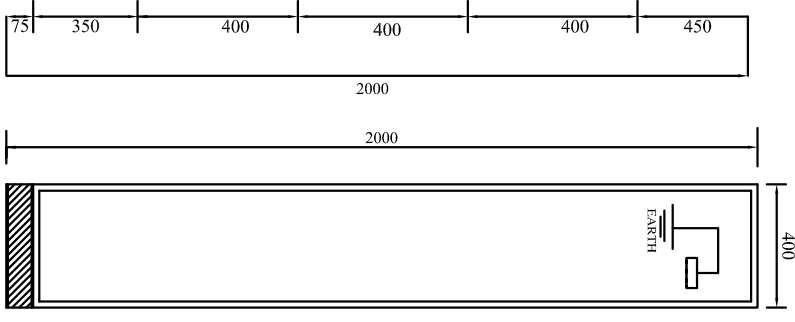
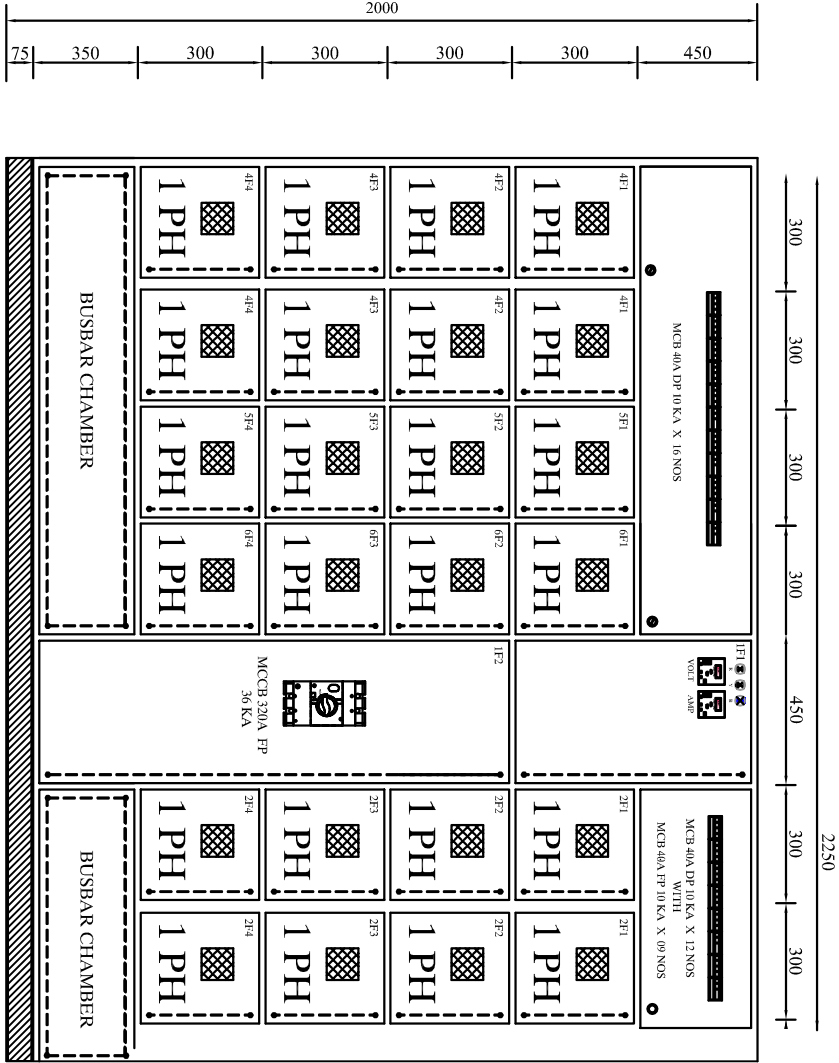


PANEL-24 NOS.

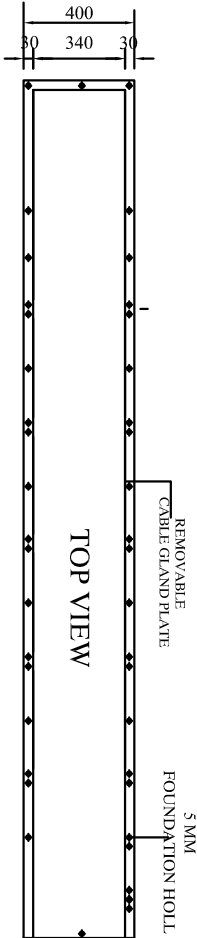

LEGEND:-	
SYMBOL	PARTICULARS
	SOFT STARTER
	VARIABLE FREQUENCY DRIVE
	AIR CIRCUIT BREAKER
	MCB,MCCB
	VIF METER
	METERING CT
	CAPACITOR
	CAPACITOR DUTY CONT.
	MANUAL C/O SWITCH

MEP CONSULTANT :-
cube consultant
A-8, PATH NO. 4, JAMUNA NAGAR,
SODALA, JAIPUR -302006
MAIL:- cubemeep@gmail.com
PH. NO. +91 141 2221089, 9214308430,

DEALT BY	REVISION	DATE: 21.07.2024
DWG NO		


TITLE:-
ALL DISTRUBUTION PANNEL
LAYOUT

SCALE:- 1= 100	DATE:
----------------	-------


PROJECT:-
PROPOSED BUILDING AT PLOT NO. 51,
RAJLAXMI ENCLAVE-X, MANPUR DEVRI
GOLIAWAS,TEH SANANGER,JAIPUR

OWNER:-
ASKG HOMES
Mr. Suresh Kumar Praewal(PARTNER)


MAIN PANEL

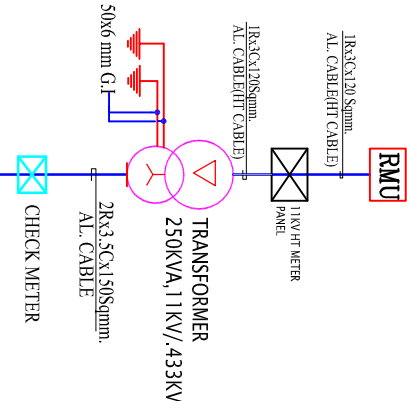

24 NOS. METER PANEL

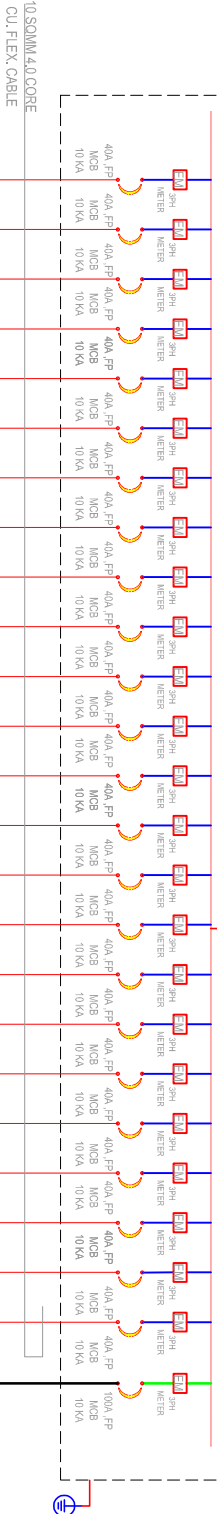


COMMON LIGHT PANEL

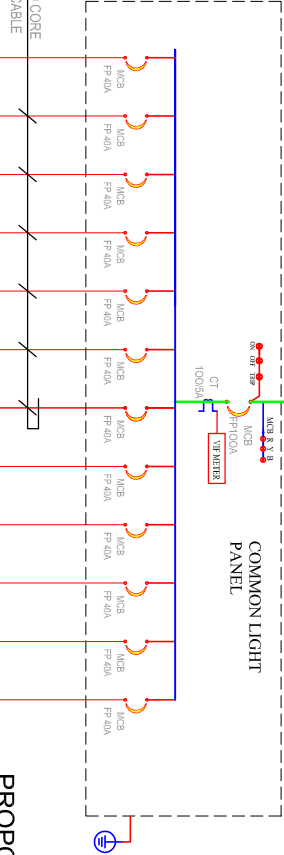

PROPOSED SLD LAYOUT (SINGLE LINE DIAGRAM)

LEGEND:-	
SYMBOL	PARTICULARS
SOFT STARTER	
VARIABLE FREQUENCY DRIVE	
AIR CIRCUIT BREAKER	
MCB/MCCB	
VFI METER	
METERING CT	
CAPACITOR	
CAPACITOR DUTY CONT.	
MANUAL CO SWITCH	

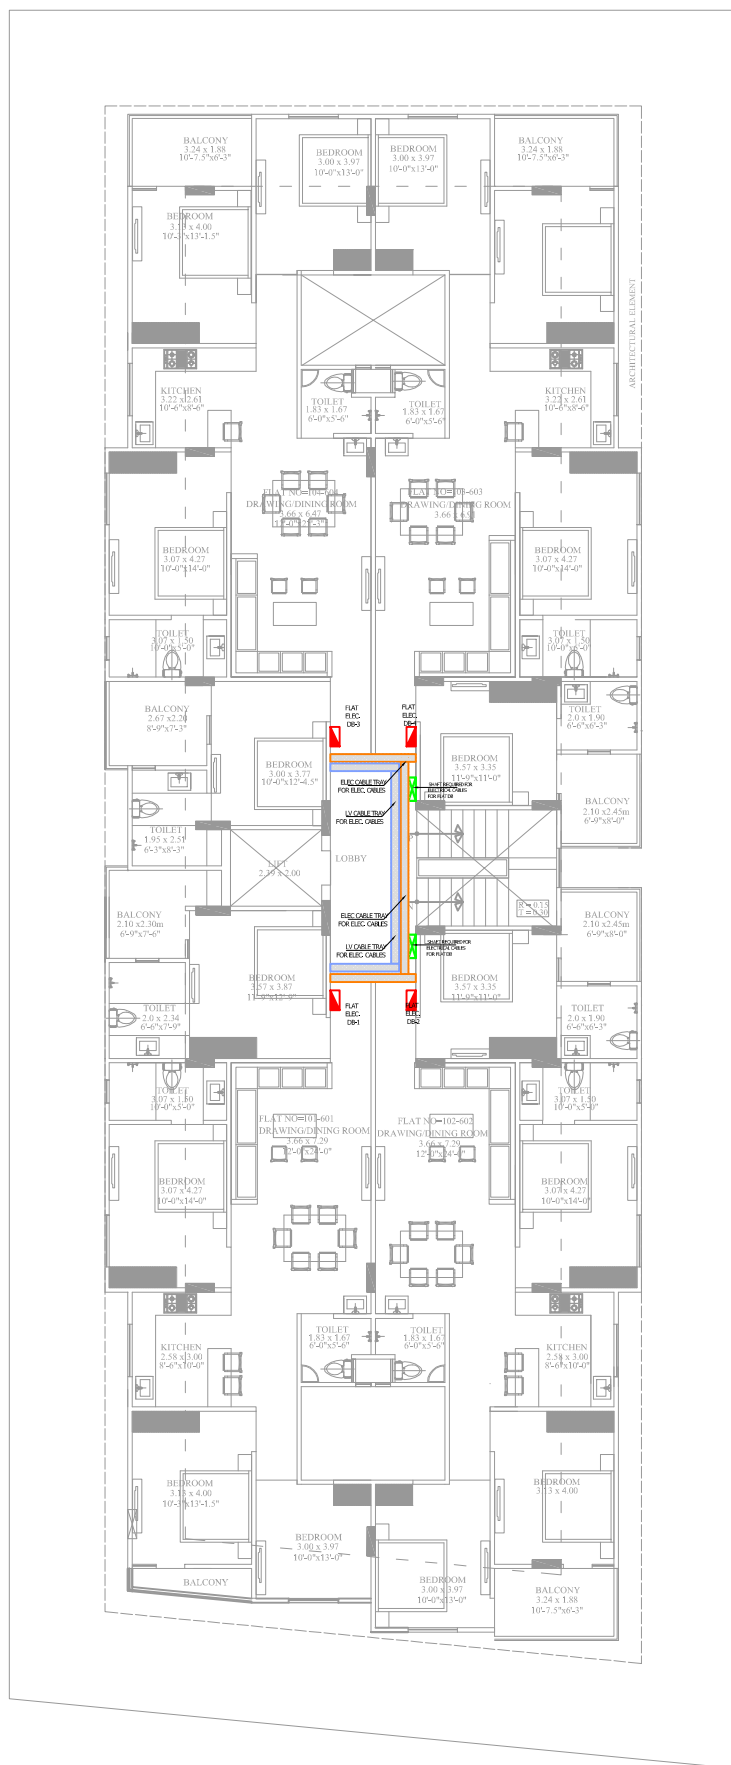

PROPOSED GROUND FLOOR 1st TO 5th FLOOR ELECTRICAL CABLE ROUTE LAYOUT



For ASKG HOMES
Edmund
PARTNER

Aman Gupta
M.E.P. Consultant
D.E. Electrical

PRODUCED BY AN AUTODESK EDUCATIONAL PRODUCT

THIS DRAWING IS THE SOLE PROPERTY OF
M/S AKRITI AYOJAN AND IS NOT TO BE COPIED,
USED OR REPRODUCED FOR ANY PURPOSE
OTHER THAN FOR WHICH IT HAS BEEN LOANED

LEGEND

SYMBOL	DESCRIPTION
	SWITCH SOCKET (BA SOCKET & SWITCHES)
	2BA SOCKET WITH SWITCH
	BA POWER SOCKET WITH SWITCH
	CAMERA
	SPOT AC
	CONVERTER POINT
	TARGET HORIZONTAL LIGHT
	WALL FAN
	CEILING LIGHT
	FIBER LIGHT
	WALL BRACKET LED LIGHT
	1 x 1/4 W MIRROR LIGHT
	180 / 120MM RING COILING FAN
	1 x 1/4 W TILED COILING LIGHT
	1 x 7/2 W CHANDELIER LIGHT
	2 x 5/8 CIRCULAR FLOOR LIGHT
	8/55 W FANREGULATED, SWITCH (RHT 24V)
	8A SS 25A
	8A SS 25A
	8A SS 25A SOCKET + 10A 10A SWITCH, 10A COILAR SOCKET (RHT 24V)
	10A SS FOR OSER & BA SS FOR NO RHT 24V
	10A SS FOR MEDICINE & BA SS FOR RHT 24V RHT 24V
	8A SS FOR CHIRREVENT 24V
	10A SS FOR FIBERLIGHT 540°
	3 x 1.5 SOHM LIGHT CONTROL CIR. MIRE
	3 x 1.5 SOHM 2 WAY LIGHT CONTROL CIR.
	3 x 1.5 SOHM CIR. MIRE FOR AC CIR.
	3 x 1.5 SOHM CIR. MIRE FOR LIGHT CIRCUIT
	3 x 1.5 SOHM CIR. MIRE FOR POWER CIRCUIT
	CAT 6 LAN HIRE RJ45 JACK TO LAN SWITCH
	CAT 6 TELEPHONE HIRE RJ45 JACK TO TV
	RGS TO CABLE STOP CIRCUIT TO 3x RJ45
	CAT 6/CTV CABLE 50 TV CAMERA TO TV

MEP CONSULTANT :-
 **cube consultant**
 A-8, PATH NO. 4, JAMUNA NAGAR,
 SODALA, JAIPUR-302006
 MAIL: - cube_mep@gmail.com
 PH. NO. +91 141 2221089, 9214308430

DEALT BY	REVISION	DATE: 23.07.2024
DWG NO.		

TITLE:-
PROPOSED GROUND FLOOR 1st TO 5th FLOOR
ELECTRICAL CABLE ROUTE LAYOUT

SCALE:- 1-100	DATE:-
---------------	--------

PROJECT:-	
-----------	--

PROPOSED BUILDING AT PLOT NO. 51,
RAJLAXMI ENCLAVE-X, MANPUR DEVT

OWNER-

ASKG HOMES

ARCHITECT

100 JOURNAL OF DOCUMENTATION, vol. 57, no. 1, 2002

M/S AKRITI AYOJAN

ARCHITECTS. INTERIOR DESIGNERS.

E-37 THIRD FLOOR, NAGLAM TOWER, 3024 SD
GOPALPURA, JAIPUR-05, RAJASTHAN 3351
saryaspeakash.arth@gmail.com;

1. *Journal of the American Medical Association*, 1997; 277: 1039-1043.

DATE:	NORTH :
-------	---------



1

d

THIS DRAWING IS THE SOLE PROPERTY OF M/S AKRITI AYOJAN AND IS NOT TO BE COPIED, USED OR REPRODUCED FOR ANY PURPOSE OTHER THAN FOR WHICH IT HAS BEEN LOANED.

LEGEND

SYMBOL	DESCRIPTION
	DISTRIBUTION BOX
	SWITCH BOXED (6A SOCKET & SWTCH ES)
	1.8 A SOCKET WITH SWITCH
	6A POWER SOCKET WITH SWITCH
	OTHER
	SPLIT AC
	COMPUTER POINT
	TOILET FLOOR LIGHT (100W)
	WALL FAN
	CEILING LIGHT
	TUBE LIGHT
	WALL BRACKET LED LIGHT
	1 x 14 W MIRROR LIGHT
	800 / 1200 MM SWEEP CEILING FAN
	4 x 11 W LED CEILING LIGHT
	1 x 72 W CHANDELIER LIGHT
	3 x 5 W CONCEALED FOOT LIGHT
	6A SS FAN REGULATOR / TL SWITCH (8HT 24"
	6A SS 25A MCB (8HT 24"
	6A 2 NOS. SOCKET + 1 NOS. 16A SWITCH, TV COWAN SOCKET (8HT 34"
	16A SS FOR DRYER & 6A SS FOR RD (8HT 54"
	16A SS FOR MICROWAVE & 6A SS FOR MIXER (8HT 34"
	6A SS FOR CHILLER (8HT 54"
	16A SS FOR FRIDGE (8HT 54"
	3 x 1.5 SQMM LIGHT CONTROL CU. WIRE
	3 x 1.5 SQMM 2 WAY LIGHT CONTROL WIRE
	3 x 2.5 SQMM CU. WIRE FOR AC/DU
	3 x 4.0 SQMM CU. WIRE FOR POWER CIRCUIT
	3 x 2.5 SQMM CU. WIRE FOR LIGHT CIRCUIT
	CAT-6 LAN WIRE RJ-45 JACK TO LAN SWITCH
	CAT-6 TELEPHONE WIRE RJ-11 JACK TO TTB
	RG-6 TV CABLE SETUP BOX TO TV SPLITTER
	CAT-6 CCTV CABLE CAMERA TO NVR

MEP CONSULTANT -
cube consultant
A-8, PATH NO. 4, JAMUNA NAGAR,
SODALA, JAIPUR-302006
MAIL: - cubeconsultant@gmail.com
PH. NO. +91 141 2221089, 9214308430.

DRAWN BY: REVISION: DATE: 23.07.2024

DWG NO

TITLE:-
PROPOSED TYPICAL FLOOR
HAVC LAYOUT

SCALE:- 1=100

DATE:

PROJECT:-

PROPOSED BUILDING AT PLOT NO. 51,
RAILAXMI ENCLAVE-K, JAMNAPUR DEVTRI
GOLLAWASTH SANGANER,JAIPUR

OWNER:-

ASIG HOMES
Mr. Surish Kumar Prasad(PARTNER)

ARCHITECT

 
M/S AKRITI AYOJAN

ARCHITECTS, INTERIOR DESIGNERS.

E-47, THIRD FLOOR, MANGLAM TOWER, JODHSI ROAD,
GOPALPUR, JAIPUR, RAJASTHAN. 3020154101
ayojan@akritiayojan.com

DATE:

NORTH :




GROUND, 1st TO 5th FLOOR PLAN

PROPOSED TYPICAL FLOOR
HAVC LAYOUT

For ASKG HOMES
Partner
PARTNER



Aman Gupta
M.E.P. Consultant
S.E. Electrical

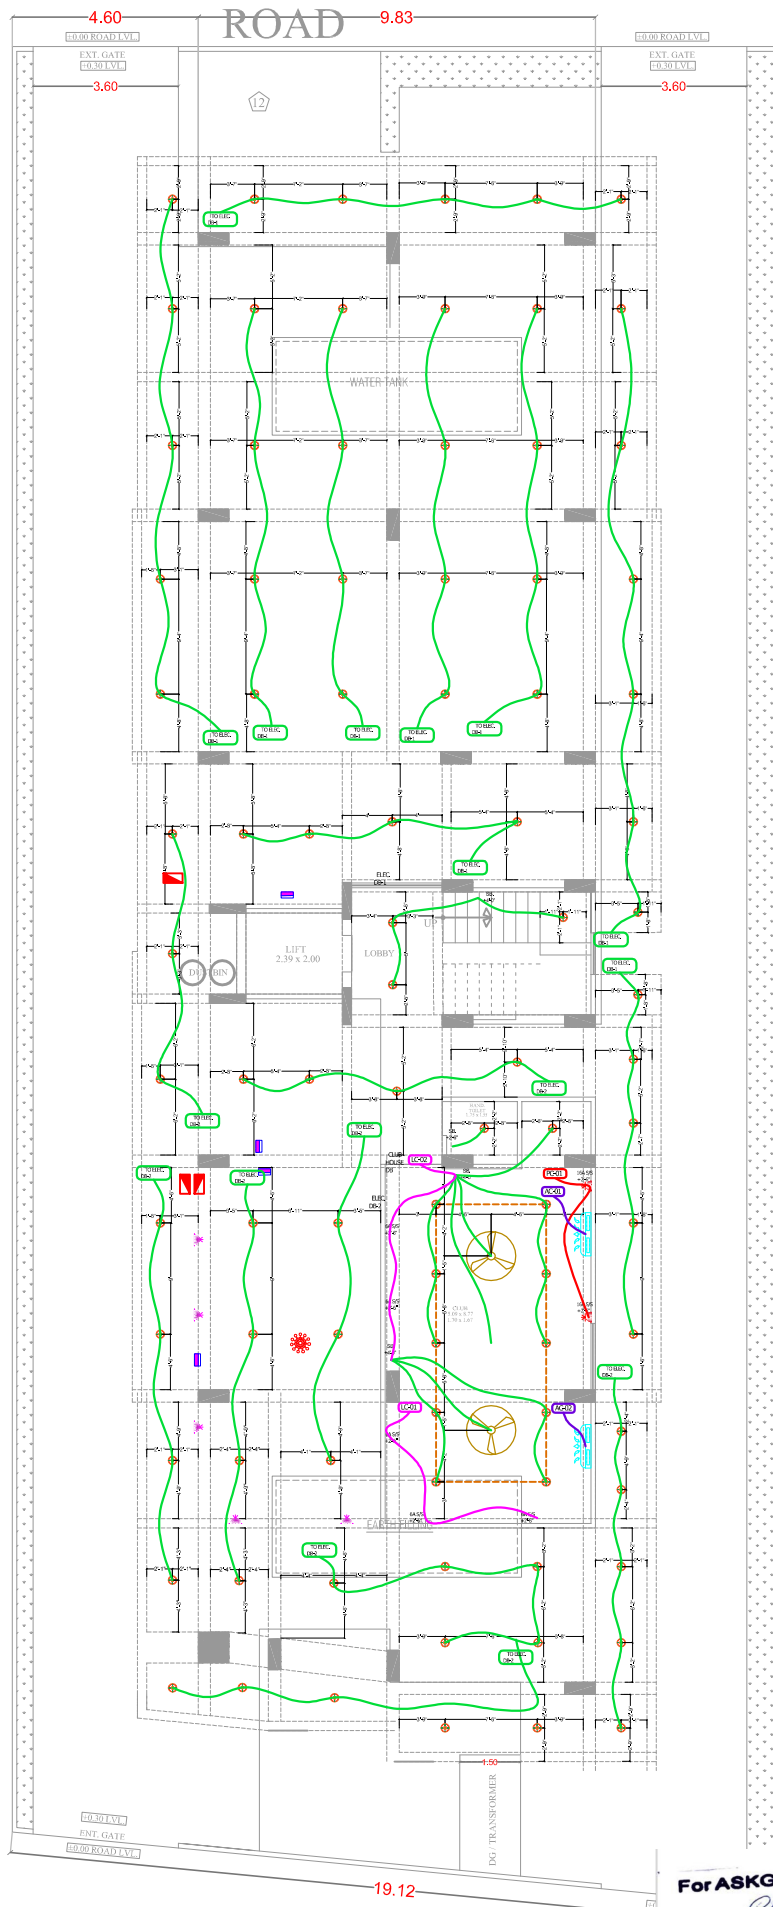

PROPOSED STILT FLOOR
ELECTRICAL LAYOUT

THIS DRAWING IS THE SOLE PROPERTY OF
M/S AKRITI AYOJAN AND IS NOT TO BE COPIED,
USED OR REPRODUCED FOR ANY PURPOSE
OTHER THAN FOR WHICH IT HAS BEEN LOANED.

LEGEND

SYMBOL	DESCRIPTION
	SWITCH (BROKE OR SOCKET & SWITCHES)
	16 A SOCKET WITH SWITCH
	6A POWER SOCKET WITH SWITCH
	CAMERA
	SPLIT AC
	COMPUTER POINT
	TOILET MIRROR LIGHT (WALL)
	WALL FAN
	CEILING LIGHT
	TUBE LIGHT
	WALL BRACKET LED LIGHT
	1 x 14 W MIRROR LIGHT
	800 / 1200 MM SWEEP CEILING FAN
	1 x 11 W LED CEILING LIGHT
	1 x 22 W CHANDELIER LIGHT
	2 x 5 W CONCEALED POINT LIGHT
	6A 55 FAN REGULATOR, 1 SWITCH @ HT 2-2"
	6A 55 25 A/C @ HT 2-2"
	6A 2 NOS. SOCKET + 1 NOS. 16A SWITCH, TV CORDIAL SOCKET @ HT 2-2"
	16A 5/5 FOR CYSER & 6A 5/5 FOR RD @ HT 5-4"
	16A 5/5 FOR MICROWAVE & 6A 5/5 FOR MDR @ HT 5-4"
	6A 5/5 FOR CHIMNEY @ HT 5-4"
	16A 5/5 FOR FRIDGE @ HT 5-4"
	3 x 1.5 SQMM LIGHT CONTROL CUL WIRE
	3 x 1.5 SQMM 2 WAY LIGHT CONTROL WIRE
	3 x 2.5 SQMM CUL WIRE FOR ACB
	3 x 4.0 SQMM CUL WIRE FOR POWER CIRCUIT
	3 x 2.5 SQMM CUL WIRE FOR LIGHT CIRCUIT
	CAT-6 LAN WIRE RJ-45 JACK TO LAN SWITCH
	CAT-6 TELEPHONE WIRE RJ-11 JACK TO TTB
	RG-6 TV CABLE SETUP BOX TO TV SPLITTER
	CAT-6 CCTV CABLE CAMERA TO DVR

PREPARED BY: **cube consultant**
S.S. PATHI NO. 4, JAMUNA NAGAR,
SODALA, JAIPUR-302006
MAIL: - cubepath@gmail.com
PH. NO. - 991 141 2221089, 9214368430.

DRAWN BY: _____ REVISION: _____ DATE: 13.07.2024
DWG NO: _____

TITLE:-
**PROPOSED STILT FLOOR
ELECTRICAL LAYOUT**

SCALE:- 1= 100 DATE: _____

PROJECT:-
PROPOSED BUILDING AT PLOT NO. 51,
B-1/1, 5TH FLOOR, JALPETH, MANPUR (B-1/1)
GOLIAWAS, TEH SANGANER, JAIPUR

OWNER:-
ASRG HOMES
M. Suresh Kumar Prasad (PARTNER)

ARCHITECT


M/S AKRITI AYOJAN
ARCHITECTS, INTERIOR DESIGNERS,
E-67, THIRD FLOOR, BANGALAN TOWER, JRDH BLDG,
COMPLEX, JAIPUR, RAJASTHAN - 302001
suryaprakash.arch@gmail.com

DATE: _____ NORTH: _____



For ASKG HOMES
Partner
PARTNER

Amar Gupta
M.E.P. Consultant
M.E. Electrical

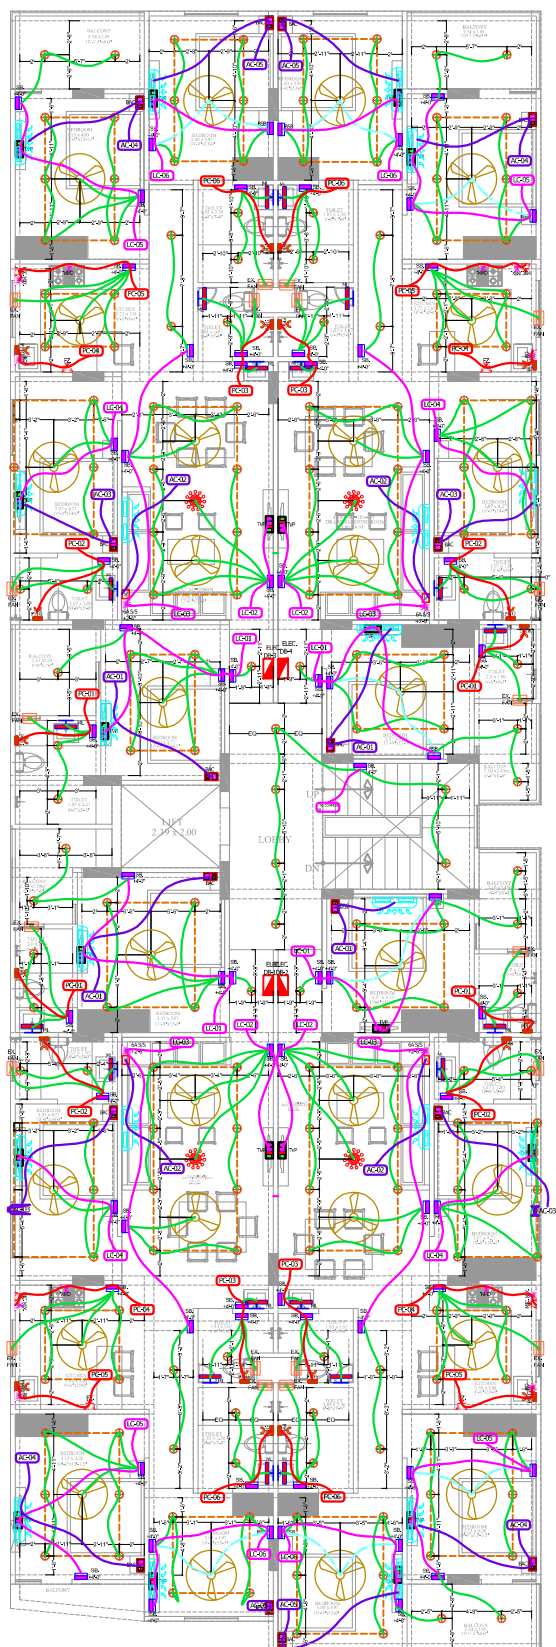

PROPOSED TYPICAL FLOOR
ELECTRICAL LAYOUT
GROUND, 1st TO 5th FLOOR PLAN

For ASKG HOMES
Partner
PARTNER



Aman Gupta
M.E.P. Consultant
M.E. Electrical

THIS DRAWING IS THE SOLE PROPERTY OF
M/S AKRITI AYOJAN AND IS NOT TO BE COPIED,
USED OR REPRODUCED FOR ANY PURPOSE
OTHER THAN FOR WHICH IT HAS BEEN LOANED.

LEGEND

SYMBOL	DESCRIPTION
	DISTRIBUTION BOX
	SWITCH BOARD (6A SOCKET & SWITCHES)
	16 A SOCKET WITH SWITCH
	6A POWER SOCKET WITH SWITCH
	CAMERA
	SPLIT AC
	COMPUTER POINT
	TOILET MIRROR LIGHT (1x10W)
	WALL FAN
	CEILING LIGHT
	TUBE LIGHT
	WALL BRACKET LED LIGHT
	1x 14 W MIRROR LIGHT
	900x1200 MM SWEEP CEILING FAN
	1x 11 W LED CEILING LIGHT
	1x 72 W CHANDELIER LIGHT
	3x 5 W CONTAINED FOOT LIGHT
	BASS FAN REGULATOR TL SWITCH @ HT 54
	BAC 25A AC @ HT 24
	6A 2 NOS. SOCKET + 1 NOS. 16A SWITCH TL CONTROL SOCKET @ HT 34
	16A S/S FOR GYSEB & 6A S/S FOR RO @ HT 54
	16A S/S FOR MICROWAVE & 6A S/S FOR MIXER @ HT 34
	6A S/S FOR CHILLER @ HT 34
	16A S/S FOR FREEZER @ HT 34
	3x 1.5 SOMM LIGHT CONTROL CU WIRE
	3x 1.5 SOMM 2 WAY LIGHT CONTROL WIRE
	3x 2.5 SOMM CU WIRE FOR AC BU
	3x 4.0 SOMM CU WIRE FOR POWER CIRCUIT
	3x 2.5 SOMM CU WIRE FOR LIGHT CIRCUIT
	CAT-6 LAN WIRE RJ-45 JACK TO LAN SWITCH
	CAT-6 TELEPHONE WIRE RJ-11 JACK TO TTS
	RG-6 TV CABLE SETUP BOX TO TV SPLITTER
	CAT-6 CCTV CABLE CCTV CAMERA TO NVR

MEP CONSULTANT -
cubo consultant
A-5, PATH NO. 4, JAMUNA NAGAR,
SODALA, JAIPUR-302006
MAIL - cuboconsult@gmail.com
PH. NO. +91 141 2221089, 9214308430,

DEALT BY	REVISION	DATE: 23.07.2024
DWG NO		

TITLE:-
**PROPOSED TYPICAL FLOOR
ELECTRICAL LAYOUT**

SCALE:- (1=100) DATE:

PROJECT:-

PROPOSED BUILDING AT PLOT NO. 51,
RAJLAASHI ENCLAVE-X, MANIPUR DEV'N
GOLIAWAS, TEH SANGANER, JAIPUR.

OWNER:-

ASKG HOMES
Mr. Sunish Kumar Prasad (PARTNER)

ARCHITECT

M/S AKRITI AYOJAN

ARCHITECTS, INTERIOR DESIGNERS,
E-47, THIRD FLOOR, MANGLAM TOWER, JRDH BETA,
GOPALPURA, JAIPUR-302018, RAJASTHAN
www.akritiayojan.com 9301154101

DATE: NORTH :

