




Aman Gupta
M.E.P. Consultant
S.E. Electrical

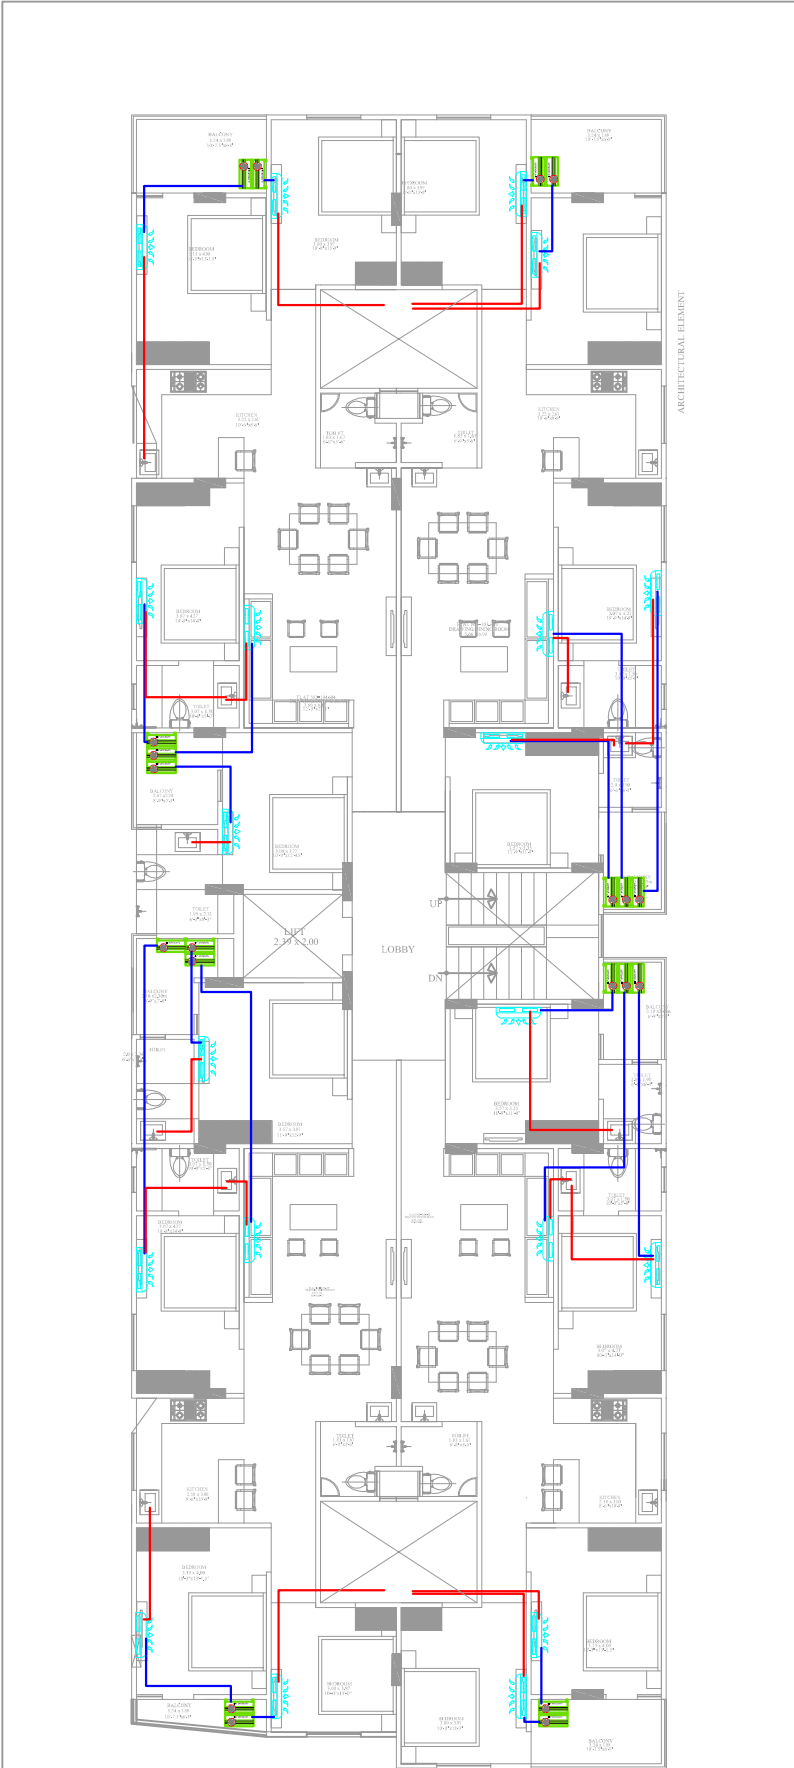

GROUND, 1st TO 5th FLOOR PLAN

PROPOSED TYPICAL FLOOR HAVC LAYOUT



For ASKG HOMES
PARTNER

Aman Gupta
M.E.P. Consultant
S.E. Electrical

THIS DRAWING IS THE SOLE PROPERTY OF
M/S AKRITI AYOJAN AND IS NOT TO BE COPIED,
USED OR REPRODUCED FOR ANY PURPOSE
OTHER THAN FOR WHICH IT HAS BEEN LOANED.

LEGEND

SYMBOL	DESCRIPTION
	COMPARTMENT BOX
	SWITCH BOARD (6A SOCKET & SW TO ES)
	1.6 A SOCKET WITH SWITCH
	6A POWER SOCKET WITH SWITCH
	OTHER
	BUILT AC
	COMPUTER POINT
	TILESET FLOOR LIGHT (100mm)
	WALL FAN
	CEILING LIGHT
	TUBE LIGHT
	WALL BRACKET LED LIGHT
	1 x 14 W MIRROR LIGHT
	800 / 1200 MM SWEEP CEILING FAN
	4 x 11 W LED CEILING LIGHT
	1 x 72 W CHANDELIER LIGHT
	3 x 5 W CONCEALED FOOT LIGHT
	6A SS FAN REGULATOR / SWITCH (HT 24"
	6A SS 25A MC (HT 24"
	6A 2 NOS. SOCKET + 1 NOS. 16A SWITCH, TV COWAN SOCKET (HT 24"
	16A SS FOR CYBER & 6A SS FOR RD (HT 24"
	16A SS FOR MICROWAVE & 6A SS FOR MDR (HT 24"
	6A SS FOR CHINESE (HT 24"
	16A SS FOR REFRIG (HT 24"
	3 x 1.5 SQMM LIGHT CONTROL CUL WIRE
	3 x 1.5 SQMM 2 WAY LIGHT CONTROL WIRE
	3 x 2.5 SQMM CUL WIRE FOR AC/DU
	3 x 4.0 SQMM CUL WIRE FOR POWER CIRCUIT
	3 x 2.5 SQMM CUL WIRE FOR LIGHT CIRCUIT
	CAT-6 LAN WIRE RJ-45 JACK TO LAN SWITCH
	CAT-6 TELEPHONE WIRE RJ-11 JACK TO TTB
	RS-485 TV CABLE SETUP BOX TO TV SPLITTER
	CAT-6 OCTV CABLE OCTV CAMERA TO DVR

MEP CONSULTANT -
cube consultant
A-8, PATH NO. 4, JAMUNA NAGAR,
SODALA, JAIPUR-302006
MAIL: - cubemepl@gmail.com
PH. NO. +91 141 2221089, 9214308430.

DRAWN BY: REVISION: DATE: 23.07.2024

DWG NO:

TITLE:-
PROPOSED TYPICAL FLOOR
HAVC LAYOUT

SCALE:- 1=100 DATE:

PROJECT:-
PROPOSED BUILDING AT PLOT NO. 51,
RAILAXMI ENCLAVE-K, JAMNAPUR DEVTRI
GOLIAWASTH SANGANER, JAIPUR


OWNER:-
ASKG HOMES
Mr. Surish Kumar Prasad (PARTNER)

ARCHITECT

M/S AKRITI AYOJAN
ARCHITECTS. INTERIOR DESIGNERS.
E-47, THIRD FLOOR, MANGLAM TOWER, JODHPUR,
GOPALPUR, JAIPUR, RAJASTHAN. 3020154101
www.akritiayojan.com

DATE: NORTH :



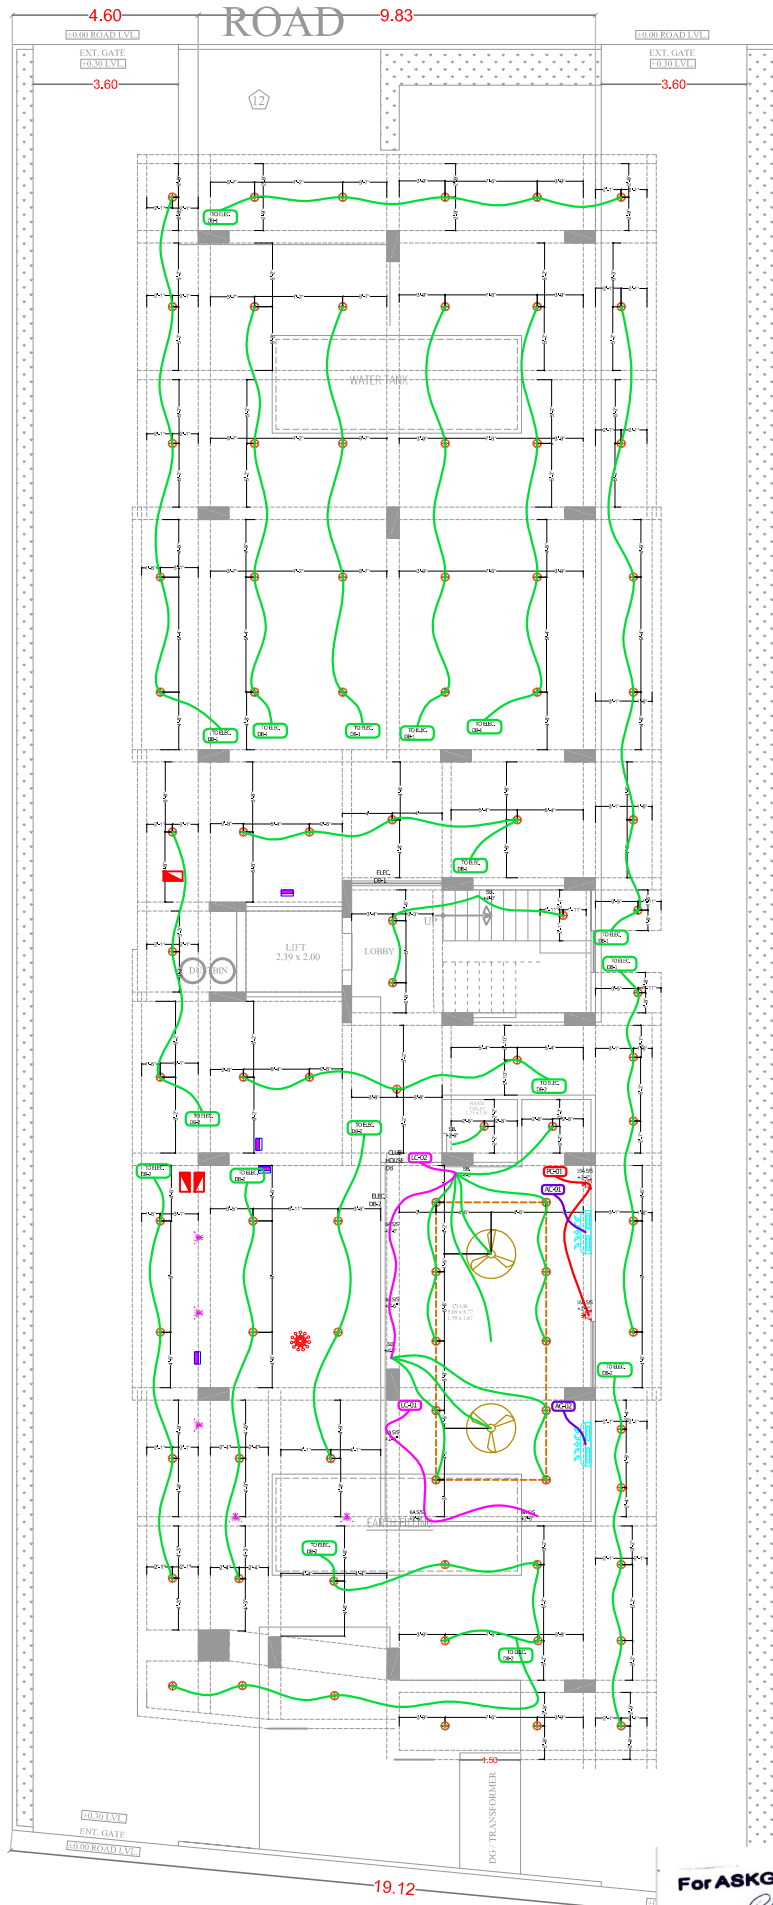

PROPOSED STILT FLOOR
ELECTRICAL LAYOUT

THIS DRAWING IS THE SOLE PROPERTY OF
M/S AKRITI AYOJAN AND IS NOT TO BE COPIED,
USED OR REPRODUCED FOR ANY PURPOSE
OTHER THAN FOR WHICH IT HAS BEEN LOANED.

LEGEND

SYMBOL	DESCRIPTION
	SWITCH (BROKE OR SOCKET & SWITCHES)
	16 A SOCKET WITH SWITCH
	6A POWER SOCKET WITH SWITCH
	CAMERA
	SPLIT AC
	COMPUTER POINT
	TOILET MIRROR LIGHT (WALL)
	WALL FAN
	CEILING LIGHT
	TUBE LIGHT
	WALL BRACKET LED LIGHT
	1 x 14 W MIRROR LIGHT
	800 / 1200 MM SWEEP CEILING FAN
	1 x 11 W LED CEILING LIGHT
	1 x 22 W CHANDELIER LIGHT
	2 x 5 W CONCEALED POINT LIGHT
	6A 5S FAN REGULATOR, 1L SWITCH @ HT 2-2"
	6A 5S 25 A/C @ HT 2-2"
	6A 2 NOS. SOCKET + 1 NOS. 16A SWITCH, TV CORDIAL SOCKET @ HT 2-2"
	16A 5S FOR CYSER & 6A 5S FOR RD @ HT 5-4"
	16A 5S FOR MICROWAVE & 6A 5S FOR MDR @ HT 5-4"
	6A 5S FOR CHIMNEY @ HT 5-4"
	16A 5S FOR FRIDGE @ HT 5-4"
	3 x 1.5 SQMM LIGHT CONTROL CUL WIRE
	3 x 1.5 SQMM 2 WAY LIGHT CONTROL WIRE
	3 x 2.5 SQMM CUL WIRE FOR AC/DU
	3 x 4.0 SQMM CUL WIRE FOR POWER CIRCUIT
	3 x 2.5 SQMM CUL WIRE FOR LIGHT CIRCUIT
	CAT-6 LAN WIRE RJ-45 JACK TO LAN SWITCH
	CAT-6 TELEPHONE WIRE RJ-11 JACK TO TTB
	RG-6 TV CABLE SETUP BOX TO TV SPLITTER
	CAT-6 CCTV CABLE CAMERA TO DVR

PREPARED BY: **cube consultant**
S.S. PATHI NO. 4, JAMUNA NAGAR,
SODALA, JAIPUR-302006
MAIL: - cubeprep@gmail.com
PH. NO. - 991 141 2221089, 9214368430.

DRAWN BY: REVISION: DATE: 13.07.2024
DWG NO:

TITLE:-
**PROPOSED STILT FLOOR
ELECTRICAL LAYOUT**

SCALE:- 1= 100 DATE:

PROJECT:-
PROPOSED BUILDING AT PLOT NO. 51,
B-1/1, SMT ENCLAVE-3, MANPUR (B-1/1)
GOLIAWAS, TEH SANGANER, JAIPUR

OWNER:-
ASRG HOMES
M. Suresh Kumar Prasad (PARTNER)

ARCHITECT


M/S AKRITI AYOJAN
ARCHITECTS, INTERIOR DESIGNERS,
E-67, THIRD FLOOR, BANGALAN TOWER, JRDH BLDG,
COMPLEX, JAIPUR, RAJASTHAN - 302001
suryaprakash.arch@gmail.com

DATE: NORTH :



For ASKG HOMES
Partner
PARTNER

Amar Gupta
M.E.P. Consultant
M.E. Electrical

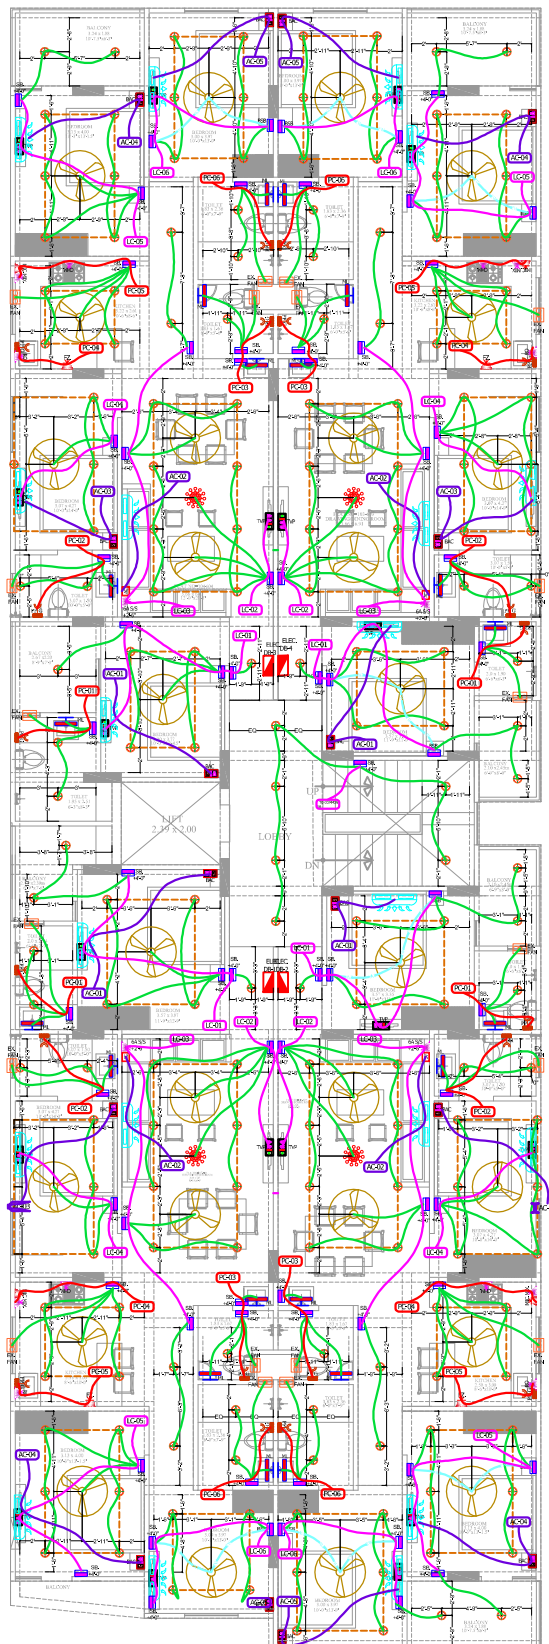

PROPOSED TYPICAL FLOOR
ELECTRICAL LAYOUT
GROUND, 1st TO 5th FLOOR PLAN

THIS DRAWING IS THE SOLE PROPERTY OF
M/S AKRITI AYOJAN AND IS NOT TO BE COPIED,
USED OR REPRODUCED FOR ANY PURPOSE
OTHER THAN FOR WHICH IT HAS BEEN LOANED.

LEGEND

SYMBOL	DESCRIPTION
	DISTRIBUTION BOX
	SWITCH BOARD (6A SOCKET & SWITCHES)
	16 A SOCKET WITH SWITCH
	6A POWER SOCKET WITH SWITCH
	CAMERA
	SPLIT AC
	COMPUTER POINT
	TOILET MIRROR LIGHT (1x1m)
	WALL FAN
	CEILING LIGHT
	TUBE LIGHT
	WALL BRACKET LED LIGHT
	1 x 14 W MIRROR LIGHT
	900x1200 MM SWEEP CEILING FAN
	1 x 11 W LED CEILING LIGHT
	1 x 72 W CHANDELIER LIGHT
	3 x 5 W CONTAINED ROOF LIGHT
	BASS FAN REGULATOR TL SWITCH @ HT 54"
	BAC 25 A AC @ HT 24"
	6A 2 NOS. SOCKET + 1 NOS. 16A SWITCH TL CONTROL SOCKET @ HT 34"
	16A S/S FOR GYSEB & 6A S/S FOR RO @ HT 54"
	16A S/S FOR MICROWAVE & 6A S/S FOR MIXER @ HT 34"
	6A S/S FOR CHILLER @ HT 54"
	16A S/S FOR FREEZER @ HT 54"
	3 x 1.5 SOMM LIGHT CONTROL CU WIRE
	3 x 1.5 SOMM 2 WAY LIGHT CONTROL WIRE
	3 x 2.5 SOMM CU WIRE FOR AC BU
	3 x 4.0 SOMM CU WIRE FOR POWER CIRCUIT
	3 x 2.5 SOMM CU WIRE FOR LIGHT CIRCUIT
	CAT-6 LAN WIRE RJ45 JACK TO LAN SWITCH
	CAT-6 TELEPHONE WIRE RJ-11 JACK TO TTS
	RG-6 TV CABLE SETUP BOX TO TV SPLITTER
	CAT-6 CCTV CABLE CCTV CAMERA TO NVR

MEP CONSULTANT -
cubo consultant
A-5, PATH NO. 4, JAMUNA NAGAR,
SODALA, JAIPUR-302006
MAIL - cuboconsult@gmail.com
PH. NO. +91 141 2221089, 9214308430,

DEALT BY: DIVISION: DATE: 23.07.2024
DWG NO:

TITLE:-
**PROPOSED TYPICAL FLOOR
ELECTRICAL LAYOUT**

SCALE:- (1=100) DATE:

PROJECT:-

PROPOSED BUILDING AT PLOT NO. 51,
RAJLAASHI ENCLAVE-X, MANIPUR DEV'N
GOLIAWAS, TEH SANGANER, JAIPUR

OWNER:-

AS/GH HOMES
Mr. Sunish Kumar Prasad (PARTNER)

ARCHITECT

M/S AKRITI AYOJAN

ARCHITECTS, INTERIOR DESIGNERS,
E-47, THIRD FLOOR, MANGLAM TOWER, JRDH BETA,
GOPALPURA, JAIPUR-302018
www.akritiayojan.com 9311154101

DATE: NORTH :



For ASKG HOMES
Partner
PARTNER



Aman Gupta
M.E.P. Consultant
M.E. Electrical