



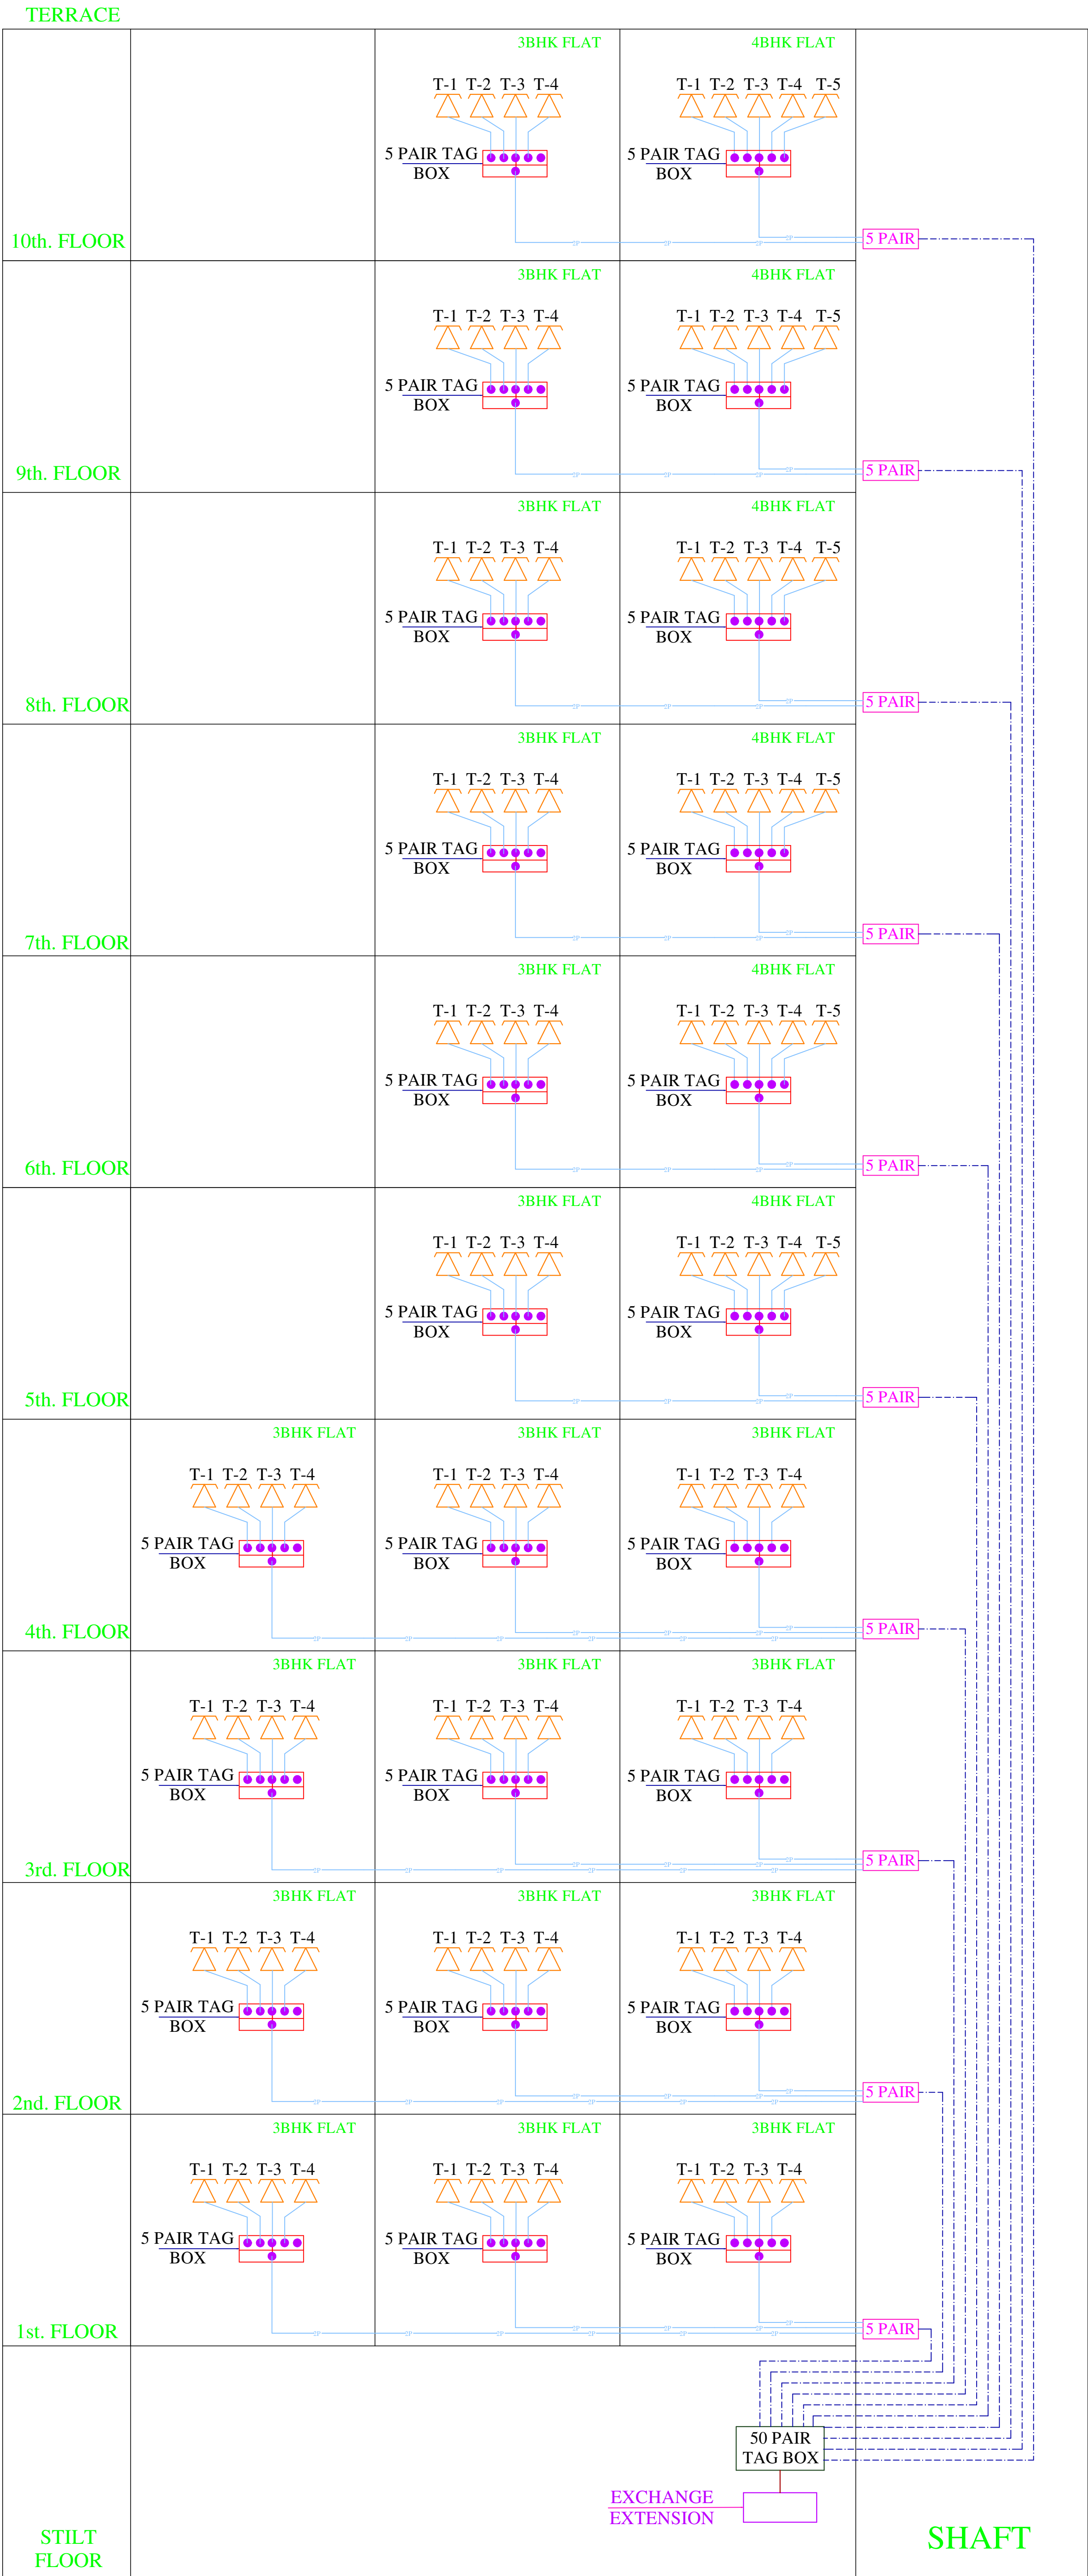


Vipul
VIPUL AGARWAL
M.E.P. CONSULTANT
B.E. ELECTRICAL

CODE	DESCRIPTION
	100 PAIR ARMoured CABLE
	50 PAIR ARMoured CABLE
	5 PAIR ARMoured CABLE
	2 PAIR UNARMoured CABLE
SERVICE CONSULTANT	
ASHI ASSOCIATES F 9 / 440 , Keshav Marg Chitrakut Scheme,Jaipur PH:91-0-93146-10438 ,0141-2440946, Mail:vipul8599@yahoo.com	
DEVELOPER NAME:- PEARL SPYTECH REALTORS LLP	
PROJECT NAME:- PEARL PRISTINE	
ADDRESS:- PLOT NO. B-173 RAJENDRA MARG, BAPU NAGAR, JAIPUR	
DRG. TITLE:- TELEPHONE SINGLE LINE DIAGRAM	
SCALE = 1:100	

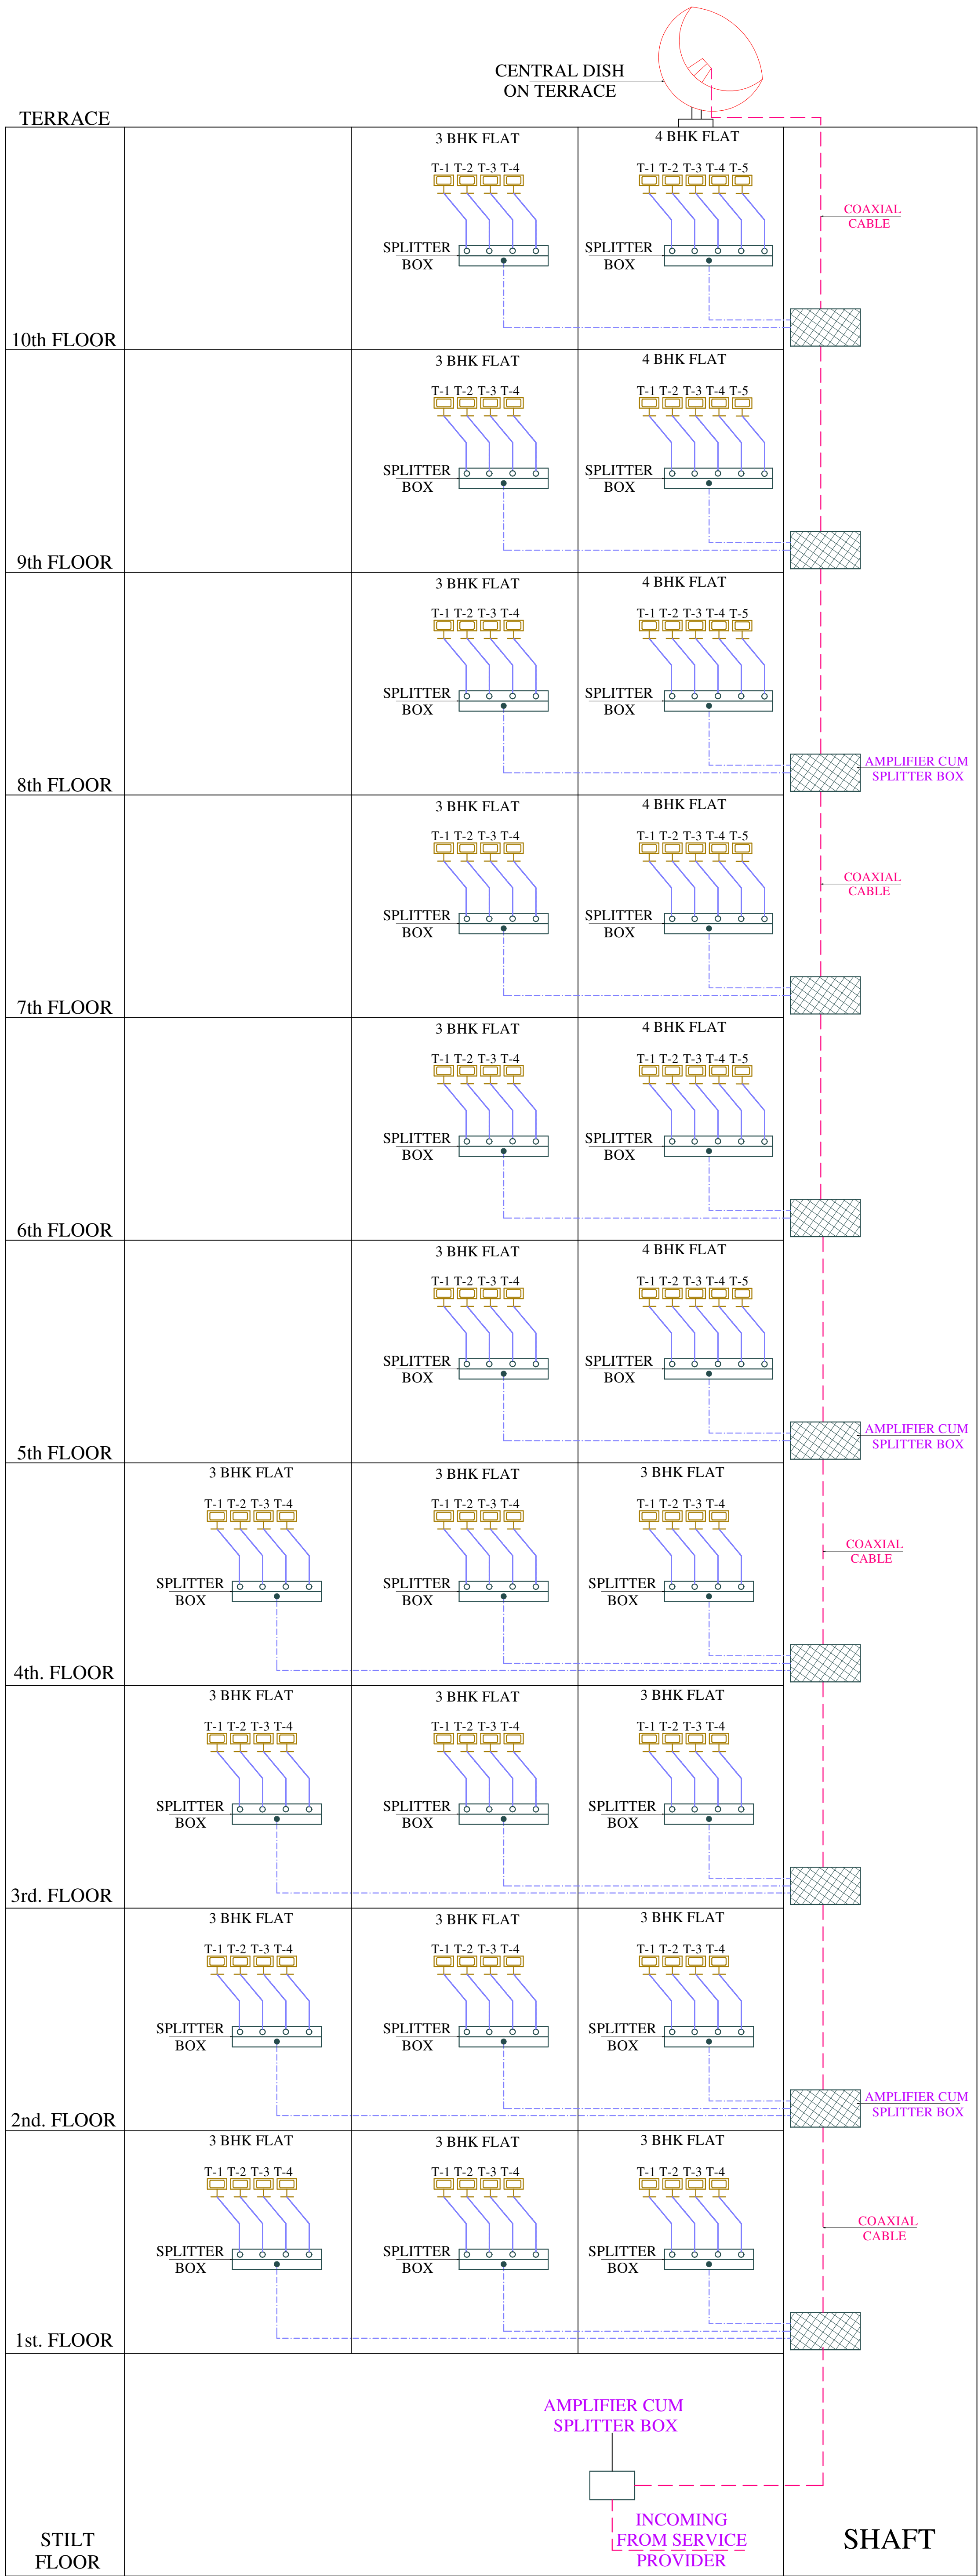

 Vipul
VIPUL AGARWAL
M.E.P. CONSULTANT
B.E. ELECTRICAL

SR.N	CODE	DESCRIPTION
01		COAXIAL CABLE
02		RG-6 COAXIAL CABLE
03		SPLITTER BOX
04		AMPLIFIER CUM SPLITTER BOX

SERVICE CONSULTANT

ASHI ASSOCIATES

F 9 / 440 , Keshav Marg Chitrakut Scheme,Jaipur
PH:91-0-93146-10438 ,0141-2440946, Mail:vipul8599@yahoo.com

DEVELOPER NAME:-

**PEARL SPYTECH
REALTORS LLP**

PROJECT NAME:-

PEARL PRISTINE


ADDRESS:-


**PLOT NO. B-173
RAJENDRA MARG,
BAPU NAGAR, JAIPUR**

DRG. TITLE:-

**TYPICAL
TV SINGLE LINE DIAGRAM**



SCALE = 1:100

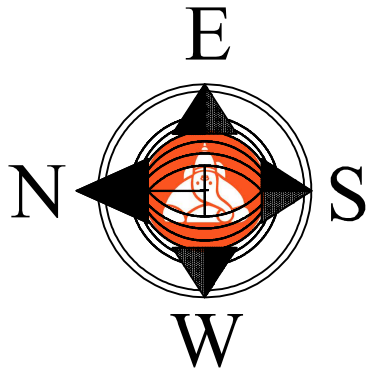

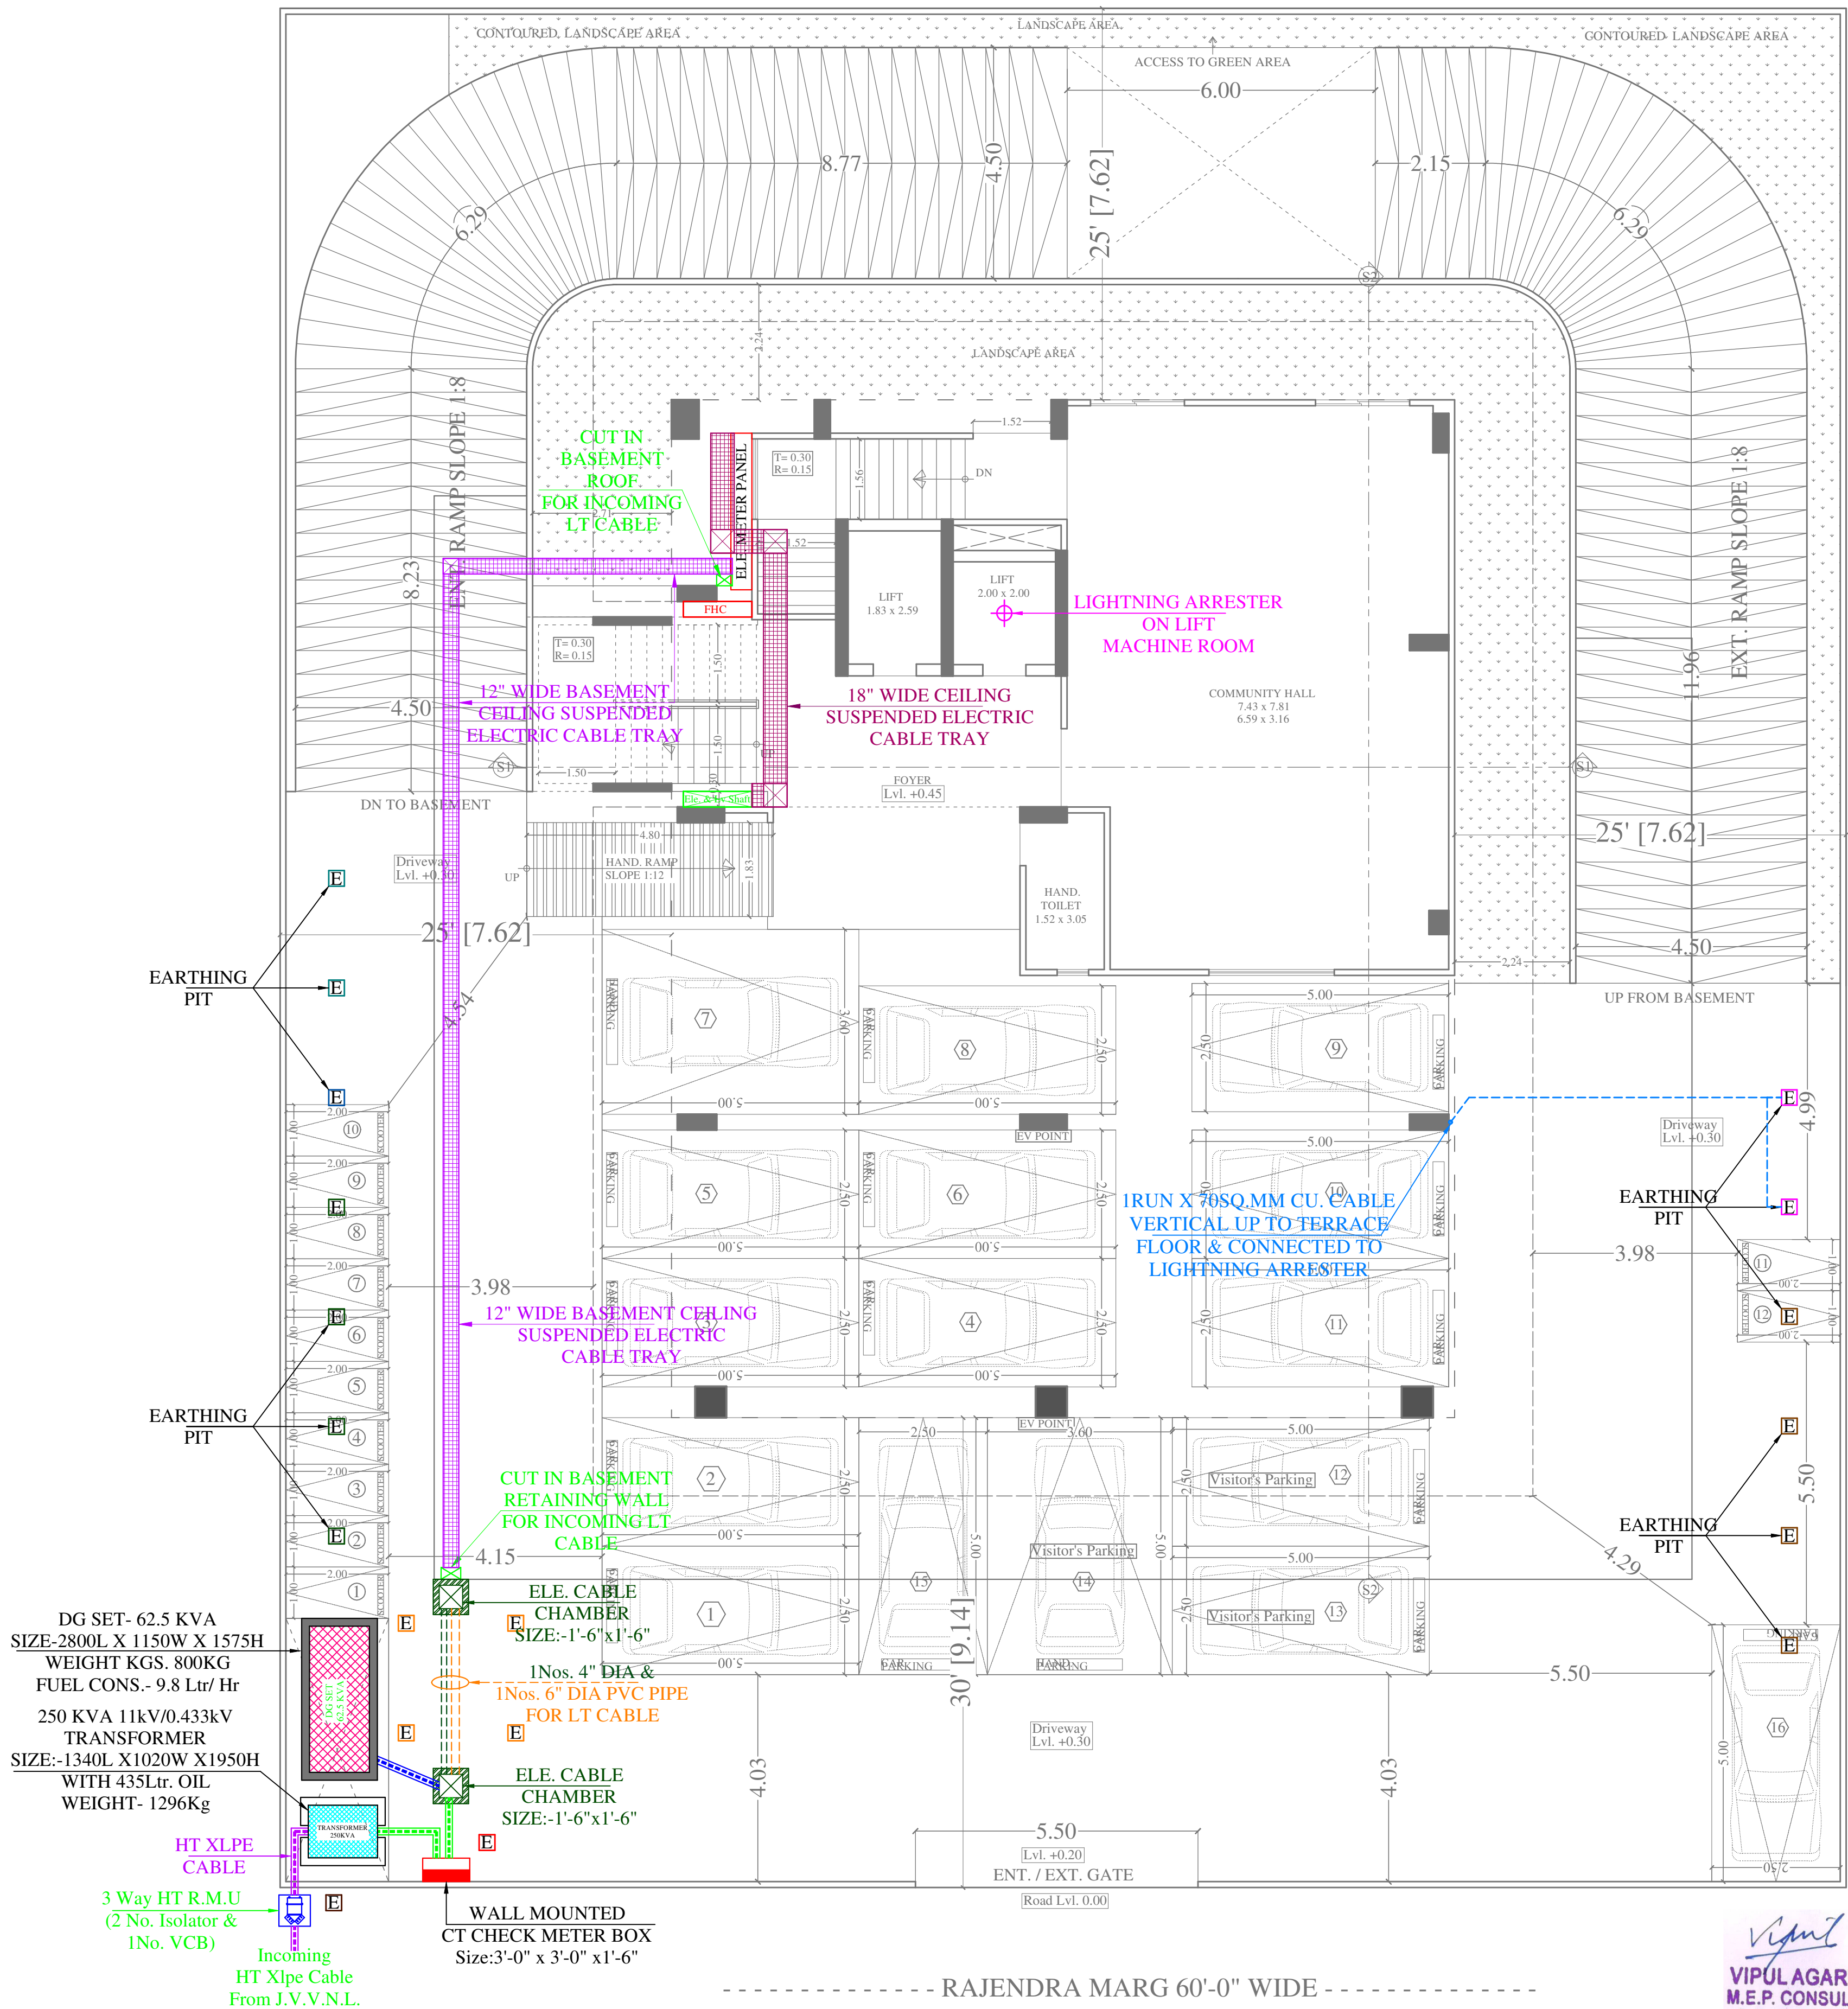

Lightning
Arrester

Model: Stormaster –
ESE - 30 (Level
2/Medium Protection)
(Protection radius - 25M,
Mast Height -2 Mtr)

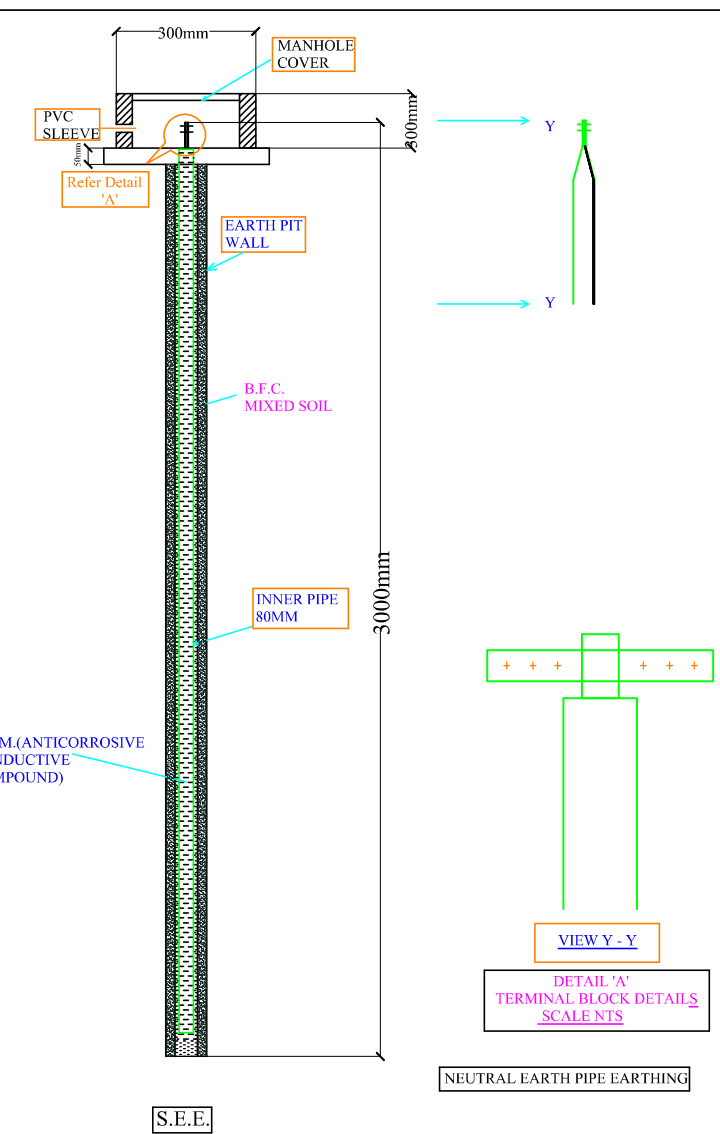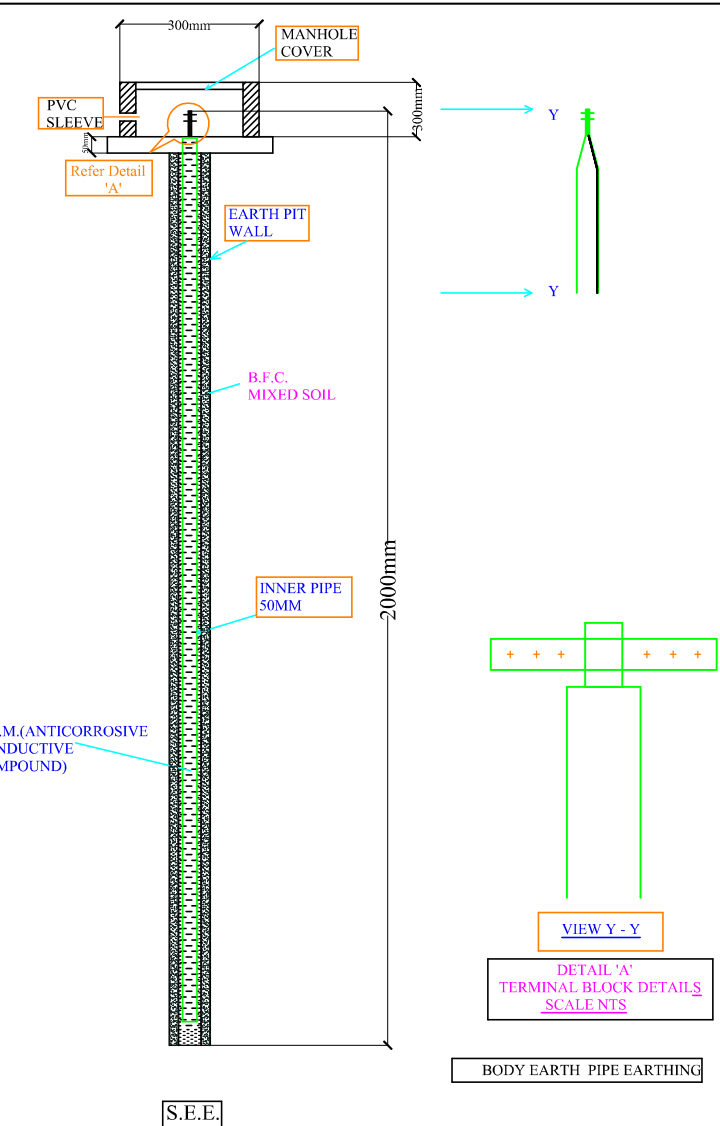

EARTHING DETAILS

01	50MM PIPE(2METER)	3WAY HT RMU BODY EARTH
01	50MM PIPE(2METER)	CT CHECK METER BOX BODY EARTH
02	50MM PIPE(2METER)	TRANSFORMER BODY EARTH
02	80MM PIPE(3METER)	TRANSFORMER NEUTRAL EARTH
02	50MM PIPE(2METER)	DG SET BODY EARTH
02	80MM PIPE(3METER)	DG SET NEUTRAL EARTH
02	50MM PIPE(2METER)	LIGHTNING ARRESTER BODY EARTH
02	50MM PIPE(2METER)	ELECTRIC PANEL BODY EARTH
01	50MM PIPE(2METER)	TELEPHONE EXCH. BODY EARTH
04	50MM PIPE(2METER)	LIFT PANEL BODY EARTH

NOTES:
1. ALL NEUTRAL EARTHS TO BE CONNECTED 50 X 3
GI EARTH STRIP FROM EARTH PIT TO EQUIPMENT.
2. ALL BODY EARTHS TO BE CONNECTED
25 X 3 GI EARTH STRIP FROM EARTH PIT TO
EQUIPMENT.

SERVICE CONSULTANT

ASHI ASSOCIATES

F 9 / 440 , Keshav Marg Chitrakut Scheme,Jaipur
PH:91-0-93146-10438 ,0141-2440946,
Mail:vipul8599@yahoo.com

DEVELOPER NAME:-

PEARL SPYTECH
REALTORS LLP

PROJECT NAME:-


PEARL
PRISTINE

ADDRESS:-

PLOT NO. B-173
RAJENDRA MARG,
BAPU NAGAR, JAIPUR

DRG. TITLE:-

STILT FLOOR ELE. SUB-
STATION, CABLE
ROUTE & LIGHTNING
ARRESTER PLAN

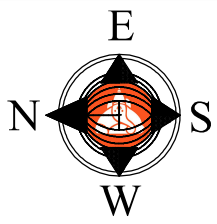


SCALE = 1:100

ARCHITECT :-

SPACE GRID

C-49, VIDYA
APARTMENT, PARAS MARG,
BAPU NAGAR, NEAR JANTA
STORE CIRCLE, JAIPUR-302015
PH-09314918766, 0141-4005506 (O)
Email: info.spacegrid@gmail.com

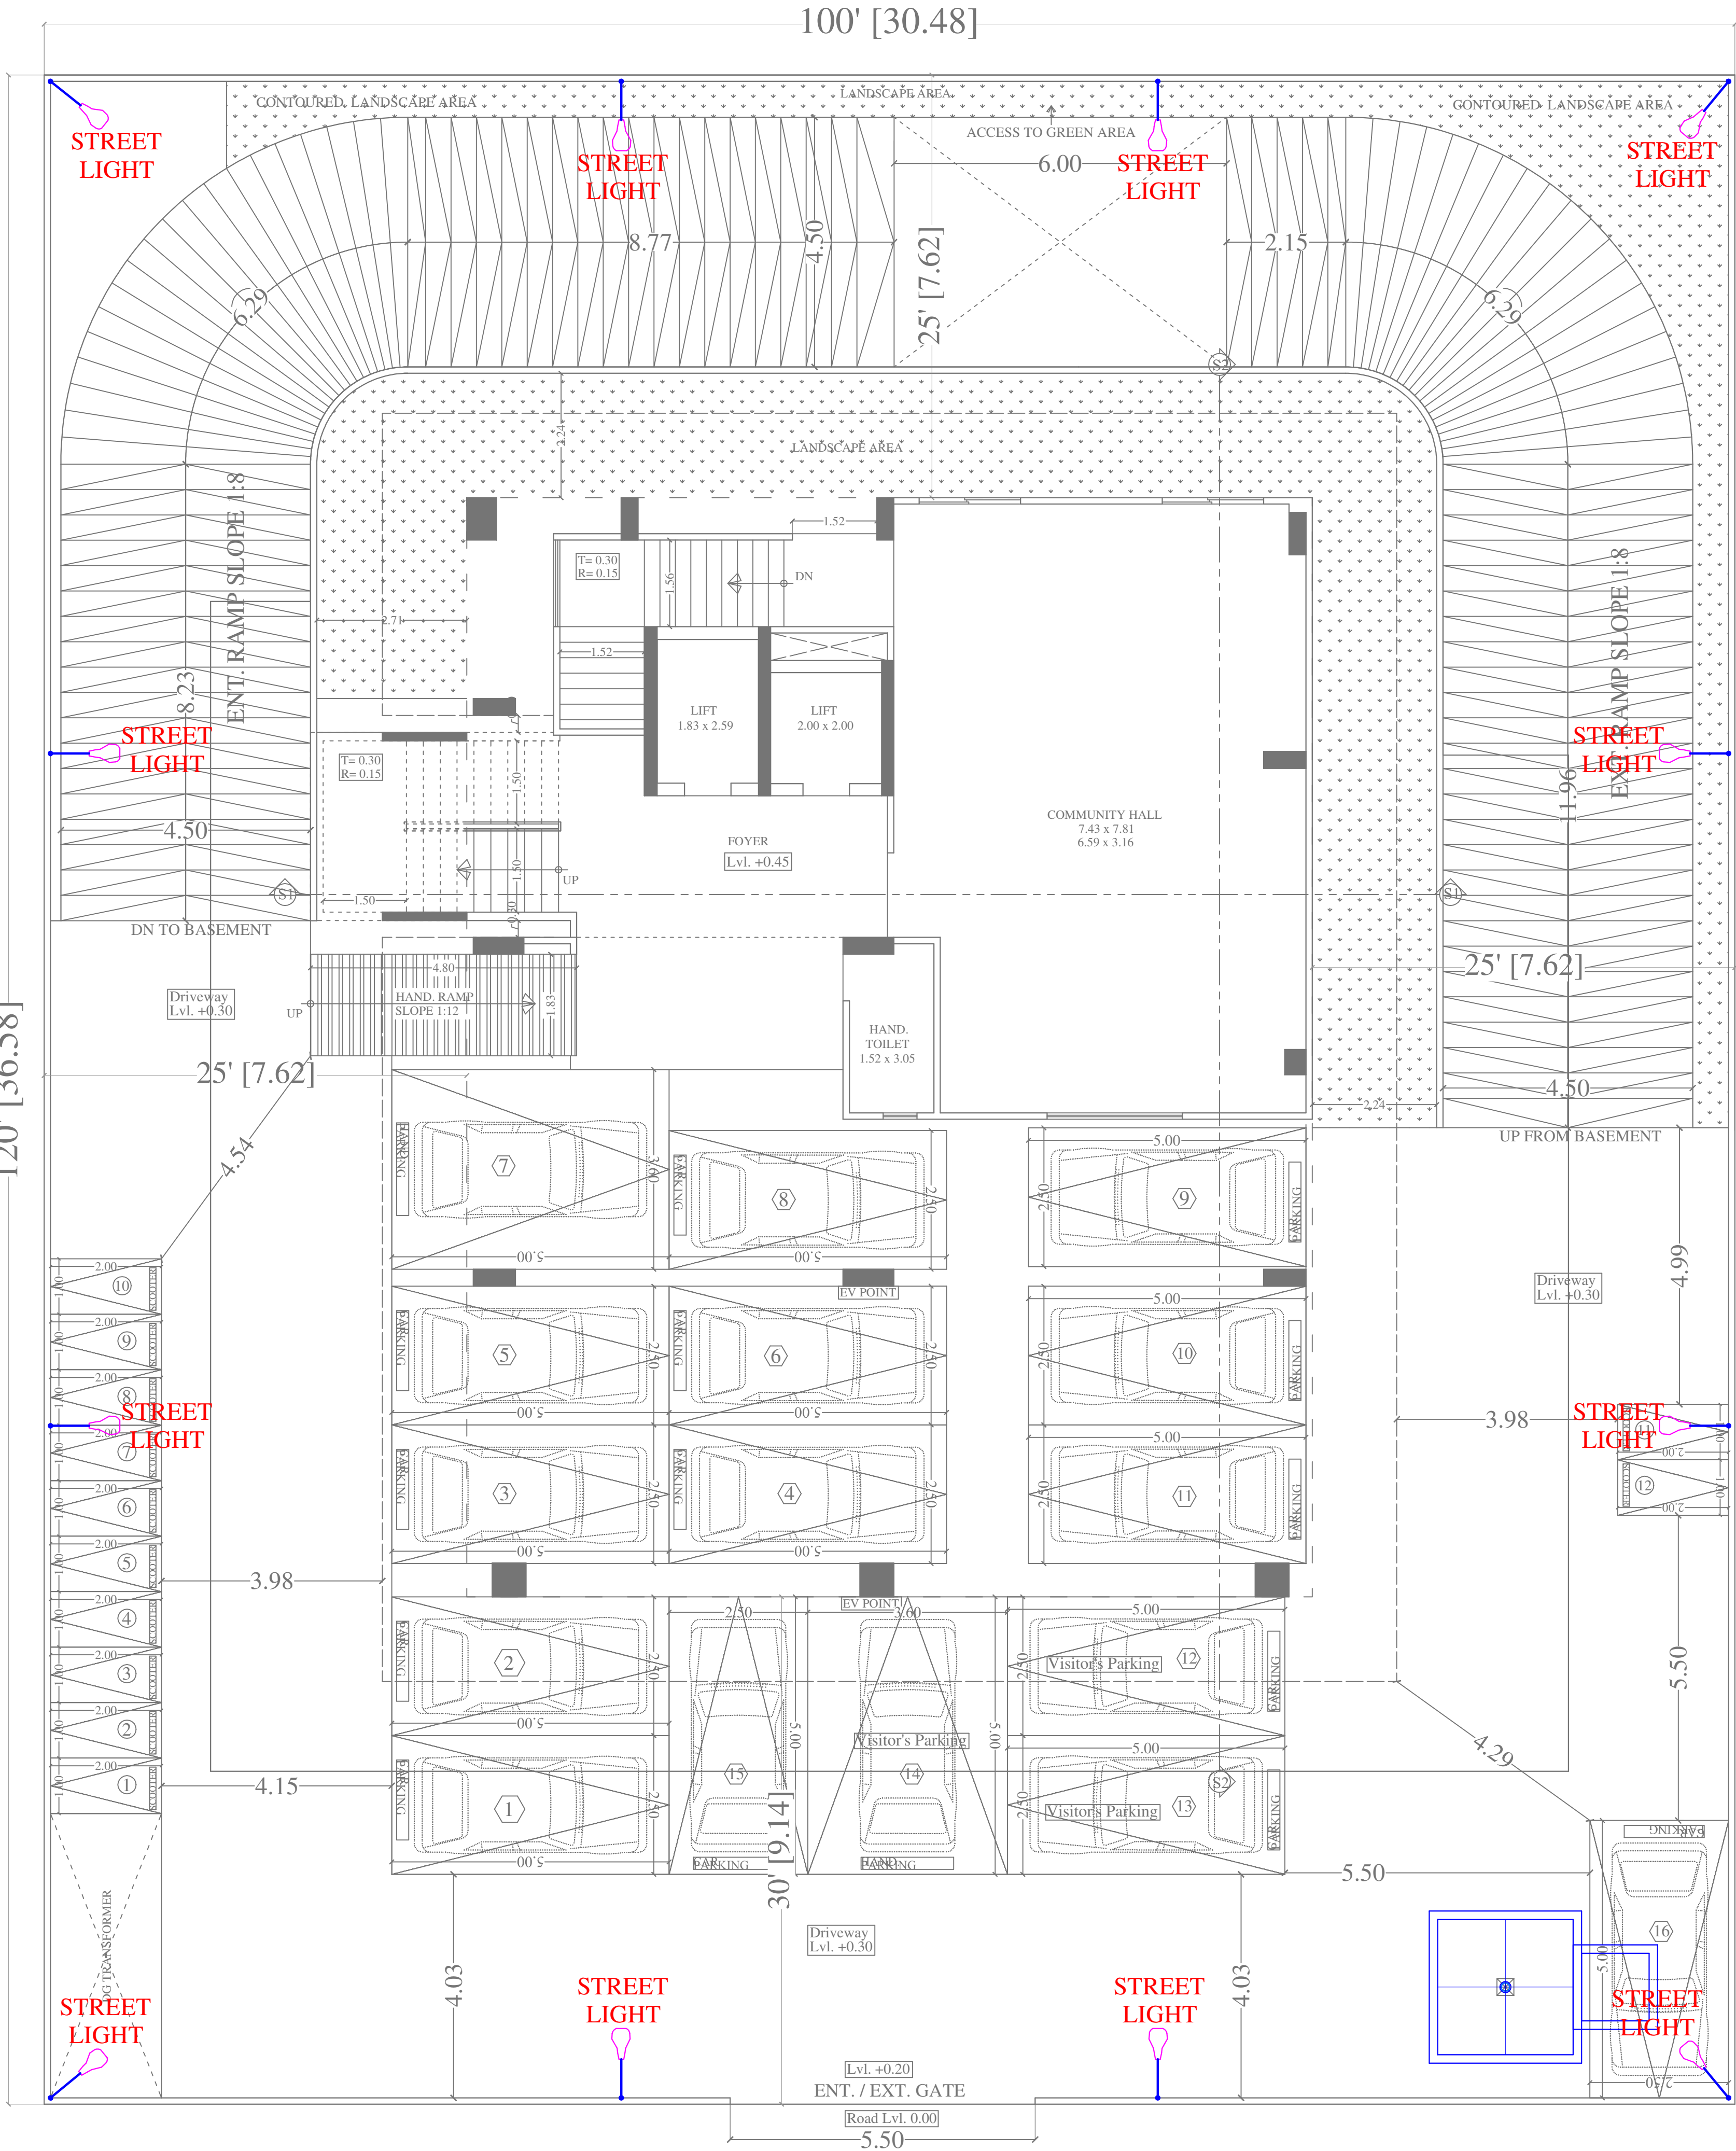

STILT PLAN

----- RAJENDRA MARG 60'-0" WIDE -----

Vipul
VIPUL AGARWAL
M.E.P. CONSULTANT
B.E. ELECTRICAL

NOTE:-
ALL EXTERNAL STREET LIGHT
CONTROL BY GUARD ROOM DB

LEGENDS:

Qty.	ID	Symbol	Description
12	PL		STREET LIGHT

SERVICE CONSULTANT
ASHI ASSOCIATES
F 9 / 440 , Keshav Marg Chitrakut Scheme,Jaipur
PH-91-0-93146-10438 ,0141-2440946, Mail:vipul8599@yahoo.com

ARCHITECT :-
 SPACE GRID
C-49, VIDYA
APARTMENT, PARAS MARG,
BAPU NAGAR, NEAR JANTA
STORE CIRCLE, JAIPUR-302015
PH-09314918766, 0141-4005506 (O)
Email:-info.spacegrid@gmail.com


DEVELOPER NAME:-
PEARL SPYTECH
REALTORS LLP





PROJECT NAME:-
PEARL PRISTINE


ADDRESS:-
PLOT NO. B-173
RAJENDRA MARG,
BAPU NAGAR, JAIPUR

DRG. TITLE:-
STILT FLOOR
EXTERNAL LIGHTING PLAN

SCALE = 1:100

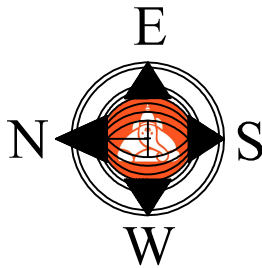

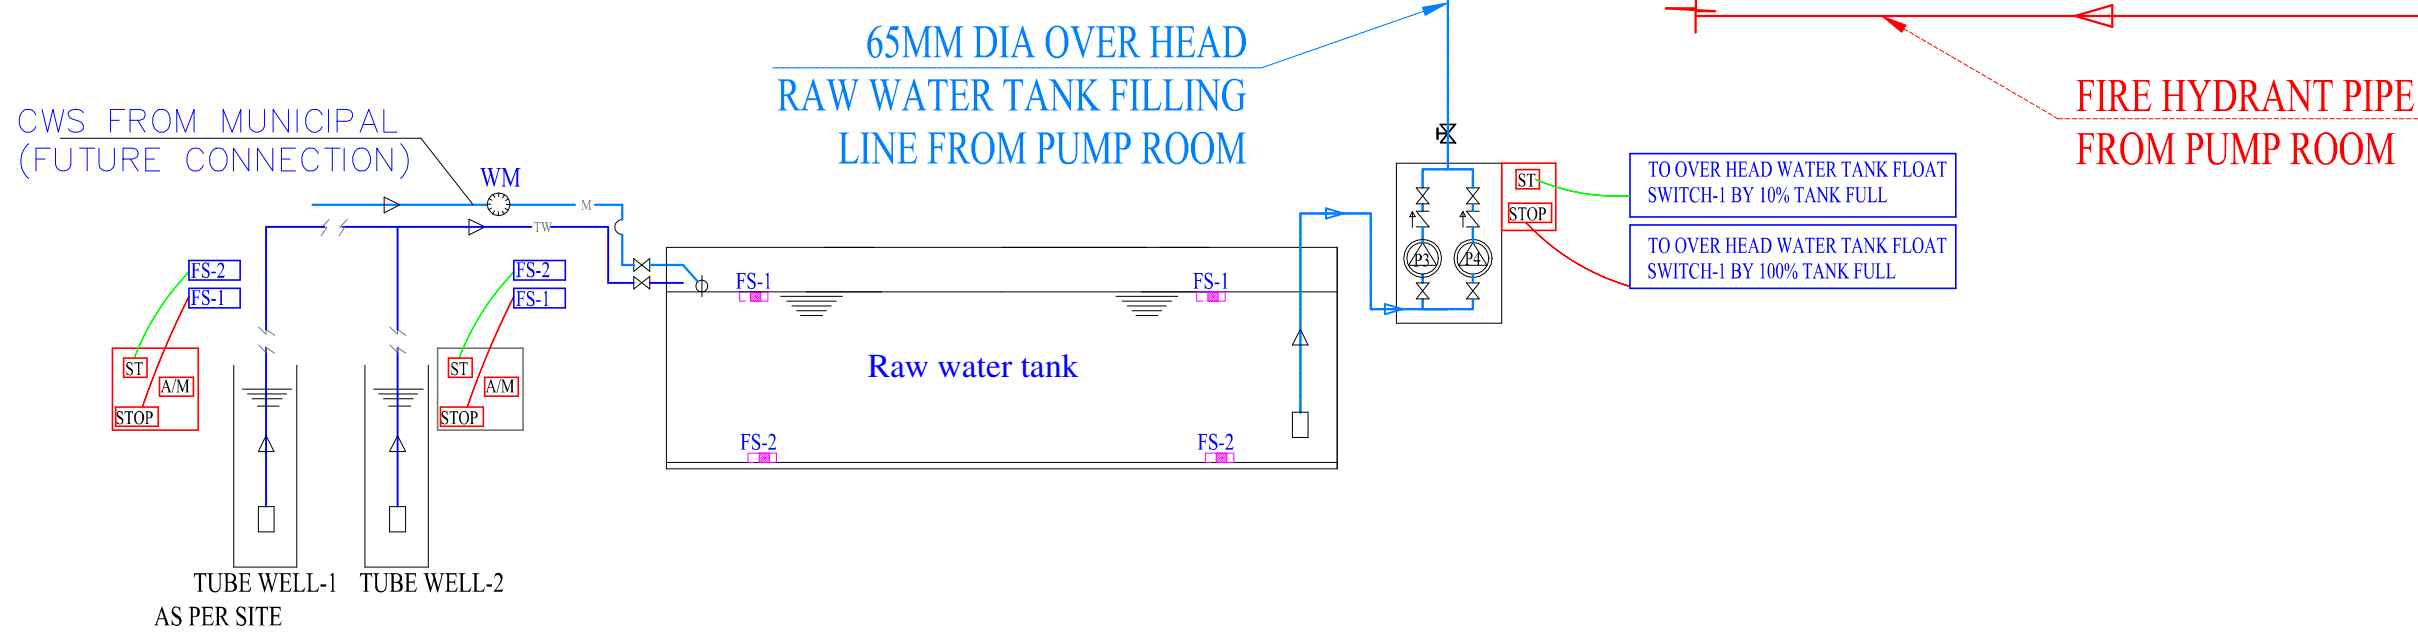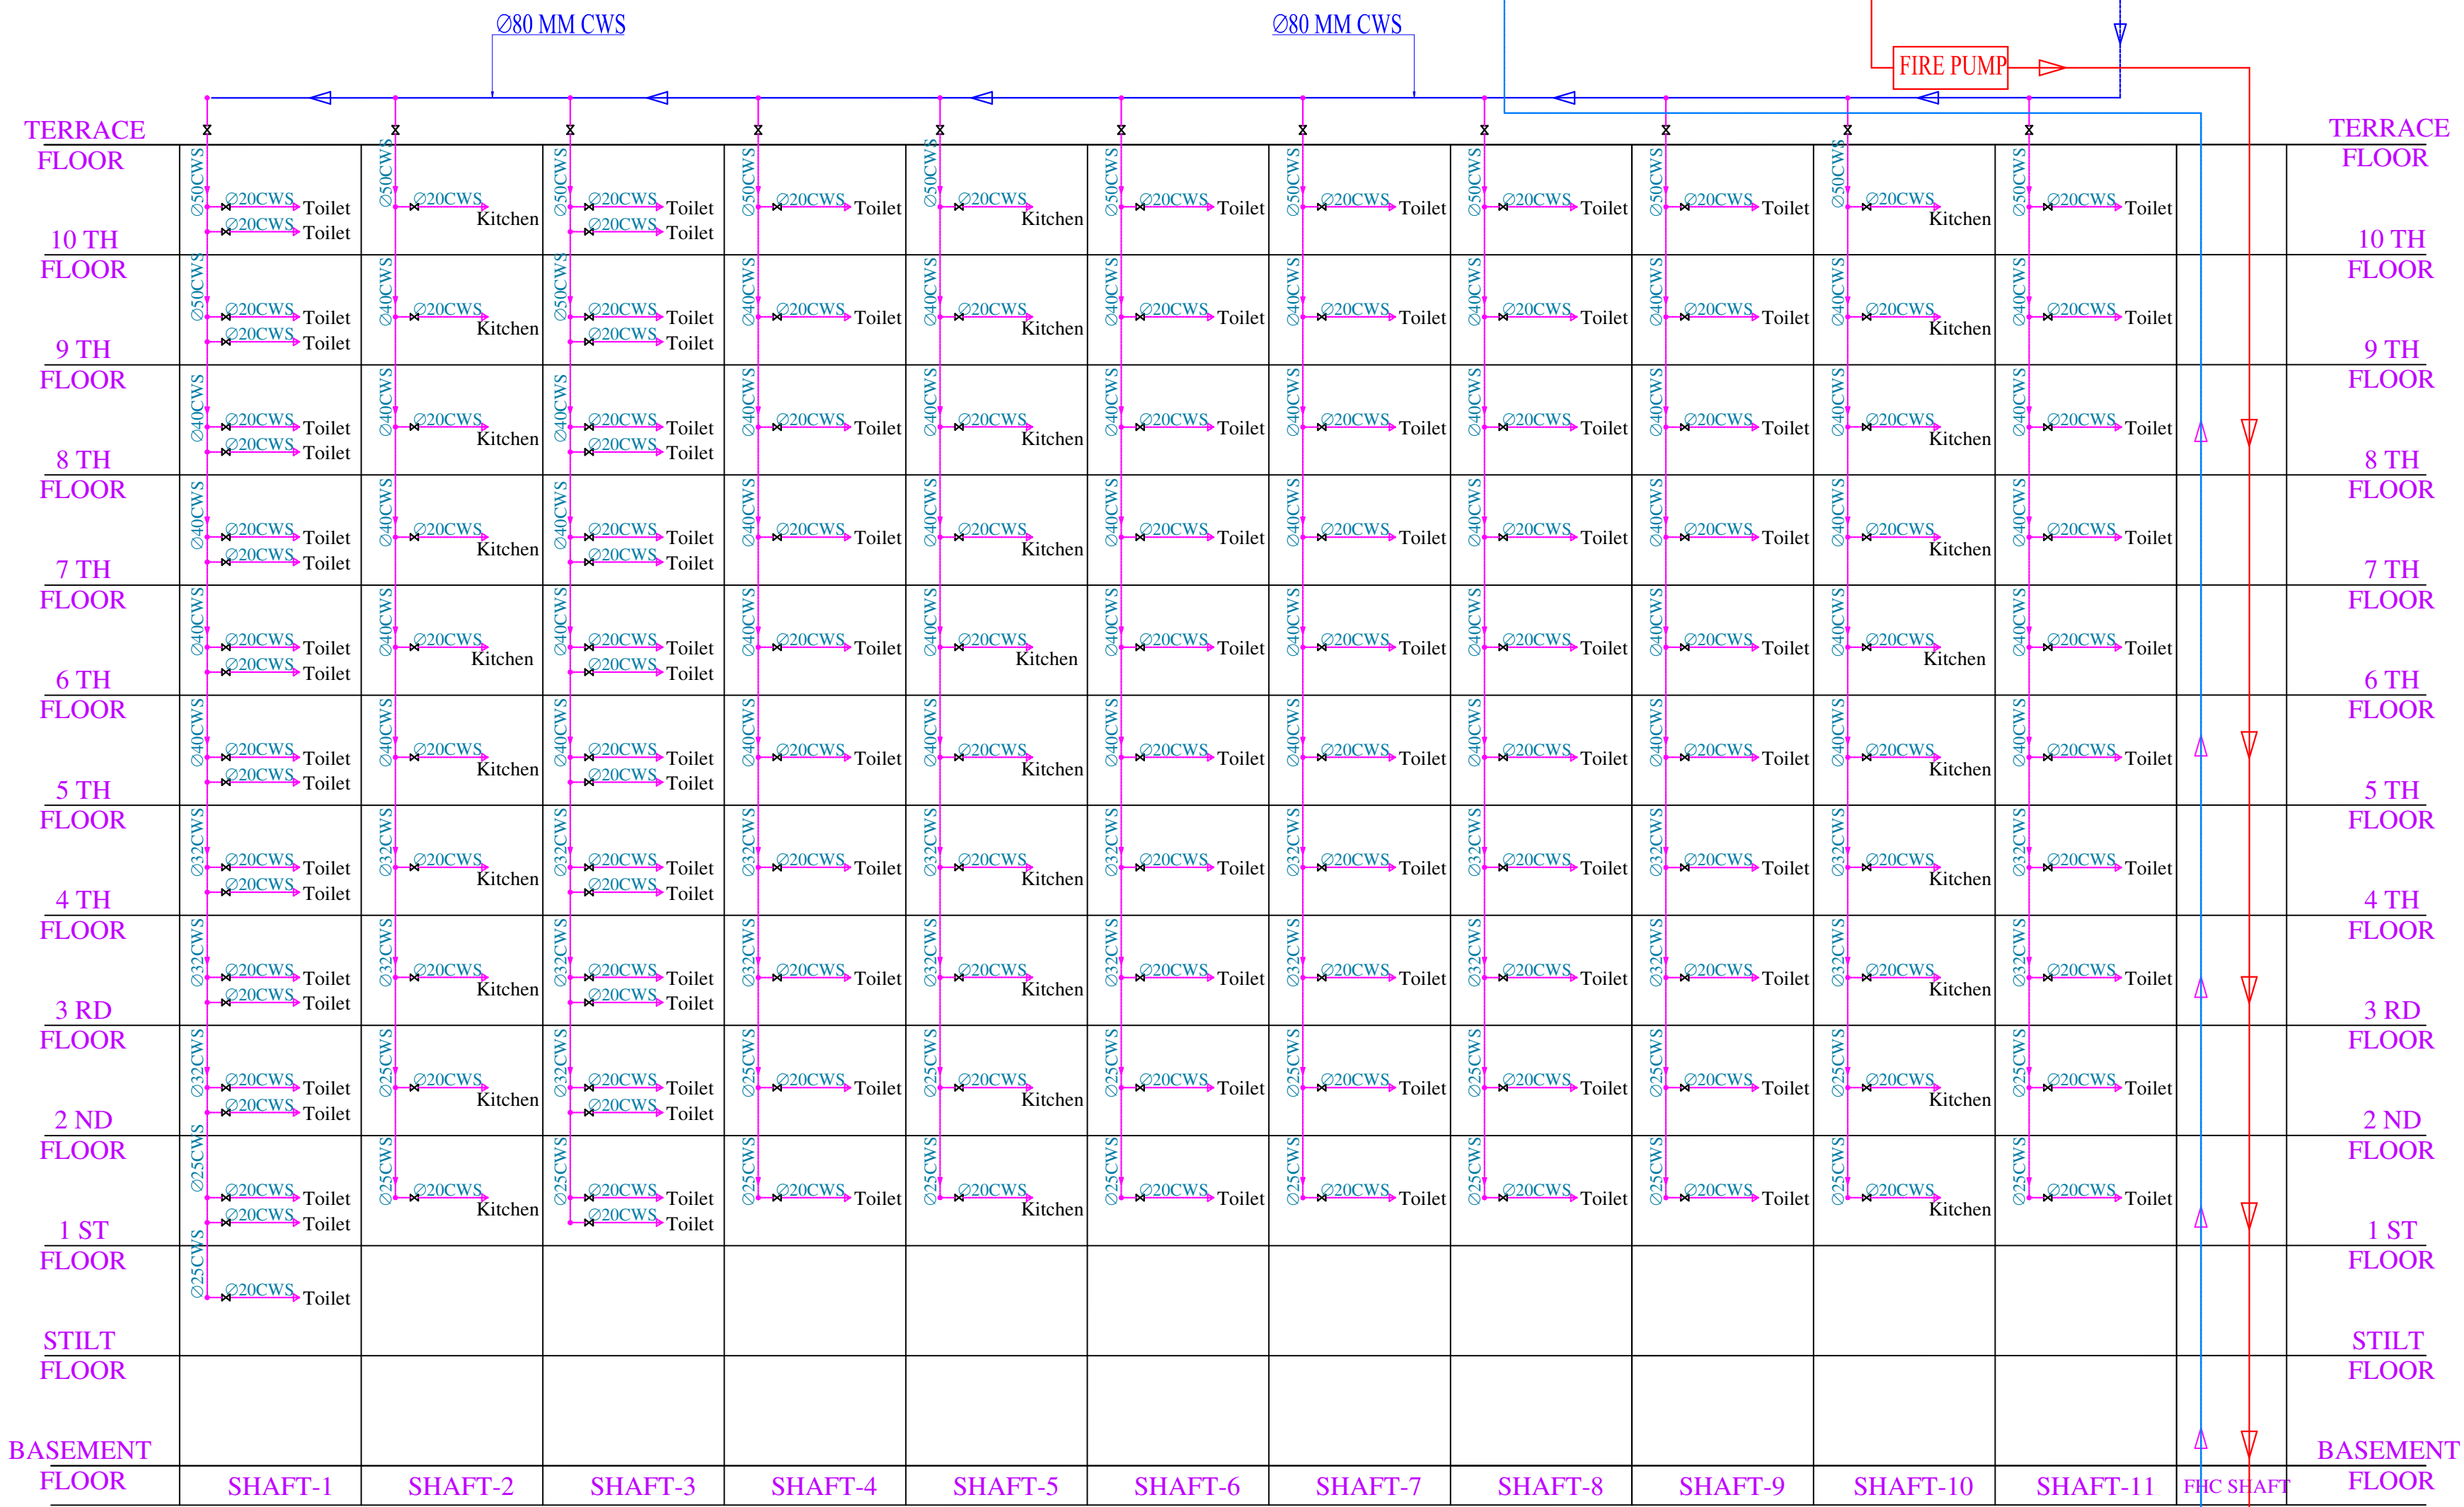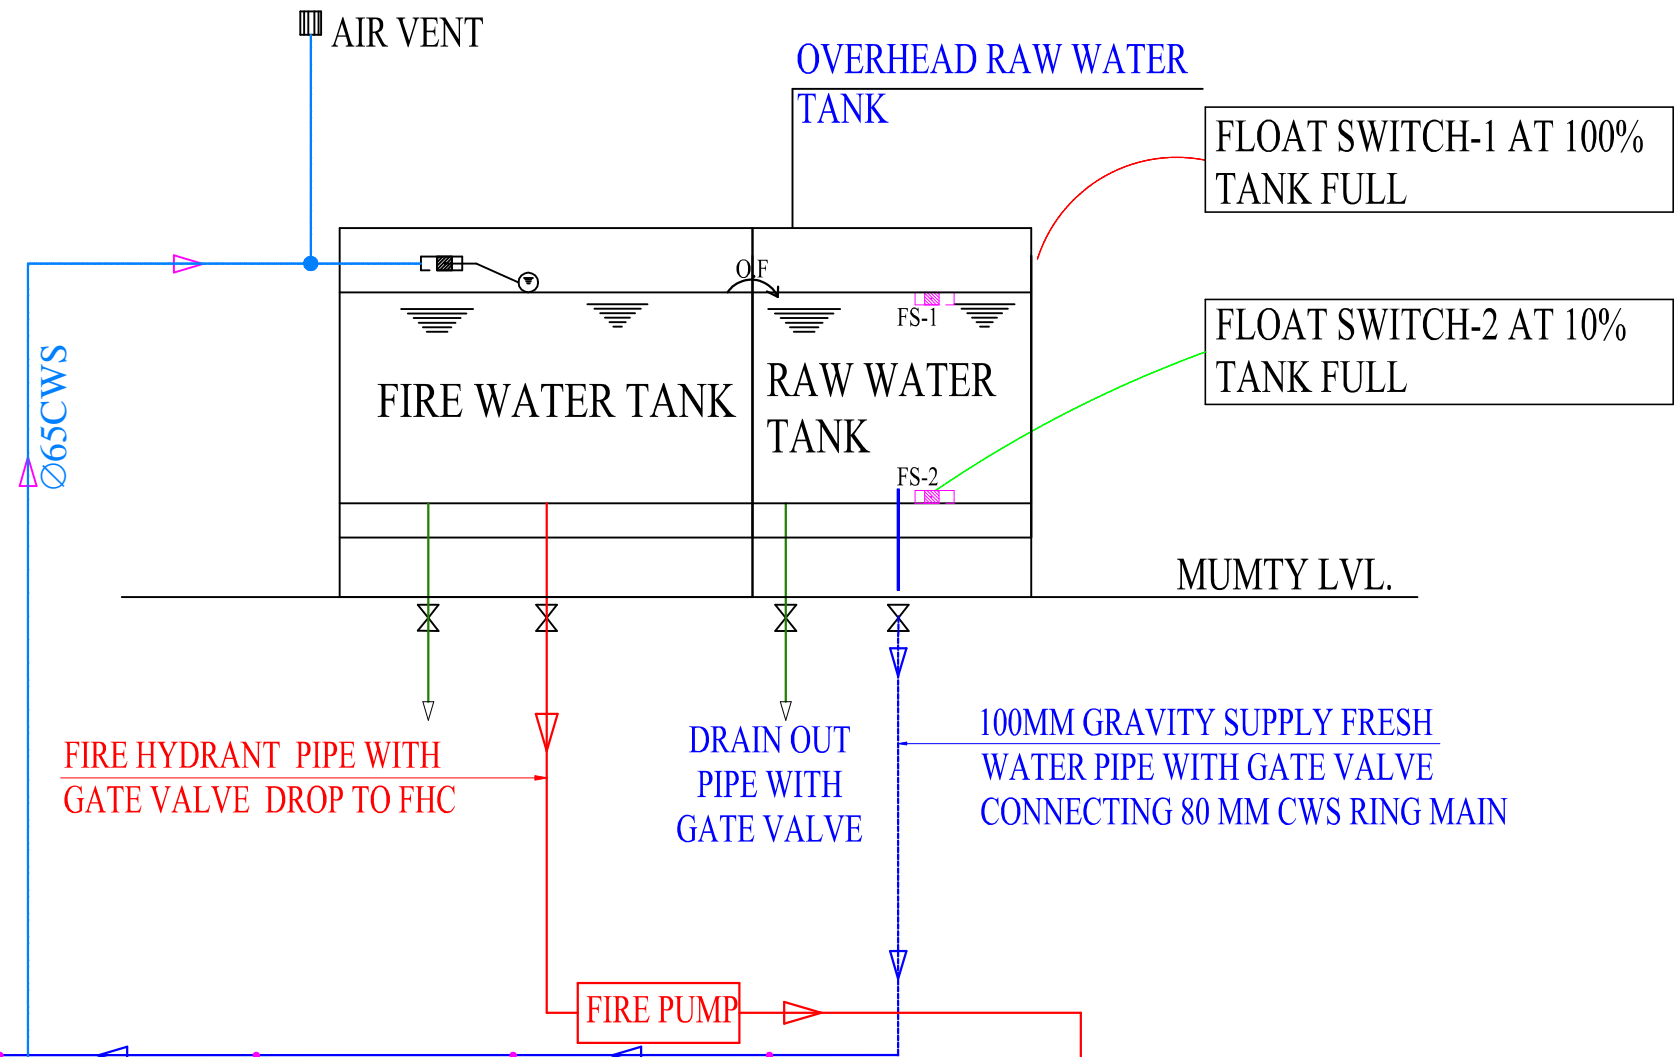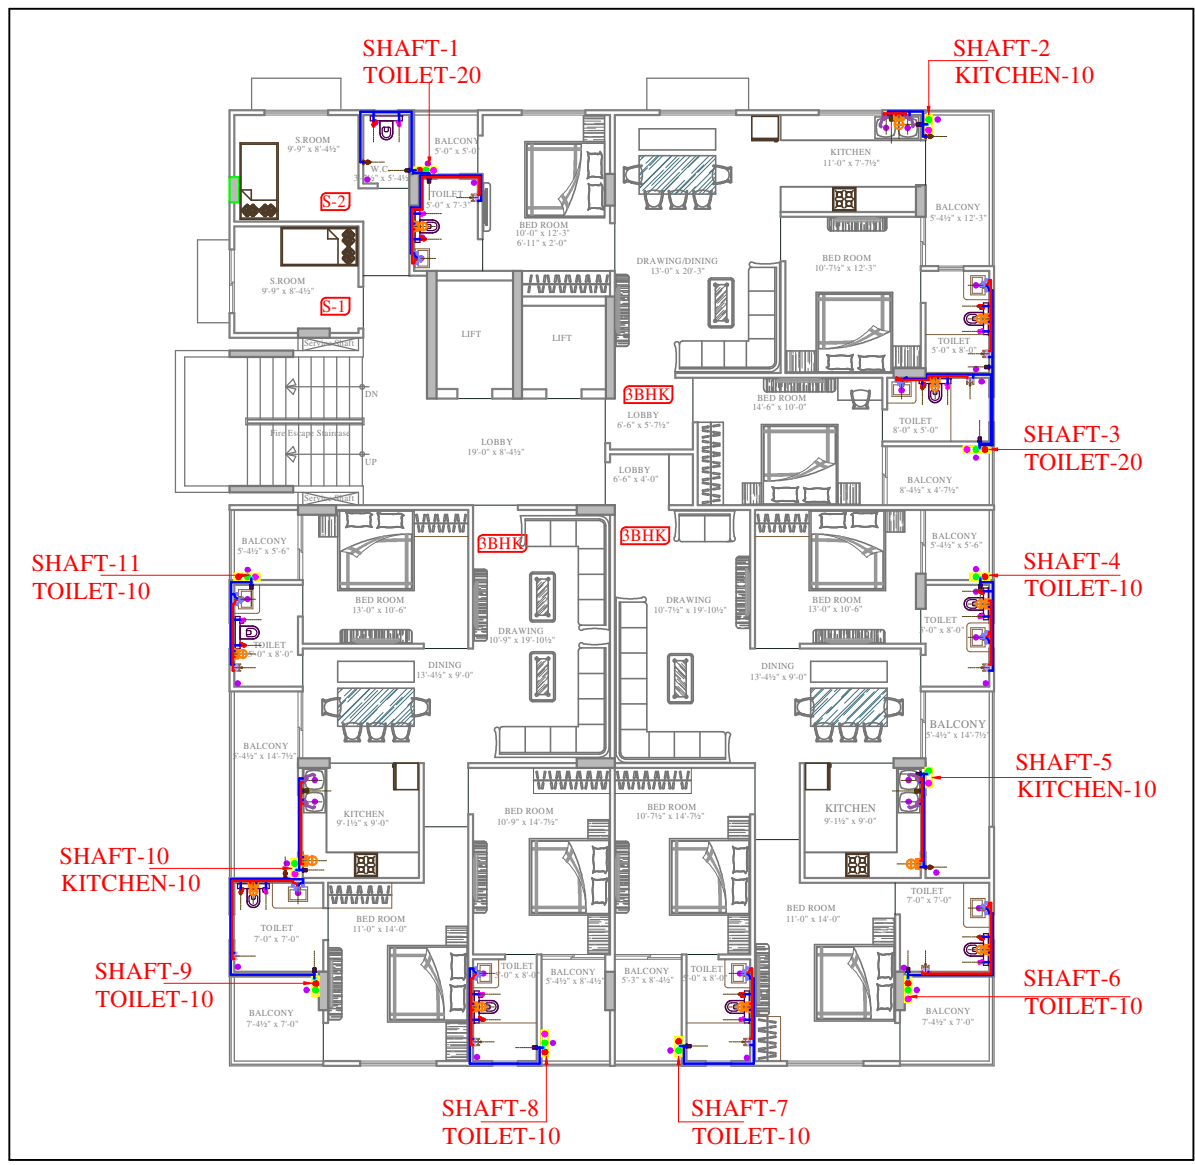

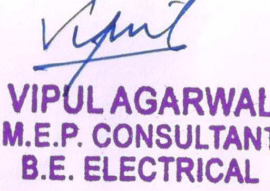

VIPUL AGARWAL
M.E.P. CONSULTANT
B.E. ELECTRICAL

SERVICE CONSULTANT

ASHI ASSOCIATES
F 9 / 440 , Keshav Marg Chitrakut Scheme,Jaipur
PH-91-0-93146-10438 ,0141-2440946,
Mail:vipu8599@yahoo.com

ARCHITECT :-

SPACE GRID
C-49,VIDYA
APARTMENT,PARAS MARG,
BAPU NAGAR,NEAR JANTA
STORE CIRCLE, JAIPUR-302015
PH-09314918766,0141-4005506 (O)
Email:info.spacegrid@gmail.com

DEVELOPER NAME:-

PEARL SPYTECH
REALTORS LLP

PROJECT NAME:-

PEARL PRISTINE


ADDRESS:-


PLOT NO. B-173
RAJENDRA MARG,
BAPU NAGAR, JAIPUR

DRG. TITLE:-

WATER SUPPLY
SCHEMATIC
DIAGRAM

SCALE = 1:100

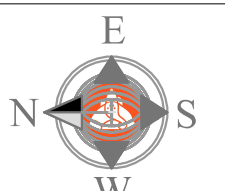

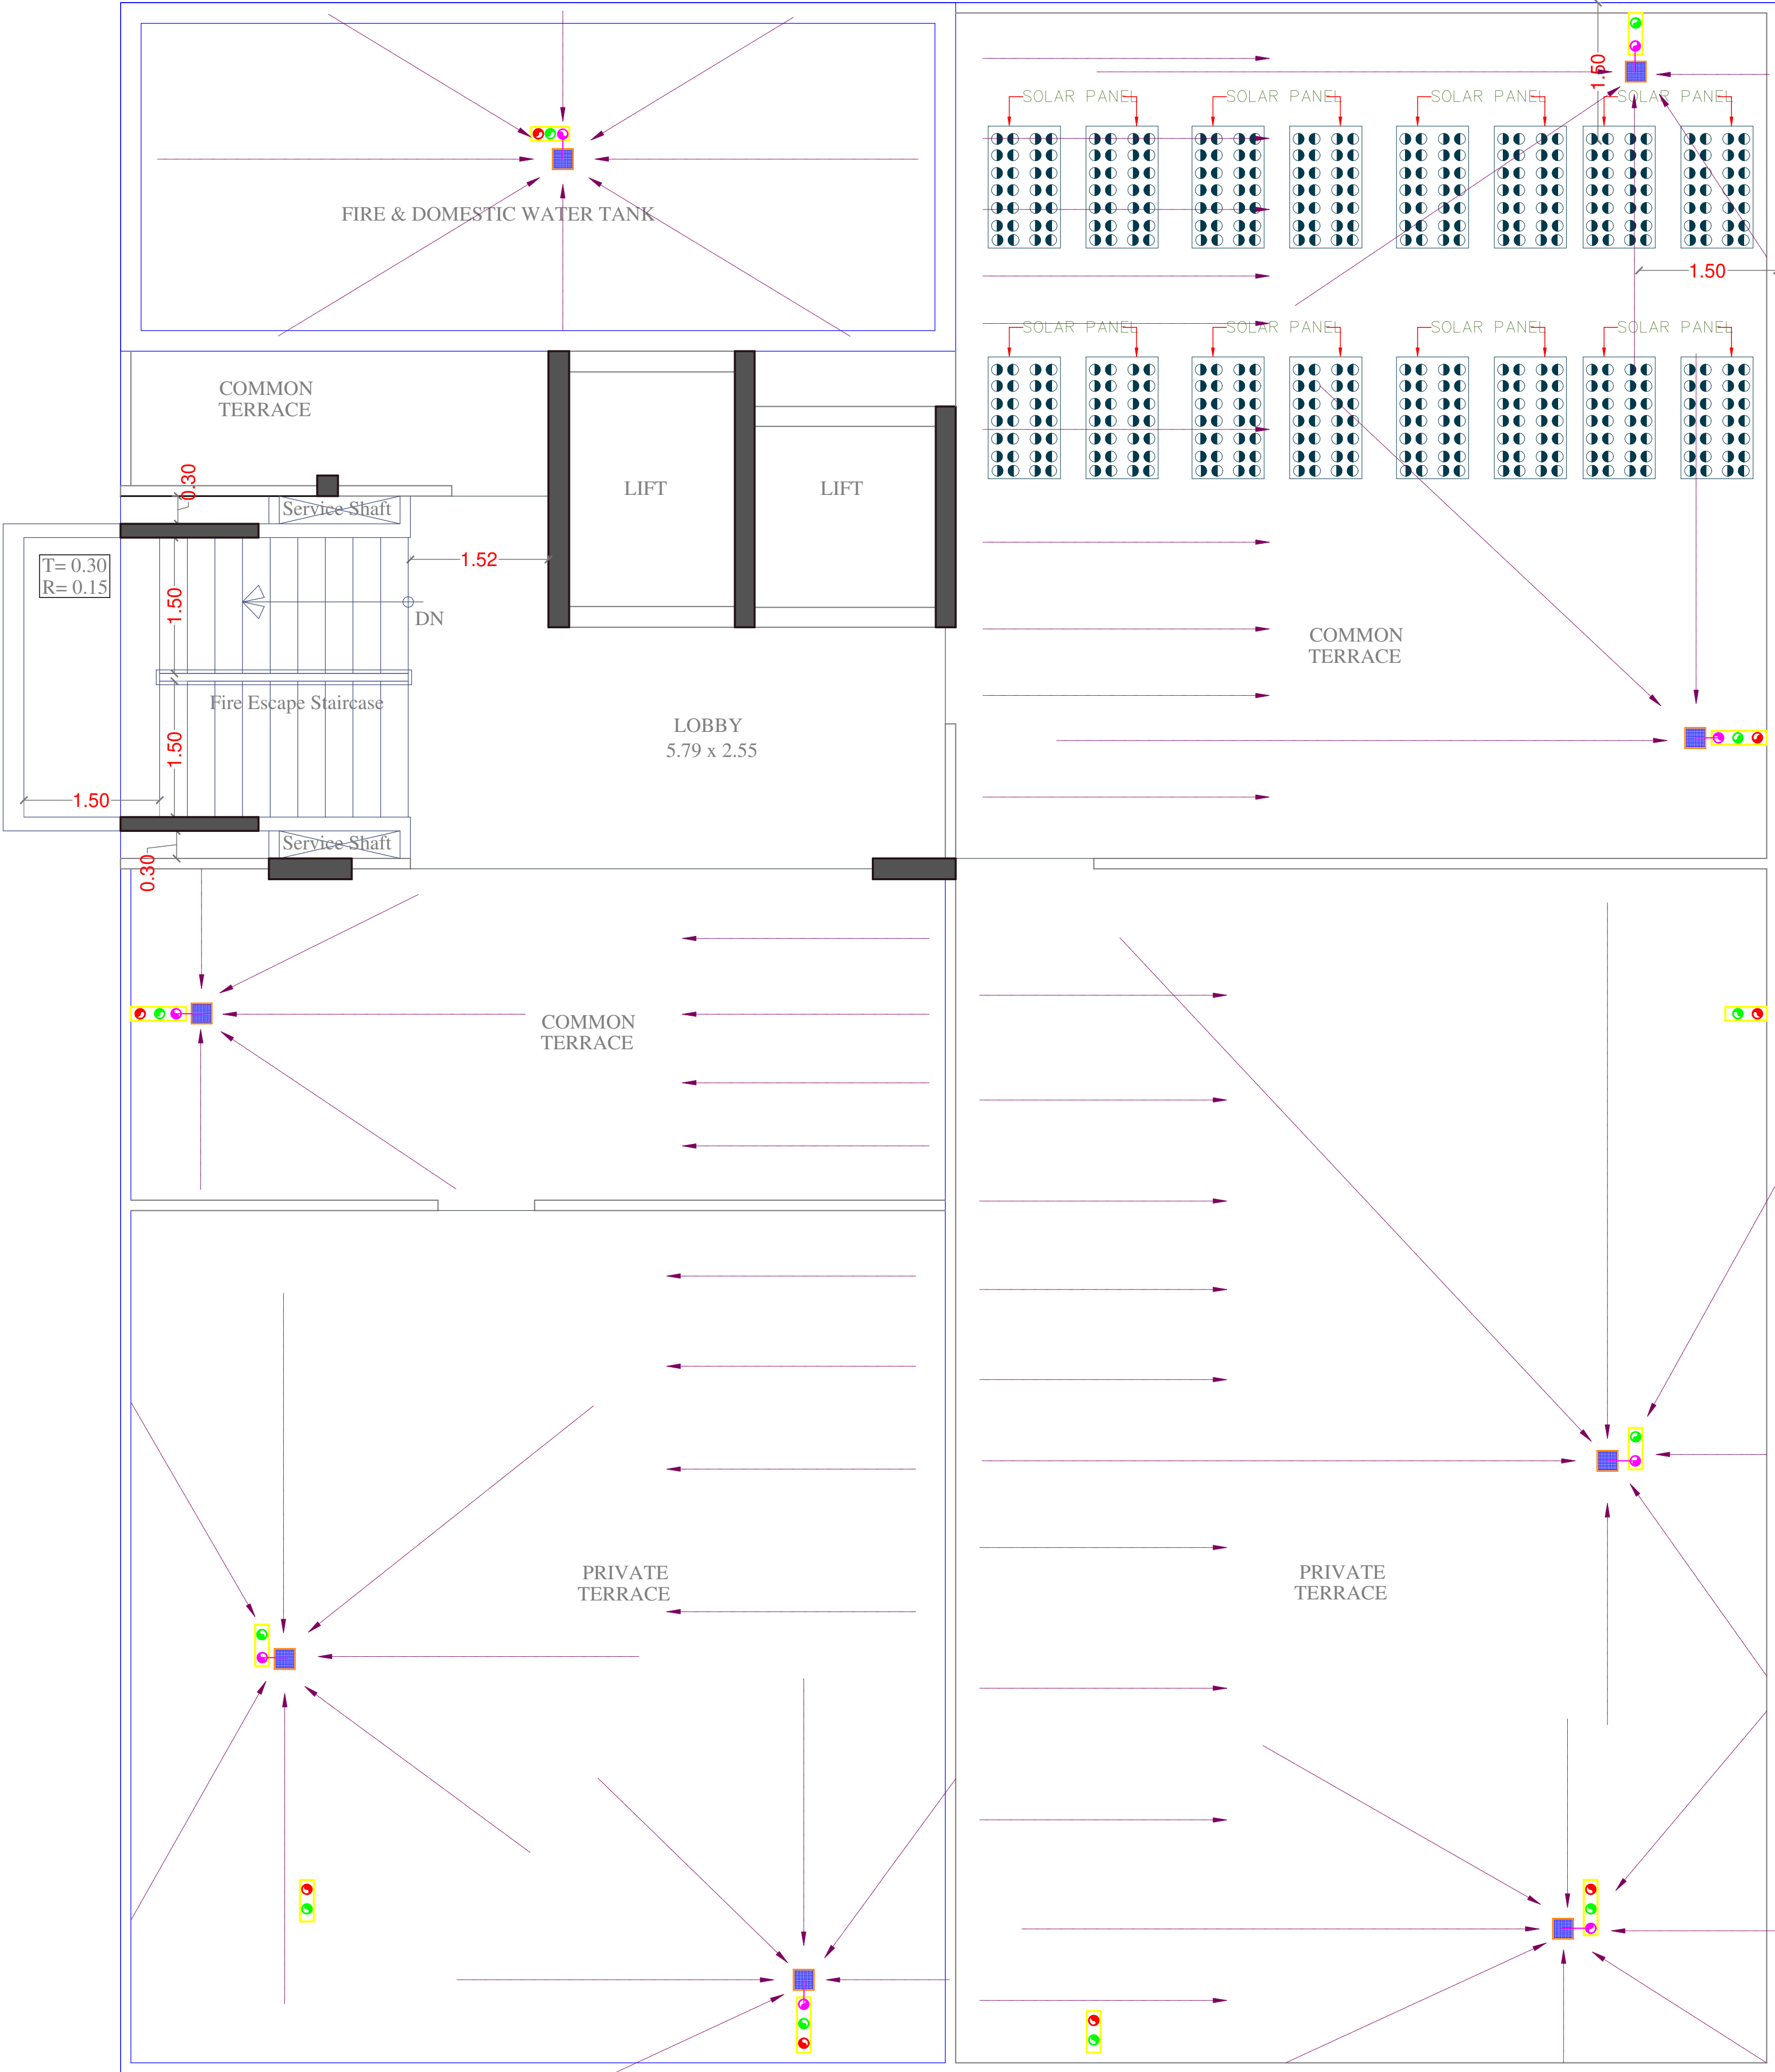

TERRACE PLAN

Vipul
VIPUL AGARWAL
M.E.P. CONSULTANT
B.E. ELECTRICAL

SYMBOL	DESCRIPTION
	Ø 110 mm Soil Waste Water Pipe
	Ø 110 mm Waste Water Pipe
	Ø 110 mm Rain Water Pipe
	Ø 110 mm Soil Waste Water Pipe Slope 1:150
	Ø 75mm Rain Water Pipe Slope 1:150
	Ø 110 mm Rain Water Pipe Slope 1:150
	Floor Trap
	Flow Direction
	KHURRA 9"X9"

SERVICE CONSULTANT
ASHI ASSOCIATES
F 9 / 440 , Keshav Marg Chitrakut Scheme Jaipur
PH:91-0-93146-10438 ,0141-2440946, Mail:vipul8599@yahoo.com

ARCHITECT :-
SPACE GRID
C-49,VIDYA
APARTMENT,PARAS MARG,
BAPU NAGAR,NEAR JANTA
STORE CIRCLE, JAIPUR-302015
PH-09314918766,0141-4005506 (O)
Email:-info.spacegrid@gmail.com

DEVELOPER NAME:-
PEARL SPYTECH
REALTORS LLP

PROJECT NAME:-
PEARL PRISTINE

ADDRESS:-
PLOT NO. B-173
RAJENDRA MARG,
BAPU NAGAR, JAIPUR

DRG. TITLE: -
TERRACE FLOOR RAIN WATER
SLOPE PLAN

SCALE = 1:100