
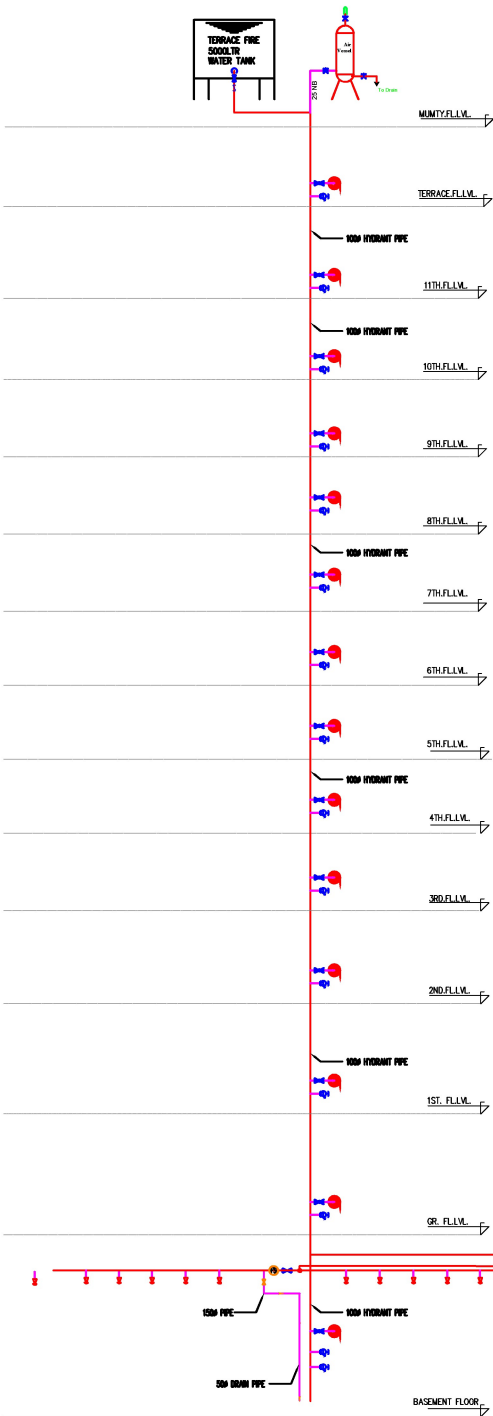
 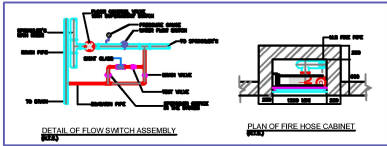

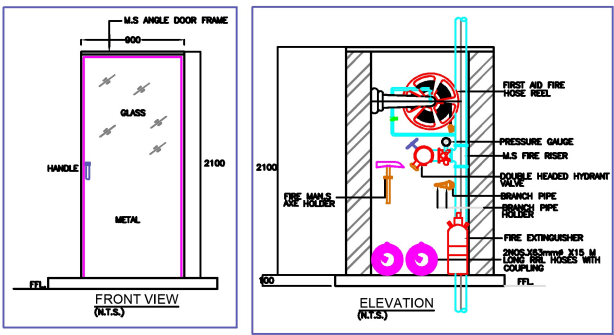


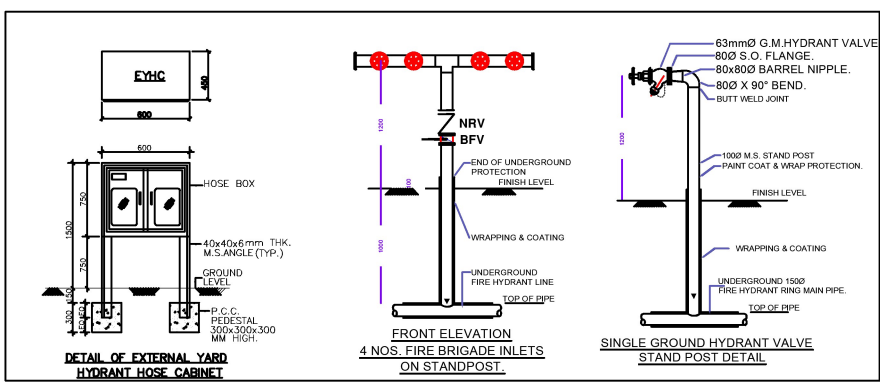


LEGEND	
SYMBOL	DESCRIPTION
	YARD HYDRANT VALVE (SINGLE HEADED)
	BUTTERFLY VALVE 1500
	LANDING VALVE
	HOSE REEL H.R.
	PRESSURE SWITCH
	PRESSURE GAUGE
	NON RETURN VALVE (CHECK VALVE)
	Y TYPE STRAINER
	SPRINKLER
	FLOW SWITCH
	EXPANSION BELLOWS
	INLET CONNECTION
	DRAWOUT CONNECTION

FIRE PUMPSET		FLOW IN M ³ /HR	FLOW IN LPM	HEAD IN METERS	QTY.
P1	AUTO DIESEL ENGINE DRIVEN STAND BY PUMP	137	2280	90	1 No.
P2	AUTO ELECTRIC DRIVEN PUMP FOR HYDRANT SYSTEM	137	2280	90	1 No.
P3	AUTO ELECTRIC DRIVEN JOCKEY PUMP	10.8	180	90	1 No.

FIRE REQUIREMENT OF UPASANA AZURE		
Type of Building: Residential (A4)		
Ad: above 35 Mtr. but not exceeding 45 Mtr in Height		
2016		
SN	NBC and ITEM	Type A4
1	3 Fire Extinguisher	R
2	4 House Riser	R
4	5 Wet Riser	R
5	6 Down Corner	NR
6	7 Yard Hydrant	NR
7	8 Automatic Sprinkler System	R (IN THE BASEMENT)
8	9 Manually operated Fire alarm system	R
9	10 Automatic Detection and Alarm system	NR
10	11 Under ground Water tank	75000 Lt
11	12 Terrace Tank	5000 Lt
12	13 Pump Capacity in Pump room	2280 LPM (38LPS)
13	13 Diesel Pump Capacity in Pump room	2280 LPM (38LPS)
14	13 Jockey Pump Capacity	180 LPM (3 LPS)
15	14 Terrace Pump Capacity	NR

Praveen KUMAR
BTECH (ELECT)

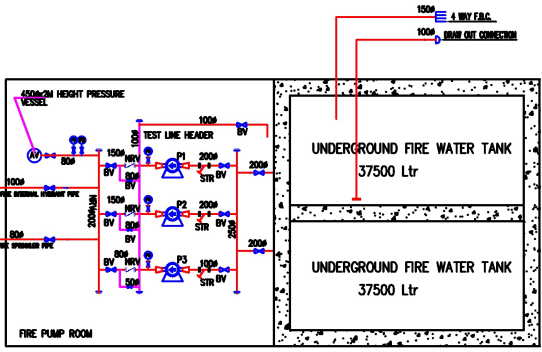

SUBMISSION DRAWING FIRE FIGHTING SCHEMATIC PLAN

DATE: 07-01-2025

SCALE: 1:100


PROPOSED RESIDENTIAL APARTMENT AT AURALLIS, A-22, SHANTI PATH, TILAK NAGAR JAIPUR, UPASANA INFRA LLP

ARCHITECT: m3 architects pvt. ltd.

OWNER: _____

ARCHITECTS: _____

BLOCK - A
SHAFT - 01

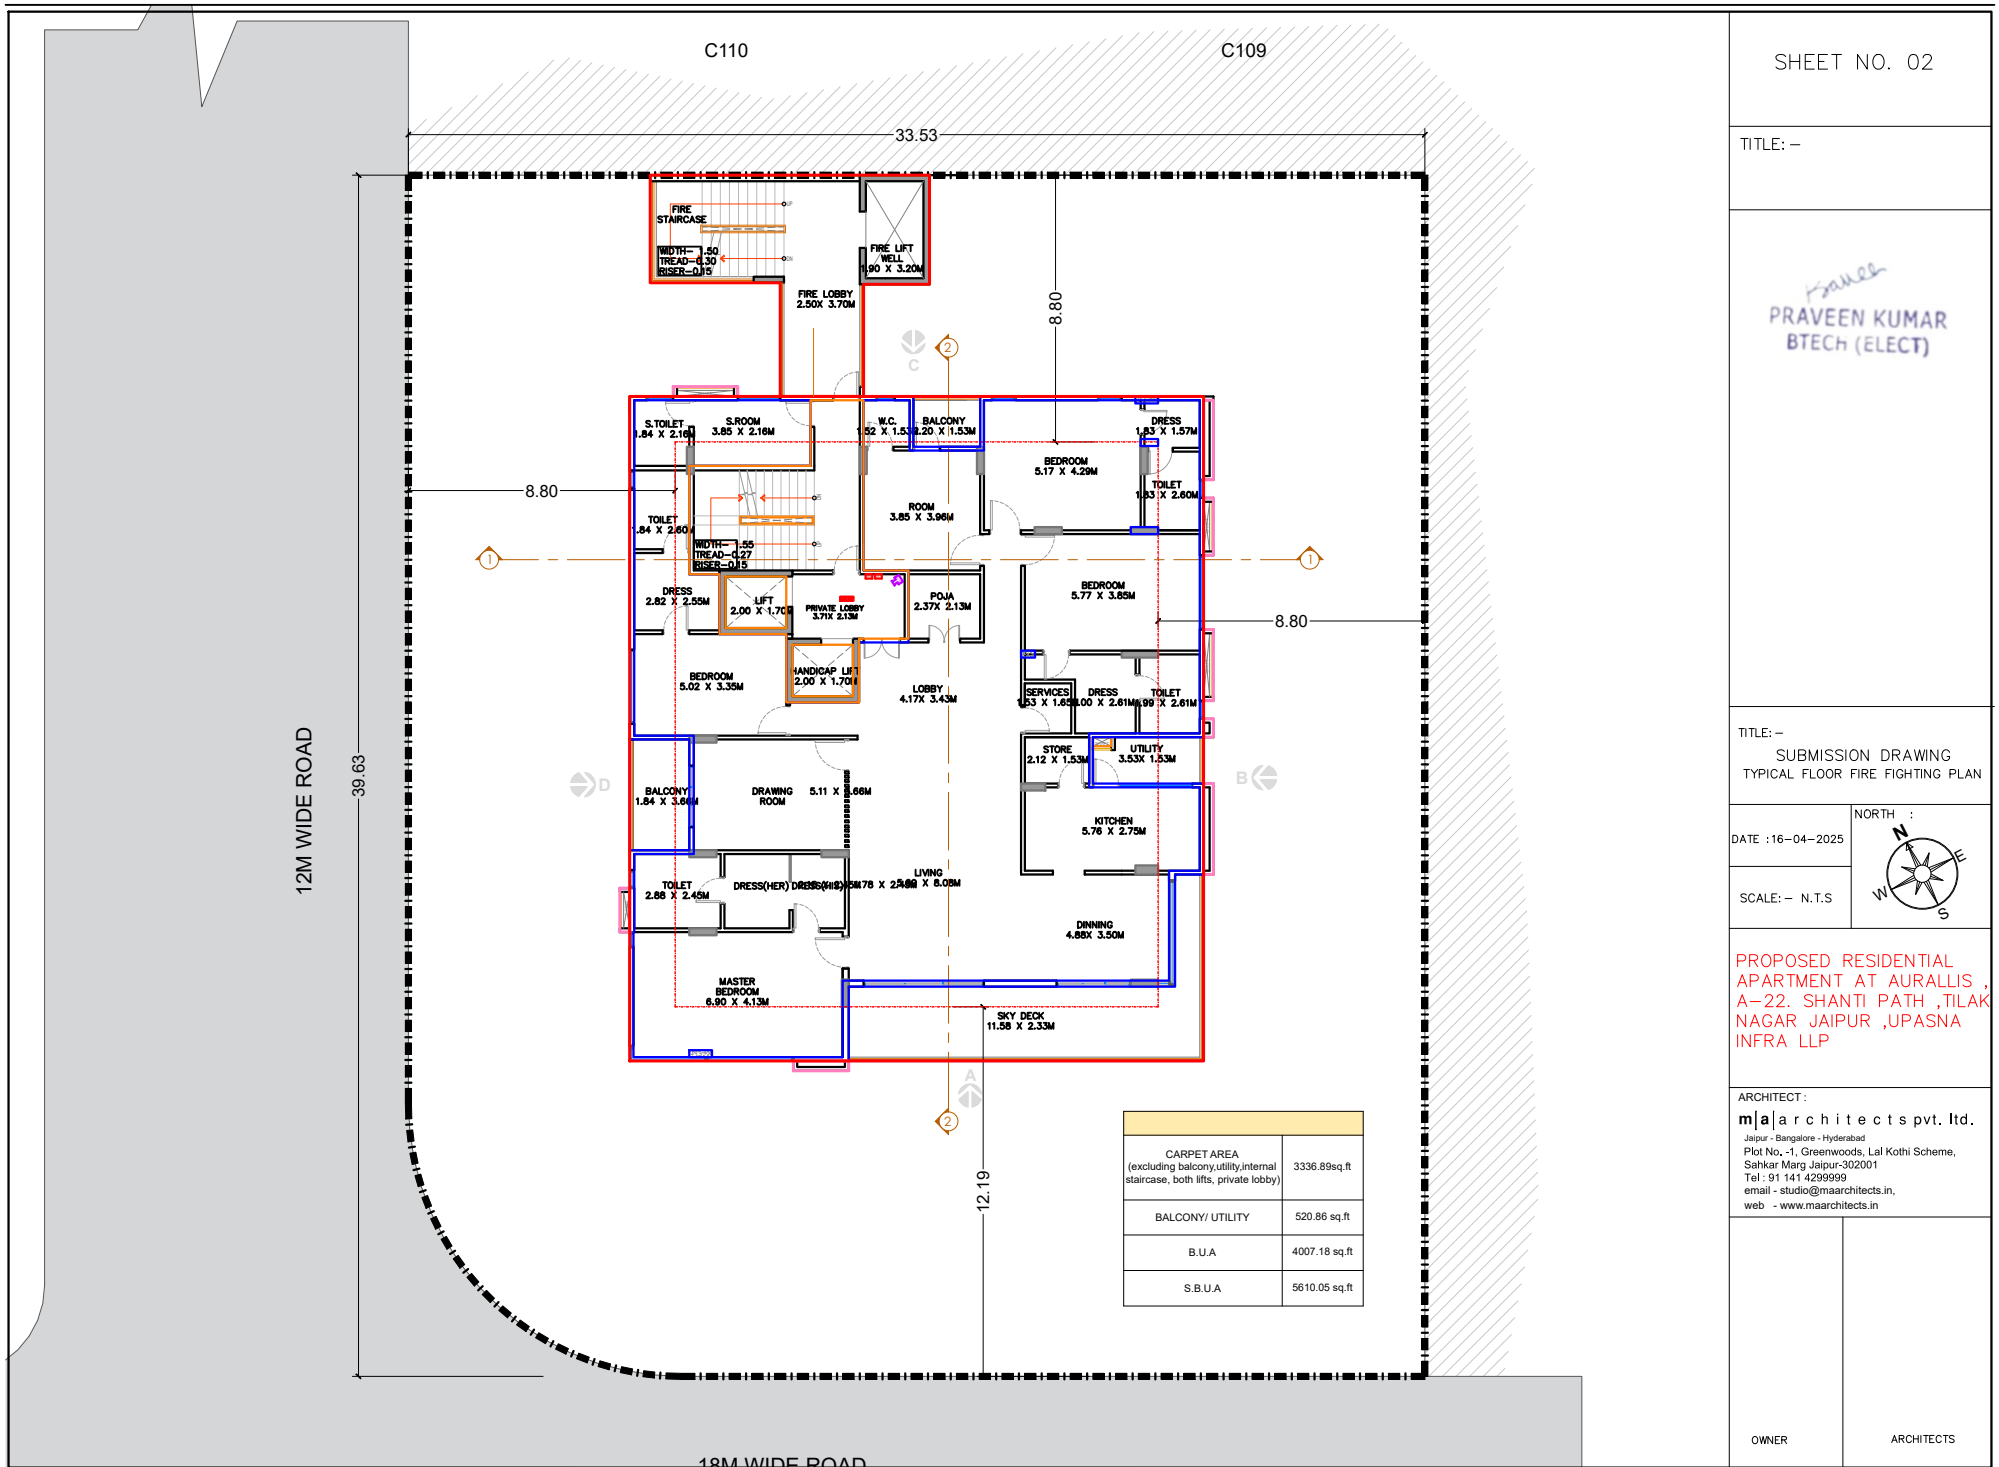

SHEET NO. 02

TITLE: -

Praveen
PRAVEEN KUMAR
BTECH (ELECT)

TITLE: -
SUBMISSION DRAWING
TYPICAL FLOOR FIRE FIGHTING PLAN

DATE : 16-04-2025


NORTH :

SCALE: - N.T.S

PROPOSED RESIDENTIAL
APARTMENT AT AURALLIS ,
A-22. SHANTI PATH ,TILAK
NAGAR JAIPUR ,UPASNA
INFRA LLP

ARCHITECT :
m|a|architects pvt. ltd.
Jaipur - Bangalore - Hyderabad
Plot No. -1, Greenwoods, Lal Kothi Scheme,
Sahakar Marg Jaipur-302001
Tel : 91 141 4299999
email - studio@maarchitects.in,
web - www.maarchitects.in

OWNER ARCHITECTS

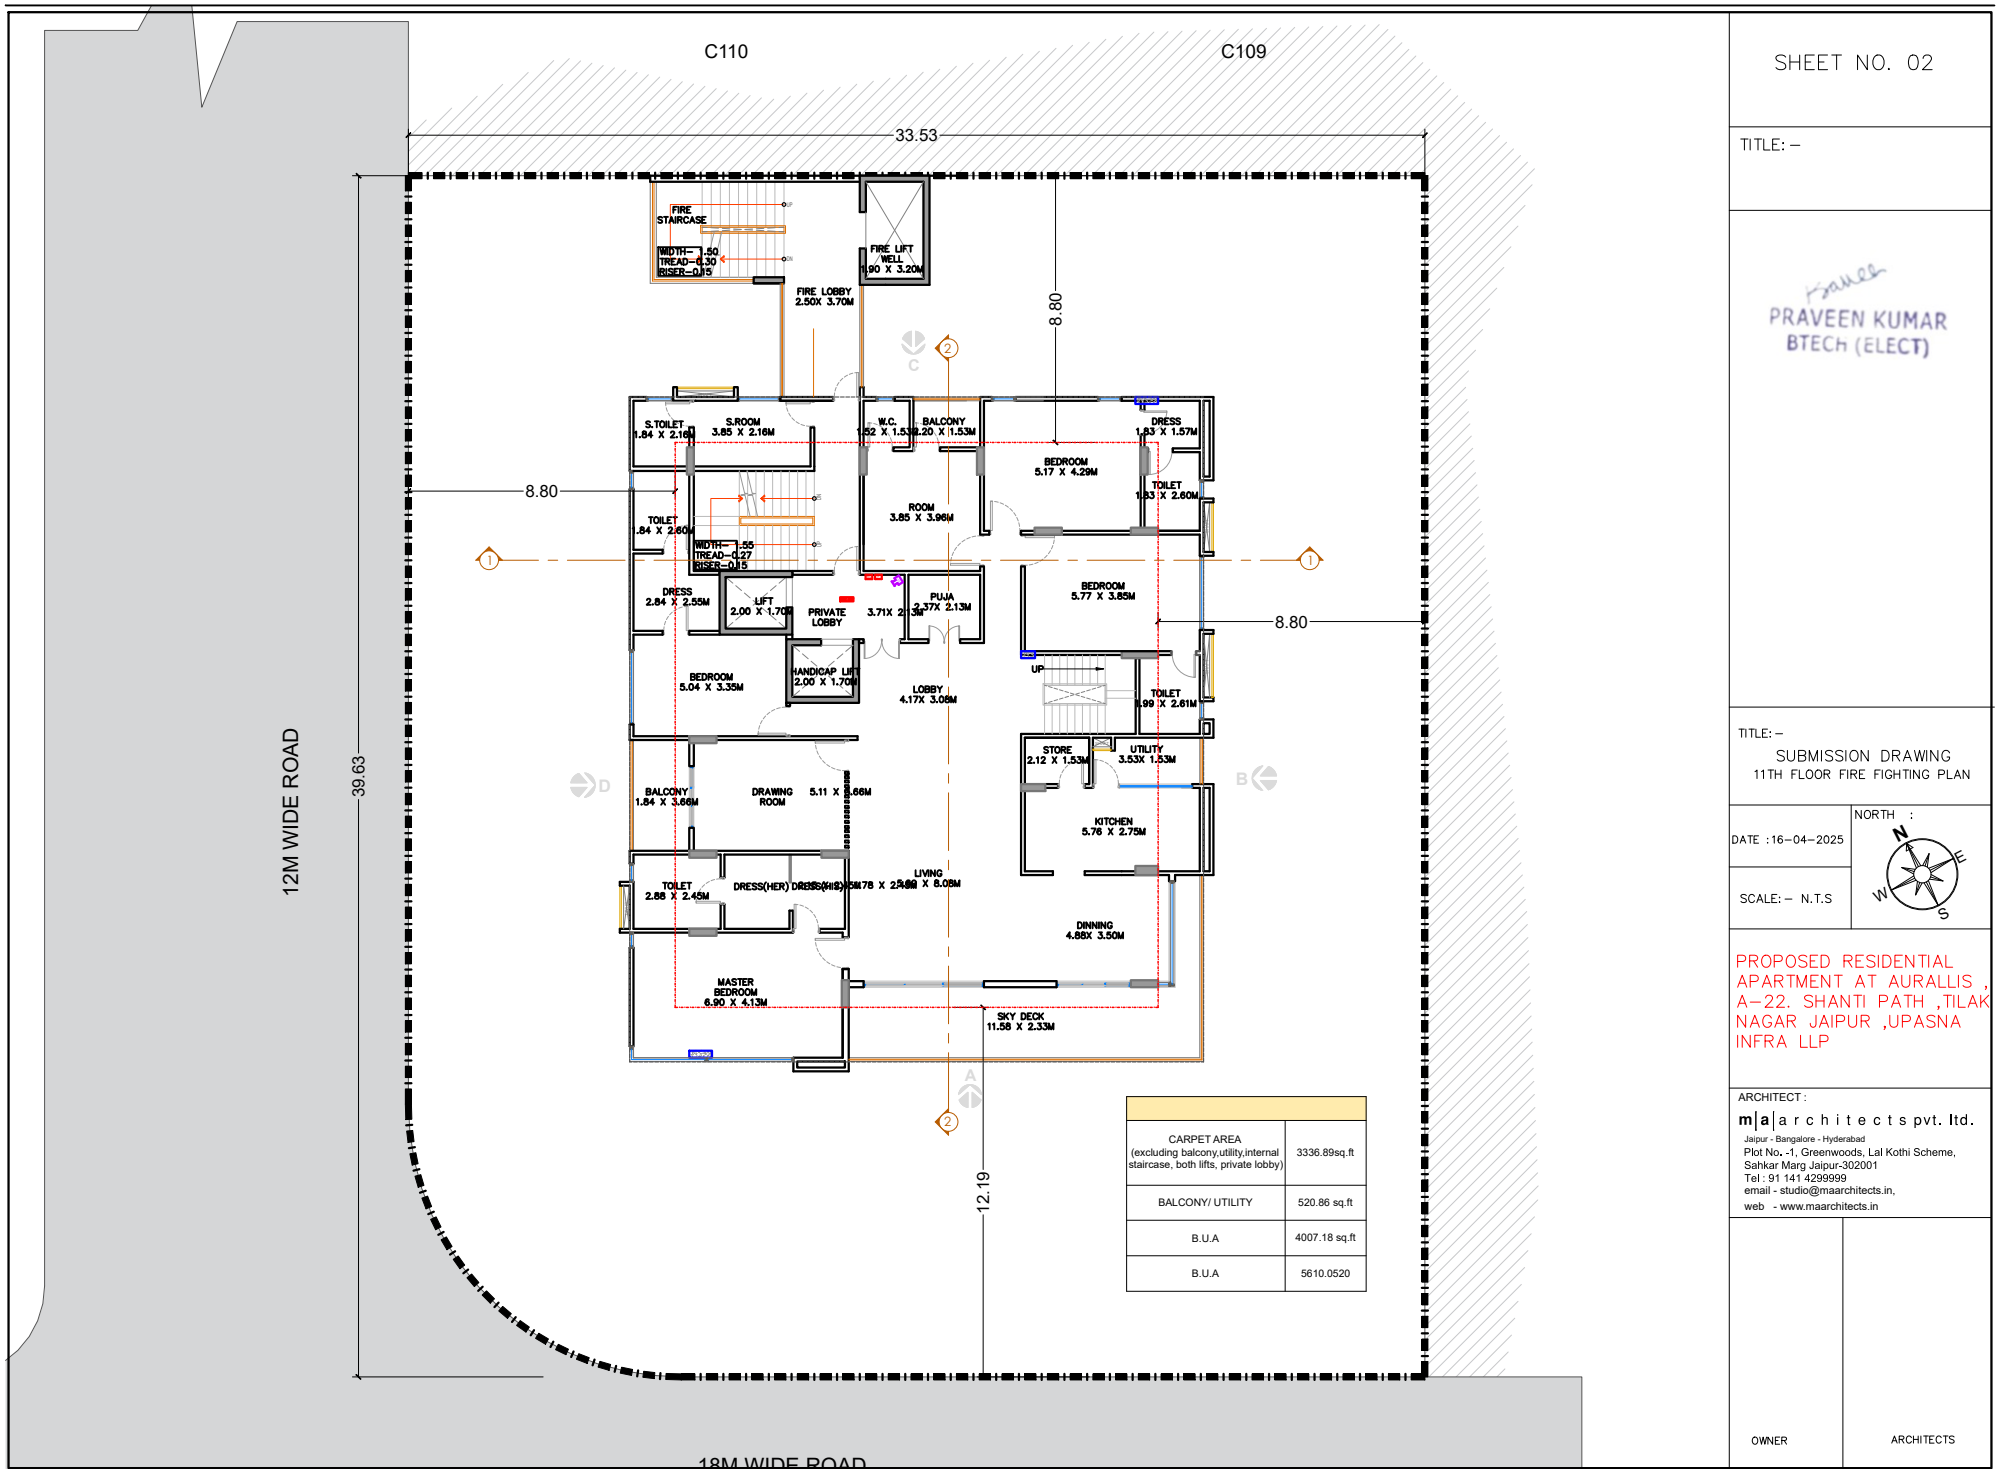


SHEET NO. 02

TITLE: -

Praveen
PRAVEEN KUMAR
BTECH (ELECT)

TITLE: -
SUBMISSION DRAWING
11TH FLOOR FIRE FIGHTING PLAN

DATE : 16-04-2025

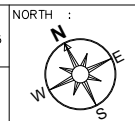


SCALE: - N.T.S

PROPOSED RESIDENTIAL
APARTMENT AT AURALLIS ,
A-22. SHANTI PATH ,TILAK
NAGAR JAIPUR ,UPASNA
INFRA LLP

ARCHITECT :
m|a|architects pvt. ltd.
Jaipur - Bangalore - Hyderabad
Plot No. -1, Greenwood, Lal Kothi Scheme,
Sahkar Marg Jaipur-302001
Tel : 91 141 4299999
email - studio@maarchitects.in,
web - www.maarchitects.in

OWNER

ARCHITECTS

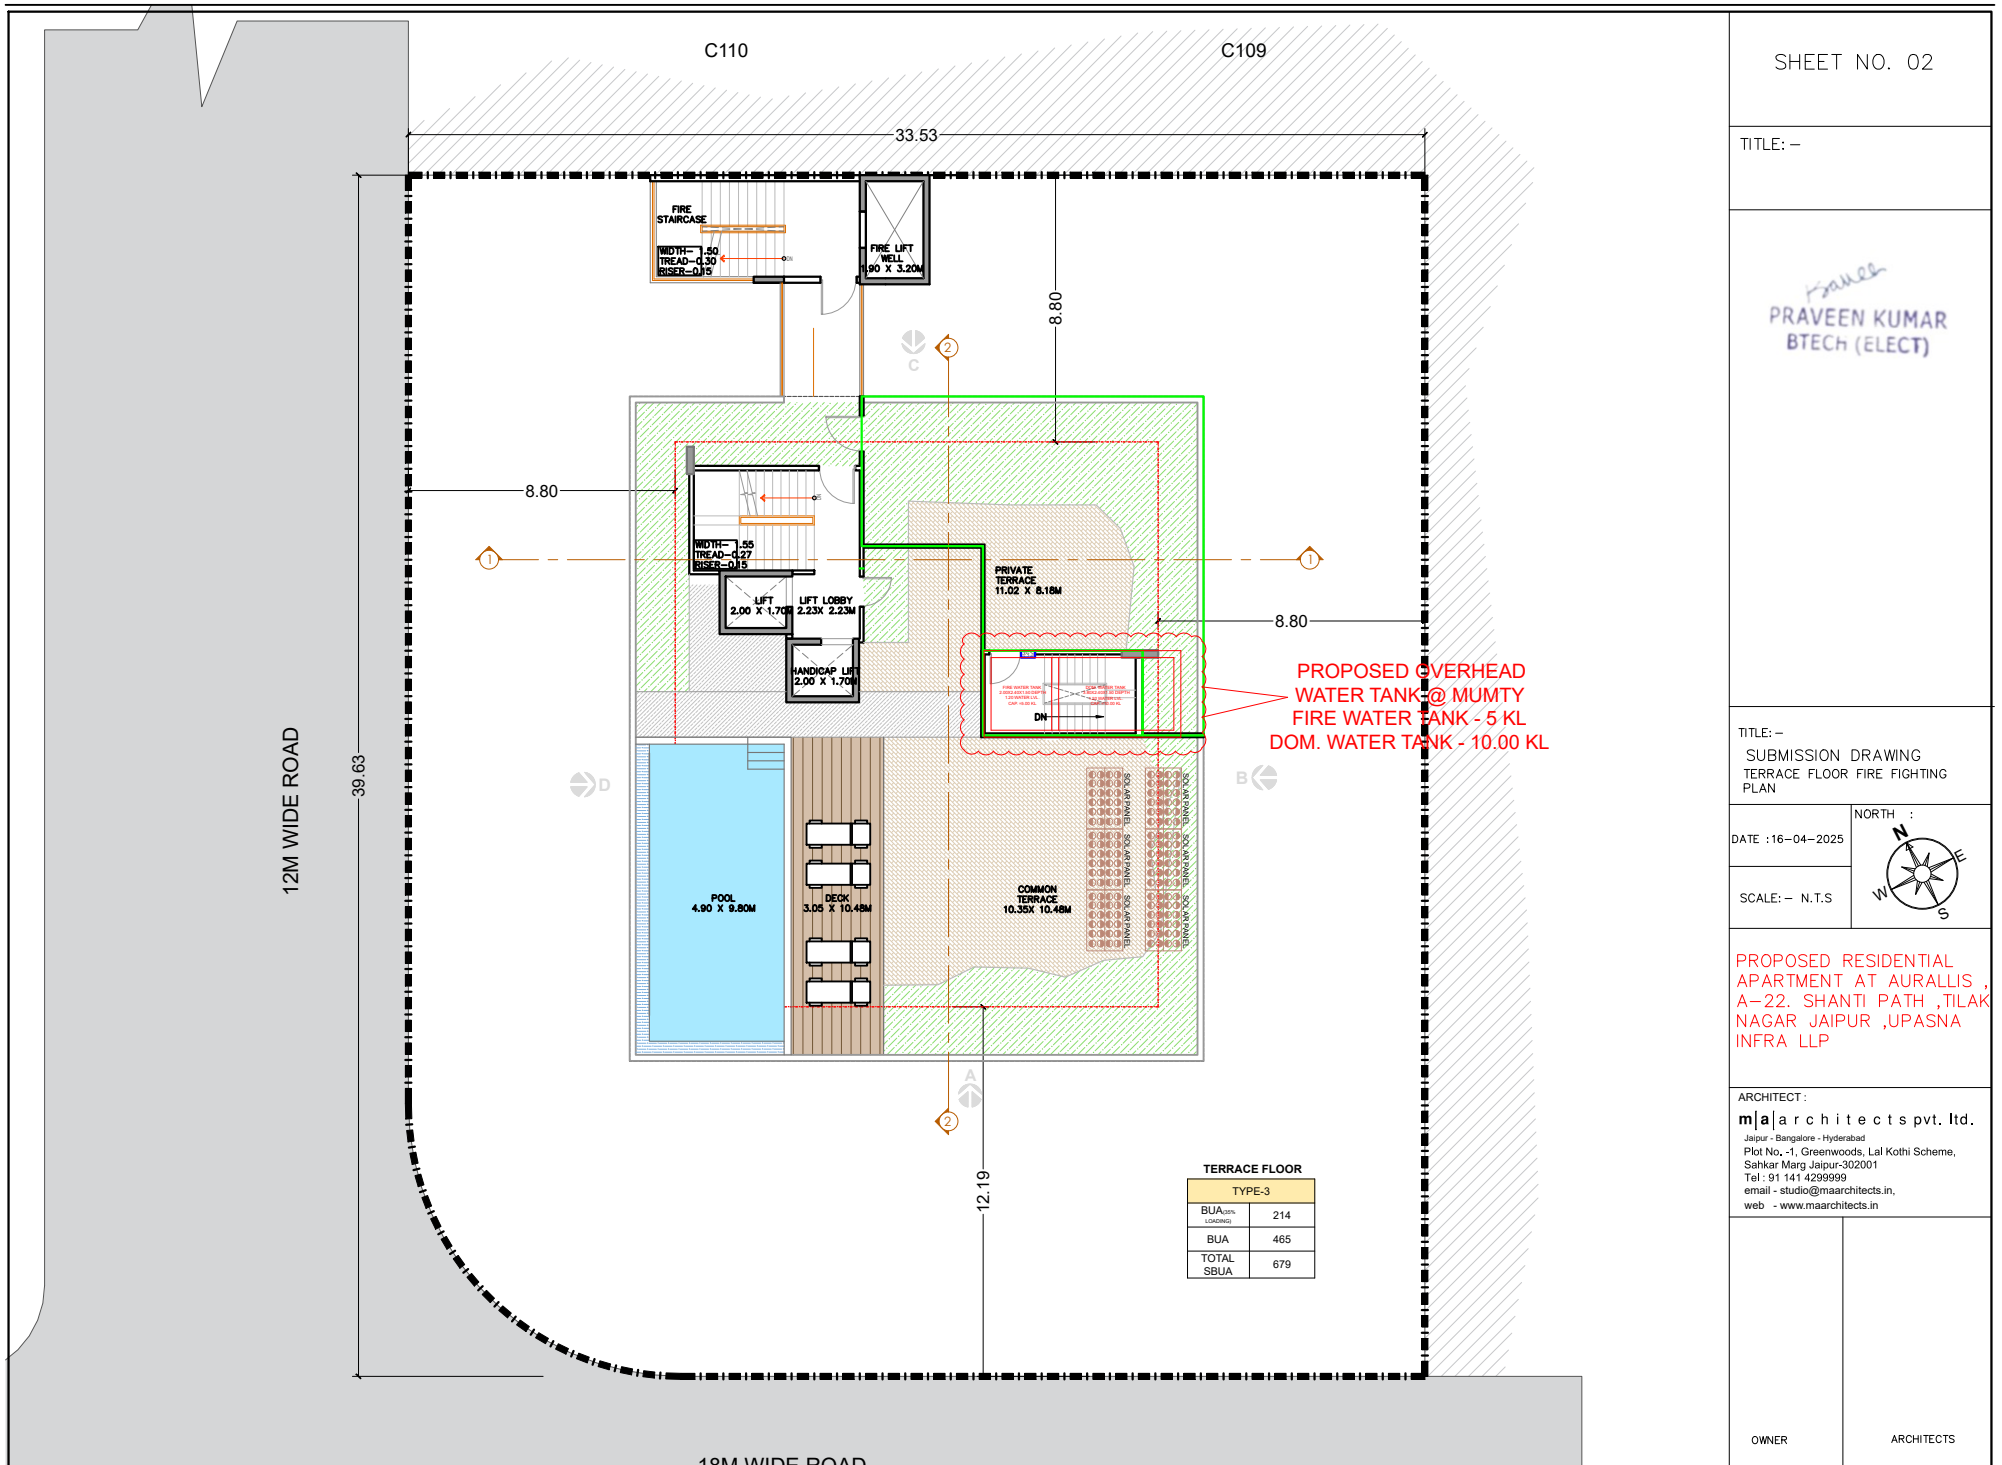

SHEET NO. 02


TITLE: -

Praveen
PRAVEEN KUMAR
BTECH (ELECT)

TITLE: -
SUBMISSION DRAWING
TERRACE FLOOR FIRE FIGHTING
PLAN

DATE : 16-04-2025

SCALE: - N.T.S.

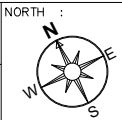

PROPOSED RESIDENTIAL
APARTMENT AT AURALLIS ,
A-22, SHANTI PATH ,TILAK
NAGAR JAIPUR ,UPASNA
INFRA LLP

ARCHITECT :
m|a|architects pvt. ltd.
Jaipur - Bangalore - Hyderabad
Plot No. -1, Greenwoods, Lal Kothi Scheme,
Sahkar Marg Jaipur-302001
Tel : 91 141 4299999
email - studio@maarchitects.in,
web - www.maarchitects.in