


PROJECT NAME :
BALAJI AASHIYANA I

DEVELOPER NAME :
BALAJI BUILDER

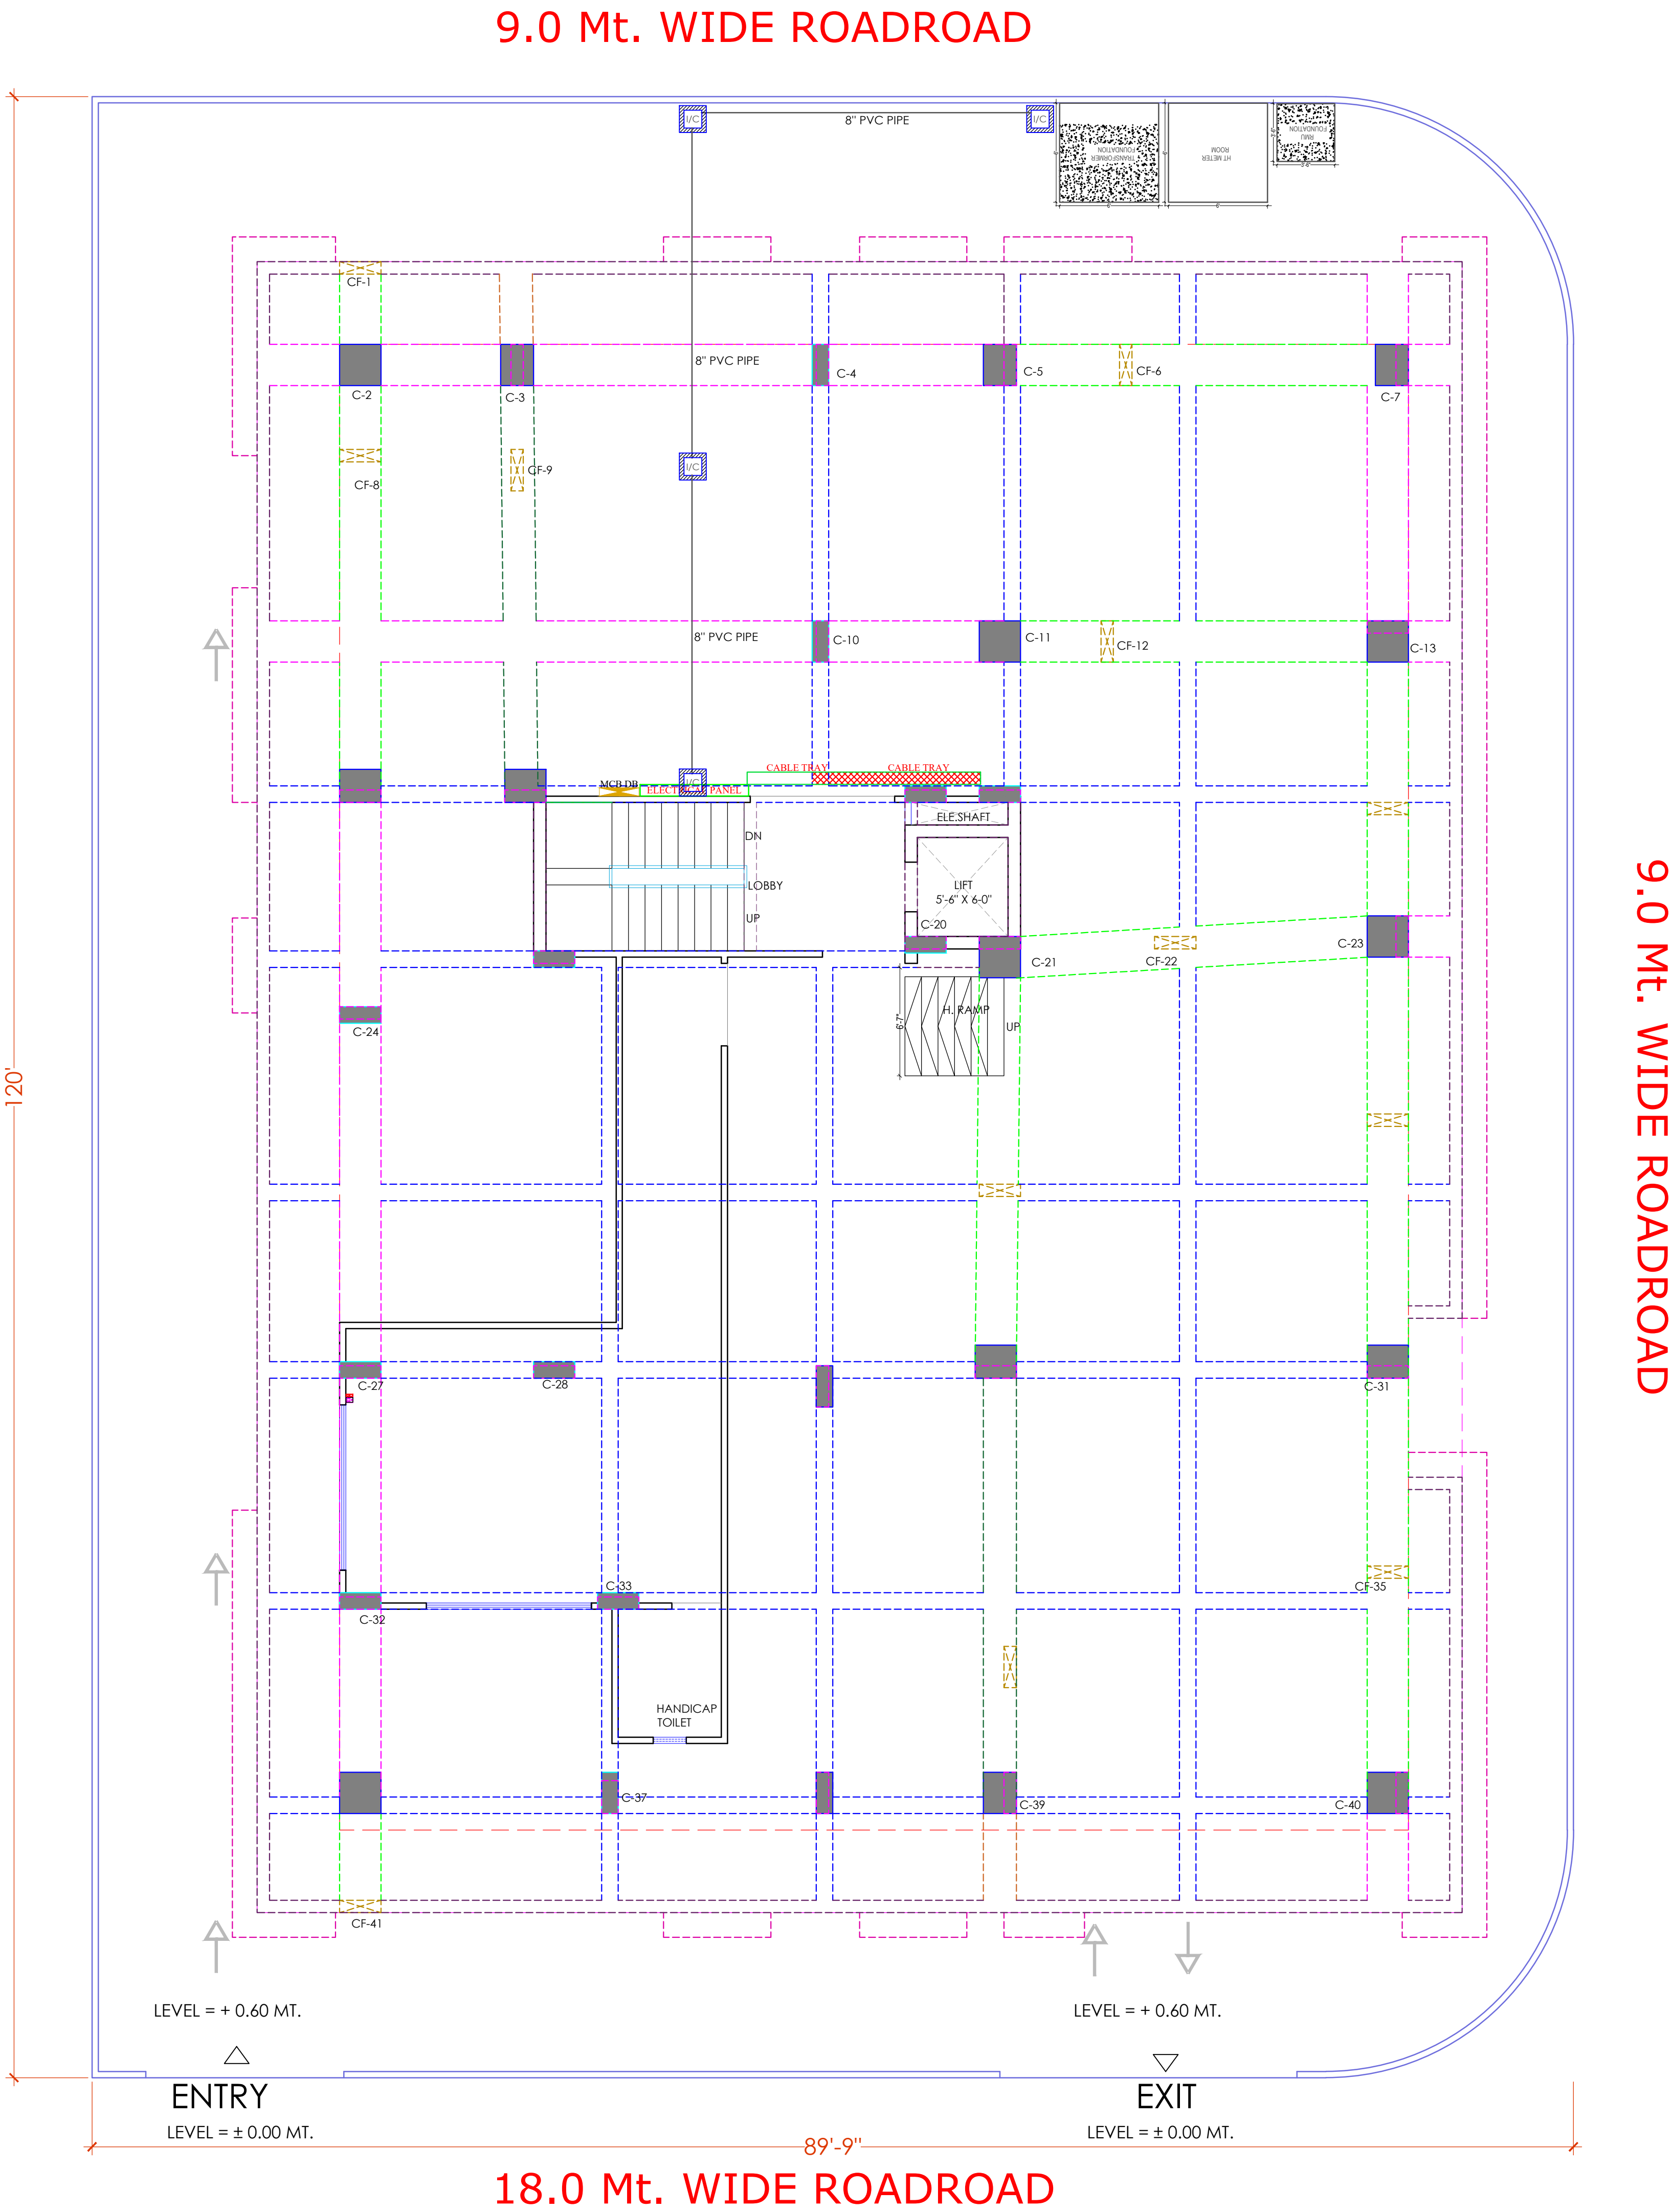

LEGENDS:		
Mounting Height	ID	Symbol Description
CEILING	FAN48"	CEILING FAN 48"
CEILING	FAN30"	CEILING FAN 30"
CEILING	CHI	CHANDELLIER
+93"	TL/W	Led Wall Tube Light
+93"	BULB	Led Bulb 20W
+93"	GL	WALL BRACKETS AS DESIGN FOR GANESH LIGHT
+78"	ML	12x2 Led Mirror Light
CEILING	DL	Led 6" Down Lighter 20W (Surface Mounted)
VENTILATOR HT.	CR	CEILING ROSE
VENTILATOR HT.	EXF	9" DIA FRESH AIR FAN
+24"	2wSB	2w SWITCH BOARD
+42"	SB	SWITCH BOARD/NA SOCKET & SWITCH
+24"	TEL	TELEPHONE POINT
+24"	LP TEL	6 A PLUG POINT FOR TELEPHONE
+48"	TV	TV COAXIAL POINT
+48"	LP TV	6 A PLUG POINT FOR TV
+24"	LP	6 A PLUG POINT FOR SIDE TABLE
+72"	LP/CH	6 A PLUG POINT FOR CHIMNEY
+12"	LP/PC	6 A PLUG FOR COMPUTER POINT
+93"	SAC	SPLIT AC INDOOR UNIT
+42"	PP-MIX	16 A POWER POINT FOR MIXER
+42"	PP-MIC	16 A POWER POINT FOR MICROWAVE
+78"	PP-G	16 A POWER POINT FOR GEYSER
+54"	PP-F	16 A POWER POINT FOR FRIDGE
+78"	PP-WP	16 A POWER POINT FOR WATER PURIFIER
+48"	PP-WM	16 A POWER POINT FOR WASHING MACHINE
+12"	PP-INV	16 A POWER POINT FOR INVERTOR
+93"	PP-AC	25A SWITCH/MCB FOR AC
	UC	CHAMBER/UT X 2)
+18"		6A 2 NOS. SOCKET 11 NOS. 16A SWITCH TELEPHONE/LAN
+60"	MCB DB	MCB DISTRIBUTION BOARD
		CAMERA
		WALL FAN
BSB	6A S/S FAN REGULATOR, TL SWITCH	
BAC	6A S/S, 25 A AC	

S.No	DATE	REVISION DESCRIPTION
GENERAL NOTES :		
1.	All dimensions on this drawing are in MMS System Only written dimensions are to be followed. drawing should not be scaled.	
2.	All measurements must be checked and verified by the contractors prior to execution of work at the site.	
3.	This drawing is to be read in conjunction with all relevant structural, services & facility planning drawings.	
4.	Architectural drawings are to be followed for the location of all structural members & memory walls for sizes & reinforcement details of structural members, relevant structural drawings are to be referred.	
5.	Any discrepancies between architectural, structural and services drawings must be brought to the notice of the architect immediately & prior to execution at site.	
6.	Coordinate with services such as hvac, plumbing & electrical etc. at the responsibility of the contractor.	
7.	All memory walls should be aligned with the columns as indicated on the plan, irrespective of the position as calculated with the dimensions.	
8.	For details, refer relevant large scale detail drawings as indicated.	

PROJECT:
PROPOSED RESIDENTIAL FLATS
ON PLOT. NO. 51,52,60,61
SCHEME-NO. 17 LAXMAN REKHA

NAME OF DRAWING:
STILT FLOOR ELECTRIC SUB-STATION,
CABLE CHAMBER, PIPE ROUTE &
LIGHTENING ARRESTER PLAN

DRAWING WORKING DRAWING	NORTH:
PROJECT NO. :	DATE : 20-08-2024
SCALE : NTS	REV NO. : R-0
DRAWING NO. : PROJECT CATEGORY BLOCK FLOOR TYPE NUMBER A-01	


Er. SANJEEV SHARMA
B.E (Electrical)

For BALAJI BUILDERS
Proprietor

STILT FLOOR ELECTRIC SUB-STATION,
CABLE CHAMBER, PIPE ROUTE &
LIGHTENING ARRESTER PLAN

PROJECT NAME :
BALAJI AASHIYANA I

DEVELOPER NAME :
BALAJI BUILDER

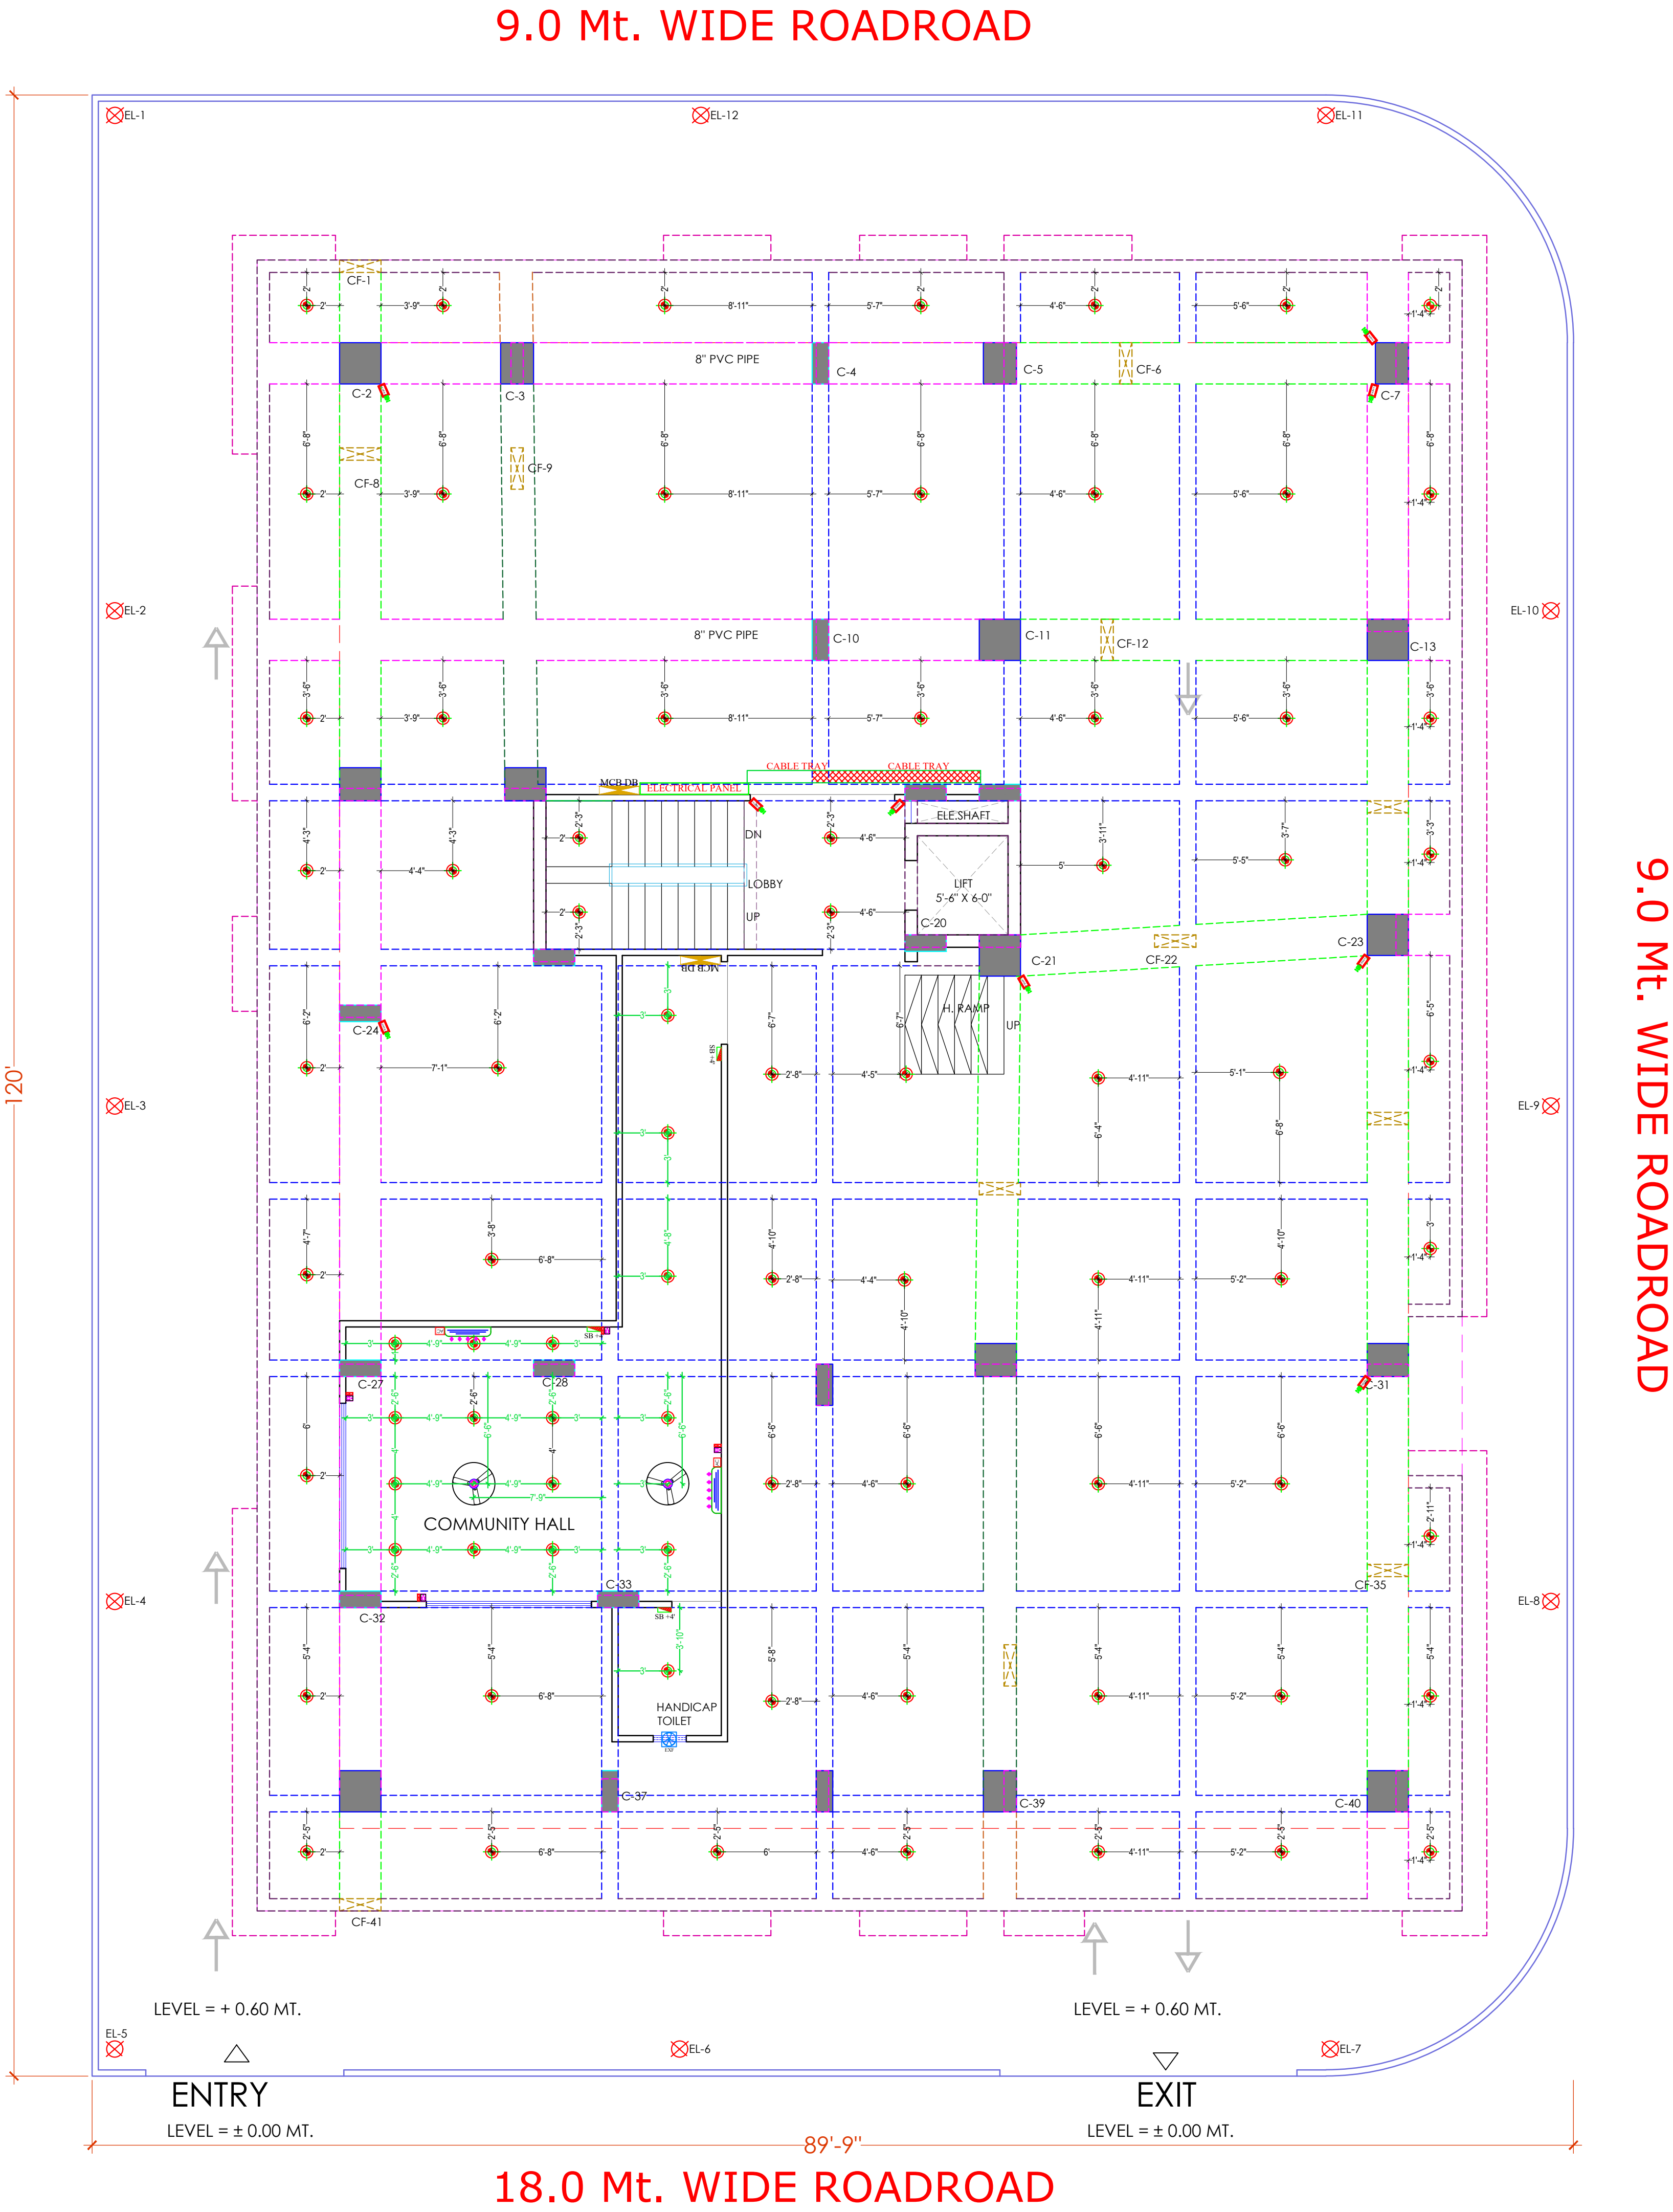

LEGENDS:			
Mounting Height	ID	Symbol	Description
CEILING	FAN 48"		CEILING FAN 48"
CEILING	FAN 30"		CEILING FAN 30"
CEILING	CHI		CHANDELER
+93"	TL/W		Lea Wall Tube Light
+93"	BULB		Lea Bulb 20W
+93"	GL		WALL BRACKETS AS DESIGN FOR GANESH LIGHT
+78"	ML		12x2 Lea Mirror Light
CEILING	DL		Lea 6" Down Lighter 20W (Surface Mounted)
VENTILATOR HT.	CR		CEILING ROSE
VENTILATOR HT.	EXF		9" DIA FRESH AIR FAN
+24"	2xSB		2xSWITCH BOARD
+42"	SB		SWITCH BOARD 6A SOCKET & SWITCH
+24"	TEL		TELEPHONE POINT
+24"	LP TEL		6 A PLUG POINT FOR TELEPHONE
+48"	TV		TV COAXIAL POINT
+48"	LP TV		6 A PLUG POINT FOR TV
+24"	LP		6 A PLUG POINT FOR SIDE TABLE
+72"	LP CH		6 A PLUG POINT FOR CHIMNEY
+12"	LP PC		6 A PLUS FOR COMPUTER POINT
+93"	SAC		SPLIT AC INDOOR UNIT
+42"	PP-MIX		16 A POWER POINT FOR MIXER
+42"	PP-MIC		16 A POWER POINT FOR MICROWAVE
+54"	PP-F		16 A POWER POINT FOR FRIDGE
+78"	PP-WP		16 A POWER POINT FOR WATER PURIFIER
+48"	PP-WM		16 A POWER POINT FOR WASHING MACHINE
+12"	PP-INV		16 A POWER POINT FOR INVERTOR
+93"	PP-AC		25A SWITCH MCB FOR AC
			CHAMBER (2' X 7')
+18"			6A 3 NOS. SOCKET + 1 NOS. (6A SWITCH, TELEPHONE LAN
+60"	MCB DB		MCB DISTRIBUTION BOARD
			CAMERA
			WALL FAN
BSB	6A S/S FAN REGULATOR, T.L. SWITCH		
BAC	6A S/S, 25 A AC		
	EL (EXTERNAL LIGHT)		


S.NO.	DATE	REVISION DESCRIPTION
GENERAL NOTES:		
1.	All dimension on this drawing are in MMS System. Only written dimensions are to be followed. Drawing should not be scaled.	
2.	All measurements must be checked and verified by the contractors prior to execution of work at the site.	
3.	This drawing is to be read in conjunction with all relevant structural, services & facility planning drawings.	
4.	Architectural drawings are to be followed for the location of all structural members & masonry walls, for sizes & reinforcement details of structural members, relevant structural drawings are to be referred.	
5.	Any discrepancies between architectural, structural and services drawings must be brought to the notice of the architects immediately & prior to execution at site.	
6.	Coordinate with services such as: HVAC, plumbing & electrical, etc. is the responsibility of the contractor.	
7.	All masonry walls should be designed with the columns as indicated on the plan, irrespective of the position as calculated with the dimensions.	
8.	For details, refer relevant large scale detail drawings, as indicated.	

PROJECT:

PROPOSED RESIDENTIAL FLATS ON PLOT. NO. 51,52,60,61 SCHEME-NO. 17 LAXMAN REKHA

NAME OF DRAWING:

 STILT FLOOR EXTERNAL LIGHTING, CEILING ELECTRICAL LAYOUT, ELECTRICAL POINT DRAWING, CAMERA POINT DRAWING

DRAWING		NORTH:													
WORKING DRAWING															
PROJECT NO. :		DATE :													
		20-08-2024													
SCALE :		REV NO. :													
NTS		R-0													
DRAWING NO. :															
<table border="1"><tr><td>PROJECT</td><td>CATEGORY</td><td>BLOCK</td><td>FLOOR</td><td>TYPE</td><td>NUMBER</td></tr><tr><td></td><td>-</td><td>-</td><td></td><td></td><td></td></tr></table>				PROJECT	CATEGORY	BLOCK	FLOOR	TYPE	NUMBER		-	-			
PROJECT	CATEGORY	BLOCK	FLOOR	TYPE	NUMBER										
	-	-													
A-01															
DRAWING PATH :															

Er. SANJEEV SHARMA
B.E (Electrical)

For BALAJI BUILDERS
Proprietor

STILT FLOOR EXTERNAL LIGHTING, CEILING ELECTRICAL LAYOUT,
ELECTRICAL POINT DRAWING, CAMERA POINT DRAWING,

9.0 Mt. WIDE ROADROAD



For BALAJI BUILDERS
21/11/24
Proprietor

**STILT FLOOR LV CONDUIT PLAN,
STILT FLOOR ELECTRIC CONDUIT PLAN,
CABLE TRAY,ELECTRICAL PANAL,MCB DB**

PROJECT NAME :
BALAJI AASHIYANA I

DEVELOPER NAME :
BALAJI BUILDER

LEGENDS:			
Mounting Height	I/D	Symbol	Description
CEILING	FAN48"		CEILING FAN 48"
CEILING	FAN30"		CEILING FAN 30"
CEILING	CHI		CHANDIELER
	+93"		12' Wall Tube Light
	+93"		12' Bulb 20W
	+93"		WALL BRACKETS AS DESIGN FOR GANESH LIGHT
	+78"		12x2 Led Mirror Light
CEILING	DL		Led 6" Down Lighter 20W (Starline) Light
VENTILATOR HT	CR		CEILING ROSE
VENTILATOR HT	EXP		9" DIA FRESH AIR FAN
	+24"		2-SWITCH BOARD
	+42"		SWITCH BOARD/NA SOCKET & SWITCH
	+24"		TELEPHONE POINT
	+24"		6 A PLUG POINT FOR TELEPHONE
	+48"		TV COAXIAL POINT
	+48"		6 A PLUG POINT FOR TV
	+24"		6 A PLUG POINT FOR SIDE TABLE
	+72"		6 A PLUG POINT FOR CHIMNEY
	+12"		6 A PLUG FOR COMPUTER POINT
	+93"		SPLIT AC INDOOR UNIT
	+42"		16 A POWER POINT FOR MIXER
	+42"		16 A POWER POINT FOR MICROWAVE
	+78"		16 A POWER POINT FOR GEYSER
	+54"		16 A POWER POINT FOR FRIDGE
	+78"		16 A POWER POINT FOR WATER PURIFIER
	+48"		16 A POWER POINT FOR WASHING MACHINE
	+12"		16 A POWER POINT FOR INVERTER
	+93"		25A SWITCH MCB FOR AC
			CHAMBER(2" X 2")
+18"			4x2 NO. SOCKET + 1 NO. NA SWITCH, TELEPHONE POINT
+60"	MCB DB		MCB DISTRIBUTION BOARD
			CAMERA
			WALL FAN
BSB	6A 5/5 FAN REGULATOR, L SWITCH		
BAC	6A 5/5, 25 A AC		

No	DATE	REVISION DESCRIPTION
GENERAL NOTES :		
1.	All dimensions on this drawing are in MM System Only written dimensions are to be followed drawing should not be scaled.	
2.	All measurements must be checked and verified by the contractor prior to execution	
3.	At all the site.	
4.	This drawing is to be read in conjunction with all relevant structural, services & civil planning drawings.	
5.	Architectural drawings are to be followed for the location of all structural members & masonry walls, for kases & reinforcement details of structural members, relevant details are to be referred to relevant drawings.	
6.	Any discrepancies between architectural, structural and services drawings (contradict) to the notice of the architect must be prior to execution at site.	
7.	Co-ordinate with the services such as hvac, plumbing & electrical, etc. as the responsibility of the contractor.	
8.	All masonry walls shall be aligned with the columns as indicated on the plan, irrespective of the position as calculated with the dimensioning.	
9.	For details, refer relevant large scale detail drawings, as indicated.	

PROJECT:
PROPOSED RESIDENTIAL FLATS
ON PLOT. NO. 51,52,60,61
SCHEME-NO. 17 LAXMAN REKHA

NAME OF DRAWING:

STILT FLOOR LV CONDUIT PLAN,
STILT FLOOR ELECTRIC CONDUIT PLAN,
CABLE TRAY,ELECTRICAL PANAL,MCB DB

DRAWING	NORTH:
WORKING DRAWING	
PROJECT NO. :	DATE :
	20-08-2024
SCALE :	REV NO. :
NTS	R-0

DRAWING NO. :

--	--	--

 /

-

 /

-

 /

--	--

 /

--	--

 /

--	--


PROJECT CATEGORY BLOCK FLOOR TYPE NUMBER

A-01

PROJECT NAME :
BALAJI AASHIYANA I

DEVELOPER NAME :
BALAJI BUILDER

9.0 Mt. WIDE ROADROAD

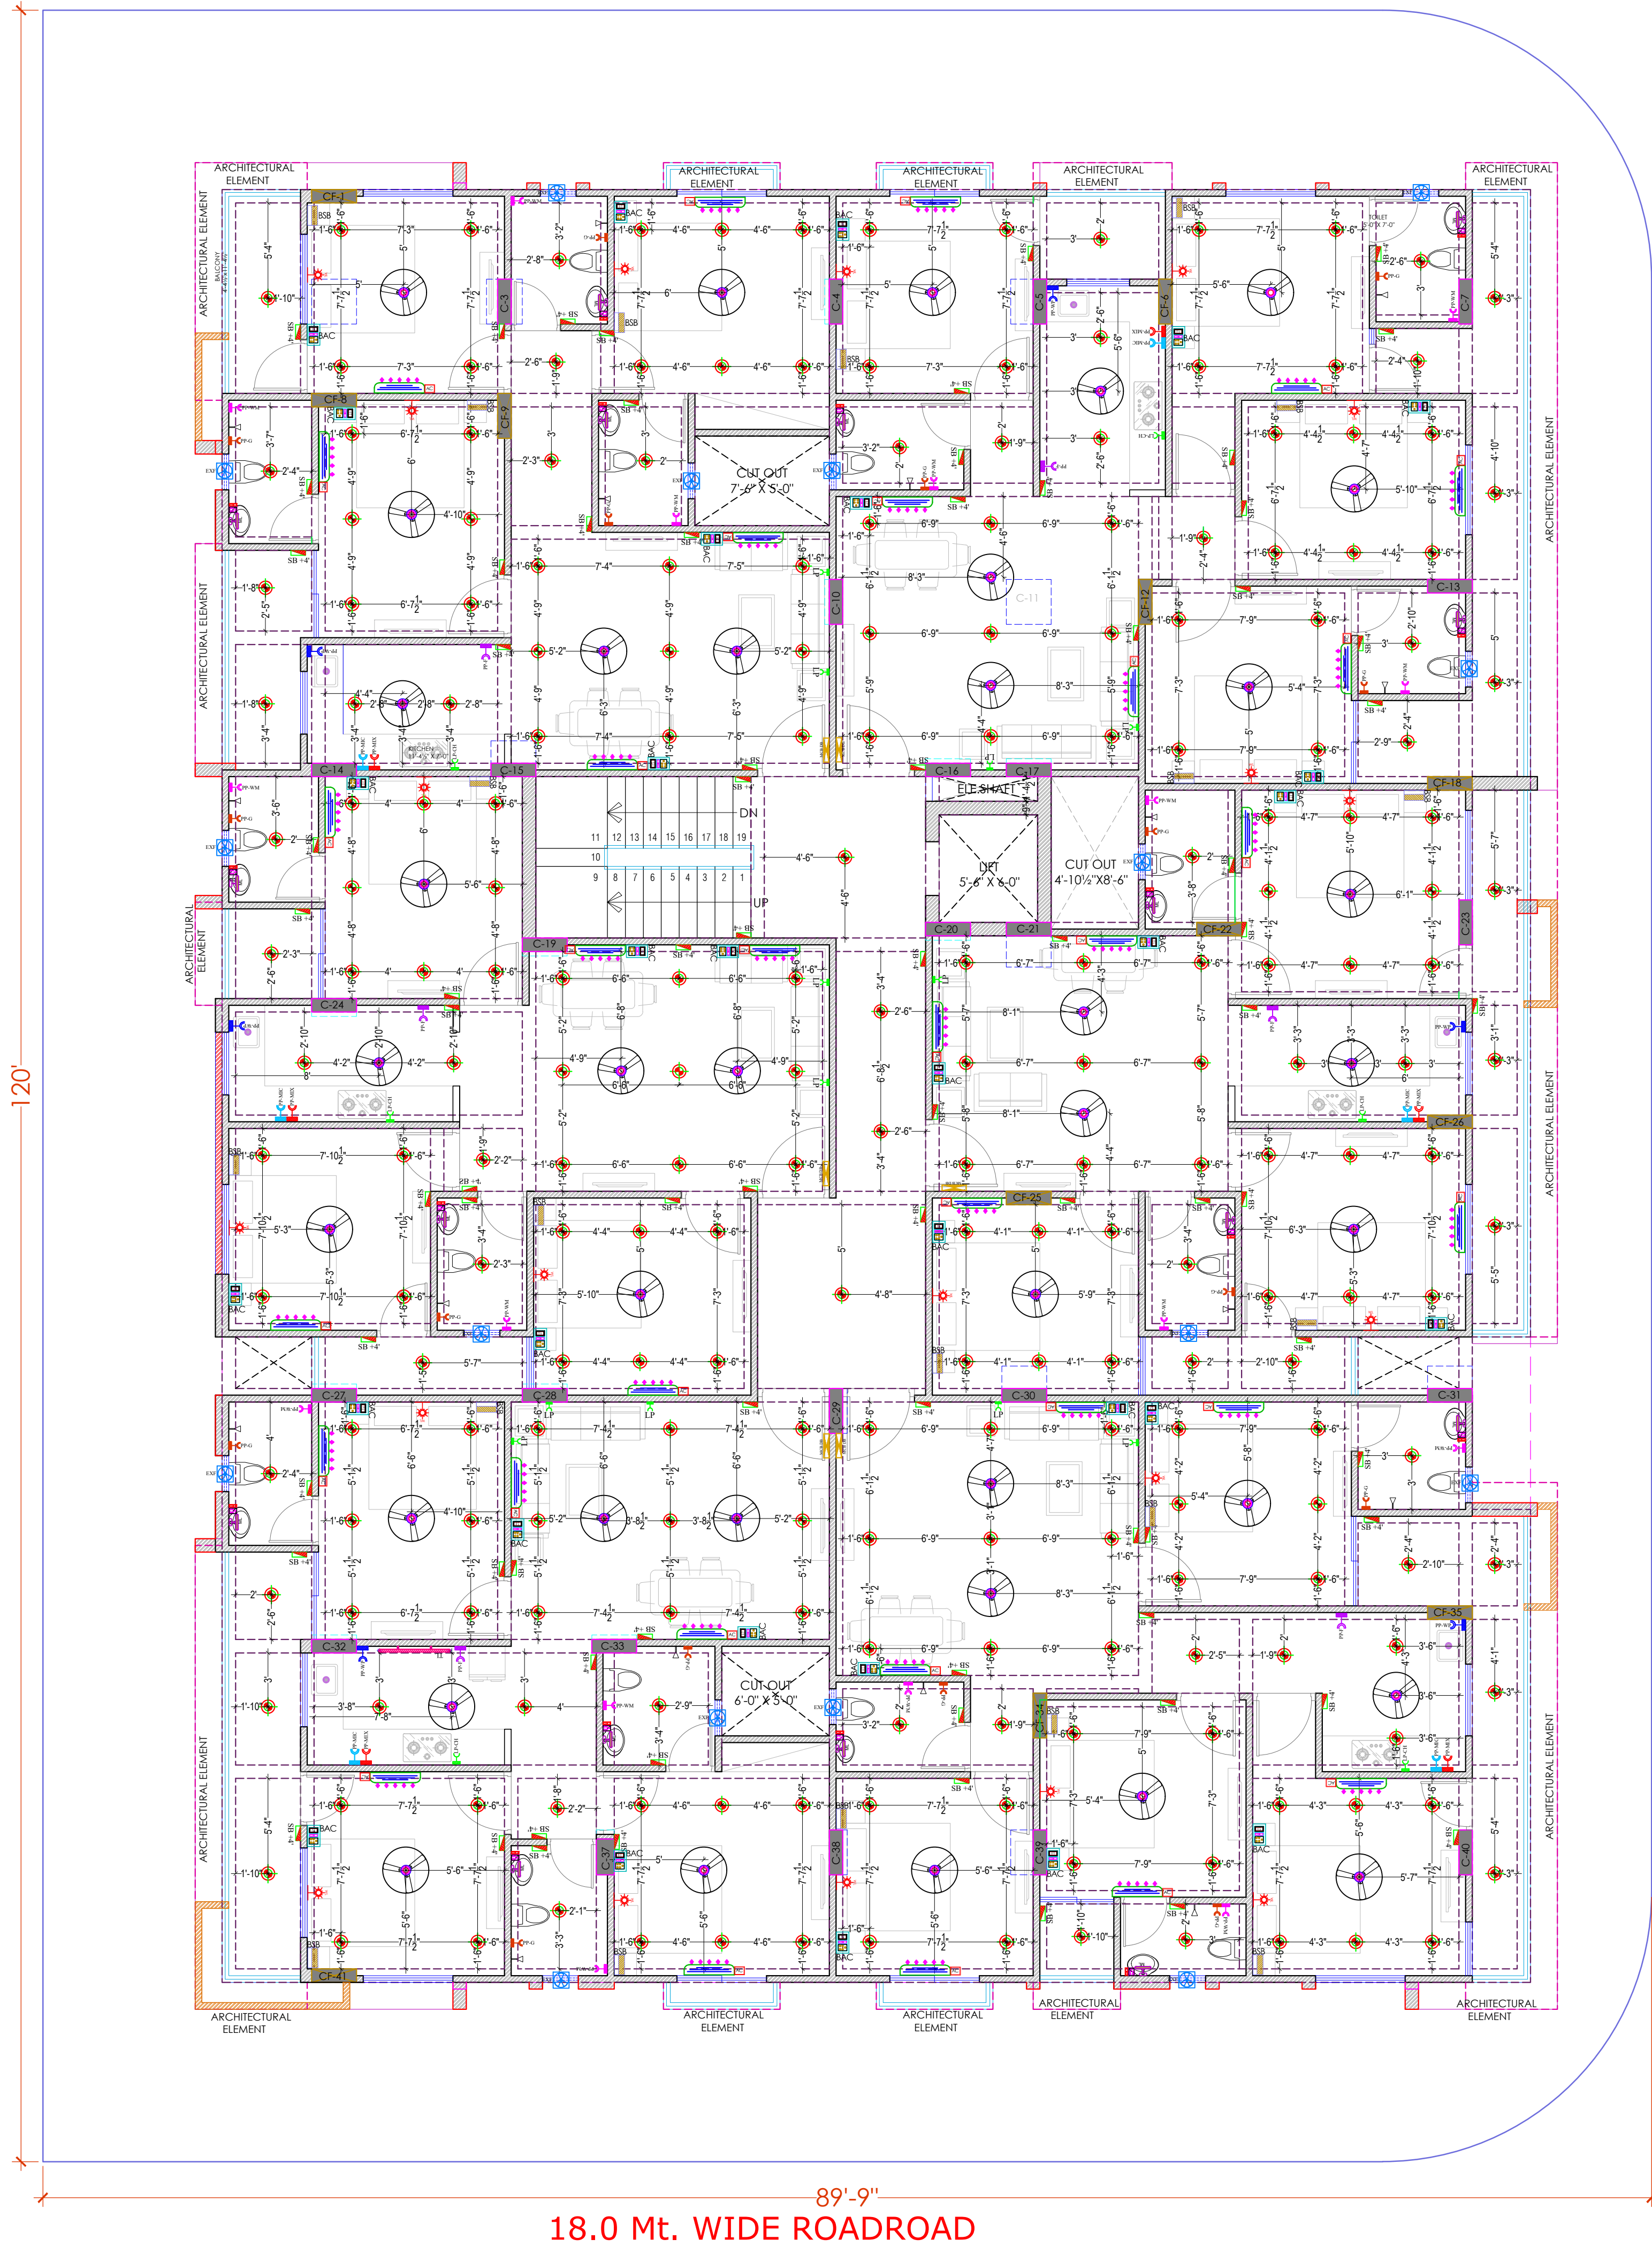

LEGENDS:			
Mounting Height	ID	Symbol	Description
CEILING	FAN48"		CEILING FAN 48"
CEILING	FAN30"		CEILING FAN 30"
CEILING	CHI		CHANDELIER
+93"	TLW		Led Wall Tube Light
+93"	BULB		Led Bulb 20W
+93"	GL		WALL BRACKETS AS DESIGN FOR GANSHI LIGHT
+78"	ML		12x2 Led Mirror Light
CEILING	DL		Led 6" Down Lighter 20W (Surface Mounted)
VENTILATOR HT.	CR		CEILING ROSE
VENTILATOR HT.	EXP		9" DIA FRESH AIR FAN
+24"	2wSB		2w SWITCH BOARD
+42"	SB		SWITCH BOARD/A SOCKET & SWITCH
+24"	TEL		TELEPHONE POINT
+24"	LP TEL		LP PLUG POINT FOR TELEPHONE
+48"	TV		TV COAXIAL POINT
+48"	LP TV		LP PLUG POINT FOR TV
+24"	LP		LP PLUG POINT FOR SIDE TABLE
+72"	LP-CH		LP PLUG POINT FOR CHIMNEY
+12"	LP-PC		LP PLUG POINT FOR COMPUTER/PC
+93"	SAC		SPLIT AC INDOOR UNIT
+42"	PP-MIX		16 A POWER POINT FOR MIXER
+42"	PP-MC		16 A POWER POINT FOR MICROWAVE
+78"	PP-G		16 A POWER POINT FOR GEYSER
+54"	PP-F		16 A POWER POINT FOR FRIDGE
+78"	PP-WP		16 A POWER POINT FOR WASHING MACHINE
+48"	PP-WM		16 A POWER POINT FOR WASHING MACHINE
+12"	PP-INV		16 A POWER POINT FOR INVERTER
+93"	PP-AC		25A SWITCH/MCB FOR AC
			CHAMBER(2 X 2)
+18"			6A 3 NOS SOCKET + 1 NOS 16A SWITCH, TELEPHONE LAN
+60"	MCB DB		MCB DISTRIBUTION BOARD
			CAMERA
			WALL FAN
BSB	6A 5/S FAN REGULATOR, TL SWITCH		
BAC	6A 5/S 25 A AC		

S.NO	DATE	REVISION DESCRIPTION
GENERAL NOTES :		
1.	All dimension on this drawing are in MMS System Only written dimensions are to be followed. Drawing should not be scaled.	
2.	All measurements must be checked and verified by the contractor prior to execution of work at the site.	
3.	This drawing is to be read in conjunction with all relevant structural, services & facility drawing.	
4.	Architectural drawings are to be followed for the location of all structural members & masonry walls, for sizes & reinforcement details of structural members, relevant structural drawings are to be referred.	
5.	Any discrepancies between architectural, structural and services drawings must be brought to the notice of the architect immediately & prior to execution at site. Coordinate with services such as HVAC, plumbing & electrical, etc. in the responsibility of the contractor.	
6.	All masonry walls should be aligned with the columns as indicated on the plan, irrespective of the position as indicated with the dimensioning.	
7.	For details, refer relevant large scale detail drgs, as indicated.	

PROJECT:
PROPOSED RESIDENTIAL FLATS ON PLOT NO. - 51, 52, 60 & 61, LAXMAN REKHA, SCHEME NO- 17, JHOTWARA, JAIPUR, RAJASTHAN.

NAME OF DRAWING:
TYPICAL FLOOR (GROUND TO FIFTH) (ELECTRICAL POINT, CEILING POINT, TV & TELEPHONE RISER DIAGRAM)


DRAWING	NORTH:
WORKING DRAWING	
PROJECT NO. :	DATE : 28, Dec. - 2024
SCALE : NTS	REV NO. : R-0
DRAWING NO. : PROJECT CATEGORY BLOCK FLOOR TYPE NUMBER A-201	

Er. SANJEEV SHARMA
B.E (Electrical)

For BALAJI BUILDERS
Proprietor

TYPICAL FLOOR (GROUND TO FIFTH)
(ELECTRICAL POINT, CEILING POINT,
TV & TELEPHONE RISER DIAGRAM)

MAIN PANEL

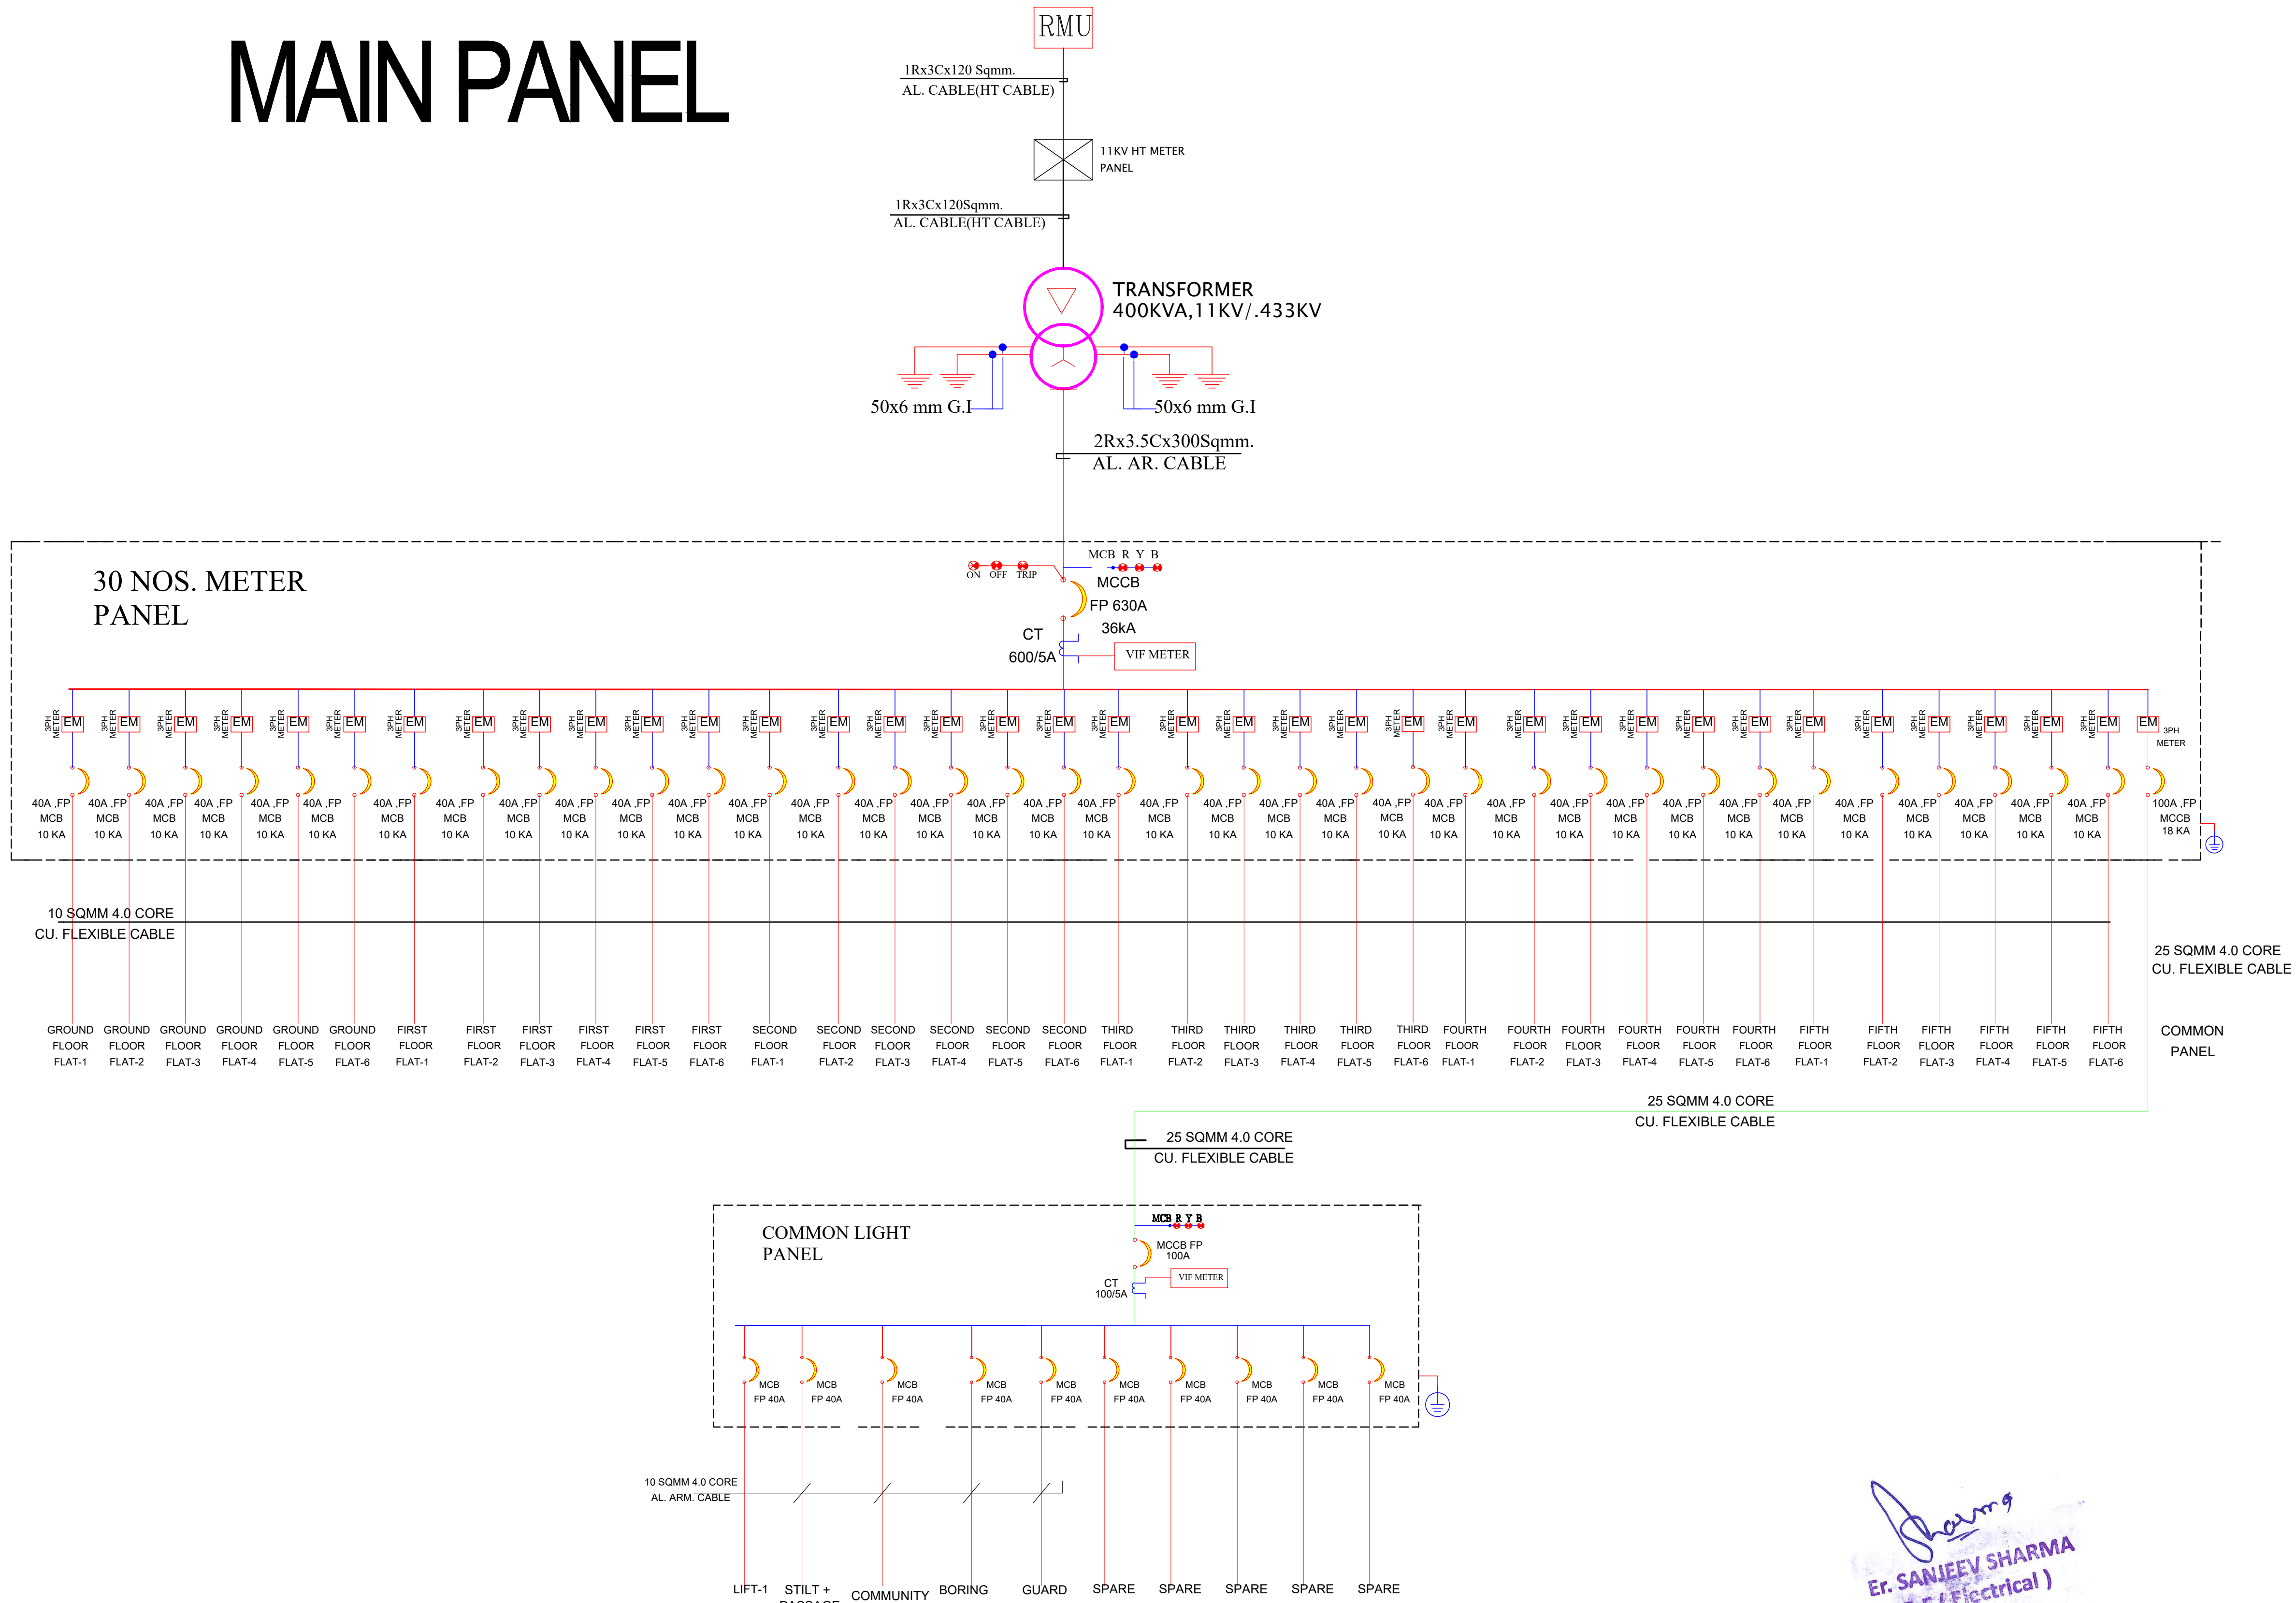

Er. SANJEEV SHARMA
B.E (Electrical)

For BALAJI BUILDERS
12/11/24
Proprietor

MAIN LT PANEL AND SLD DRAWING

PROJECT NAME :

BALAJI AASHIYANA I

DEVELOPER NAME :

BALAJI BUILDER

LEGENDS:

Mounting Height	ID	Symbol	Description
CEILING	FAN48"		CEILING FAN 48"
CEILING	FAN30"		CEILING FAN 30"
CEILING	CH1		CHANDELIER
+93"	TLW		Led Wall Tube Light
+93"	BULB		Led Bulb 20W
+93"	GL		WALL BRACKETS AS DESIGN FOR GANESH LIGHT
+78"	ML		12x2 Led Mirror Light
CEILING	DL		Led 6" Down Lighter 20W (Surface Mounted)
VENTILATOR HT.	CR		CEILING ROSE
VENTILATOR HT.	EXP		9" DIA FRESH AIR FAN
+24"	2wSB		2w SWITCH BOARD
+42"	SB		SWITCH BOARD (6A SOCKET & SWITCH)
+24"	TEL		TELEPHONE POINT
+24"	LP TEL		6 A PLUG POINT FOR TELEPHONE
+48"	TV		TV COAXIAL POINT
+48"	LP TV		6 A PLUG POINT FOR TV
+24"	LP		6 A PLUG POINT FOR SIDE TABLE
+72"	LP CH		6 A PLUG POINT FOR CHIMNEY
+12"	LP PC		6 A PLUG FOR COMPUTER POINT
+93"	SAC		SPLIT AC INDOOR UNIT
+42"	PP-MIX		16 A POWER POINT FOR MIXER
+42"	PP-MIC		16 A POWER POINT FOR MICROWAVE
+78"	PP-G		16 A POWER POINT FOR GEYSER
+54"	PP-F		16 A POWER POINT FOR FRIDGE
+78"	PP-WP		16 A POWER POINT FOR WATER PURIFIER
+48"	PP-WM		16 A POWER POINT FOR WASHING MACHINE
+12"	PP-INV.		16 A POWER POINT FOR INVERTER
+93"	PP-AC		25A SWITCH MCB FOR AC
	I/C		CHAMBER (2" X 2")
+18"			6A 2 NOS. SOCKET + 1 NOS. 16A SWITCH TELEPHONE LAN
+60"	MCB DB		MCB DISTRIBUTION BOARD
			CAMERA
			WALL FAN

BSB 6A S/S FAN REGULATOR, TL SWITCH

BAC 6A S/S, 25 A AC

S.No DATE REVISION DESCRIPTION

GENERAL NOTES:

- All dimension on this drawing are in MKS System. Only written dimensions are to be followed. Drawing should not be scaled.
- All measurements must be checked and verified by the contractors prior to execution of work at the site.
- This drawing is to be read in conjunction with all relevant structural, services & facility planning drawings.
- Architectural drawings are to be followed for the location of all structural members & masonry walls, for sizes & reinforcement details of structural members, relevant structural drawings are to be referred.
- Any discrepancies between architectural, structural and services drawings must be brought to the notice of the architects immediately & prior to execution at site.
- Co-ordination with services such as hvac, plumbing & electrical, etc. is the responsibility of the contractor.
- All masonry walls should be aligned with the columns as indicated on the plan, irrespective of the position as calculated with the dimensioning.
- For details, refer relevant large scale detail drgs. as indicated.

PROJECT:

PROPOSED RESIDENTIAL FLATS ON PLOT NO.- 51, 52, 60 & 61, LAXMAN REKHA, SCHEME NO- 17, JHOTWARA, JAIPUR, RAJASTHAN.



NAME OF DRAWING:

MAIN LT PANEL AND SLD DRAWING

DRAWING	NORTH:
WORKING DRAWING	
PROJECT NO.:	DATE:
	28, Dec. - 2024
SCALE:	REV NO.:
NTS	R-0
DRAWING NO.:	
PROJECT CATEGORY BLOCK FLOOR TYPE NUMBER	
A-201	

PROJECT NAME :
BALAJI AASHIYANA I

DEVELOPER NAME :
BALAJI BUILDER

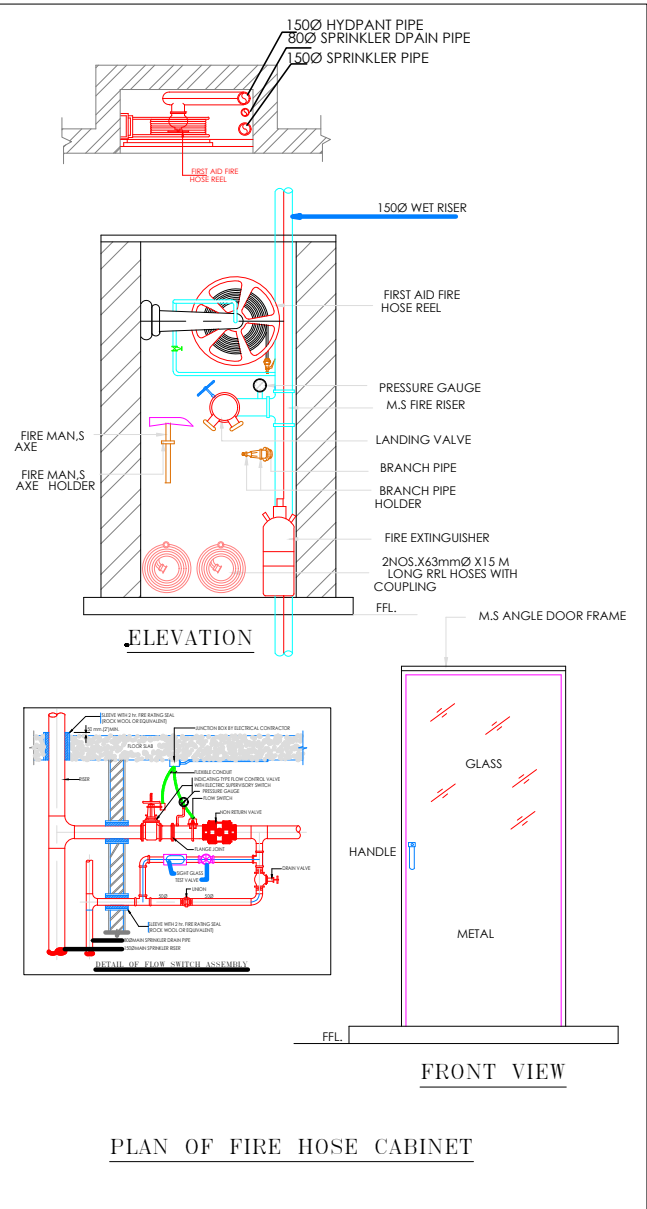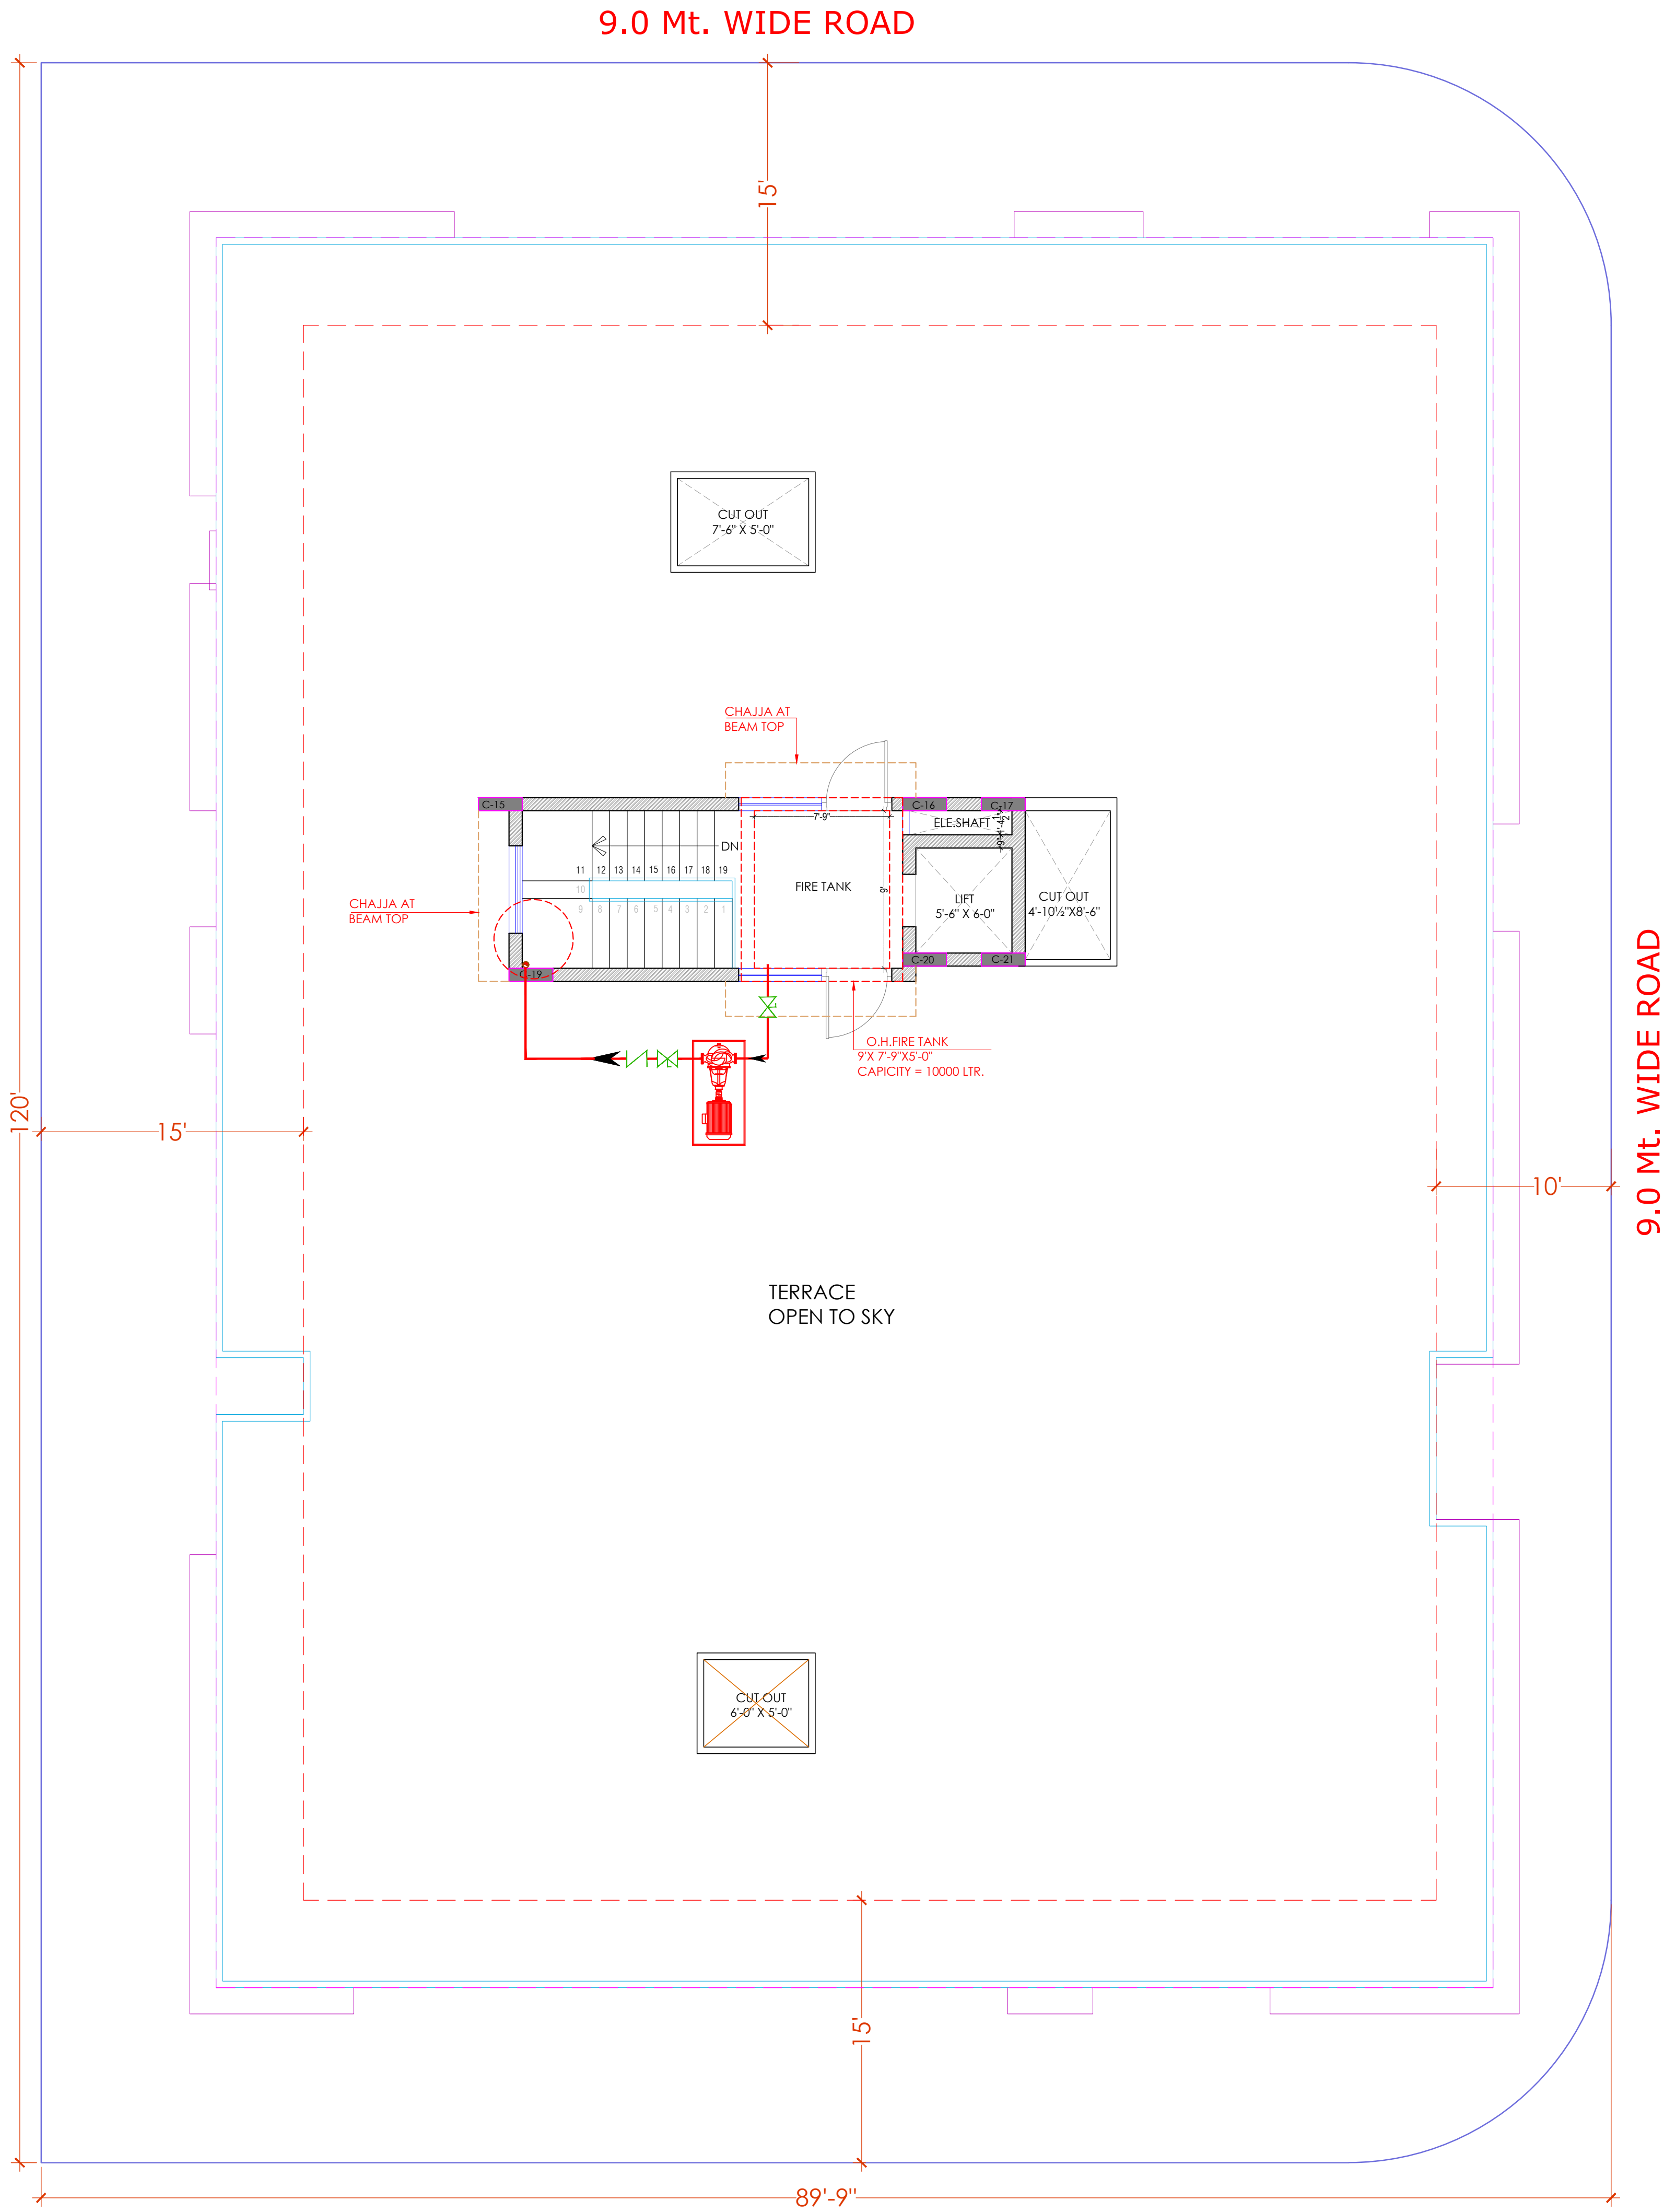

LEGEND:-

FIRE HYDRANT MS PIPE	—
BALL VALVE	⊞
EXTERNAL FIRE HYDRANT	⊞
EXTERNAL FIRE HOSE CABINAT	⊞ EFHC
FIRE HOSE CABINAT	⊞ FHC
UPRIGHT SPRINKLER HEAD	⊞
PENDENT SPRINKLER HEAD	⊞
SIDE WALL SPRINKLER HEAD	⊞
FIRE EXINGUISHER	⊞
FLOW SWITCH	⊞ FS
ISOLATION VALVE	⊞ IV
2 WAY FIRE BRIGADE INLET	⊞

- S.No DATE REVISION DESCRIPTION
- GENERAL NOTES :
- All dimension on this drawing are in MKS System Only written dimensions are to be followed drawing should not be scaled.
 - All measurements must be checked and verified by the contractors prior to execution of work at the site.
 - This drawing is to be read in conjunction with all relevant structural, services & facility planning drawings.
 - Architectural drawings are to be followed for the location of all structural members & masonry walls, for sizes & reinforcement details of structural members, relevant structural drawings are to be referred.
 - Any discrepancies between architectural, structural and services drawings must be brought to the notice of the architects immediately & prior to execution at site. Co-ordination with services such as hvac, plumbing & electrical, etc. is the responsibility of the contractor.
 - All masonry walls should be aligned with the columns as indicated on the plan, irrespective of the position as calculated with the dimensioning.
 - For details, refer relevant large scale detail drgs. as indicated.

PROJECT:
PROPOSED RESIDENTIAL FLATS ON PLOT NO.- 51, 52, 60 & 61, LAXMAN REKHA, SCHEME NO- 17,JHOTWARA, JAIPUR, RAJASTHAN.

NAME OF DRAWING:
TARRACE FLOOR FIGHTING PLAN, FIRE SCHEMATIC LAYOUT

DRAWING WORKING DRAWING	NORTH:
PROJECT NO. : DATE : 06, Mar.- 2025	SCALE : NTS REV NO. : R-0
DRAWING NO. : PROJECT CATEGORY BLOCK FLOOR TYPE NUMBER A-202	

Er. SANJEEV SHARMA
B.E (Electrical)

For BALAJI BUILDERS
Proprietor

TARRACE FLOOR FIGHTING PLAN,
FIRE SCHEMATIC LAYOUT

PROJECT NAME :
BALAJI AASHIYANA I


DEVELOPER NAME :
BALAJI BUILDER

LEGEND:-

①	SOIL PIPE	
②	WASTE PIPE	
③	VENT PIPE	
④	COLD WATER SUPPLY (CWS)	
⑤	HOT WATER SUPPLY (HWS)	
	RAIN WATER PIPE	
SW	SEWER LINE- EXTERNAL	
RW	STORM WATER DRAINAGE PIPE	
	SEWERAGE MANHOLE (2' x 2')	M.H.
	STORM WATER MANHOLE (2' x 2')	M.H.
GT	GULLY TRAP	
BV	BALL VALVE	
FT	FLOOR TRAP	
FD	FLOOR FLOOR DRAIN	
	RAIN WATER COLLECTION CHAMBER 450X450MM	
	KHURRA	


PROJECT:
PROPOSED RESIDENTIAL FLATS ON
PLOT NO.- 51, 52, 60 & 61, LAXMAN
REKHA, SCHEME NO- 17,JHOTWARA,
JAIPUR. RAJASTHAN.

NAME OF DRAWING:
TERRACE FLOOR FLOOR RING MAIN LAYOUT,
WATER SUPPLY SYSTEMATIC DIAGRAM UG WATER
TANK TO OHT FILLING ROUTE PLAN

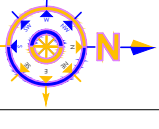DRAWING WORKING DRAWING	NORTH: 
PROJECT NO. :	DATE : 06, Mar.- 2025
SCALE : NTS	REV NO. : R-0

DRAWING NO. :									
PROJECT	CATEGORY	BLOCK	FLOOR	TYPE	NUMBER				

A-202

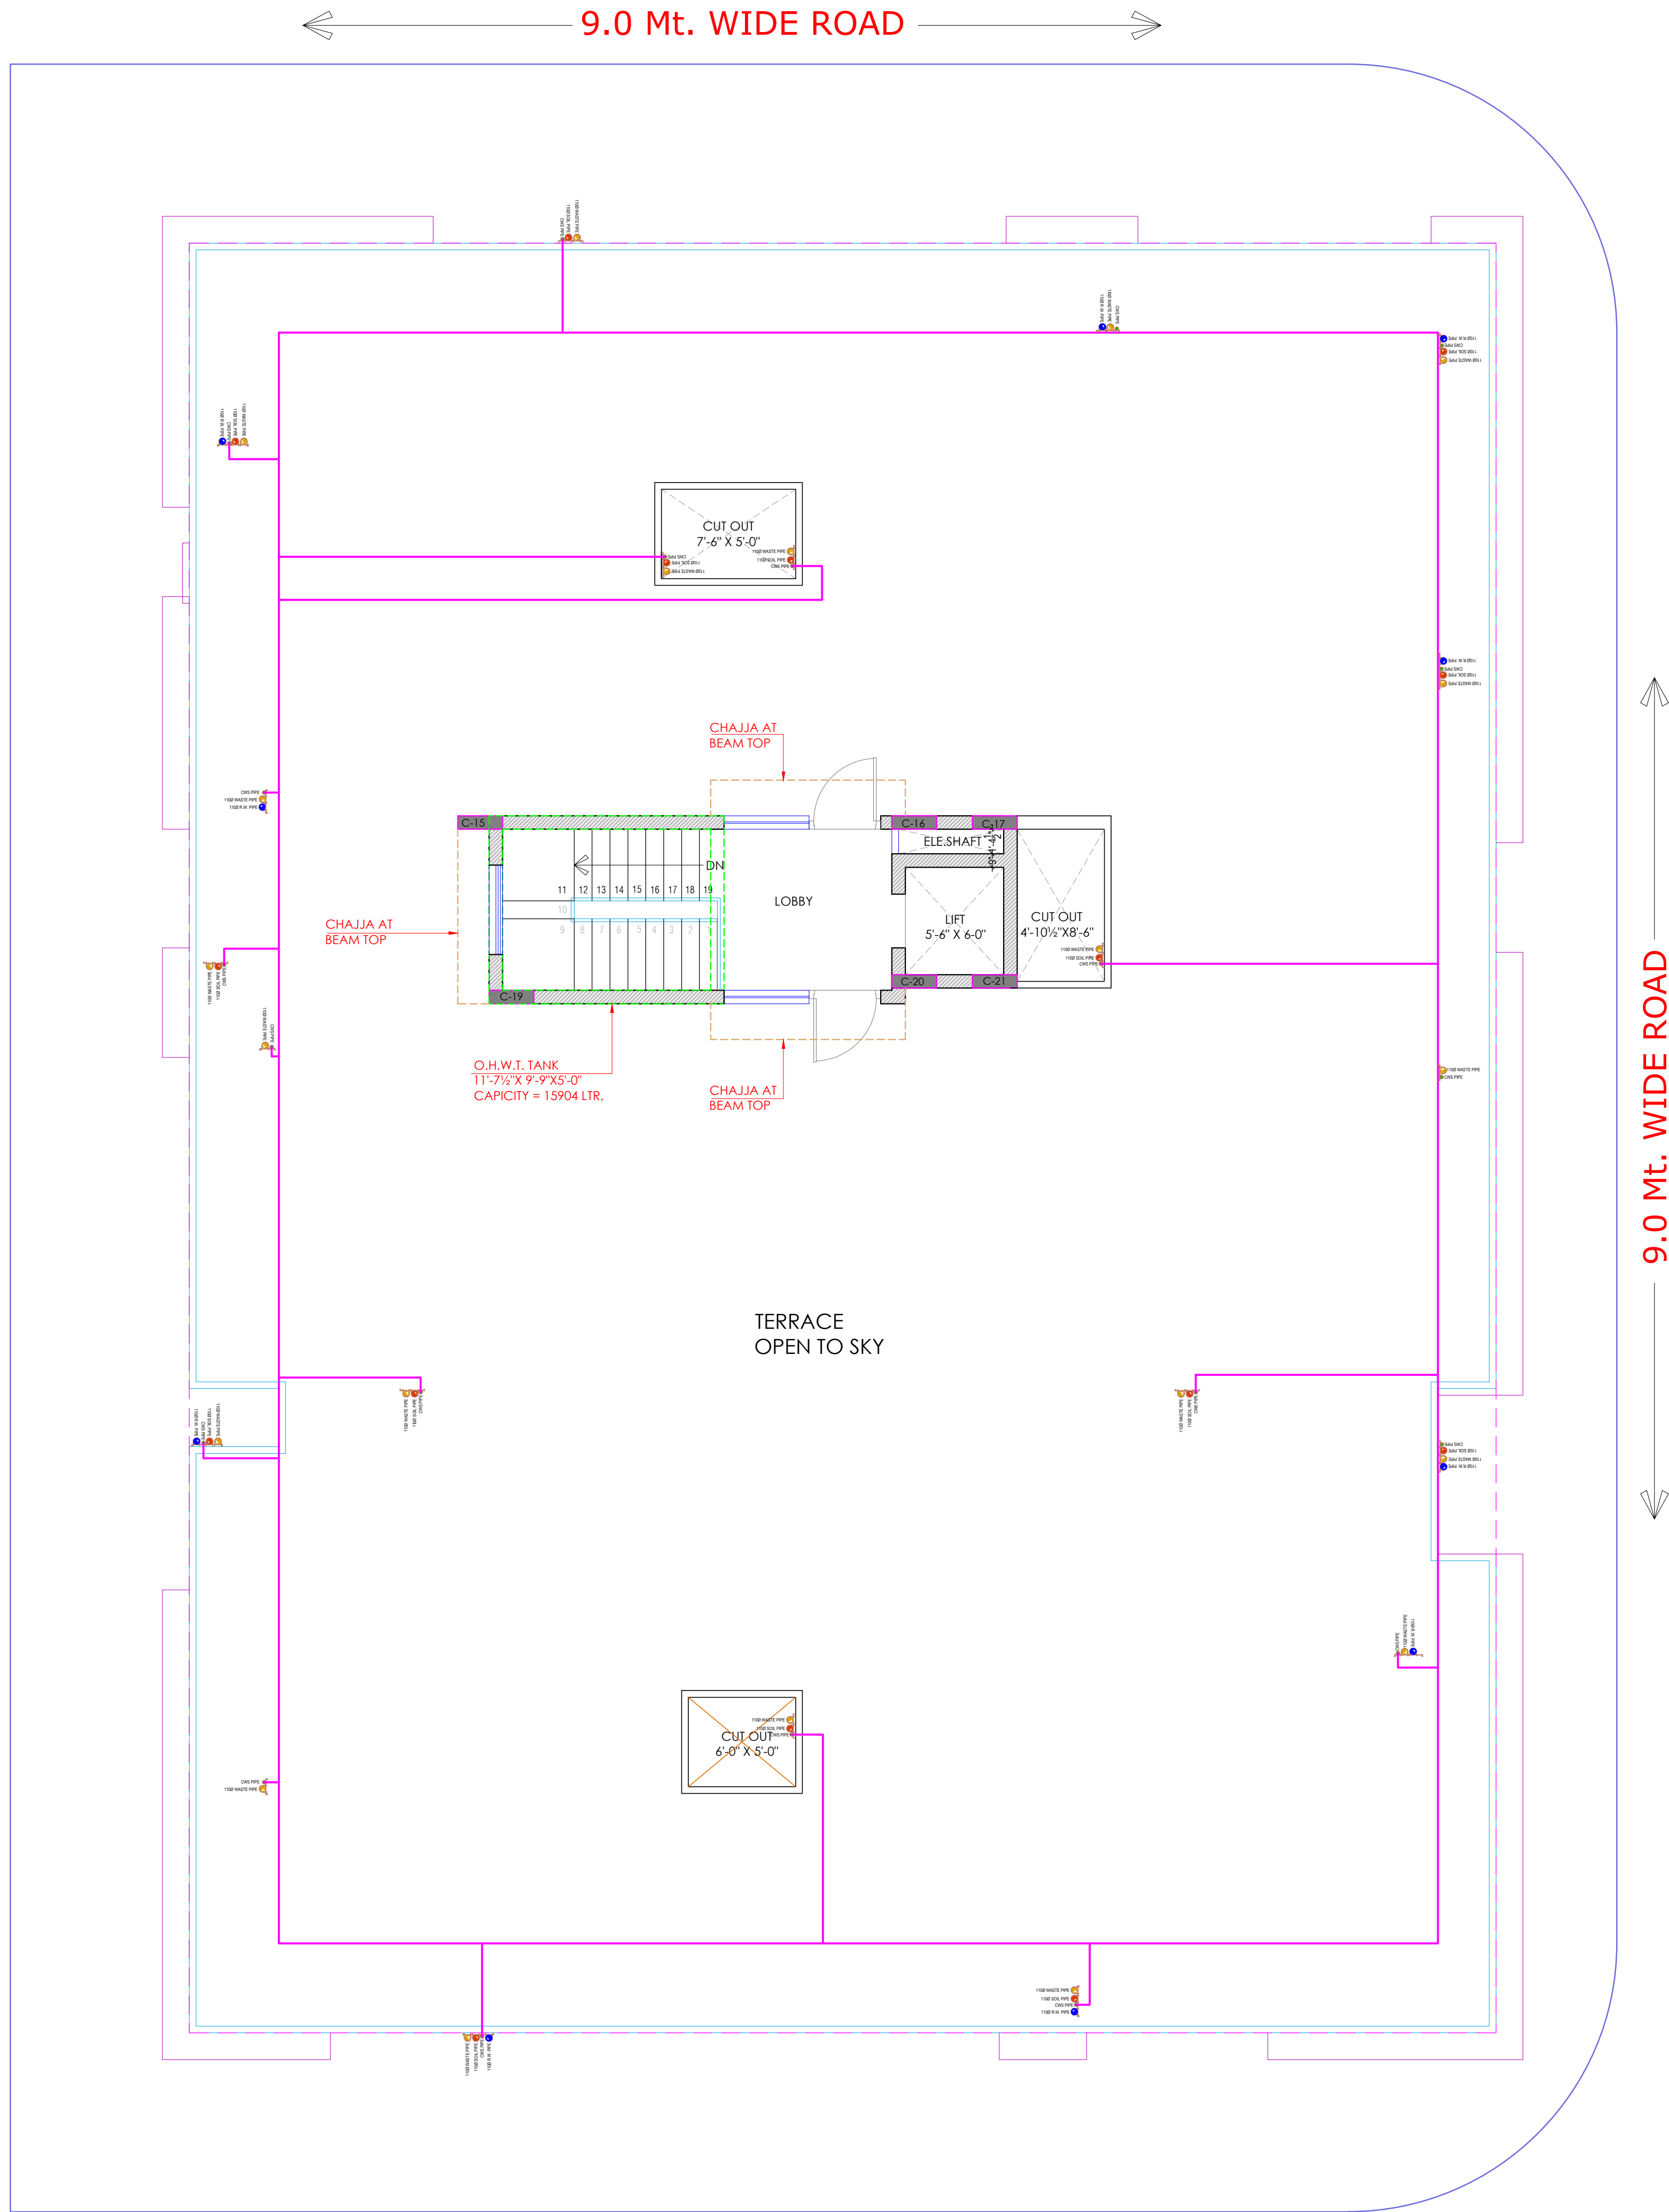

Er. SANJEEV SHARMA
B.E (Electrical)

For BALAJI BUILDERS
Proprietor

TERRACE FLOOR FLOOR RING MAIN LAYOUT, WATER SUPPLY SYSTEMATIC DIAGRAM
UG WATER TANK TO OHT FILLING ROUTE PLAN