


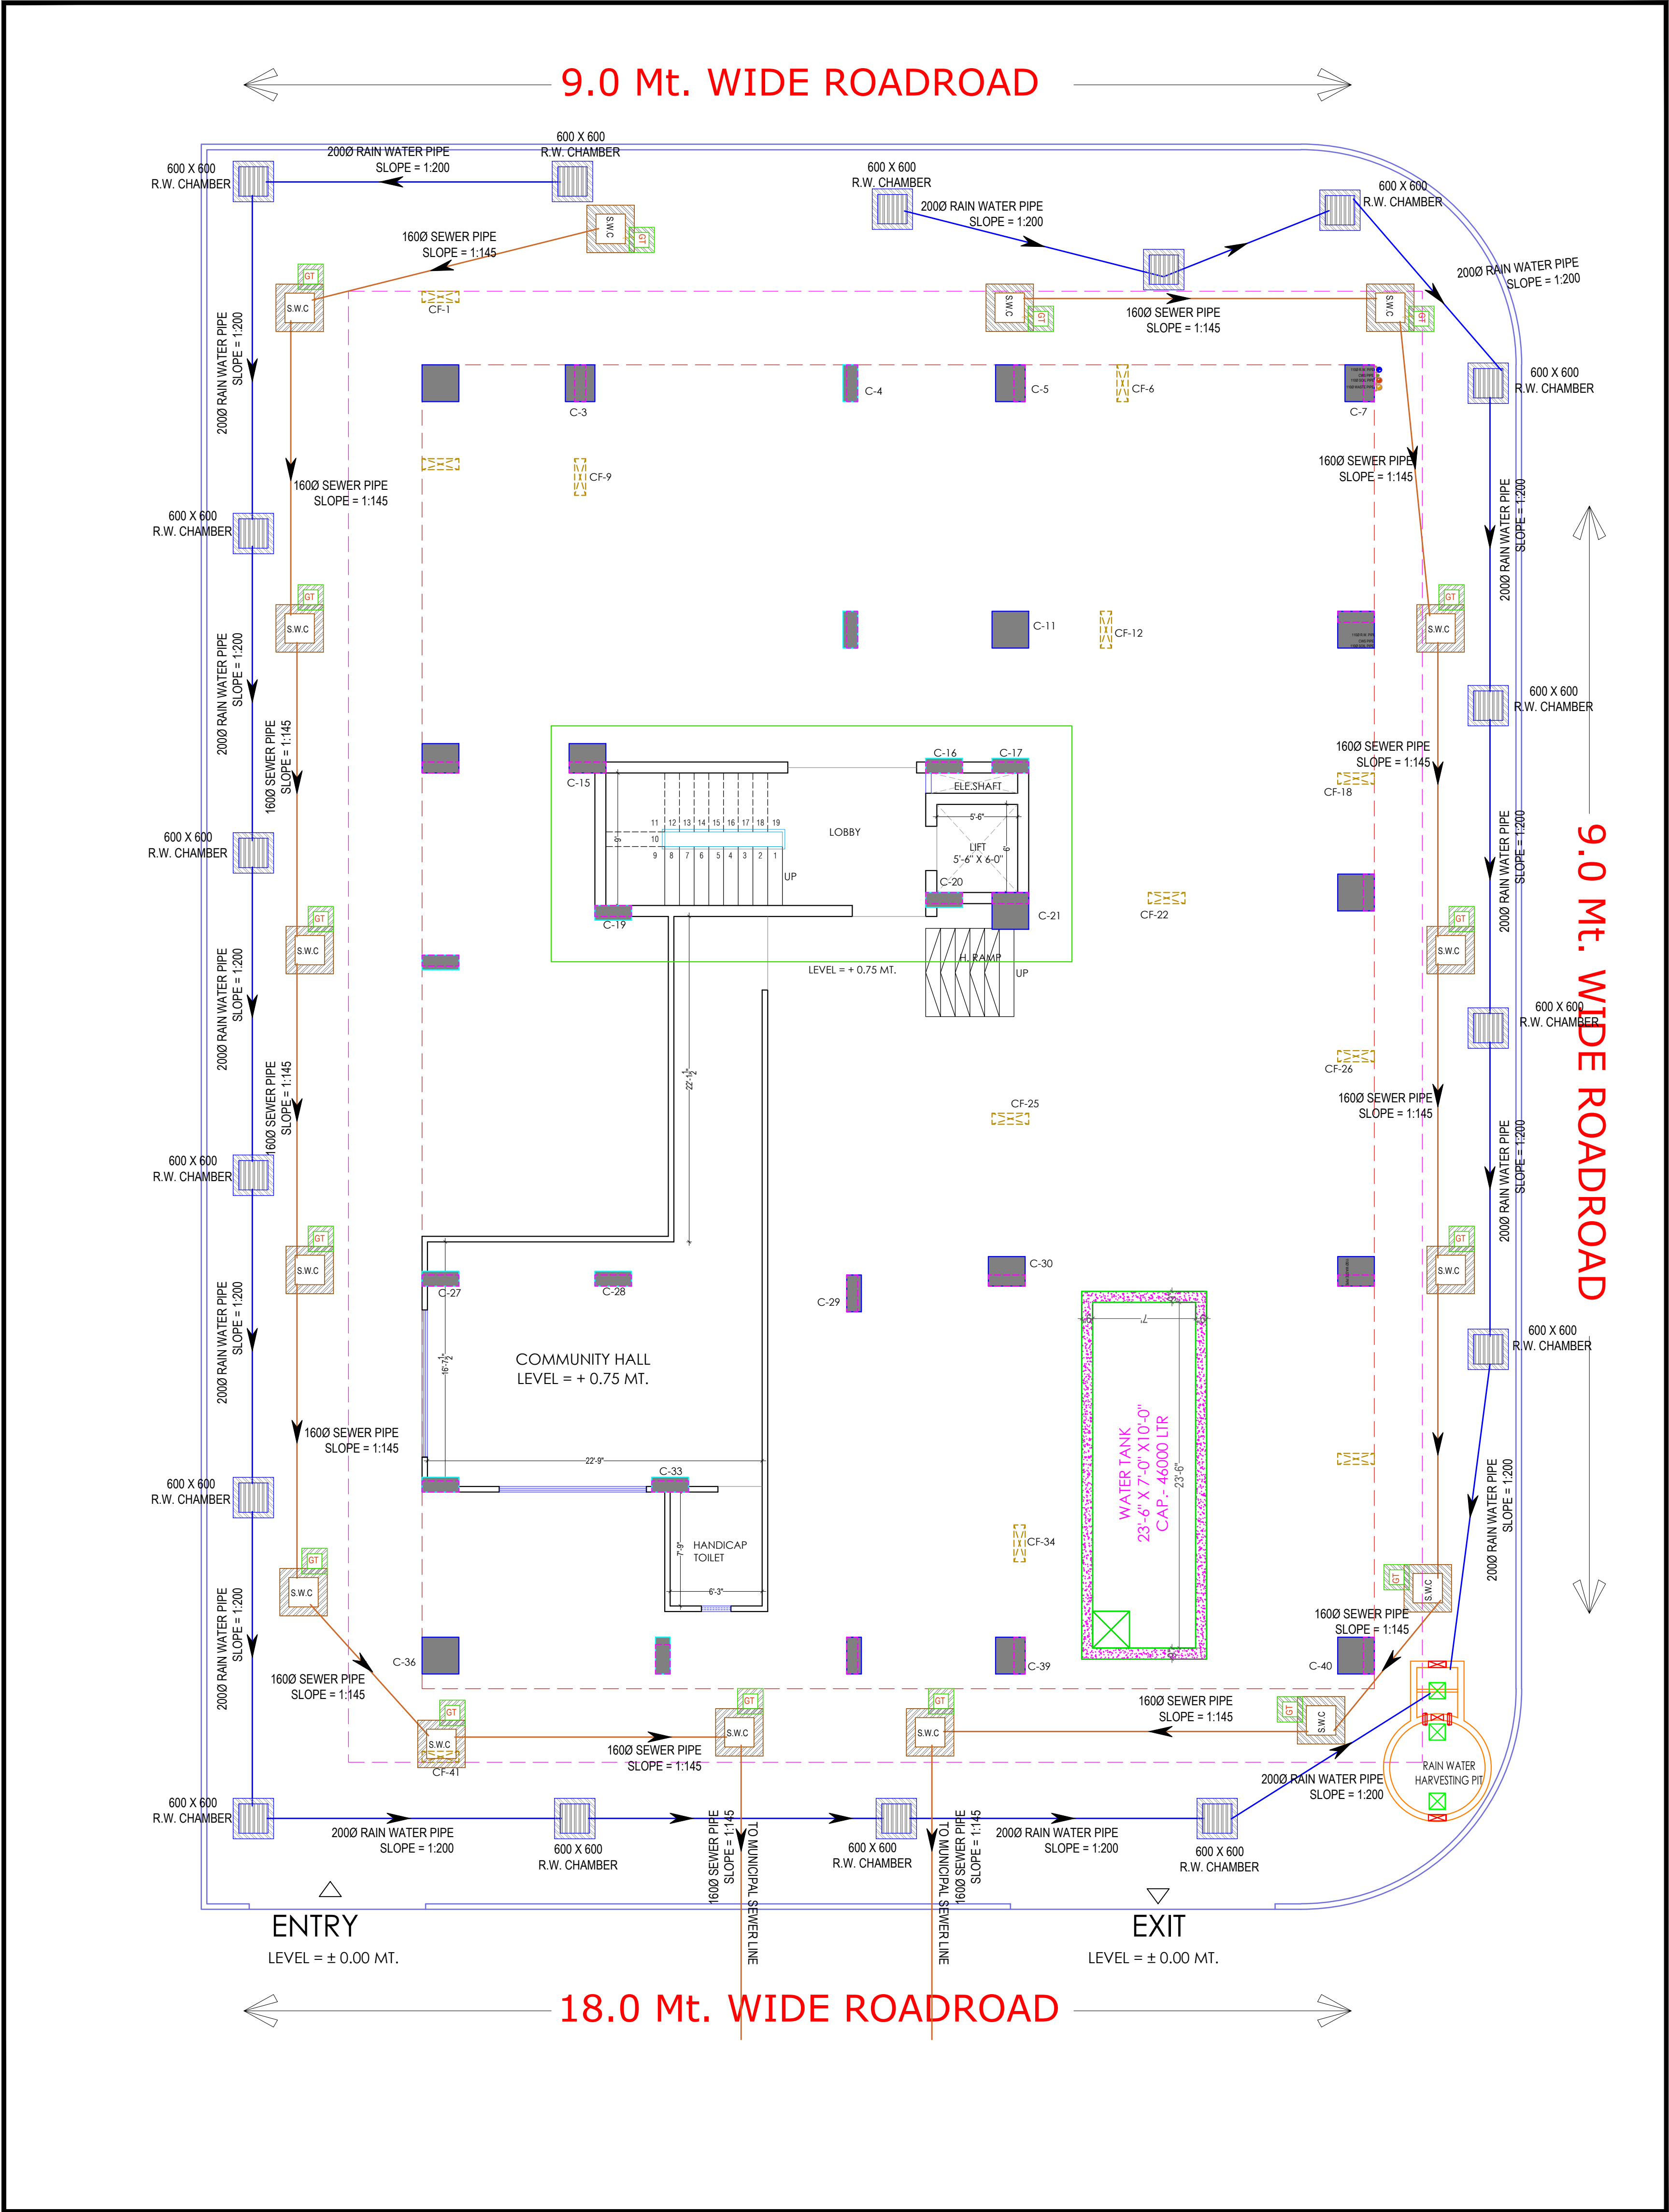

PROJECT NAME :

BALAJI AASHIYANA I

DEVELOPER NAME :

BALAJI BUILDER

LEGEND:-

①	SOIL PIPE	
②	WASTE PIPE	
③	VENT PIPE	
④	COLD WATER SUPPLY (CWS)	
⑤	HOT WATER SUPPLY (HWS)	
	RAIN WATER PIPE	
SW	SEWER LINE- EXTERNAL	
RW	STORM WATER DRAINAGE PIPE	
	SEWERAGE MANHOLE (2' x 2')	M.H.
	STORM WATER MANHOLE (2' x 2')	M.H.
GT	GULLY TRAP	
BV	BALL VALVE	
FT	FLOOR TRAP	
FD	FLOOR FLOOR DRAIN	
	RAIN WATER COLLECTION CHAMBER 450X450MM	
	KHURRA	

GENERAL NOTES:

- All dimensions on this drawing are in MMS System Only written dimensions are to be followed.
- All measurements must be checked and verified by the contractors prior to execution.
- This drawing is to be read in conjunction with all relevant structural, services & facility planning drawings.
- Architectural drawings are to be followed for the location of all structural members & necessary walls, for sizes & reinforcement details of structural members, relevant coordination with services such as basic, plumbing & electrical, etc. is the responsibility of the contractor.
- Any discrepancies between architectural, structural and services drawings must be brought to the notice of the architect immediately & prior to execution of site.
- Coordination with services such as basic, plumbing & electrical, etc. is the responsibility of the contractor.
- All necessary work should be aligned with the columns as indicated on the plan, irrespective of the position as indicated with the dimensioning.
- For details, refer relevant large scale detail drawings, as indicated.

PROJECT:

PROPOSED RESIDENTIAL FLATS ON PLOT NO.- 51, 52, 60 & 61, LAXMAN REKHA, SCHEME NO- 17, JHOTWARA, JAIPUR, RAJASTHAN.

NAME OF DRAWING:

STILT FLOOR WATER SUPPLY DRAWING, STILT FLOOR EXTERNAL RAIN WATER HARVESTING AND PIPE ROUTE PLAN, STILT FLOOR EXTERNAL SEWERAGE WATER PIPE ROUT PLAN, PIT LOCATION

DRAWING	NORTH:
WORKING DRAWING	
PROJECT NO. :	DATE:
	28, Dec. - 2024
SCALE :	REV NO. :
NTS	R-0
DRAWING NO. :	
PROJECT	CATEGORY
A-201	


Er. SANJEEV SHARMA
B.E (Electrical)

For BALAJI BUILDERS
Proprietor

STILT FLOOR WATER SUPPLY DRAWING, STILT FLOOR EXTERNAL RAIN WATER HARVESTING AND PIPE ROUTE PLAN, STILT FLOOR EXTERNAL SEWERAGE WATER PIPE ROUT PLAN, PIT LOCATION

PROJECT NAME :
BALAJI AASHIYANA I

DEVELOPER NAME :
BALAJI BUILDER

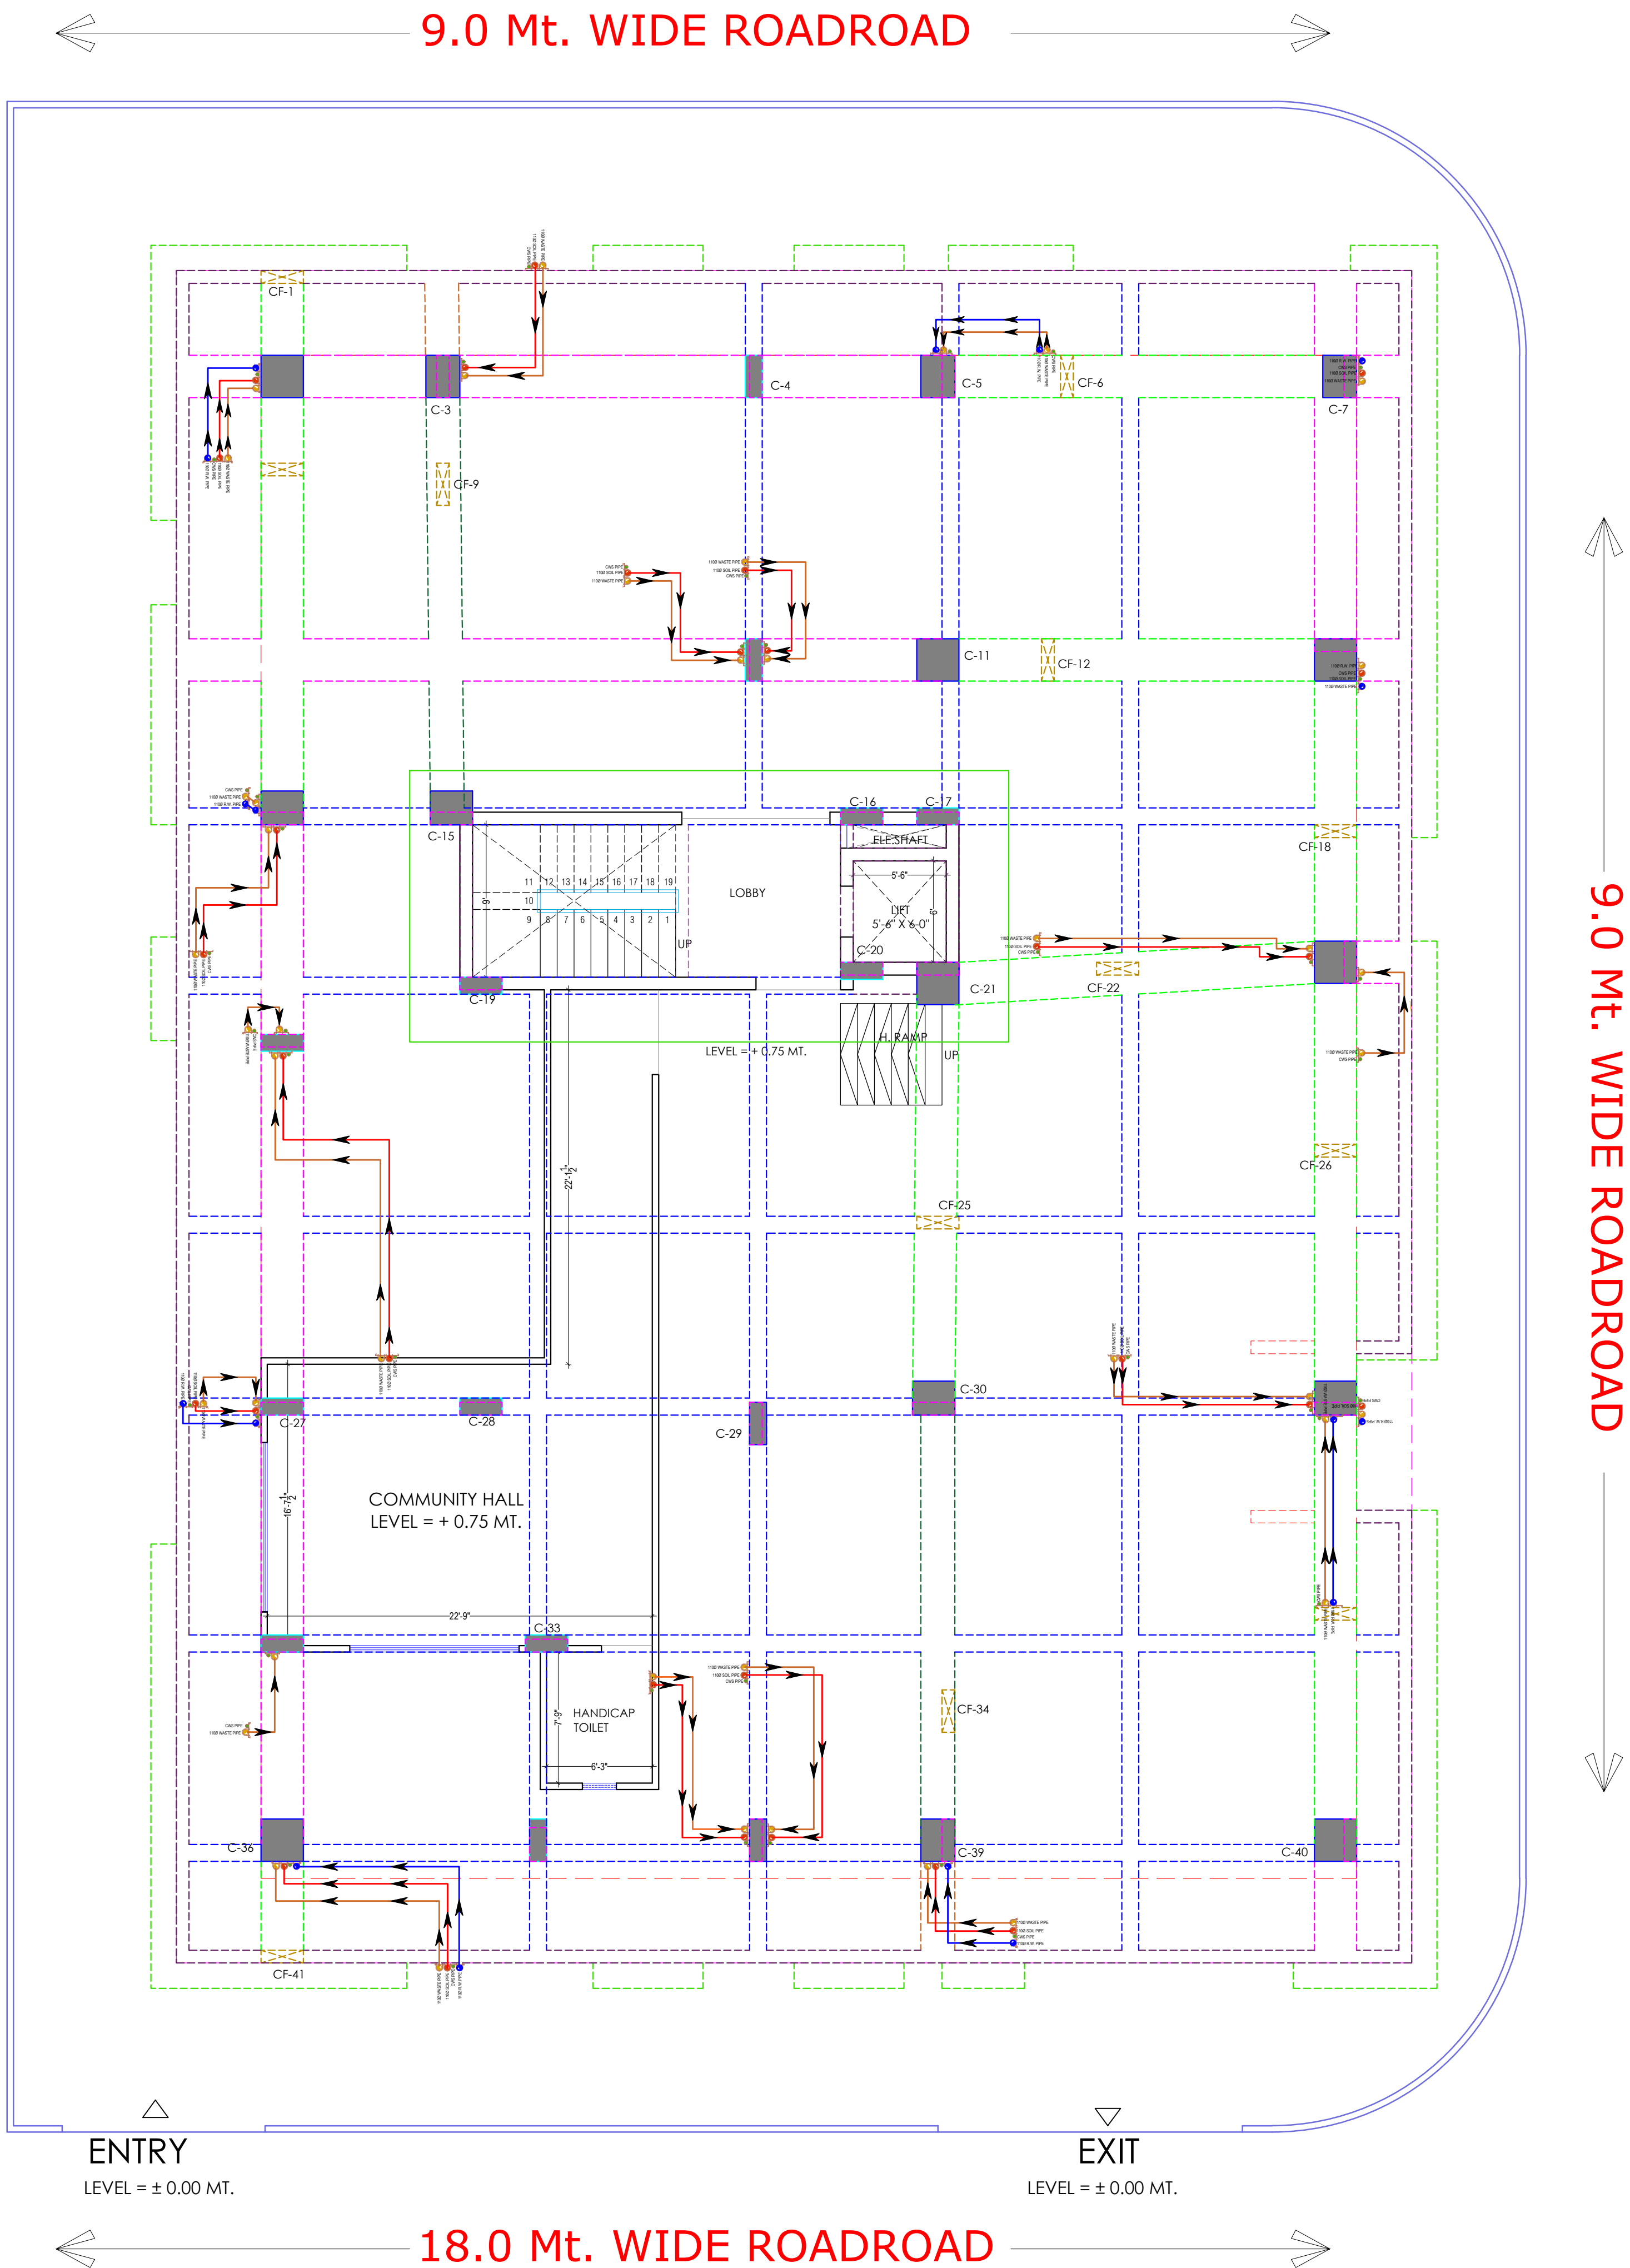

LEGEND:-

①	SOIL PIPE	—
②	WASTE PIPE	—
③	VENT PIPE	—
④	COLD WATER SUPPLY (CWS)	—
⑤	HOT WATER SUPPLY (HWS)	—
	RAIN WATER PIPE	—
SW	SEWER LINE- EXTERNAL	—
RW	STORM WATER DRAINAGE PIPE	—
	SEWERAGE MANHOLE (2' x 2')	M.H.
	STORM WATER MANHOLE (2' x 2')	M.H.
GT	GULLY TRAP	—
BV	BALL VALVE	—
FT	FLOOR TRAP	—
FD	FLOOR FLOOR DRAIN	—
	RAIN WATER COLLECTION CHAMBER 450X450MM	—
	KHURRA	—

S.NO.	DATE	REVISION DESCRIPTION
1.		GENERAL NOTES:
2.		All dimensions on this drawing are in Metric System Only written dimensions are to be followed.
3.		All measurements must be checked and verified by the contractors prior to execution of work at the site.
4.		This drawing is to be read in conjunction with all relevant structural, services & facility planning drawings.
5.		Architectural drawings are to be followed for the location of all structural members & openings.
6.		Architectural drawings are to be followed for the location of all structural members & openings.
7.		Architectural drawings are to be followed for the location of all structural members & openings.
8.		Architectural drawings are to be followed for the location of all structural members & openings.

PROJECT:

PROPOSED RESIDENTIAL FLATS ON PLOT NO.- 51, 52, 60 & 61, LAXMAN REKHA, SCHEME NO- 17, JHOTWARA, JAIPUR, RAJASTHAN.

NAME OF DRAWING:

STILT FLOOR STORM WATER DRAINAGE LAYOUT & CEILING DRAINAGE LAYOUT PLAN

DRAWING: WORKING DRAWING

NORTH:

PROJECT NO. : 28, Dec. - 2024

SCALE : NTS

REV NO. : R-0

DRAWING NO. : A-201

PROJECT CATEGORY BLOCK FLOOR TYPE NUMBER


Er. SANJEEV SHARMA
B.E (Electrical)

 
For BALAJI BUILDERS
Proprietor

STILT FLOOR STORM WATER DRAINAGE LAYOUT & CEILING DRAINAGE LAYOUT PLAN

BALAJI AASHIYANA I

BALAJI BUILDER

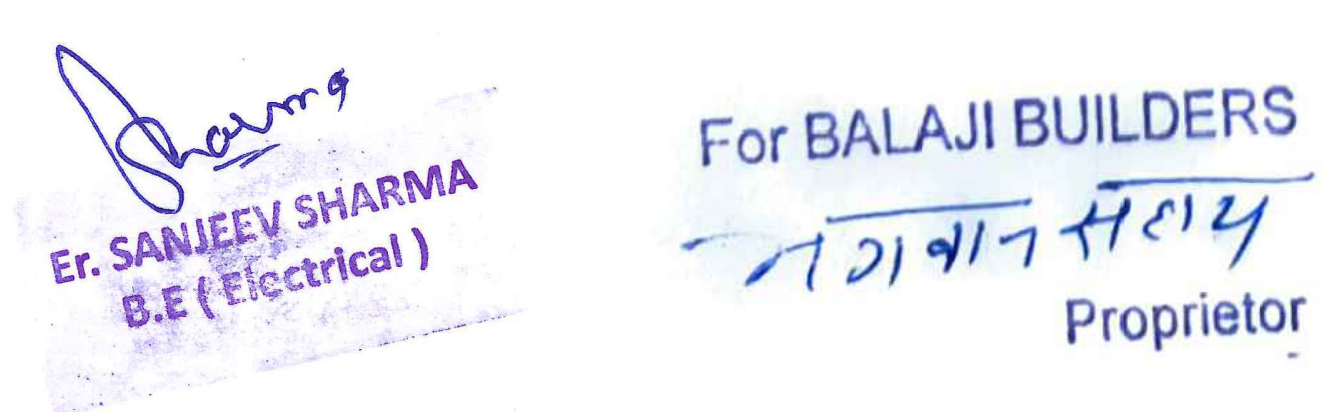

LEGEND:-		
①	SOIL PIPE	
②	WASTE PIPE	
③	VENT PIPE	
④	COLD WATER SUPPLY (CWS)	
⑤	HOT WATER SUPPLY (HWS)	
	RAIN WATER PIPE	
SW	SEWER LINE- EXTERNAL	
RW	STORM WATER DRAINAGE PIPE	
	SEWERAGE MANHOLE (2' x 2')	 M.H.
	STORM WATER MANHOLE (2' x 2')	 M.H.
GT	GULLY TRAP	
BV	BALL VALVE	
FT	FLOOR TRAP	
FD	FLOOR FLOOR DRAIN	
	RAIN WATER COLLECTION CHAMBER 450x450MM	
	KHURRA	

	S.No	DATE	REVISION DESCRIPTION
GENERAL NOTES :			
1.			All dimensions on this drawing are in MKS System Only written dimensions are to be followed; drawing should not be scaled.
2.			All measurements must be checked and verified by the contractors prior to execution of work at site.
3.			This drawing is to be read in conjunction with all relevant structural, services & facility planning drawings.
4.			Architectural drawings are to be followed for the location of all structural members & masonry walls, for sizes & reinforcement details of structural members, relevant structural drawings are to be referred.
5.			Any discrepancies between architectural, structural and services drawings must be brought to the notice of the architects immediately prior to execution at site. Co-ordinate with services such as hvac, plumbing & electrical, etc., in the responsibility of the contractor.
6.			All masonry walls must be aligned with the columns as indicated on the plan. Imprecision of the position of the column as calculated with the dimensioning. For details, refer relevant large scale detail drawings, as indicated.

PROJECT:
PROPOSED RESIDENTIAL FLATS ON
PLOT NO.- 51, 52, 60 & 61, LAXMAN
REKHA, SCHEME NO- 17, JHOTWARA,
JAIPUR, RAJASTHAN.

NAME OF DRAWING:

**TYPICAL FLOOR(GROUND TO FIFTH) INTERNAL
DRAINAGE PLAN, TYPICAL FLOOR INTERNAL
PLUMBING PLAN, UG WATER TANK TO OHT
FILLING ROUTE PLAN**

DRAWING	NORTH:
WORKING DRAWING	
PROJECT NO. :	DATE : 28, Dec. - 2024
SCALE : NTS	REV NO. : R-0
DRAWING NO. : PROJECT CATEGORY BLOCK FLOOR TYPE NUMBER	

PROJECT NAME :
BALAJI AASHIYANA I


DEVELOPER NAME :
BALAJI BUILDER

LEGEND:-

①	SOIL PIPE	
②	WASTE PIPE	
③	VENT PIPE	
④	COLD WATER SUPPLY (CWS)	
⑤	HOT WATER SUPPLY (HWS)	
	RAIN WATER PIPE	
SW	SEWER LINE- EXTERNAL	
RW	STORM WATER DRAINAGE PIPE	
	SEWERAGE MANHOLE (2' x 2')	M. H.
	STORM WATER MANHOLE (2' x 2')	M. H.
GT	GULLY TRAP	
BV	BALL VALVE	
FT	FLOOR TRAP	
FD	FLOOR FLOOR DRAIN	
	RAIN WATER COLLECTION CHAMBER 450X450MM	
	KHURRA	


PROJECT:
PROPOSED RESIDENTIAL FLATS ON
PLOT NO.- 51, 52, 60 & 61, LAXMAN
REKHA, SCHEME NO- 17,JHOTWARA,
JAIPUR. RAJASTHAN.

NAME OF DRAWING:
TERRACE FLOOR FLOOR RING MAIN LAYOUT,
WATER SUPPLY SYSTEMATIC DIAGRAM UG WATER
TANK TO OHT FILLING ROUTE PLAN

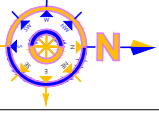DRAWING WORKING DRAWING	NORTH: 
PROJECT NO. :	DATE : 06, Mar.- 2025
SCALE : NTS	REV NO. : R-0

DRAWING NO. :																			
			/	-		/	-	/			/			/			/		
PROJECT				CATEGORY			BLOCK		FLOOR			TYPE			NUMBER				

A-202

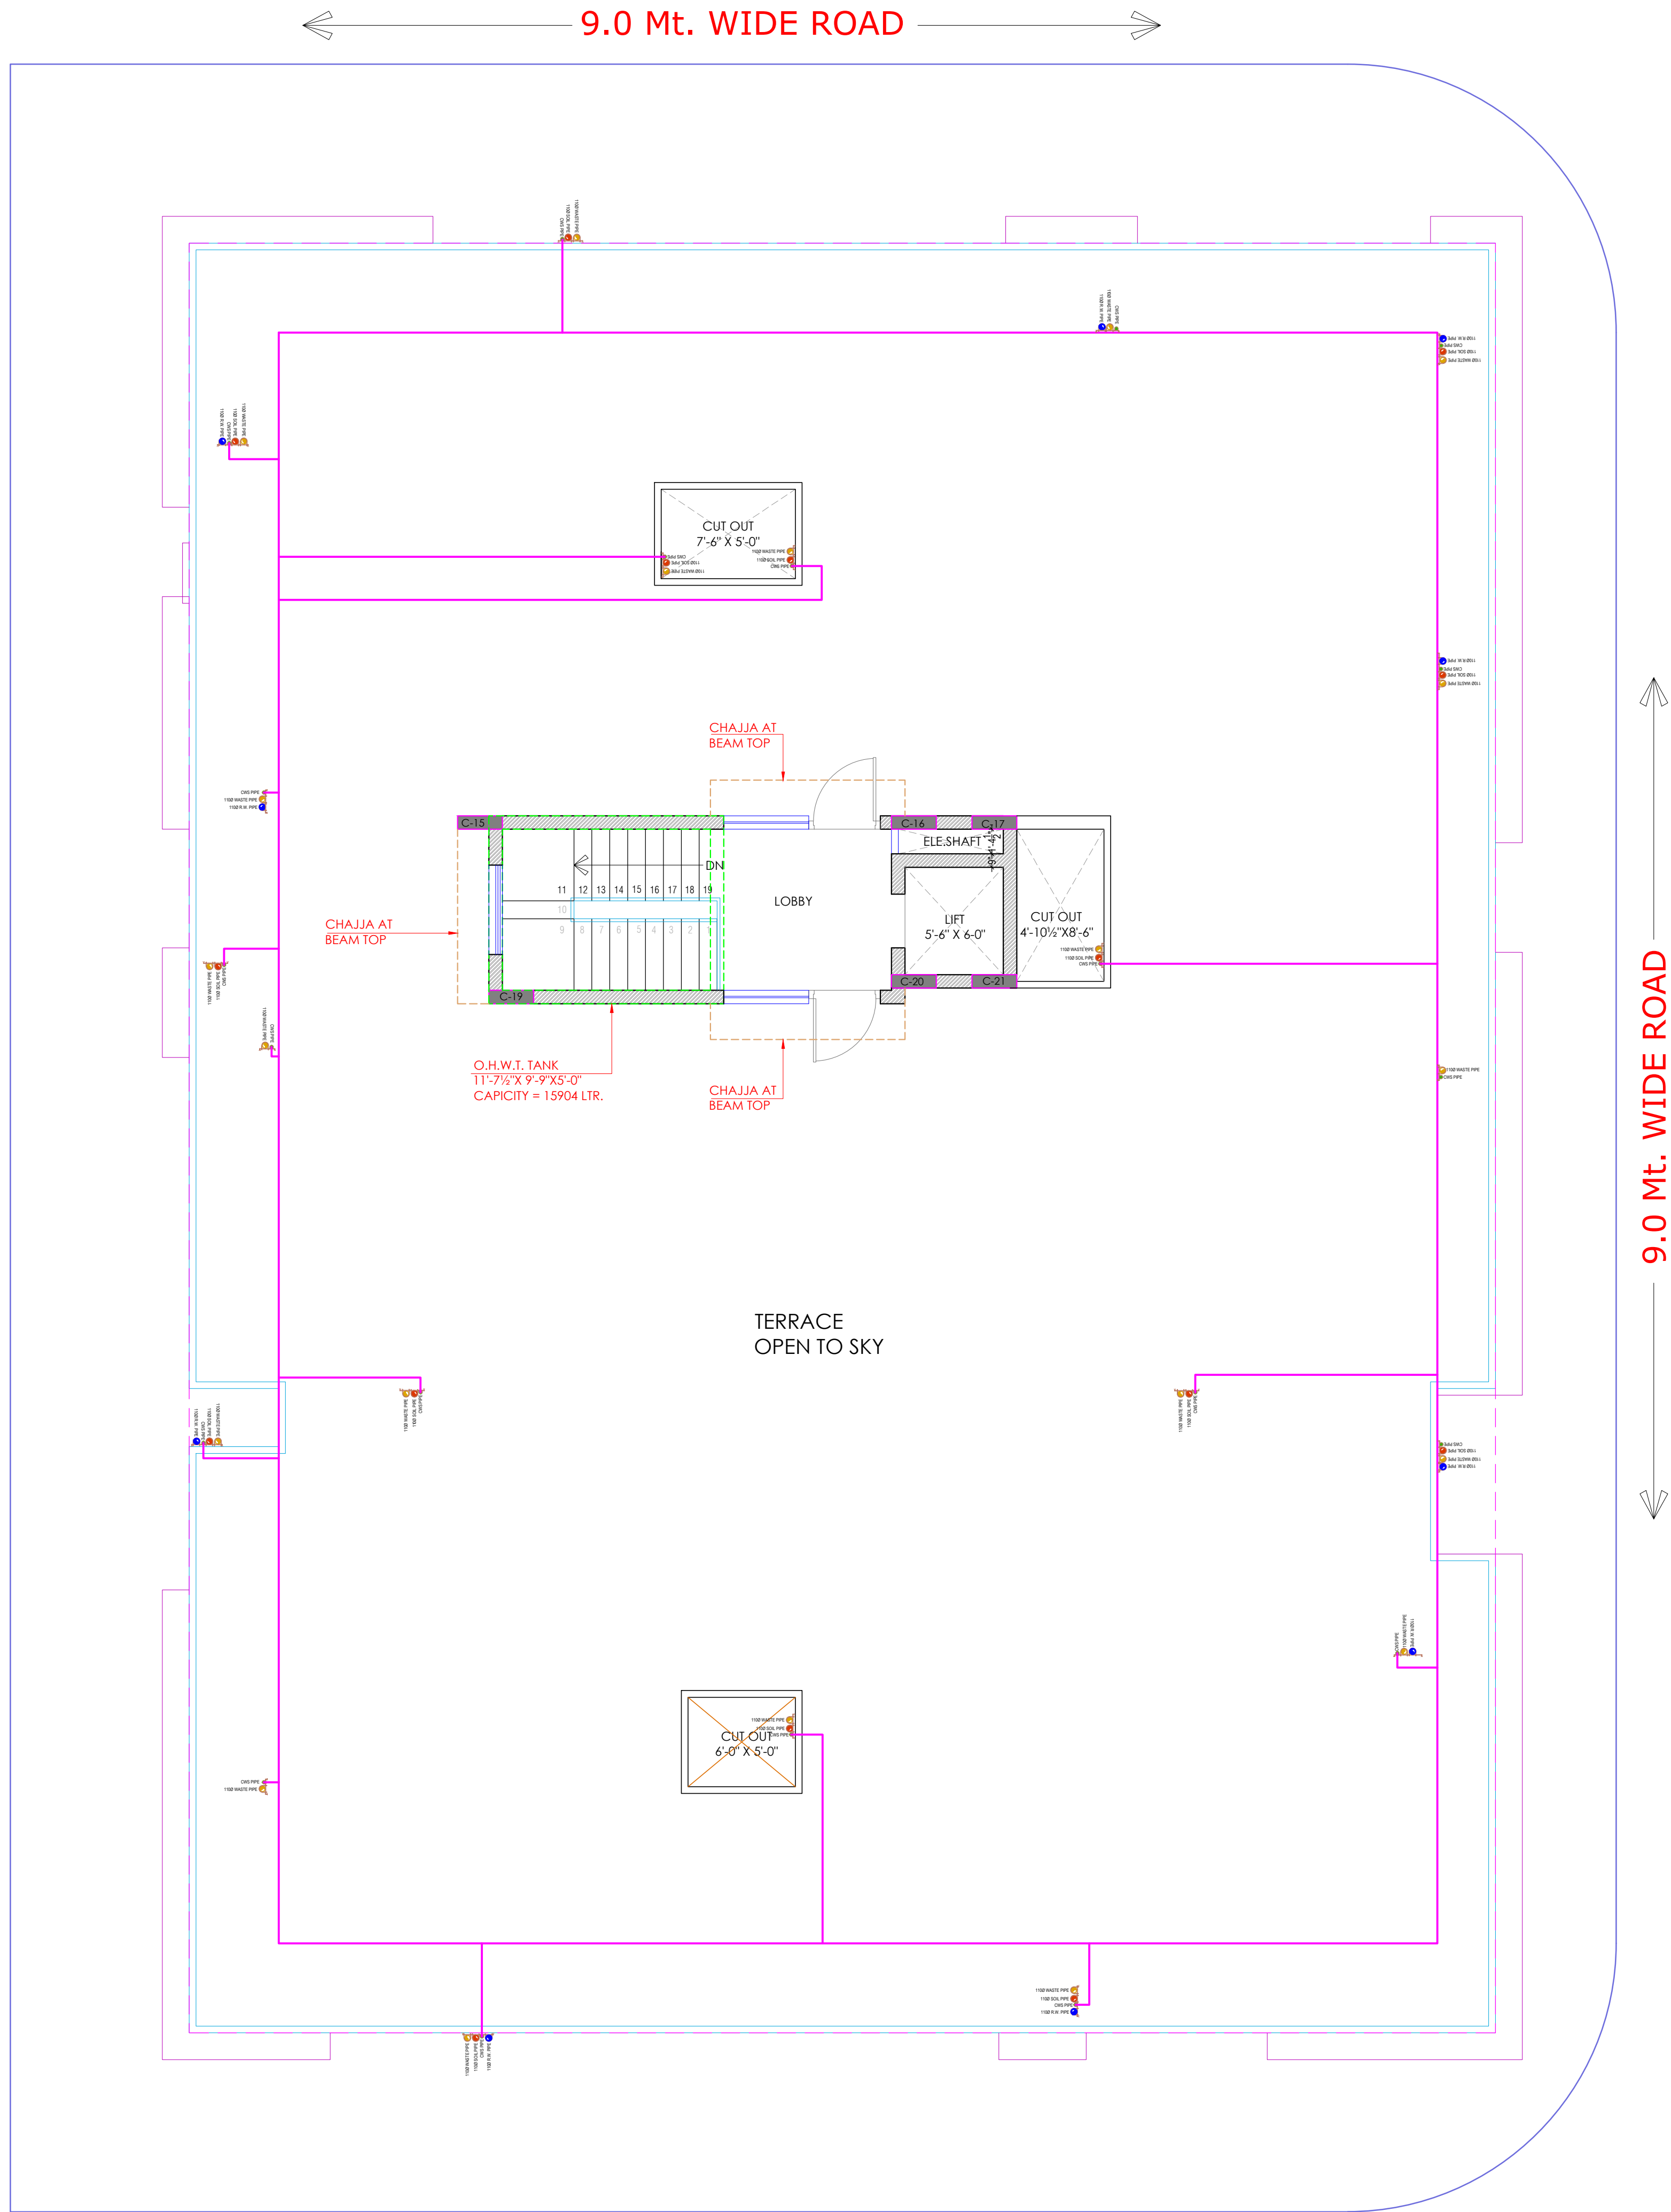

Er. SANJEEV SHARMA
B.E (Electrical)

For BALAJI BUILDERS
Proprietor

TERRACE FLOOR FLOOR RING MAIN LAYOUT, WATER SUPPLY SYSTEMATIC DIAGRAM
UG WATER TANK TO OHT FILLING ROUTE PLAN