


PROJECT NAME :
BALAJI AASHIYANA I

DEVELOPER NAME :
BALAJI BUILDER

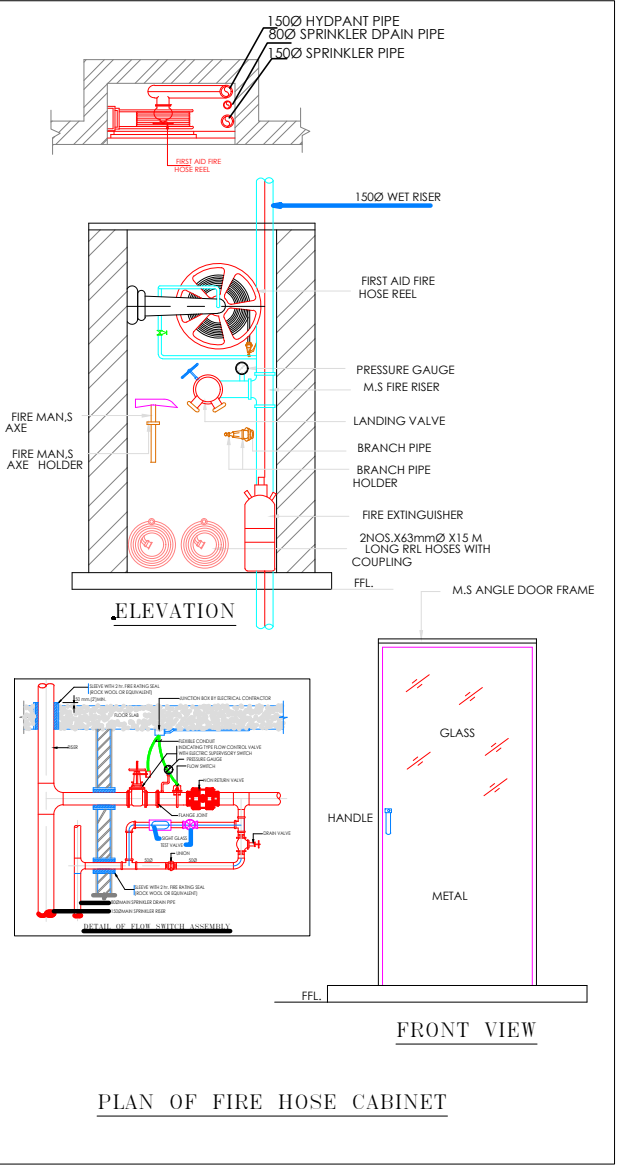

LEGEND:-

FIRE HYDRANT MS PIPE	—
BALL VALVE	⊞
EXTERNAL FIRE HYDRANT	EFHC
EXTERNAL FIRE HOSE CABINET	EFHC
FIRE HOSE CABINET	FHC
UPRIGHT SPRINKLER HEAD	⊙
PENDENT SPRINKLER HEAD	⊙
SIDE WALL SPRINKLER HEAD	⊙
FIRE EXINGUISHER	⊙
FLOW SWITCH	FS
ISOLATION VALVE	IV
2 WAY FIRE BRIGADE INLET	⊙

S.No	DATE	REVISION DESCRIPTION
1		GENERAL NOTES: 1. All dimension on this drawing are in MMS System Only written dimensions are to be followed. 2. All measurements must be checked and verified by the contractors prior to execution of work at site. 3. This drawing is to be read in conjunction with all relevant structural, services & facility planning drawings. 4. Architectural drawings are to be followed for the location of all structural members & masonry walls. For sizes & reinforcement details of structural members, relevant structural drawings are to be referred. 5. Any discrepancies between architectural, structural, and services drawings must be brought to the notice of the architect immediately & prior to execution at site. 6. Coordination with services such as HVAC, plumbing & electrical, etc., is the responsibility of the contractor. 7. All necessary walls should be aligned with the columns as indicated on the plan, irrespective of the position as calculated with the dimensions. 8. For details, refer relevant large scale detail drawings as indicated.

PROJECT:
PROPOSED RESIDENTIAL FLATS
ON PLOT. NO. 51,52,60,61
SCHEME-NO. 17 LAXMAN REKHA

NAME OF DRAWING:

**STILT FLOOR FIRE FIGHTING PLAN
SITE EXTERNAL FIRE
HYDRANT & FIRE PIPE ROUTE PLAN**


DRAWING
WORKING DRAWING

PROJECT NO. :
DATE: 20-08-2024

SCALE: NTS
REV NO. : R-0

DRAWING NO. :
PROJECT CATEGORY BLOCK FLOOR TYPE NUMBER

A-01

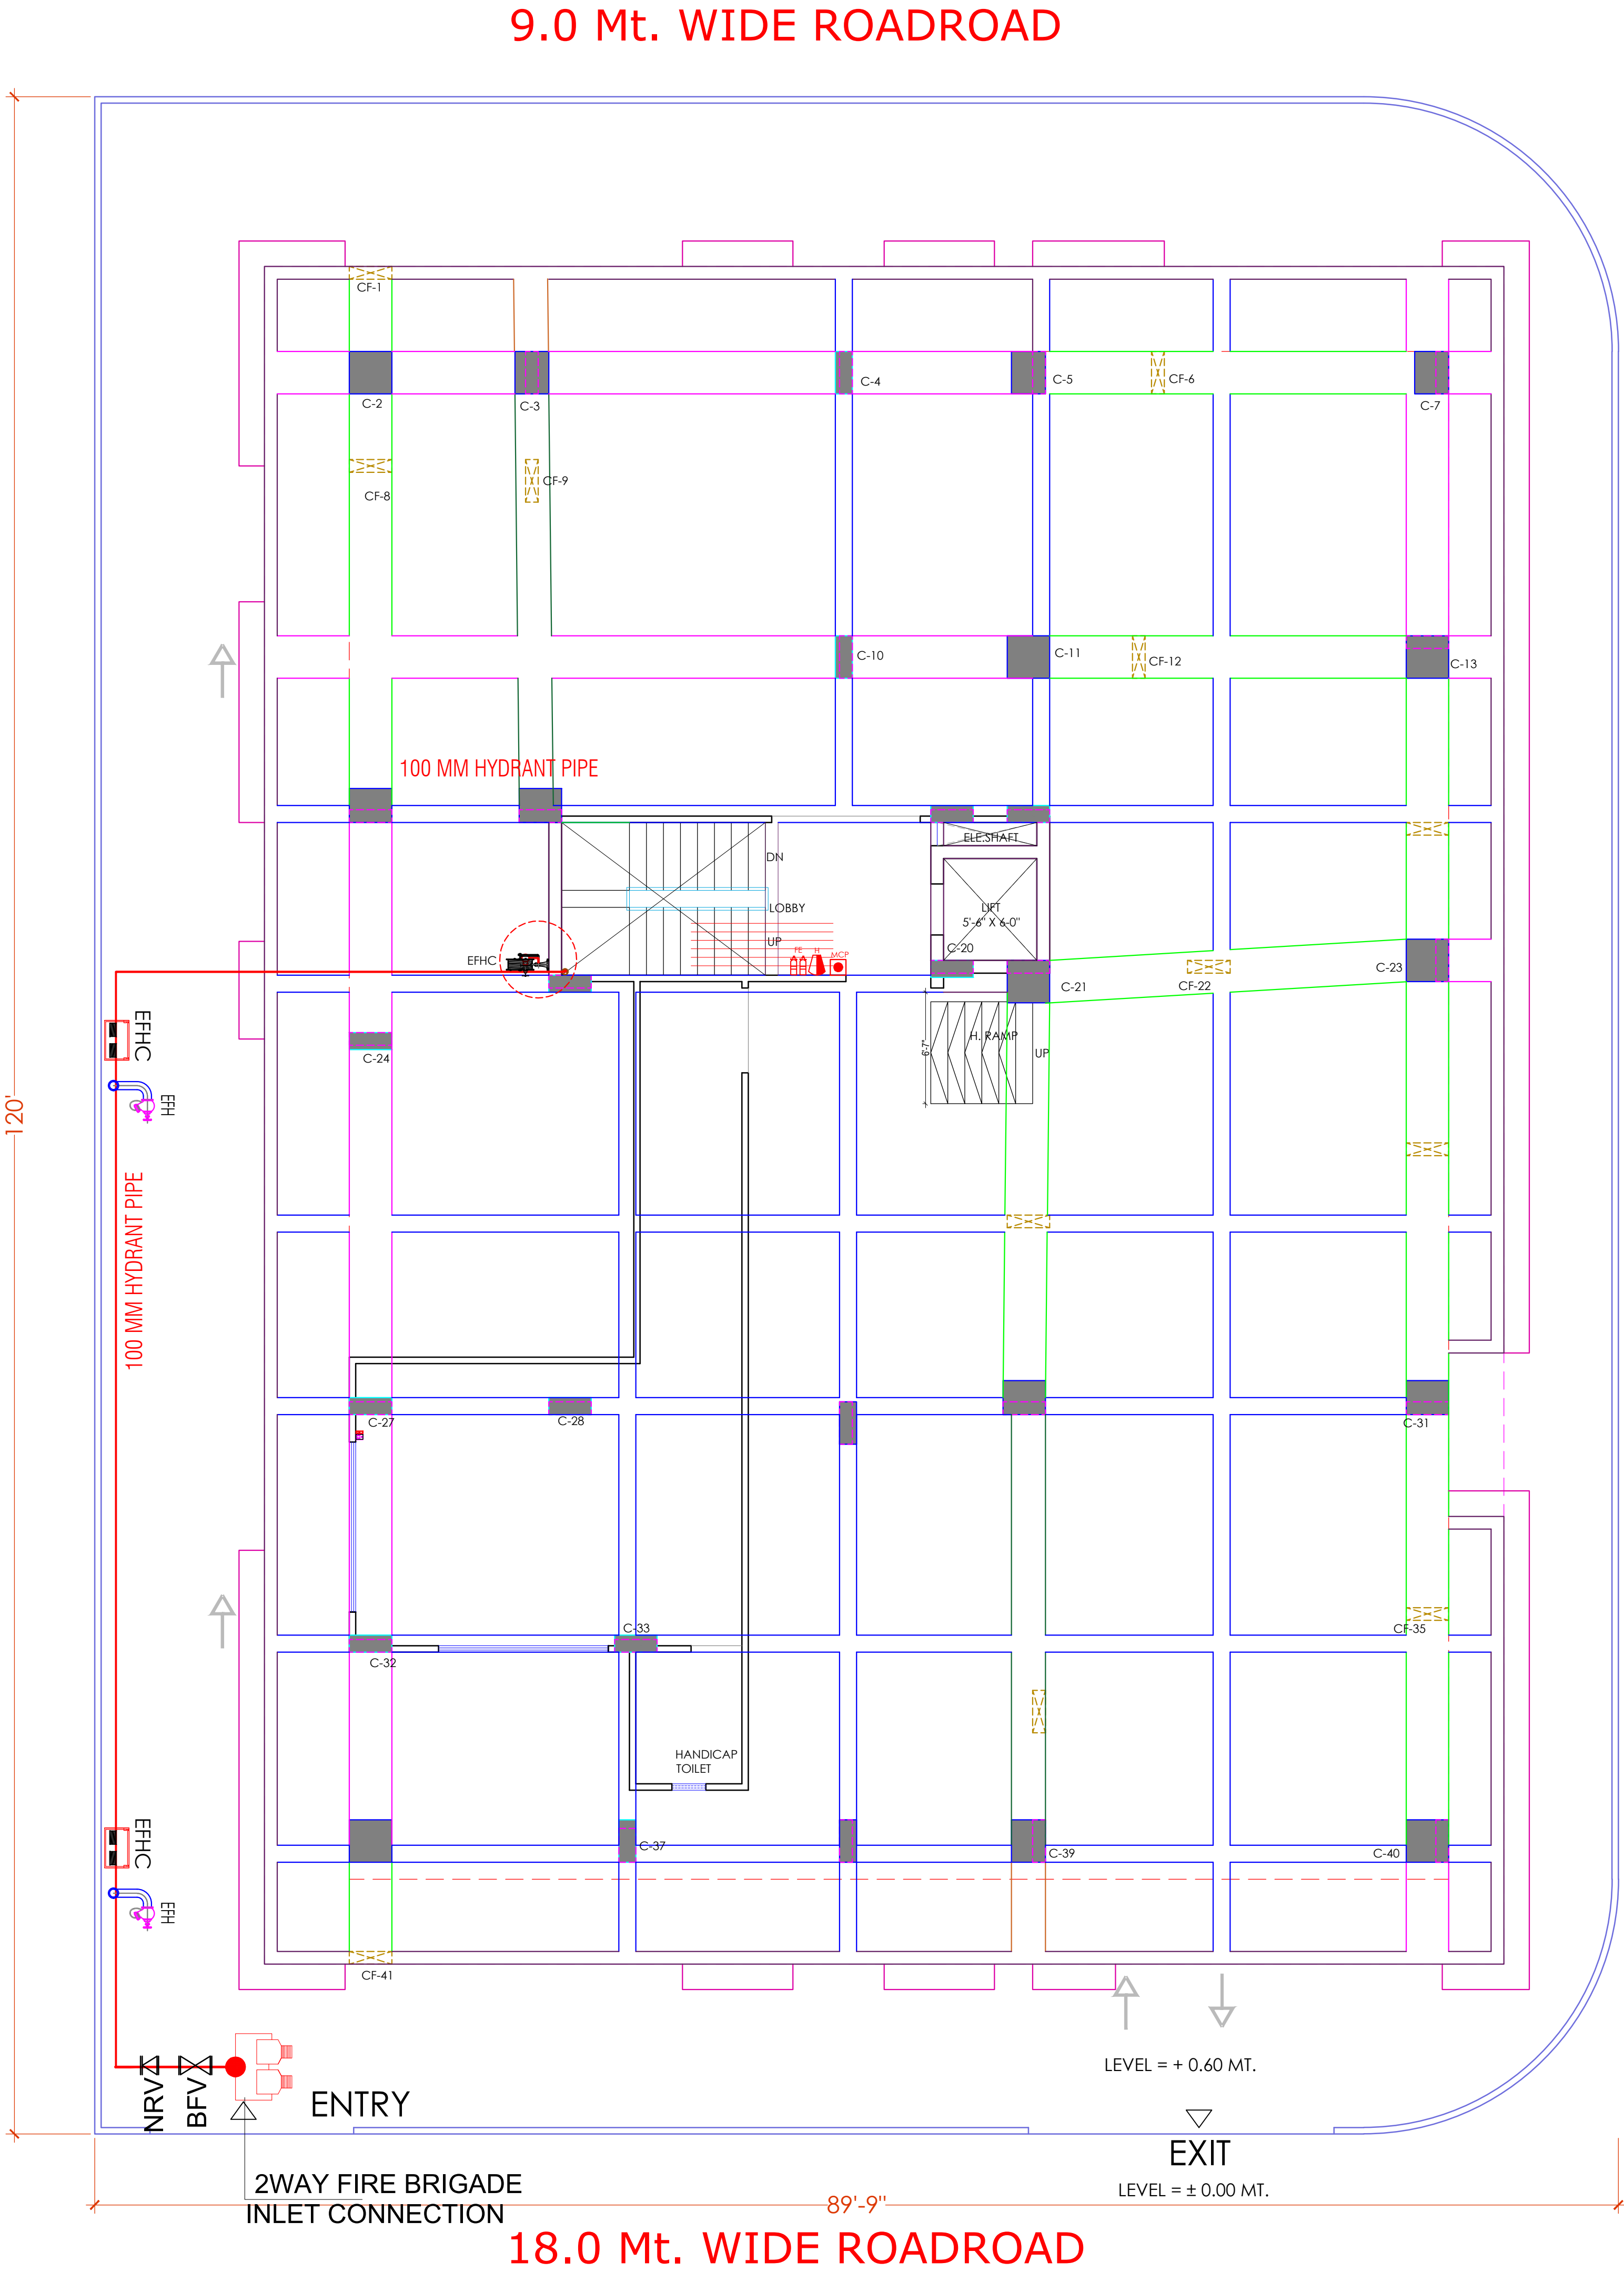

Er. SANJEEV SHARMA
B.E (Electrical)

For BALAJI BUILDERS
Proprietor

**STILT FLOOR FIRE FIGHTING PLAN
SITE EXTERNAL FIRE HYDRANT & FIRE PIPE ROUTE PLAN**



Er. SANJEEV SHARMA
B.E (Electrical)

For BALAJI BUILDERS
Proprietor

TYPICAL FLOOR FIRE FIGHTING PLAN(GROUND TO FIFTH)
FHC, MCP, HOOTER & FIRE EXTINGUISHER PLAN

PROJECT NAME :
BALAJI AASHIYANA I

DEVELOPER NAME :
BALAJI BUILDER

9.0 Mt. WIDE ROADROAD

ELEVATION

FRONT VIEW

PLAN OF FIRE HOSE CABINET

LEGEND:-

FIRE HYDRANT MS PIPE	
BALL VALVE	
EXTERNAL FIRE HYDRANT	
EXTERNAL FIRE HOSE CABINAT	
FIRE HOSE CABINAT	
UPRIGHT SPRINKLER HEAD	
PENDENT SPRINKLER HEAD	
SIDE WALL SPRINKLER HEAD	
FIRE EXINGUISHER	
FLOW SWITCH	
ISOLATION VALVE	
2 WAY FIRE BRIGADE INLET	

GENERAL NOTES :

- All dimension on this drawing are in MKS System Only written dimensions are to be followed drawing should not be scaled.
- All measurements must be checked and verified by the contractors prior to execution of work at the site.
- This drawing is to be read in conjunction with all relevant structural, services & facility planning drawings.
- Architectural drawings are to be followed for the location of all structural members & masonry walls, for sizes & reinforcement details of structural members, relevant structural drawings are to be referred.
- Any discrepancies between architectural, structural and services drawings must be brought to the notice of the architects immediately & prior to execution at site.
- Co-ordination with services such as hvac, plumbing & electrical, etc. is the responsibility of the contractor.
- All masonry walls should be aligned with the columns as indicated on the plan, irrespective of the position as calculated with the dimensioning.
- For details, refer relevant large scale detail drigs, as indicated.

PROJECT:

PROPOSED RESIDENTIAL FLATS ON PLOT NO.- 51, 52, 60 & 61, LAXMAN REKHA, SCHEME NO- 17,JHOTWARA, JAIPUR. RAJASTHAN.



NAME OF DRAWING:

TYPICAL FLOOR FIRE FIGHTING PLAN (GROUND TO FIFTH) FHC, MCP, HOOTER & FIRE EXTINGUISHER PLAN

DRAWING	NORTH:
WORKING DRAWING	
PROJECT NO. :	DATE :
	28, Dec. - 2024
SCALE :	REV NO. :
NTS	R-0
DRAWING NO. :	
PROJECT	CATEGORY
BLOCK	FLOOR
TYPE	NUMBER
A-201	

PROJECT NAME :
BALAJI AASHIYANA I

DEVELOPER NAME :
BALAJI BUILDER

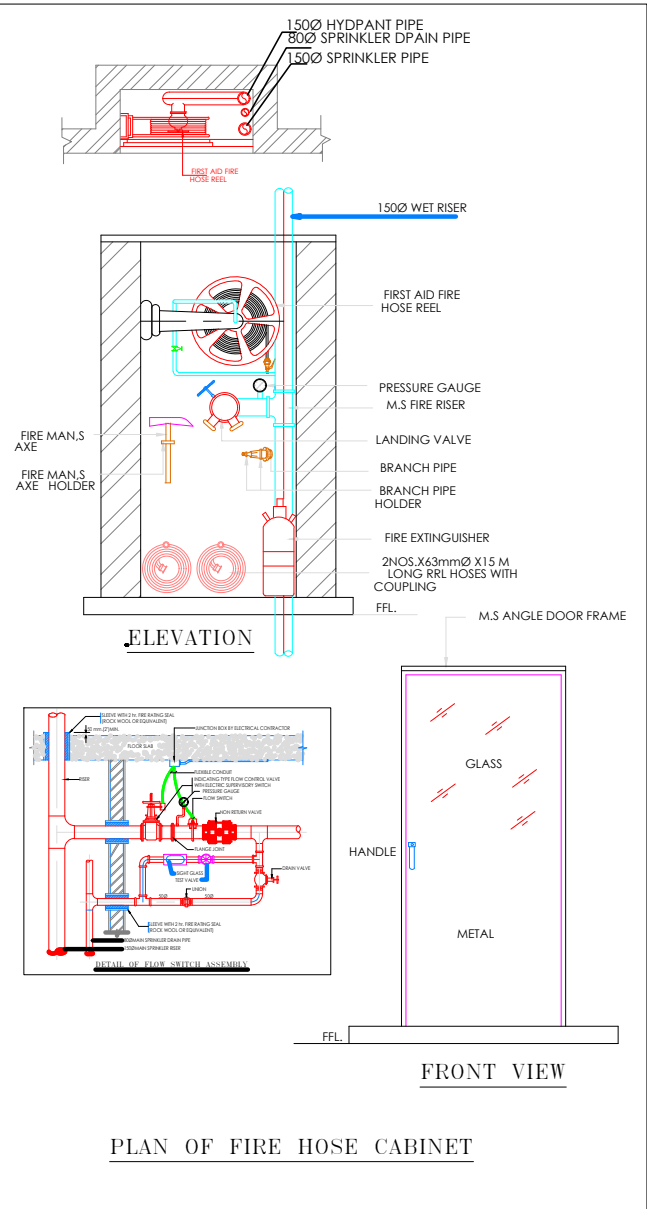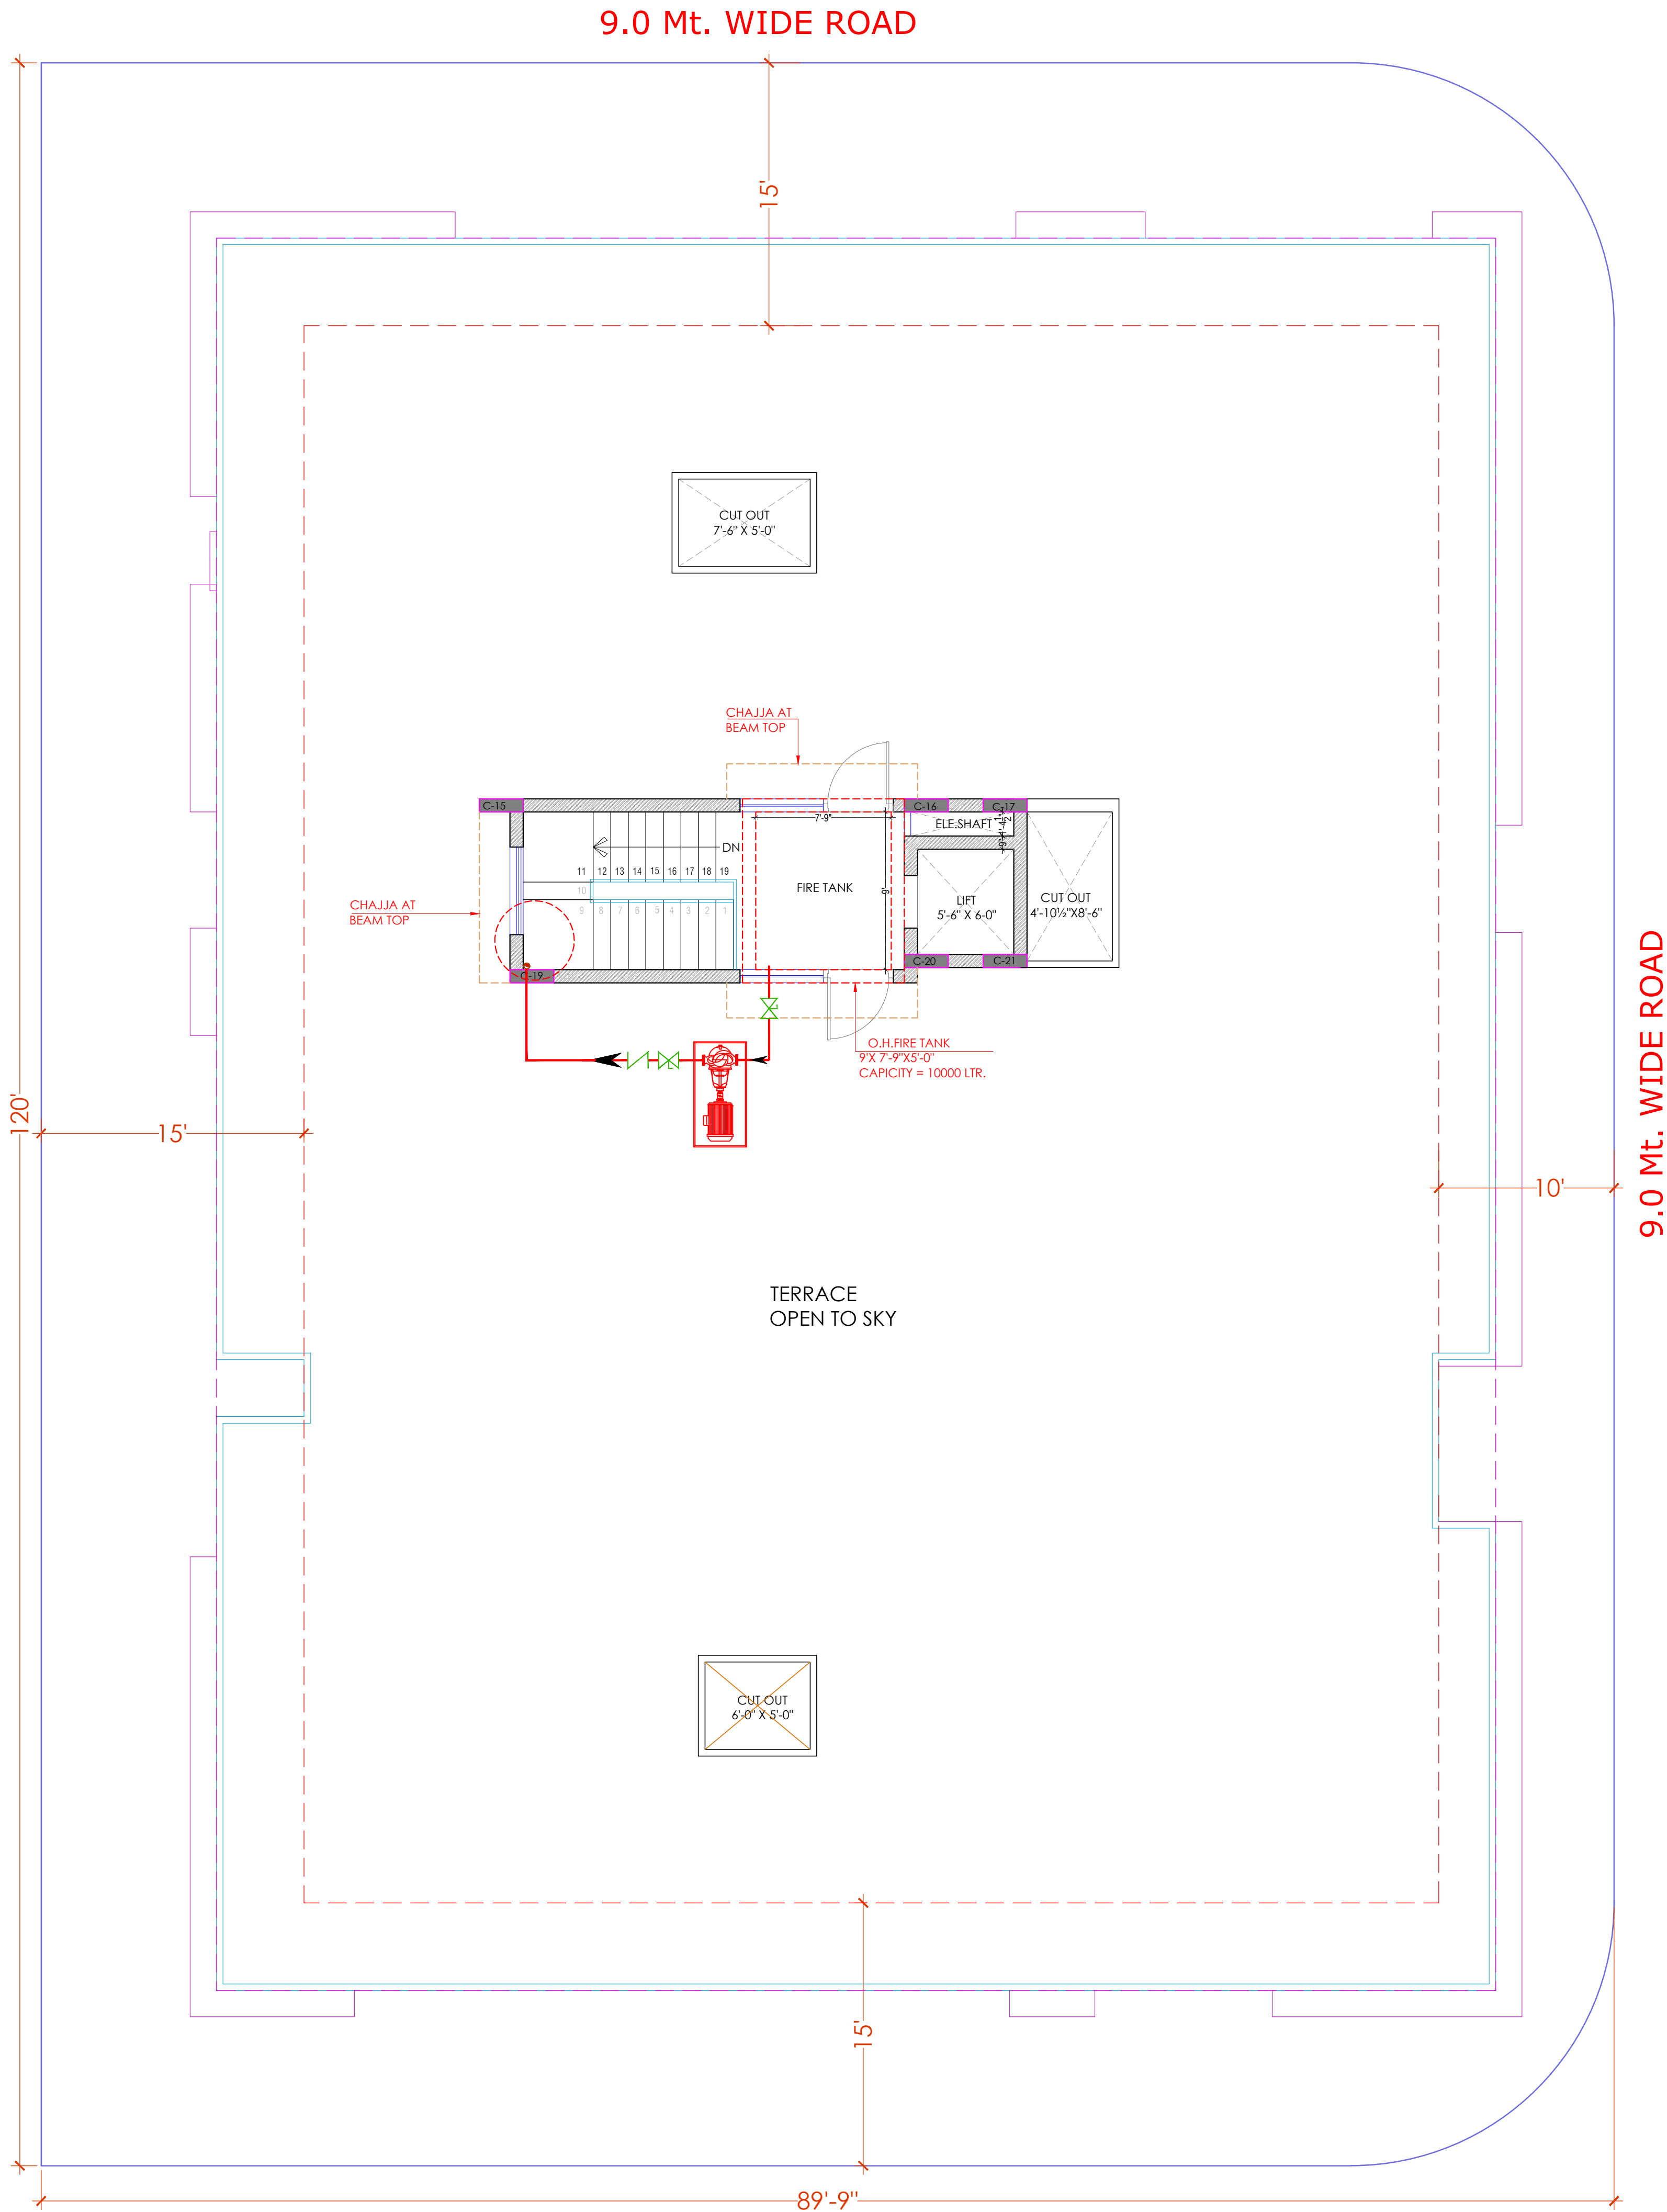

LEGEND:-

FIRE HYDRANT MS PIPE	—
BALL VALVE	⊞
EXTERNAL FIRE HYDRANT	⊞
EXTERNAL FIRE HOSE CABINAT	⊞
FIRE HOSE CABINAT	⊞
UPRIGHT SPRINKLER HEAD	⊞
PENDENT SPRINKLER HEAD	⊞
SIDE WALL SPRINKLER HEAD	⊞
FIRE EXINGUISHER	⊞
FLOW SWITCH	⊞ FS
ISOLATION VALVE	⊞ IV
2 WAY FIRE BRIGADE INLET	⊞

- S.No DATE REVISION DESCRIPTION
- GENERAL NOTES :
- All dimension on this drawing are in MKS System Only written dimensions are to be followed drawing should not be scaled.
 - All measurements must be checked and verified by the contractors prior to execution of work at the site.
 - This drawing is to be read in conjunction with all relevant structural, services & facility planning drawings.
 - Architectural drawings are to be followed for the location of all structural members & masonry walls, for sizes & reinforcement details of structural members, relevant structural drawings are to be referred.
 - Any discrepancies between architectural, structural and services drawings must be brought to the notice of the architects immediately & prior to execution at site. Co-ordination with services such as hvac, plumbing & electrical, etc. is the responsibility of the contractor.
 - All masonry walls should be aligned with the columns as indicated on the plan, irrespective of the position as calculated with the dimensioning.
 - For details, refer relevant large scale detail drgs. as indicated.

PROJECT:
PROPOSED RESIDENTIAL FLATS ON PLOT NO.- 51, 52, 60 & 61, LAXMAN REKHA, SCHEME NO- 17,JHOTWARA, JAIPUR, RAJASTHAN.

NAME OF DRAWING:
TARRACE FLOOR FIGHTING PLAN, FIRE SCHEMATIC LAYOUT

DRAWING WORKING DRAWING	NORTH:
PROJECT NO. : DATE : 06, Mar.- 2025	SCALE : NTS REV NO. : R-0
DRAWING NO. : PROJECT CATEGORY BLOCK FLOOR TYPE NUMBER A-202	

Er. SANJEEV SHARMA
B.E (Electrical)

For BALAJI BUILDERS
Proprietor

TARRACE FLOOR FIGHTING PLAN,
FIRE SCHEMATIC LAYOUT