

30'0" WIDE ROADROAD

70'

PROJECT NAME :

BALAJI AASHIYANA II

DEVELOPER NAME :

BALAJI BUILDER

ARCHITECTS :

4 INSIDE

ARCHITECTURE N INTERIORS

Plot no. 72, S.P. Marg , C- Scheme

jaipur, rajasthan, India

cont: +91 9950595991 , 91

9982812777

e.mail: 4insideofficial@gmail.com

LEGENDS:

Mounting Height	I D	Symbol	Description
CEILING	FAN/48"		CEILING FAN 48"
CEILING	FAN/30"		CEILING FAN 30"
CEILING	CH1		CHANDELIER
+93"	TL/W		Led Wall Tube Light
+93"	BULB		Led Bulb 20W
+93"	GL		WALL BRACKETS AS DESIGN FOR GANESH LIGHT
+78"	ML		12x2 Led Mirror Light
CEILING	DL		Led 6" Down Lighter 20W (Surface Mounted)
VENTILATOR HT.	CR		CEILING ROSE
VENTILATOR HT.	EXP		9" DIA FRESH AIR FAN
+24"	2wSB		2wSWITCH BOARD
+42"	SB		SWITCH BOARD(6A SOCKET & SWITCH)
+24"	TEL		TELEPHONE POINT
+24"	LP TEL		6 A PLUG POINT FOR TELEPHONE
+48"	TV		TV COAXIAL POINT
+48"	LP TV		6 A PLUG POINT FOR TV
+24"	LP		6 A PLUG POINT FOR SIDE TABLE
+72"	LP-CH		6 A PLUG POINT FOR CHIMNEY
+12"	LP PC		6 A PLUG FOR COMPUTER POINT
+93"	SAC		SPLIT AC INDOOR UNIT
+42"	PP-MIX		16 A POWER POINT FOR MIXER
+42"	PP-MIC		16 A POWER POINT FOR MICROWAVE
+78"	PP-G		16 A POWER POINT FOR GEYSER
+54"	PP-F		16 A POWER POINT FOR FRIDGE
+78"	PP-WP		16 A POWER POINT FOR WATER PURIFIER
+48"	PP-WM		16 A POWER POINT FOR WASHING MACHINE
+12"	PP-INV.		16 A POWER POINT FOR INVERTOR
+93"	PP-AC		25A SWITCH/MCB FOR AC
			CHAMBER(2' X 2')
+18"			6A 2 NOS. SOCKET +1 NOS. 16A SWITCH, TELEPHONE LAN
+60"	MCB DB		MCB DISTRIBUTION BOARD
			CAMERA
			WALL FAN

BSB	6A S/S ,FAN REGULATOR,TL SWITCH
BAC	6A S/S ,25 A AC
	EL (EXTERNAL LIGHT)

PROJECT:

PLOT NO. 49,50,62 & 63
SCHEME NO.17 LAXMAN REKHA
JAIPUR.

NAME OF DRAWING:

STILT FLOOR ELECTRIC SUB-STATION,
CABLE CHAMBER, PIPE ROUTE &
LIGHTENING ARRESTER PLAN

DRAWING WORKING DRAWING	NORTH:
PROJECT NO. :	DATE : 18, Nov. - 2024
SCALE : NTS	REV NO. : R-0

DRAWING NO. : PROJECT CATEGORY BLOCK FLOOR TYPE NUMBER	A-501
--	-------

P.NO.48

P.NO.64

P.NO.51

120'

P.NO.61

DRIVEWAY

DRIVEWAY

ENTRY /EXIT

ENTRY /EXIT

69'-6"

60'0" WIDE ROADROAD

Er. SANJEEV SHARMA
B.E (Electrical)

For BALAJI BUILDERS
Proprietor

STILT FLOOR ELECTRIC SUB-STATION,
CABLE CHAMBER, PIPE ROUTE &
LIGHTENING ARRESTER PLAN

30'0" WIDE ROADROAD

70'

PROJECT NAME :

BALAJI AASHIYANA II

DEVELOPER NAME :

BALAJI BUILDER

ARCHITECTS :

4 INSIDE

ARCHITECTURE N INTERIORS

Plot no. 72, S.P. Marg, C- Scheme

jaipur, rajasthan, India

cont: +91 9950595991, 91

9982812777

e.mail: 4insideofficial@gmail.com

LEGENDS:

Mounting Height	I D	Symbol	Description
CEILING	FAN/48"		CEILING FAN 48"
CEILING	FAN/30"		CEILING FAN 30"
CEILING	CH1		CHANDELIER
+93"	TL/W		Led Wall Tube Light
+93"	BULB		Led Bulb 20W
+93"	GL		WALL BRACKETS AS DESIGN FOR GANESH LIGHT
+78"	ML		12x2 Led Mirror Light
CEILING	DL		Led 6" Down Lighter 20W (Surface Mounted)
VENTILATOR HT.	CR		CEILING ROSE
VENTILATOR HT.	EXP		9" DIA FRESH AIR FAN
+24"	2wSB		2w SWITCH BOARD
+42"	SB		SWITCH BOARD(6A SOCKET & SWITCH)
+24"	TEL		TELEPHONE POINT
+24"	LP TEL		6 A PLUG POINT FOR TELEPHONE
+48"	TV		TV COAXIAL POINT
+48"	LP TV		6 A PLUG POINT FOR TV
+24"	LP		6 A PLUG POINT FOR SIDE TABLE
+72"	LP-CH		6 A PLUG POINT FOR CHIMNEY
+12"	LP PC		6 A PLUG FOR COMPUTER POINT
+93"	SAC		SPLIT AC INDOOR UNIT
+42"	PP-MIX		16 A POWER POINT FOR MIXER
+42"	PP-MIC		16 A POWER POINT FOR MICROWAVE
+78"	PP-G		16 A POWER POINT FOR GEYSER
+54"	PP-F		16 A POWER POINT FOR FRIDGE
+78"	PP-WP		16 A POWER POINT FOR WATER PURIFIER
+48"	PP-WM		16 A POWER POINT FOR WASHING MACHINE
+12"	PP-INV.		16 A POWER POINT FOR INVERTOR
+93"	PP-AC		25A SWITCH/MCB FOR AC
			CHAMBER(2' X 2')
+18"			6A 2 NOS. SOCKET +1 NOS. 16A SWITCH, TELEPHONE LAN
+60"	MCB DB		MCB DISTRIBUTION BOARD
			CAMERA
			WALL FAN

BSB	6A S/S, FAN REGULATOR, TL SWITCH
BAC	6A S/S, 25 A AC
EL	EL (EXTERNAL LIGHT)

PROJECT:

PLOT NO. 49,50,62 & 63
SCHEME NO.17 LAXMAN REKHA
JAIPUR.

NAME OF DRAWING:

STILT FLOOR EXTERNAL LIGHTING,
CEILING ELECTRICAL LAYOUT,
ELECTRICAL POINT DRAWING,
CAMERA POINT DRAWING

DRAWING	NORTH:
WORKING DRAWING	
PROJECT NO. :	DATE : 18, Nov. - 2024
SCALE : NTS	REV NO. : R-0

DRAWING NO. :

			-		-						
PROJECT			CATEGORY		BLOCK	FLOOR		TYPE		NUMBER	

A-501

P.NO.48

P.NO.64

P.NO.51

P.NO.61

DRIVEWAY

DRIVEWAY

ENTRY /EXIT

ENTRY /EXIT

60'0" WIDE ROADROAD

69'-6"

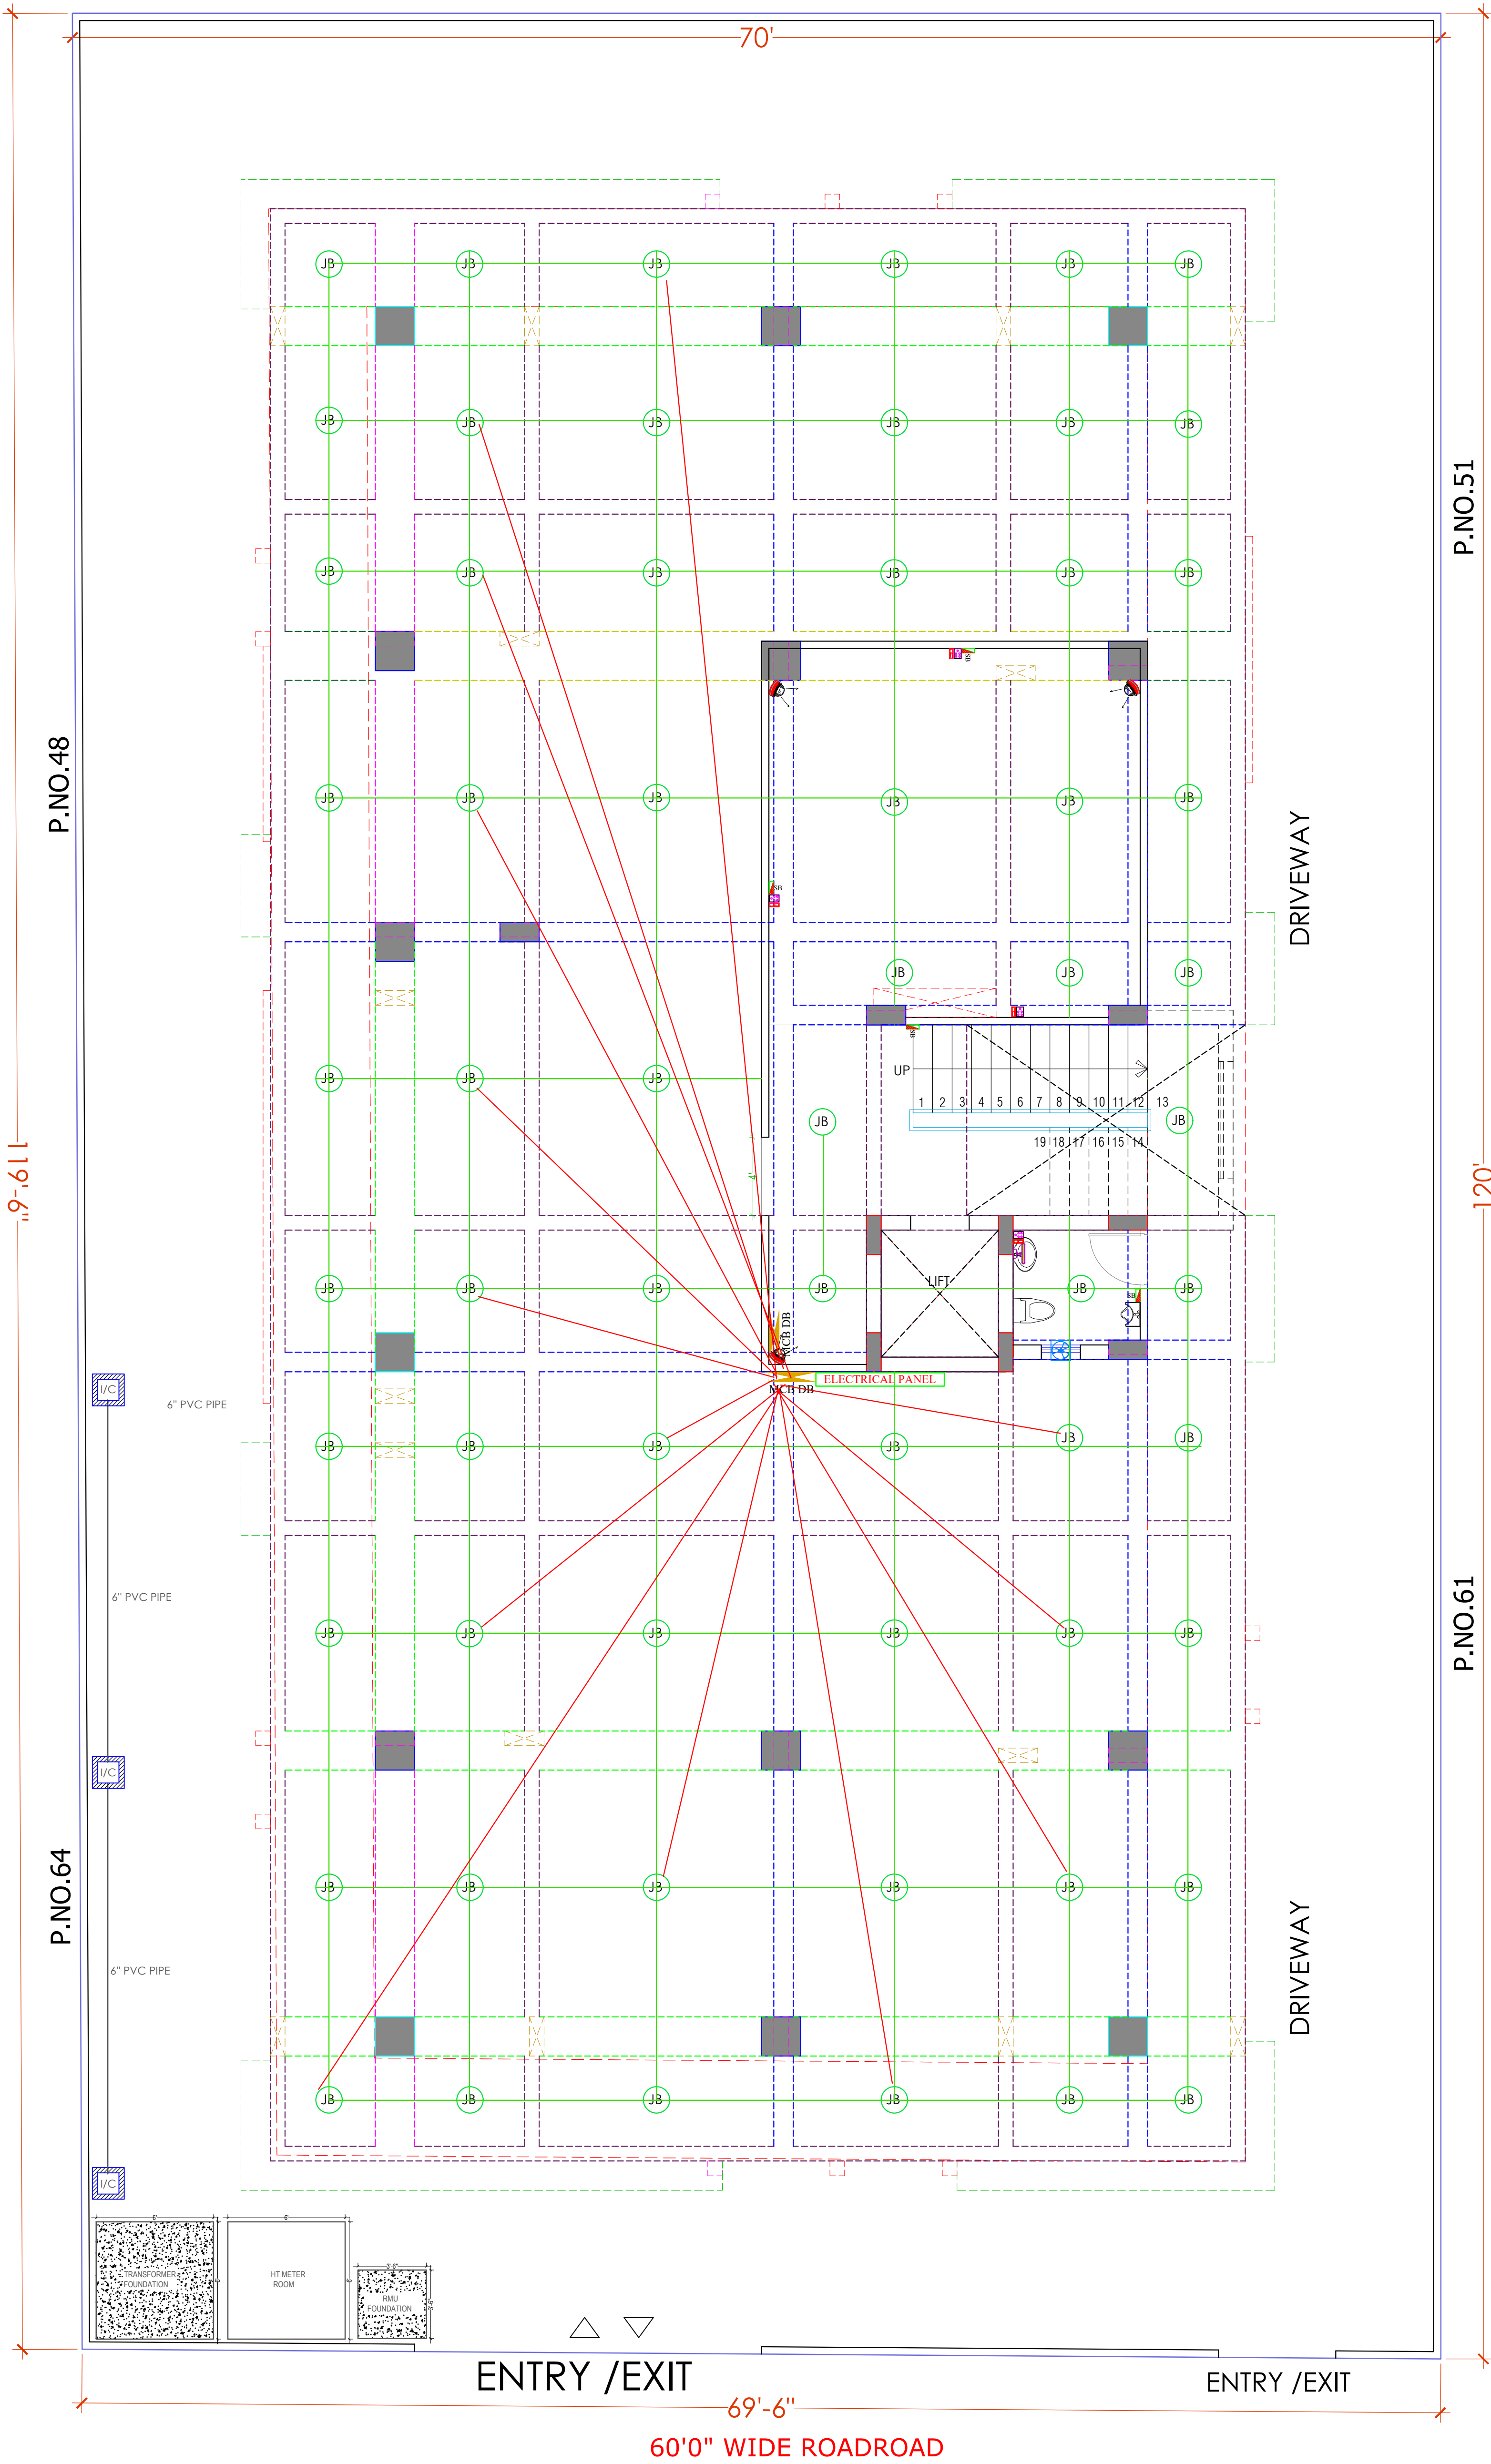
Er. SANJEEV SHARMA
B.E (Electrical)

For BALAJI BUILDERS
Proprietor

STILT FLOOR EXTERNAL LIGHTING, CEILING ELECTRICAL LAYOUT,
ELECTRICAL POINT DRAWING, CAMERA POINT DRAWING,

	25 MM PVC CONDUIT FOR JB TO WALL POINT
	32 MM PVC CONDUIT FOR DB TO JB (JUNCTION BOX)

30'0" WIDE ROADROAD



PROJECT NAME :
BALAJI AASHIYANA II

DEVELOPER NAME :
BALAJI BUILDER

ARCHITECTS :
4 INSIDE
ARCHITECTURE N INTERIORS
Plot no. 72, S.P. Marg , C- Scheme
jaipur, rajasthan, India
cont: +91 9950595991 , 91
9982812777
e.mail: 4insideofficial@gmail.com

LEGENDS:			
Mounting Height	I D	Symbol	Description
CEILING	FAN/48"		CEILING FAN 48"
CEILING	FAN/30"		CEILING FAN 30"
CEILING	CHI		CHANDELIER
+93"	TL/W		Led Wall Tube Light
+93"	BULB		Led Bulb 20W
+93"	GL		WALL BRACKETS AS DESIGN FOR GANESH LIGHT
+78"	ML		12x2 Led Mirror Light
CEILING	DL		Led 6" Down Lighter 20W (Surface Mounted)
VENTILATOR HT.	CR		CEILING ROSE
VENTILATOR HT.	EXF		9" DIA FRESH AIR FAN
+24"	2wSB		2wSWITCH BOARD
+42"	SB		SWITCH BOARD(6A SOCKET & SWITCH)
+24"	TEL		TELEPHONE POINT
+24"	LP TEL		6 A PLUG POINT FOR TELEPHONE
+48"	TV		TV COAXIAL POINT
+48"	LP TV		6 A PLUG POINT FOR TV
+24"	LP		6 A PLUG POINT FOR SIDE TABLE
+72"	LP-CH		6 A PLUG POINT FOR CHIMNEY
+12"	LP PC		6 A PLUG FOR COMPUTER POINT
+93"	SAC		SPLIT AC INDOOR UNIT
+42"	PP-MIX		16 A POWER POINT FOR MIXER
+42"	PP-MIC		16 A POWER POINT FOR MICROWAVE
+78"	PP-G		16 A POWER POINT FOR GEYSER
+54"	PP-F		16 A POWER POINT FOR FRIDGE
+78"	PP-WP		16 A POWER POINT FOR WATER PURIFIER
+48"	PP-WM		16 A POWER POINT FOR WASHING MACHINE
+12"	PP-INV.		16 A POWER POINT FOR INVERTOR
+93"	PP-AC		25A SWITCH/MCB FOR AC
			CHAMBER(2' X 2')
+18"			6A 2 NOS. SOCKET +1 NOS. 16A SWITCH, TELEPHONE LAN
+60"	MCB DB		MCB DISTRIBUTION BOARD
			CAMERA
			WALL FAN
BSB	6A S/S ,FAN REGULATOR,TL SWITCH		
BAC	6A S/S ,25 A AC		
	EL (EXTERNAL LIGHT)		

PROJECT:
PLOT NO. 49,50,62 & 63
SCHEME NO.17 LAXMAN REKHA JAIPUR.

NAME OF DRAWING:

STILT FLOOR LV CONDUIT PLAN
STILT FLOOR ELECTRIC CONDUIT PLAN
CABLE TRAY,ELECTRICAL PANAL,MCB DB

DRAWING WORKING DRAWING	NORTH:
PROJECT NO. :	DATE : 18, Nov. - 2024
SCALE : NTS	REV NO. : R-0
DRAWING NO. : PROJECT / CATEGORY / BLOCK / FLOOR / TYPE / NUMBER A-501	

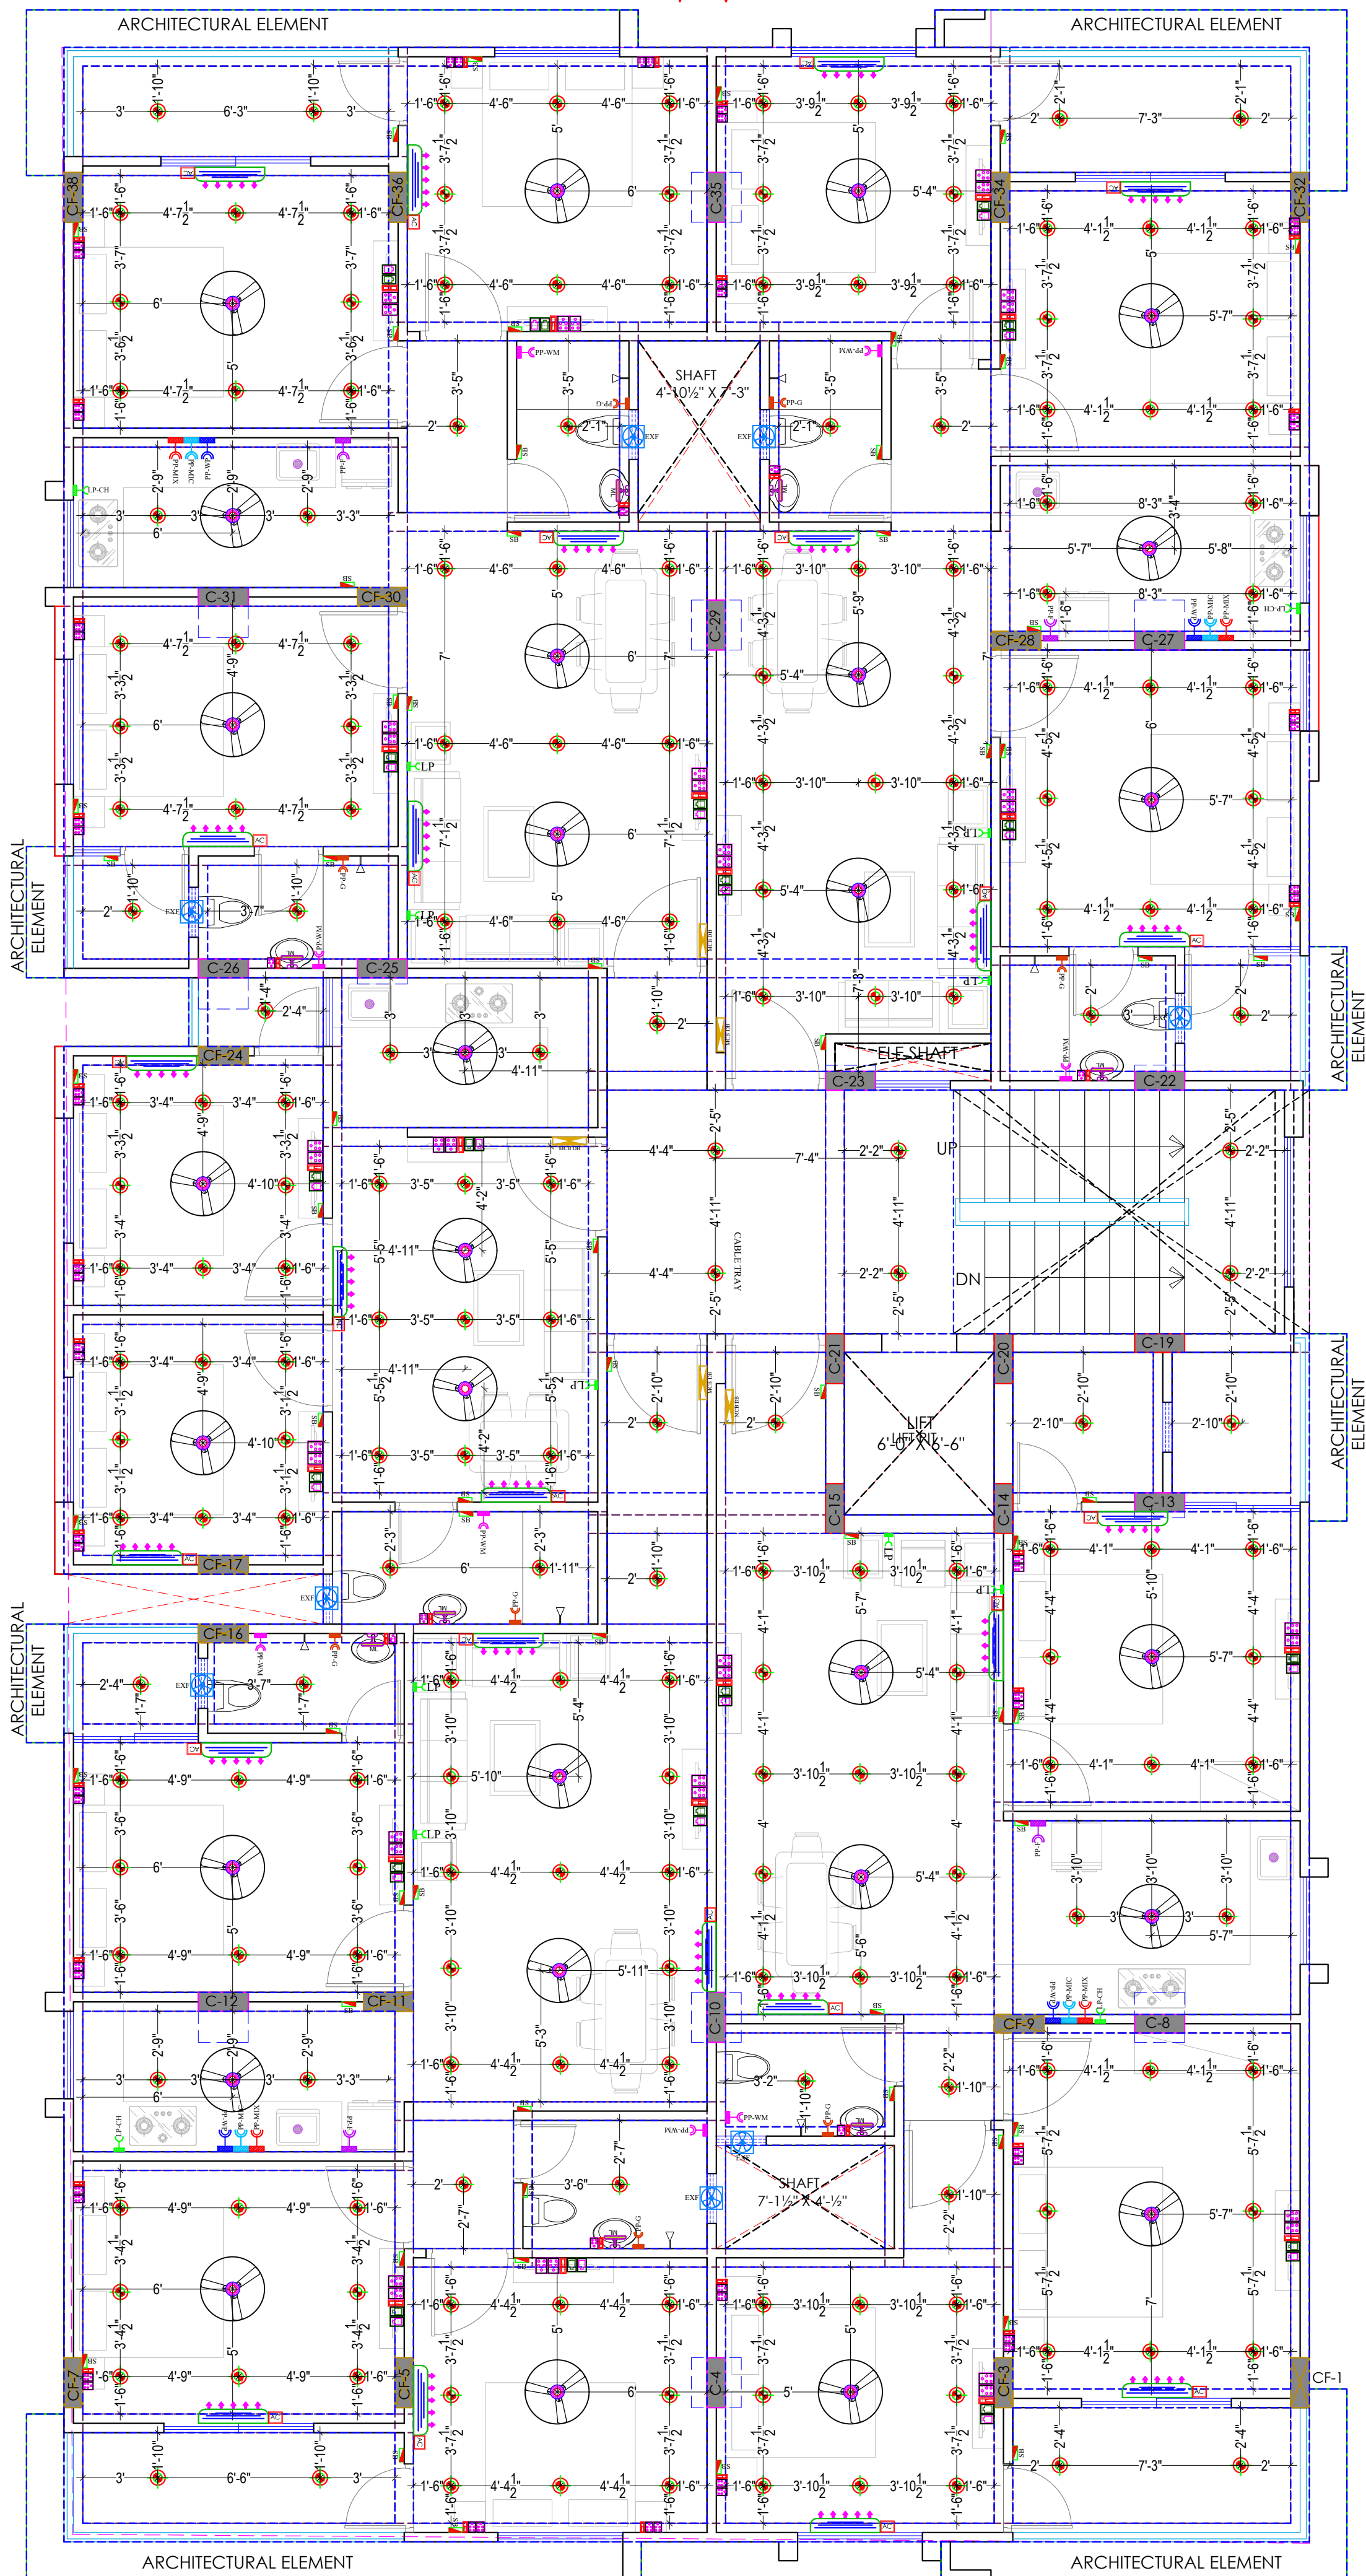
Er. SANJEEV SHARMA
B.E (Electrical)
For BALAJI BUILDERS
Proprietor

STILT FLOOR LV CONDUIT PLAN,
STILT FLOOR ELECTRIC CONDUIT PLAN,
CABLE TRAY,ELECTRICAL PANAL,MCB DB

30'0" WIDE ROADROAD

70'

W



S

N

E

60'0" WIDE ROADROAD

69'-6"

Er. SANJEEV SHARMA
B.E (Electrical)

For BALAJI BUILDERS
Proprietor

TYPICAL FLOOR (GROUND TO FIFTH)
(ELECTRICAL POINT, CEILING POINT,
TV & TELEPHONE RISER DIAGRAM)

PROJECT NAME :

BALAJI AASHIYANA II

DEVELOPER NAME :

BALAJI BUILDER

ARCHITECTS :

4 INSIDE

ARCHITECTURE N INTERIORS

Plot no. 72, S.P. Marg, C- Scheme

 
 
 
 
 
 
 
 
 
 
 
 
 
jaipur, rajasthan, India

cont: +91 9950595991, 91

9982812777

e.mail: 4insideofficial@gmail.com

LEGENDS:

Mounting Height	I D	Symbol	Description
CEILING	FAN/48"		CEILING FAN 48"
CEILING	FAN/30"		CEILING FAN 30"
CEILING	CHI		CHANDELIER
+93"	TL/W		Led Wall Tube Light
+93"	BULB		Led Bulb 20W
+93"	GL		WALL BRACKETS AS DESIGN FOR GANESH LIGHT
+78"	ML		12x2 Led Mirror Light
CEILING	DL		Led 6" Down Lighter 20W (Surface Mounted)
VENTILATOR HT.	CR		CEILING ROSE
VENTILATOR HT.	EXF		9" DIA FRESH AIR FAN
+24"	2wSB		2wSWITCH BOARD
+42"	SB		SWITCH BOARD(6A SOCKET & SWITCH)
+24"	TEL		TELEPHONE POINT
+24"	LP TEL		6 A PLUG POINT FOR TELEPHONE
+48"	TV		TV COAXIAL POINT
+48"	LP TV		6 A PLUG POINT FOR TV
+24"	LP		6 A PLUG POINT FOR SIDE TABLE
+72"	LP-CH		6 A PLUG POINT FOR CHIMNEY
+12"	LP PC		6 A PLUG FOR COMPUTER POINT
+93"	SAC		SPLIT AC INDOOR UNIT
+42"	PP-MIX		16 A POWER POINT FOR MIXER
+42"	PP-MIC		16 A POWER POINT FOR MICROWAVE
+78"	PP-G		16 A POWER POINT FOR GEYSER
+54"	PP-F		16 A POWER POINT FOR FRIDGE
+78"	PP-WP		16 A POWER POINT FOR WATER PURIFIER
+48"	PP-WM		16 A POWER POINT FOR WASHING MACHINE
+12"	PP-INV.		16 A POWER POINT FOR INVERTOR
+93"	PP-AC		25A SWITCH/MCB FOR AC
			CHAMBER(2' X 2')
+18"			6A 2 NOS. SOCKET +1 NOS. 16A SWITCH, TELEPHONE LAN
+60"	MCB DB		MCB DISTRIBUTION BOARD
			CAMERA
			WALL FAN

BSB 6A S/S .FAN REGULATOR,TL SWITCH

BAC 6A S/S .25 A AC

EL (EXTERNAL LIGHT)

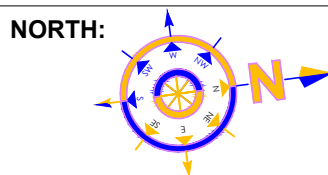
PROJECT:

PLOT NO. 49,50,62 & 63
SCHEME NO.17 LAXMAN REKHA
JAIPUR.

NAME OF DRAWING:

TYPICAL FLOOR (GROUND TO FIFTH)
(ELECTRICAL POINT, CEILING POINT,
TV & TELEPHONE RISER DIAGRAM)

DRAWING
WORKING DRAWING



PROJECT NO. :

DATE :
18, Nov. - 2024

SCALE :

REV NO. :

R-0

DRAWING NO. :

PROJECT CATEGORY BLOCK FLOOR TYPE NUMBER

A-501

	25 MM PVC CONDUIT FOR JB TO WALL POINT
	32 MM PVC CONDUIT FOR DB TO JB (JUNCTION BOX)

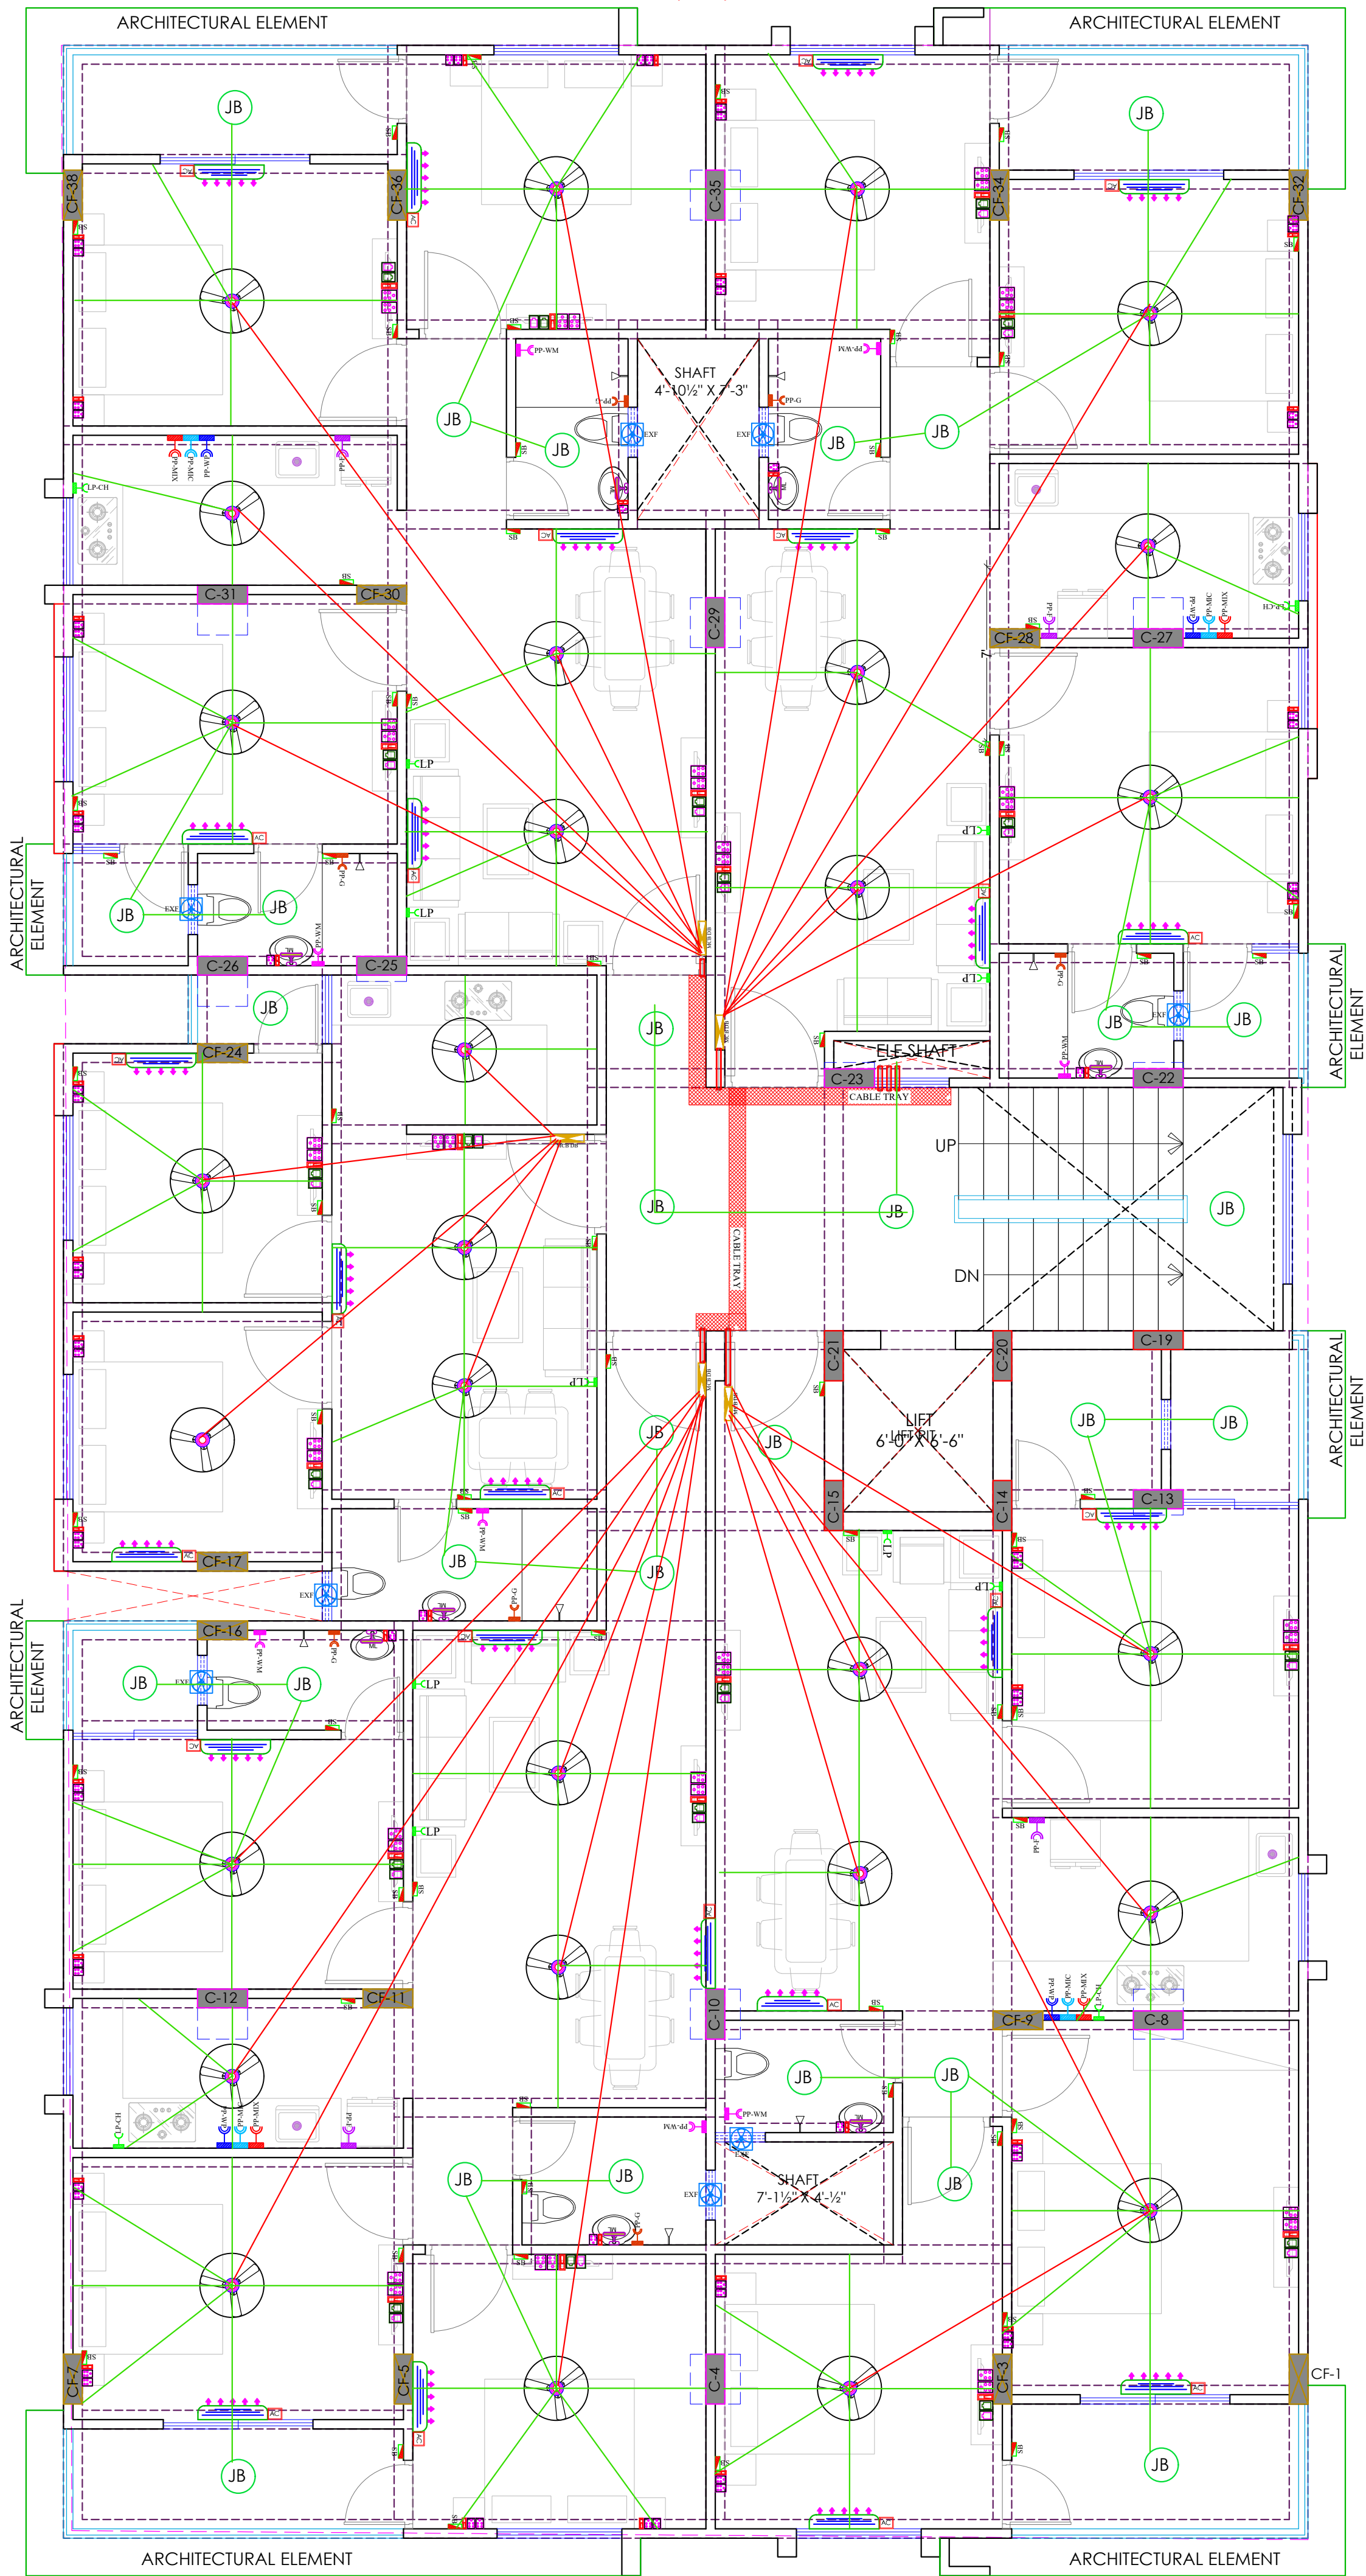
30'0" WIDE ROADROAD

P.NO.48

P.NO.64

P.NO.51

P.NO.61



69'-6"
60'0" WIDE ROADROAD

PROJECT NAME :

BALAJI AASHIYANA II

DEVELOPER NAME :

BALAJI BUILDER

ARCHITECTS :

4 INSIDE

ARCHITECTURE N INTERIORS

Plot no. 72, S.P. Marg , C- Scheme

jaipur, rajasthan, India

cont: +91 9950595991 , 91

9982812777

e.mail: 4insideofficial@gmail.com

LEGENDS:

Mounting Height	I D	Symbol	Description
CEILING	FAN/48"		CEILING FAN 48"
CEILING	FAN/30"		CEILING FAN 30"
CEILING	CHI		CHANDELIER
+93"	TL/W		Led Wall Tube Light
+93"	BULB		Led Bulb 20W
+93"	GL		WALL BRACKETS AS DESIGN FOR GANESH LIGHT
+78"	ML		12x2 Led Mirror Light
CEILING	DL		Led 6" Down Lighter 20W (Surface Mounted)
VENTILATOR HT.	CR		CEILING ROSE
VENTILATOR HT.	EXF		9" DIA FRESH AIR FAN
+24"	2wSB		2wSWITCH BOARD
+42"	SB		SWITCH BOARD(6A SOCKET & SWITCH)
+24"	TEL		TELEPHONE POINT
+24"	LP TEL		6A PLUG POINT FOR TELEPHONE
+48"	TV		TV COAXIAL POINT
+48"	LP TV		6A PLUG POINT FOR TV
+24"	LP		6A PLUG POINT FOR SIDE TABLE
+72"	LP-CH		6A PLUG POINT FOR CHIMNEY
+12"	LP PC		6A PLUG FOR COMPUTER POINT
+93"	SAC		SPLIT AC INDOOR UNIT
+42"	PP-MIX		16 A POWER POINT FOR MIXER
+42"	PP-MIC		16 A POWER POINT FOR MICROWAVE
+78"	PP-G		16 A POWER POINT FOR GEYSER
+54"	PP-F		16 A POWER POINT FOR FRIDGE
+78"	PP-WP		16 A POWER POINT FOR WATER PURIFIER
+48"	PP-WM		16 A POWER POINT FOR WASHING MACHINE
+12"	PP-INV.		16 A POWER POINT FOR INVERTOR
+93"	PP-AC		25A SWITCH/MCB FOR AC
			CHAMBER(2' X 2')
+18"			6A 2 NOS. SOCKET +1 NOS. 16A SWITCH, TELEPHONE, LAN
+60"	MCB DB		MCB DISTRIBUTION BOARD
			CAMERA
			WALL FAN

BSB	6A S/S, FAN REGULATOR, TL SWITCH
BAC	6A S/S, 25 A AC
	EL (EXTERNAL LIGHT)

PROJECT:

PLOT NO. 49,50,62 & 63
SCHEME NO.17 LAXMAN REKHA
JAIPUR.

NAME OF DRAWING:

TYPICAL FLOOR (GROUND TO 5TH)
LV CONDUIT PLAN,
ELECTRIC CONDUIT PLAN,ELECTRICAL DB,
ELECTRICAL SHAFT, CABLE TRAY

DRAWING	NORTH:
WORKING DRAWING	
PROJECT NO. :	DATE : 18, Nov. - 2024
SCALE : NTS	REV NO. : R-0

DRAWING NO. :

		-					
PROJECT	CATEGORY	BLOCK	FLOOR	TYPE	NUMBER		

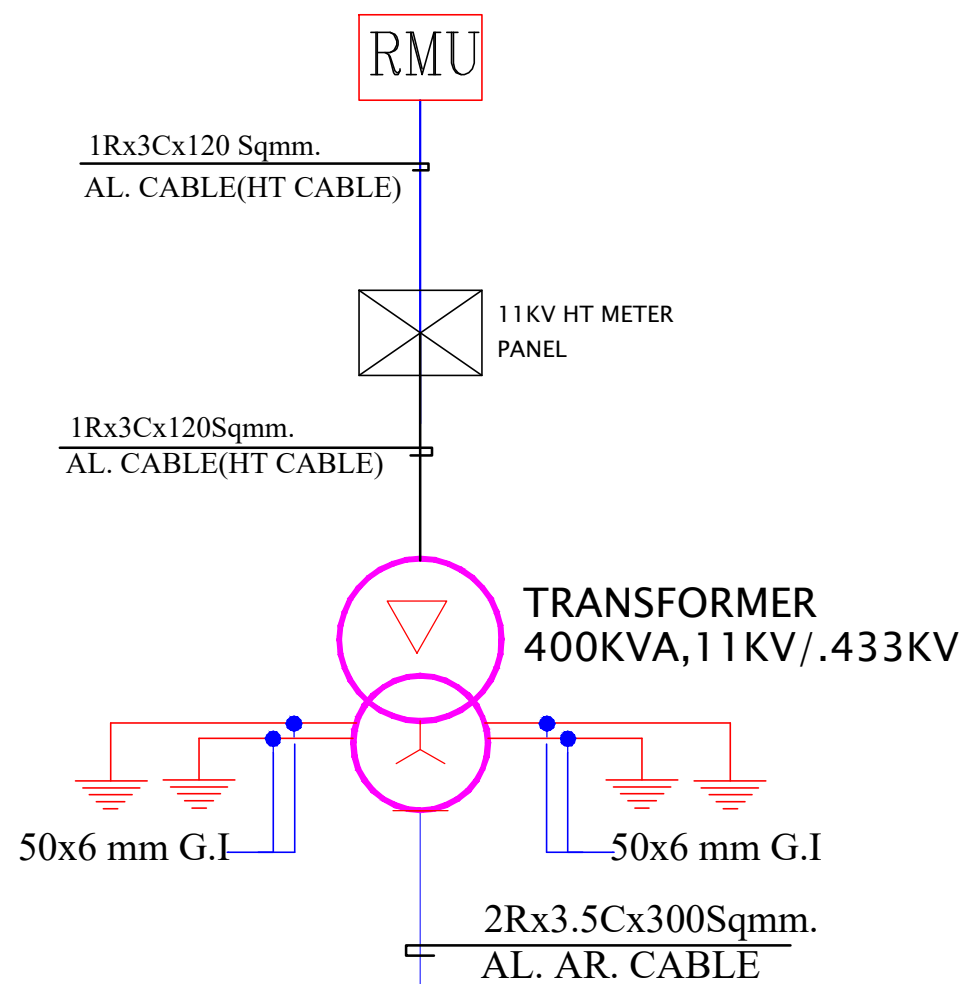
A-501

Er. SANJEEV SHARMA
B.E (Electrical)


For BALAJI BUILDERS
Proprietor

TYPICAL FLOOR (GROUND TO FIFTH)
LV CONDUIT PLAN,ELECTRIC CONDUIT PLAN,
ELECTRICAL DB,ELECTRICAL SHAFT, CABLE TRAY


MAIN PANEL



30 NOS. METER PANEL

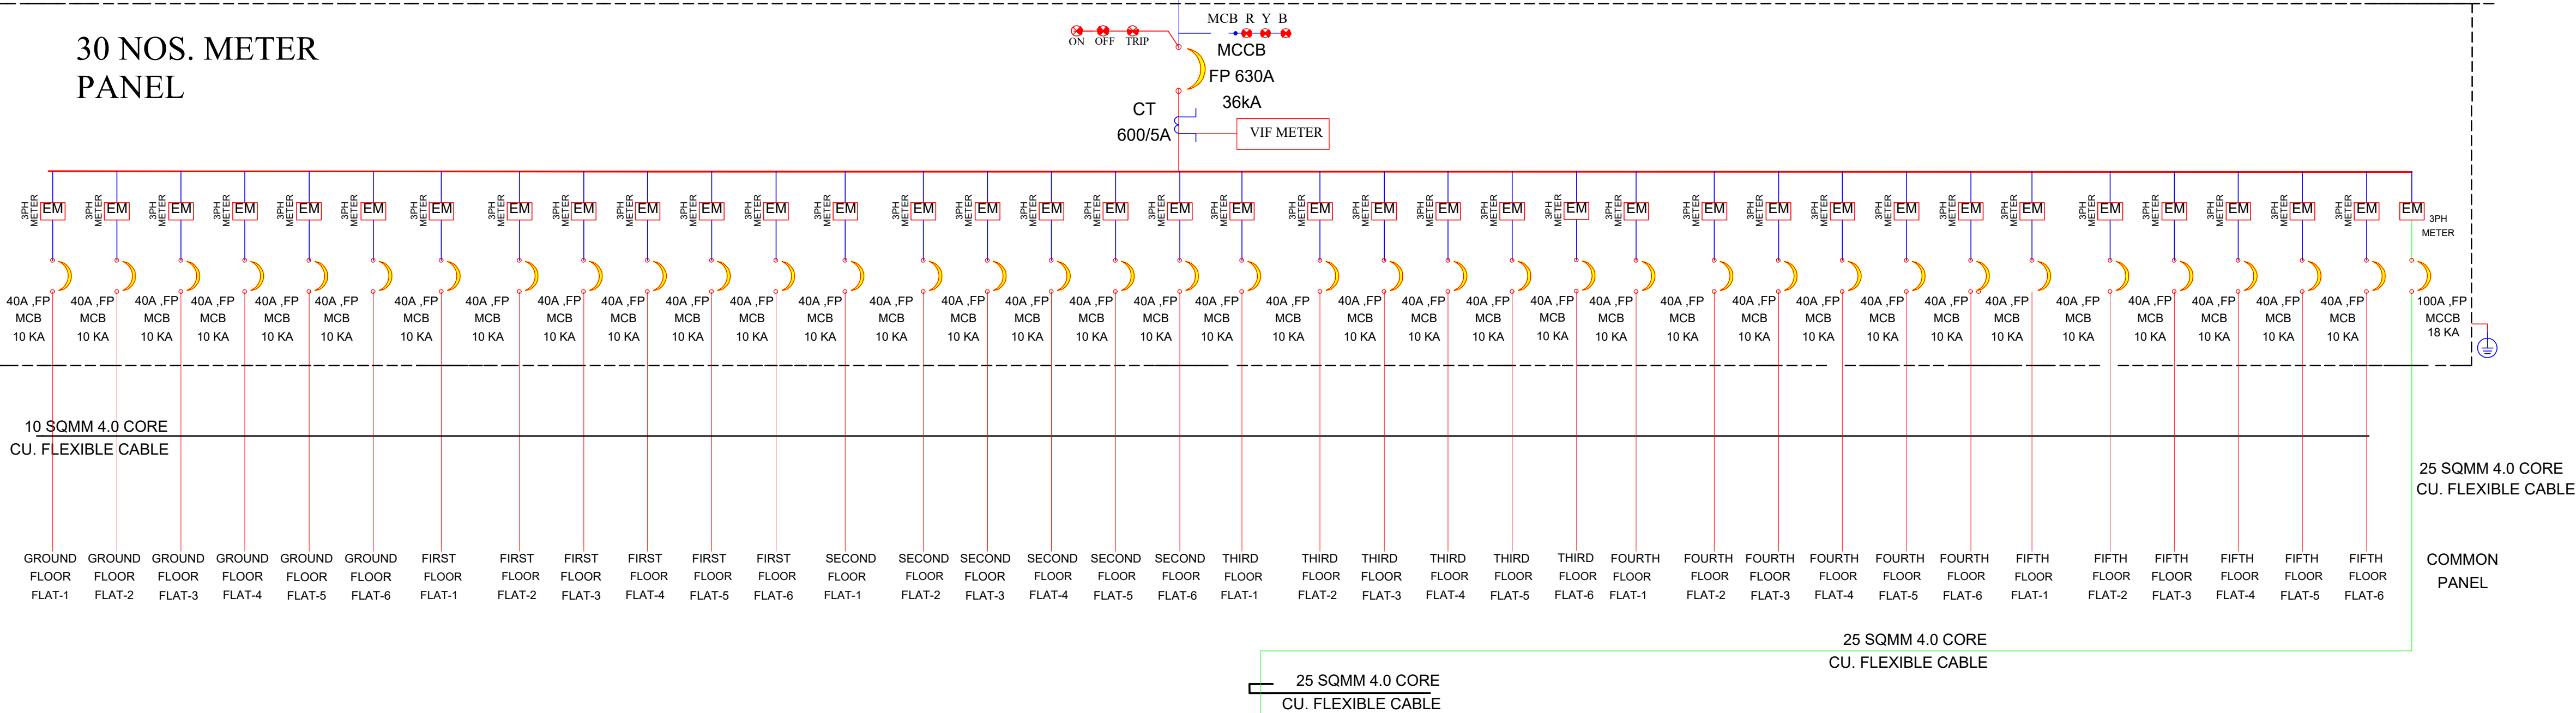

COMMON LIGHT PANEL

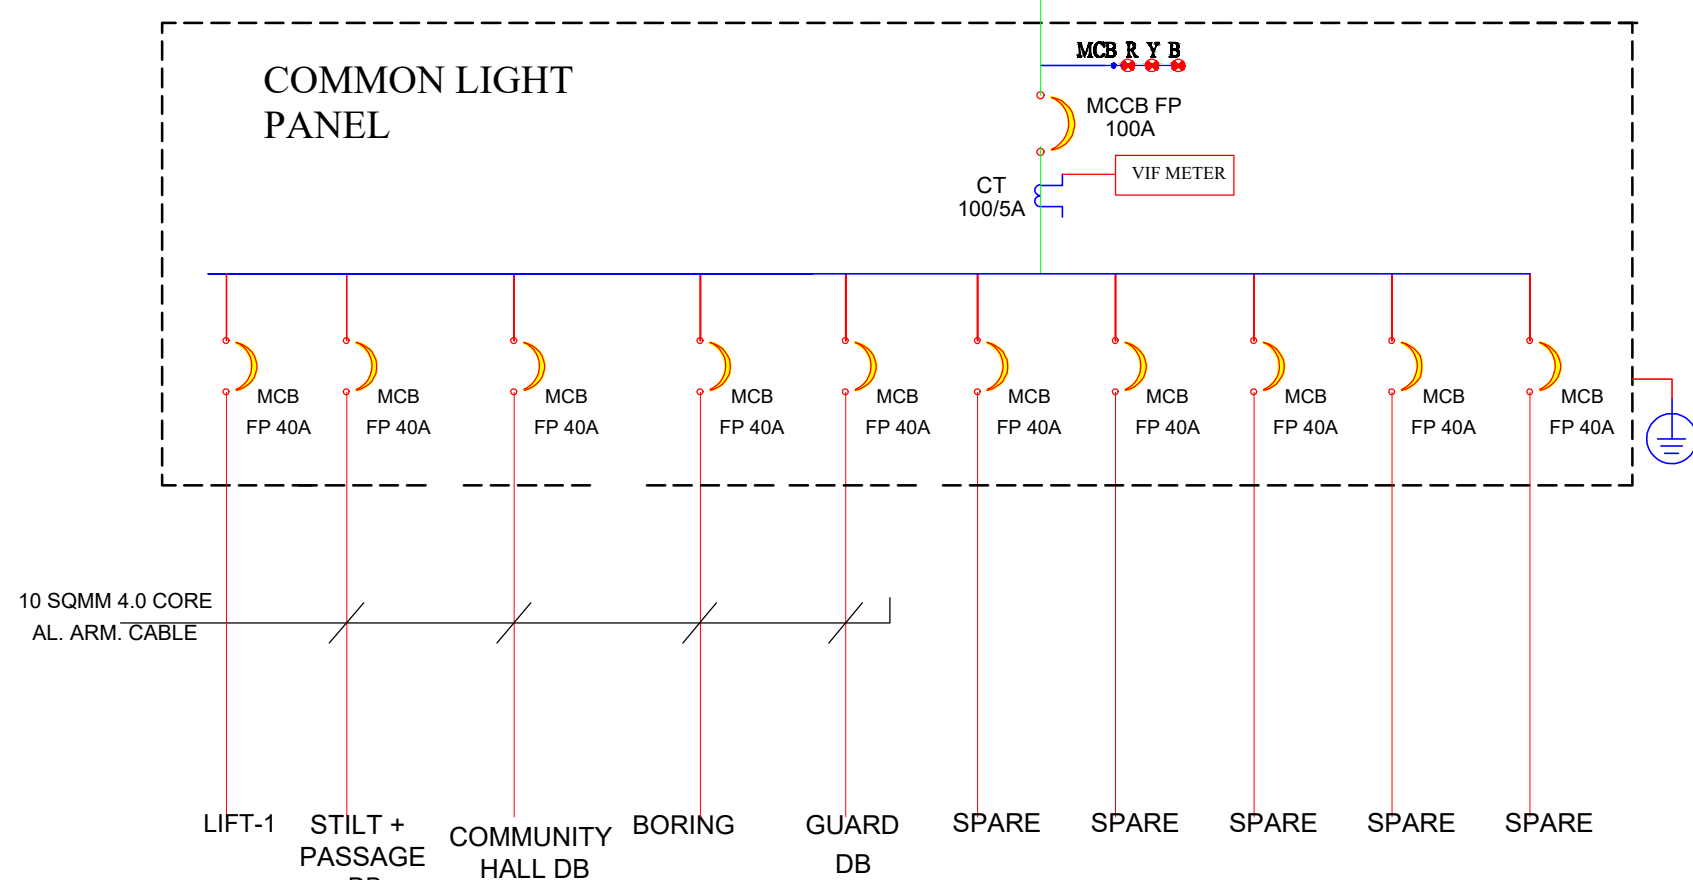

Er. SANJEEV SHARMA
B.E (Electrical)

For BALAJI BUILDERS
Proprietor

MAIN LT PANEL AND SLD DRAWING

PROJECT NAME :
BALAJI AASHIYANA II

DEVELOPER NAME :
BALAJI BUILDER

ARCHITECTS :
4 INSIDE
ARCHITECTURE N INTERIORS
Plot no. 72, S.P. Marg, C- Scheme
jaipur, rajasthan, India
cont: +91 9950595991, 91
9982812777
e.mail: 4insideofficial@gmail.com

LEGENDS:			
Mounting Height	ID	Symbol	Description
CEILING	FAN48"		CEILING FAN 48"
CEILING	FAN30"		CEILING FAN 30"
CEILING	CHI		CHANDELIER
+93"	TLW		Led Wall Light
+93"	BULB		Led Bulb 20W
+93"	GL		WALL BRACKETS AS DESIGN FOR GANESH LIGHT
+78"	ML		12x2 Led Mirror Light
CEILING	DL		Led 6" Down Lighter 20W (Surface Mounted)
VENTILATOR HT	CR		CEILING ROSE
VENTILATOR HT	EXF		9" DIA FRESH AIR FAN
+24"	2wSB		2w SWITCH BOARD
+42"	SB		SWITCH BOARD(6A SOCKET & SWITCH)
+24"	TEL		TELEPHONE POINT
+24"	LP TEL		6 A PLUG POINT FOR TELEPHONE
+48"	TV		TV COAXIAL POINT
+48"	LP TV		6 A PLUG POINT FOR TV
+24"	LP		6 A PLUG POINT FOR SIDE TABLE
+72"	LP-CH		6 A PLUG POINT FOR CHIMNEY
+12"	LP PC		6 A PLUG FOR COMPUTER POINT
+93"	SAC		SPLIT AC INDOOR UNIT
+42"	PP-MIX		16 A POWER POINT FOR MIXER
+42"	PP-MIC		16 A POWER POINT FOR MICROWAVE
+78"	PP-G		16 A POWER POINT FOR GEYSER
+54"	PP-F		16 A POWER POINT FOR FRIDGE
+78"	PP-WP		16 A POWER POINT FOR WATER PURIFIER
+48"	PP-WM		16 A POWER POINT FOR WASHING MACHINE
+12"	PP-INV.		16 A POWER POINT FOR INVERTOR
+93"	PP-AC		25A SWITCH MCB FOR AC
			CHAMBER(2" X 2")
+18"			6A 2 NOS SOCKET-1 NOS 16A SWITCH TELEPHONE LAN
+60"	MCB DB		MCB DISTRIBUTION BOARD
			CAMERA
			WALL FAN

BSB	6A S/S FAN REGULATOR, L SWITCH
BAC	6A S/S 25 A AC
☒	EL (EXTERNAL LIGHT)

PROJECT:
PLOT NO. 49,50,62 & 63
SCHEME NO.17 LAXMAN REKHA JAIPUR.

NAME OF DRAWING:
MAIN LT PANEL AND SLD DRAWING

DRAWING WORKING DRAWING	NORTH:
PROJECT NO.:	DATE: 18, Nov. - 2024
SCALE: NTS	REV NO.: R-0

DRAWING NO.:	
PROJECT	CATEGORY
BLOCK	FLOOR
TYPE	NUMBER