


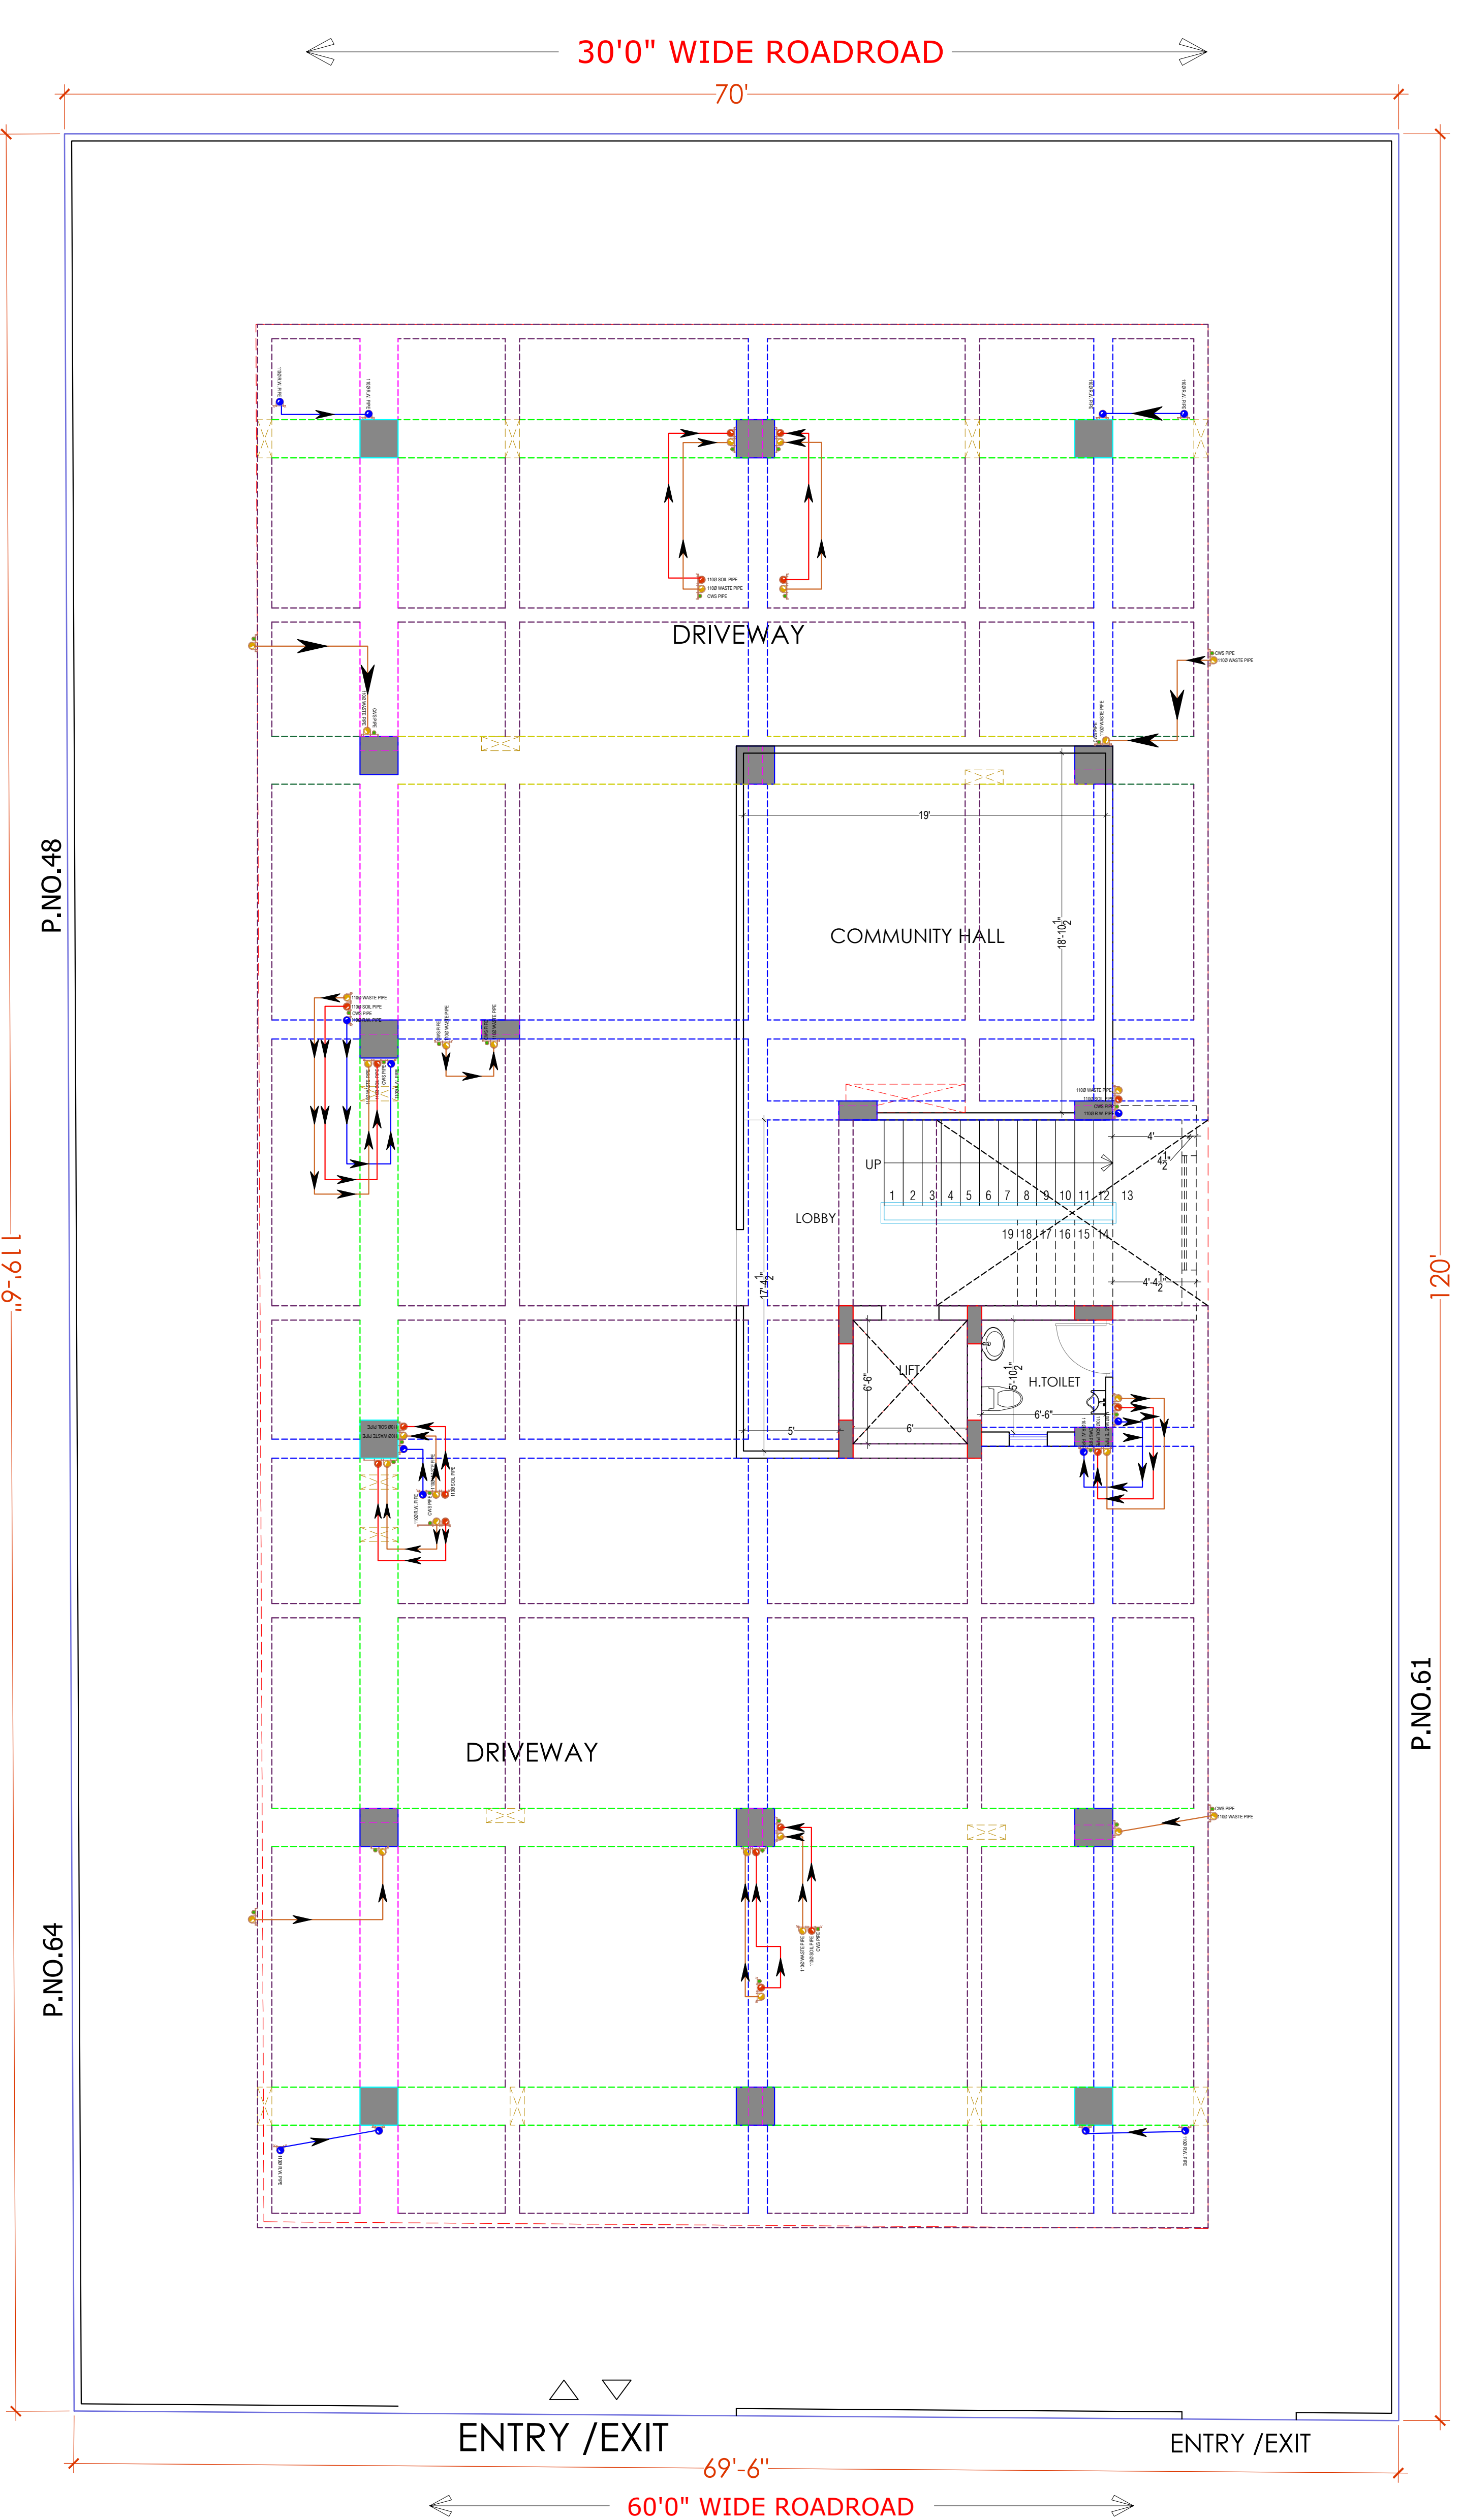

PROJECT NAME :
BALAJI AASHIYANA II

DEVELOPER NAME :
BALAJI BUILDER

ARCHITECTS :
4 INSIDE
ARCHITECTURE N INTERIORS
Plot no. 72, S.P. Marg , C- Scheme
jaipur, rajasthan, India
cont: +91 9950595991 , 91
9982812777
e.mail: 4insideofficial@gmail.com

LEGEND:-

①	SOIL PIPE	—
②	WASTE PIPE	—
③	VENT PIPE	—
④	COLD WATER SUPPLY (CWS)	—
⑤	HOT WATER SUPPLY (HWS)	—
	RAIN WATER PIPE	—
SW	SEWER LINE- EXTERNAL	—
RW	STORM WATER DRAINAGE PIPE	—
	SEWERAGE MANHOLE (2' x 2')	M.H.
	STORM WATER MANHOLE (2' x 2')	M.H.
GT	GULLY TRAP	
BV	BALL VALVE	
FT	FLOOR TRAP	
FD	FLOOR FLOOR DRAIN	
	RAIN WATER COLLECTION CHAMBER 450X450MM	
	KHURRA	

S.NO	DATE	REVISION DESCRIPTION
1.		All dimension on this drawing are in MKS System Only written dimensions are to be followed drawing should not be scaled.
2.		All measurements must be checked and verified by the contractors prior to execution of work at the site.
3.		This drawing is to be read in conjunction with all relevant structural, services & facility planning drawings.
4.		Architectural drawings are to be followed for the location of all structural members & masonry walls, for sizes & reinforcement details of structural members, relevant structural drawings are to be referred.
5.		Any discrepancies between architectural, structural and services drawings must be brought to the notice of the architects immediately & prior to execution at site.
6.		Co-ordinate with services such as hvac, plumbing & electrical, etc. is the responsibility of the contractors.
7.		All masonry walls should be aligned with the columns as indicated on the plan, irrespective of the position as calculated with the dimensions.
8.		For details, refer relevant large scale detail drgs. as indicated.

PROJECT:
PLOT NO. 49,50,62 & 63
SCHEME NO.17 LAXMAN REKHA
JAIPUR.

NAME OF DRAWING:
STILT FLOOR STORM WATER DRAINAGE LAYOUT & CEILING DRAINAGE LAYOUT PLAN

DRAWING WORKING DRAWING	NORTH:
PROJECT NO. :	DATE : 21, Nov. - 2024
SCALE : NTS	REV NO. : R-0

DRAWING NO. :	DRAWING PATH :
PROJECT CATEGORY BLOCK FLOOR TYPE NUMBER	A-201

For BALAJI BUILDERS
Proprietor

Er. SANJEEV SHARMA
B.E (Electrical)

STILT FLOOR STORM WATER DRAINAGE LAYOUT & CEILING DRAINAGE LAYOUT PLAN


30'0" WIDE ROADROAD
70'

P.NO.48

P.NO.64

P.NO.51

P.NO.61

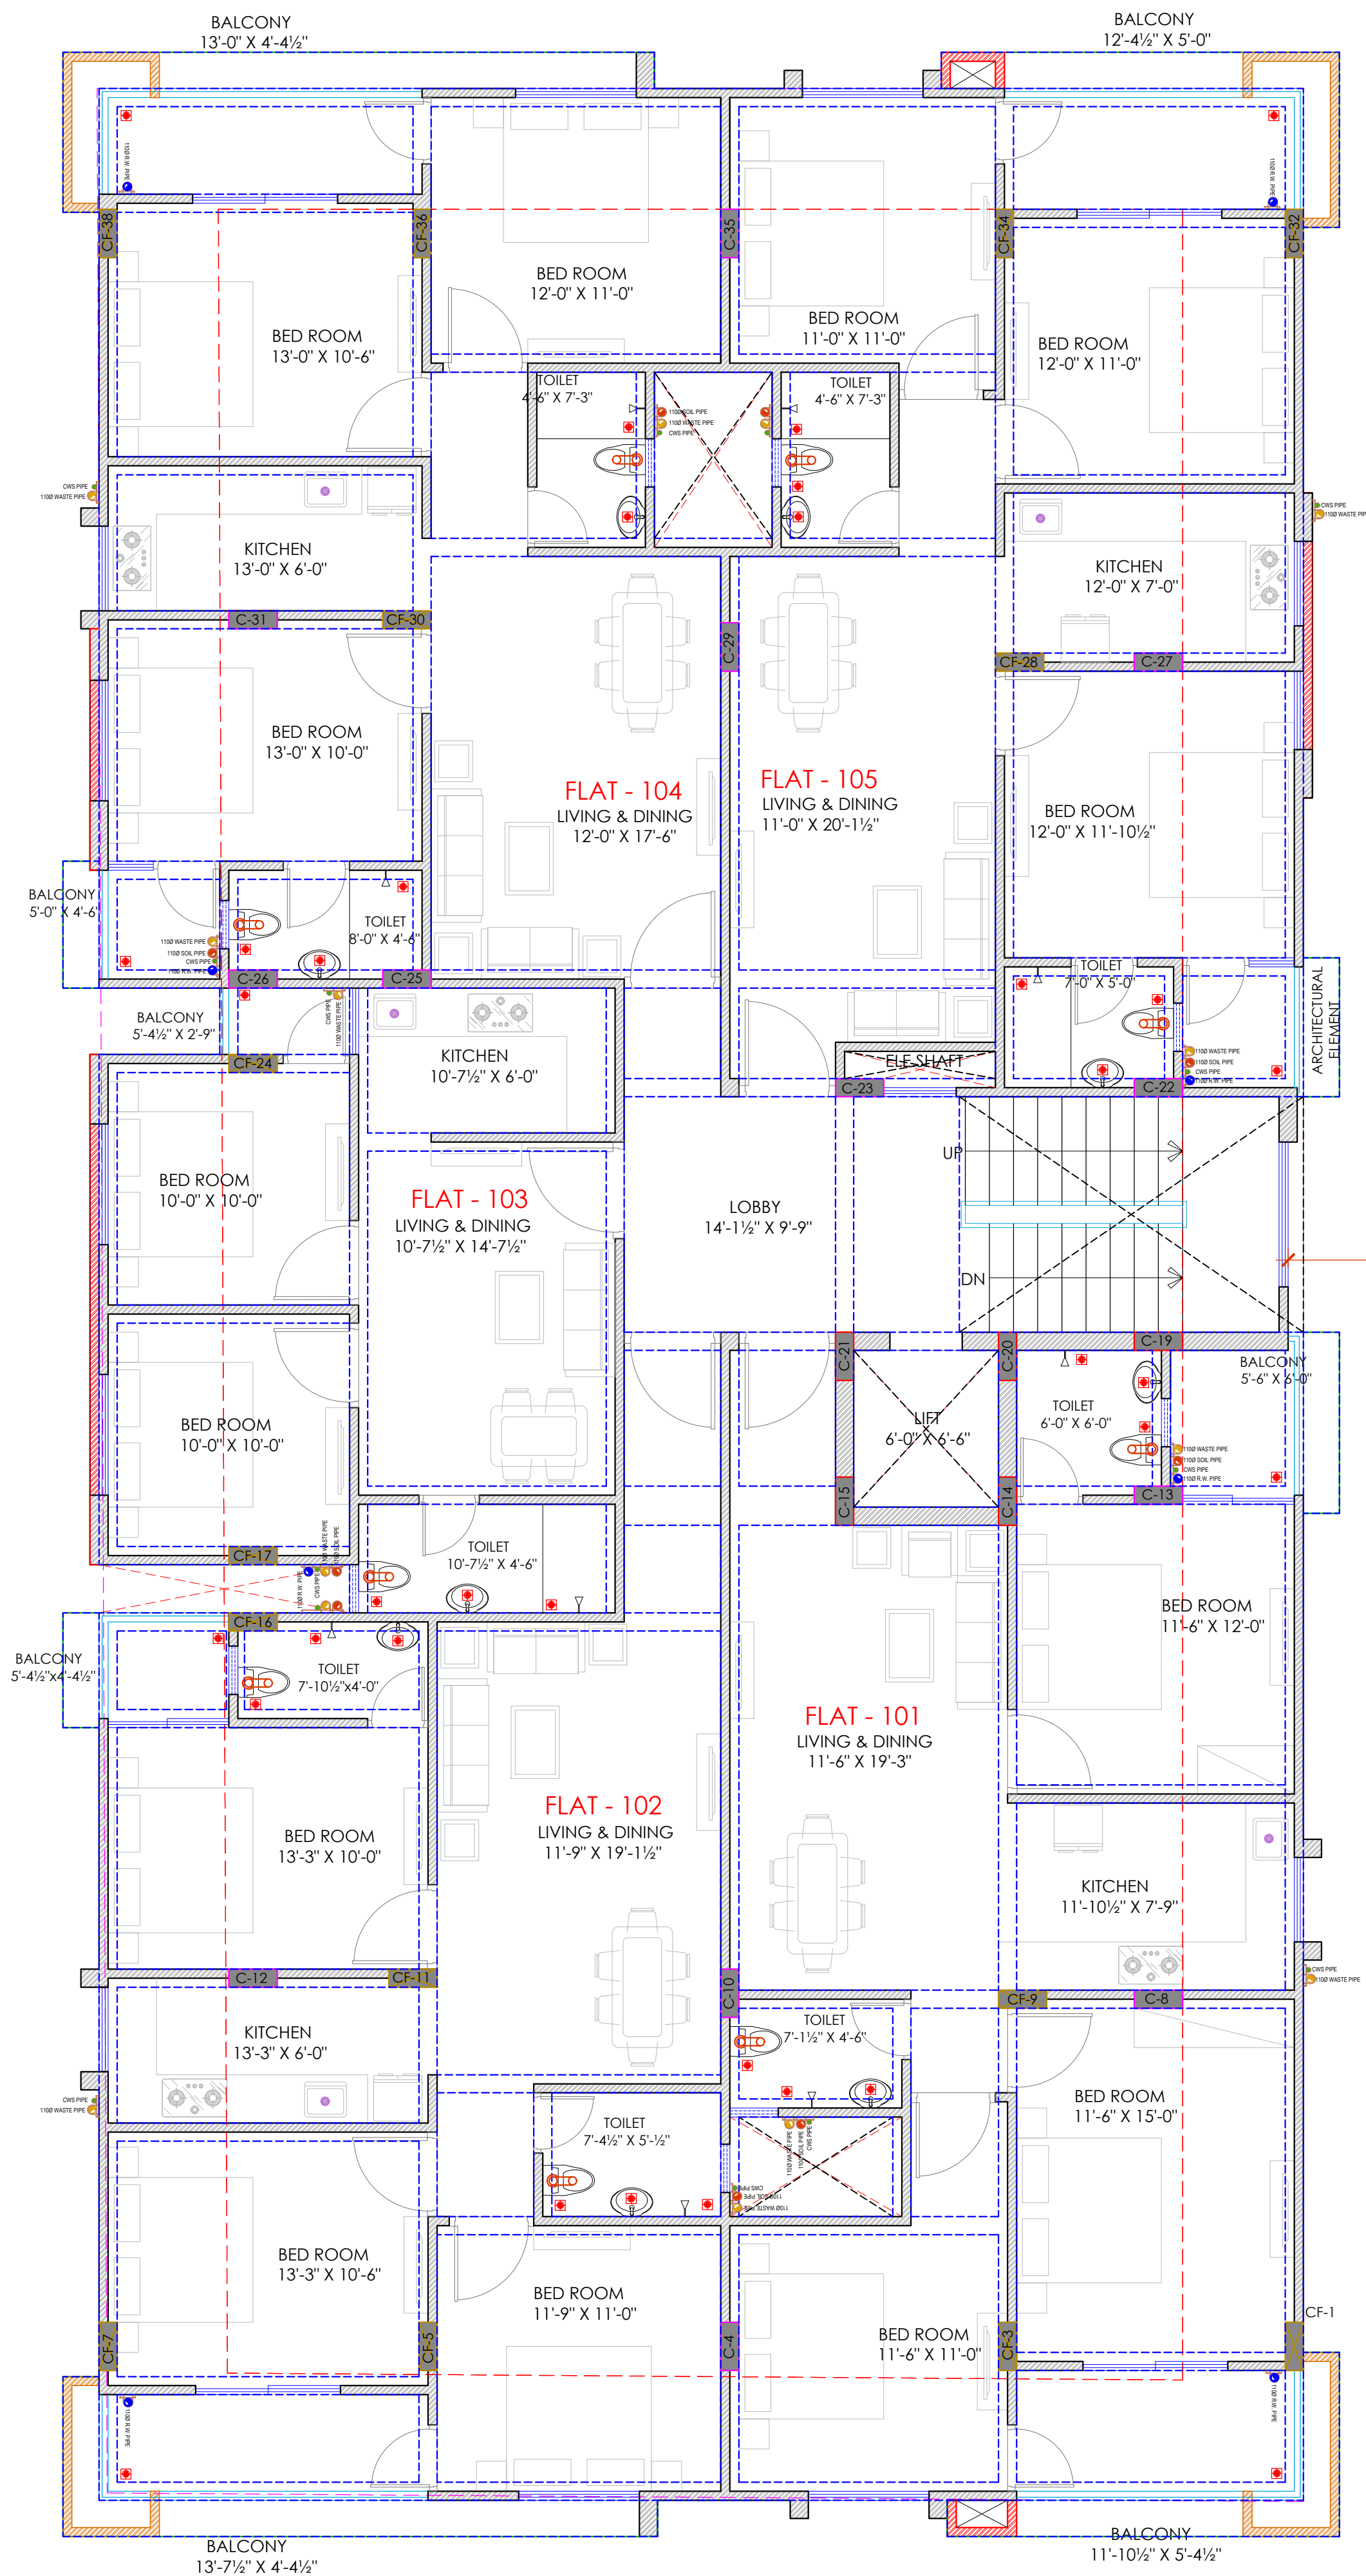

60'0" WIDE ROADROAD

Er. SANJEEV SHARMA
B.E (Electrical)

For BALAJI BUILDERS
Proprietor

TYPICAL FLOOR(GROUND TO FIFTH) INTERNAL DRAINAGE
PLAN, TYPICAL FLOOR INTERNAL PLUMBING
PLAN, UG WATER TANK TO O.H.T. FILLING ROUTE PLAN

PROJECT NAME :
BALAJI AASHIYANA II

DEVELOPER NAME :
BALAJI BUILDER

ARCHITECTS :
4 INSIDE
ARCHITECTURE N INTERIORS
Plot no. 72, S.P. Marg , C-Scheme
jaipur, rajasthan, India
cont: +91 9950595991 , 91
9982812777
e.mail: 4insideofficial@gmail.com

LEGEND:-		
①	SOIL PIPE	
②	WASTE PIPE	
③	VENT PIPE	
④	COLD WATER SUPPLY (CWS)	
⑤	HOT WATER SUPPLY (HWS)	
	RAIN WATER PIPE	
SW	SEWER LINE- EXTERNAL	
RW	STORM WATER DRAINAGE PIPE	
	SEWERAGE MANHOLE (2' x 2')	M.H.
	STORM WATER MANHOLE (2' x 2')	M.H.
GT	GULLY TRAP	
BV	BALL VALVE	
FT	FLOOR TRAP	
FD	FLOOR FLOOR DRAIN	
	RAIN WATER COLLECTION CHAMBER 450X450MM	
	KHURRA	

S.NO	DATE	REVISION DESCRIPTION
GENERAL NOTES :		
1.	All dimension on this drawing are in MKS System Only written dimensions are to be followed drawing should not be scaled.	
2.	All measurements must be checked and verified by the contractors prior to execution of work at the site.	
3.	This drawing is to be read in conjunction with all relevant structural, services & facility planning drawings.	
4.	Architectural drawings are to be followed for the location of all structural members & masonry walls, for sizes & reinforcement details of structural members, relevant structural drawings are to be referred.	
5.	Any discrepancies between architectural, structural and services drawings must be brought to the notice of the architects immediately & prior to execution at site.	
6.	Co-ordinate with services such as hvac, plumbing & electrical, etc. is the responsibility of the contractors.	
7.	All masonry walls should be aligned with the columns as indicated on the plan, irrespective of the position as calculated with the dimensions.	
8.	For details, refer relevant large scale detail drgs. as indicated.	


PROJECT:
**PLOT NO. 49,50,62 & 63
SCHEME NO.17 LAXMAN REKHA
JAIPUR.**

NAME OF DRAWING:

TYPICAL FLOOR(GROUND TO FIFTH) INTERNAL
DRAINAGE PLAN, TYPICAL FLOOR INTERNAL
PLUMBING PLAN, UG WATER TANK TO O.H.T.
FILLING ROUTE PLAN

DRAWING WORKING DRAWING	NORTH:
PROJECT NO. :	DATE : 21, Nov. - 2024
SCALE : NTS	REV NO. : R-0

DRAWING NO. :						DRAWING PATH :
PROJECT	CATEGORY	BLOCK	FLOOR	TYPE	NUMBER	
A-201						

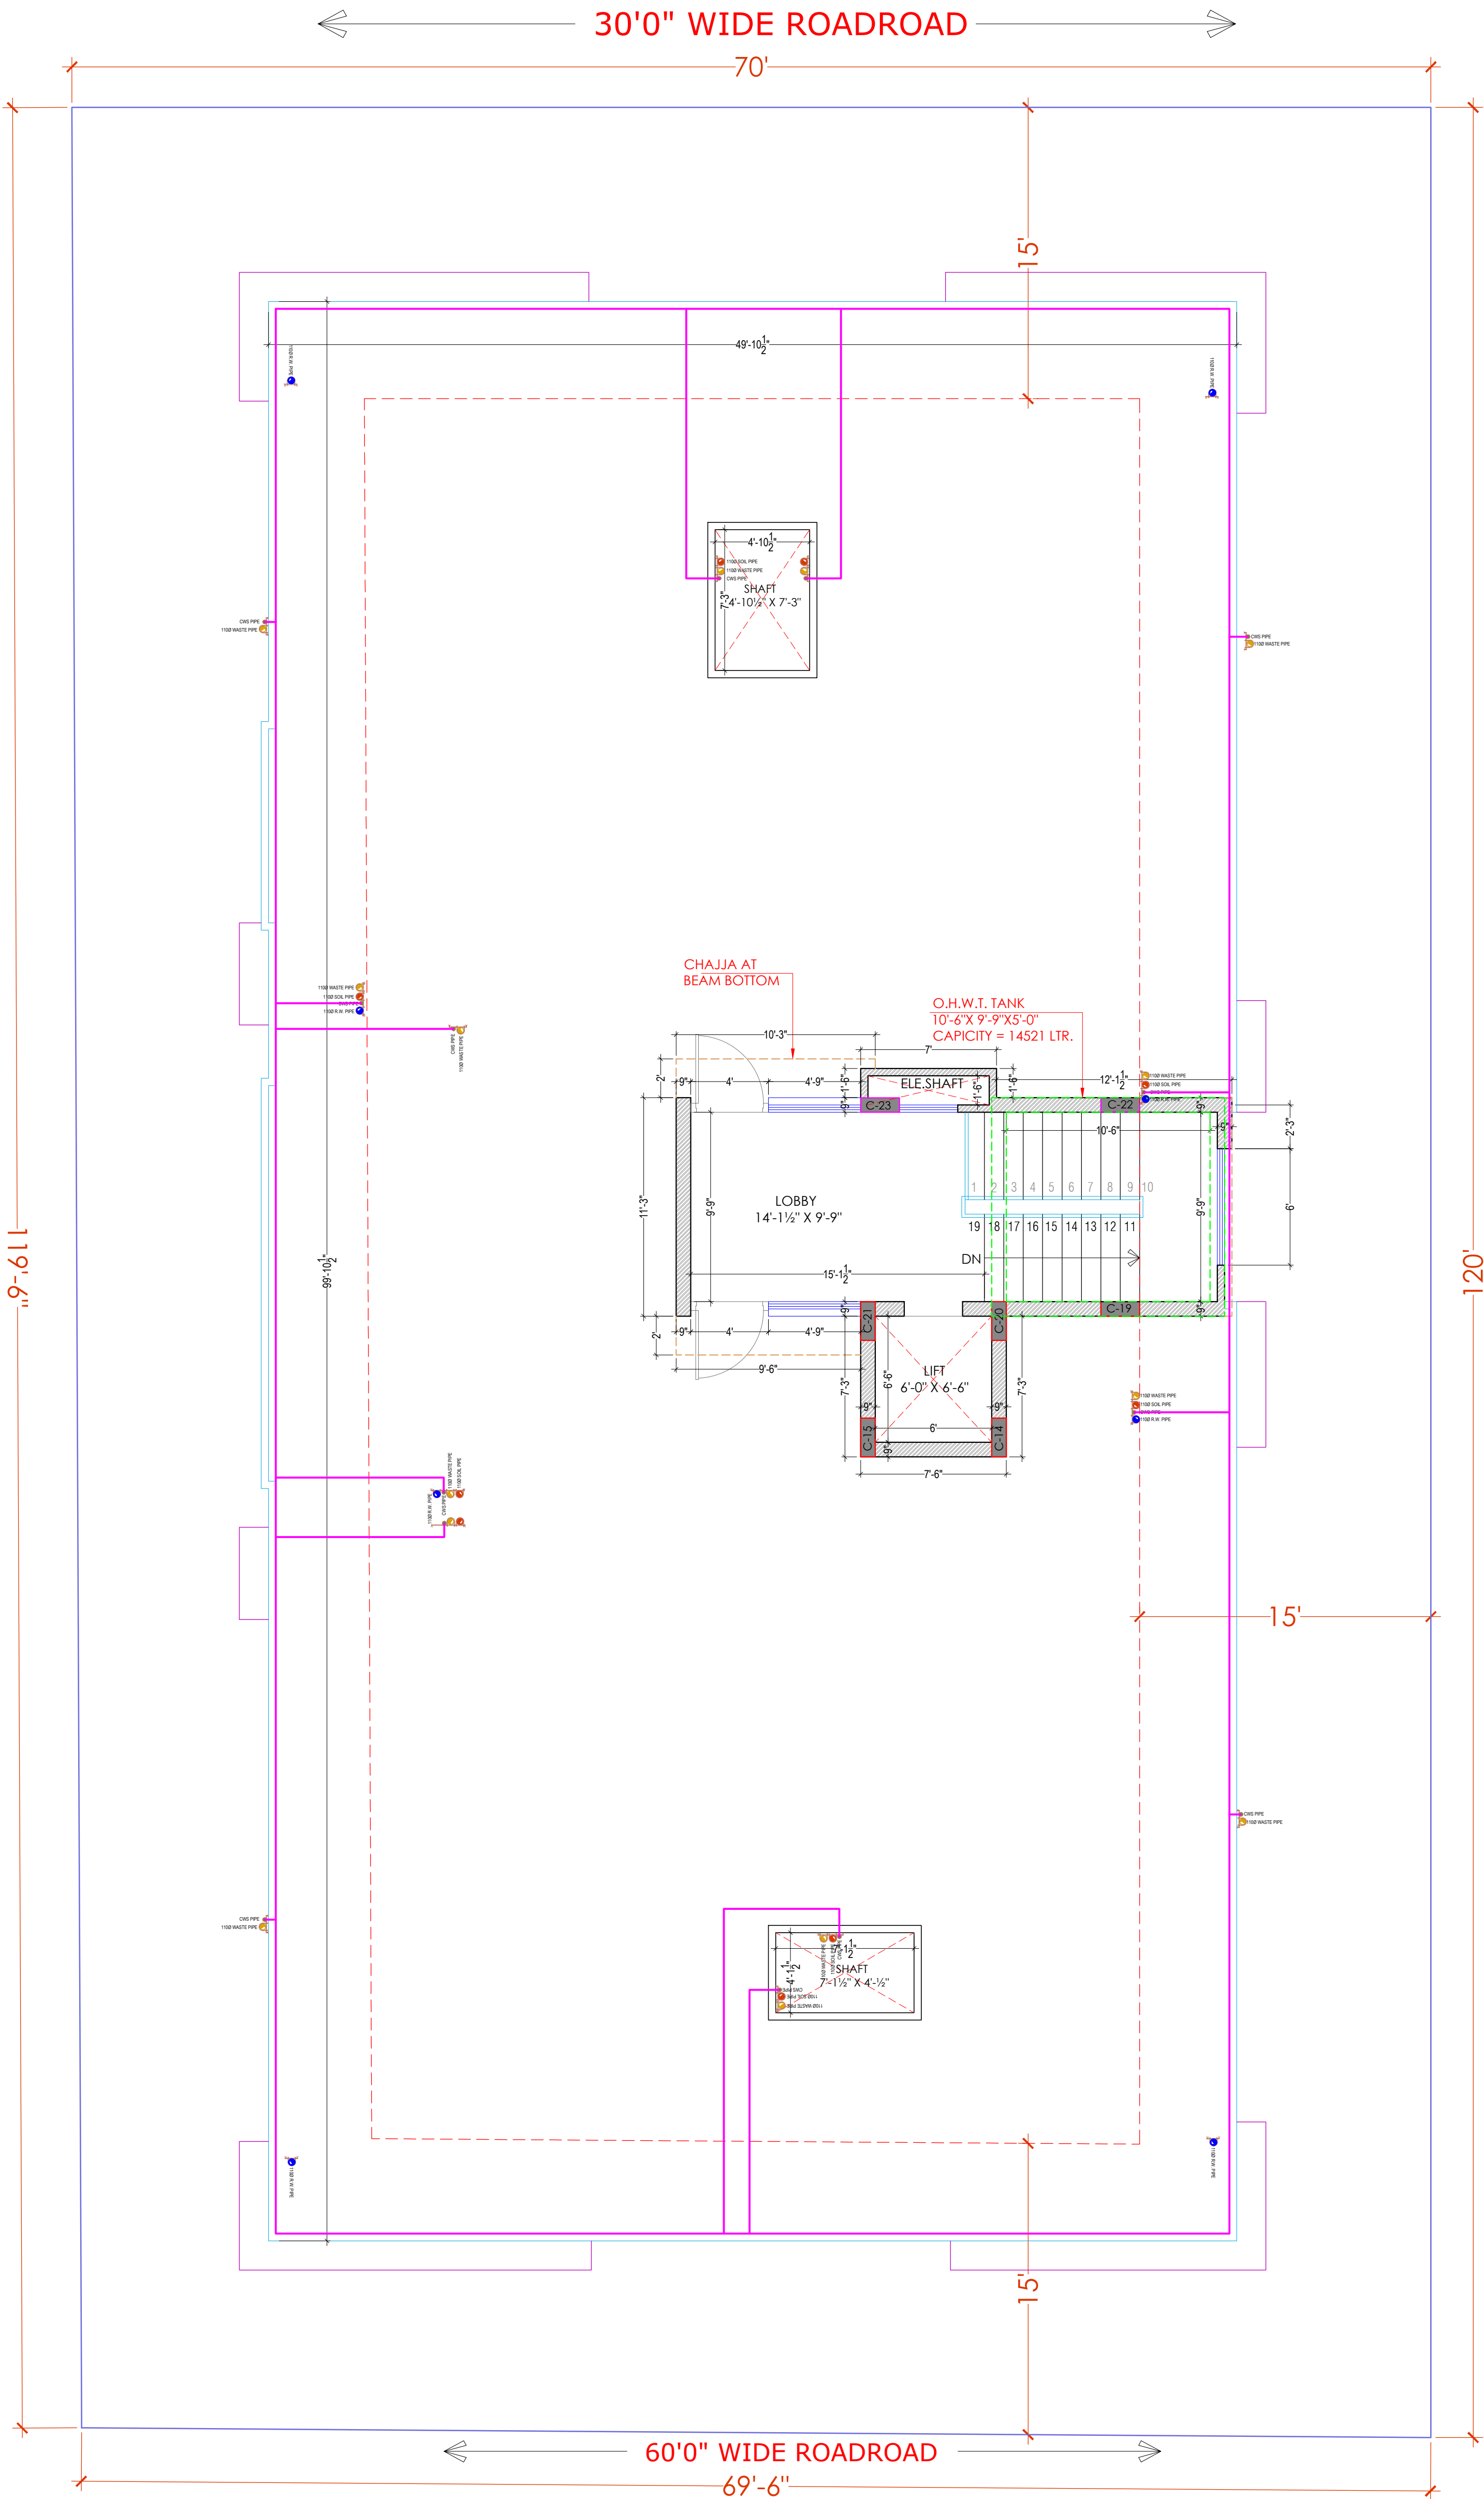

PROJECT NAME :
BALAJI AASHIYANA II

DEVELOPER NAME :
BALAJI BUILDER

ARCHITECTS :
4 INSIDE
ARCHITECTURE N INTERIORS
Plot no. 72, S.P. Marg , C- Scheme
jaipur, rajasthan, India
cont: +91 9950595991 , 91
9982812777
e.mail: 4insideofficial@gmail.com

LEGEND:-		
①	SOIL PIPE	
②	WASTE PIPE	
③	VENT PIPE	
④	COLD WATER SUPPLY (CWS)	
⑤	HOT WATER SUPPLY (HWS)	
	RAIN WATER PIPE	
SW	SEWER LINE- EXTERNAL	
RW	STORM WATER DRAINAGE PIPE	
	SEWERAGE MANHOLE (2' x 2')	
	STORM WATER MANHOLE (2' x 2')	
GT	GULLY TRAP	
BV	BALL VALVE	
FT	FLOOR TRAP	
FD	FLOOR FLOOR DRAIN	
	RAIN WATER COLLECTION CHAMBER 450X450MM	
	KHURRA	

- GENERAL NOTES :
- All dimension on this drawing are in MKS System Only written dimensions are to be followed drawing should not be scaled.
 - All measurements must be checked and verified by the contractors prior to execution of work at the site.
 - This drawing is to be read in conjunction with all relevant structural, services & facility planning drawings.
 - Architectural drawings are to be followed for the location of all structural members & masonry walls, for sizes & reinforcement details of structural members, relevant structural drawings are to be referred.
 - Any discrepancies between architectural, structural and services drawings must be brought to the notice of the architects immediately & prior to execution at site.
 - Co-ordinate with services such as hvac, plumbing & electrical, etc. is the responsibility of the contractors.
 - All masonry walls should be aligned with the columns as indicated on the plan, irrespective of the position as calculated with the dimensions.
 - For details, refer relevant large scale detail drgs. as indicated.

PROJECT:
PLOT NO. 49,50,62 & 63
SCHEME NO.17 LAXMAN REKHA
JAIPUR.

NAME OF DRAWING:
TERRACE FLOOR FLOOR RING MAIN LAYOUT,
WATER SUPPLY SYSTEMATIC DIAGRAM ,UG WATER
TANK TO OHT FILLING ROUTE PLAN

DRAWING WORKING DRAWING	NORTH:
PROJECT NO. :	DATE : 21, Nov. - 2024
SCALE : NTS	REV NO. : R-0

DRAWING NO. :	DRAWING PATH :
PROJECT	CATEGORY
BLOCK	FLOOR
TYPE	NUMBER
A-201	

TERRACE FLOOR FLOOR RING MAIN LAYOUT, WATER SUPPLY SYSTEMATIC DIAGRAM ,
UG WATER TANK TO OHT FILLING ROUTE PLAN