

30'0" WIDE ROADROAD

70'

PROJECT NAME :

BALAJI AASHIYANA II

DEVELOPER NAME :

BALAJI BUILDER

ARCHITECTS :

4 INSIDE

ARCHITECTURE N INTERIORS

Plot no. 72, S.P. Marg , C- Scheme

jaipur, rajasthan, India

cont: +91 9950595991 , 91

9982812777

e.mail: 4insideofficial@gmail.com

LEGENDS:

Mounting Height	I D	Symbol	Description
CEILING	FAN/48"		CEILING FAN 48"
CEILING	FAN/30"		CEILING FAN 30"
CEILING	CH1		CHANDELIER
+93"	TL/W		Led Wall Tube Light
+93"	BULB		Led Bulb 20W
+93"	GL		WALL BRACKETS AS DESIGN FOR GANESH LIGHT
+78"	ML		12x2 Led Mirror Light
CEILING	DL		Led 6" Down Lighter 20W (Surface Mounted)
VENTILATOR HT.	CR		CEILING ROSE
VENTILATOR HT.	EXP		9" DIA FRESH AIR FAN
+24"	2wSB		2wSWITCH BOARD
+42"	SB		SWITCH BOARD(6A SOCKET & SWITCH)
+24"	TEL		TELEPHONE POINT
+24"	LP TEL		6 A PLUG POINT FOR TELEPHONE
+48"	TV		TV COAXIAL POINT
+48"	LP TV		6 A PLUG POINT FOR TV
+24"	LP		6 A PLUG POINT FOR SIDE TABLE
+72"	LP-CH		6 A PLUG POINT FOR CHIMNEY
+12"	LP PC		6 A PLUG FOR COMPUTER POINT
+93"	SAC		SPLIT AC INDOOR UNIT
+42"	PP-MIX		16 A POWER POINT FOR MIXER
+42"	PP-MIC		16 A POWER POINT FOR MICROWAVE
+78"	PP-G		16 A POWER POINT FOR GEYSER
+54"	PP-F		16 A POWER POINT FOR FRIDGE
+78"	PP-WP		16 A POWER POINT FOR WATER PURIFIER
+48"	PP-WM		16 A POWER POINT FOR WASHING MACHINE
+12"	PP-INV.		16 A POWER POINT FOR INVERTOR
+93"	PP-AC		25A SWITCH/MCB FOR AC
			CHAMBER(2' X 2')
+18"			6A 2 NOS. SOCKET +1 NOS. 16A SWITCH, TELEPHONE LAN
+60"	MCB DB		MCB DISTRIBUTION BOARD
			CAMERA
			WALL FAN

BSB	6A S/S ,FAN REGULATOR,TL SWITCH
BAC	6A S/S ,25 A AC
	EL (EXTERNAL LIGHT)

PROJECT:

PLOT NO. 49,50,62 & 63
SCHEME NO.17 LAXMAN REKHA
JAIPUR.

NAME OF DRAWING:

STILT FLOOR ELECTRIC SUB-STATION,
CABLE CHAMBER, PIPE ROUTE &
LIGHTENING ARRESTER PLAN

DRAWING WORKING DRAWING	NORTH:
PROJECT NO. :	DATE : 18, Nov. - 2024
SCALE : NTS	REV NO. : R-0

DRAWING NO. :																	
			/	-		/	-		/			/			/		
PROJECT				CATEGORY			BLOCK			FLOOR			TYPE			NUMBER	
A-501																	

P.NO.48

P.NO.64

P.NO.51

120'

P.NO.61

DRIVEWAY

DRIVEWAY

ENTRY /EXIT

69'-6"

ENTRY /EXIT

60'0" WIDE ROADROAD

Er. SANJEEV SHARMA
B.E (Electrical)

For BALAJI BUILDERS
Proprietor

STILT FLOOR ELECTRIC SUB-STATION,
CABLE CHAMBER, PIPE ROUTE &
LIGHTENING ARRESTER PLAN

30'0" WIDE ROADROAD

70'

PROJECT NAME :

BALAJI AASHIYANA II

DEVELOPER NAME :

BALAJI BUILDER

ARCHITECTS :

4 INSIDE

ARCHITECTURE N INTERIORS

Plot no. 72, S.P. Marg, C- Scheme

jaipur, rajasthan, India

cont: +91 9950595991, 91

9982812777

e.mail: 4insideofficial@gmail.com

LEGENDS:

Mounting Height	I D	Symbol	Description
CEILING	FAN/48"		CEILING FAN 48"
CEILING	FAN/30"		CEILING FAN 30"
CEILING	CH1		CHANDELIER
+93"	TL/W		Led Wall Tube Light
+93"	BULB		Led Bulb 20W
+93"	GL		WALL BRACKETS AS DESIGN FOR GANESH LIGHT
+78"	ML		12x2 Led Mirror Light
CEILING	DL		Led 6" Down Lighter 20W (Surface Mounted)
VENTILATOR HT.	CR		CEILING ROSE
VENTILATOR HT.	EXP		9" DIA FRESH AIR FAN
+24"	2wSB		2w SWITCH BOARD
+42"	SB		SWITCH BOARD(6A SOCKET & SWITCH)
+24"	TEL		TELEPHONE POINT
+24"	LP TEL		6 A PLUG POINT FOR TELEPHONE
+48"	TV		TV COAXIAL POINT
+48"	LP TV		6 A PLUG POINT FOR TV
+24"	LP		6 A PLUG POINT FOR SIDE TABLE
+72"	LP-CH		6 A PLUG POINT FOR CHIMNEY
+12"	LP PC		6 A PLUG FOR COMPUTER POINT
+93"	SAC		SPLIT AC INDOOR UNIT
+42"	PP-MIX		16 A POWER POINT FOR MIXER
+42"	PP-MIC		16 A POWER POINT FOR MICROWAVE
+78"	PP-G		16 A POWER POINT FOR GEYSER
+54"	PP-F		16 A POWER POINT FOR FRIDGE
+78"	PP-WP		16 A POWER POINT FOR WATER PURIFIER
+48"	PP-WM		16 A POWER POINT FOR WASHING MACHINE
+12"	PP-INV.		16 A POWER POINT FOR INVERTOR
+93"	PP-AC		25A SWITCH/AC FOR AC
			CHAMBER(2' X 2')
+18"			6A 2 NOS. SOCKET +1 NOS. 16A SWITCH, TELEPHONE LAN
+60"	MCB DB		MCB DISTRIBUTION BOARD
			CAMERA
			WALL FAN

BSB	6A S/S, FAN REGULATOR, TL SWITCH
BAC	6A S/S, 25 A AC
EL	EL (EXTERNAL LIGHT)

PROJECT:

PLOT NO. 49,50,62 & 63
SCHEME NO.17 LAXMAN REKHA
JAIPUR.

NAME OF DRAWING:

STILT FLOOR EXTERNAL LIGHTING,
CEILING ELECTRICAL LAYOUT,
ELECTRICAL POINT DRAWING,
CAMERA POINT DRAWING

DRAWING	NORTH:
WORKING DRAWING	
PROJECT NO. :	DATE : 18, Nov. - 2024
SCALE : NTS	REV NO. : R-0

DRAWING NO. :																							
			/	-		/	-		/				/			/			/				
PROJECT				CATEGORY			BLOCK			FLOOR				TYPE			NUMBER						
A-501																							

P.NO.48

P.NO.64

P.NO.51

P.NO.61

DRIVEWAY

DRIVEWAY

ENTRY /EXIT

ENTRY /EXIT

60'0" WIDE ROADROAD

69'-6"


Er. SANJEEV SHARMA
B.E (Electrical)

For BALAJI BUILDERS
Proprietor

STILT FLOOR EXTERNAL LIGHTING, CEILING ELECTRICAL LAYOUT,
ELECTRICAL POINT DRAWING, CAMERA POINT DRAWING,

	25 MM PVC CONDUIT FOR JB TO WALL POINT
	32 MM PVC CONDUIT FOR DB TO JB (JUNCTION BOX)

30'0" WIDE ROADROAD

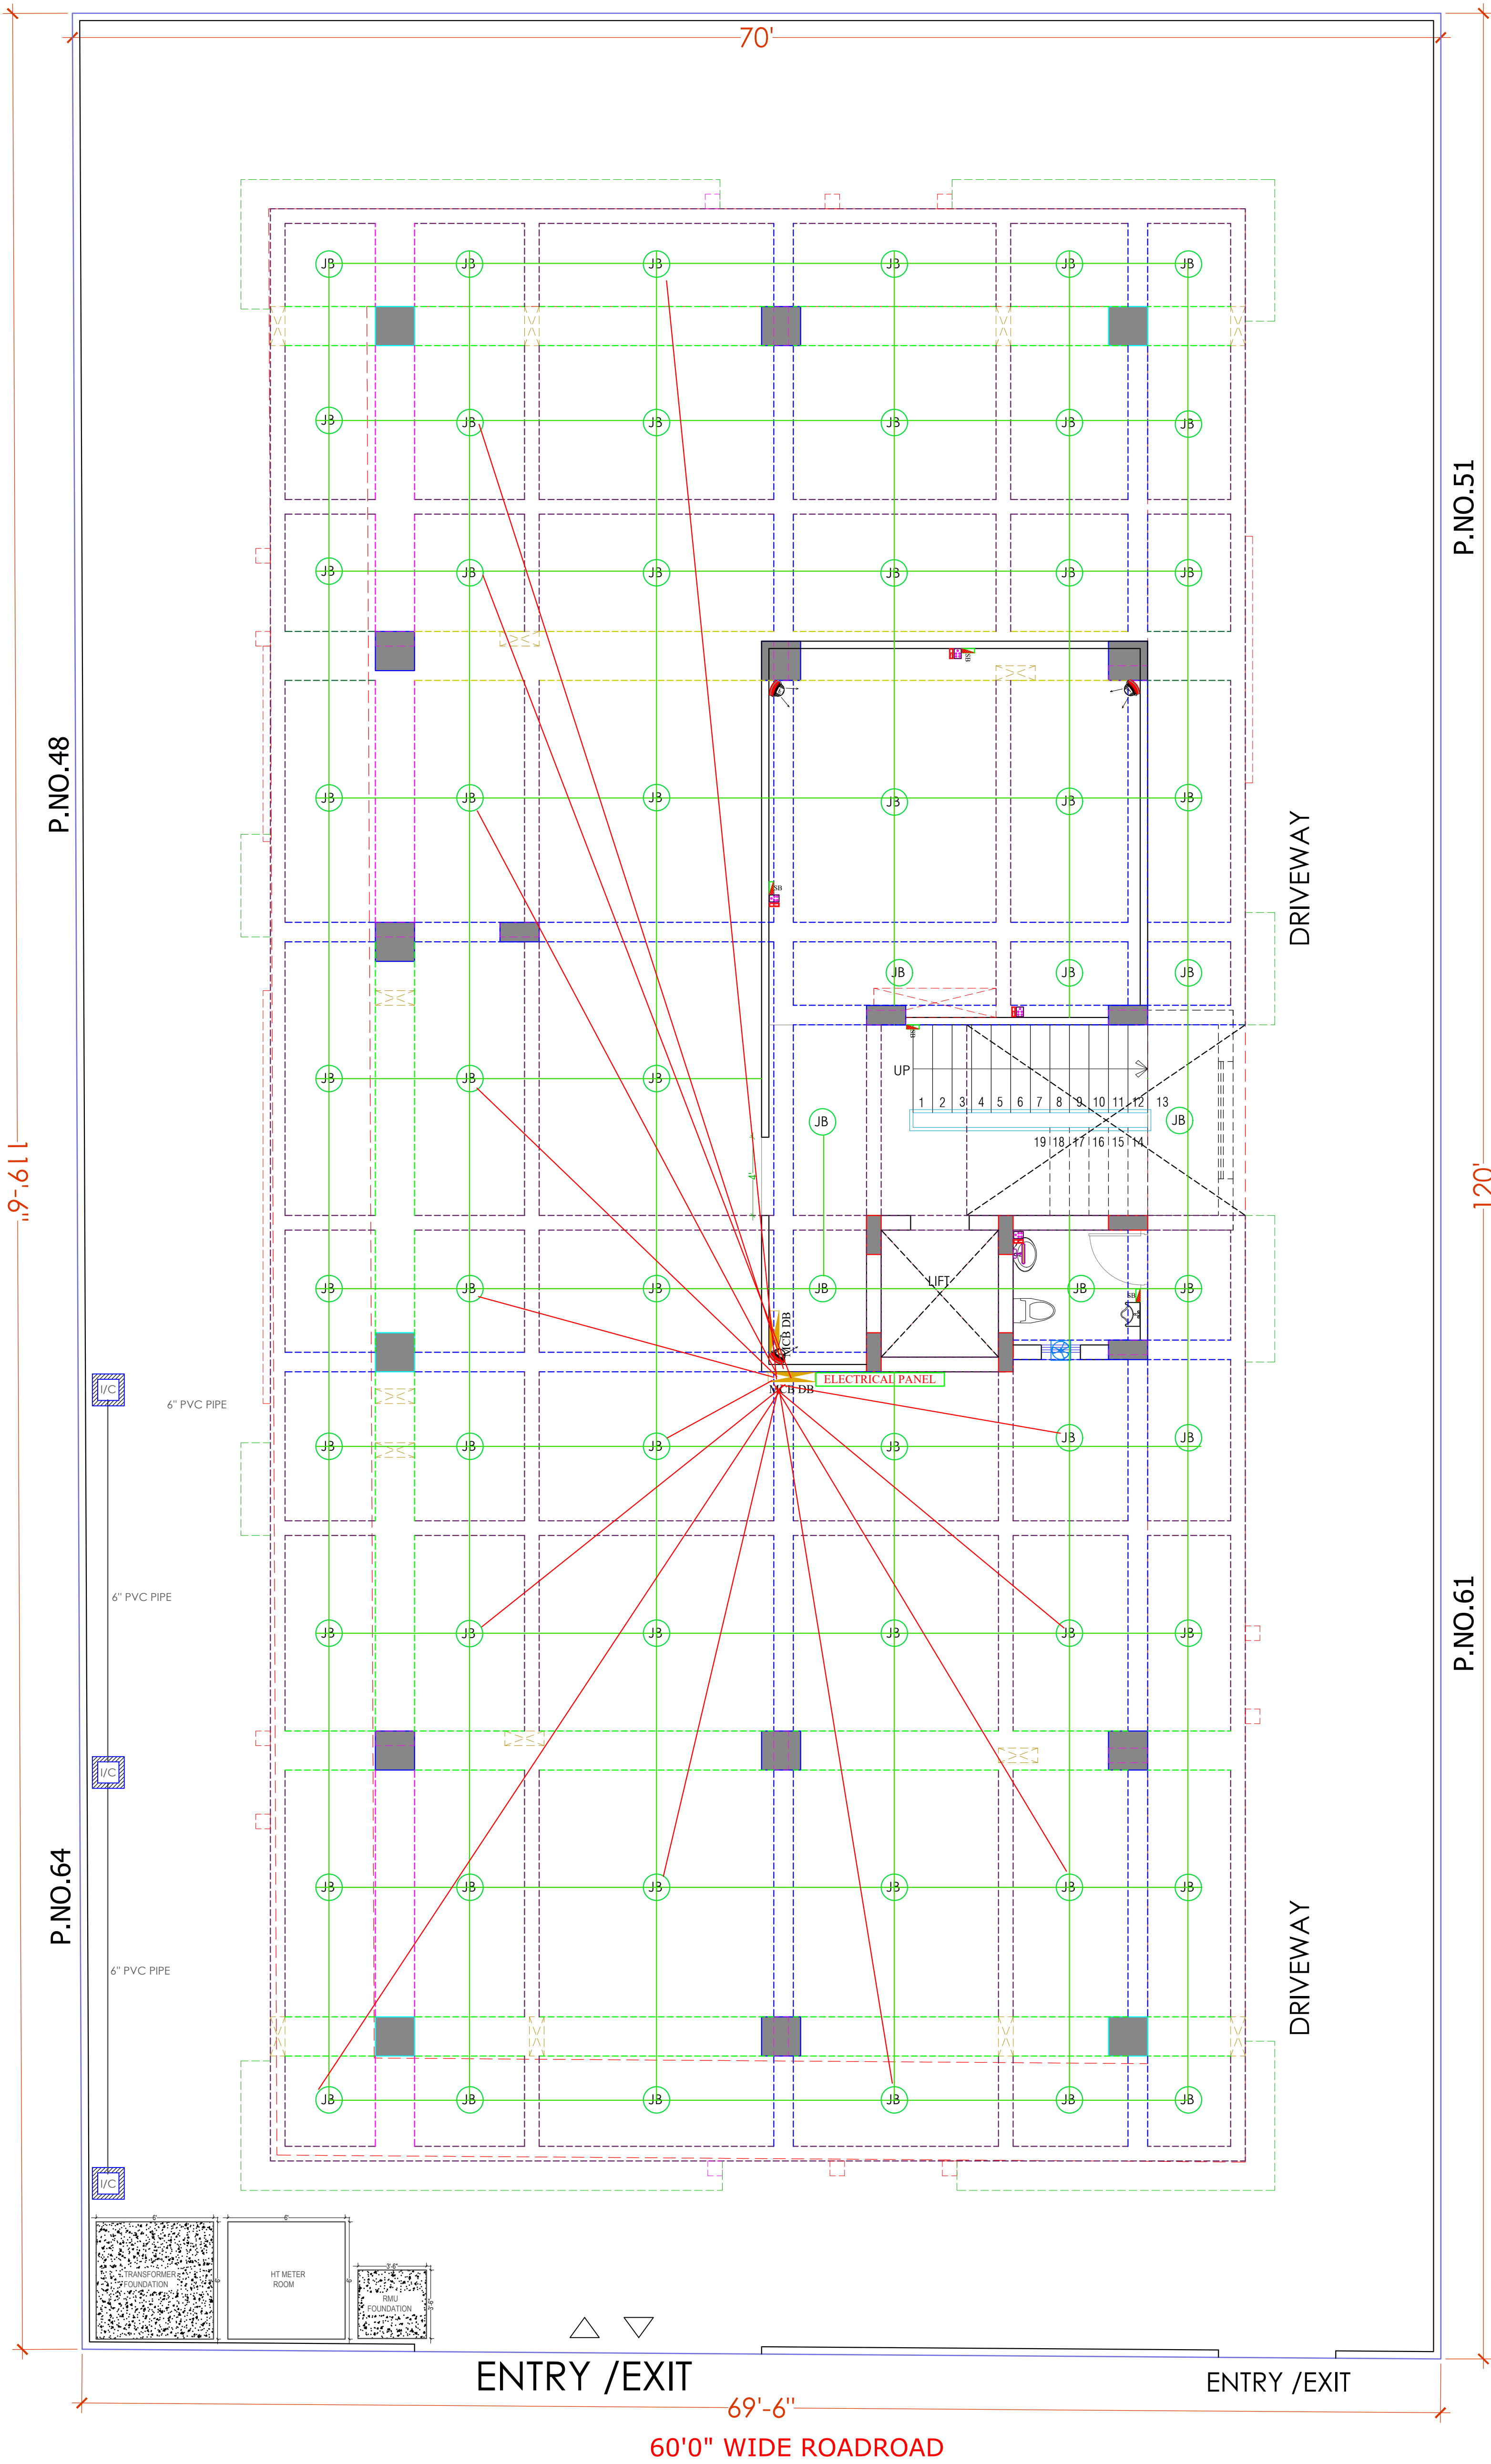

PROJECT NAME :
BALAJI AASHIYANA II

DEVELOPER NAME :
BALAJI BUILDER

ARCHITECTS :
4 INSIDE
ARCHITECTURE N INTERIORS
Plot no. 72, S.P. Marg , C- Scheme
jaipur, rajasthan, India
cont: +91 9950595991 , 91
9982812777
e.mail: 4insideofficial@gmail.com

LEGENDS:			
Mounting Height	I D	Symbol	Description
CEILING	FAN/48"		CEILING FAN 48"
CEILING	FAN/30"		CEILING FAN 30"
CEILING	CHI		CHANDELIER
+93"	TL/W		Led Wall Tube Light
+93"	BULB		Led Bulb 20W
+93"	GL		WALL BRACKETS AS DESIGN FOR GANESH LIGHT
+78"	ML		12x2 Led Mirror Light
CEILING	DL		Led 6" Down Lighter 20W (Surface Mounted)
VENTILATOR HT.	CR		CEILING ROSE
VENTILATOR HT.	EXF		9" DIA FRESH AIR FAN
+24"	2wSB		2wSWITCH BOARD
+42"	SB		SWITCH BOARD(6A SOCKET & SWITCH)
+24"	TEL		TELEPHONE POINT
+24"	LP TEL		6 A PLUG POINT FOR TELEPHONE
+48"	TV		TV COAXIAL POINT
+48"	LP TV		6 A PLUG POINT FOR TV
+24"	LP		6 A PLUG POINT FOR SIDE TABLE
+72"	LP-CH		6 A PLUG POINT FOR CHIMNEY
+12"	LP PC		6 A PLUG FOR COMPUTER POINT
+93"	SAC		SPLIT AC INDOOR UNIT
+42"	PP-MIX		16 A POWER POINT FOR MIXER
+42"	PP-MIC		16 A POWER POINT FOR MICROWAVE
+78"	PP-G		16 A POWER POINT FOR GEYSER
+54"	PP-F		16 A POWER POINT FOR FRIDGE
+78"	PP-WP		16 A POWER POINT FOR WATER PURIFIER
+48"	PP-WM		16 A POWER POINT FOR WASHING MACHINE
+12"	PP-INV.		16 A POWER POINT FOR INVERTOR
+93"	PP-AC		25A SWITCH/MCB FOR AC
			CHAMBER(2' X 2')
+18"			6A 2 NOS. SOCKET +1 NOS. 16A SWITCH, TELEPHONE LAN
+60"	MCB DB		MCB DISTRIBUTION BOARD
			CAMERA
			WALL FAN
BSB	6A S/S ,FAN REGULATOR,TL SWITCH		
BAC	6A S/S ,25 A AC		
	EL (EXTERNAL LIGHT)		

PROJECT:
PLOT NO. 49,50,62 & 63
SCHEME NO.17 LAXMAN REKHA JAIPUR.

NAME OF DRAWING:

STILT FLOOR LV CONDUIT PLAN
STILT FLOOR ELECTRIC CONDUIT PLAN
CABLE TRAY,ELECTRICAL PANAL,MCB DB

DRAWING WORKING DRAWING	NORTH:
PROJECT NO. :	DATE : 18, Nov. - 2024
SCALE : NTS	REV NO. : R-0
DRAWING NO. : PROJECT / CATEGORY / BLOCK / FLOOR / TYPE / NUMBER A-501	


Er. SANJEEV SHARMA
B.E (Electrical)
For BALAJI BUILDERS
Proprietor

STILT FLOOR LV CONDUIT PLAN,
STILT FLOOR ELECTRIC CONDUIT PLAN,
CABLE TRAY,ELECTRICAL PANAL,MCB DB

30'0" WIDE ROADROAD

70'

W

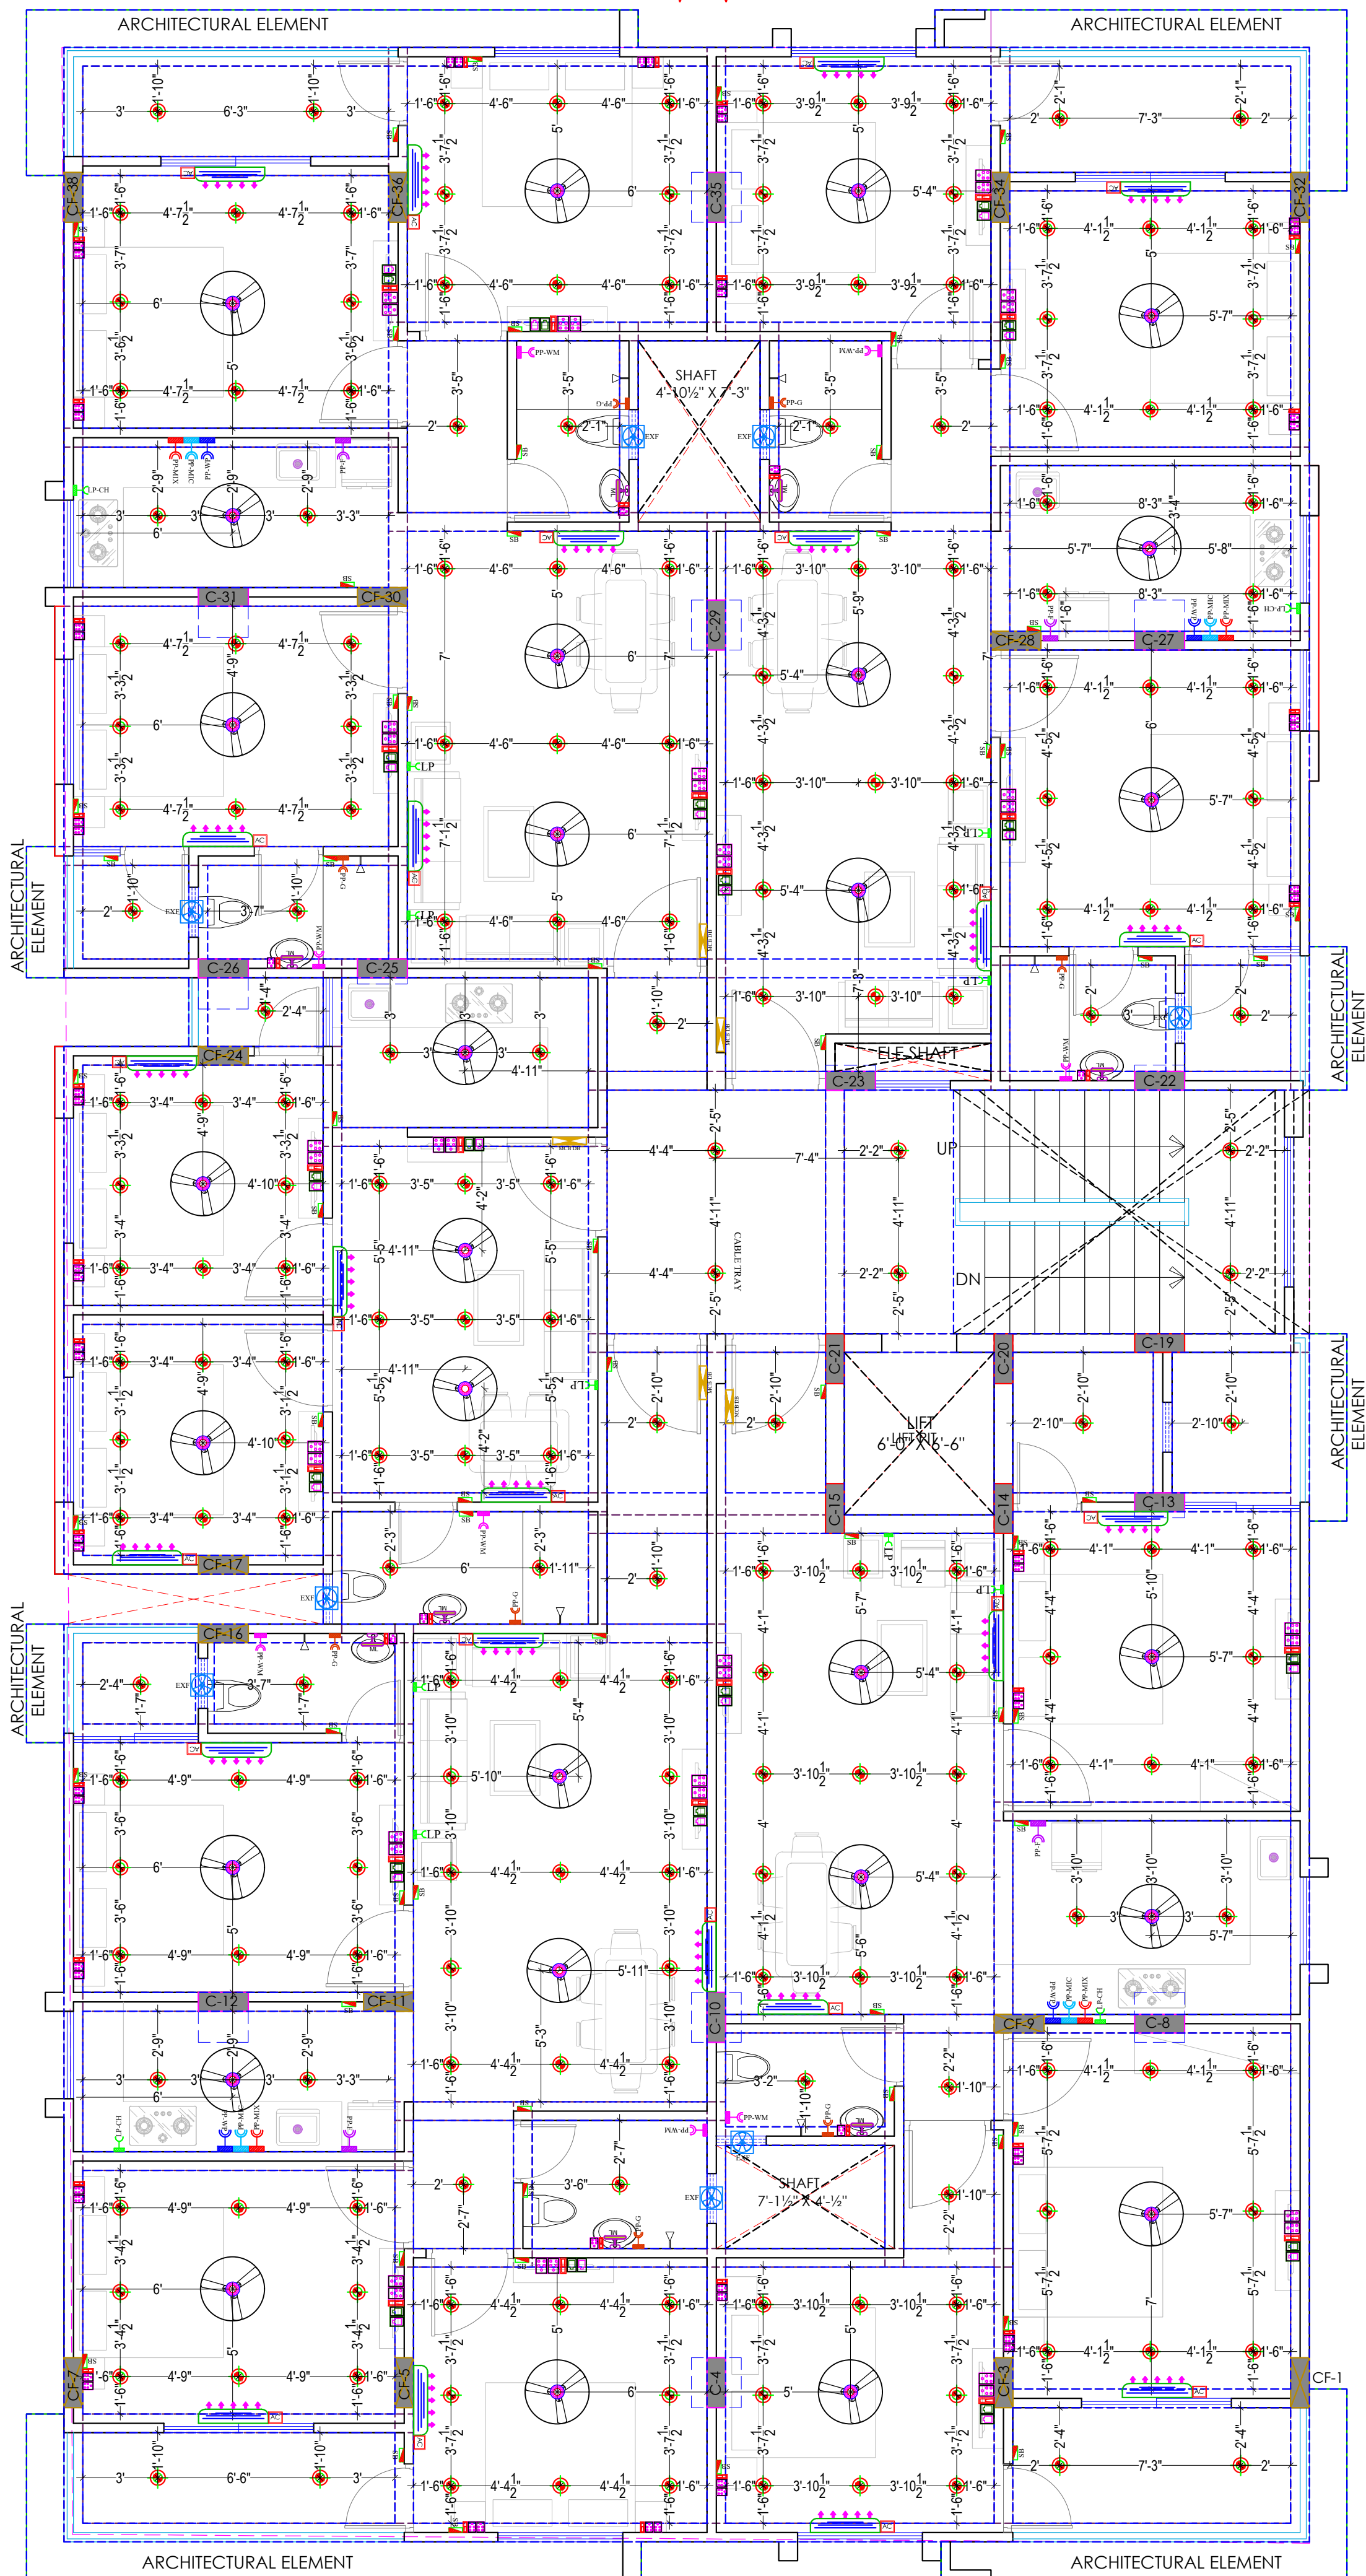

S

N

E

60'0" WIDE ROADROAD

69'-6"

P.NO.48

P.NO.64

P.NO.51

P.NO.61

PROJECT NAME :

BALAJI AASHIYANA II

DEVELOPER NAME :

BALAJI BUILDER

ARCHITECTS :

4 INSIDE

ARCHITECTURE N INTERIORS

Plot no. 72, S.P. Marg, C- Scheme

jaipur, rajasthan, India

cont: +91 9950595991, 91

9982812777

e.mail: 4insideofficial@gmail.com

LEGENDS:

Mounting Height	I D	Symbol	Description
CEILING	FAN/48"		CEILING FAN 48"
CEILING	FAN/30"		CEILING FAN 30"
CEILING	CHI		CHANDELIER
+93"	TL/W		Led Wall Tube Light
+93"	BULB		Led Bulb 20W
+93"	GL		WALL BRACKETS AS DESIGN FOR GANESH LIGHT
+78"	ML		12x2 Led Mirror Light
CEILING	DL		Led 6" Down Lighter 20W (Surface Mounted)
VENTILATOR HT.	CR		CEILING ROSE
VENTILATOR HT.	EXF		9" DIA FRESH AIR FAN
+24"	2wSB		2w SWITCH BOARD
+42"	SB		SWITCH BOARD(6A SOCKET & SWITCH)
+24"	TEL		TELEPHONE POINT
+24"	LP TEL		6 A PLUG POINT FOR TELEPHONE
+48"	TV		TV COAXIAL POINT
+48"	LP TV		6 A PLUG POINT FOR TV
+24"	LP		6 A PLUG POINT FOR SIDE TABLE
+72"	LP-CH		6 A PLUG POINT FOR CHIMNEY
+12"	LP PC		6 A PLUG FOR COMPUTER POINT
+93"	SAC		SPLIT AC INDOOR UNIT
+42"	PP-MIX		16 A POWER POINT FOR MIXER
+42"	PP-MIC		16 A POWER POINT FOR MICROWAVE
+78"	PP-G		16 A POWER POINT FOR GEYSER
+54"	PP-F		16 A POWER POINT FOR FRIDGE
+78"	PP-WP		16 A POWER POINT FOR WATER PURIFIER
+48"	PP-WM		16 A POWER POINT FOR WASHING MACHINE
+12"	PP-INV.		16 A POWER POINT FOR INVERTOR
+93"	PP-AC		25A SWITCH/MCB FOR AC
			CHAMBER(2' X 2')
+18"			6A 2 NOS. SOCKET +1 NOS. 16A SWITCH, TELEPHONE LAN
+60"	MCB DB		MCB DISTRIBUTION BOARD
			CAMERA
			WALL FAN

BSB 6A S/S, FAN REGULATOR, TL SWITCH

BAC 6A S/S, 25 A AC

EL (EXTERNAL LIGHT)

PROJECT:

PLOT NO. 49,50,62 & 63
SCHEME NO.17 LAXMAN REKHA
JAIPUR.

NAME OF DRAWING:

TYPICAL FLOOR (GROUND TO FIFTH)
(ELECTRICAL POINT, CEILING POINT,
TV & TELEPHONE RISER DIAGRAM)

DRAWING
WORKING DRAWING

NORTH:

PROJECT NO. :
DATE :
18, Nov. - 2024

SCALE :
NTS
REV NO. :
R-0

DRAWING NO. :
PROJECT CATEGORY BLOCK FLOOR TYPE NUMBER


A-501

Er. SANJEEV SHARMA
B.E (Electrical)


For BALAJI BUILDERS
Proprietor

TYPICAL FLOOR (GROUND TO FIFTH)
(ELECTRICAL POINT, CEILING POINT,
TV & TELEPHONE RISER DIAGRAM)


MAIN PANEL

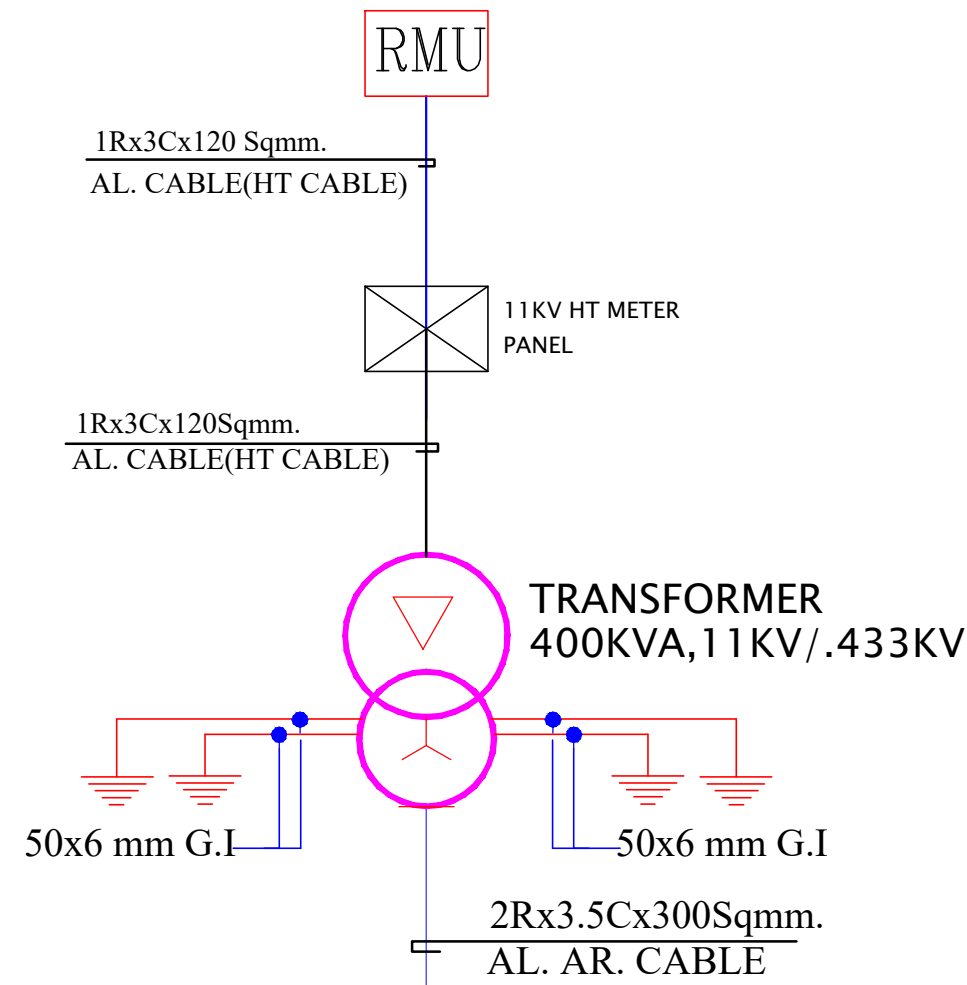

30 NOS. METER PANEL

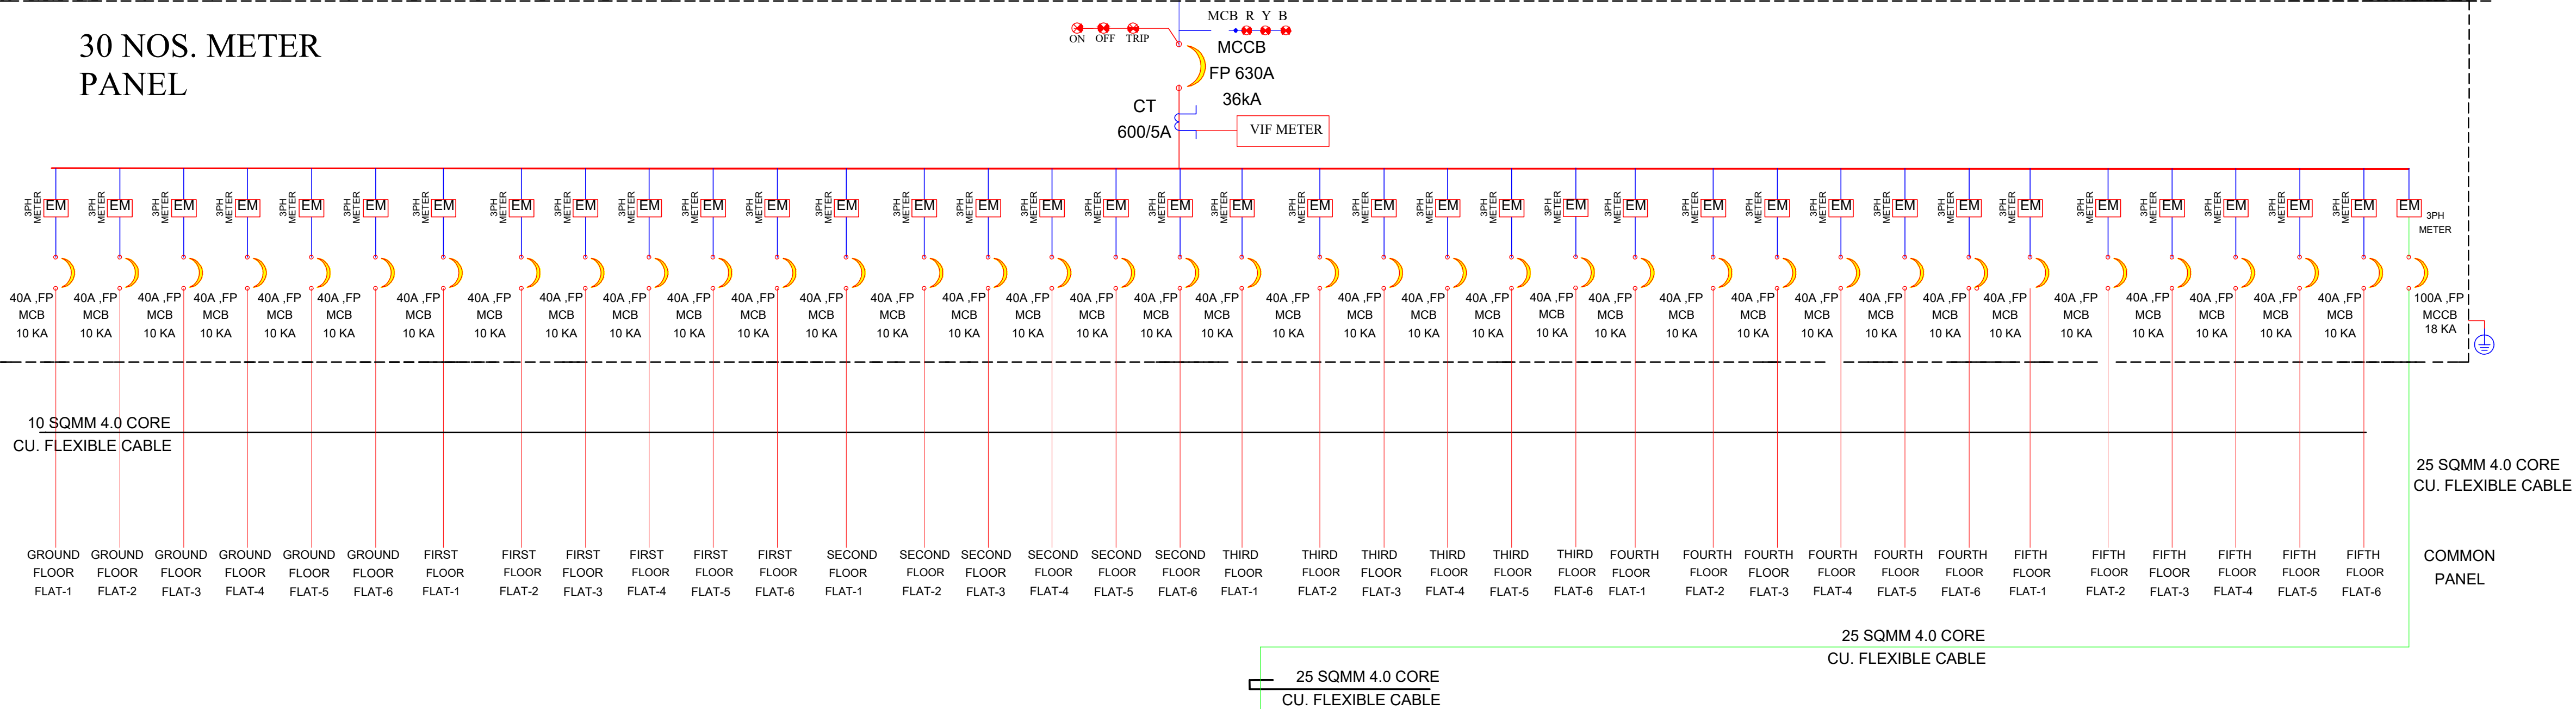

COMMON LIGHT PANEL

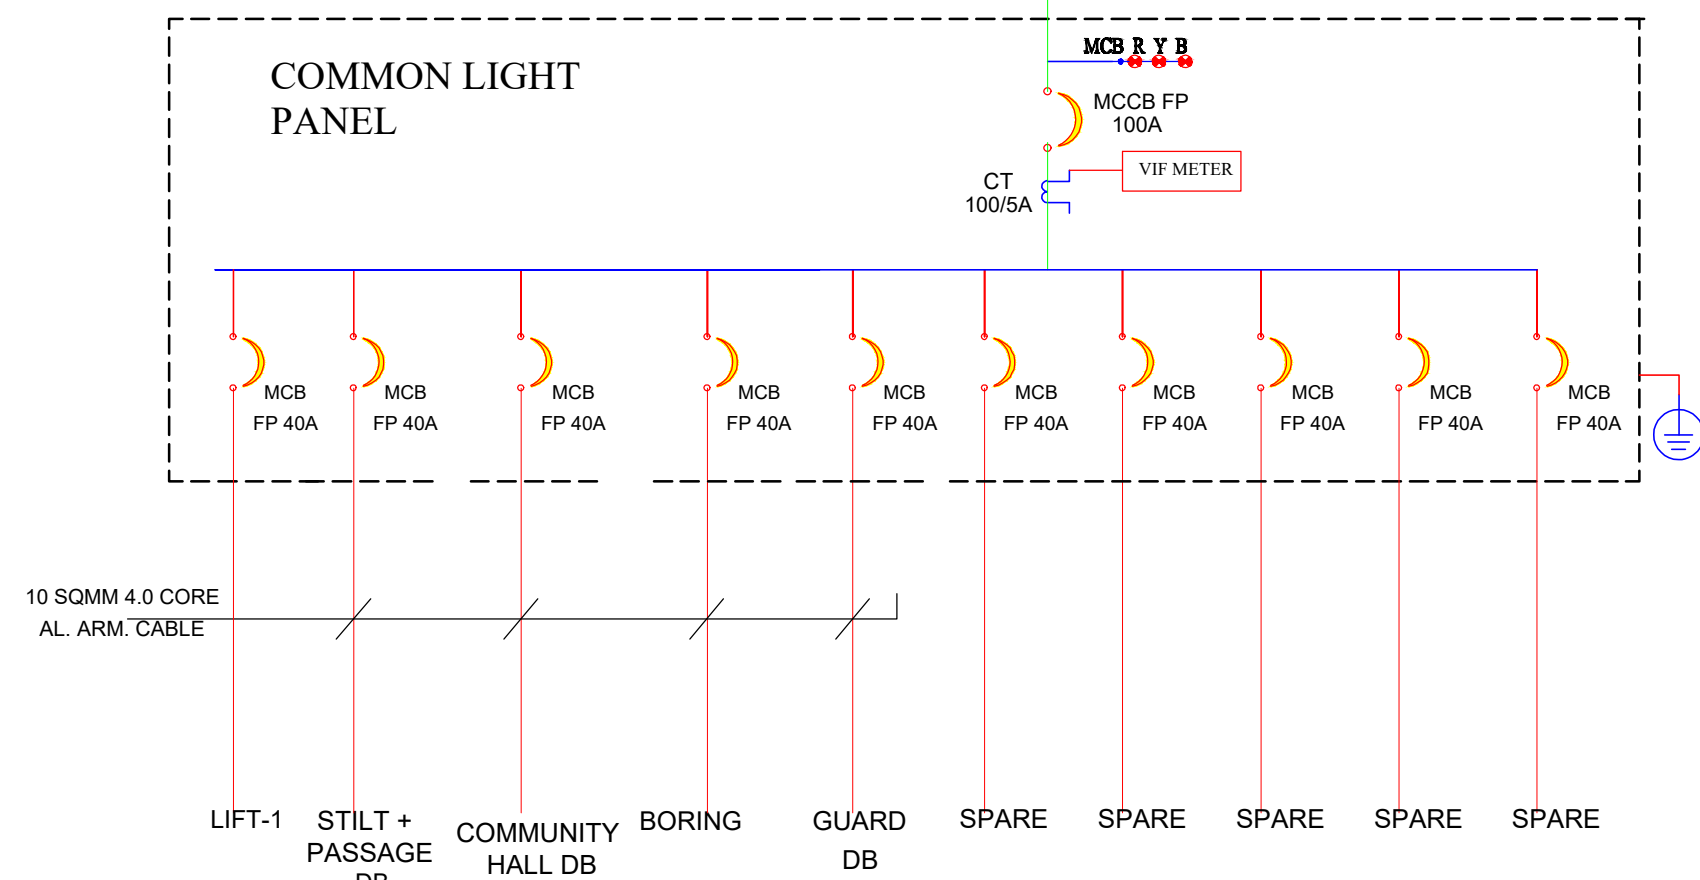

Er. SANJEEV SHARMA
B.E (Electrical)

For BALAJI BUILDERS
Proprietor

MAIN LT PANEL AND SLD DRAWING

PROJECT NAME :
BALAJI AASHIYANA II

DEVELOPER NAME :
BALAJI BUILDER

ARCHITECTS :
4 INSIDE
ARCHITECTURE N INTERIORS
Plot no. 72, S.P. Marg, C- Scheme
jaipur, rajasthan, India
cont: +91 9950595991, 91
9982812777
e.mail: 4insideofficial@gmail.com

LEGENDS:			
Mounting Height	ID	Symbol	Description
CEILING	FAN48"		CEILING FAN 48"
CEILING	FAN30"		CEILING FAN 30"
CEILING	CHI		CHANDELIER
+93"	TLW		Led Wall Light
+93"	BULB		Led Bulb 20W
+93"	GL		WALL BRACKETS AS DESIGN FOR GANESH LIGHT
+78"	ML		12x2 Led Mirror Light
CEILING	DL		Led 6" Down Lighter 20W (Surface Mounted)
VENTILATOR HT	CR		CEILING ROSE
VENTILATOR HT	EXF		9" DIA FRESH AIR FAN
+24"	2wSB		2w SWITCH BOARD
+42"	SB		SWITCH BOARD(6A SOCKET & SWITCH)
+24"	TEL		TELEPHONE POINT
+24"	LP TEL		6 A PLUG POINT FOR TELEPHONE
+48"	TV		TV COAXIAL POINT
+48"	LP TV		6 A PLUG POINT FOR TV
+24"	LP		6 A PLUG POINT FOR SIDE TABLE
+72"	LP-CH		6 A PLUG POINT FOR CHIMNEY
+12"	LP PC		6 A PLUG FOR COMPUTER POINT
+93"	SAC		SPLIT AC INDOOR UNIT
+42"	PP-MIX		16 A POWER POINT FOR MIXER
+42"	PP-MIC		16 A POWER POINT FOR MICROWAVE
+78"	PP-G		16 A POWER POINT FOR GEYSER
+54"	PP-F		16 A POWER POINT FOR FRIDGE
+78"	PP-WP		16 A POWER POINT FOR WATER PURIFIER
+48"	PP-WM		16 A POWER POINT FOR WASHING MACHINE
+12"	PP-INV.		16 A POWER POINT FOR INVERTOR
+93"	PP-AC		25A SWITCH MCB FOR AC
			CHAMBER(2" X 2")
+18"			6A 2 NOS SOCKET-1 NOS 16A SWITCH TELEPHONE LAN
+60"	MCB DB		MCB DISTRIBUTION BOARD
			CAMERA
			WALL FAN
BSB	6A S/S FAN REGULATOR, L SWITCH		
BAC	6A S/S 25 A AC		
	EL (EXTERNAL LIGHT)		

PROJECT:
PLOT NO. 49,50,62 & 63
SCHEME NO.17 LAXMAN REKHA JAIPUR.

NAME OF DRAWING:
MAIN LT PANEL AND SLD DRAWING


DRAWING WORKING DRAWING	NORTH:
PROJECT NO.:	DATE: 18, Nov. - 2024
SCALE: NTS	REV NO.: R-0

DRAWING NO.:				
PROJECT	CATEGORY	BLOCK	FLOOR	NUMBER
A-501				

PROJECT NAME :
BALAJI AASHIYANA II

DEVELOPER NAME :
BALAJI BUILDER

ARCHITECTS :
4 INSIDE
ARCHITECTURE N INTERIORS
Plot no. 72, S.P. Marg , C- Scheme
jaipur, rajasthan, India
cont: +91 9950595991 , 91
9982812777
e.mail: 4insideofficial@gmail.com

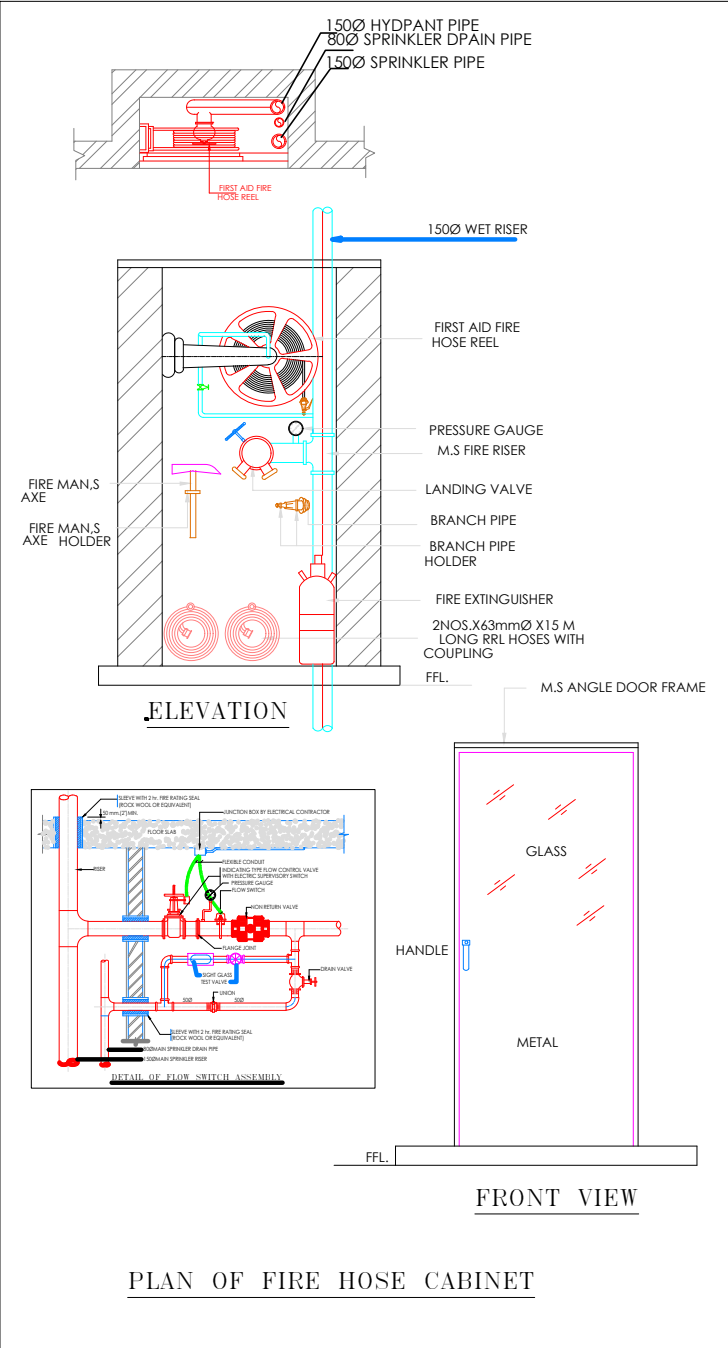


LEGEND:-


FIRE HYDRANT MS PIPE	
BALL VALVE	
EXTERNAL FIRE HYDRANT	
EXTERNAL FIRE HOSE CABINAT	
FIRE HOSE CABINAT	
UPRIGHT SPRINKLER HEAD	
PENDENT SPRINKLER HEAD	
SIDE WALL SPRINKLER HEAD	
FIRE EXINGUISHER	
FLOW SWITCH	FS
ISOLATION VALVE	IV
2 WAY FIRE BRIGADE INLET	

S.NO	DATE	REVISION DESCRIPTION
GENERAL NOTES :		
1.	All dimension on this drawing are in MKS System Only written dimensions are to be followed drawing should not be scaled.	
2.	All measurements must be checked and verified by the contractors prior to execution of work at the site.	
3.	This drawing is to be read in conjunction with all relevant structural, services & facility planning drawings.	
4.	Architectural drawings are to be followed for the location of all structural members & masonry walls, for sizes & reinforcement details of structural members, relevant structural drawings are to be referred.	
5.	Any discrepancies between architectural, structural and services drawings must be brought to the notice of the architects immediately & prior to execution at site.	
6.	Co-ordinate with services such as hvac, plumbing & electrical, etc. is the responsibility of the contractors.	
7.	All masonry walls should be aligned with the columns as indicated on the plan, irrespective of the position as calculated with the dimensions.	
8.	For details, refer relevant large scale detail drgs. as indicated.	

PROJECT:
PLOT NO. 49,50,62 & 63
SCHEME NO.17 LAXMAN REKHA
JAIPUR.

NAME OF DRAWING:
TYPICAL FLOOR FIRE FIGHTING PLAN (GROUND TO FIFTH) FHC, MCP, HOOTER & FIRE EXTINGUISHER PLAN

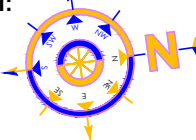DRAWING WORKING DRAWING	NORTH: 													
PROJECT NO. :	DATE : 21, Nov. - 2024													
SCALE : NTS	REV NO. : R-0													
DRAWING NO. : <table><tr><td>PROJECT</td><td>CATEGORY</td><td>BLOCK</td><td>FLOOR</td><td>TYPE</td><td>NUMBER</td></tr><tr><td></td><td></td><td></td><td></td><td></td><td></td></tr></table>		PROJECT	CATEGORY	BLOCK	FLOOR	TYPE	NUMBER							DRAWING PATH : A-201
PROJECT	CATEGORY	BLOCK	FLOOR	TYPE	NUMBER									

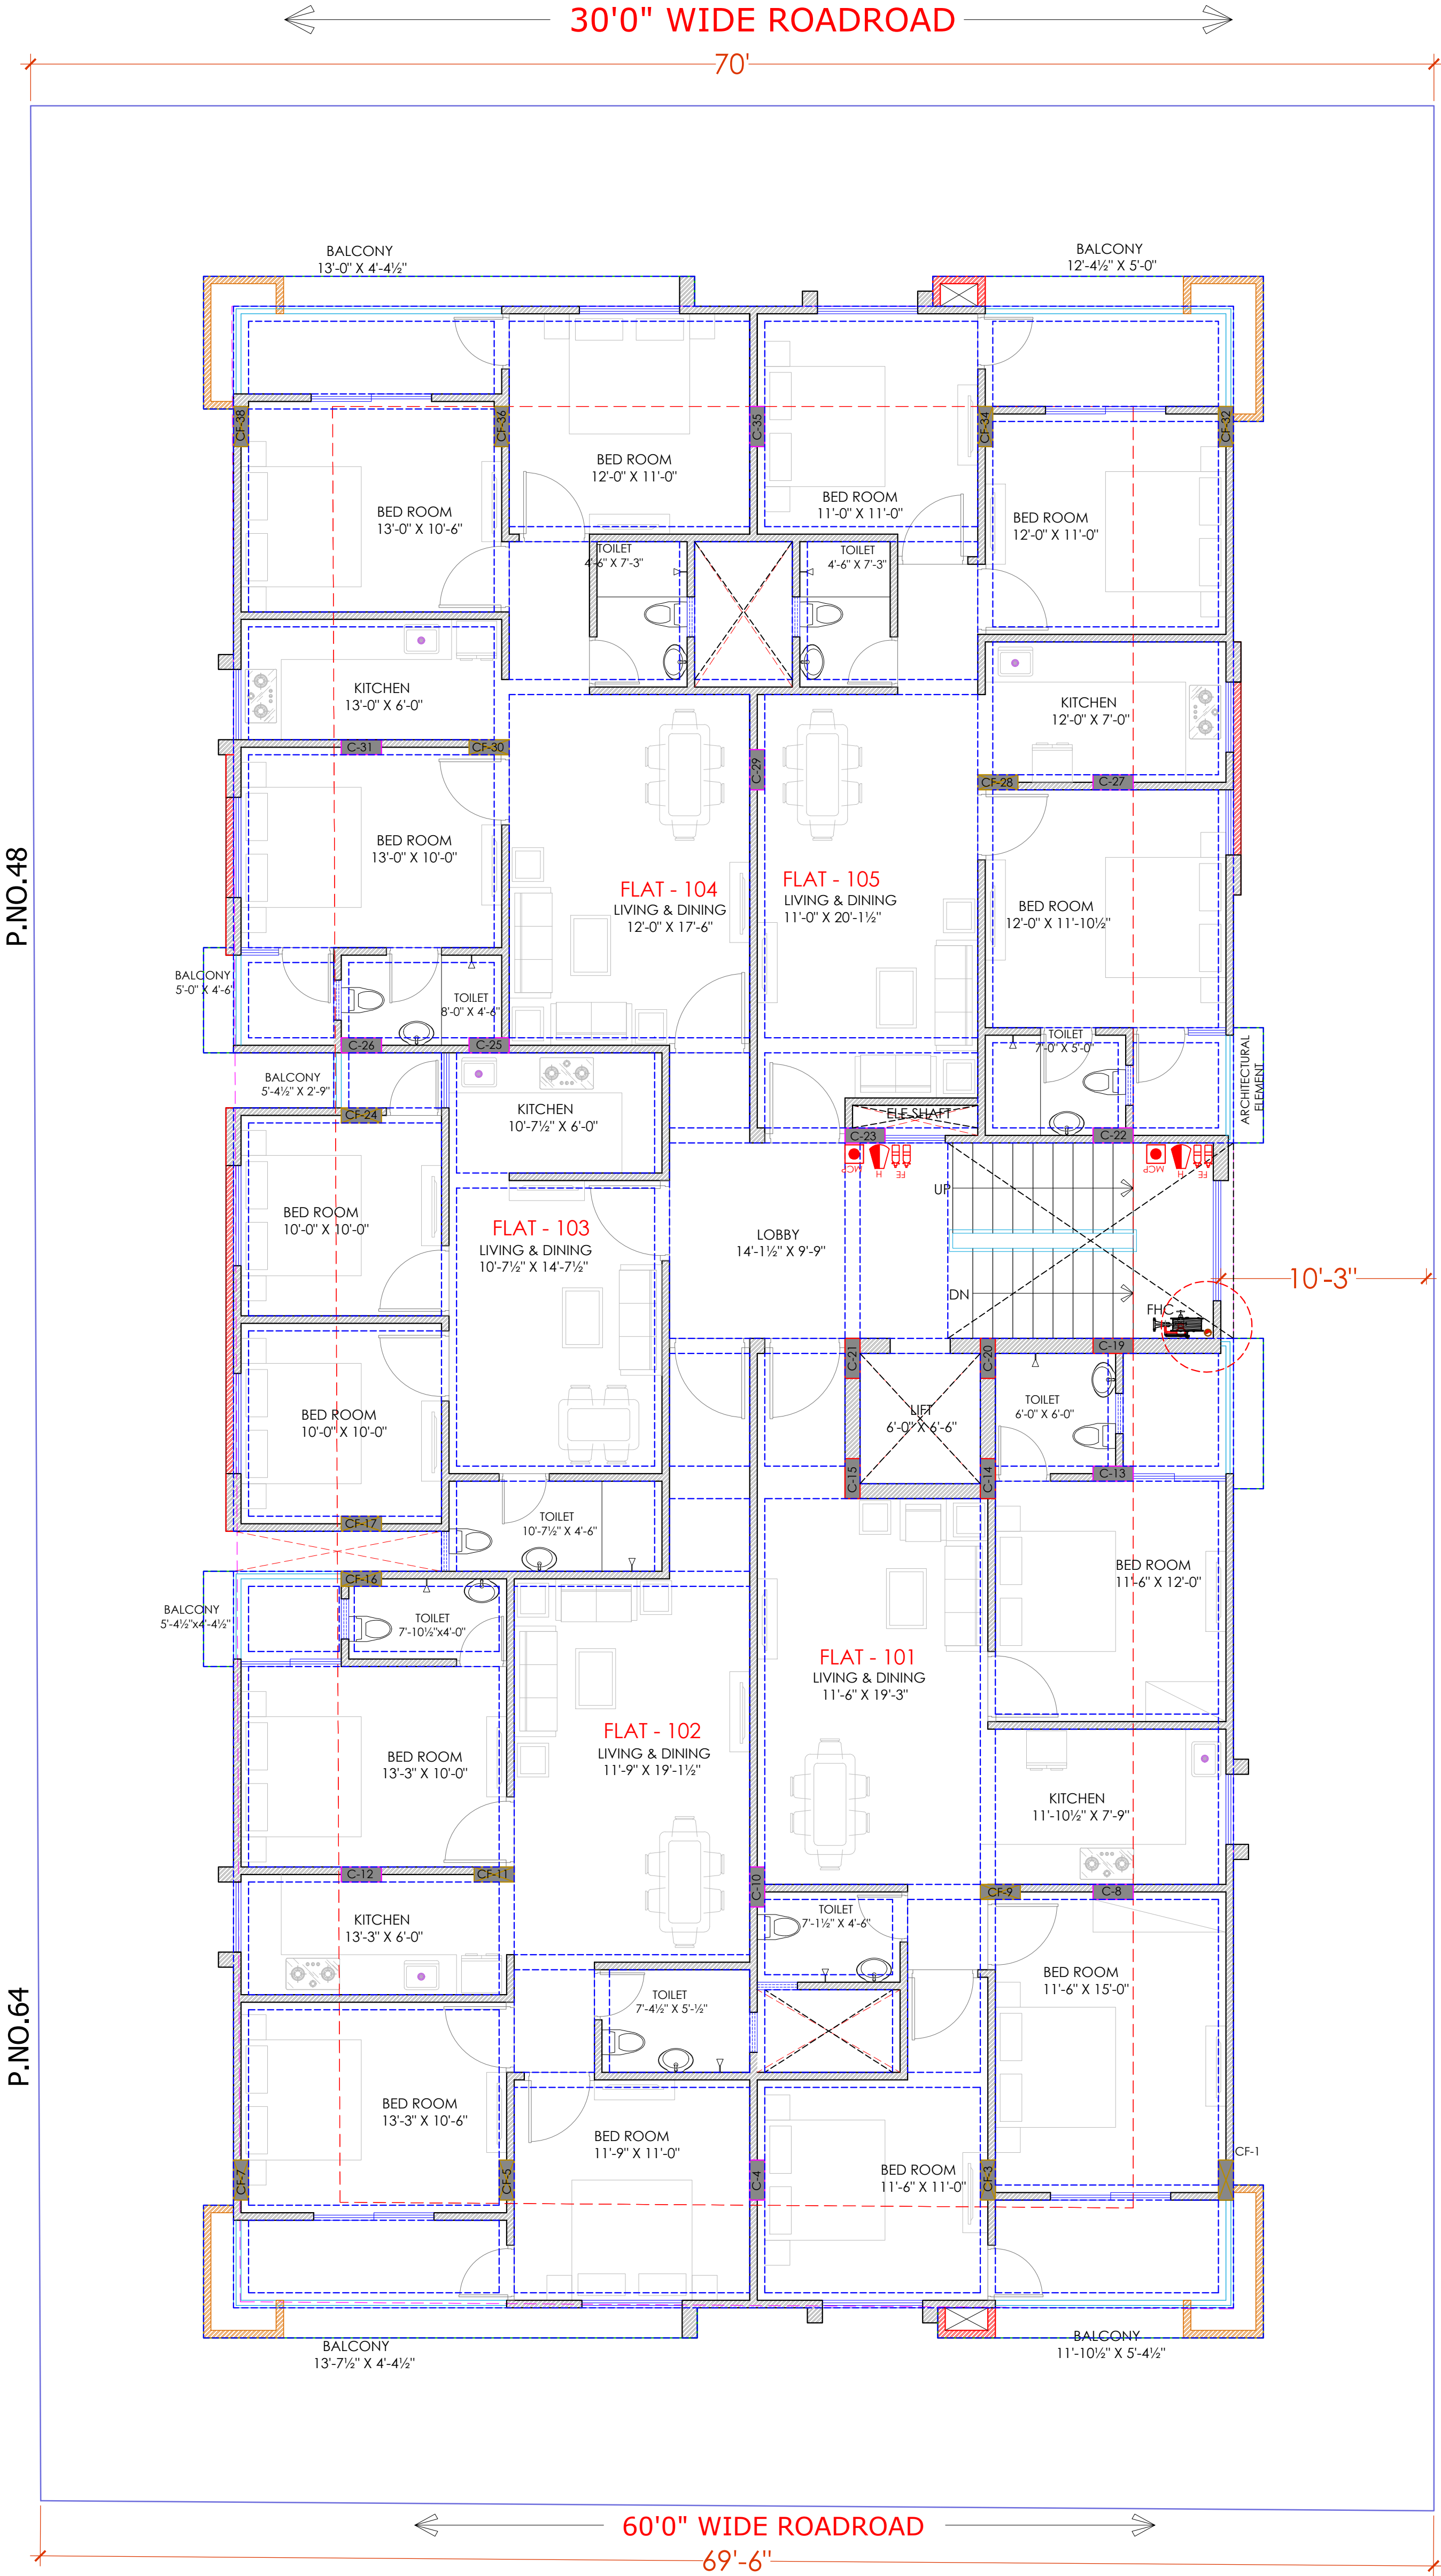

Er. SANJEEV SHARMA
B.E (Electrical)

For BALAJI BUILDERS
Proprietor

TYPICAL FLOOR FIRE FIGHTING PLAN(GROUND TO FIFTH)
FHC, MCP, HOOTER & FIRE EXTINGUISHER PLAN

BALAJI AASHIYANA II

BALAJI BUILDER


e.mail: 4insideofficial@gmail.com

DRAWING NO. :

			-	-						
PROJECT			CATEGORY	BLOCK	FLOOR		TYPE		NUMBER	

A-201

TARRACE FLOOR FIRE FIGHTING PLAN, FIRE SCHEMATIC LAYOUT

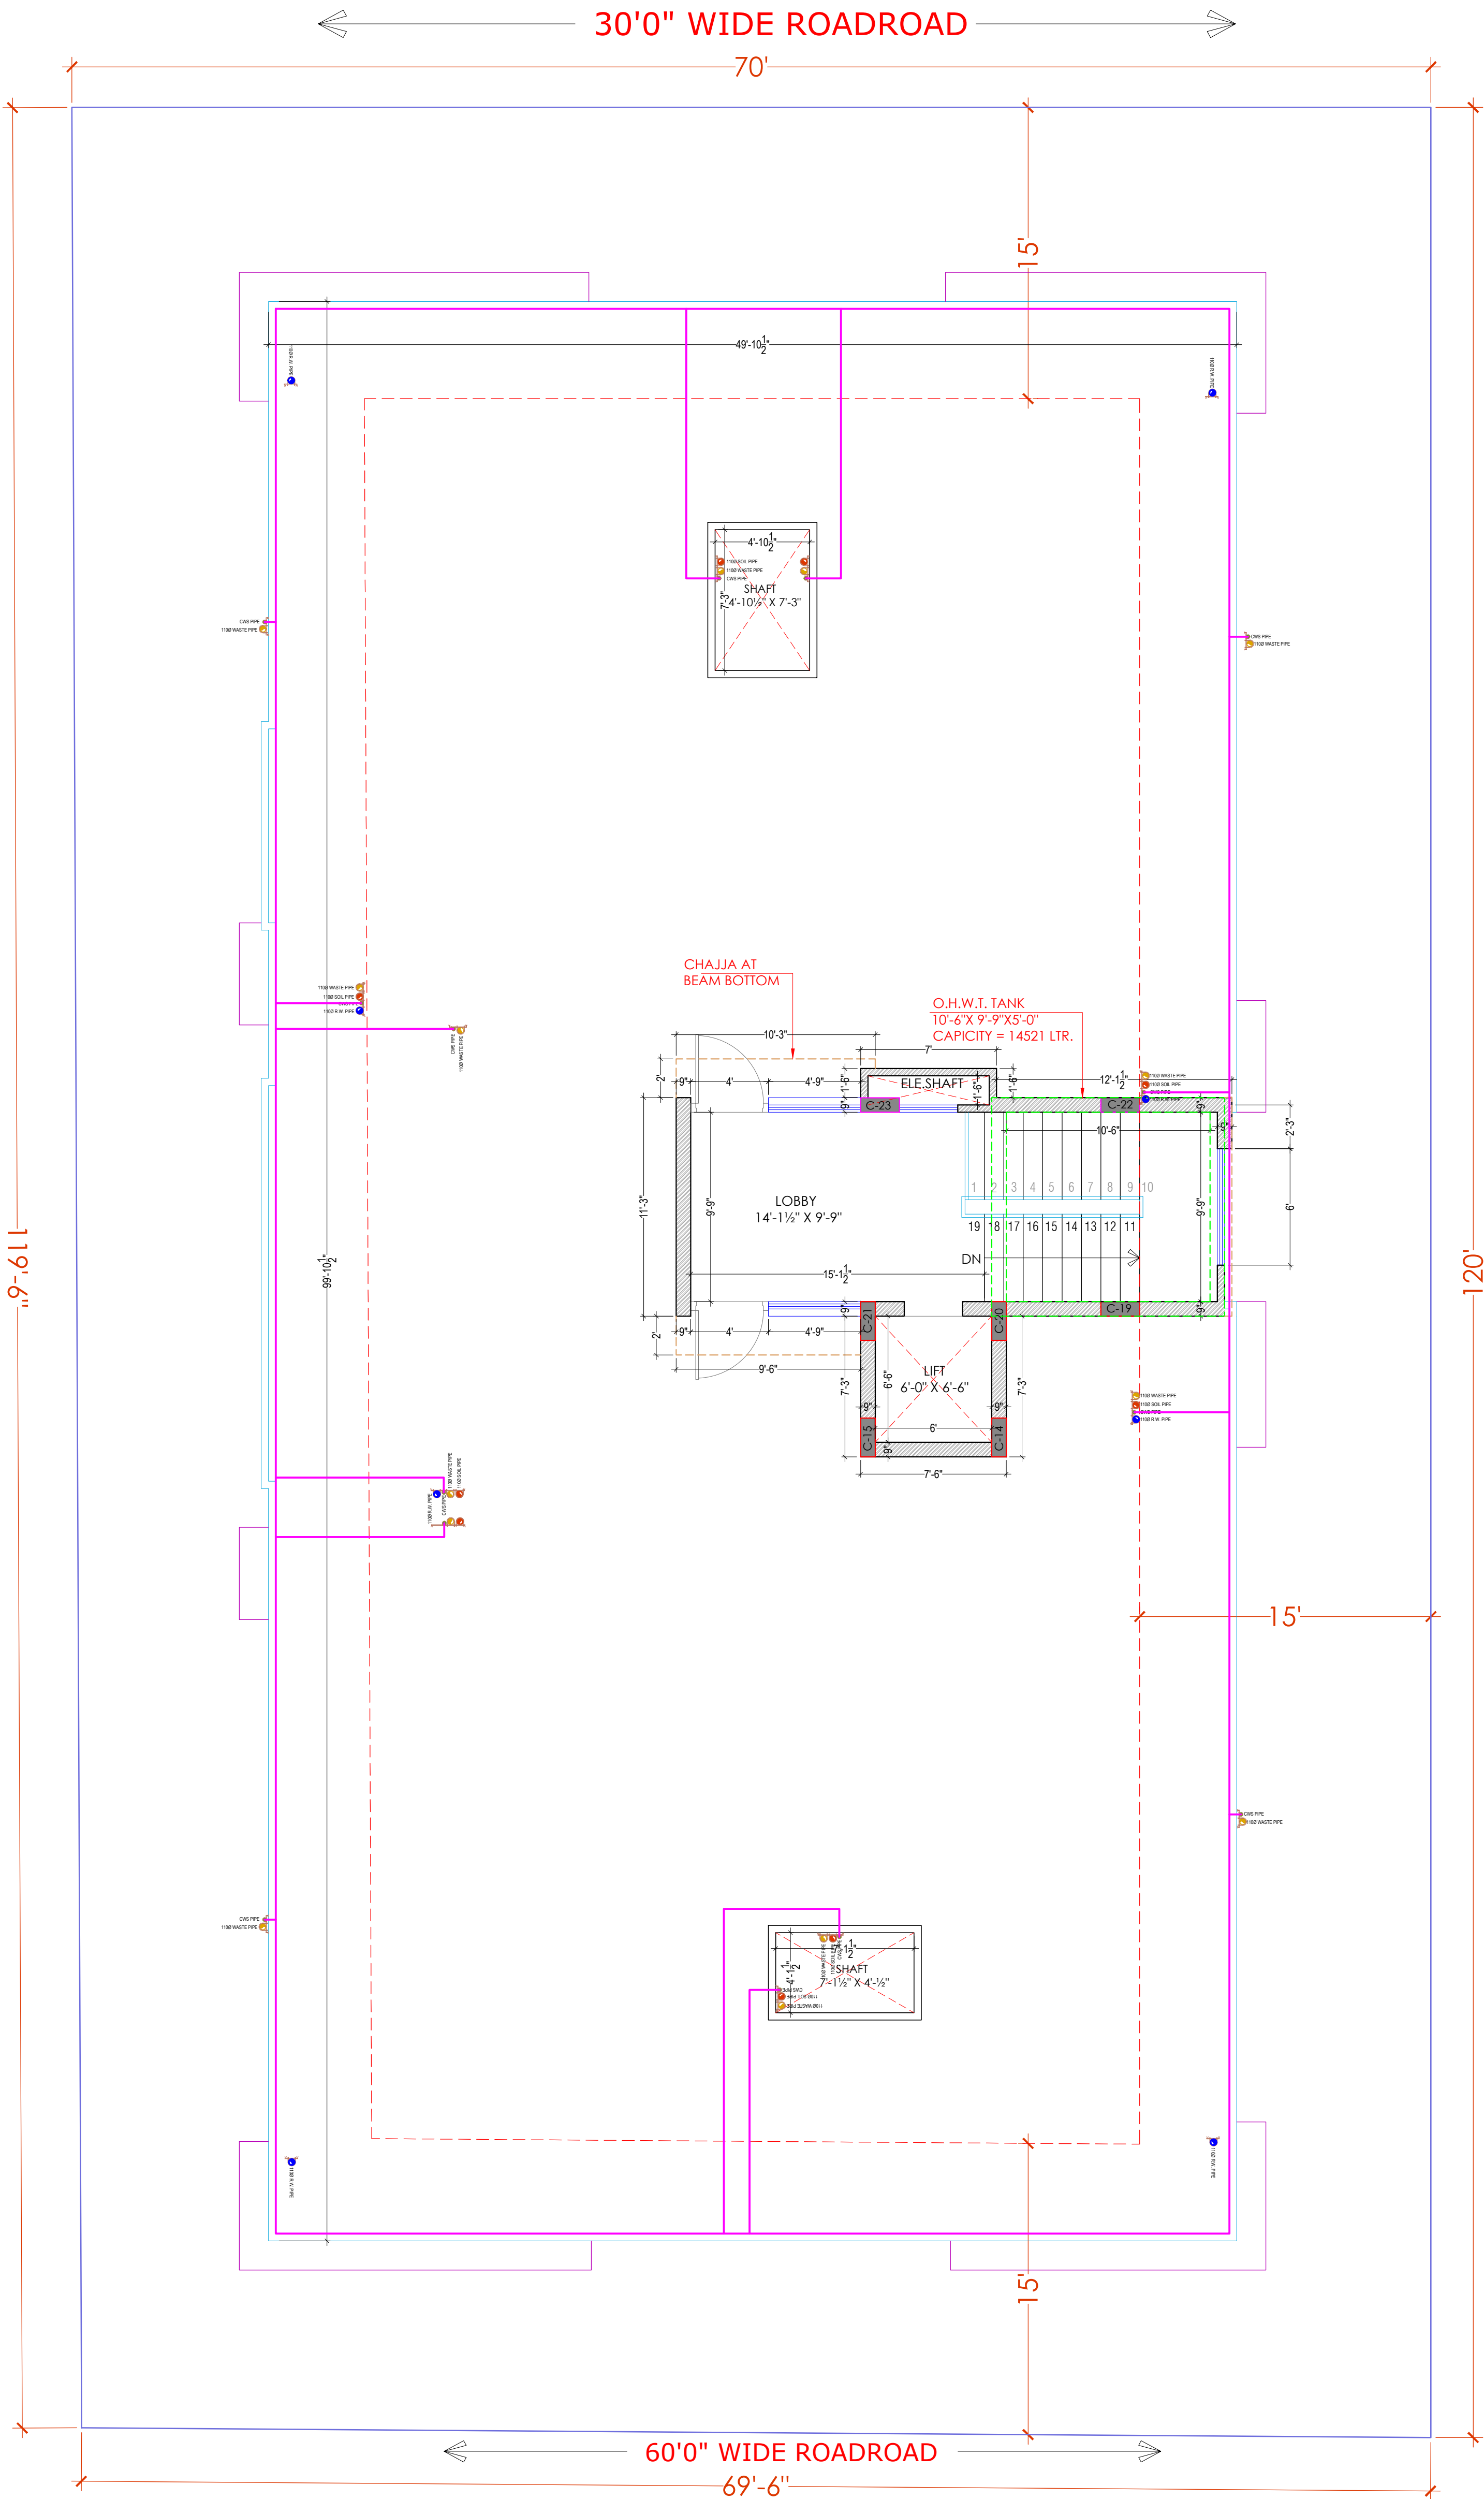

Er. SANJEEV SHARMA
B.E (Electrical)

For BALAJI BUILDERS
Proprietor

PROJECT NAME :
BALAJI AASHIYANA II

DEVELOPER NAME :
BALAJI BUILDER

ARCHITECTS :
4 INSIDE
ARCHITECTURE N INTERIORS
Plot no. 72, S.P. Marg , C- Scheme
jaipur, rajasthan, India
cont: +91 9950595991 , 91
9982812777
e.mail: 4insideofficial@gmail.com

LEGEND:-		
①	SOIL PIPE	
②	WASTE PIPE	
③	VENT PIPE	
④	COLD WATER SUPPLY (CWS)	
⑤	HOT WATER SUPPLY (HWS)	
	RAIN WATER PIPE	
SW	SEWER LINE- EXTERNAL	
RW	STORM WATER DRAINAGE PIPE	
	SEWERAGE MANHOLE (2' x 2')	M.H.
	STORM WATER MANHOLE (2' x 2')	M.H.
GT	GULLY TRAP	
BV	BALL VALVE	
FT	FLOOR TRAP	
FD	FLOOR FLOOR DRAIN	
	RAIN WATER COLLECTION CHAMBER 450X450MM	
	KHURRA	

- GENERAL NOTES :-
- All dimension on this drawing are in MKS System Only written dimensions are to be followed drawing should not be scaled.
 - All measurements must be checked and verified by the contractors prior to execution of work at the site.
 - This drawing is to be read in conjunction with all relevant structural, services & facility planning drawings.
 - Architectural drawings are to be followed for the location of all structural members & masonry walls, for sizes & reinforcement details of structural members, relevant structural drawings are to be referred.
 - Any discrepancies between architectural, structural and services drawings must be brought to the notice of the architects immediately & prior to execution at site.
 - Co-ordinate with services such as hvac, plumbing & electrical, etc. is the responsibility of the contractors.
 - All masonry walls should be aligned with the columns as indicated on the plan, irrespective of the position as calculated with the dimensions.
 - For details, refer relevant large scale detail drgs. as indicated.

PROJECT:
PLOT NO. 49,50,62 & 63
SCHEME NO.17 LAXMAN REKHA
JAIPUR.

NAME OF DRAWING:

TERRACE FLOOR FLOOR RING MAIN LAYOUT,
WATER SUPPLY SYSTEMATIC DIAGRAM ,UG WATER
TANK TO OHT FILLING ROUTE PLAN

DRAWING WORKING DRAWING	NORTH:
PROJECT NO. :	DATE : 21, Nov. - 2024
SCALE : NTS	REV NO. : R-0

DRAWING NO. :						DRAWING PATH :
PROJECT	CATEGORY	BLOCK	FLOOR	TYPE	NUMBER	
						A-201

TERRACE FLOOR FLOOR RING MAIN LAYOUT, WATER SUPPLY SYSTEMATIC DIAGRAM ,
UG WATER TANK TO OHT FILLING ROUTE PLAN