

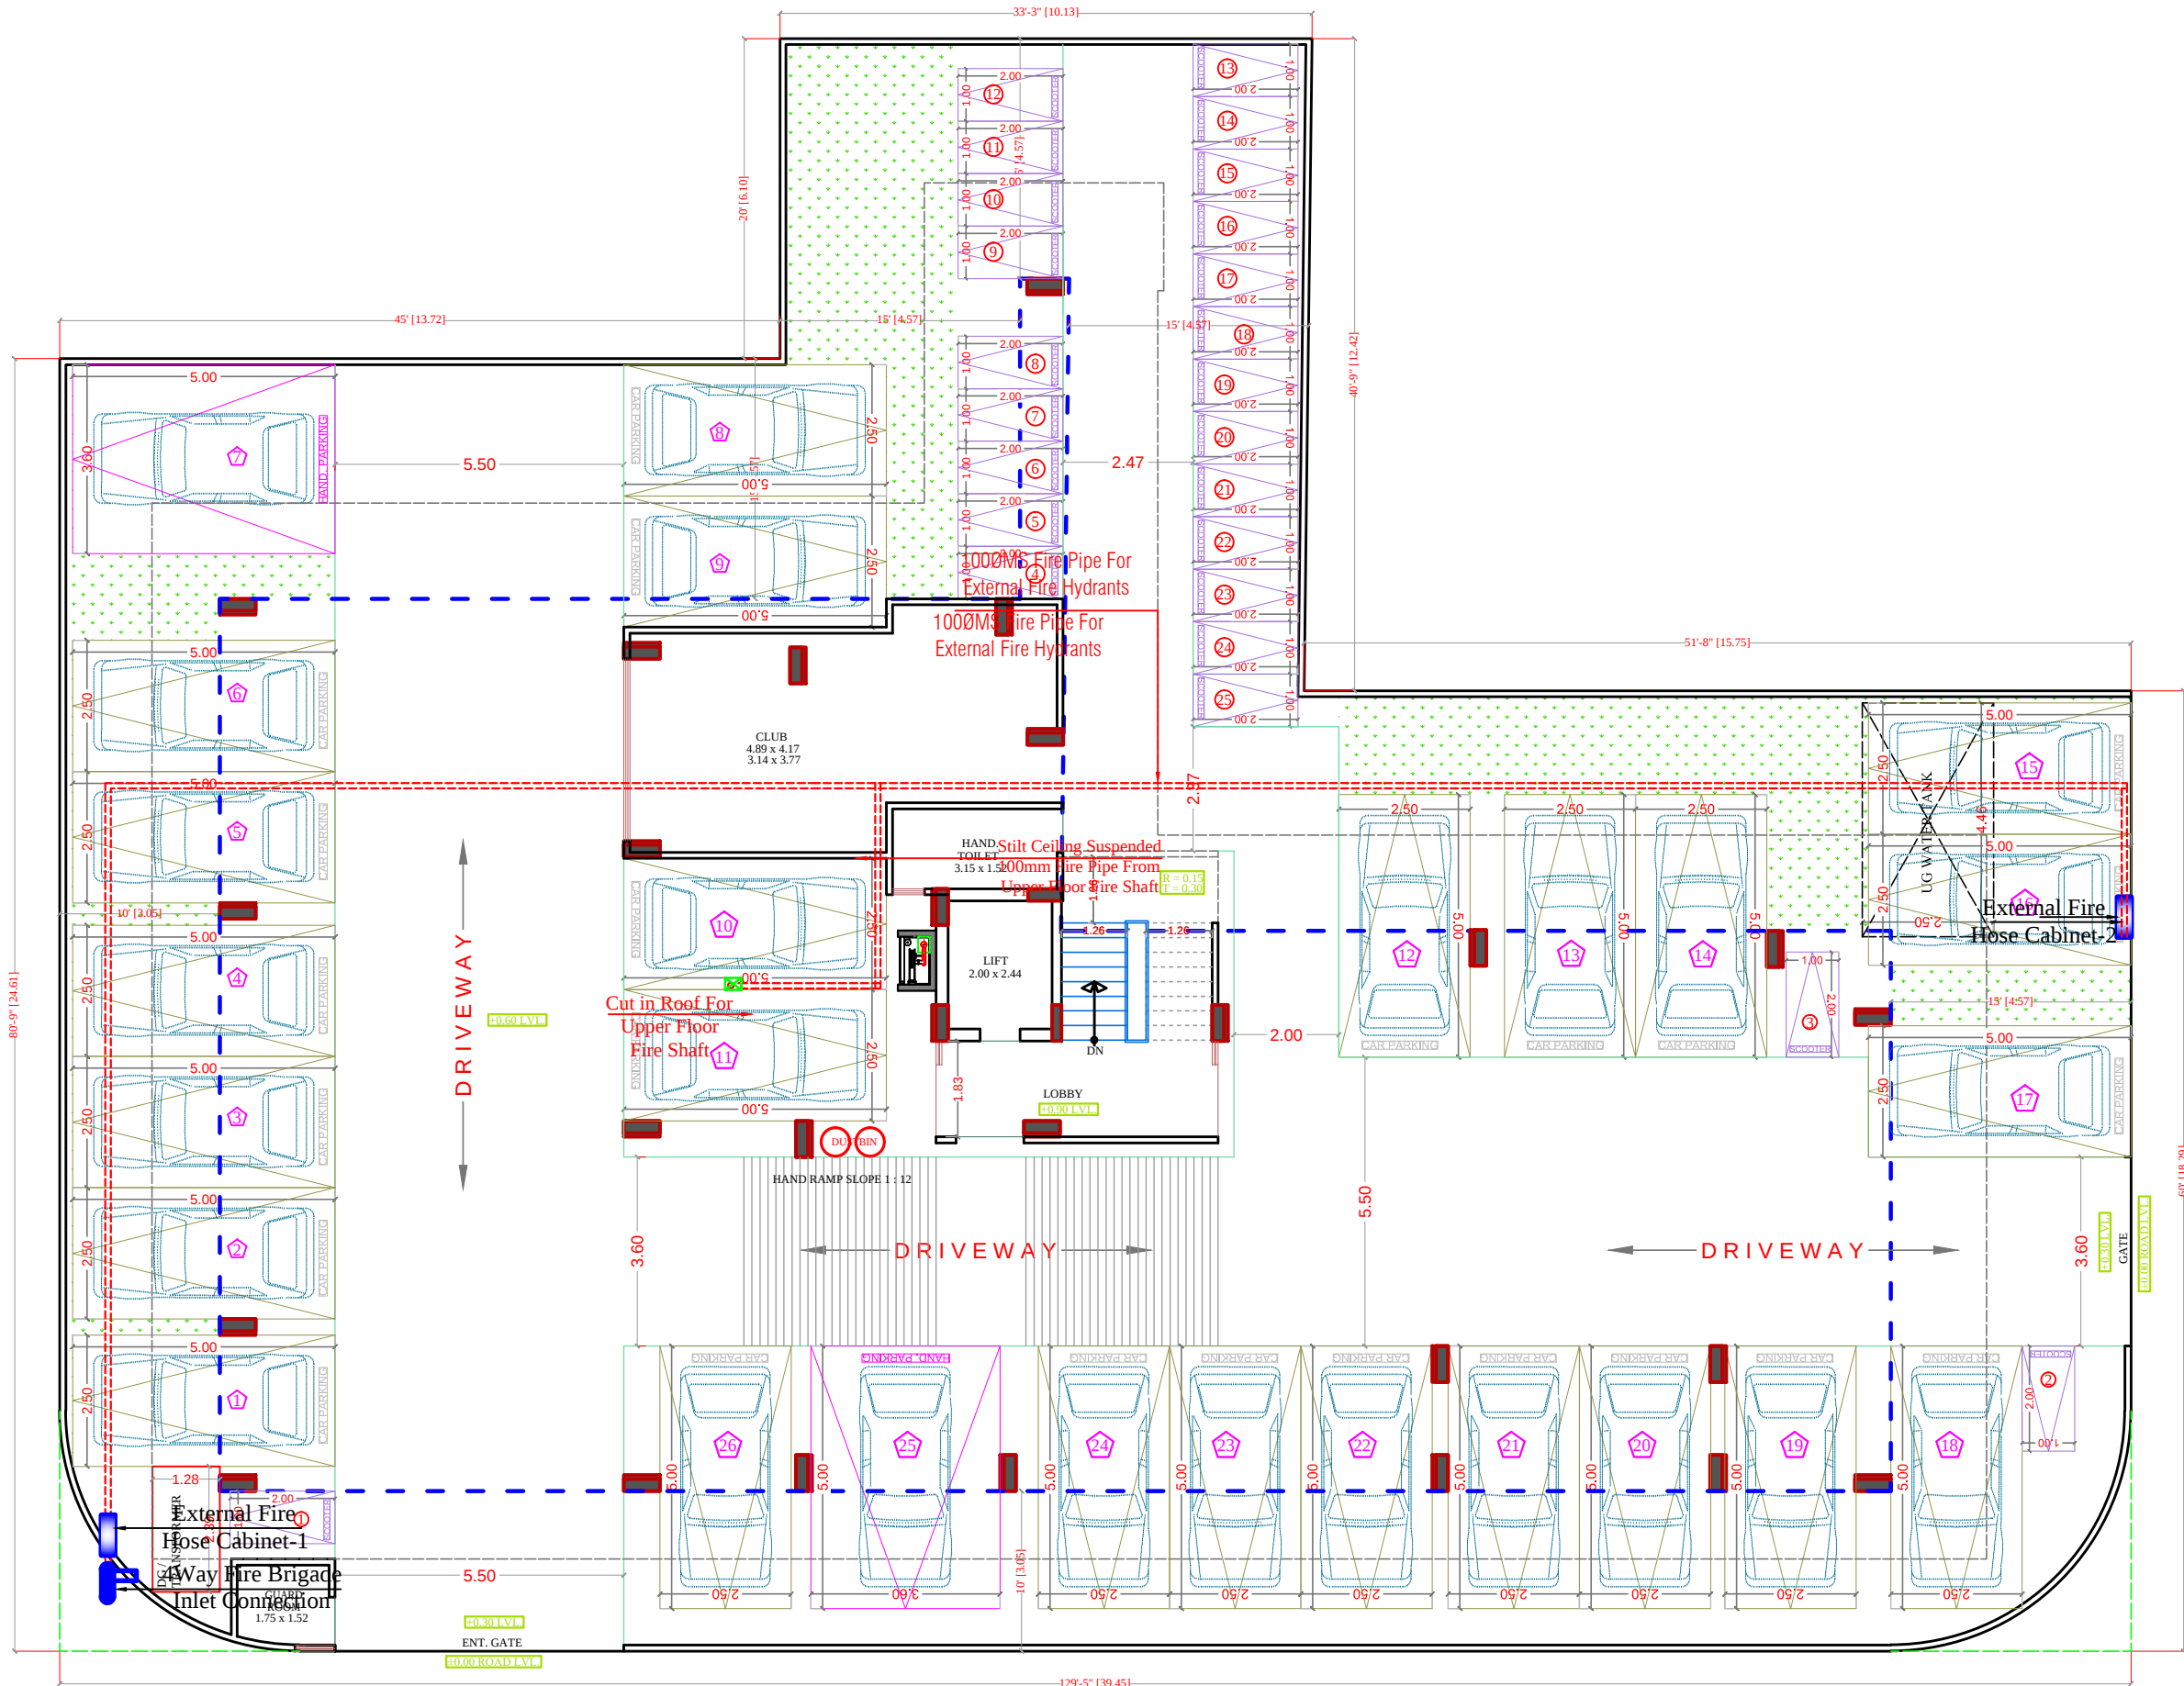


ROAD 40'-0"

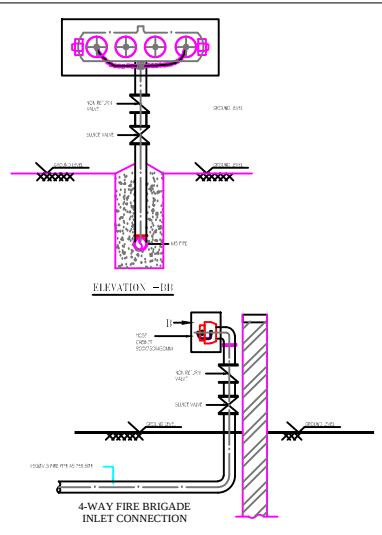

STILT FLOOR PLAN

ROAD 40'-0"

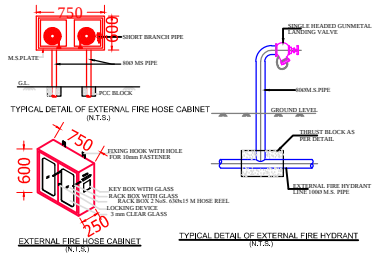

LEGEND

SYMBOL	QTY.	DESCRIPTION
	02	EXTERNAL FIRE HOSE CABINET
	01	FIRE HOSE CABINET
		1000MS FIRE PIPE FOR EXTERNAL FIRE HYDRANTS

SEAL:-

RAMESH KUMAWAT
M.E.P. CONSULTANT
B.E. CIVIL

SHRI RAM BUILDERS GROUP
Partner

SPACE CONSULTANT

PLOT-A-173, JAGDAMBA NAGAR, HEERAPURA
POWER HOWER, JAIPUR (RAJ) 302024

ARCHITECT :-

FRANK SQUARE
ARCHITECTURE | PLANNER | DESIGNER
C-49 VIDYA APARTMENT PARAS MARG,
BAPU NAGAR JAIPUR, (RAJ.)
Email-afanksquare@gmail.com
Mobile-9461302542

PROJECT :-


PROPOSED BUILDING AT PLOT NO.
PLOT NO-7(SP)8,8-A,8-B NARAYAN
PURI OF HATHROI GADI
GNSS,JAIPUR

BUILDING NAME ANANDAM HEIGHTS 1V

DEVELOPER NAME SHRI RAM BUILDERS GROUP

DRAWING: STILT FLOOR
EXTERNAL FIRE HYDRANT
FOR RERA SUBMISSION PLAN

DATE
SCALE:- N.T.S.

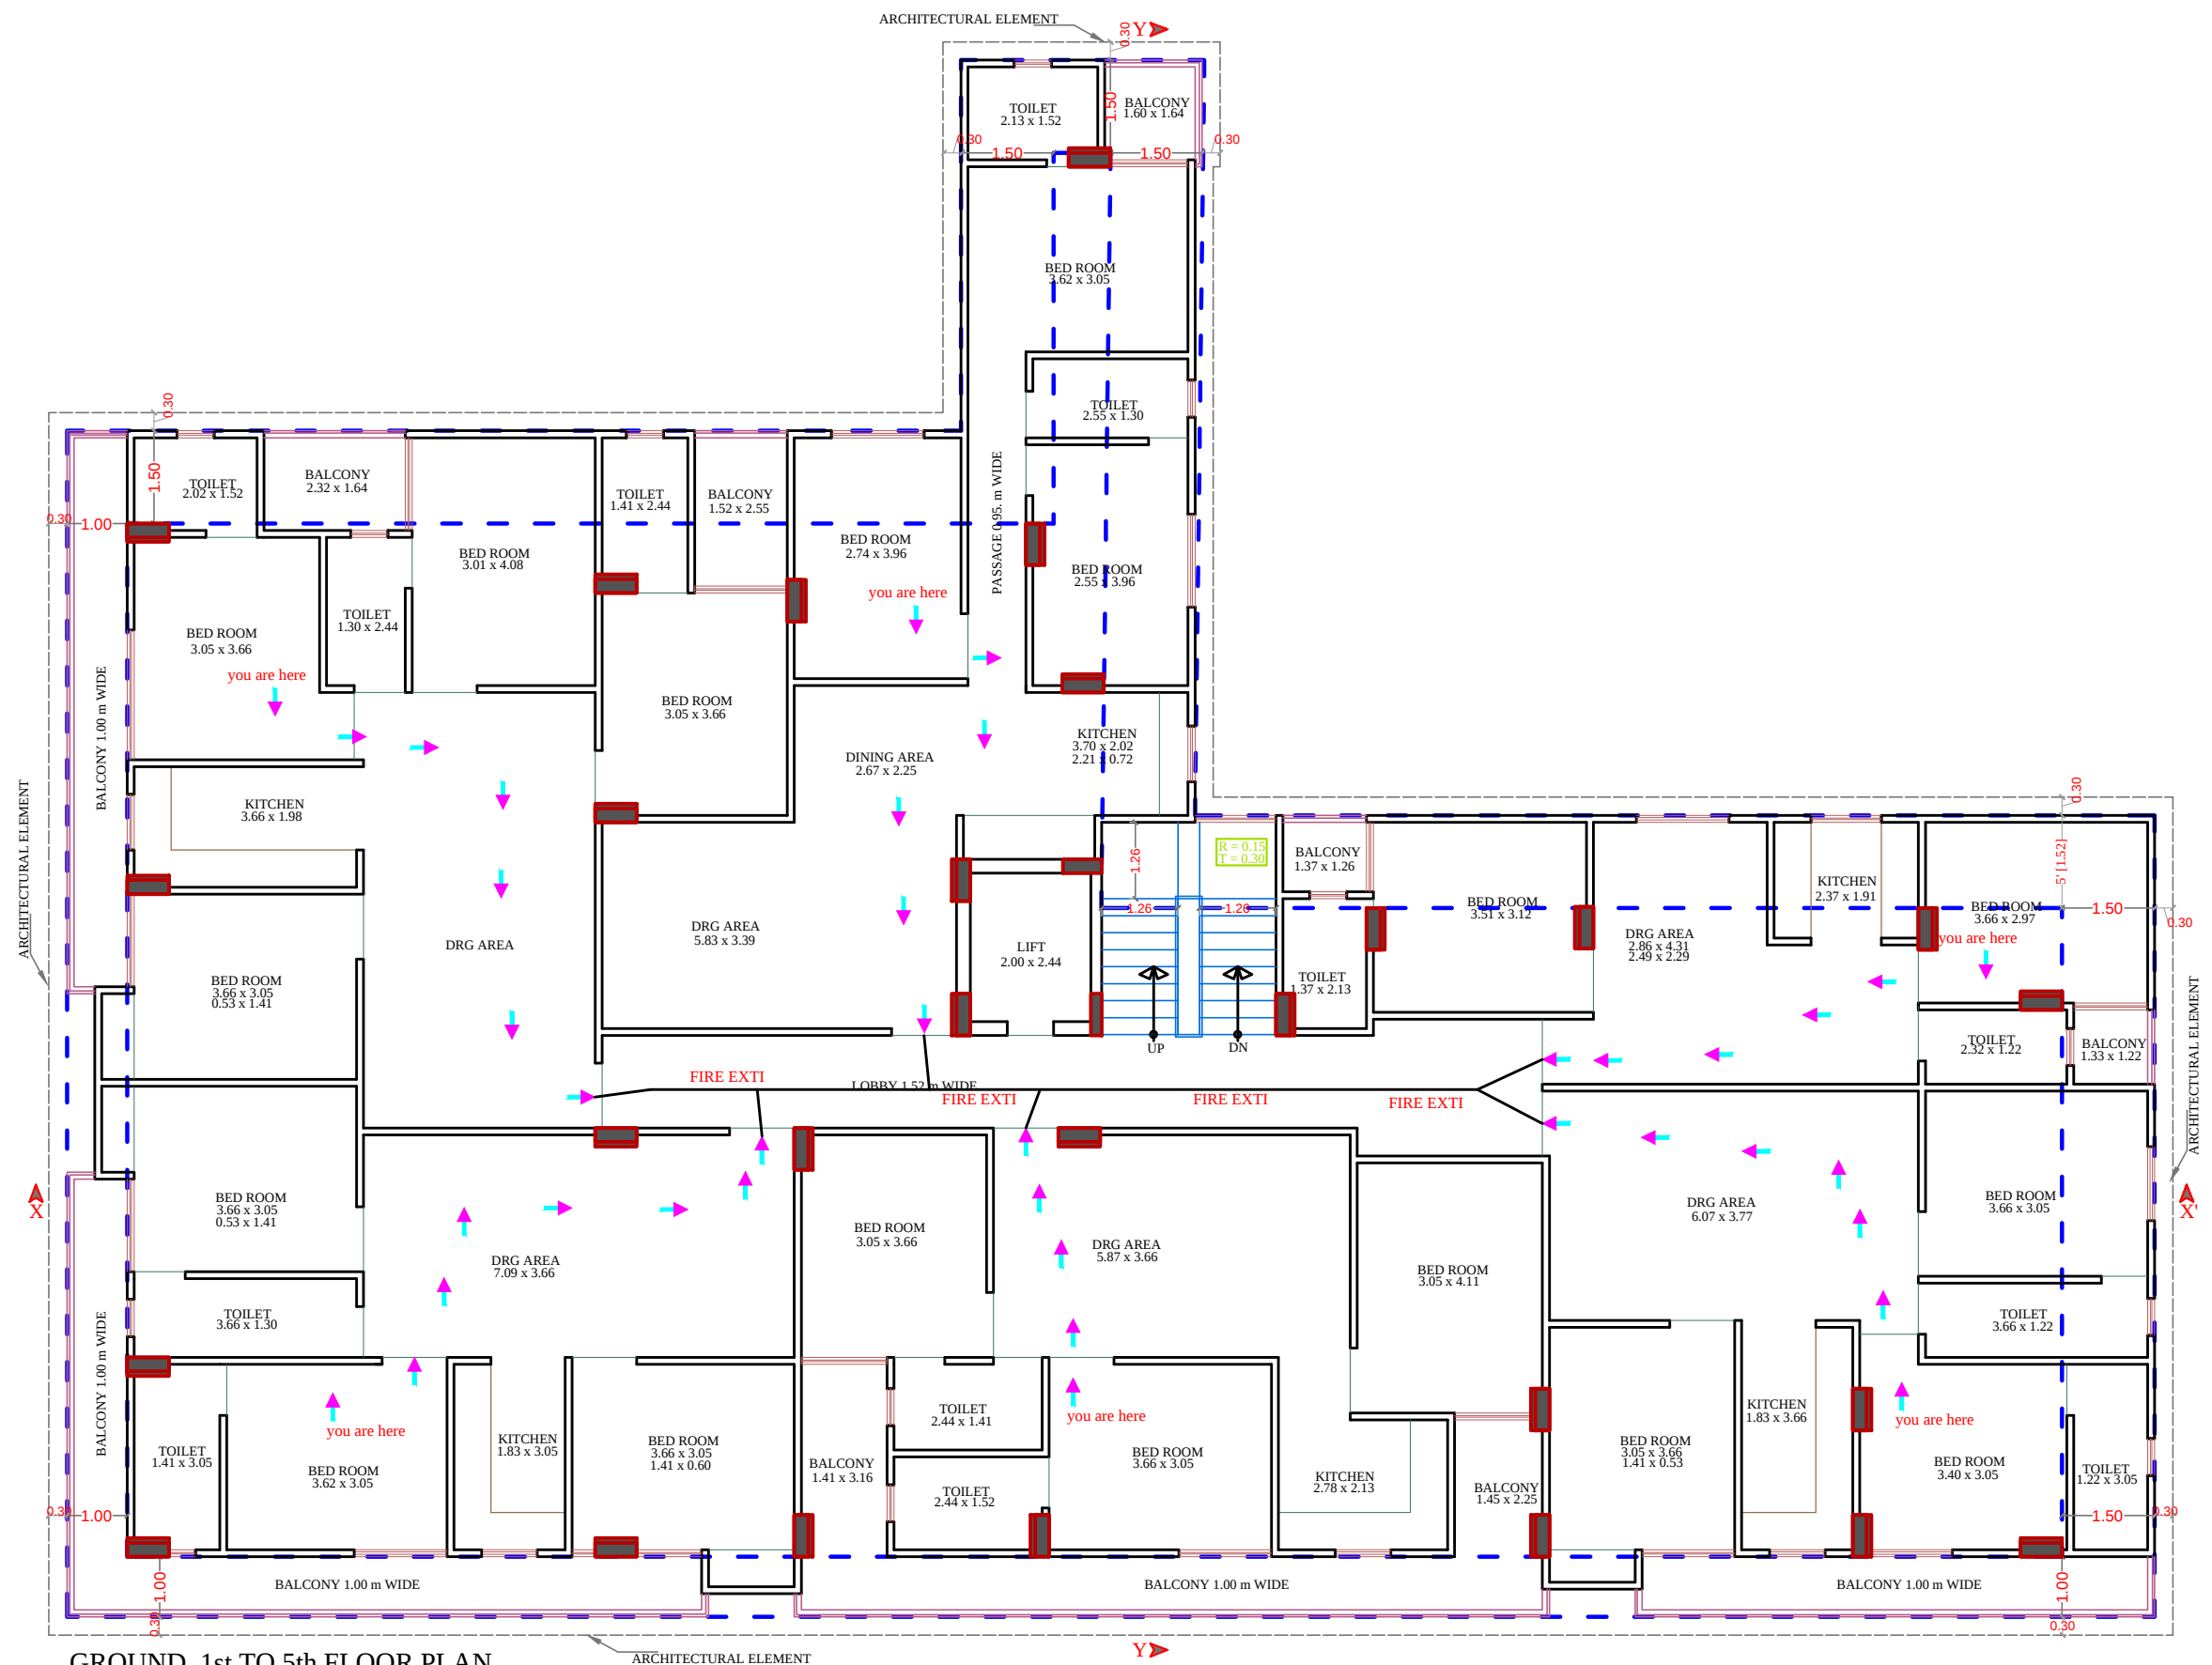


GROUND, 1st TO 5th FLOOR PLAN

RAMESH KUMAWAT
M.E.P. CONSULTANT
B.E. CIVIL

SHRI RAM BUILDERS GROUP
Partner

PROJECT TITLE :- PROPOSED BUILDING AT PLOT NO. PLOT NO-7(SP)8,8-A,8-B NARAYAN PURI OF HATHROI GADI GNSS.JAIPUR	BUILDING NAME ANANDAM HEIGHTS 1V	DRAWING TITLE :- TYPICAL FLOOR FIRE FIGHTING	SERVICES CONSULTANT	DRN. BY		DATE	NORTH
				APPD. BY		REVISION	
	DEVELOPER NAME SHRI RAM BUILDERS GROUP			SCALE			

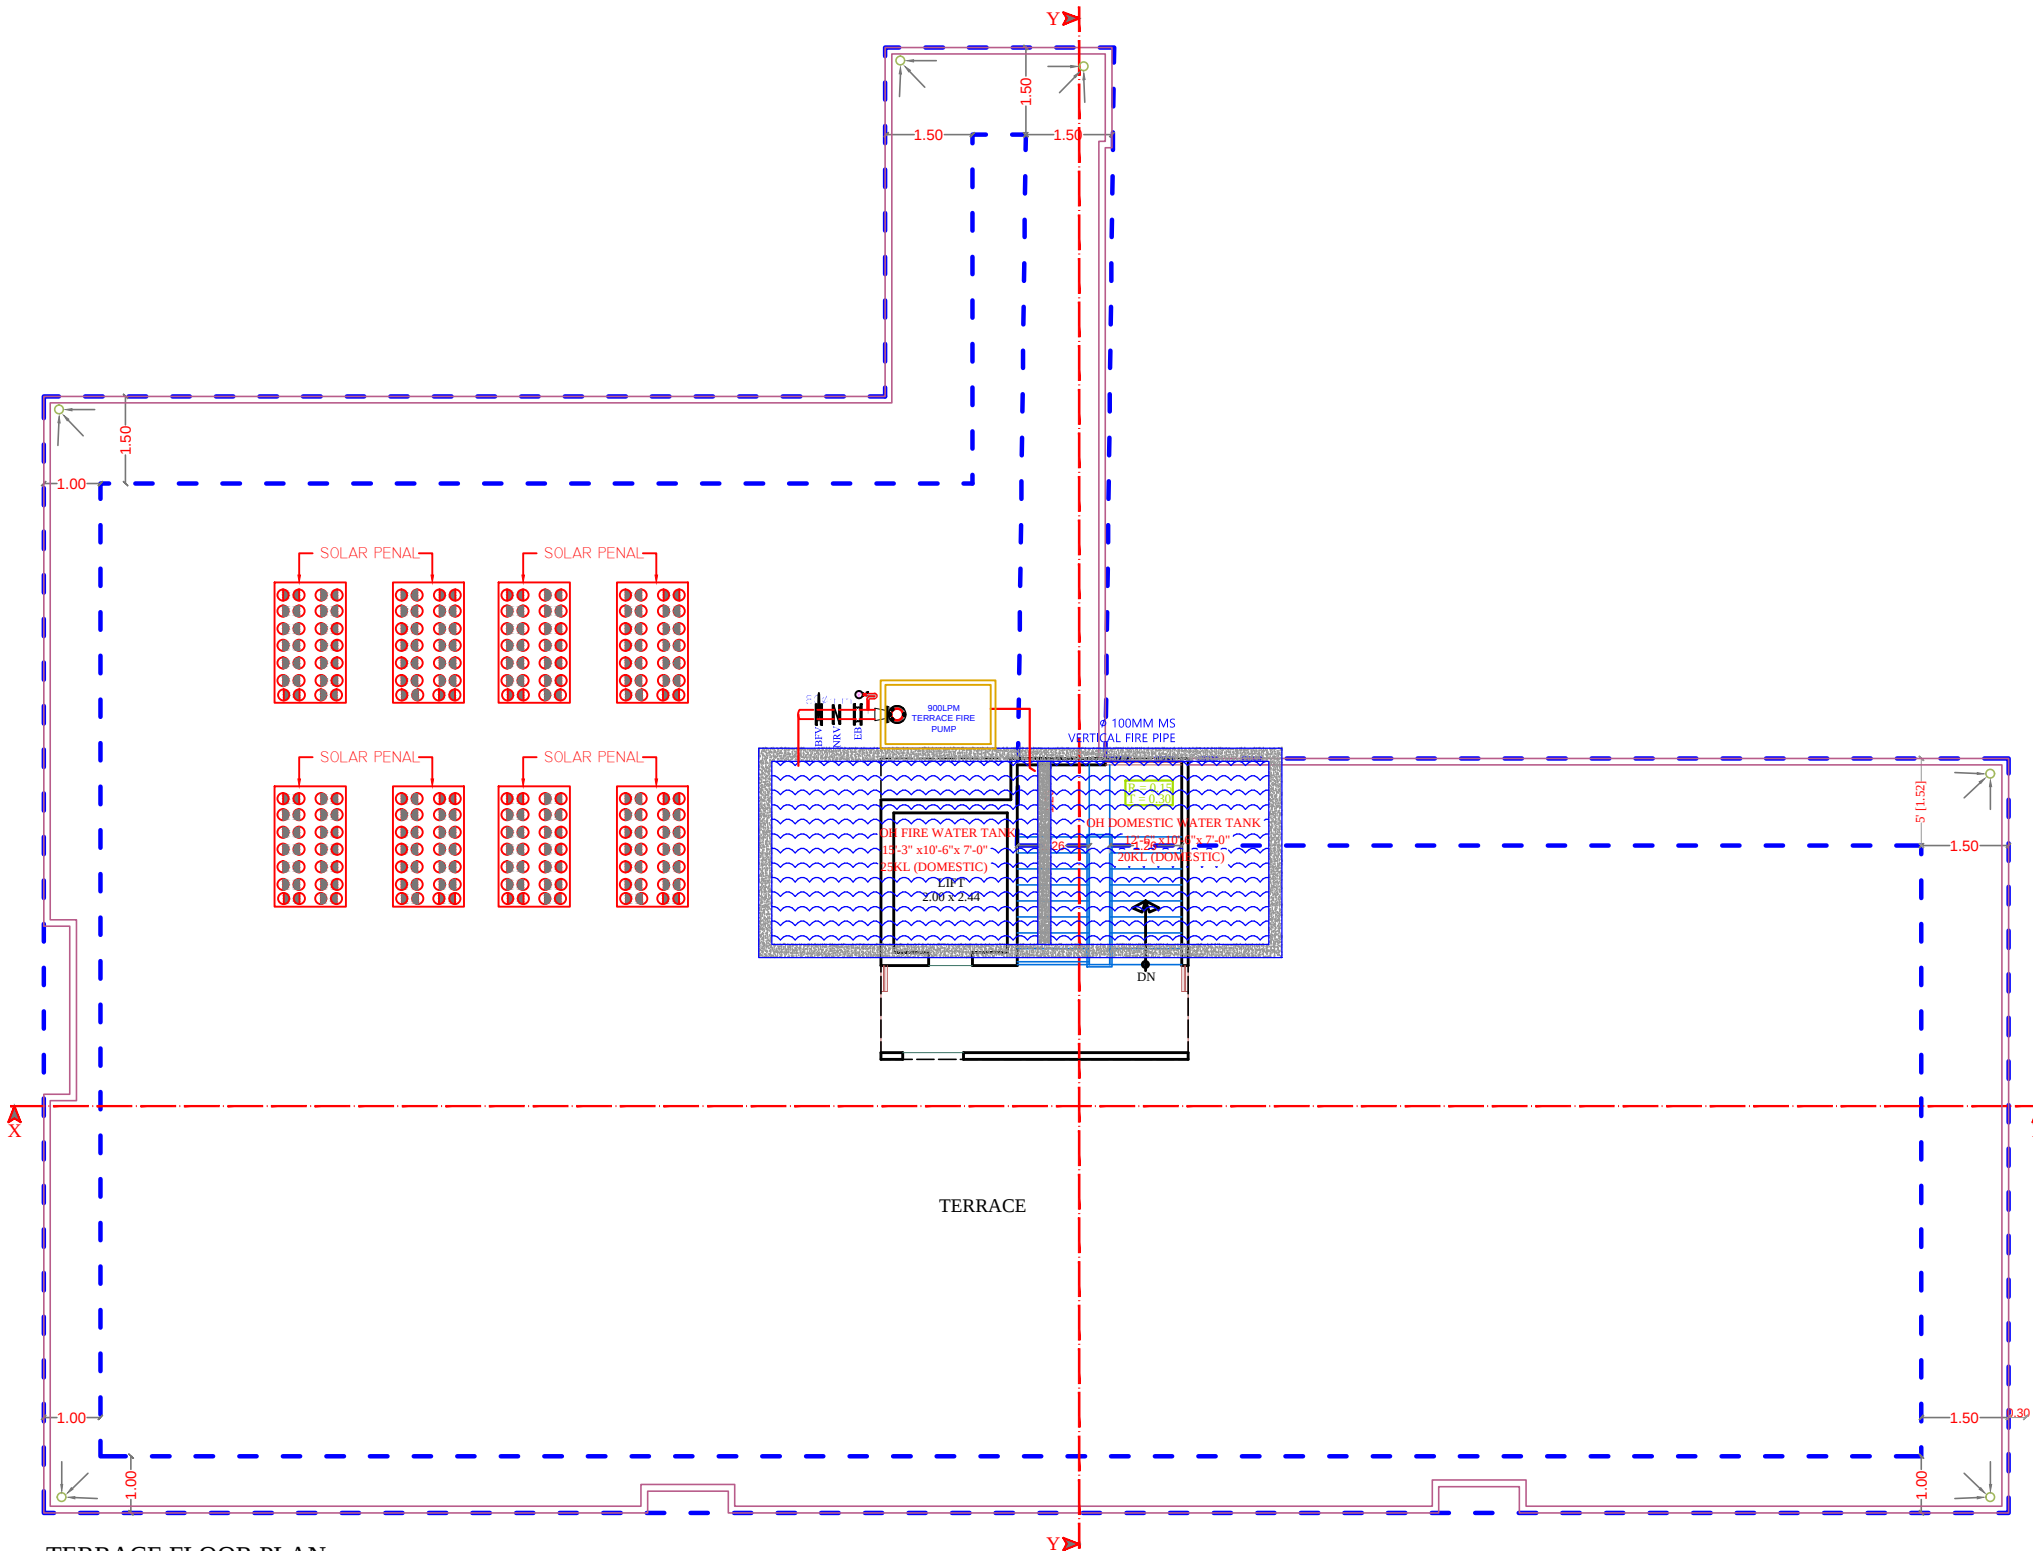

TERRACE FLOOR PLAN

LEGEND		
	Symbole	DESCRIPTION
1.		HOSEREEL
2.		FIRE PIPE
3.		FIRE PIPE
4.		FIRE EXTINGUISHER
5.		EXTERNAL YARD HYDRANT

RAMESH KUMAWAT
M.E.P. CONSULTANT
B.E. CIVIL

SHRI RAM BUILDERS GROUP
Partner

PROJECT TITLE :- PROPOSED BUILDING AT PLOT NO. PLOT NO-7(SP)8,8-A,8-B NARAYAN PURI OF HATHROI GADI GNSS.JAIPUR	BUILDING NAME ANANDAM HEIGHTS 1V	DRAWING TITLE :- TARRACE FLOOR FIRE FIGHTING	SPACE CONSULTANT PLOT-A-173, JAGDAMBA NAGAR, HEERAPURA POWER HOWER, JAIPUR (RAJ) 302024	DRN. BY		DATE	NORTH
	DEVELOPER NAME SHRI RAM BUILDERS GROUP			APPD. BY		REVISION	
				SCALE			

