


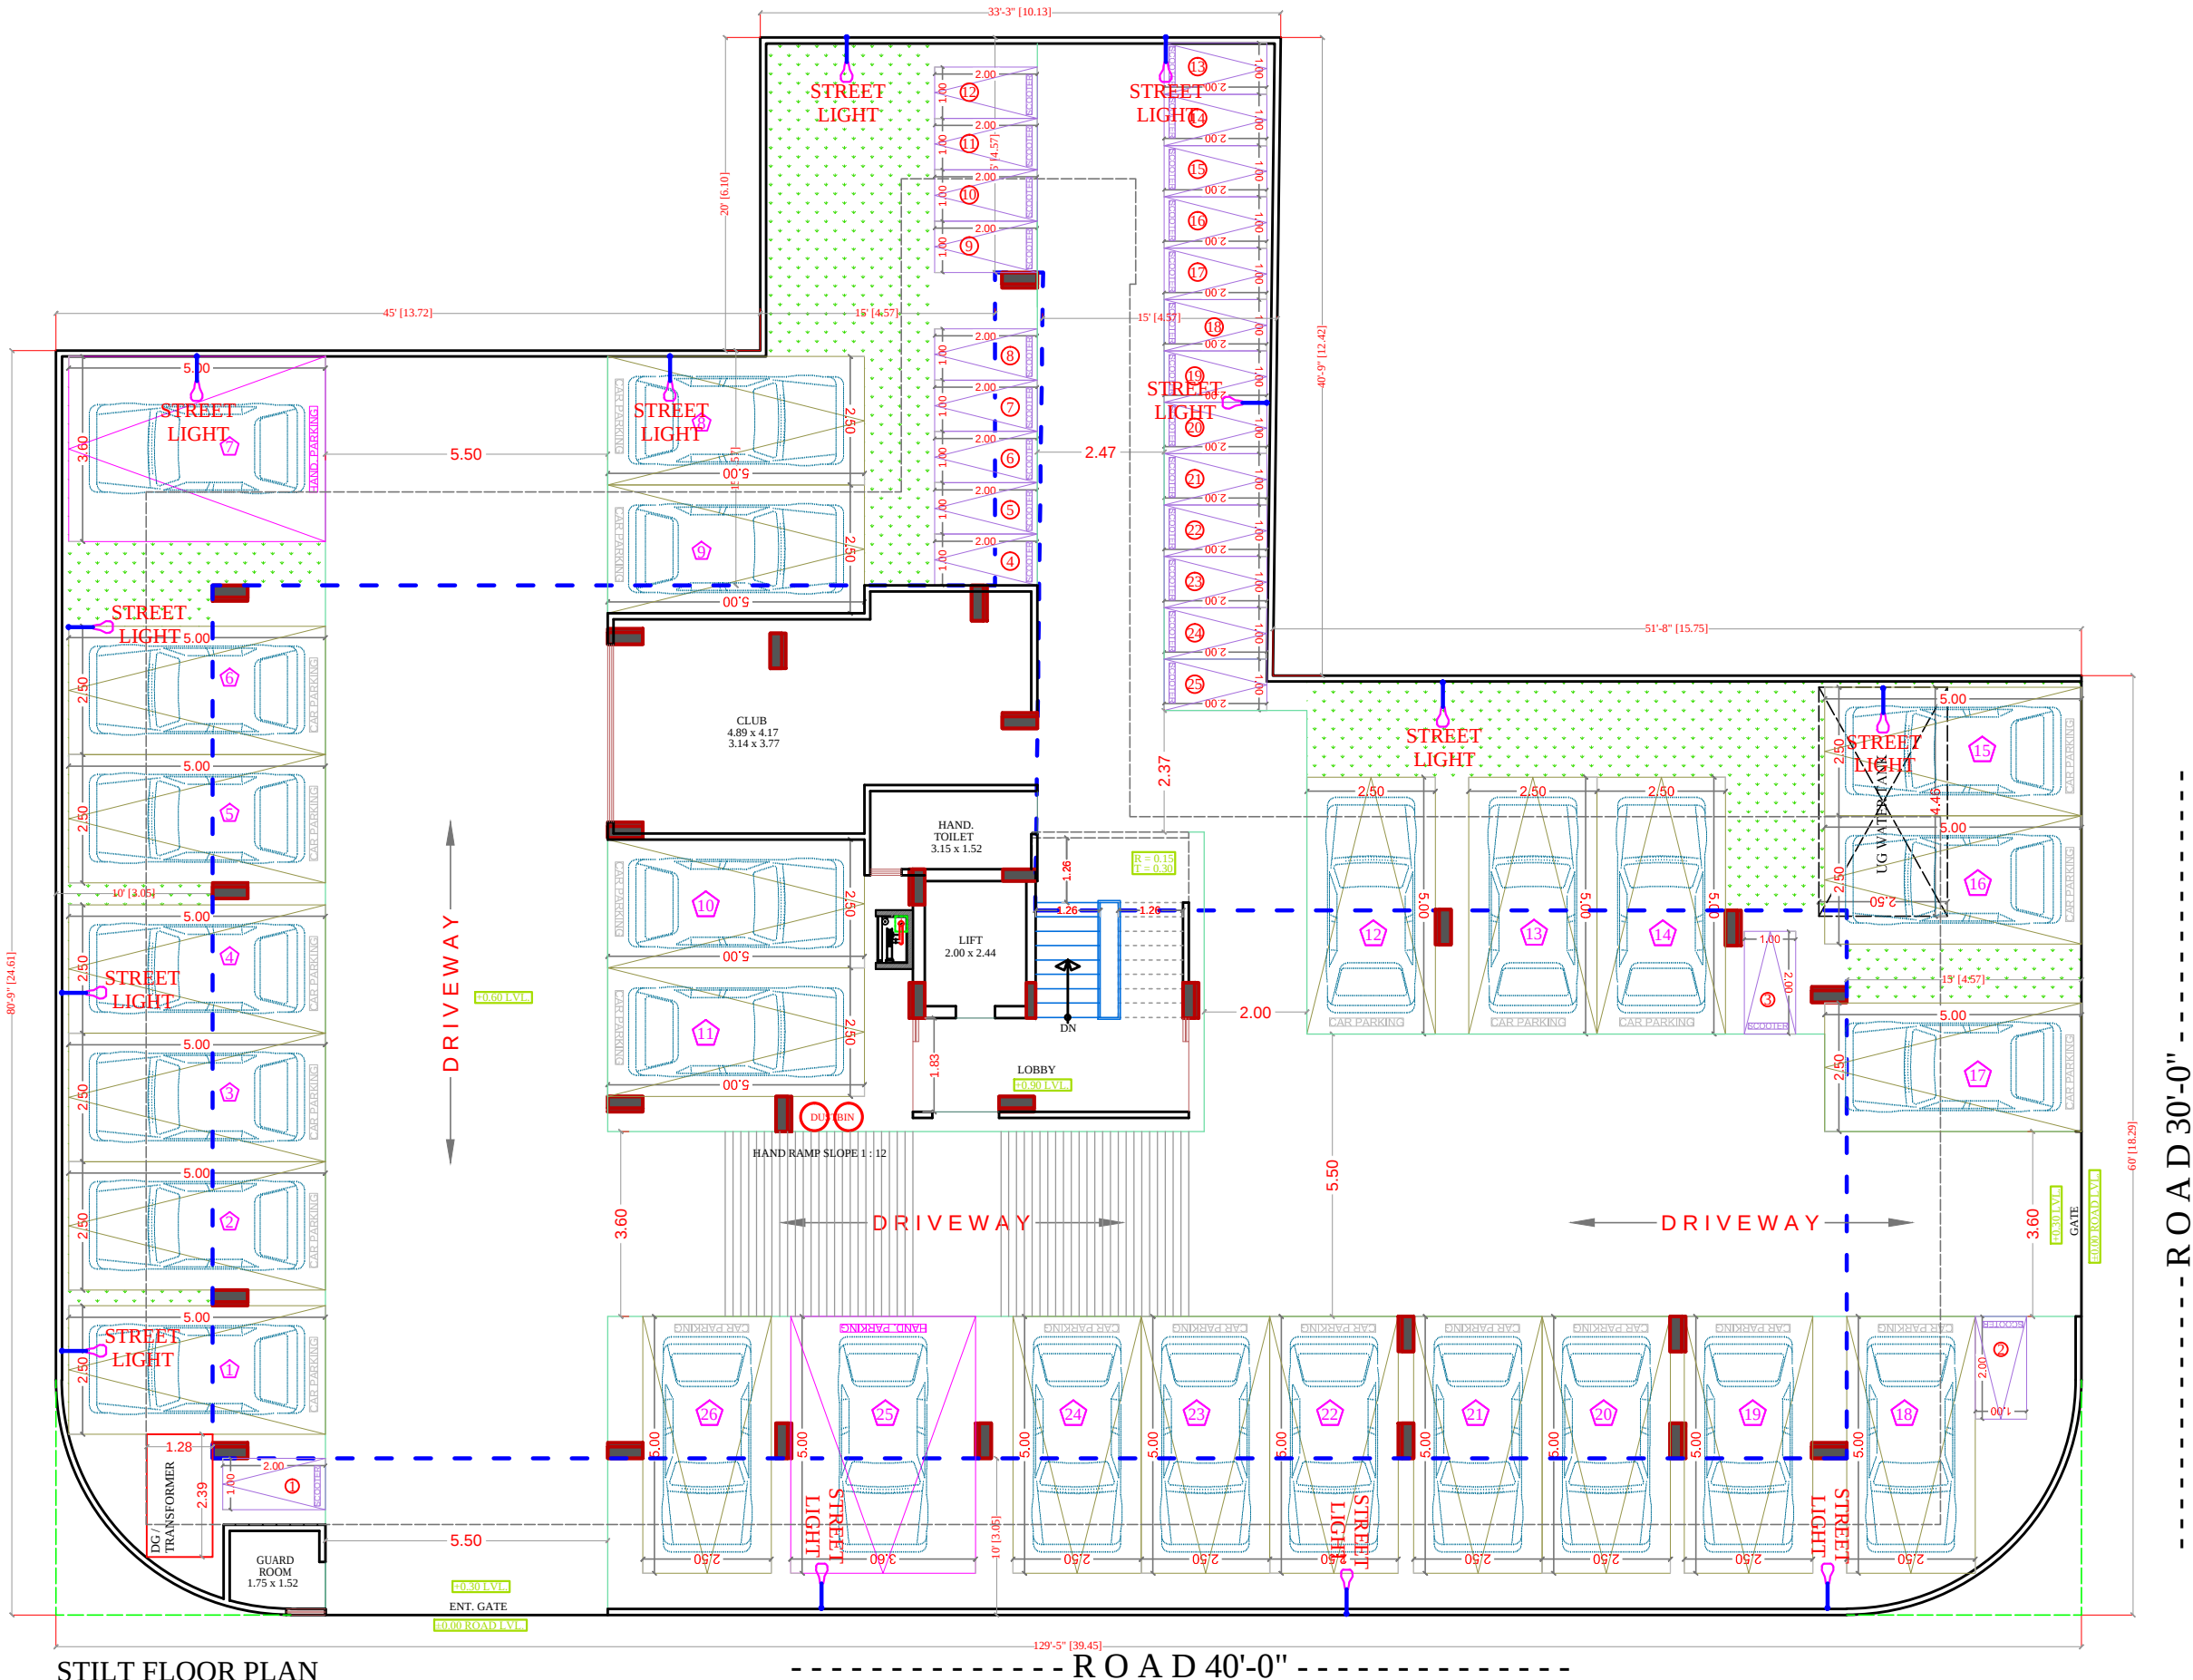

STILT FLOOR PLAN

LEGENDS:

Qty.	I D	Symbol	Description
14	PL		STREET LIGHT

SIGN:-

RAMESH KUMAWAT
M.E.P. CONSULTANT
B.E. CIVIL

SHRI RAM BUILDERS GROUP
Partner

SPACE CONSULTANT

PLOT-A-173, JAGDAMBA NAGAR, HEERAPURA
POWER HOWER, JAIPUR (RAJ) 302024

ARCHITECT :-

FRANK SQUARE
ARCHITECTURE | PLANNER | DESIGNER
C-49 VIDYA APARTMENT PARAS MARG,
BAPU NAGAR JAIPUR, (RAJ.)
Email-afranksquare@gmail.com
Mobile-9461302542

PROJECT :-

PROPOSED BUILDING AT PLOT NO.
PLOT NO-7(SP)8.8-A,8-B NARAYAN
PURI OF HATHROI GADI
GNSS.JAIPUR

BUILDING NAME

ANANDAM HEIGHTS 1V

DEVELOPER NAME

SHRI RAM BUILDERS GROUP

DRAWING: STILT FLOOR


EXTERNAL STREET LIGHT
FOR RERA SUBMISSION PLAN

DATE

SCALE:-

N.T.S.

SCHEMATIC DIAGRAM
LIGHTNING PROTECTION SYSTEM

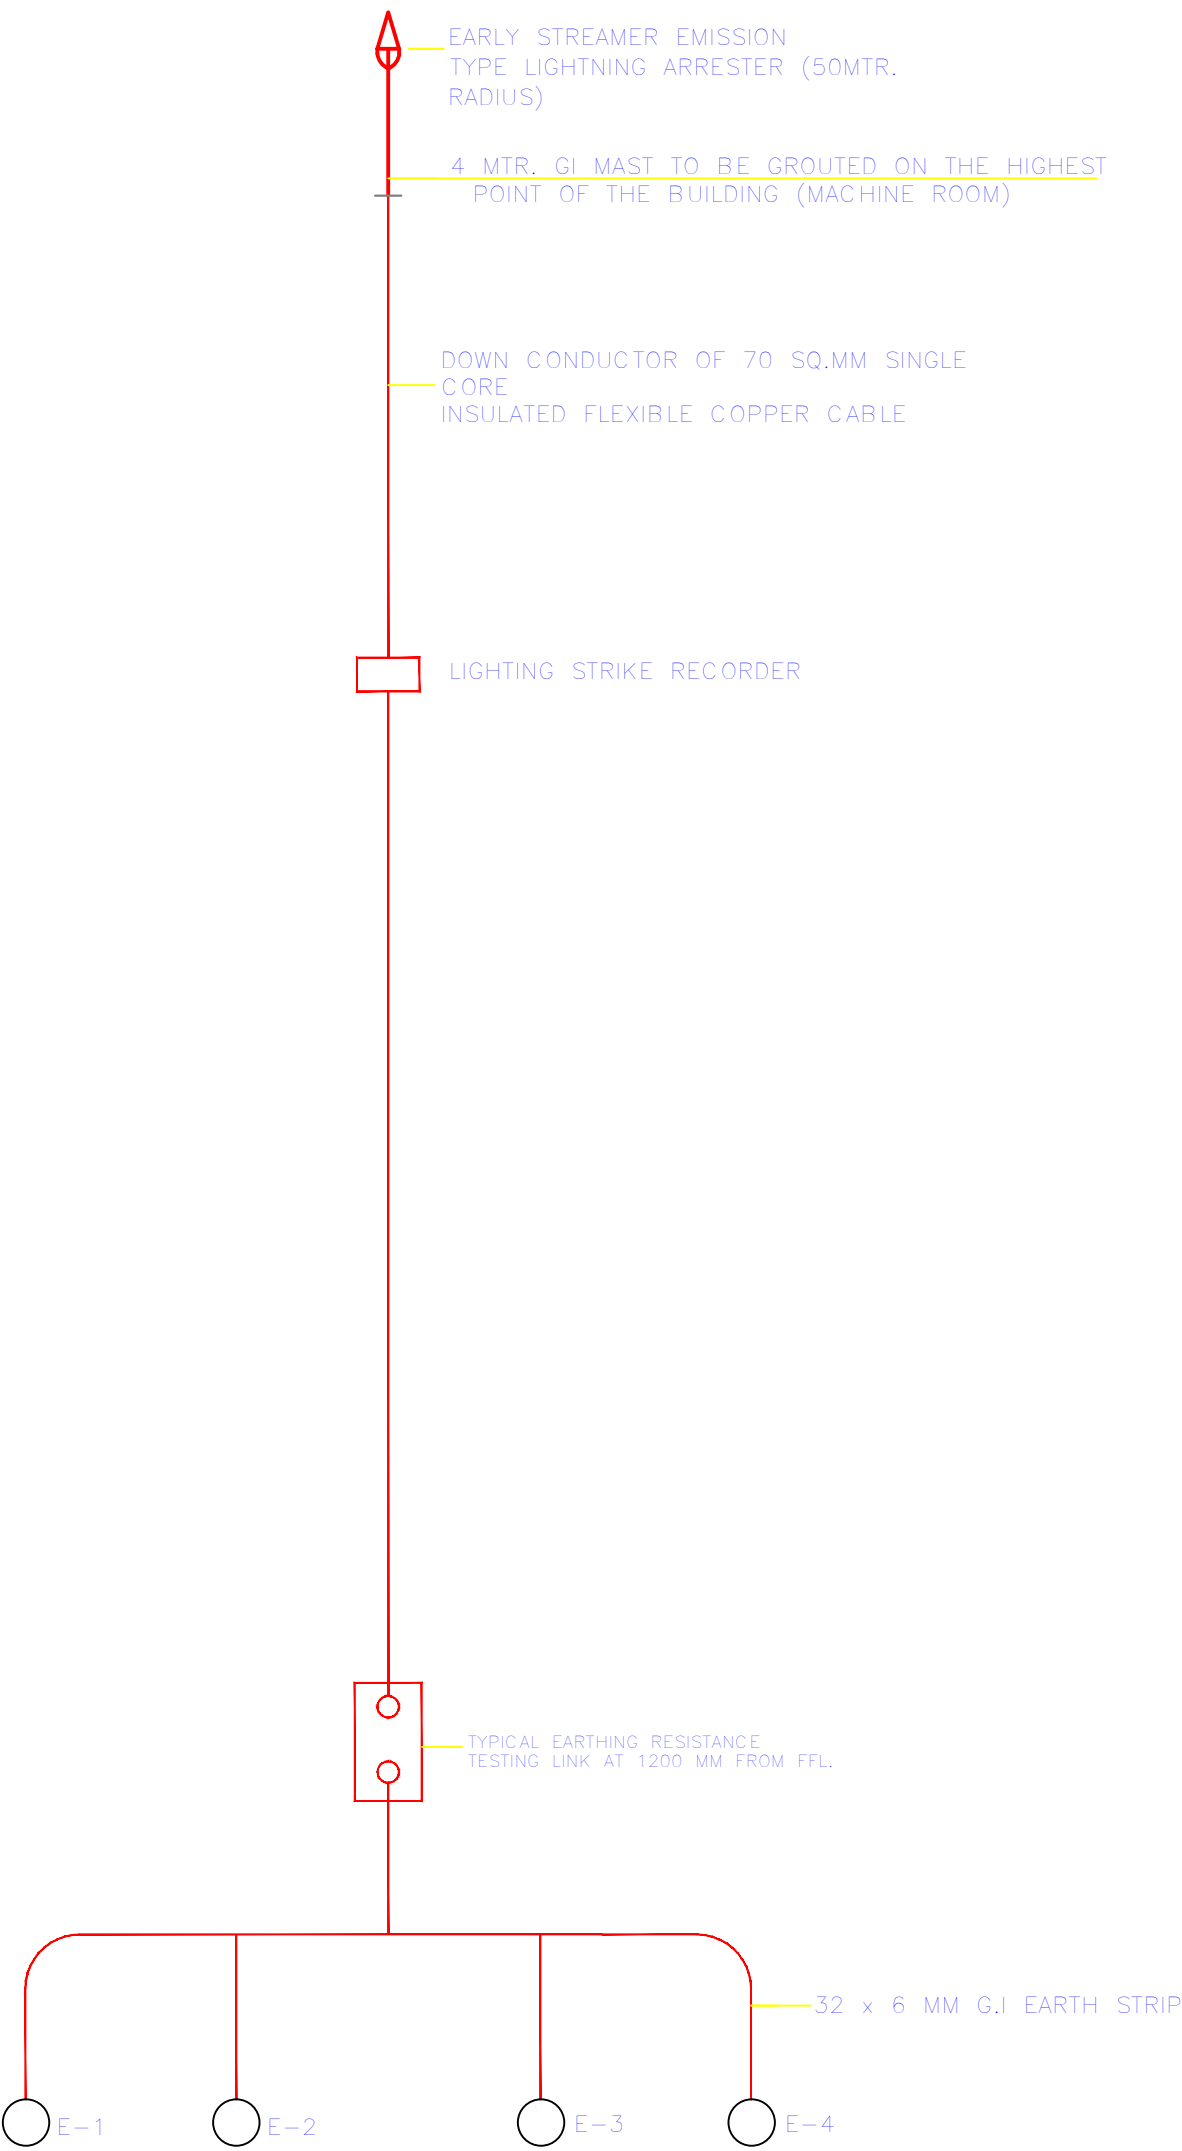


LIGHTENING ARRESTOR SLD

RAMESH KUMAWAT
M.E.P. CONSULTANT
B.E. CIVIL

SHRI RAM BUILDERS GROUP
Partner

PROJECT TITLE :- PROPOSED BUILDING AT PLOT NO. PLOT NO-7(SP)8,8-A,8-B NARAYAN PURI OF HATHROI GADI GNSS.JAIPUR	BUILDING NAME ANANDAM HEIGHTS 1V	DRAWING TITLE :- LIGHTENING ARRESTOR SLD	SPACE CONSULTANT PLOT-A-173, JAGDAMBA NAGAR, HEERAPURA POWER HOWER, JAIPUR (RAJ) 302024	DRN. BY		DATE	NORTH
	DEVELOPER NAME SHRI RAM BUILDERS GROUP			APPD. BY		REVISION	
				SCALE			

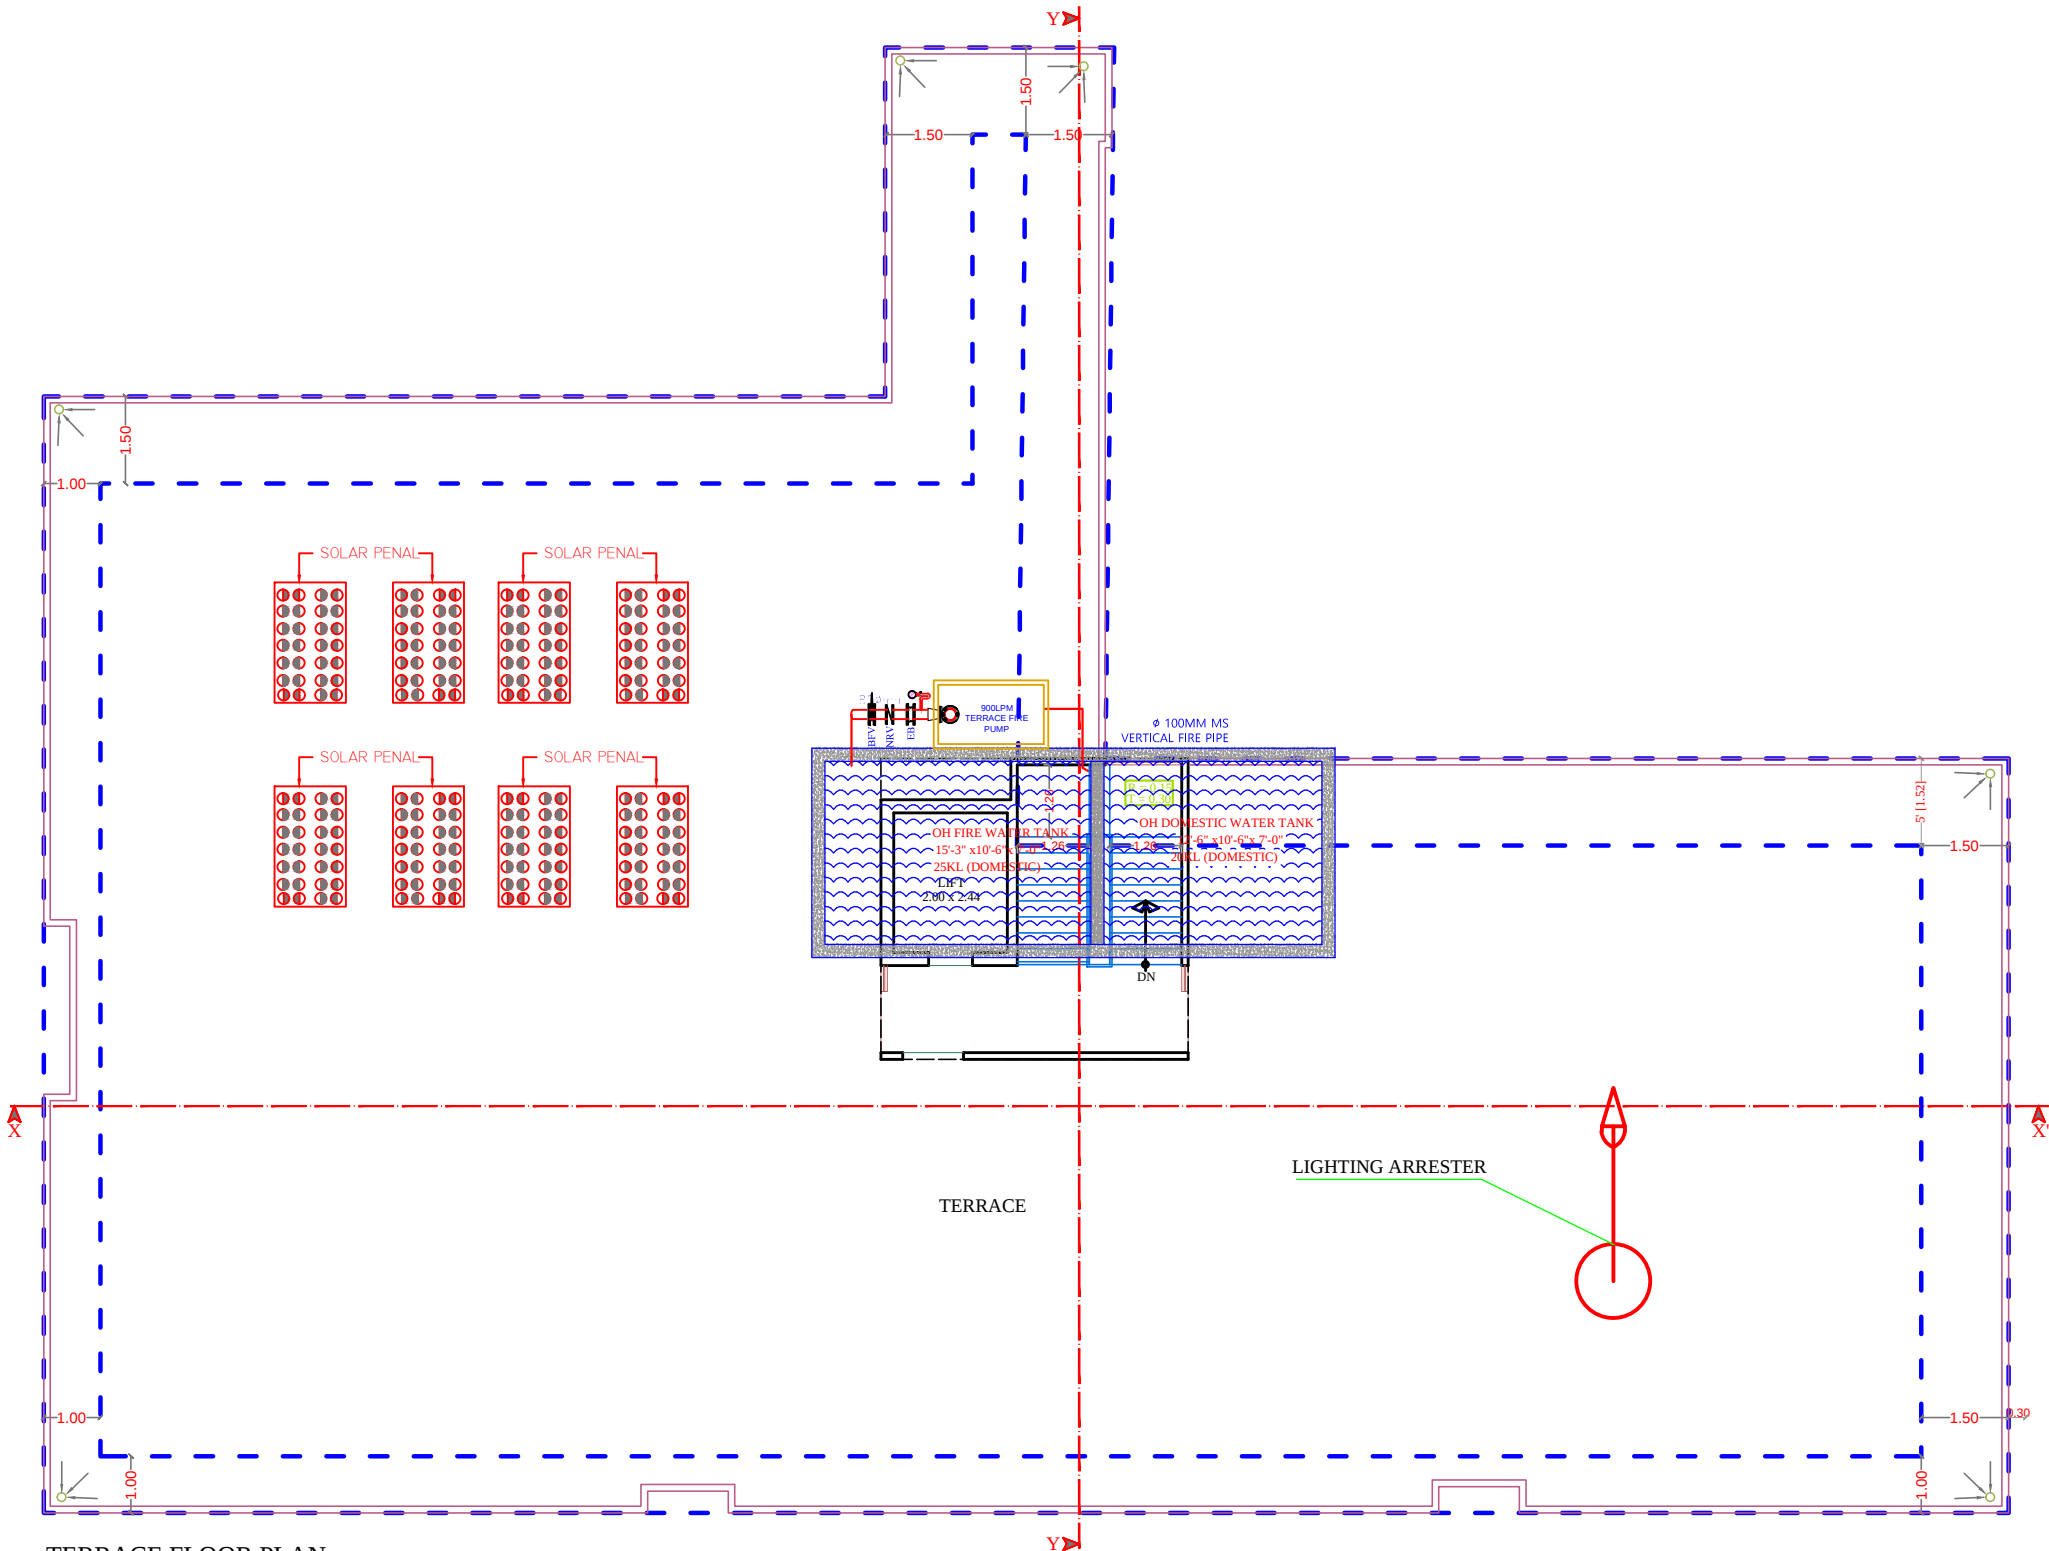

LEGEND		
	Symbole	DESCRIPTION
1.		HOSEREEL
2.		FIRE PIPE
3.		FIRE PIPE
4.		FIRE EXTINGUISHER
5.		EXTERNAL YARD HYDRANT

RAMESH KUMAWAT
M.E.P. CONSULTANT
B.E. CIVIL

SHRI RAM BUILDERS GROUP
Partner

PROJECT TITLE :- PROPOSED BUILDING AT PLOT NO. PLOT NO-7(SP)8,8-A,8-B NARAYAN PURI OF HATHROI GADI GNSS.JAIPUR	BUILDING NAME ANANDAM HEIGHTS 1V	DRAWING TITLE :- TARRACE FLOOR LIGHTING ARRESTER LOCATION	SPACE CONSULTANT PLOT-A-173, JAGDAMBA NAGAR, HEERAPURA POWER HOWER, JAIPUR (RAJ) 302024	DRN. BY		DATE	NORTH
	DEVELOPER NAME SHRI RAM BUILDERS GROUP			APPD. BY	REVISION		
				SCALE			

