
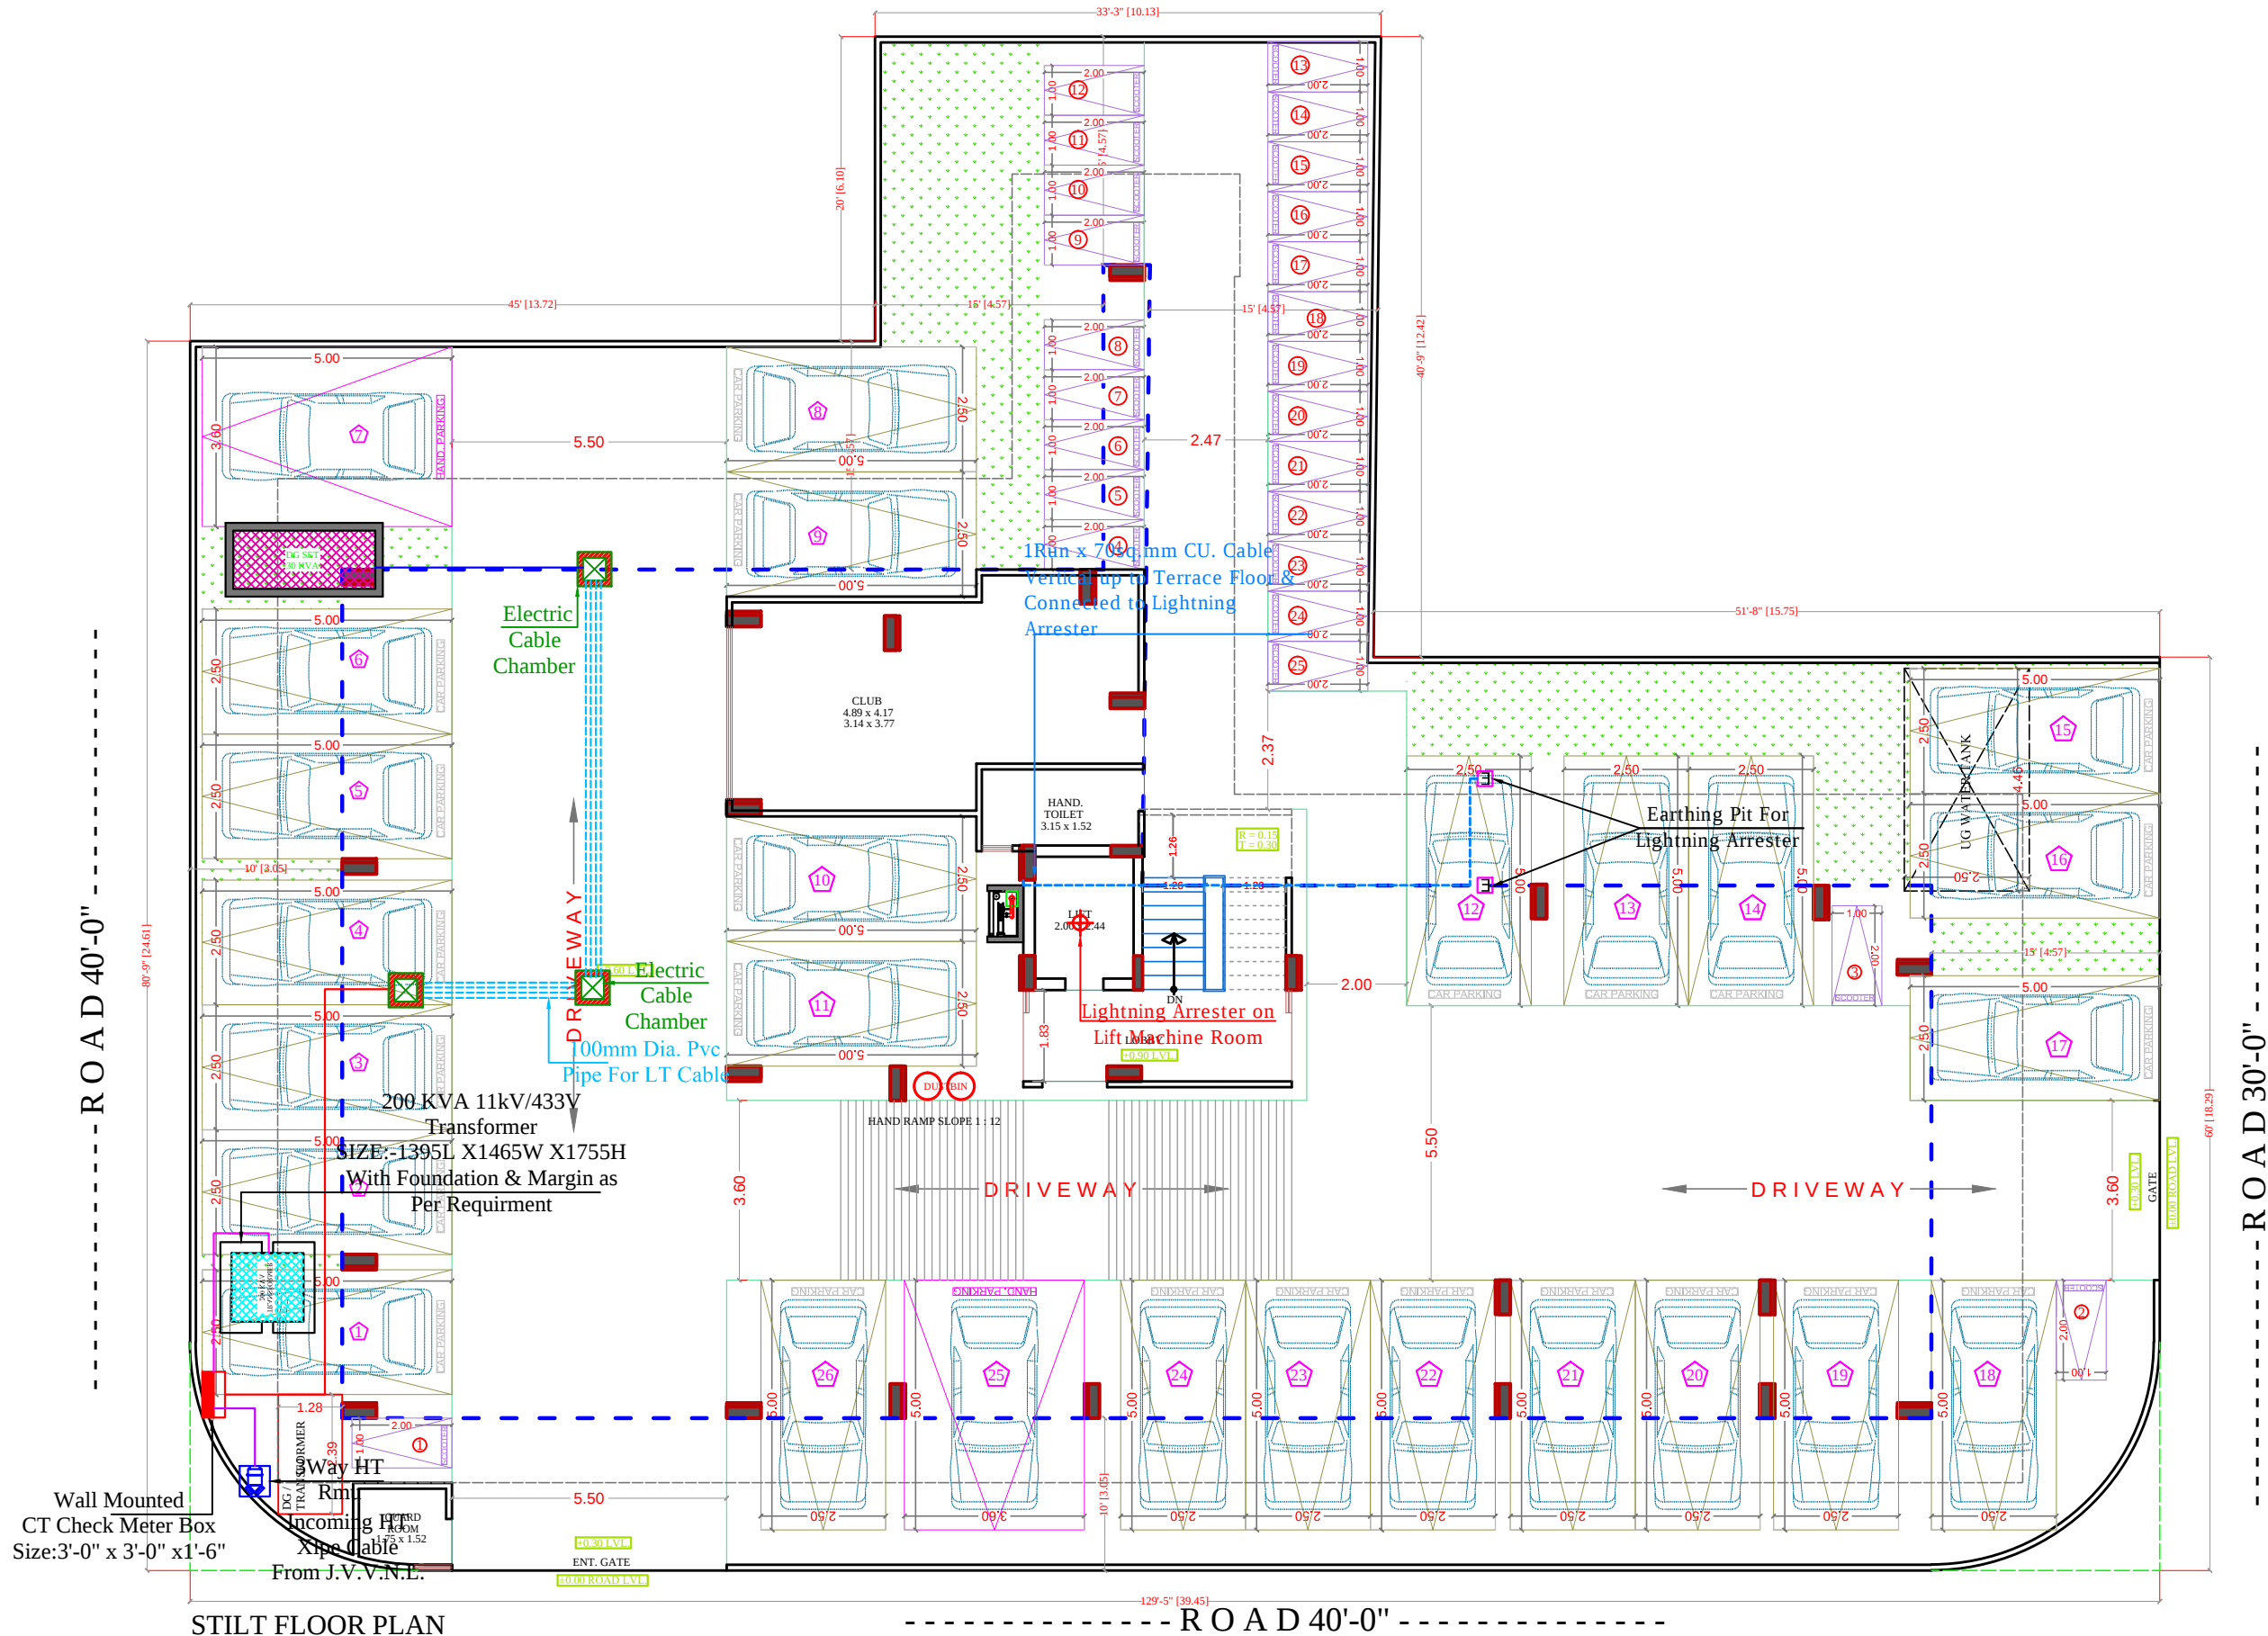


Model: Stormaster – ESE
- 30 (Level 2/Medium
Protection)
(Protection radius - 25M,
Mast Height -2 Mtr)

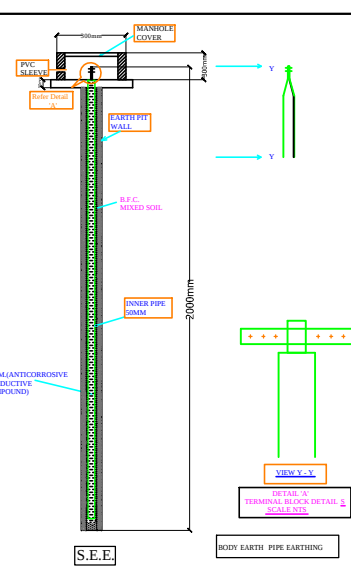

SIGN:-
SEAL:-
RAMESH KUMAR
M.E.P. CONSULTANT
B.E. CIVIL
SHRI RAM BUILDERS GROUP
Partner

SPACE CONSULTANT

PLOT-A-173, JAGDAMBA NAGAR, HEERAPURA
POWER HOWER, JAIPUR (RAJ.) 302024

ARCHITECT :-

FRANK SQUARE
ARCHITECTURE | PLANNER | DESIGNER
C-49 VIDYA APARTMENT PARAS MARG,
BAPU NAGAR JAIPUR, (RAJ.)
Email-afranksquare@gmail.com
Mobile-9461302542


PROJECT :-
PROPOSED BUILDING AT PLOT NO.
PLOT NO-7(SP)8,8-A,8-B NARAYAN
PURI OF HATHROI GADI
GNSS,JAIPUR

BUILDING NAME
ANANDAM HEIGHTS 1V

DEVELOPER NAME
SHRI RAM BUILDERS GROUP

DRAWING:
STILT FLOOR
ELECTRIC SUB STATION,
CABLE ROUTE &
LIGHTNING ARRESTER FOR
RERA SUBMISSION PLAN

DATE
SCALE:- N.T.S.

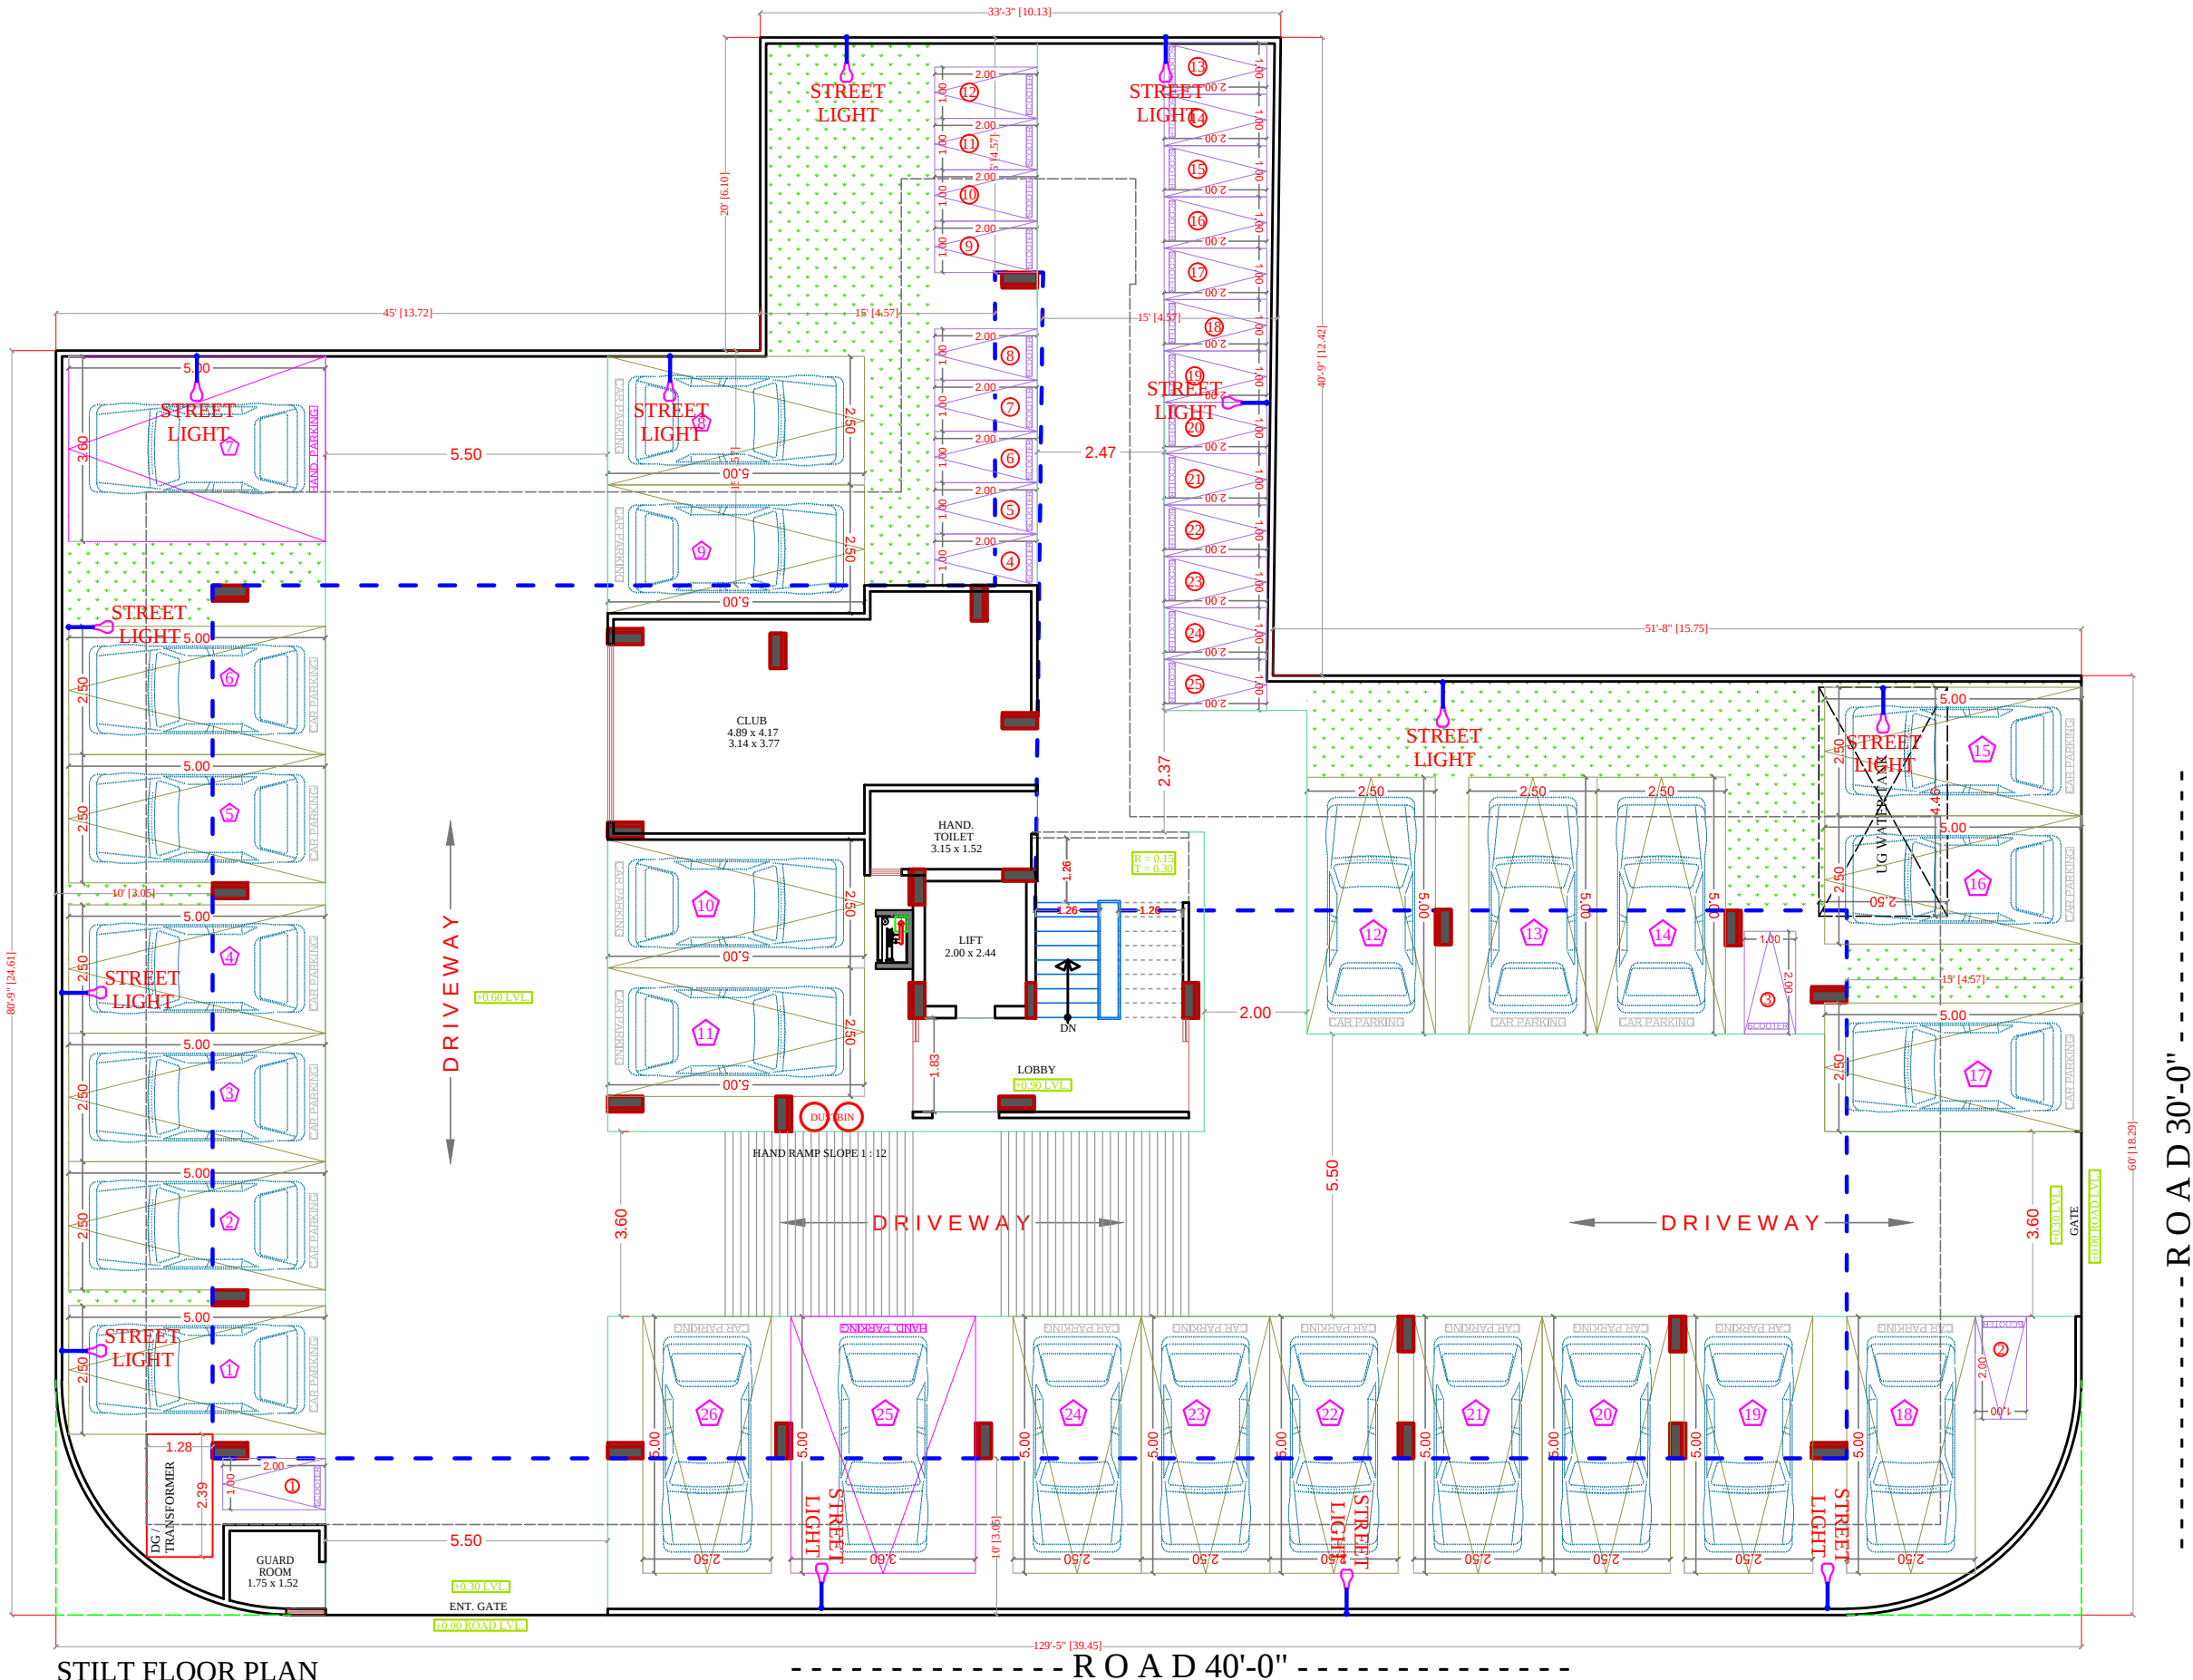

STILT FLOOR PLAN

LEGENDS:

Qty.	I D	Symbol	Description
14	PL		STREET LIGHT

SIGN:-

RAMESH KUMAWAT
M.E.P. CONSULTANT
B.E. CIVIL

SHRI RAM BUILDERS GROUP
Partner

SPACE CONSULTANT

PLOT-A-173, JAGDAMBA NAGAR, HEERAPURA
POWER HOWER, JAIPUR (RAJ) 302024

ARCHITECT :-

FRANK SQUARE
ARCHITECTURE | PLANNER | DESIGNER
C-49 VIDYA APARTMENT PARAS MARG,
BAPU NAGAR JAIPUR, (RAJ.)
Email-afranksquare@gmail.com
Mobile-9461302542


PROJECT :-
PROPOSED BUILDING AT PLOT NO.
PLOT NO-7(SP)8.8-A,8-B NARAYAN
PURI OF HATHROI GADI
GNSS.JAIPUR

BUILDING NAME
ANANDAM HEIGHTS 1V

DEVELOPER NAME
SHRI RAM BUILDERS GROUP

DRAWING: STILT FLOOR
EXTERNAL STREET LIGHT
FOR RERA SUBMISSION PLAN

DATE
SCALE:- N.T.S.

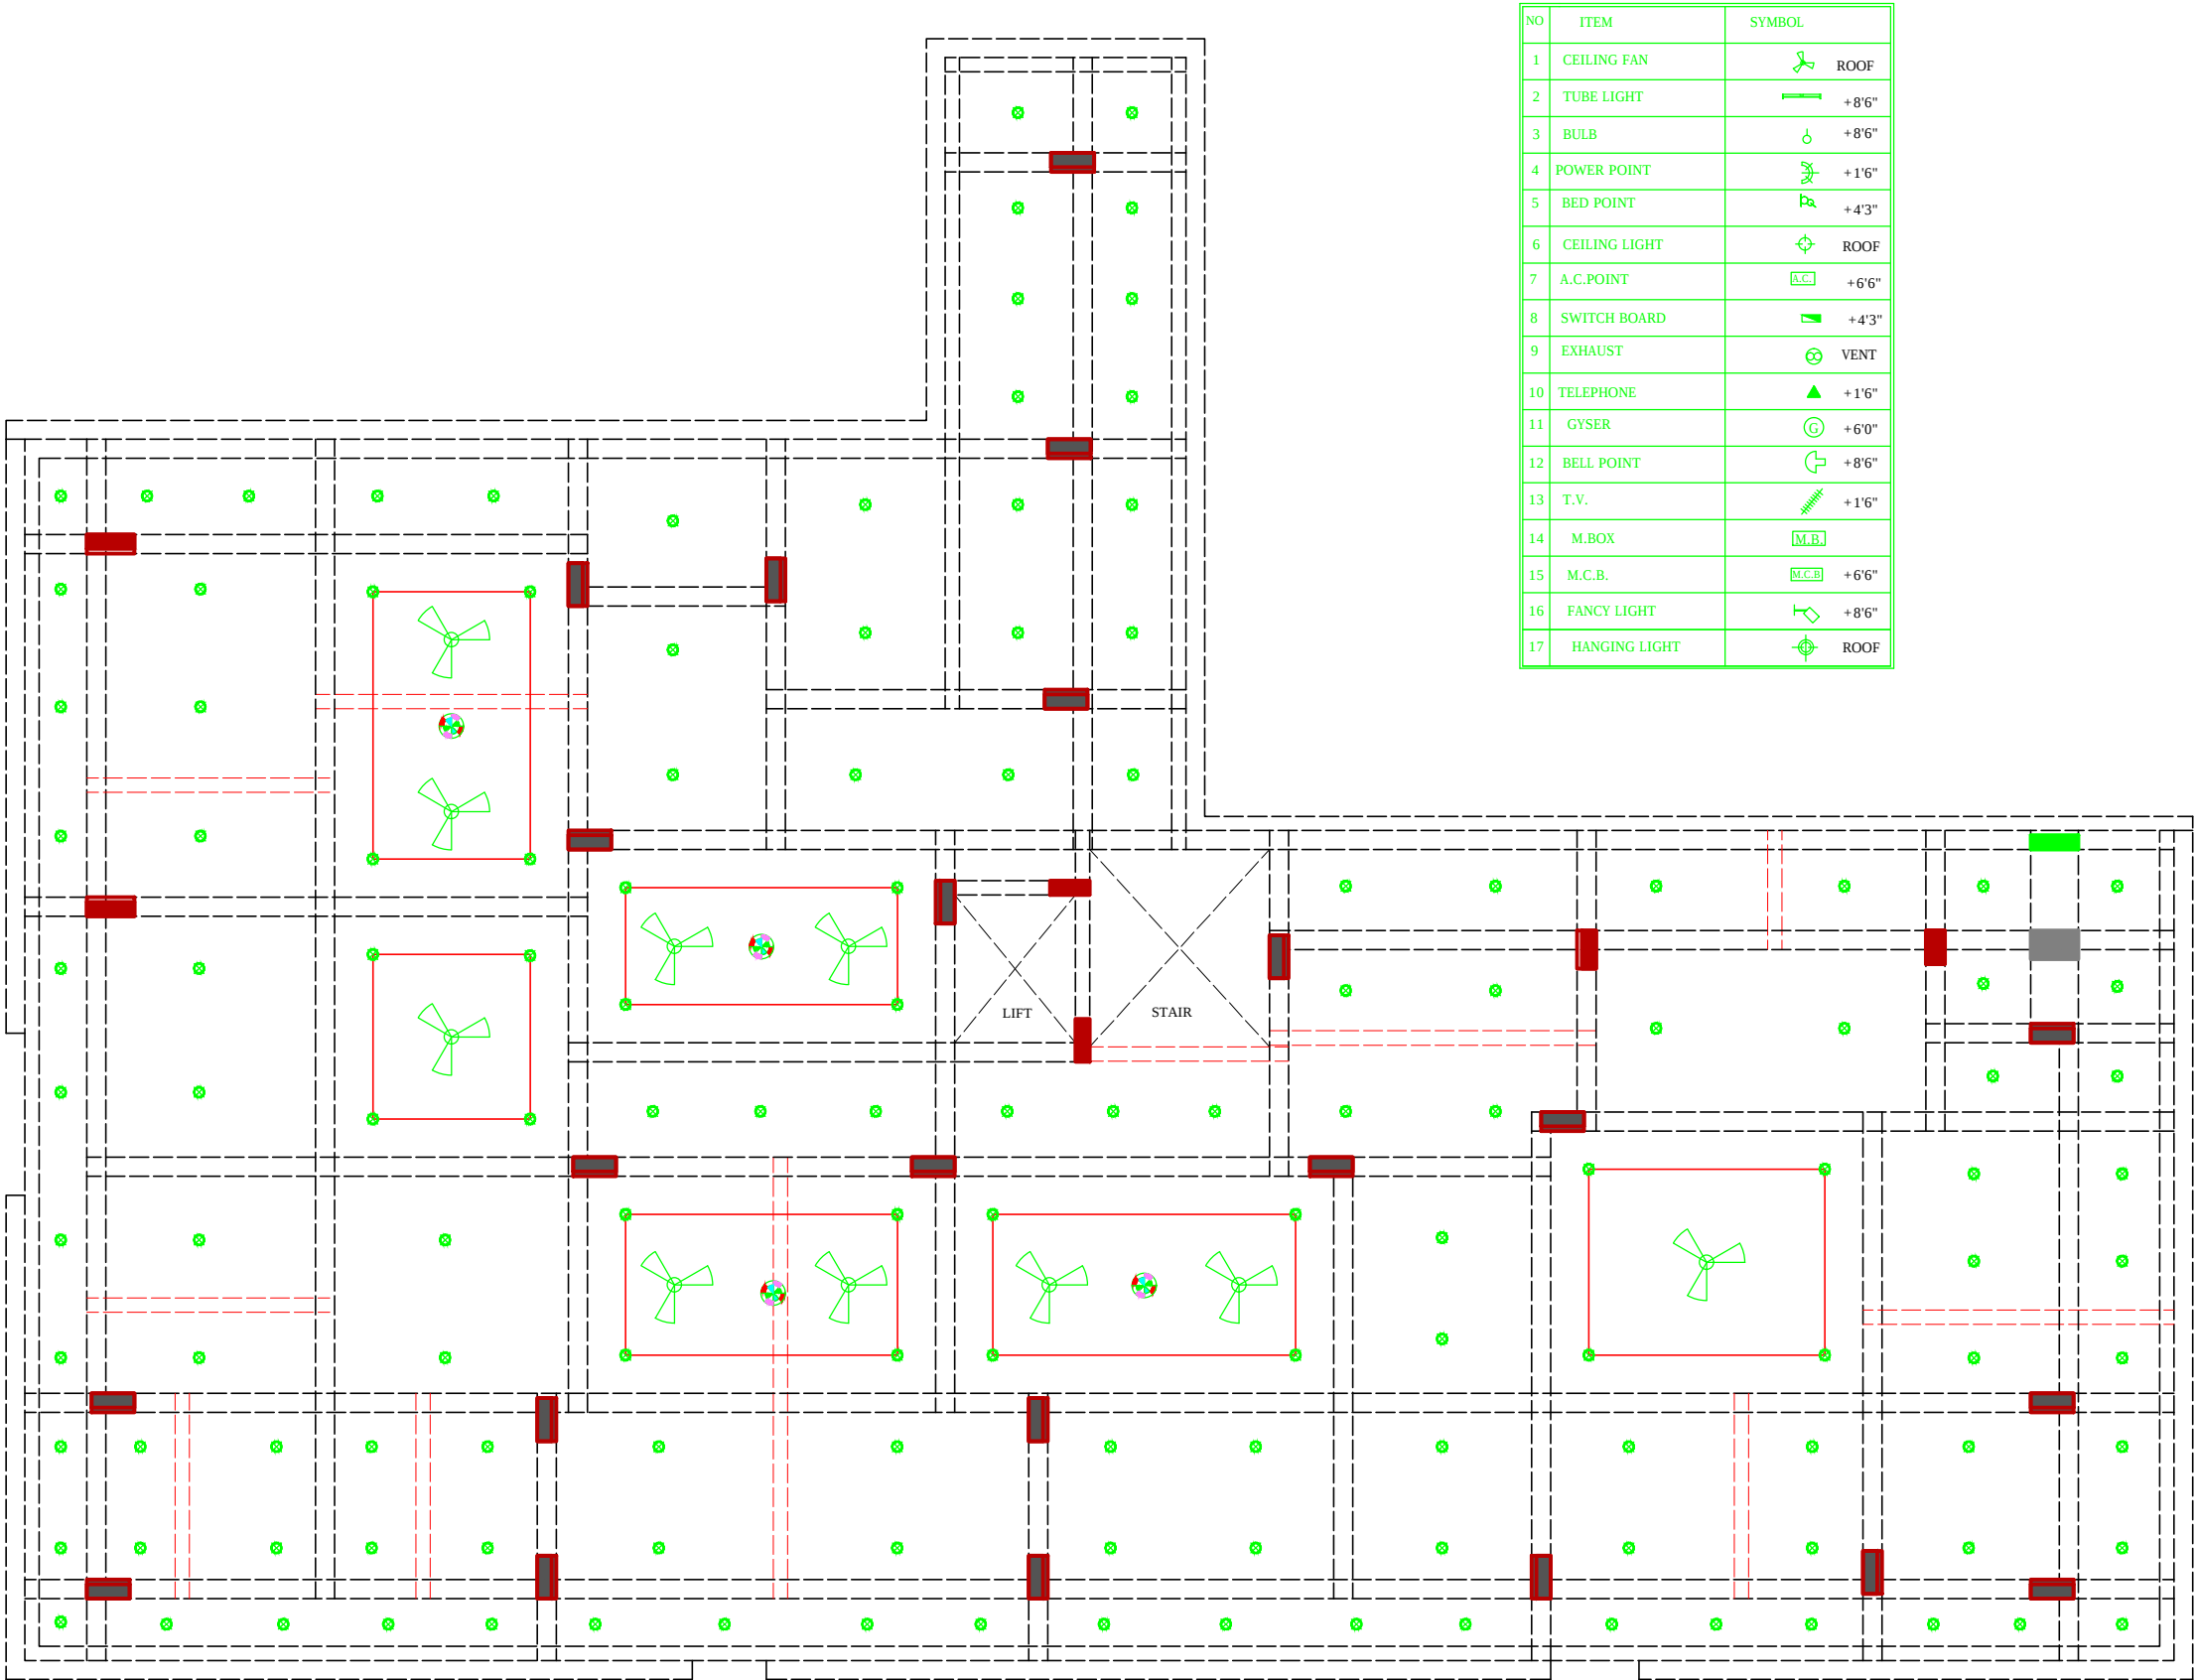

NO	ITEM	SYMBOL
1	CEILING FAN	ROOF
2	TUBE LIGHT	+8'6"
3	BULB	+8'6"
4	POWER POINT	+1'6"
5	BED POINT	+4'3"
6	CEILING LIGHT	ROOF
7	A.C.POINT	+6'6"
8	SWITCH BOARD	+4'3"
9	EXHAUST	VENT
10	TELEPHONE	+1'6"
11	GYSER	+6'0"
12	BELL POINT	+8'6"
13	T.V.	+1'6"
14	M.BOX	
15	M.C.B.	+6'6"
16	FANCY LIGHT	+8'6"
17	HANGING LIGHT	ROOF

RAMESH KUMAWAT
M.E.P. CONSULTANT
B.E. CIVIL

SHRI RAM BUILDERS GROUP
Partner

PROJECT TITLE :- PROPOSED BUILDING AT PLOT NO. PLOT NO-7(SP)8,8-A,8-B NARAYAN PURI OF HATHROI GADI GNSS.JAIPUR	BUILDING NAME ANANDAM HEIGHTS 1V	DRAWING TITLE :- STILT FLOOR ELECTRIC PLAN	SPACE CONSULTANT PLOT-A-173, JAGDAMBA NAGAR, HEERAPURA POWER HOWER, JAIPUR (RAJ) 302024	DRN. BY		DATE	NORTH
	DEVELOPER NAME SHRI RAM BUILDERS GROUP			APPD. BY		REVISION	
				SCALE			

