
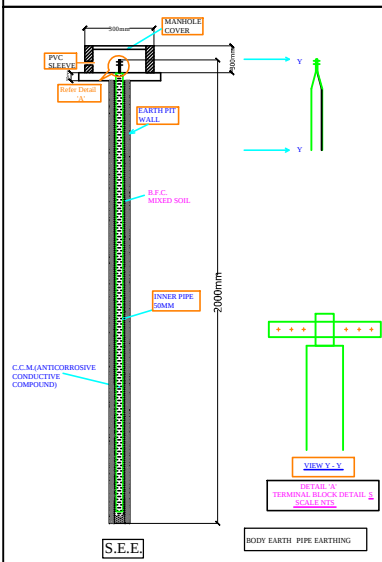
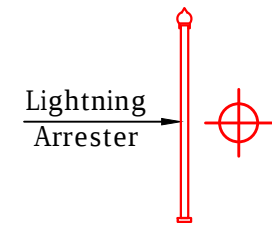


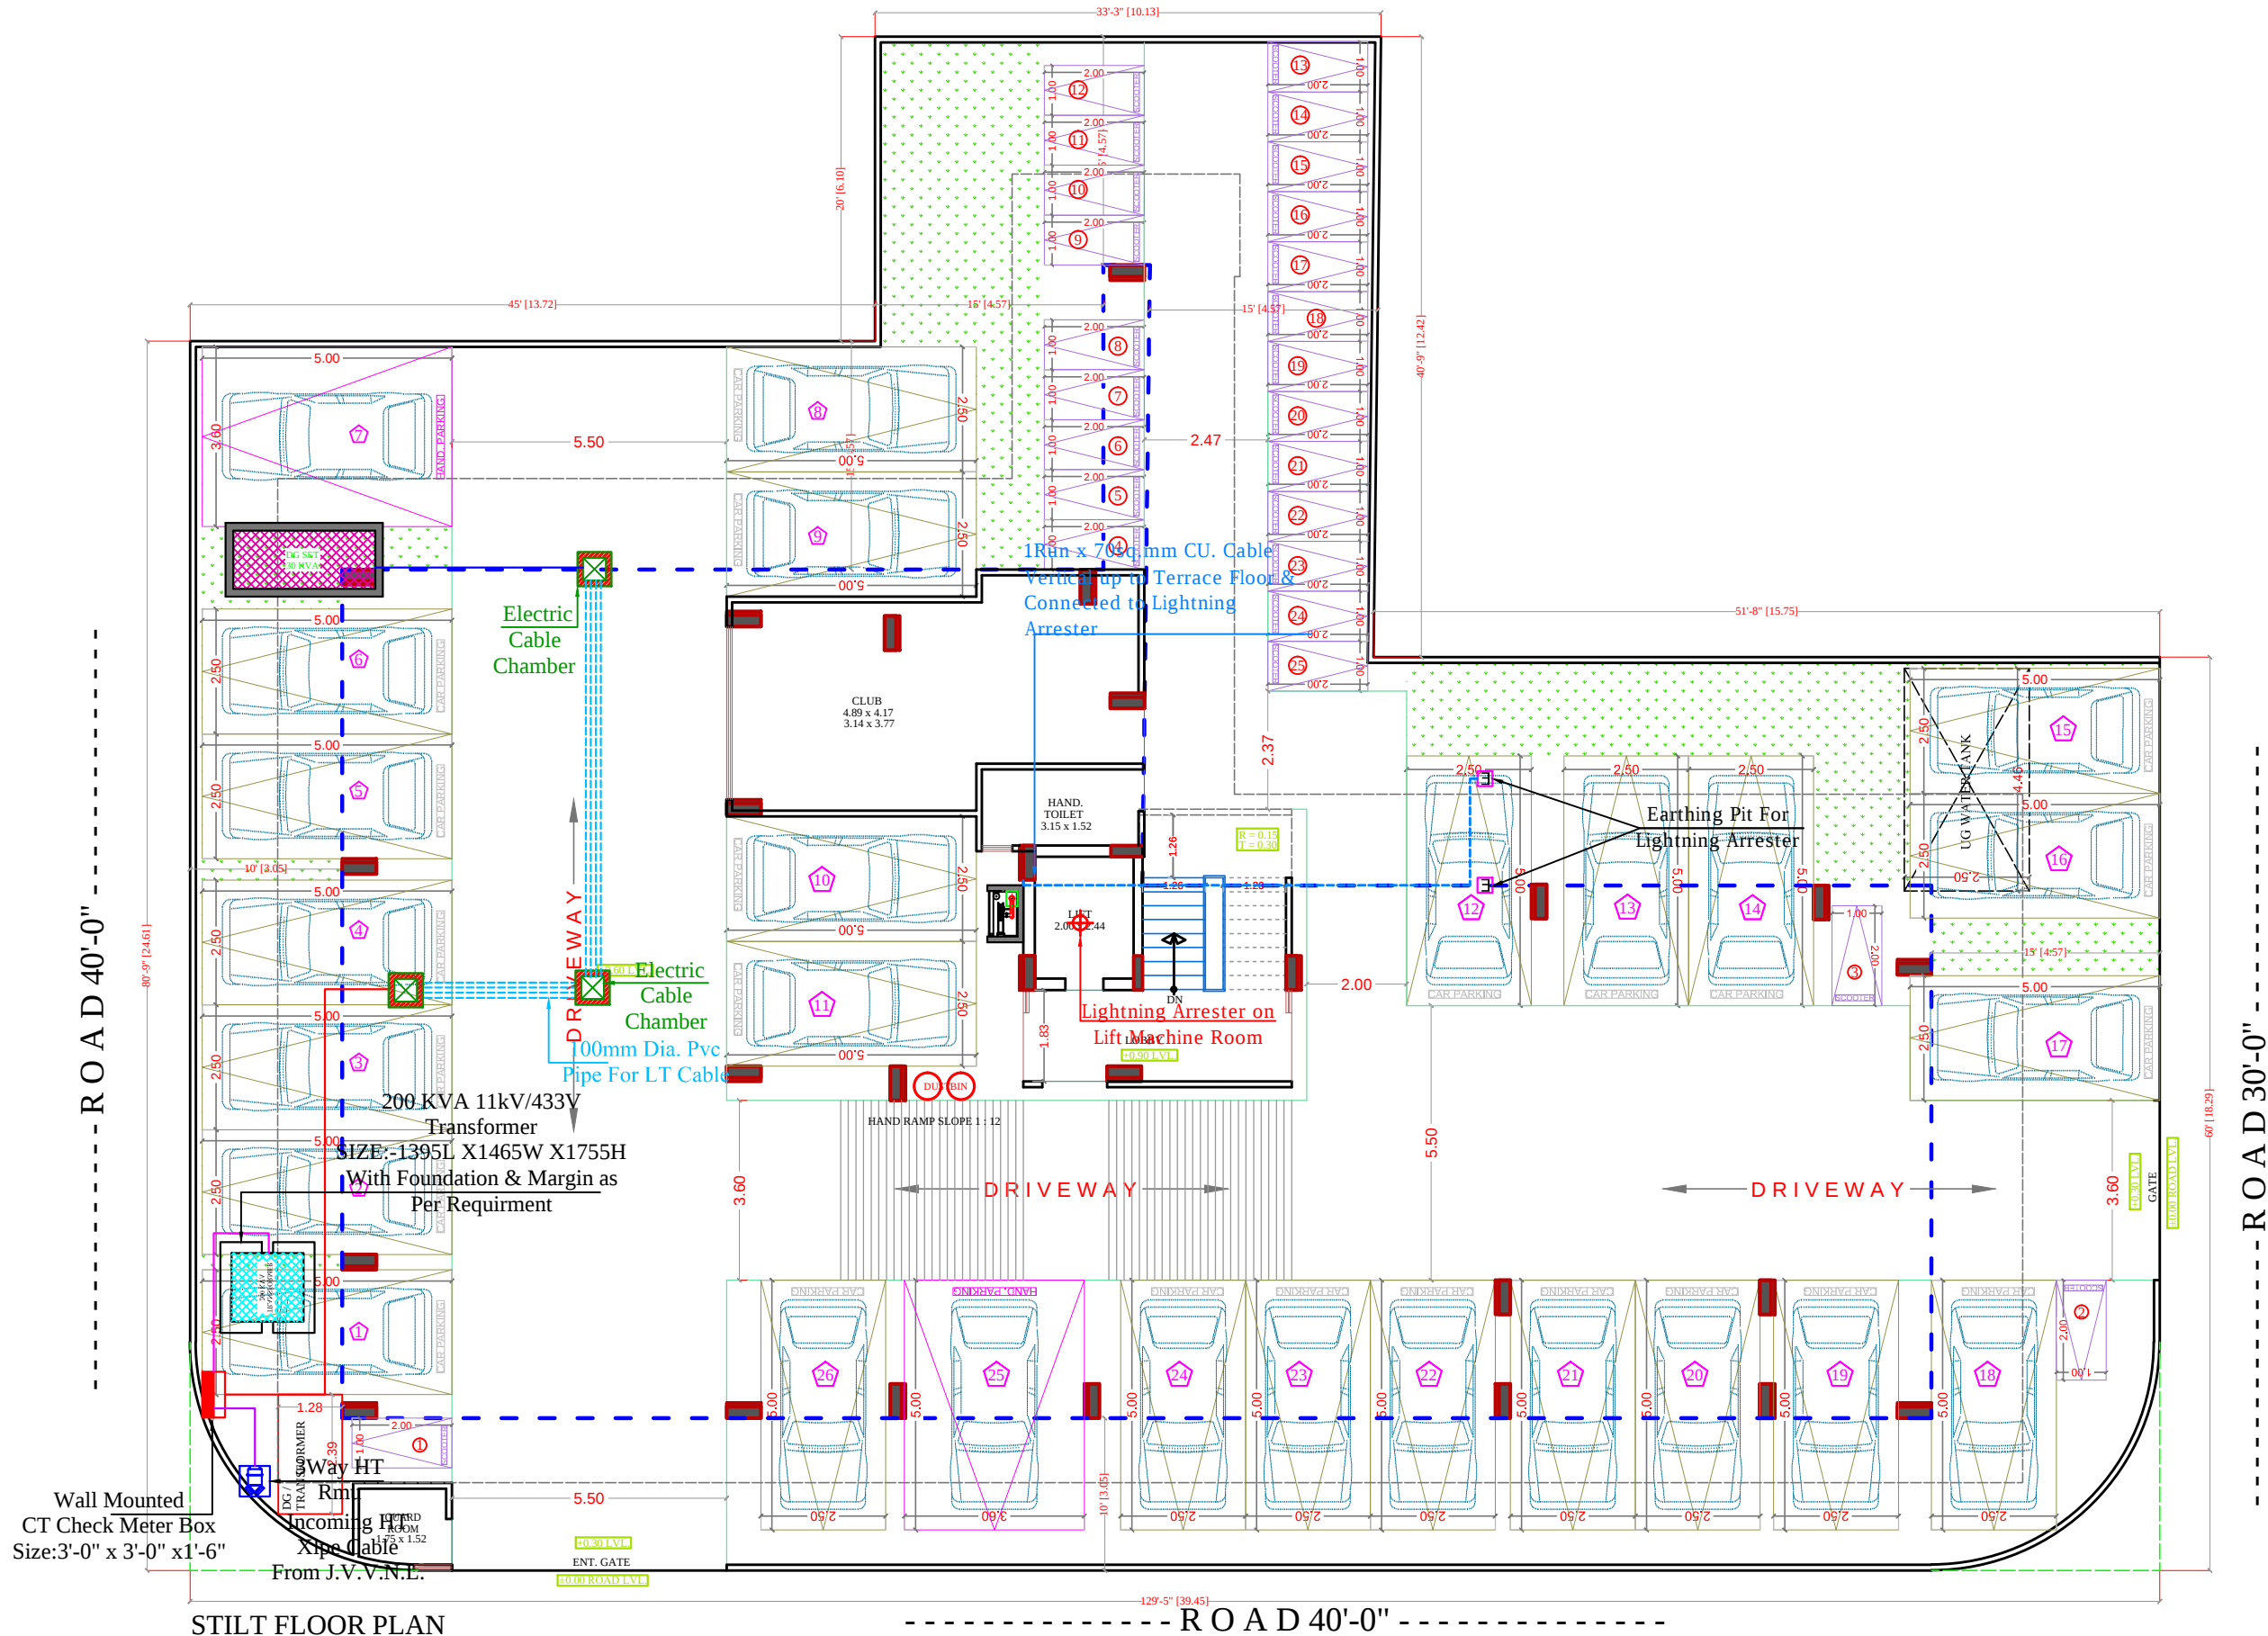

SIGN:-
RAMESH KUMAWAT
M.E.P. CONSULTANT
B.E. CIVIL

SEAL:-
SHRI RAM BUILDERS GROUP
Partner

SPACE CONSULTANT
PLOT-A-173, JAGDAMBA NAGAR, HEERAPURA
POWER HOWER, JAIPUR (RAJ.) 302024

ARCHITECT :-
FRANK SQUARE
ARCHITECTURE | PLANNER | DESIGNER
C-49 VIDYA APARTMENT PARAS MARG,
BAPU NAGAR JAIPUR, (RAJ.)
Email-afranksquare@gmail.com
Mobile-9461302542


PROJECT :-
PROPOSED BUILDING AT PLOT NO.
PLOT NO-7(SP)8,8-A,8-B NARAYAN
PURI OF HATHROI GADI
GNSS.JAIPUR

BUILDING NAME
ANANDAM HEIGHTS 1V

DEVELOPER NAME
SHRI RAM BUILDERS GROUP

DRAWING:
STILT FLOOR
ELECTRIC SUB STATION,
CABLE ROUTE &
LIGHTNING ARRESTER FOR
RERA SUBMISSION PLAN

DATE
SCALE:- N.T.S.

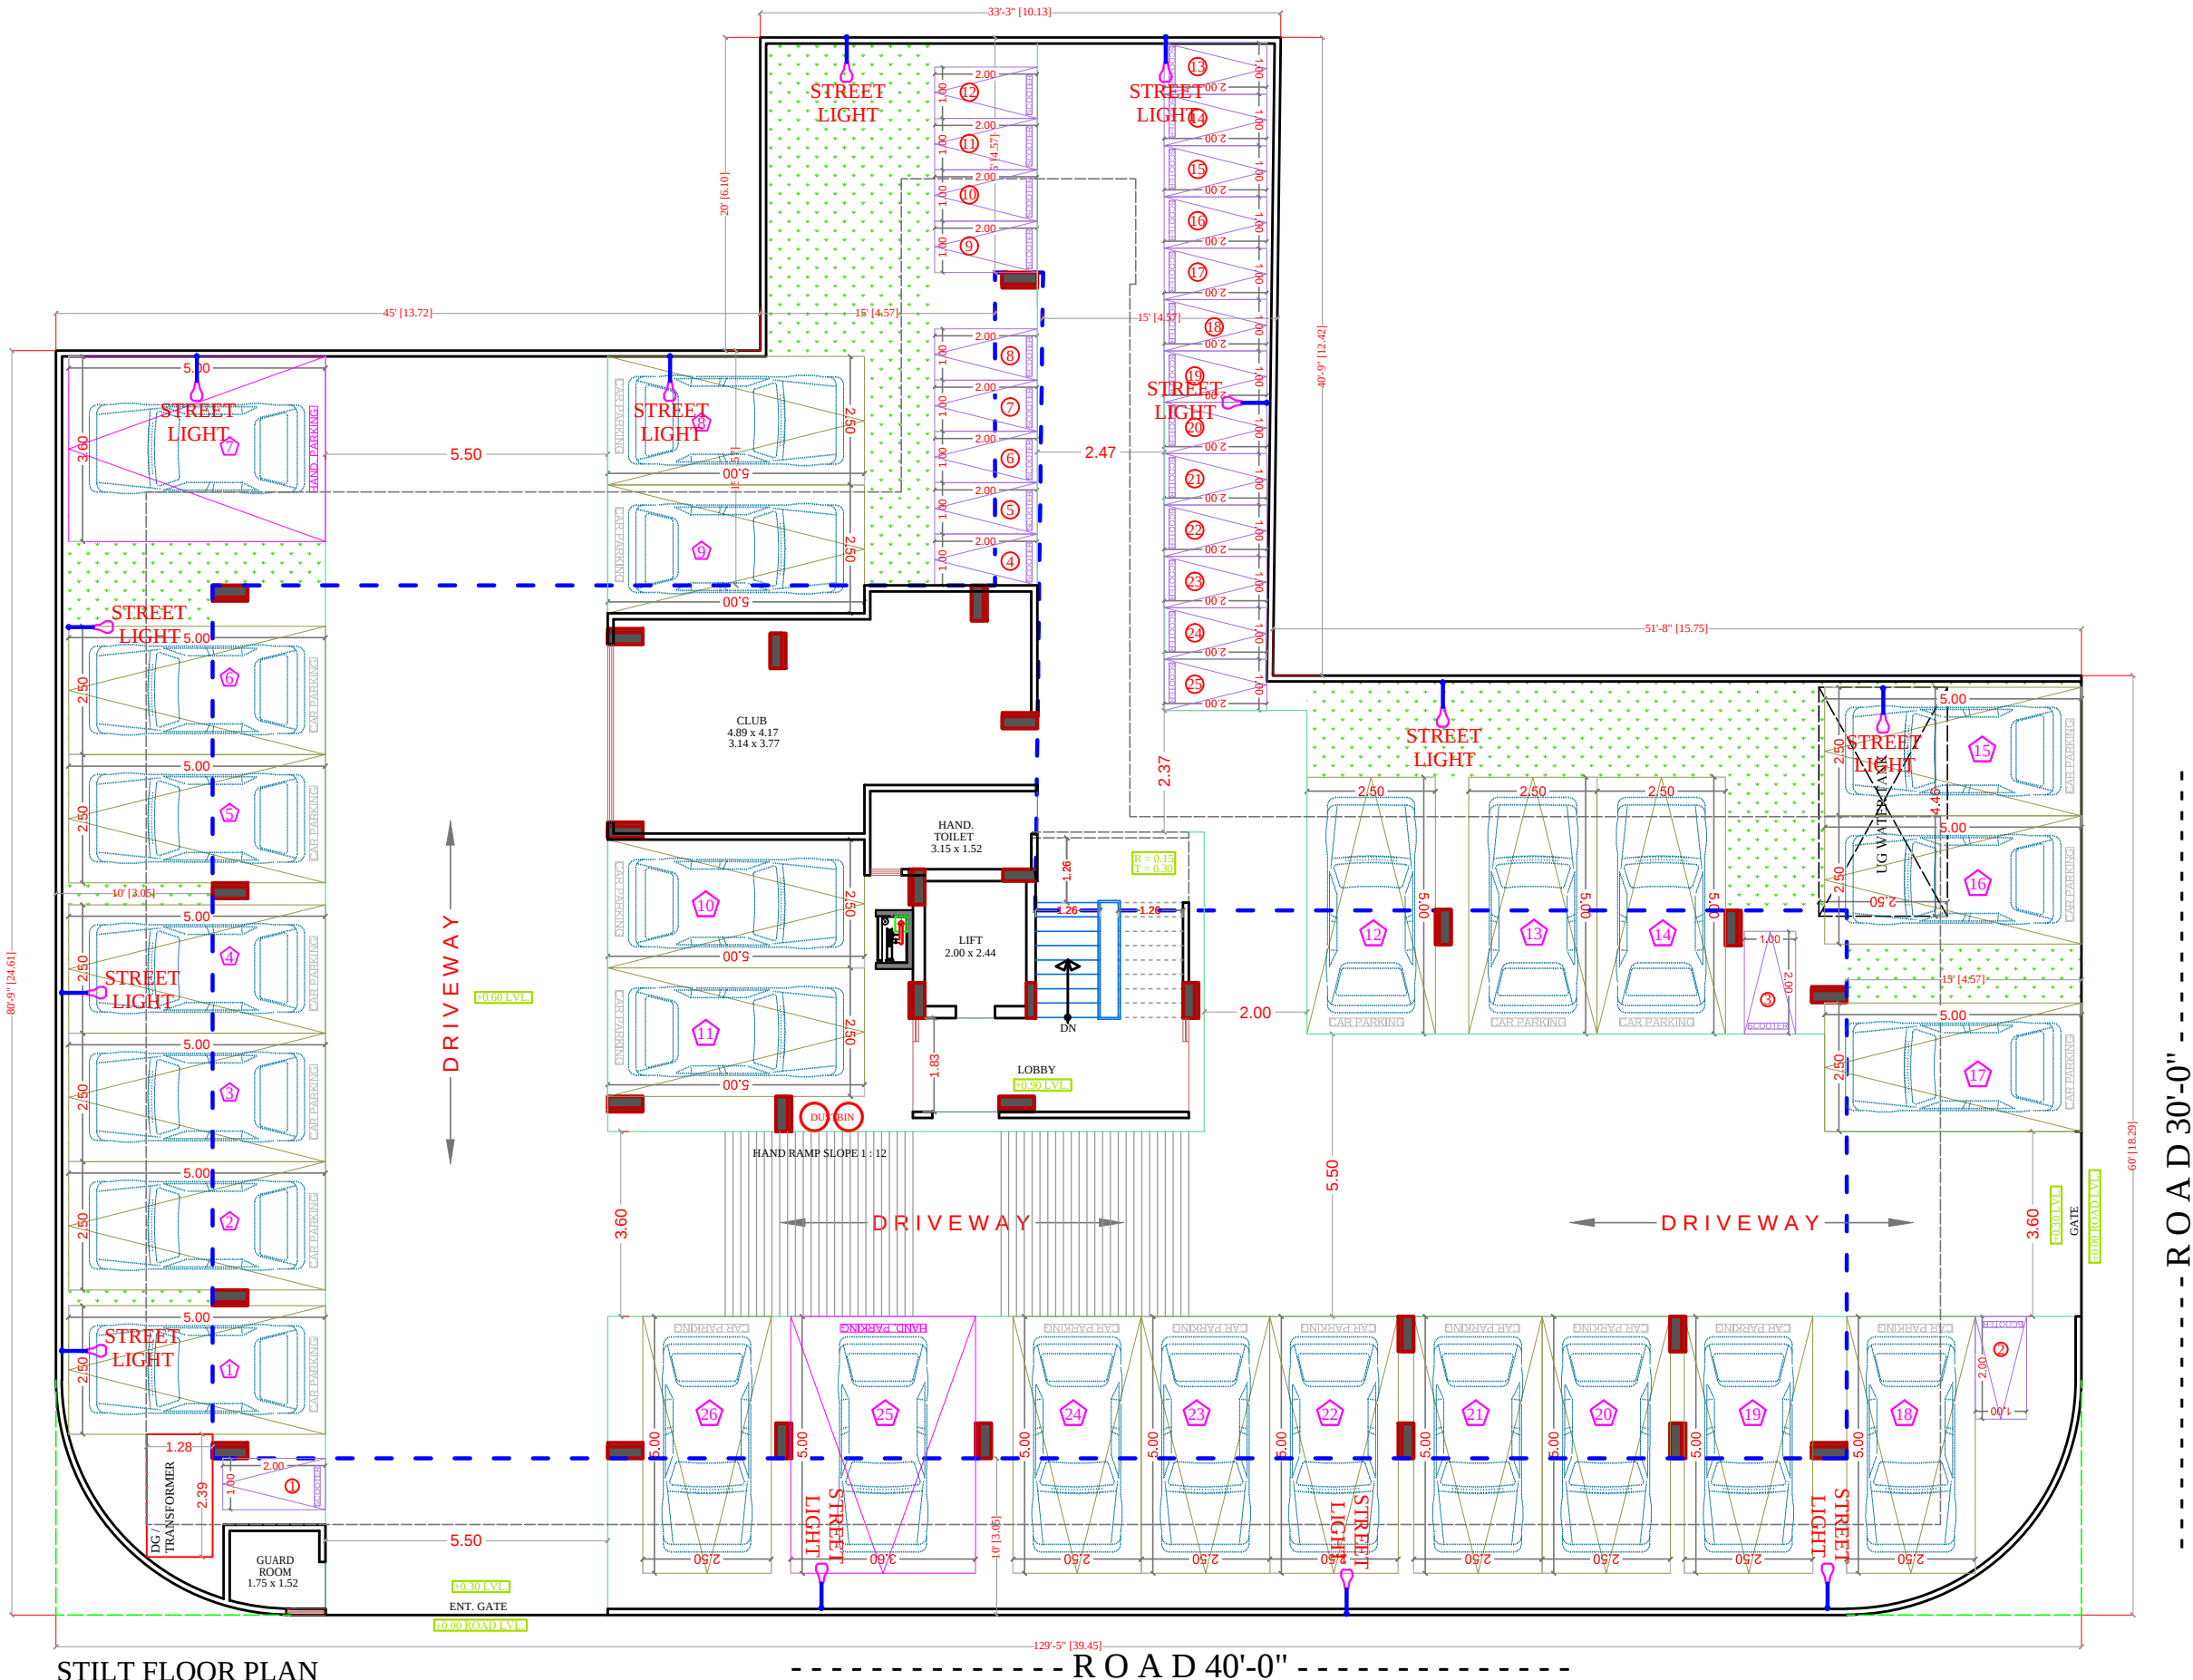

STILT FLOOR PLAN

LEGENDS:

Qty.	I D	Symbol	Description
14	PL		STREET LIGHT

SIGN:-

RAMESH KUMAWAT
M.E.P. CONSULTANT
B.E. CIVIL

SHRI RAM BUILDERS GROUP
Partner

SPACE CONSULTANT

PLOT-A-173, JAGDAMBA NAGAR, HEERAPURA
POWER HOWER, JAIPUR (RAJ) 302024

ARCHITECT :-

FRANK SQUARE
ARCHITECTURE | PLANNER | DESIGNER
C-49 VIDYA APARTMENT PARAS MARG,
BAPU NAGAR JAIPUR, (RAJ.)
Email-afranksquare@gmail.com
Mobile-9461302542

PROJECT :-

PROPOSED BUILDING AT PLOT NO.
PLOT NO-7(SP)8.8-A,8-B NARAYAN
PURI OF HATHROI GADI
GNSS.JAIPUR

BUILDING NAME

ANANDAM HEIGHTS 1V

DEVELOPER NAME

SHRI RAM BUILDERS GROUP


DRAWING:

STILT FLOOR
EXTERNAL STREET LIGHT
FOR RERA SUBMISSION PLAN

DATE


SCALE:-

N.T.S.

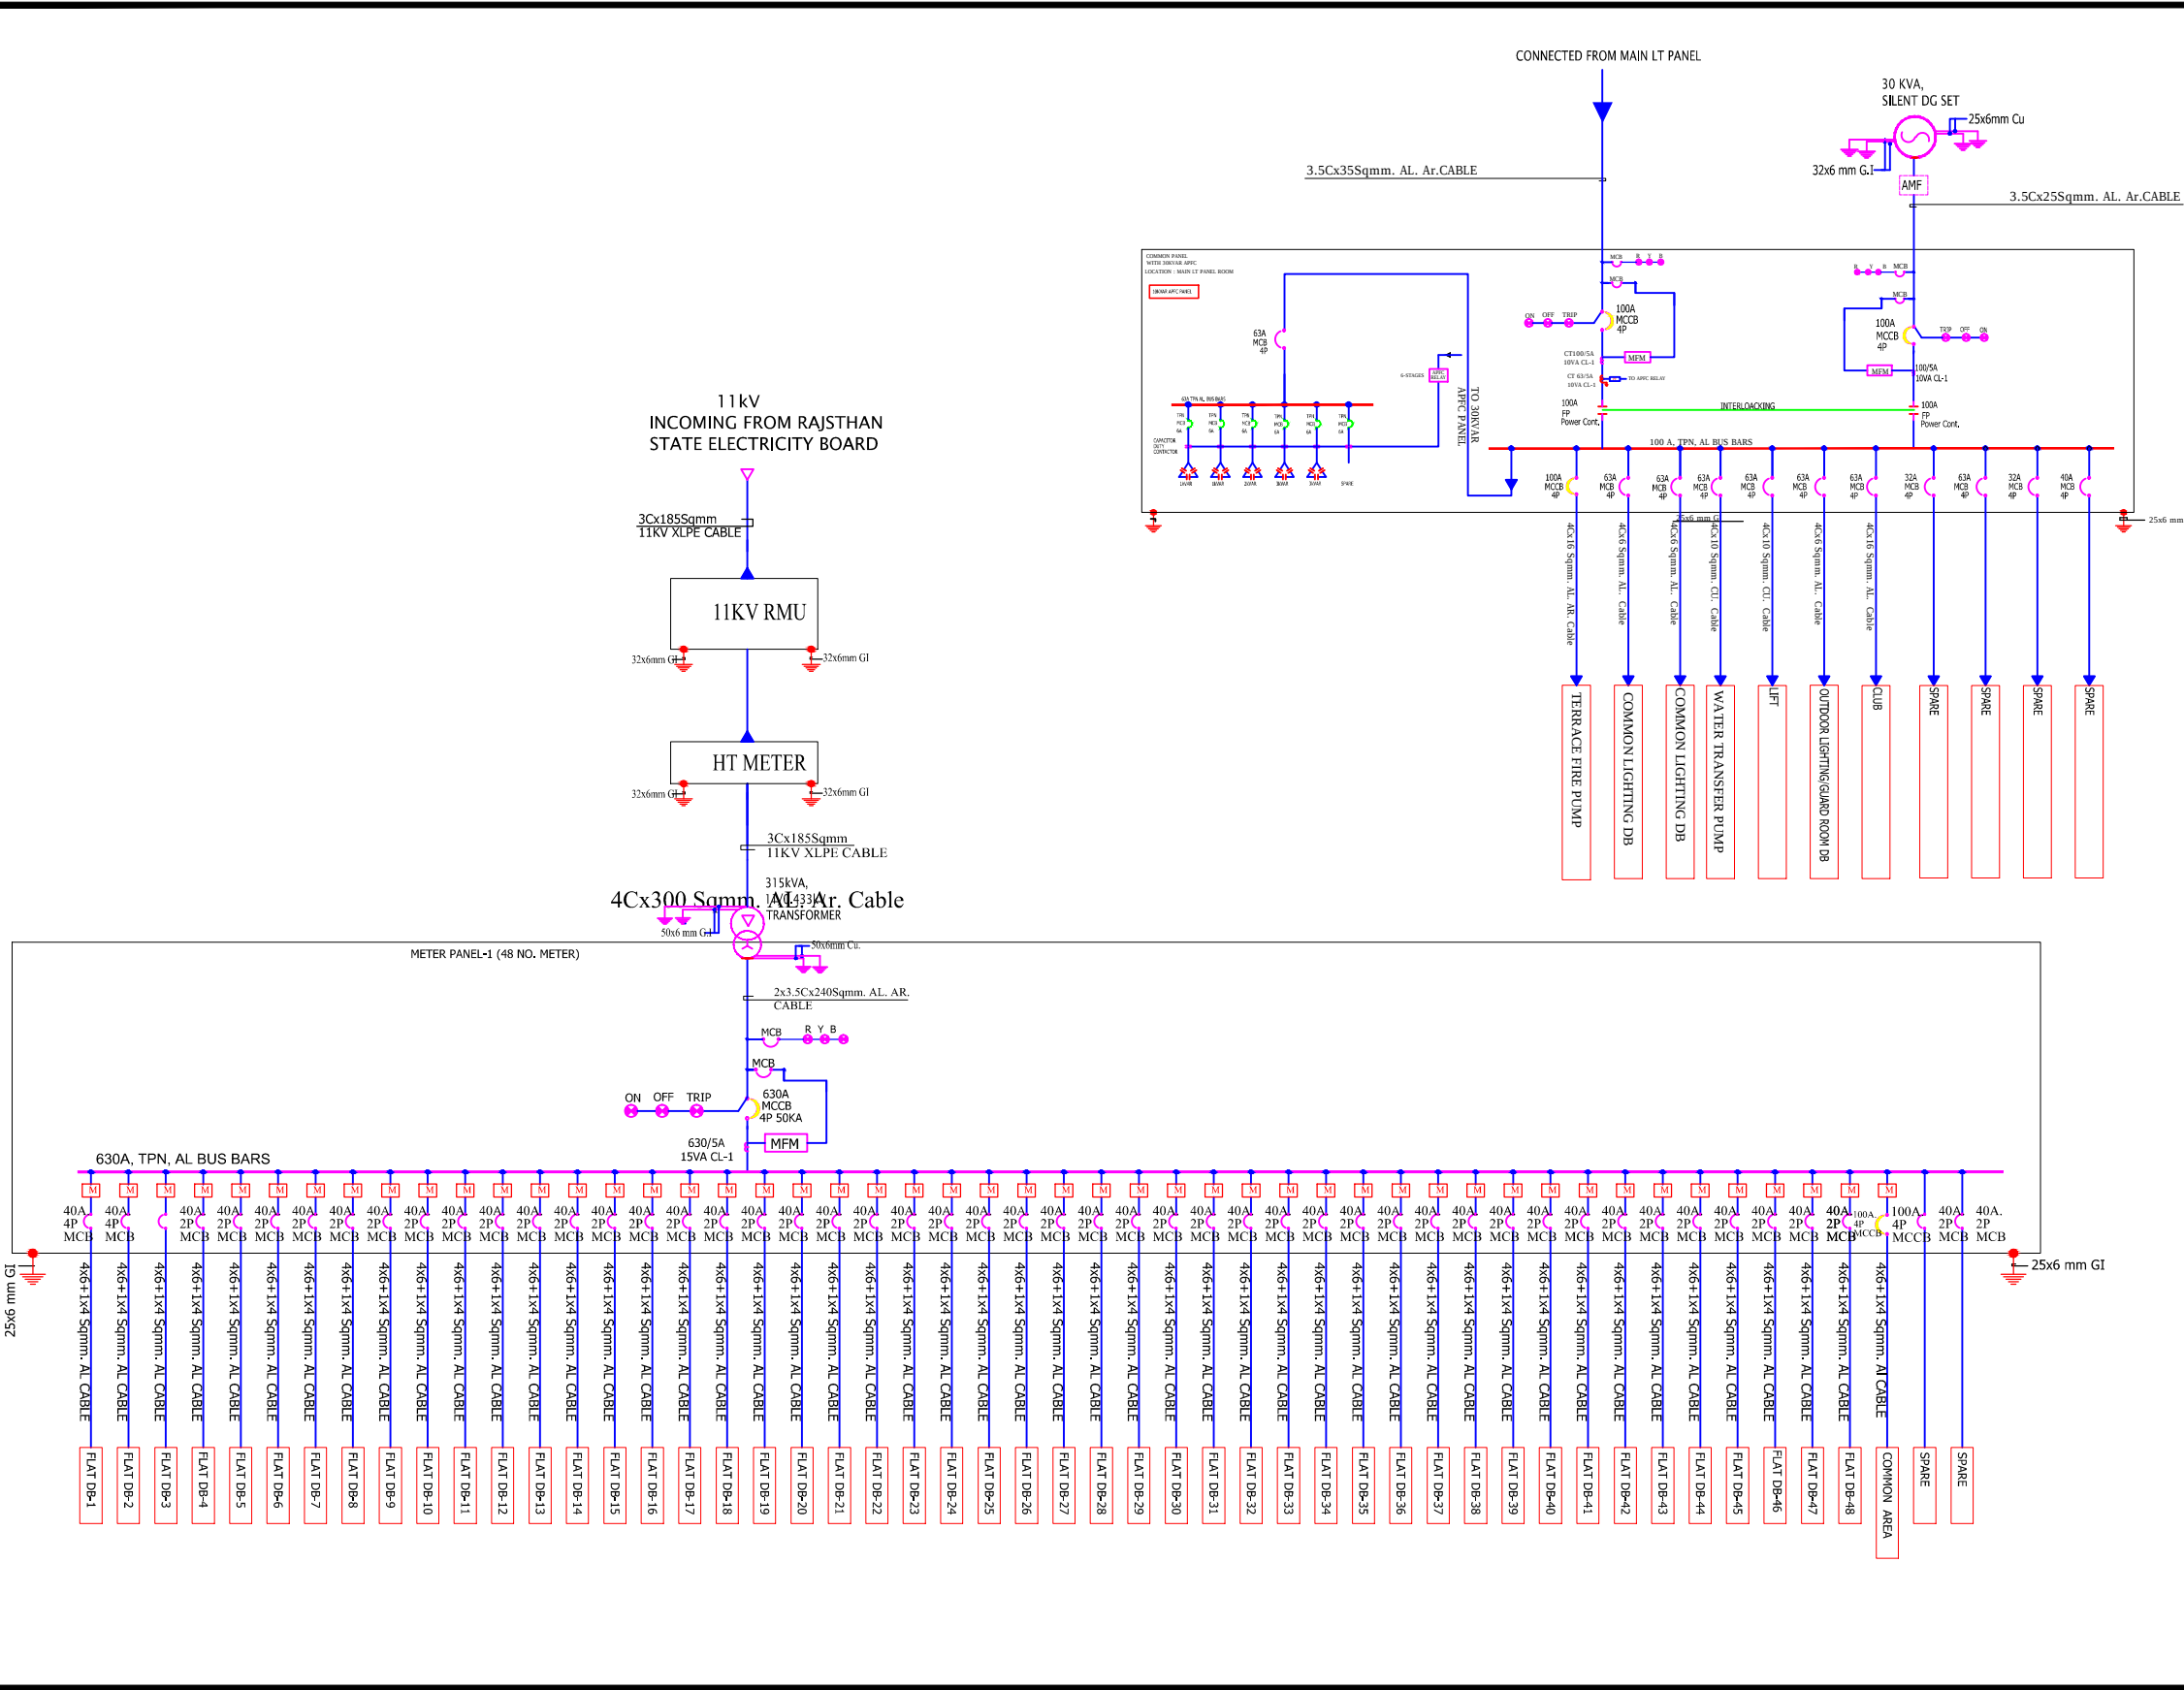

LEGEND	
SYMB.	DESCRIPTION
	AMMETER
	VOLTMETER
	POWER FACTOR METER
	VOLTMETER, AMMETER, FRICTION METER
	FREQUENCY METER
	KILOWATT HOUR METER
	KILOWATT METER
	AMMETER SELECTOR SWITCH
	VOLTMETER SELECTOR SWITCH
	LOCKOUT RELAY
	SUPERVISORY TRIP RELAY
	UNDER VOLTAGE DEVICE
	OVER VOLTAGE DEVICE
	REVERSE POWER PHASE DEVICE
	DIFFERENTIAL PROTECTION RELAY
	OVER CURRENT & EARTH FAULT RELAY
	MULTI FUNCTION RELAY
	ELECTRICAL OPERATED MANUALLY DRAWOUT
	CONTROL FUSE
	CURRENT TRANSFORMER
	TRIVECTOR METER
	INDICATING LAMP
	OVER LOAD RELAY
	POWER CONTACTOR
	POTENTIAL TRANSFORMER
	DUAL SOURCE ELECTRONIC ENERGY METER
	GROUNDING
	MICRO PROCESSOR BASED RELEASE
	ELECTRONIC ENERGY METER
	AIR CIRCUIT BREAKER
	VACUUM CIRCUIT BREAKER
	MINIATURE CIRCUIT BREAKER
	MOULDED CASE CIRCUIT BREAKER
	MOTOR PROTECTION CIRCUIT BREAKER

REVISION - 00			
GENERAL NOTES :			
1. ALL THE DIMENSIONS ON THE DRAWING ARE IN WRITTEN.			
2. ONLY WRITTEN DIMENSIONS ARE TO BE FOLLOWED, DRAWING SHOULD NOT BE SCALED IN ANY CIRCUMSTANCES.			
3. ALL MEASUREMENTS MUST BE CHECKED AND VERIFIED BY THE CONTRACTORS PRIOR TO EXECUTION OF WORK AT THE SITE.			
4. THIS DRAWING IS TO BE READ IN CONJUNCTION WITH ALL RELEVANT STRUCTURAL, ARCHITECTURAL & FACILITY PLANNING DRAWINGS.			
5. ANY DISCREPANCIES MUST BE BROUGHT TO THE NOTICE OF THE ENGINEER IMMEDIATELY & PRIOR TO EXECUTION AT SITE.			
6. CO-ORDINATION WITH SERVICES SUCH AS HVAC, PLUMBING & ELECTRICAL, ETC. IS THE RESPONSIBILITY OF THE CONTRACTORS.			
7. FOR DETAILS, REFER RELEVANT LARGE SCALE DETAIL DRGS. AS INDICATED.			
LIGHTING LEGEND			
R.NO.	SYMBOL	DESCRIPTION	HEIGHT FROM FFL
1		CEILING TUBELIGHT POINT	CEILING
2		LED CEILING LIGHT POINT	CEILING
3		LED WALL BRACKET LIGHT POINT AT WALL	+7'-4"
4		6A SOCKET WITH SWITCH	+2'-0"
5		GENERAL POINT 16A SOCKET WITH SWITCH	+2'-0"
6		MDF BOX	+5'-0"
7		CEILING ROSE	+7'-6"
8		SWITCH BOARD	+4'-0"
9		EXHAUST FAN	VENT. HT.
10		LIGHT & POWER DISTRIBUTION BOARD	+5'-1"
11		Ø25MM POINT CONDUIT	CEILING
12		Ø25MM POWER CIRCUIT CONDUIT	CEILING FLOORING
13		Ø25MM LIGHT CIRCUIT CONDUIT	CEILING FLOORING
14		CEILING FAN	CEILING
ARCHITECT			
ARCHITECT :-  FRANK SQUARE ARCHITECTURE PLANNER DESIGNER C-49 VIDYA APARTMENT PARAS MARG, BAPU NAGAR JAIPUR, (RAJ.) Email-afranksquare@gmail.com Mobile-9461302542			
PROJECT :-			
PROPOSED BUILDING AT PLOT NO. PLOT NO-7(SP)8,8-A,8-B NARAYAN PURI OF HATHROI GADI GNSS.JAIPUR			
BUILDER/DEVELOPER/CLIENT:-			
SHRI RAM BUILDERS GROUP			
BUILDING NAME			
ANANDAM HEIGHTS 1V			
DRAWING TITLE:-			
MAIN PANEL SLD			
SUBMITTED FOR :-			
PRELIMINARY	☐	APPROVAL	☐
PROPOSAL	☐	FOR RERA	☒
DATE :-		NORTH :-	
DRAWN :-			
APPROVED :-			
DRAWING NO.:-		SCALE :-	
CONSULTANT			
AMP INFRA SERVICES VILLA NO 16. SHUBHASIS GEETA JAISINGHPURA, BHANKROTA & CHIMANPURA.JAIPUR 302026 EMAIL ID- ampinfrajpr@gmail.com CONTACT NO. :- 9462866389			

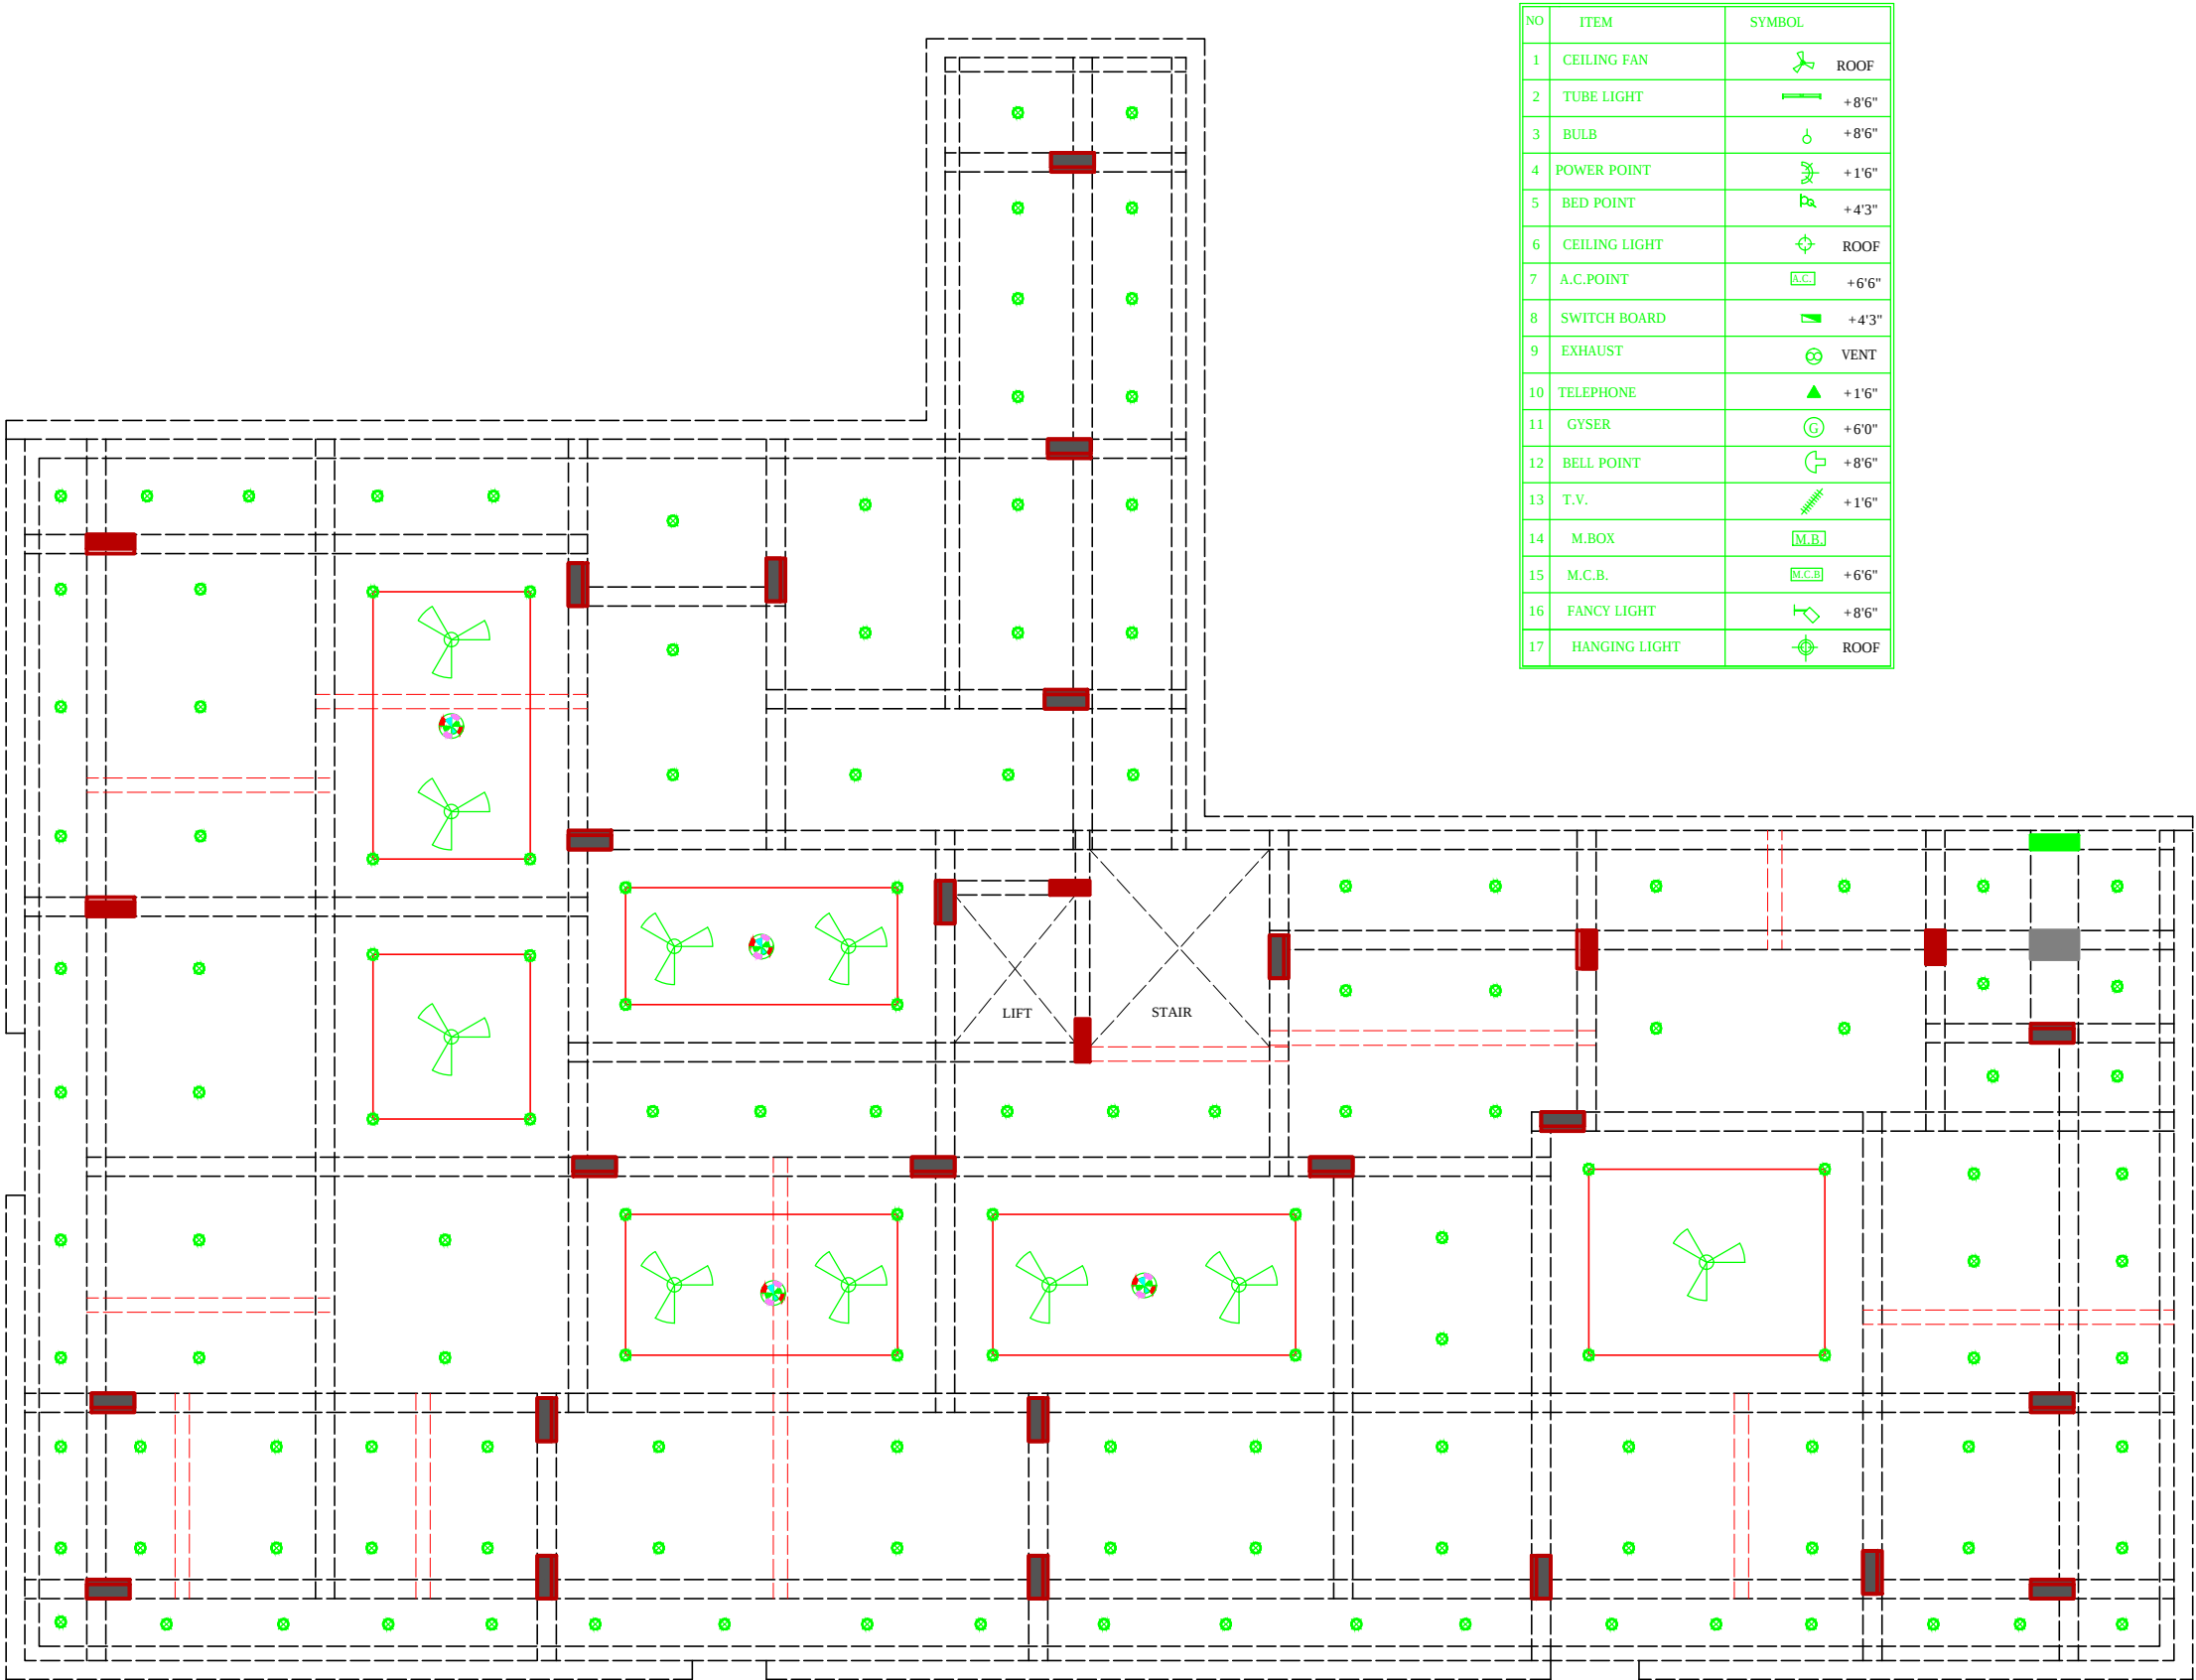

NO	ITEM	SYMBOL
1	CEILING FAN	ROOF
2	TUBE LIGHT	+8'6"
3	BULB	+8'6"
4	POWER POINT	+1'6"
5	BED POINT	+4'3"
6	CEILING LIGHT	ROOF
7	A.C.POINT	+6'6"
8	SWITCH BOARD	+4'3"
9	EXHAUST	VENT
10	TELEPHONE	+1'6"
11	GYSER	+6'0"
12	BELL POINT	+8'6"
13	T.V.	+1'6"
14	M.BOX	
15	M.C.B.	+6'6"
16	FANCY LIGHT	+8'6"
17	HANGING LIGHT	ROOF

RAMESH KUMAWAT
M.E.P. CONSULTANT
B.E. CIVIL

SHRI RAM BUILDERS GROUP
Partner

PROJECT TITLE :- PROPOSED BUILDING AT PLOT NO. PLOT NO-7(SP)8,8-A,8-B NARAYAN PURI OF HATHROI GADI GNSS.JAIPUR	BUILDING NAME ANANDAM HEIGHTS 1V	DRAWING TITLE :- STILT FLOOR ELECTRIC PLAN	SPACE CONSULTANT PLOT-A-173, JAGDAMBA NAGAR, HEERAPURA POWER HOWER, JAIPUR (RAJ) 302024	DRN. BY		NORTH
	DEVELOPER NAME SHRI RAM BUILDERS GROUP			APPD. BY		DATE
				SCALE		REVISION

