


ROAD 40'-0"

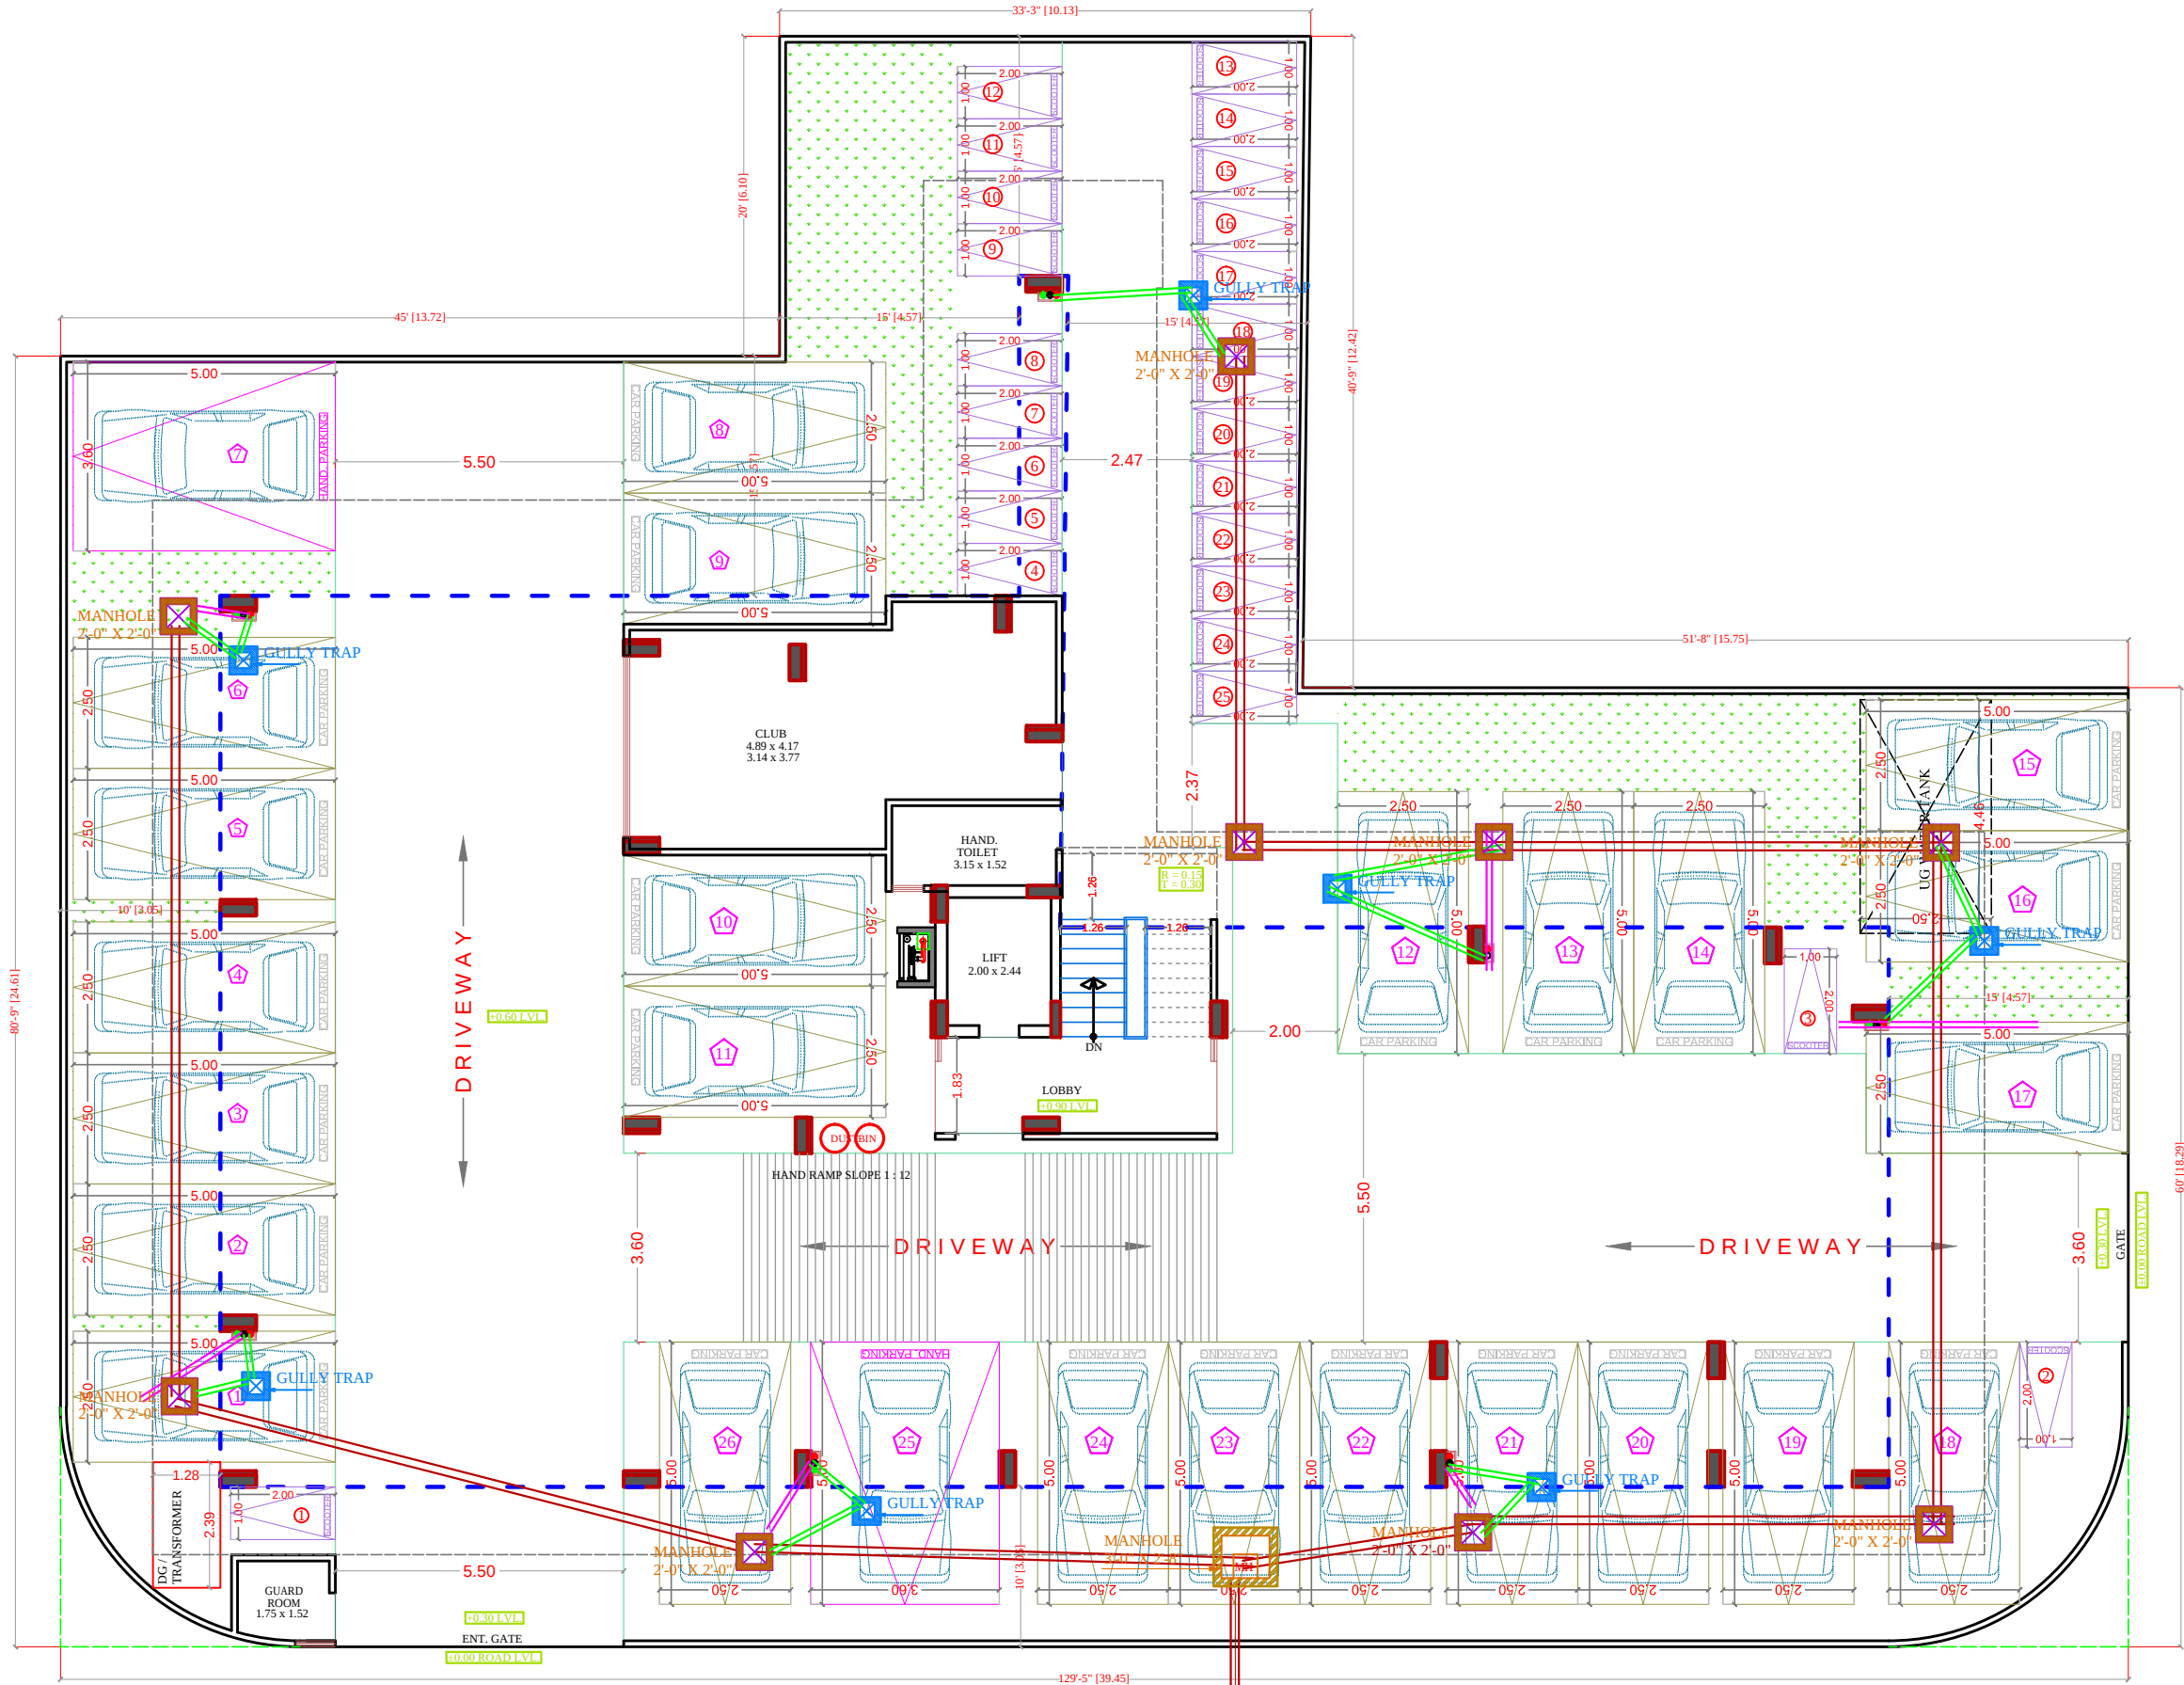

STILT FLOOR PLAN

SYMBOL	DESCRIPTION
	Ø 110 mm Soil Waste Water Pipe
	Ø 110 mm Waste Water Pipe
	Ø 110 mm Rain Water Pipe
	Ø 160 mm Soil Waste Water Pipe Slope 1:150
	Ø 110 mm Soil Waste Water Pipe Slope 1:150
	Ø 110 mm Waste Water Pipe Slope 1:150
	Ø 75 mm Waste Water Pipe Slope 1:150
	50mm Waste Water Pipe Bottle Trap
	Floor Trap
	P-Trap Required
	Gully Trap-12"X12" Depth According to Slope
	Main Hole-18"X18" Depth According to Slope
	Main Hole-24"X24" Depth According to Slope
	Main Hole-36"X32" Depth According to Slope
	Flow Direction

SIGN:-

RAMESH KUMAWAT
M.E.P. CONSULTANT
B.E. CIVIL

SHRI RAM BUILDERS GROUP
Partner

SPACE CONSULTANT
PLOT-A-173, JAGDAMBA NAGAR, HEERAPURA
POWER HOWER, JAIPUR (RAJ.) 302024

ARCHITECT :-

FRANK SQUARE
ARCHITECTURE | PLANNER | DESIGNER
C-49 VIDYA APARTMENT PARAS MARG,
BAPU NAGAR JAIPUR, (RAJ.)
Email-afranksquare@gmail.com
Mobile-9461302542

PROJECT :-
PROPOSED BUILDING AT PLOT NO.
PLOT NO-7(SP)8,8-A,8-B NARAYAN
PURI OF HATHROI GADI
GNSS.JAIPUR


BUILDING NAME
ANANDAM HEIGHTS 1V

DEVELOPER NAME
SHRI RAM BUILDERS GROUP


DRAWING: STILT FLOOR
EXTERNAL SEWERAGE
CHAMBER & PIPE ROUTE FOR
RERA SUBMISSION PLAN

DATE
SCALE:-
N.T.S.

WATER SUPPLY SCHEMATIC DIAGRAM

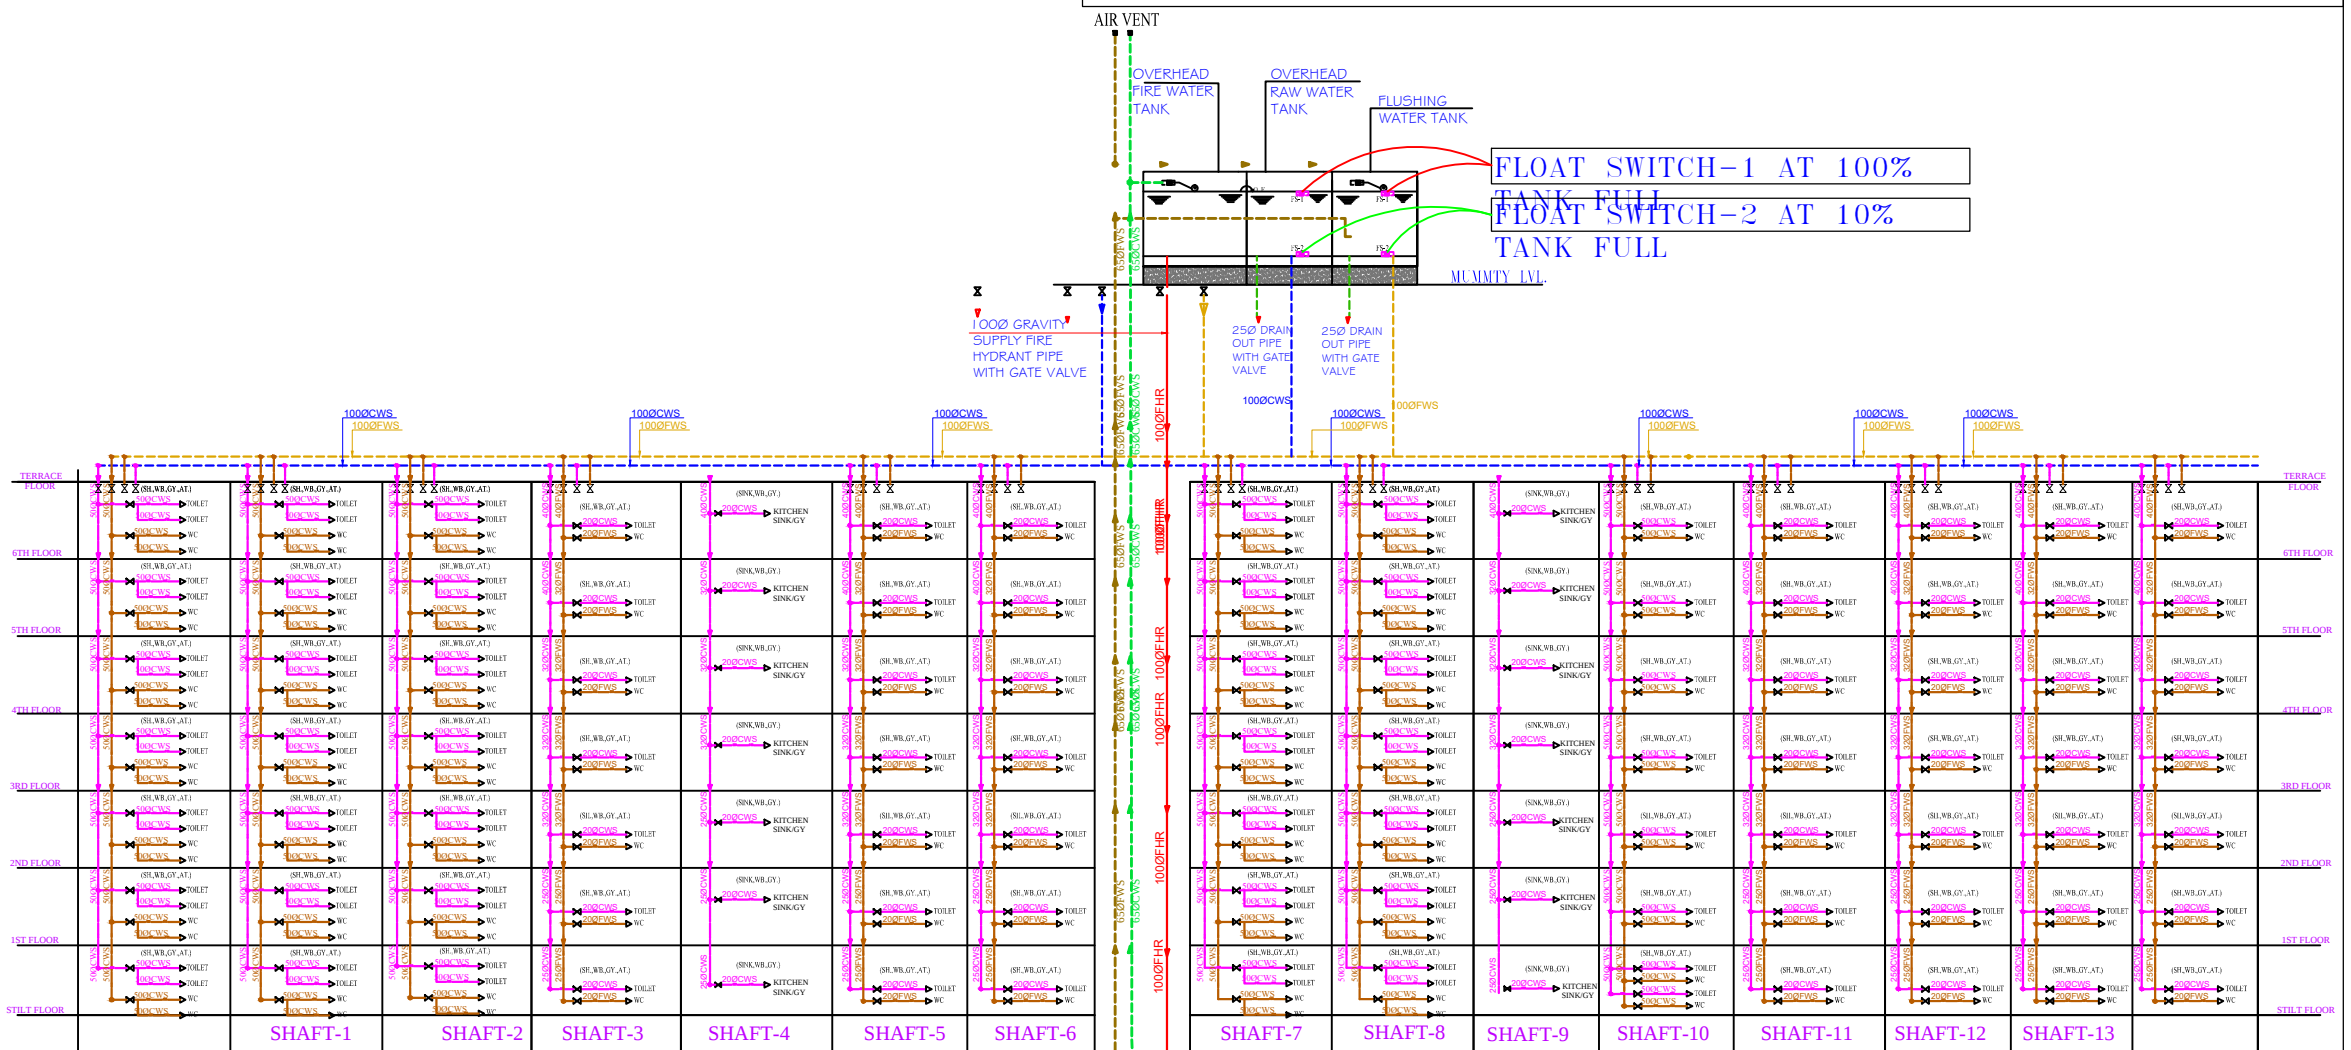



SHAFT MARKING KEY PLAN

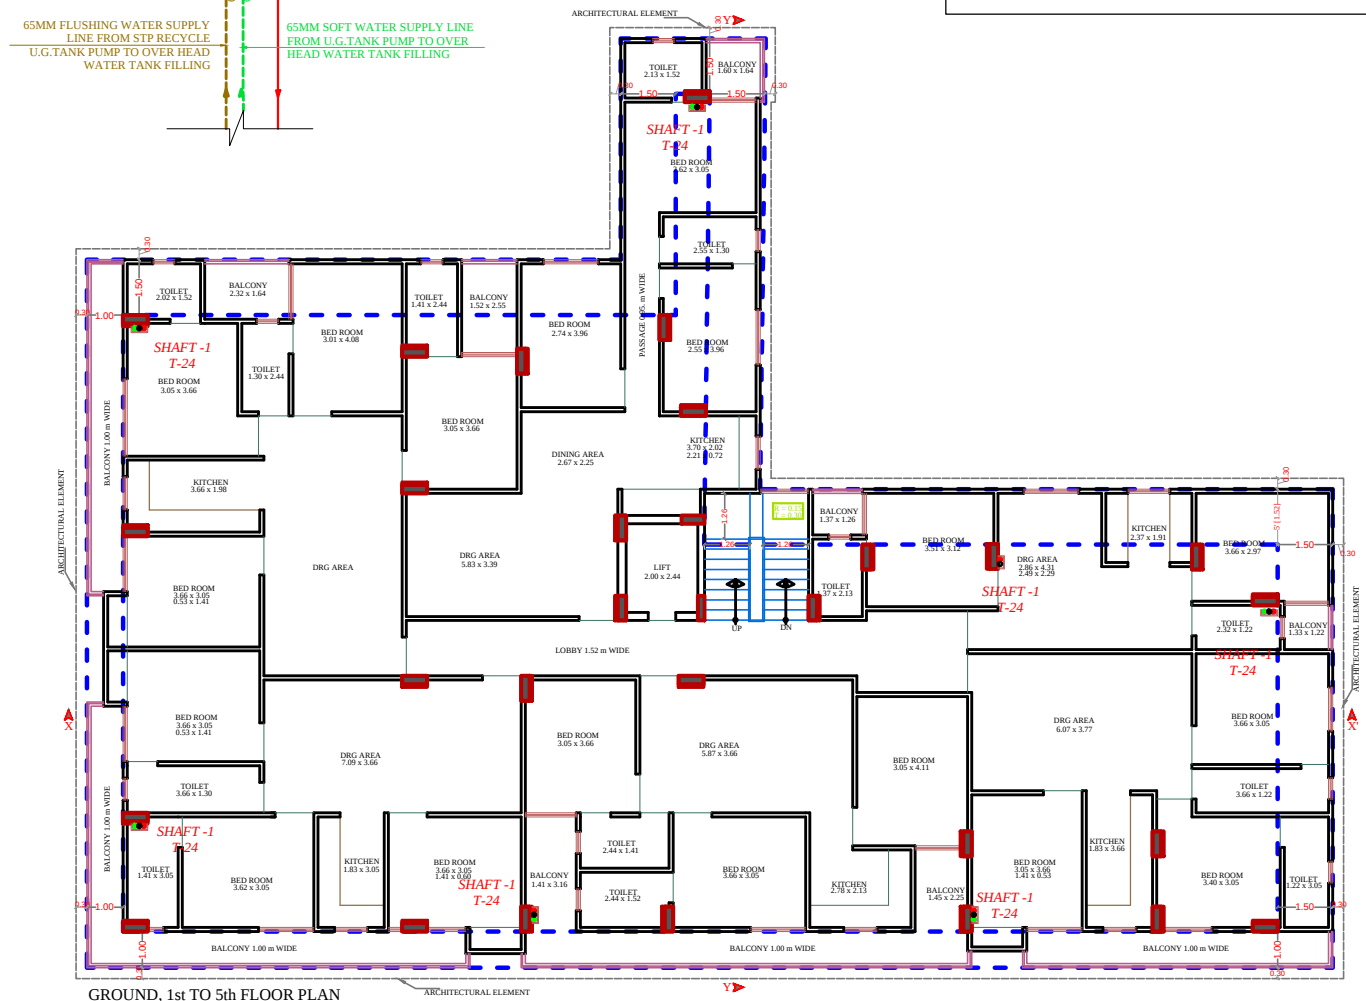

SERVICES CONSULTANT: PLOT-A-173, JAGDAMBA NAGAR ,HEERAPURA POWER HOWER ,JAIPUR (RAJ) 302024	
ARCHITECTS:-  FRANK SQUARE ARCHITECTURE PLANNER DESIGNER C-49 VIDYA APARTMENT PARAS MARG, BAPU NAGAR JAIPUR, (RAJ.) Email-afranksquare@gmail.com Mobile-9461302542	
Project: PROPOSED BUILDING AT PLOT NO. PLOT NO-7(SP)8-A,8-B NARAYAN PURI OF HATHROI GADI GNSS,JAIPUR	
BUILDING NAME ANANDAM HEIGHTS 1V	
DEVELOPER NAME SHRI RAM BUILDERS GROUP	
Drawing: WATER SUPPLY SCHEMATIC DIAGRAM	
DRN BY :	CHKD BY :
APPRVD BY :	DATE:-

 
RAMESH KUMAWAT
M.E.P. CONSULTANT
B.E. CIVIL


SHRI RAM BUILDERS GROUP
Partner

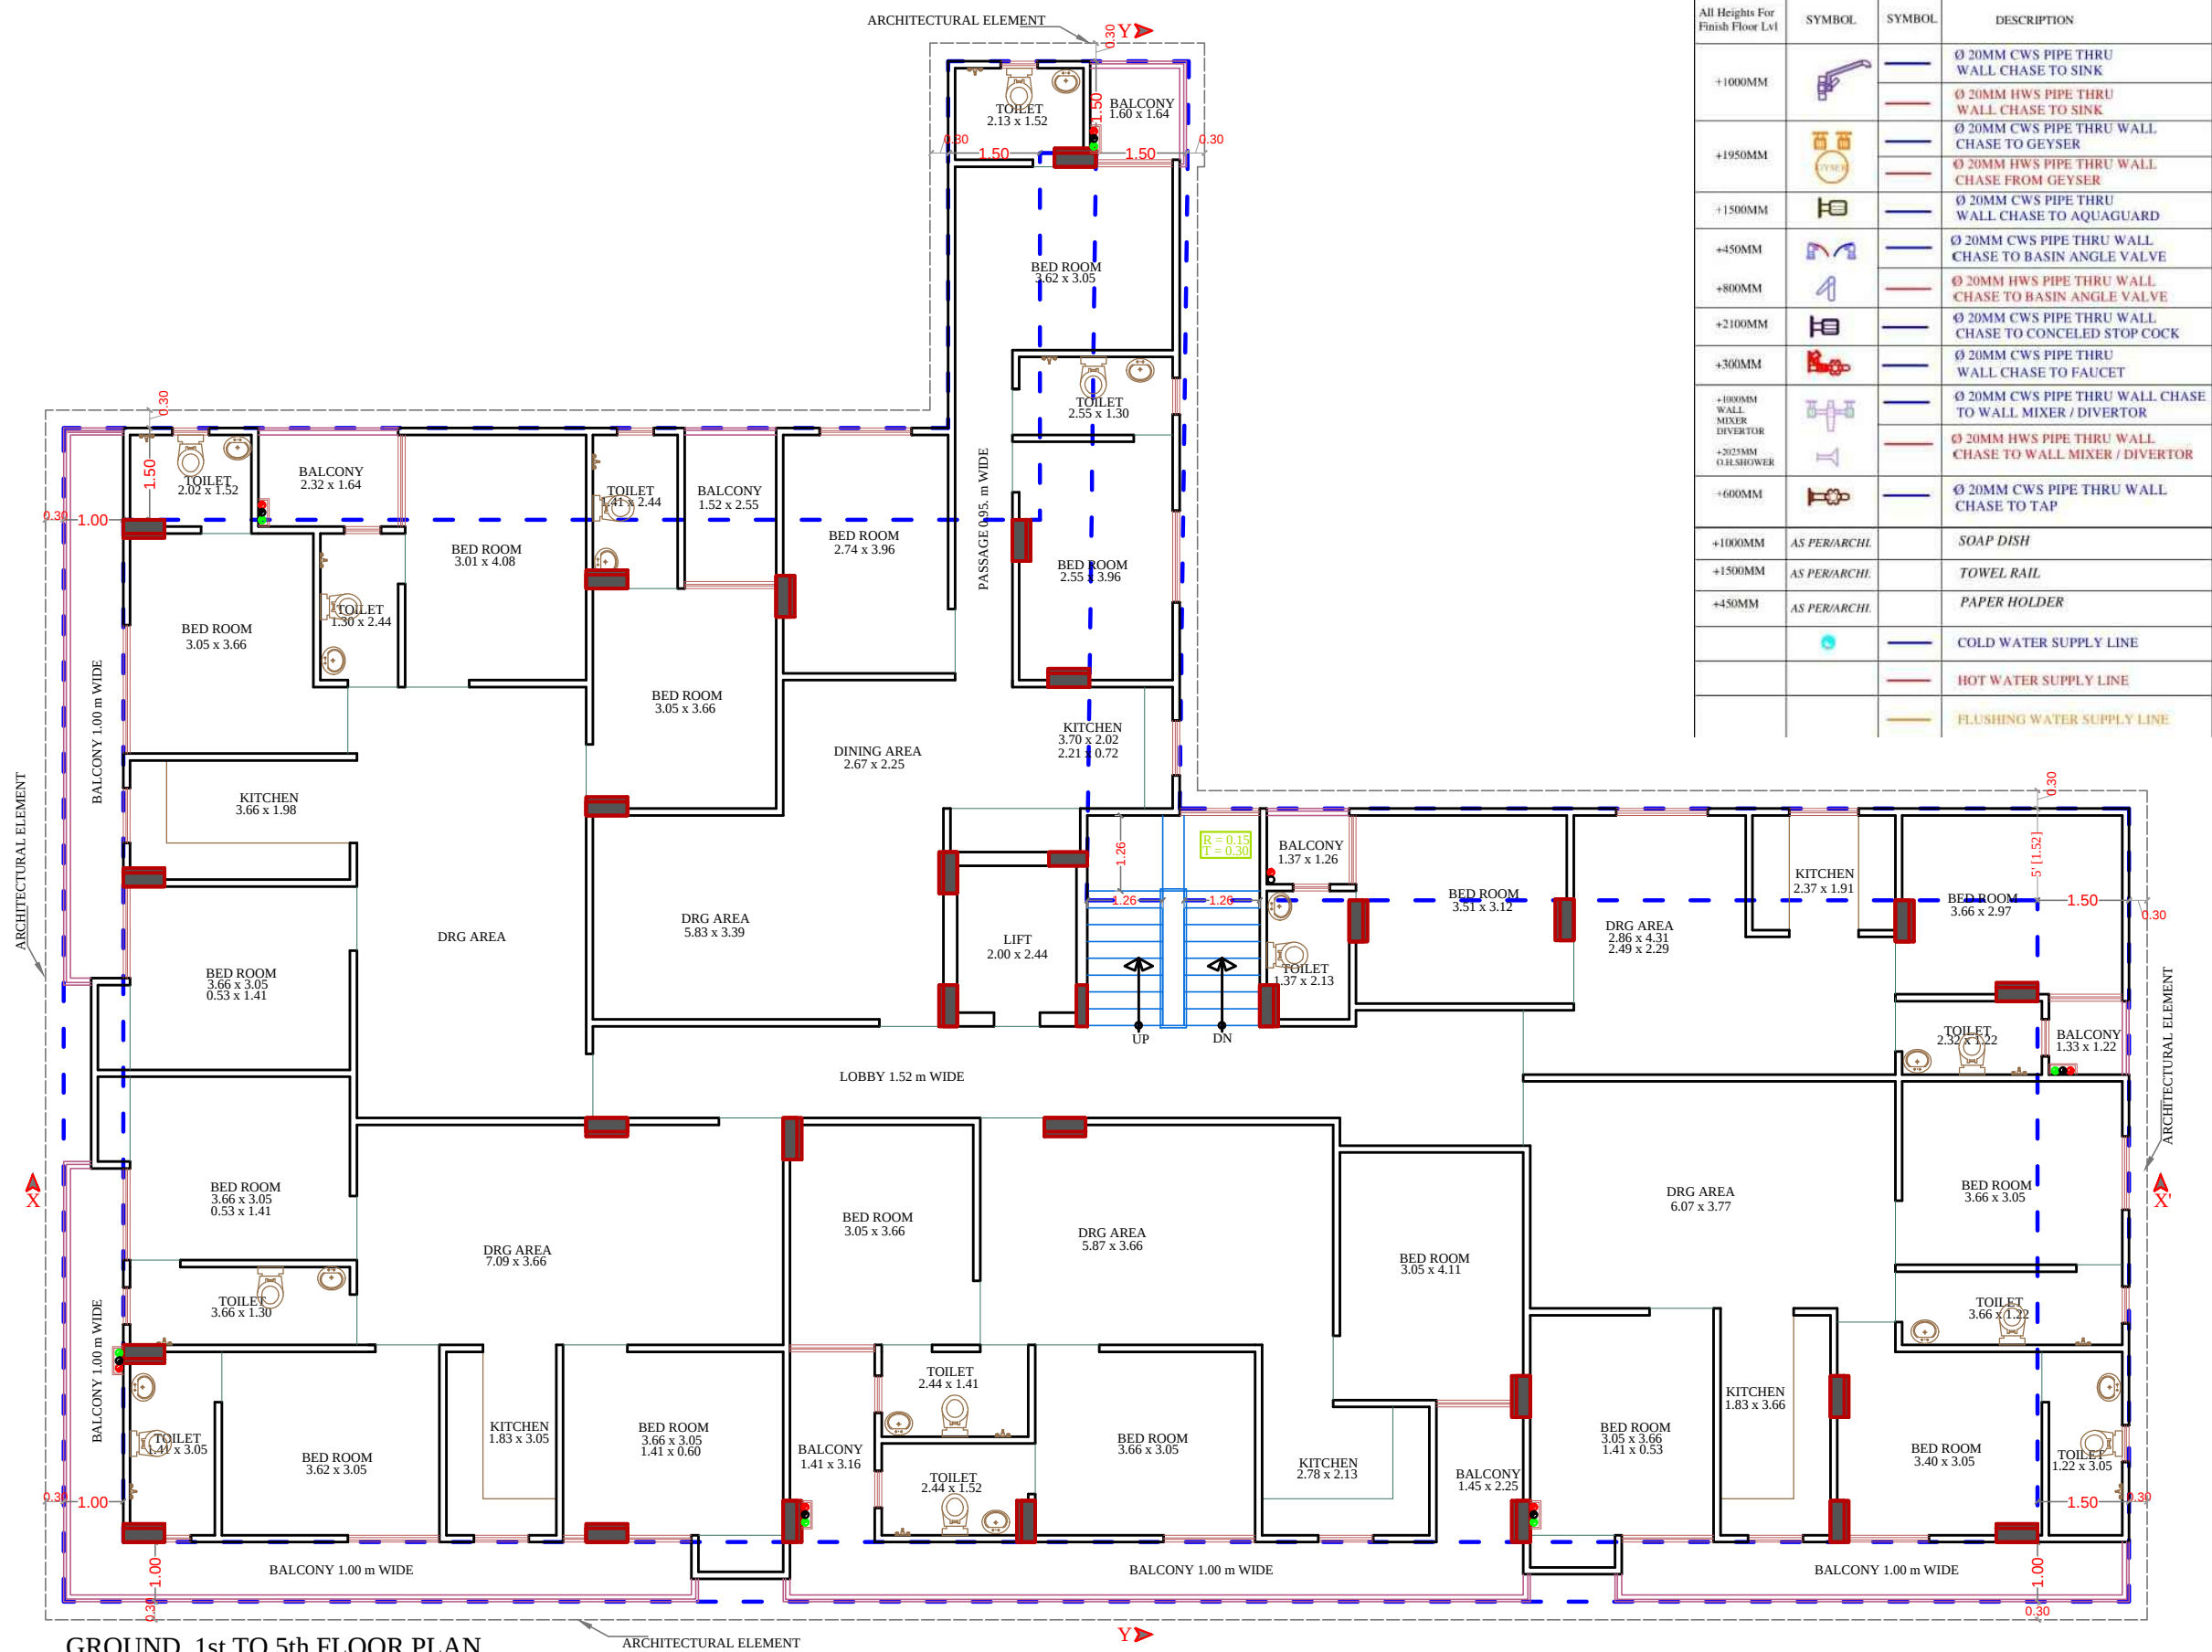

GROUND, 1st TO 5th FLOOR PLAN

RAMESH KUMAWAT
M.E.P. CONSULTANT
B.E. CIVIL

SHRI RAM BUILDERS GROUP
Partner

PROJECT TITLE :- PROPOSED BUILDING AT PLOT NO. PLOT NO-7(SP)8,8-A,8-B NARAYAN PURI OF HATHROI GADI GNSS.JAIPUR	BUILDING NAME ANANDAM HEIGHTS 1V	DRAWING TITLE :- TYPICAL FLOOR PLUMBING PLAN	SERVICES CONSULTANT	DRN. BY			NORTH
	DEVELOPER NAME SHRI RAM BUILDERS GROUP			DATE			
				APPD. BY		REVISION	
				SCALE			