



Schematic arrangement of Fire Fighting System
at **AKSHAT SKYHOMES** Kanota

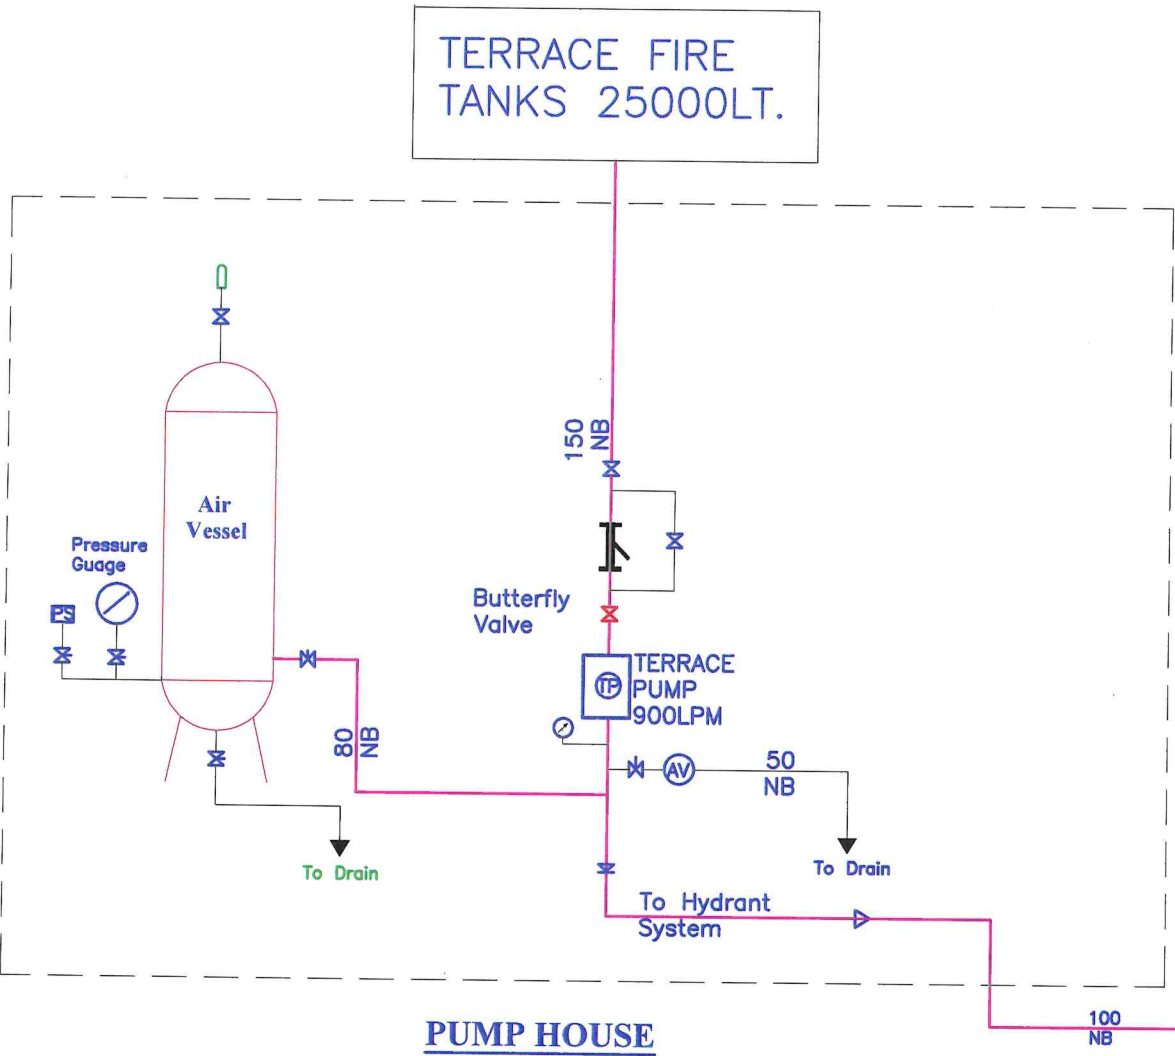

LEGEND	
	Butterfly Valve
	Brass Strainer
	Ball Valve
	Hydrant Valve
	FIRE BRIGADE INLET CONNECTION

FIRE REQUIREMENT OF PROPOSED APURTMENT HOUSE			
Type of Building APURTMENT HOUSE (A-4)			
(A-4)- (2) 15 Mt AND ABOVE BUT NOT EXCEEDING 35 Mtr in Height ,			
SN	NBC sno	ITEM	Type A-4
1	3	Fire Extingusher	R
2	4	House Reel	R
3	5	Wet Riser	NR
4	6	Down Comer	R
5	7	Yard Hydrant	NR
6	8	Automatic Sprinkler System	R (IN THE BASEMENT)
7	9	Manually operated Fire alarm system	R
8	10	Automatic Detection and Alarm system	NR
9	11	Under ground Water tank	NR
10	12	Terrace Tank	25000 LTR
11	13	Pump Capacity in Pump room (Hudrant Pump)	NR
12	13	Pump Capacity in Pump room (Sprinkler Pump)	NR
13	13	Diesel Pump Capacity in Pump room	NR
14	13	Jocky Pump Capacity	NR
15	14	Terrace Pump Capacity	900

LEGEND	
SYMBOL	DESCRIPTION
	YARD HYDRANT VALVE (SINGLE HEADED)
	BUTTERFLY VALVE 150Ø
	LANDING VALVE
	HOSE REEL H.R.
	PRESSURE SWITCH
	PRESSURE GAUGE
	NON RETURN VALVE (CHECK VALVE)
	Y TYPE STRAINER
	SPRINKLER
	FLOW SWITCH
	EXPANSION BELLOWES
	INLET CONNECTION
	DRAWOUT CONNECTION

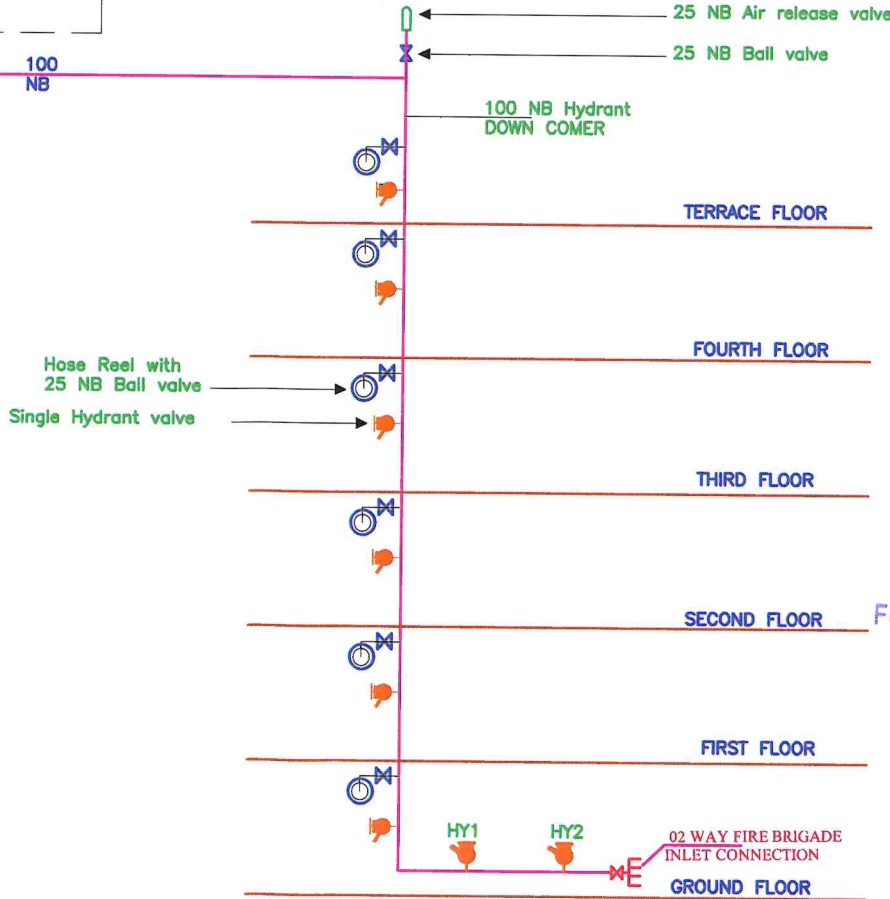

Praveen
PRAVEEN KUMAR
BTECH (ELECT)

For AKSHAT APARTMENTS PVT. LTD.
SUNIL JAIN
Director
DIN: 00155259

DRAWING TITLE -
FIRE FIGHTING SCHEMATIC
DRAWING

PLAN OF FIRE HOSE CABINET
DETAIL

SERVICES CONSULTANT :

SRAJAN ASSOCIATES
C-35A, LAJPAT MARG,
C-SCHEME, JAIPUR.
TEL. : (0141) 4040129
Email : snajaiipur@hotmail.com

PROJECT TITLE :

**PROPOSED AKSHAT KANOTA
SKYHOMES ,KANOTA**

ARCHITECT:-

mja architects pvt.ltd.
Jaipur - Bangalore - Hyderabad
Plot No. - 1, Greenwood, Lal Kothi Scheme,
off Sakinagar, Jaipur-302001
Tel: 91 141 4299999,
email - studio@mjaarchitects.in web-www.mjaarchitects.in

DRAWING TITLE:-

**FIRE FIGHTING SCHEMATIC PLAN
OF PLOT -4**


SCALE N.T.S. DATE APR_29_2025

DEALT BY RAHMAN STATUS WORKING

DWG NO. - SA/MA/E108 NORTH -

4BHK UNIT+ SERV.
BUA- 2114 sq ft
SBUA @25% LOADING - 2643 sq ft

4BHK UNIT+ SERV.
BUA- 2121 sq ft
SBUA @25% LOADING - 2652 sq ft

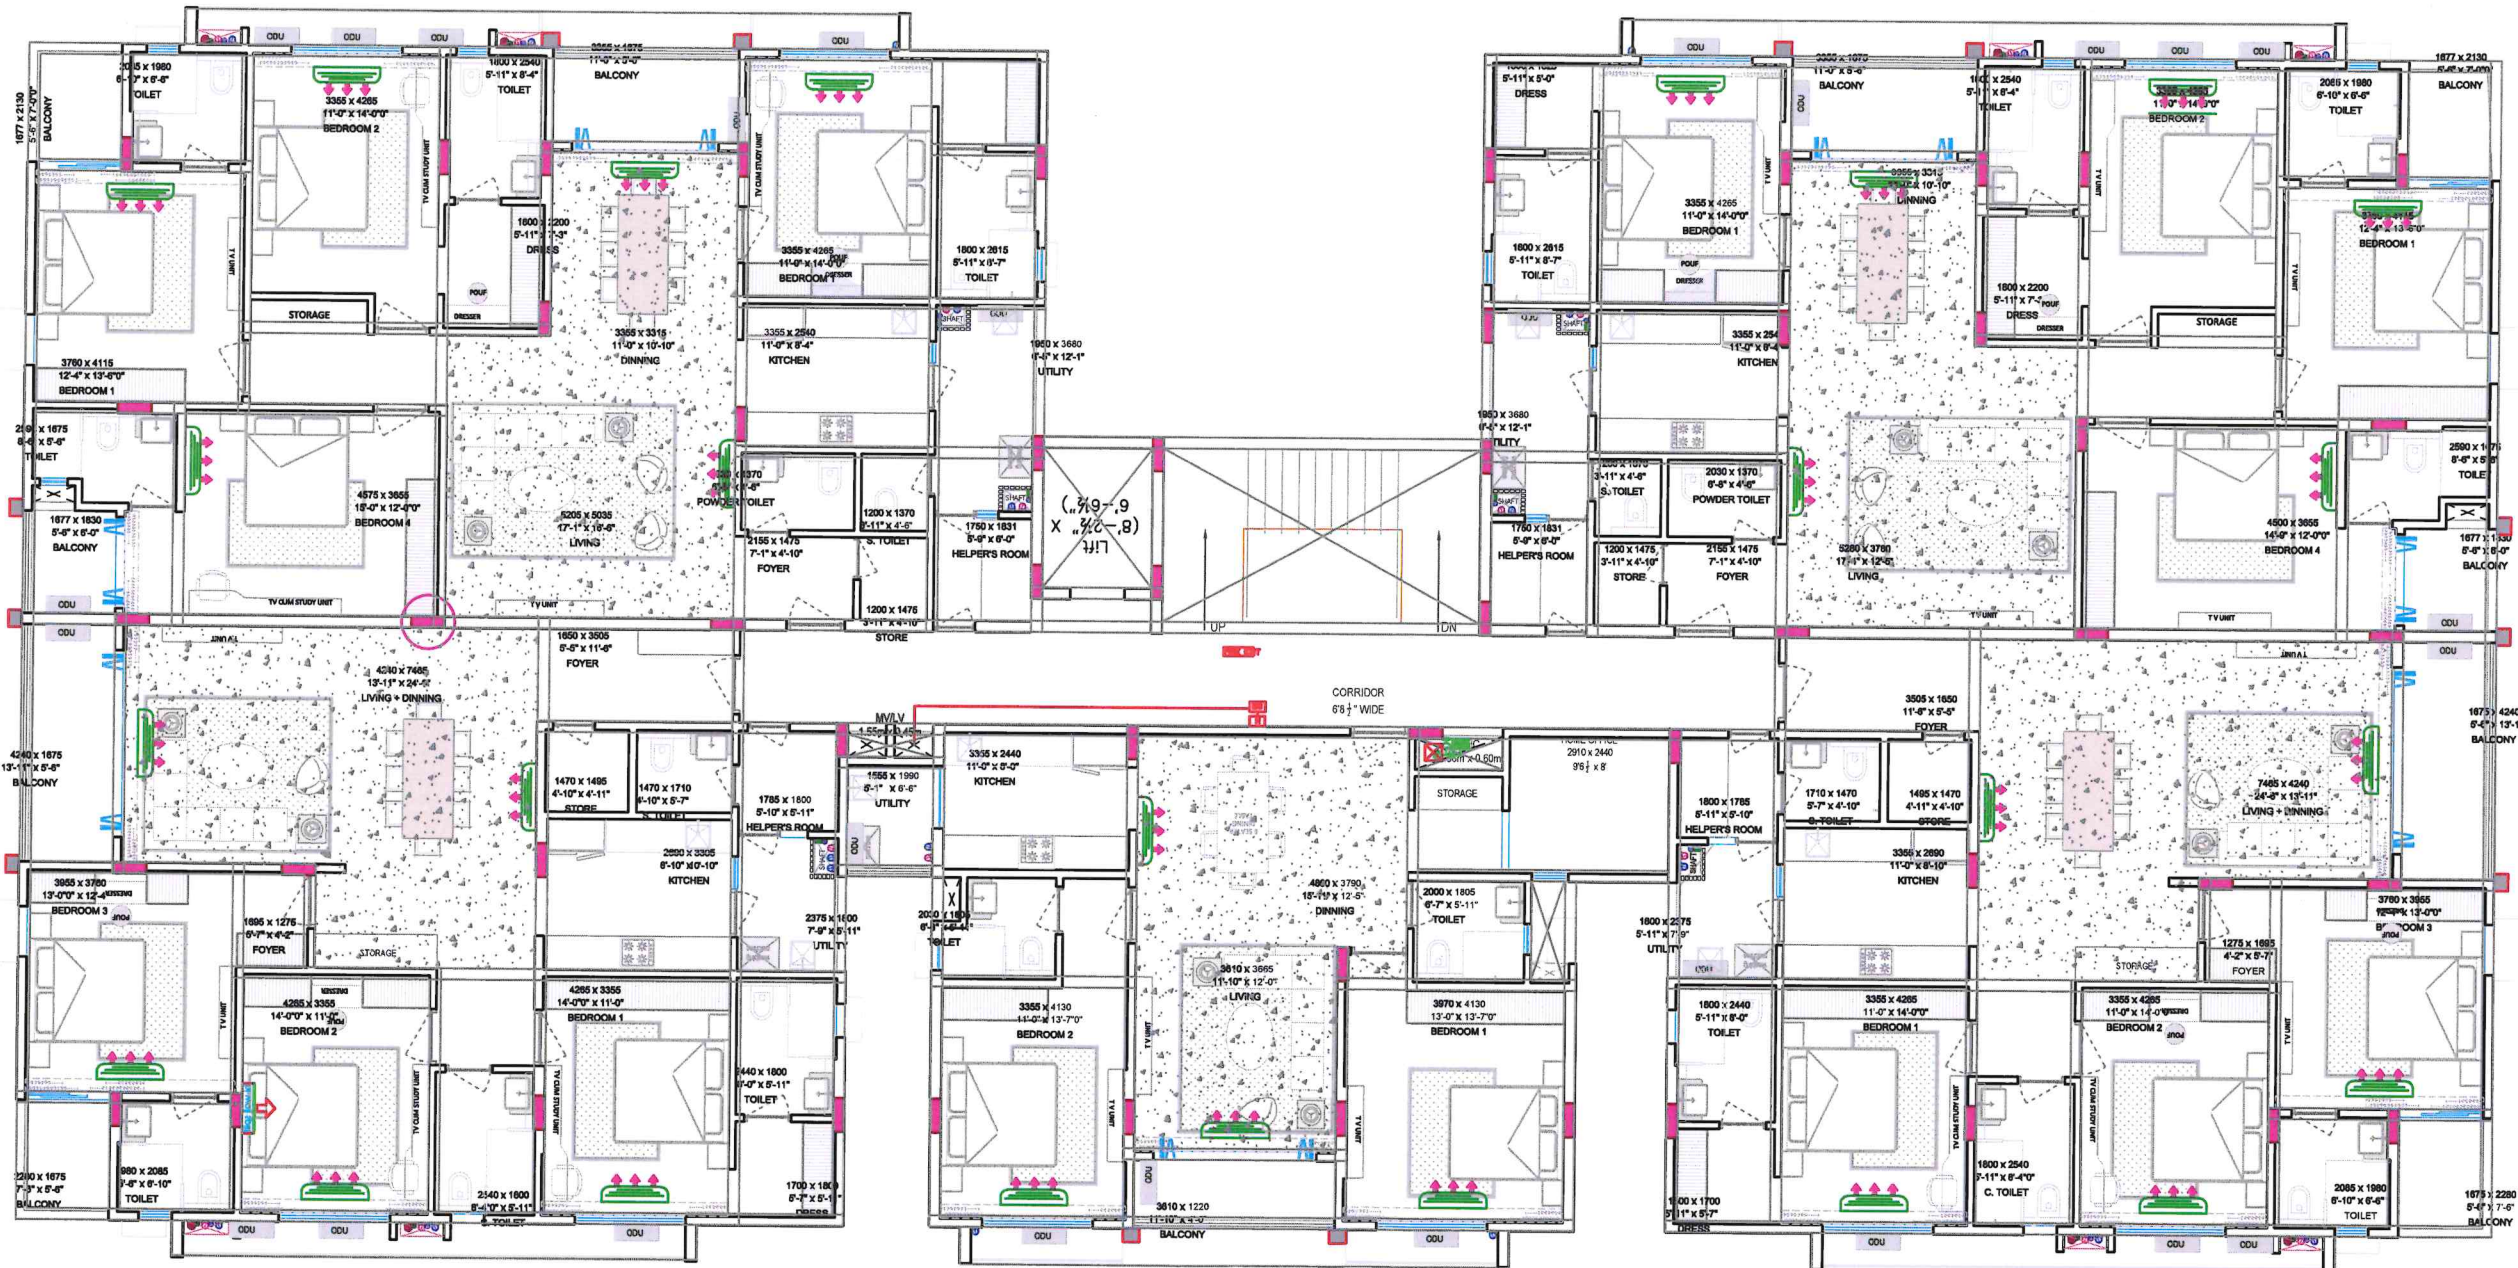

3BHK UNIT+ SERV.
BUA- 1760 sq ft
SBUA @25% LOADING - 2200 sq ft

2 BHK
BUA- 1192 sq ft
SBUA @25% LOADING - 1490 sq ft

3BHK UNIT+ SERV.
BUA- 1760 sq ft
SBUA @25% LOADING - 2200 sq ft



Praveen
PRAVEEN KUMAR
BTECH (ELECT)

For AKSHAT APARTMENTS PVT. LTD.

(SUNIL JAIN)
Director
DIN: 00155259


PROJECT :
AKSHAT KANOTA
ESTATES.JAIPUR.

ELECTRICAL CONSULTANT:

SRAJAN ASSOCIATES
C-SCHEME, JAIPUR
Email :- snajipur@hotmail.com

ARCHITECTS:-
m | a | r | c | h | i | t | e | c | t | s | p | v | t . l | t | d .

Jaipur - Bangalore - Hyderabad
Plot No. -1, greenwoods, Lal Kothi Scheme,
Jaipur-302001
Tel- 91 141 4299999
email - studio@maarchitects.in
web - www.maarchitects.in

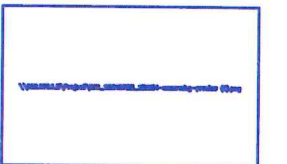

LEGEND			
NO	DESCRIPTION	SYMBOL	QTY
1.	HEAT DETECTOR		NIL
2.	SMOKE DETECTOR		NIL
3.	MANUAL CALL POINT		01 NOS
4.	ROOPER		01 NOS
6.	23MM MMS CONDUIT		01 NOS
7.	SELF LUMINOUS GLOW SIGN BOARD		01 NOS
8.	FIRE HYDRANT		01 NOS
9.	1000 FIRE FIGHTING MMS PIPE		NIL
10.	FIRE BRIGADE INLET CONNECTION		NIL
11.	EXTERNAL FIREHYDRANT		NIL
12.	FIRE ALARM PANEL		NIL

DRG BY :

RAHMAN

NORTH:



CHECKED BY :

AK

DATE :
29-04-2025

SCALE :
1:100

Drawing Title :

AKSHAT KANOTA PLOT NO.-04
TYPICAL FLOOR FIRE
FIGHTING RERA
SUBMISSION PLAN

PROJECT NO:


TS-5105

REV. NO.

01

Drawing No.

SA/MA/22/111

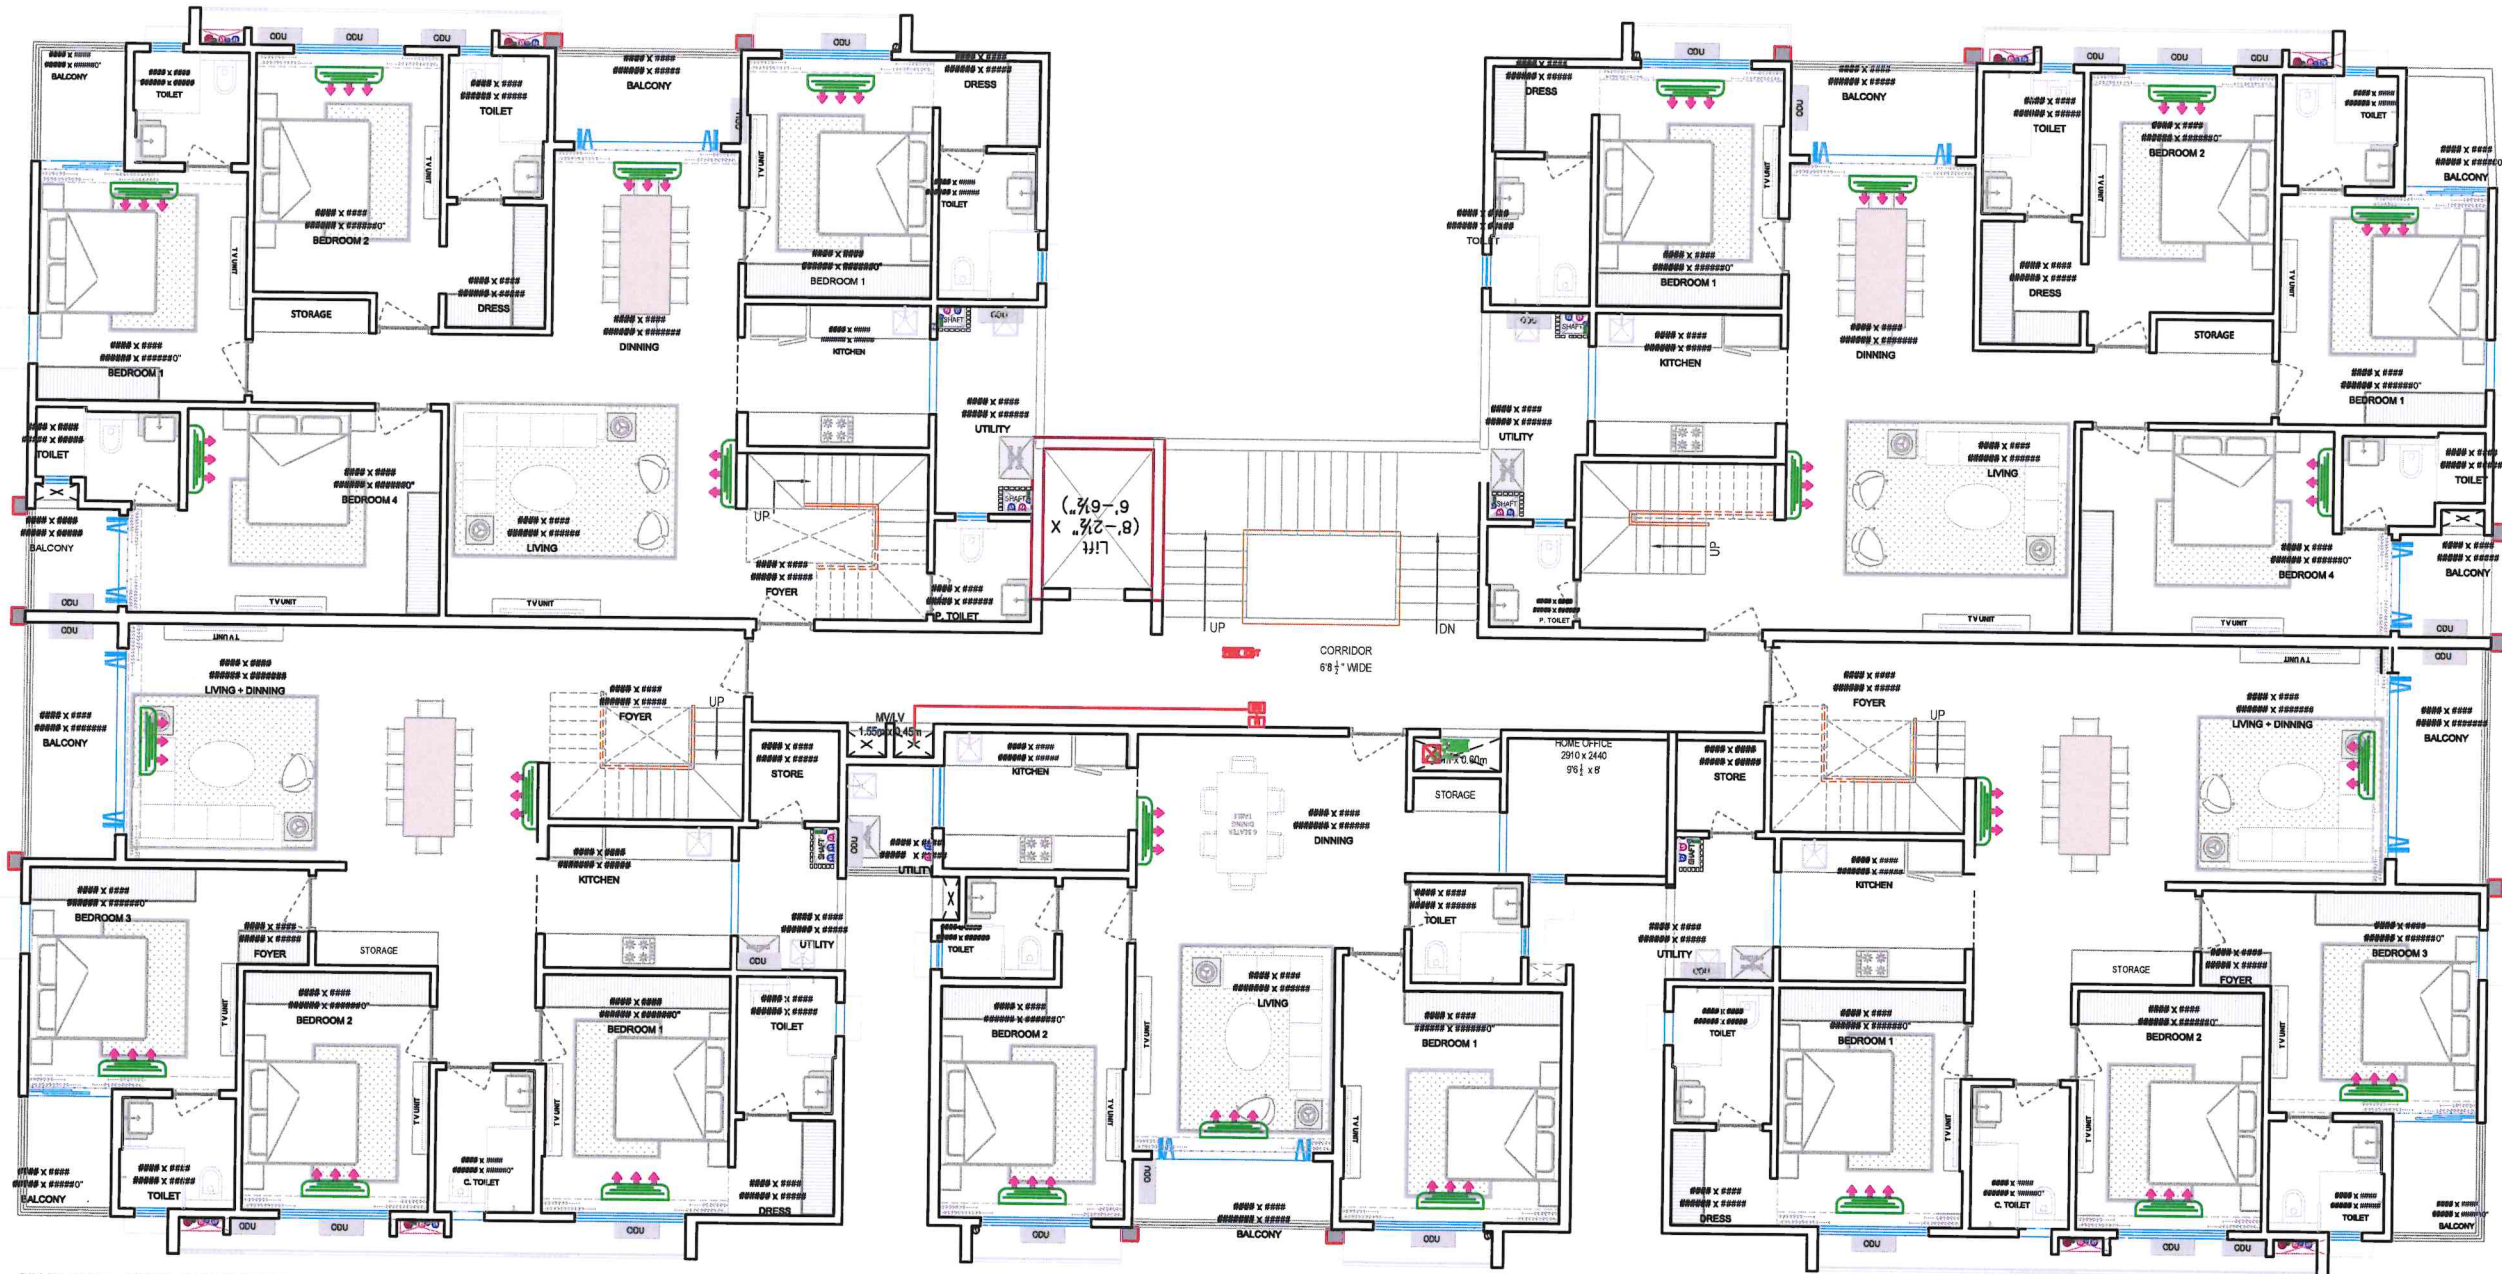

3BHK UNIT+ SERV. PENTHOUSE
BUA- 1748 sq ft
SBUA @25% LOADING - 2185 sq ft

2 BHK
BUA- 1192 sq ft
SBUA @25% LOADING - 1490 sq ft

3BHK UNIT+ SERV. PENTHOUSE
BUA- 1748 sq ft
SBUA @25% LOADING - 2185 sq ft



Praveen
PRAVEEN KUMAR
BTECH (ELECT)

For AKSHAT APARTMENTS PVT. LTD.

(SUNIL JAIN)
Director
DIN: 00155259


PROJECT :
AKSHAT KANOTA
ESTATES.JAIPUR.

ELECTRICAL CONSULTANT:

SRAJAN ASSOCIATES
C-SCHEME, JAIPUR
Email :- snajaipur@hotmail.com

ARCHITECTS:-
m|a|architects pvt.ltd.

Jaipur - Bangalore - Hyderabad
Plot No.-1, greenwoods, Lal Kothi Scheme,
Jaipur-302001
Tel : 91 141 4299999
email - studio@maarchitects.in
web - www.maarchitects.in

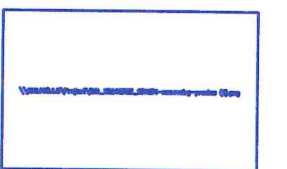

LEGEND			
NO	DESCRIPTION	SYMBOL	QTY
1.	HEAT DETECTOR		NIL
2.	SMOKE DETECTOR		NIL
3.	MANUAL CALL POINT		01 NOS
5.	ROOFER		01 NOS
6.	25MM MS CONDUIT		01 NOS
7.	SELF LUMINOUS GLOW SIGN BOARD		01 NOS
8.	FIRE HYDRANT		01 NOS
9.	1000 FIRE FIGHTING AIR PIPE		NIL
10.	FIRE BRIDE ASIDE DIET CONNECTION		NIL
11.	EXTERNAL FIRE HYDRANT		NIL
12.	FIRE ALARM PANEL		NIL

DWG BY :
RAHMAN

CHECKED BY :
AK

DATE :
29-04-2025

Drawing Title :

AKSHAT KANOTA PLOT NO.-04
LOWER PENT HOUSE
FLOOR FIRE FIGHTING
RERA SUBMISSION PLAN

PROJECT NO:
TS-5105

REV. NO.
01

Drawing No.

SA/MA/22/112