

SPECIFICATION:-

1. THIS DRAWING IS THE PROPERTY OF **CARYATID ARCHITECTS** AND SHALL NOT BE USED OR PRODUCE IN ANY MANNER WITHOUT HIS WRITTEN PERMISSION.
2. DIMENSIONS ON THE DRAWINGS ARE TO BE READ NOT SCALED.
3. THE EXECUTING AGENCY IS REQUIRED TO CORRELATE ALL RELEVANT DRAWINGS AND ANY ERRORS OR DISCREPANCIES ARE TO BE BROUGHT TO THE NOTICE OF **CARYATID ARCHITECTS** BEFORE COMMENCE OF WORK

Mounting Height	ID	SYMBOL	DESCRIPTION
IN RCC SLAB	CONDUIT		Rigid PVC Conduit 25mm/1.0 sqmm wire for Light points
IN RCC SLAB	CONDUIT		Rigid PVC Conduit 25mm/2.5 sqmm wire for POWER Circuits
IN RCC SLAB	CONDUIT		Rigid PVC Conduit 25mm/4.00 sqmm wire for POWER Circuits
IN RCC SLAB	CONDUIT		Submain wire to Common & Flats DB from Main Panel on Ground Floor in 1 nos. 32 mm dia conduits
CEILING	FAN/48"		CEILING FAN 48"
CEILING	FAN/30"		CEILING FAN 30"
CEILING	CH1		CHANDELIER
CEILING	CL		LED 6" DOWNLIGHTER 20W (SURFACE MOUNTED) MAKE SYSCA LED CAT NO SDL-15W GLD 6.5K/4K
+90"	TL/W		LED WALL TUBE LIGHT MAKE SYSCA LED CAT NO SDL-15W GLD 6.5K/4K
+90"	CFL		LED WALL TUBE LIGHT MAKE SYSCA LED CAT NO SDL-15W GLD 6.5K/4K
+90"	GL		WALL BRACKETS GANESH LIGHT AS PER DESIGN
+24"	SB (BS)		SWITCH BOARD (BED SIDE)
+42"	SB		SWITCH BOARD
+78"	ML		10X2 LED MIRROR LIGHT CAT NO. - PPS - 12523
VENTILATOR HT.	CR		CEILING ROSE
VENTILATOR HT.	EXF		9" DIA FRESH AIR FAN
+24"	TEL		TELEPHONE POINT
+48"	TV		TV COAXIAL POINT.
+24"	LP		6 A PLUG POINT
+48"	LP-TV		6 A PLUG POINT FOR TV
+72"	LP-CH		6 A PLUG POINT FOR CHIMNEY
+42"	PP-MIX		15 A POWER POINT FOR MIXER
+42"	PP-MIC		15 A POWER POINT FOR MICROWAVE
+78"	PP-G		15 A POWER POINT FOR GEYSER
+54"	PP-F		15 A POWER POINT FOR FRIDGE
+78"	PP-WP		15 A POWER POINT FOR WATER PURIFIER
+48"	PP-WM		15 A POWER POINT FOR WASHING MACHINE
+18"	PP-INV.		15 A POWER POINT FOR INVERTER
+24"	LP		6 A PLUG POINT
+90"	SP		SPLIT AC INDOOR UNIT
+60"	BP		6 A BELL PUSH
+90"	BZ		BUZZER FOR CALL BELL
+60"	MCB DB		MCB DISTRIBUTION BOARD

PROJECT TITLE:-

AFFORDABLE HOUSING SCHEME
Khasra no. 36/2 of Village - Badgaon,
Tehsil - Sheoganj, Distt. - Sirahi

CONSULTANTS:-

CHECKED BY:-

Rishabh Sharma

SIGNATURE:-

DRAWN BY:-

Parmesver

SCALE:-

N.T.S.

DATE:-

2025

SHEET:-


01

SHEET TITLE:-

EWS UNIT G.F. ELECTRICAL DRAWING

caryatid
architects & consultants

caryatidjaipur@gmail.com
96020-86971

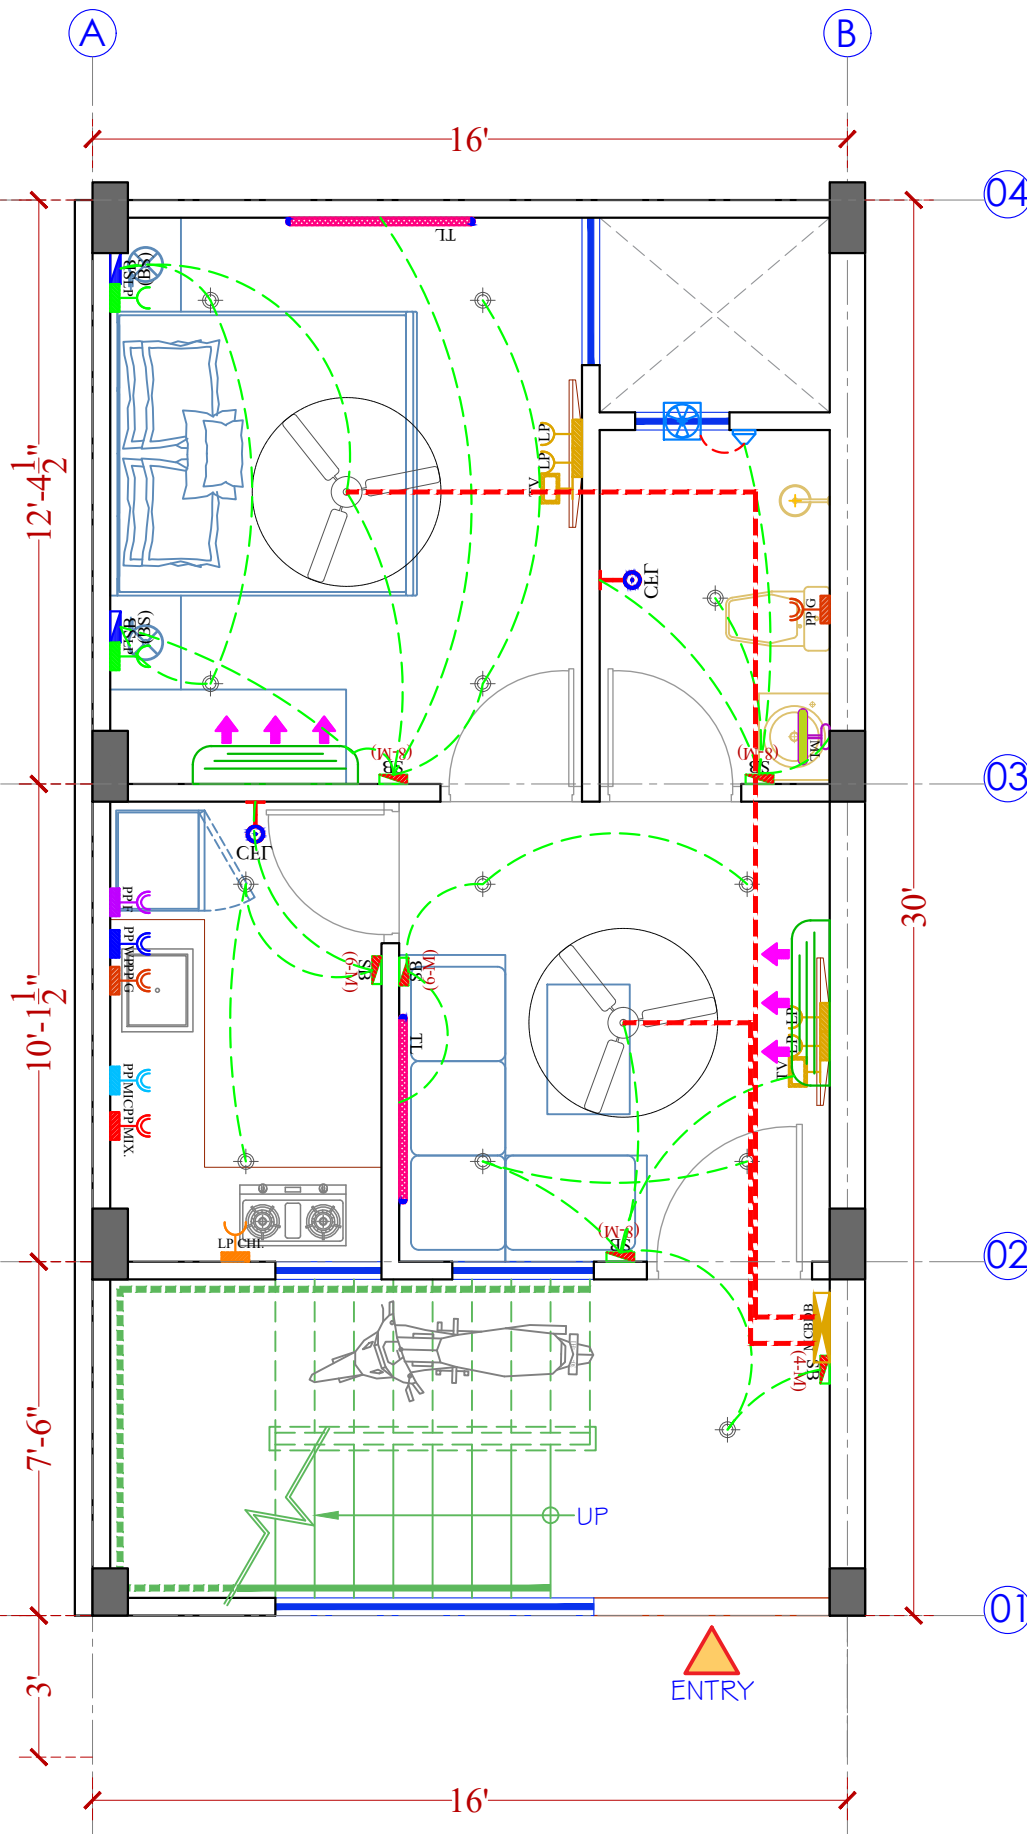


ENTRY

दिव्याजीत मारीठिया
DIVYAJEET MAROTHIYA
(IEI)
CHARTERED ENGINEER (CIVIL)
AM 3007165

SPECIFICATION:-

- THIS DRAWING IS THE PROPERTY OF **CARYATID ARCHITECTS** AND SHALL NOT BE USED OR PRODUCE IN ANY MANNER WITHOUT HIS WRITTEN PERMISSION.
- DIMENSIONS ON THE DRAWINGS ARE TO BE READ NOT SCALED.
- THE EXECUTING AGENCY IS REQUIRED TO CORRELATE ALL RELEVANT DRAWINGS AND ANY ERRORS OR DISCREPANCIES ARE TO BE BROUGHT TO THE NOTICE OF **CARYATID ARCHITECTS** BEFORE COMMENCE OF WORK

Mounting Height	ID	SYMBOL	DESCRIPTION
IN RCC SLAB	CONDUIT		Rigid PVC Conduit 25mm/1.0 sqmm wire for Light points
IN RCC SLAB	CONDUIT		Rigid PVC Conduit 25mm/2.5 sqmm wire for Light Circuits
IN RCC SLAB	CONDUIT		Rigid PVC Conduit 25mm/4.00 sqmm wire for POWER Circuits
IN RCC SLAB	CONDUIT		Submain wire to Common & Flats DB from Main Panel on Ground Floor in 1 nos. 32 mm dia conduits
CEILING	FAN48"		CEILING FAN 48"
CEILING	FAN30"		CEILING FAN 30"
CEILING	CHI		CHANDLIER
CEILING	CL		LED 6" DOWNLIGHTER 20W (SURFACE MOUNTED) MAKE SYSCA LED CAT NO. SSC-20B-4-CK-GR
+90°	TL/W		LED WALL TUBE LIGHT MAKE SYSCA LED CAT NO. SSC-25-20W
+90°	CFL		LED BULB 20W MAKE SYSCA LED CAT NO. SSC-20B-4-CK-GR
+90°	GL		WALL BRACKETS GANESH LIGHT AS PER DESIGN
+24"	SB (BS)		SWITCH BOARD (RED SIDE)
+42"	SB		SWITCH BOARD
+78"	ML		LED LED DOWNLIGHT MAKE SYSCA LED CAT NO. SSC-20B-4-CK-GR
VENTILATOR HT	CR		CEILING ROSE
VENTILATOR HT	EXF		9" DIA FRESH AIR FAN
+24"	TEL		TELEPHONE POINT
+48"	TV		TV COAXIAL POINT
+24"	LP		6 A PLUG POINT
+48"	LP TV		6 A PLUG POINT FOR TV
+72"	LP-CH		6 A PLUG POINT FOR CHIMNEY
+42"	PP-MIX		15 A POWER POINT FOR MIXER
+42"	PP-MIC		15 A POWER POINT FOR MICROWAVE
+78"	PP-G		15 A POWER POINT FOR GEYSER
+54"	PP-F		15 A POWER POINT FOR FRIDGE
+78"	PP-WP		15 A POWER POINT FOR WATER PURIFIER
+48"	PP-WM		15 A POWER POINT FOR WASHING MACHINE
+18"	PP-INV.		15 A POWER POINT FOR INVERTER
+24"	LP		6 A PLUG POINT
+90°	SP		SPLIT AC INDOOR UNIT
+60"	BP		6 A BELL PUSH
+90°	BZ		BELL FOR CALL BELL
+60"	MCB DB		MCB DISTRIBUTION BOARD

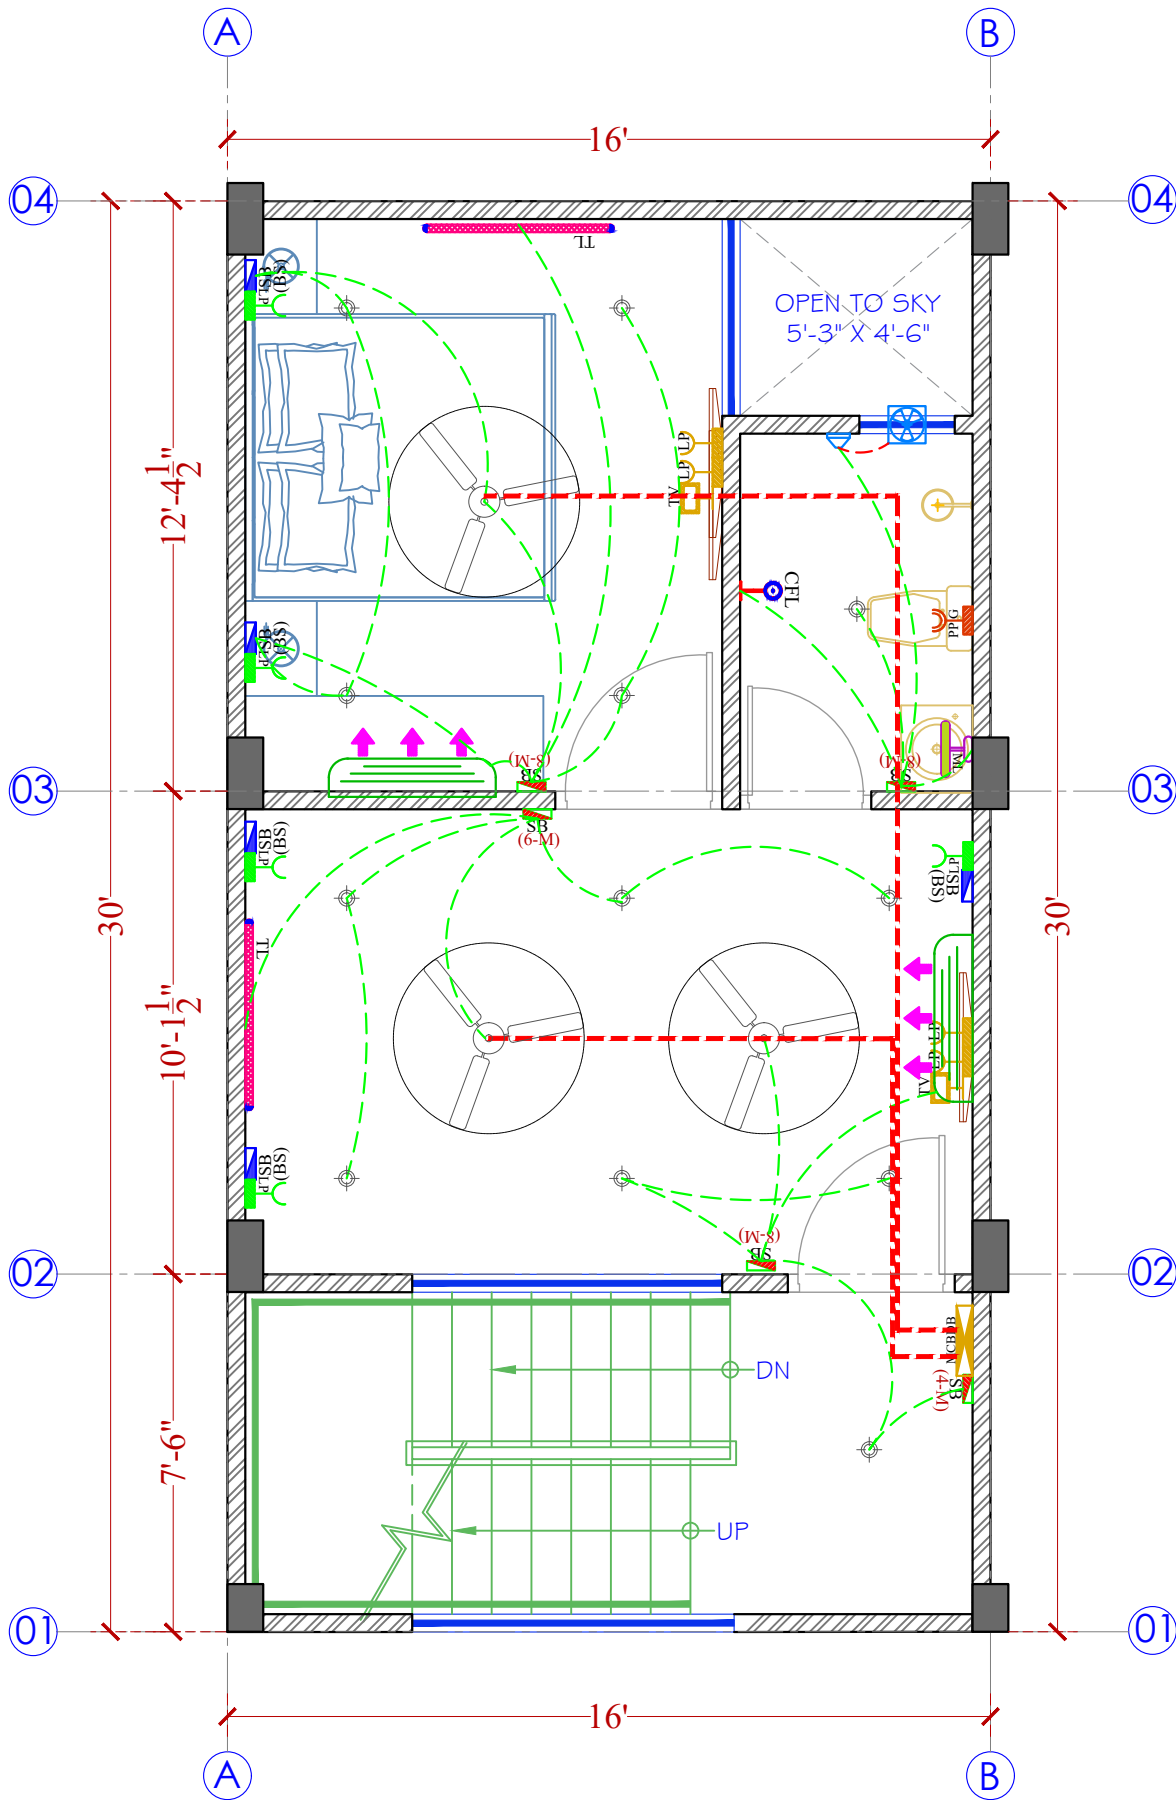

दिव्यजीत मरोथिया
DIVYAJEET MAROTHIYA
(IEI)
CHARTERED ENGINEER (CIVIL)
AM 3007165

PROJECT TITLE:-

AFFORDABLE HOUSING SCHEME
Khasra no. 36/2 of Village - Badgaon,
Tehsil - Sheoganj, Distt. - Sirahi
CONSULTANTS:-

CHECKED BY:-

Rishabh Sharma

DRAWN BY:-

Parnesver

SIGNATURE:-

N.T.S.

DATE:- 14/08/2025

SHEET:-

NORTH

SHEET TITLE:-

EWS FIRST FLOOR ELECTRICAL DRAWING


caryatid
architects & consultants
caryatidjaipur@gmail.com
96020-86971

SPECIFICATION:-

1. THIS DRAWING IS THE PROPERTY OF **CARYATID ARCHITECTS** AND SHALL NOT BE USED OR PRODUCE IN ANY MANNER WITHOUT HIS WRITTEN PERMISSION.
2. DIMENSIONS ON THE DRAWINGS ARE TO BE READ NOT SCALED.
3. THE EXECUTING AGENCY IS REQUIRED TO CORRELATE ALL RELEVANT DRAWINGS AND ANY ERRORS OR DISCREPANCIES ARE TO BE BROUGHT TO THE NOTICE OF **CARYATID ARCHITECTS** BEFORE COMMENCE OF WORK

SYMBOL	LEGEND
	CHANDILLIER
	CEILING FAN
	CONCEALED LIGHT
	METER BOX
	MCB BOX
	CCTV CAMERA

PROJECT TITLE:-		
AFFORDABLE HOUSING SCHEME		
Khasra no. 36/2 of Village - Badgaon, Tehsil - Sheoganj, Distt. - Sirahi		
CONSULTANTS:-		
CHECKED BY:-	DRAWN BY:-	
Rishabh Sharma	Parmesver	
SIGNATURE:-	SCALE:-	DATE:-
	N.T.S.	14/04/2025
	NORTH	SHEET:-
		
SHEET TITLE:-		
EWS UNIT G.F.ELECTRICAL CONDUCTED PLAN		
 architects & consultants caryatidjaipur@gmail.com 96020-86971		

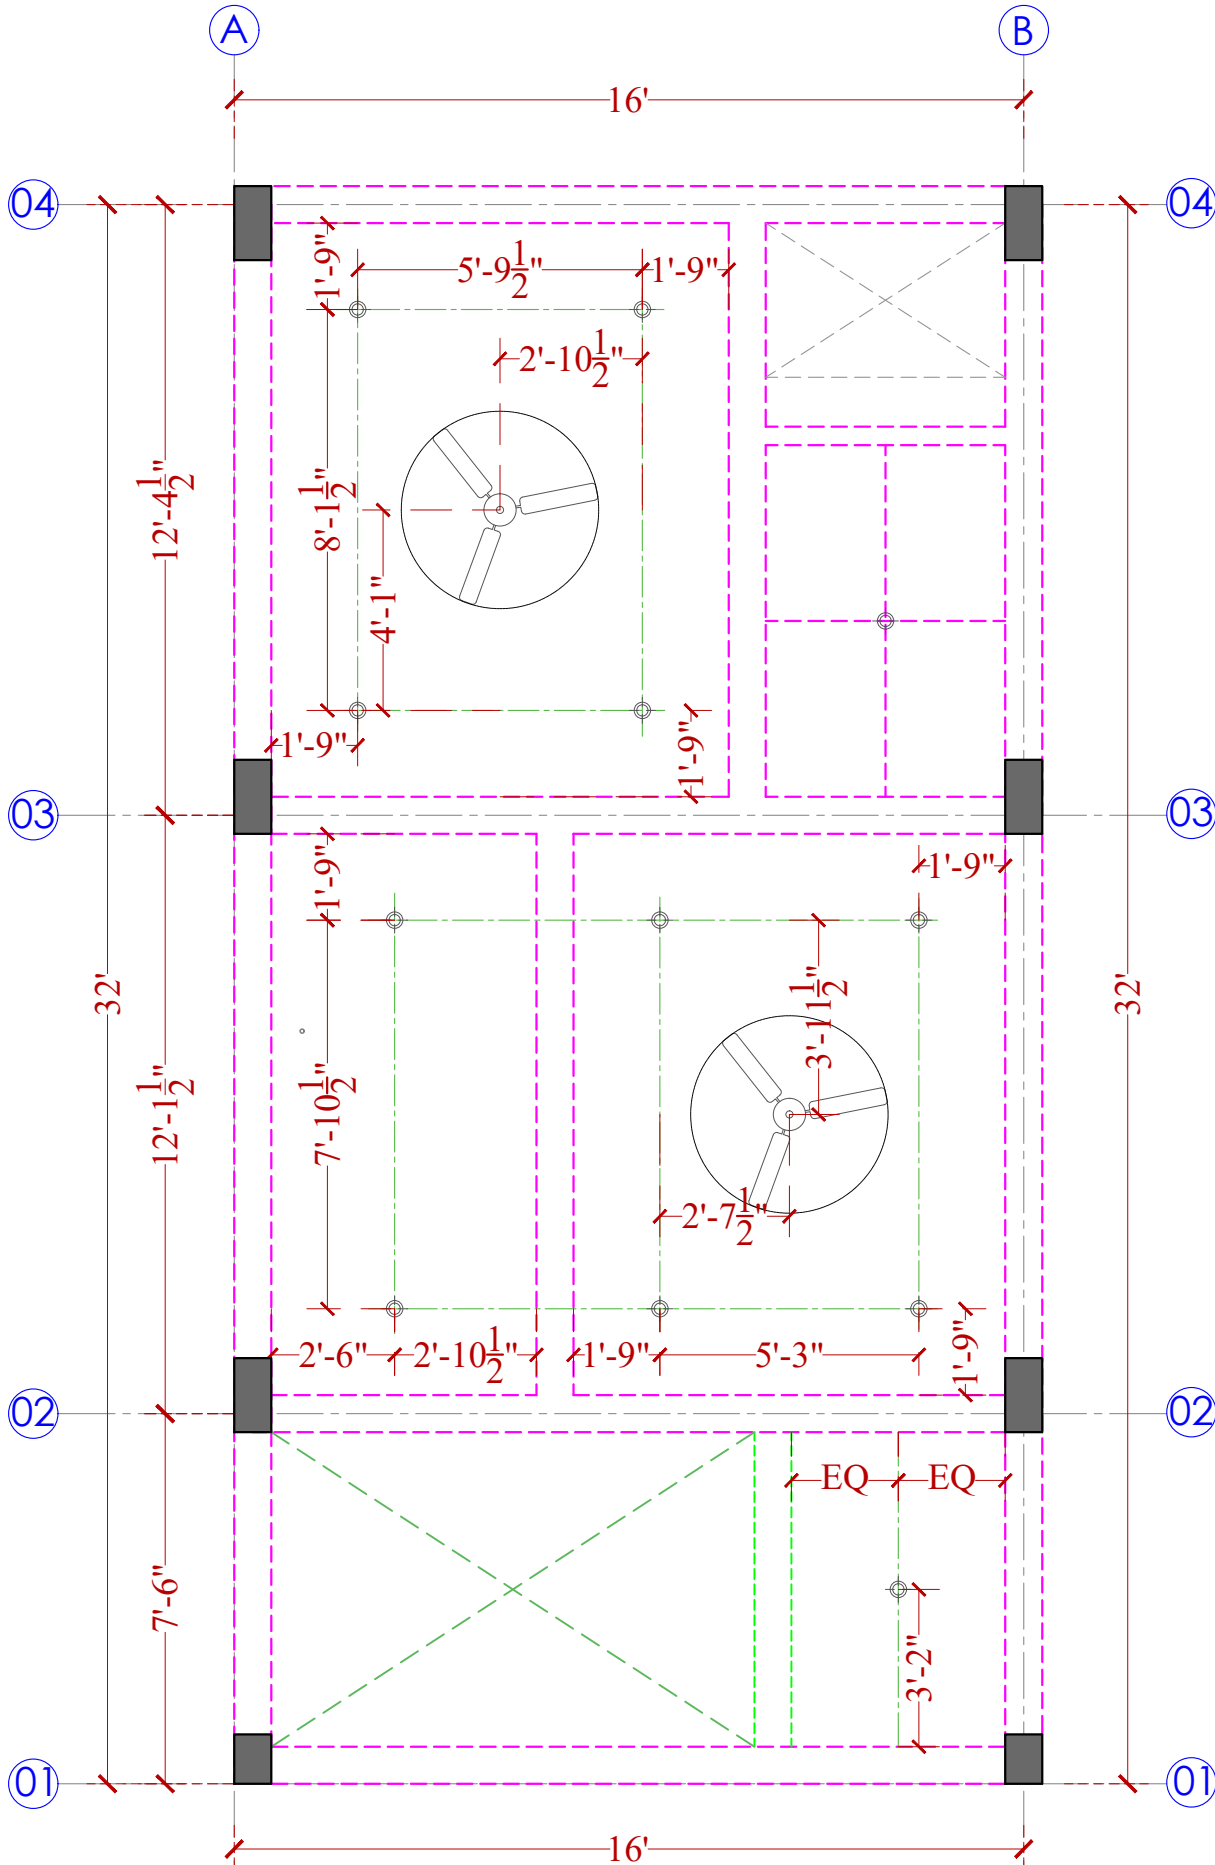


दिव्यजीत मरोथिया
DIVYAJEET MAROTHIYA
 (IEI)
 CHARTERED ENGINEER (CIVIL)
 AM 3007165

SPECIFICATION:-

1. THIS DRAWING IS THE PROPERTY OF **CARYATID ARCHITECTS** AND SHALL NOT BE USED OR PRODUCE IN ANY MANNER WITHOUT HIS WRITTEN PERMISSION.
2. DIMENSIONS ON THE DRAWINGS ARE TO BE READ NOT SCALED.
3. THE EXECUTING AGENCY IS REQUIRED TO CORRELATE ALL RELEVANT DRAWINGS AND ANY ERRORS OR DISCREPANCIES ARE TO BE BROUGHT TO THE NOTICE OF **CARYATID ARCHITECTS** BEFORE COMMENCE OF WORK

SYMBOL	LEGEND
	CHANDILLIER
	CEILING FAN
	CONCEALED LIGHT
	METER BOX
	MCB BOX
	CCTV CAMERA

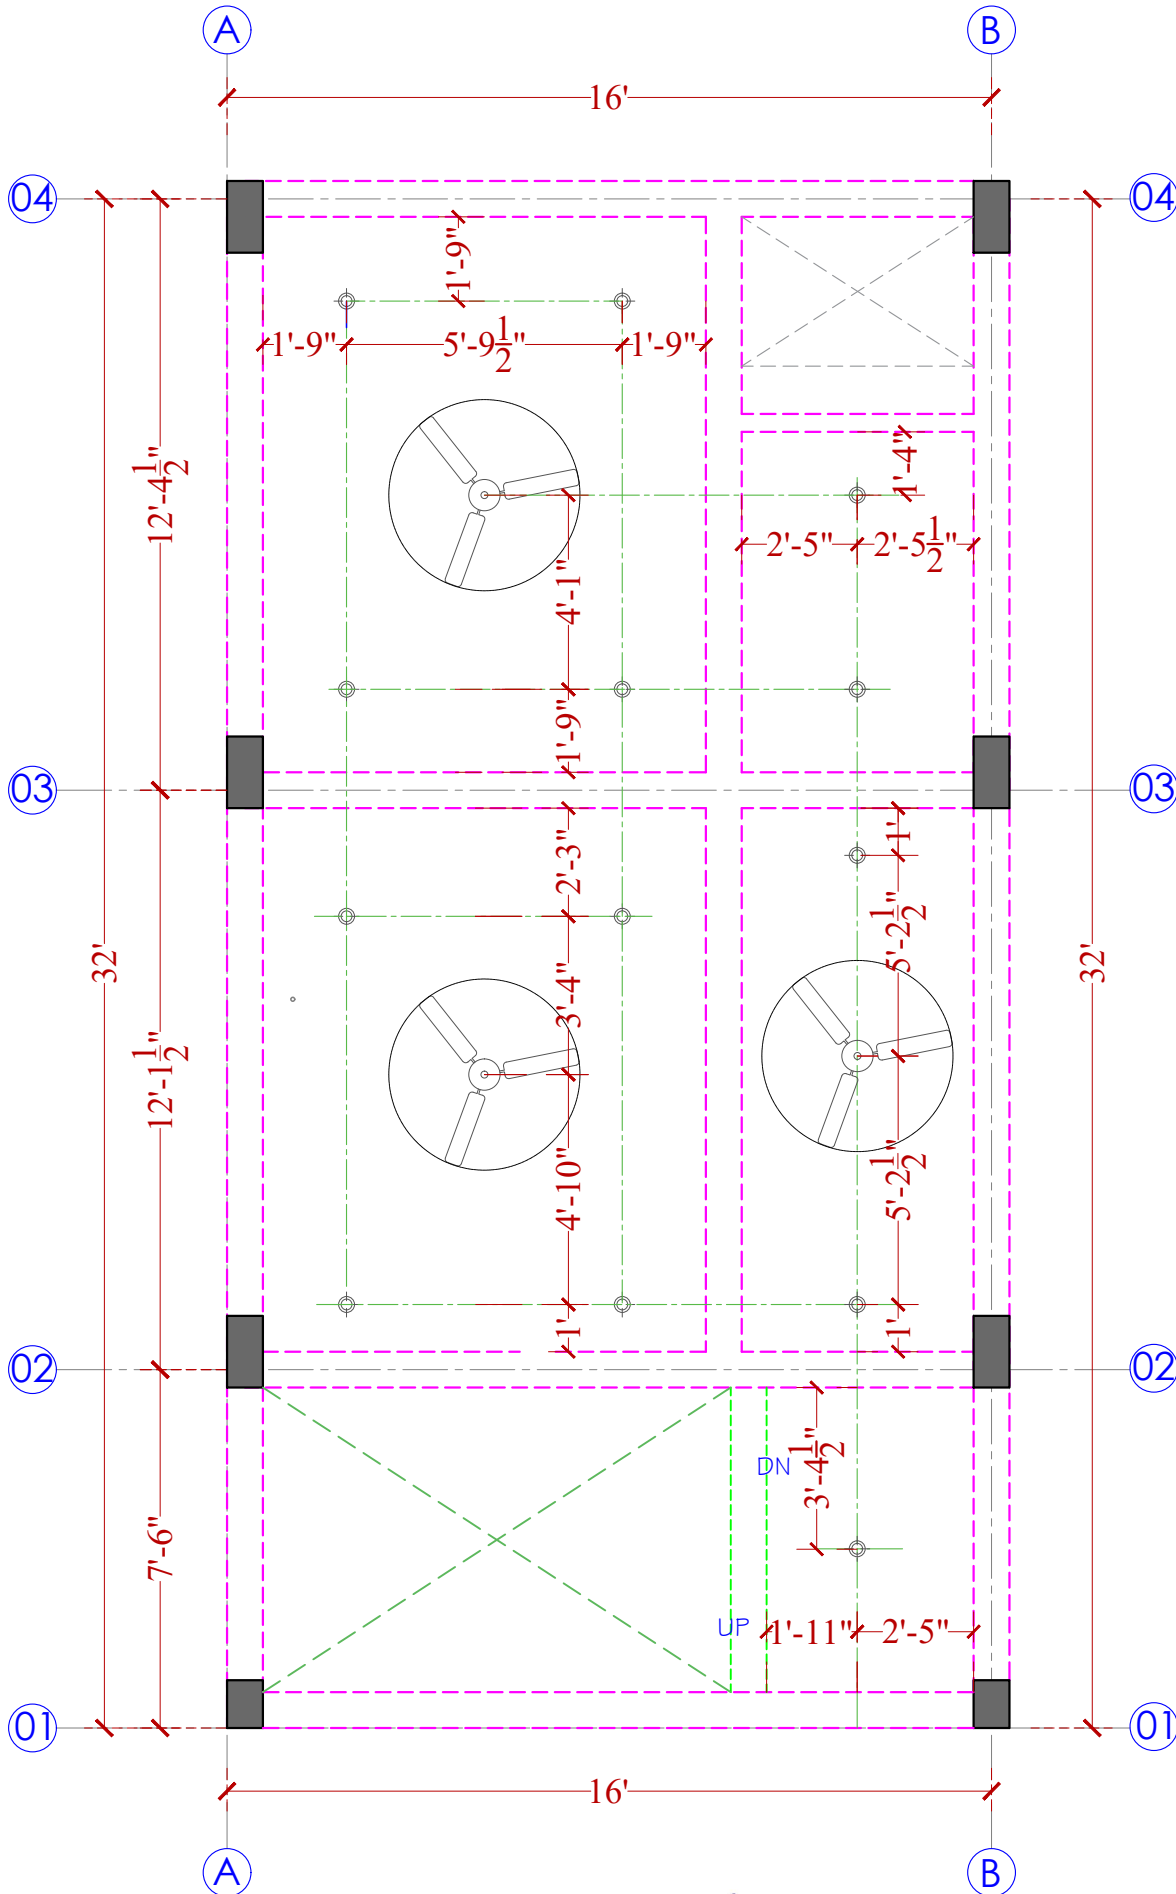

दिव्याजीत मरोठिया
DIVYAJEET MAROTHIYA
 (IEI)
 CHARTERED ENGINEER (CIVIL)
 AM 3007165

PROJECT TITLE:-
AFFORDABLE HOUSING SCHEME
 Kharsa no. 36/2 of Village - Badgaon,
 Tehsil - Sheoganj, Distt. - Sirohi
CONSULTANTS:-

CHECKED BY:- Rishabh Sharma	DRAWN BY:- Parmesver
SIGNATURE:-	SCALE:- N.T.S.
	DATE:- 11/08/2025
	SHEET:-

SHEET TITLE:-
EW'S UNIT FIRST FLOOR ELECTRICAL CONDUCTED PLAN

 architects & consultants
 caryatidjaipur@gmail.com
 96020-86971

SPECIFICATION:-

- THIS DRAWING IS THE PROPERTY OF **CARYATID ARCHITECTS** AND SHALL NOT BE USED OR PRODUCE IN ANY MANNER WITHOUT HIS WRITTEN PERMISSION.
- DIMENSIONS ON THE DRAWINGS ARE TO BE READ NOT SCALED.
- THE EXECUTING AGENCY IS REQUIRED TO CORRELATE ALL RELEVANT DRAWINGS AND ANY ERRORS OR DISCREPANCIES ARE TO BE BROUGHT TO THE NOTICE OF **CARYATID ARCHITECTS** BEFORE COMMENCE OF WORK

Mounting Height	ID	SYMBOL	DESCRIPTION
IN RCC SLAB	CONDUIT		Rigid PVC Conduit 25mm/1.0 sqmm wire for Light points
IN RCC SLAB	CONDUIT		Rigid PVC Conduit 25mm/2.5 sqmm wire for Light Circuits
IN RCC SLAB	CONDUIT		Rigid PVC Conduit 25mm/400 sqmm wire for POWER Circuits
IN RCC SLAB	CONDUIT		Submain wire to Common & Flats DB from Main Panel on Ground Floor in 1 nos. 32 mm dia conduits
CEILING	FAN/48"		CEILING FAN 48"
CEILING	FAN/30"		CEILING FAN 30"
CEILING	CH1		CHANDELLER
CEILING	CL		LED 6" DOWNLIGHTER 20W (SURFACE MOUNTED) MAKE SYSKA LED CAT NO STD-15W GLD 6-46-4K
+90"	TL/W		LED WALL FUSE LIGHT MAKE SYSKA LED CAT NO STD-25-20W
+90"	CFL		LED BULB 20W MAKE SYSKA LED CAT NO STD-25-20W
+90"	GL		WALL BRACKETS GANESH LIGHT AS PER DESIGN
+24"	SB (BS)		SWITCH BOARD (RED SIDE)
+42"	SB		SWITCH BOARD
+78"	ML		15x24 LED MIRROR LIGHT MAKE SYSKA LED CAT NO STD-15x24
VENTILATOR HTL	CR		CEILING ROSE
VENTILATOR HTL	EXF		9" DIA FRESH AIR FAN
+24"	TEL		TELEPHONE POINT
+48"	TV		TV COAXIAL POINT
+24"	LP		6 A PLUG POINT
+48"	LP TV		6 A PLUG POINT FOR TV
+72"	LP-CH		6 A PLUG POINT FOR CHIMNEY
+42"	PP-MIX		15 A POWER POINT FOR MIXER
+42"	PP-MIC		15 A POWER POINT FOR MICROWAVE
+78"	PP-G		15 A POWER POINT FOR GEYSER
+54"	PP-F		15 A POWER POINT FOR FRIDGE
+78"	PP-WP		15 A POWER POINT FOR WATER PURIFIER
+48"	PP-WM		15 A POWER POINT FOR WASHING MACHINE
+18"	PP-INV		15 A POWER POINT FOR INVERTER
+24"	LP		6 A PLUG POINT
+90"	SP		SPLIT AC INDOOR UNIT
+60"	BP		6 A BELL PUSH
+90"	BZ		BUZZER FOR CALL BELL
+60"	MCB DB		MCB DISTRIBUTION BOARD

PROJECT TITLE:-

AFFORDABLE HOUSING SCHEME
Khasra no. 36/2 of Village - Badgaon,
Tehsil - Sheoganj, Distt. - Sirahi

CONSULTANTS:-

CHECKED BY:-

Rishabh Sharma

SIGNATURE:-

DRAWN BY:-

Parnesver

SCALE:-

N.T.S.

DATE:-

14/04/2025


SHEET:-

01

SHEET TITLE:-

EWS UNIT G.F. ELECTRICAL DRAWING

caryatid
architects & consultants
caryatidjaipur@gmail.com
96020-86971

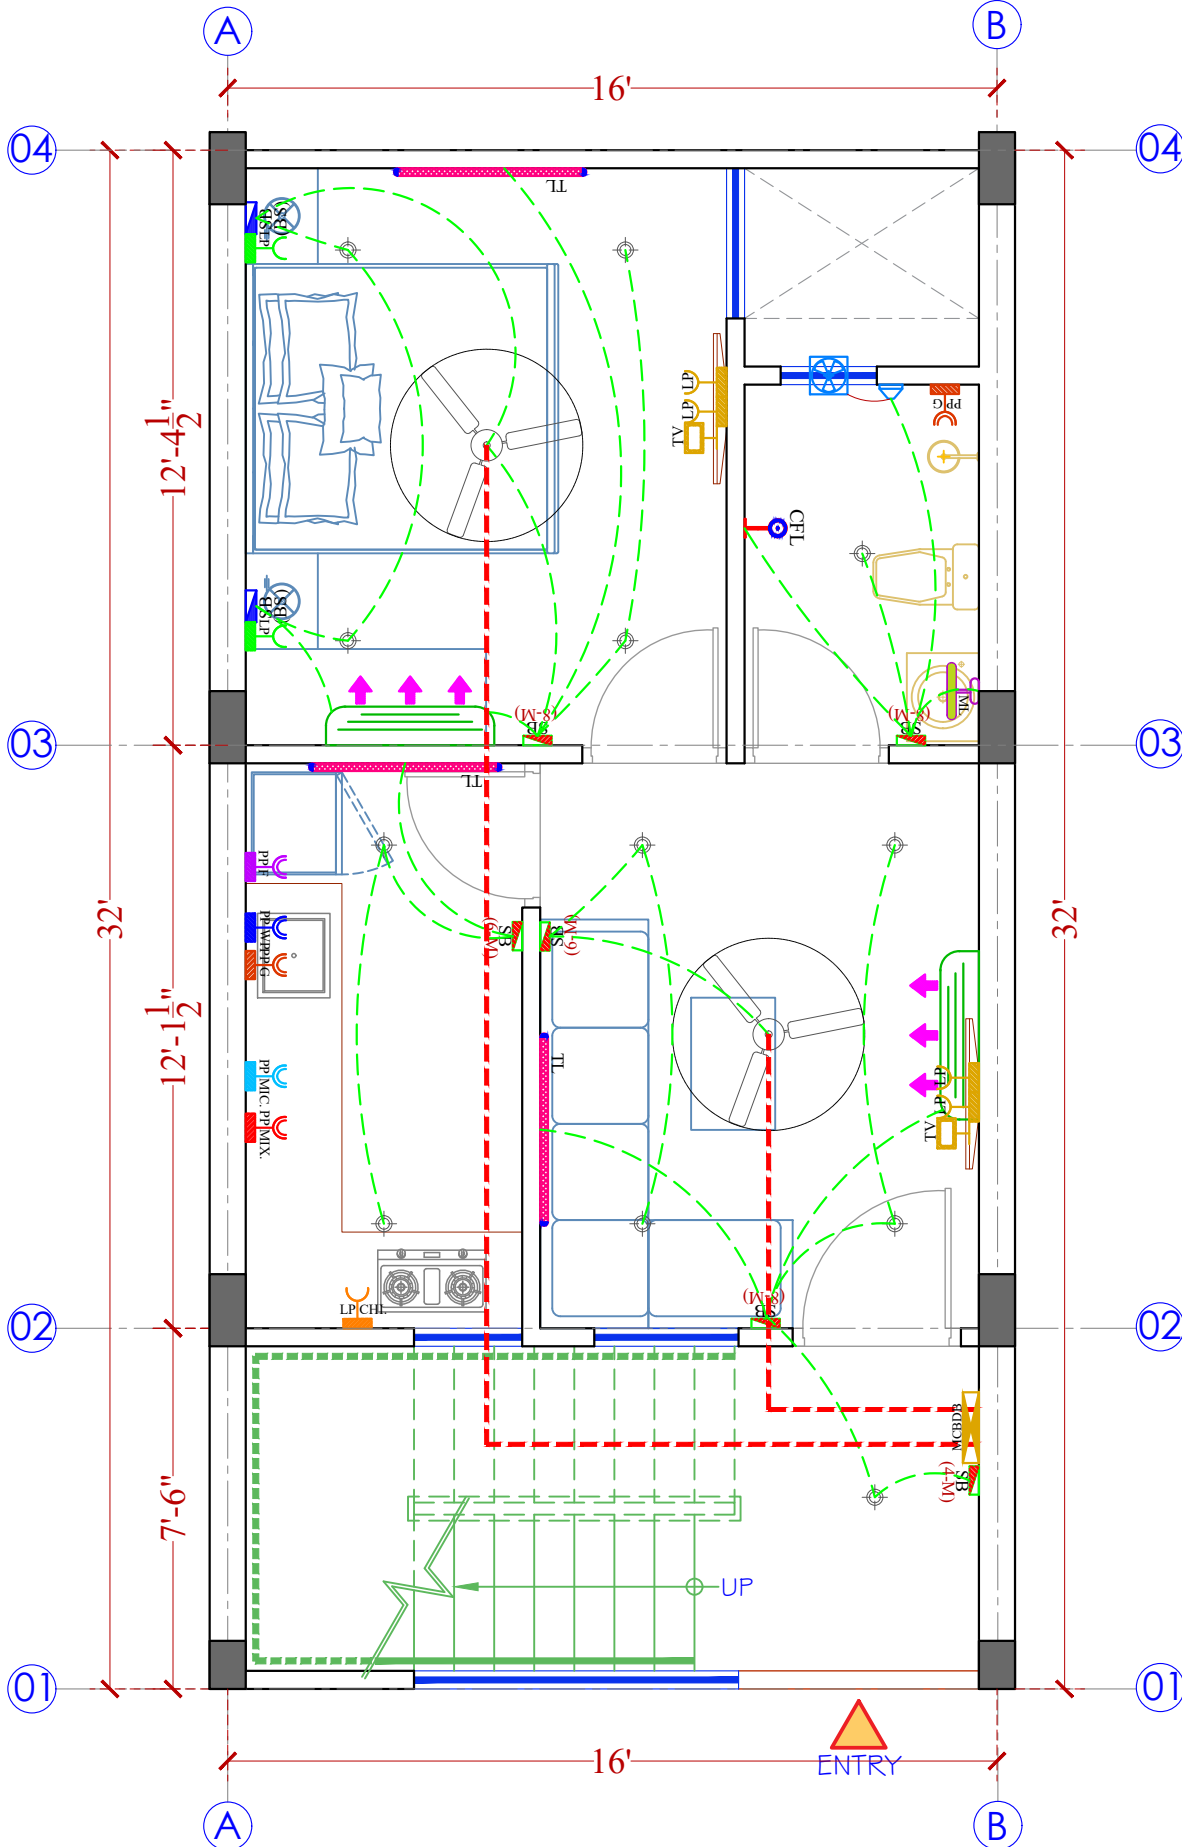

दिव्यजीत मारोठिया
DIVYAJEET MAROTHIYA
(IEI)
CHARTERED ENGINEER (CIVIL)
AM 3007165

SPECIFICATION:-

1. THIS DRAWING IS THE PROPERTY OF **CARYATID ARCHITECTS** AND SHALL NOT BE USED OR PRODUCE IN ANY MANNER WITHOUT HIS WRITTEN PERMISSION.
2. DIMENSIONS ON THE DRAWINGS ARE TO BE READ NOT SCALED.
3. THE EXECUTING AGENCY IS REQUIRED TO CORRELATE ALL RELEVANT DRAWINGS AND ANY ERRORS OR DISCREPANCIES ARE TO BE BROUGHT TO THE NOTICE OF **CARYATID ARCHITECTS** BEFORE COMMENCE OF WORK

Mounting Height	ID	SYMBOL	DESCRIPTION
IN RCC SLAB	CONDUIT		Rigid PVC Conduit 25mm/1.0 sqmm wire for Light points
IN RCC SLAB	CONDUIT		Rigid PVC Conduit 25mm/2.5 sqmm wire for Light Circuits
IN RCC SLAB	CONDUIT		Rigid PVC Conduit 25mm/4.00 sqmm wire for POWER Circuits
IN RCC SLAB	CONDUIT		Submain wire to Common & Flats DB from Main Panel on Ground Floor in 1 nos. 12 mm dia conduits
CEILING	FAN 48"		CEILING FAN 48"
CEILING	FAN 30"		CEILING FAN 30"
CEILING	CH1		CHANDELIER
CEILING	CL		LED 8" DOWNLIGHTER 3W (SURFACE MOUNTED) MAKE SYSCA LED CAT NO. SSK-15-3W
+90"	TL/W		LED WALL TUBE LIGHT 18W (SURFACE MOUNTED) MAKE SYSCA LED CAT NO. SSK-15-3W
+90"	CFL		LED BULB 30W MAKE SYSCA LED CAT NO. SSK-15-3W
+90"	GL		WALL BRACKETS GANESH LIGHT AS PER DESIGN
+24"	SB (BS)		SWITCH BOARD (BED SIDE)
+42"	SB		SWITCH BOARD
+78"	ML		12X12 LED TUBE LIGHT 18W (SURFACE MOUNTED) MAKE SYSCA LED CAT NO. SSK-15-3W
VENTILATOR HT.	CR		CEILING ROSE
VENTILATOR HT.	EXF		9" DIA FRESH AIR FAN
+24"	TEL		TELEPHONE POINT
+48"	TV		TV COAXIAL POINT
+24"	LP		6 A PLUG POINT
+48"	LP TV		6 A PLUG POINT FOR TV
+72"	LP-CH		6 A PLUG POINT FOR CHIMNEY
+42"	PP-MIX		15 A POWER POINT FOR MIXER
+42"	PP-MIC		15 A POWER POINT FOR MICROWAVE
+78"	PP-G		15 A POWER POINT FOR GEYSER
+54"	PP-F		15 A POWER POINT FOR FRIDGE
+78"	PP-WP		15 A POWER POINT FOR WATER PURIFIER
+48"	PP-WM		15 A POWER POINT FOR WASHING MACHINE
+18"	PP-INV		15 A POWER POINT FOR INVERTER
+24"	LP		6 A PLUG POINT
+90"	SP		SPLIT AC INDOOR UNIT
+60"	BP		6 A BELL PUSH
+90"	BZ		BUZZER FOR CALL BELL
+60"	MCB DB		MCB DISTRIBUTION BOARD

दिव्यजीत मारोठिया
DIVYAJEET MAROTHIYA
(IEI)
CHARTERED ENGINEER (CIVIL)
AM 3007165


PROJECT TITLE:-

AFFORDABLE HOUSING SCHEME
Khasra no. 36/2 of Village - Badgaon,
Tehsil - Sheoganj, Distt. - Sirohi
CONSULTANTS:-

CHECKED BY:- Rishabh Sharma	DRAWN BY:- Parmesver
SIGNATURE:-	SCALE:- N.T.S.
	DATE:- 14/06/2025
	NORTH
	SHEET:-

SHEET TITLE:-
EWS UNIT FIRST FLOOR ELECTRICAL
DRAWING

caryatid
architects & consultants
caryatidjaipur@gmail.com
96020-86971

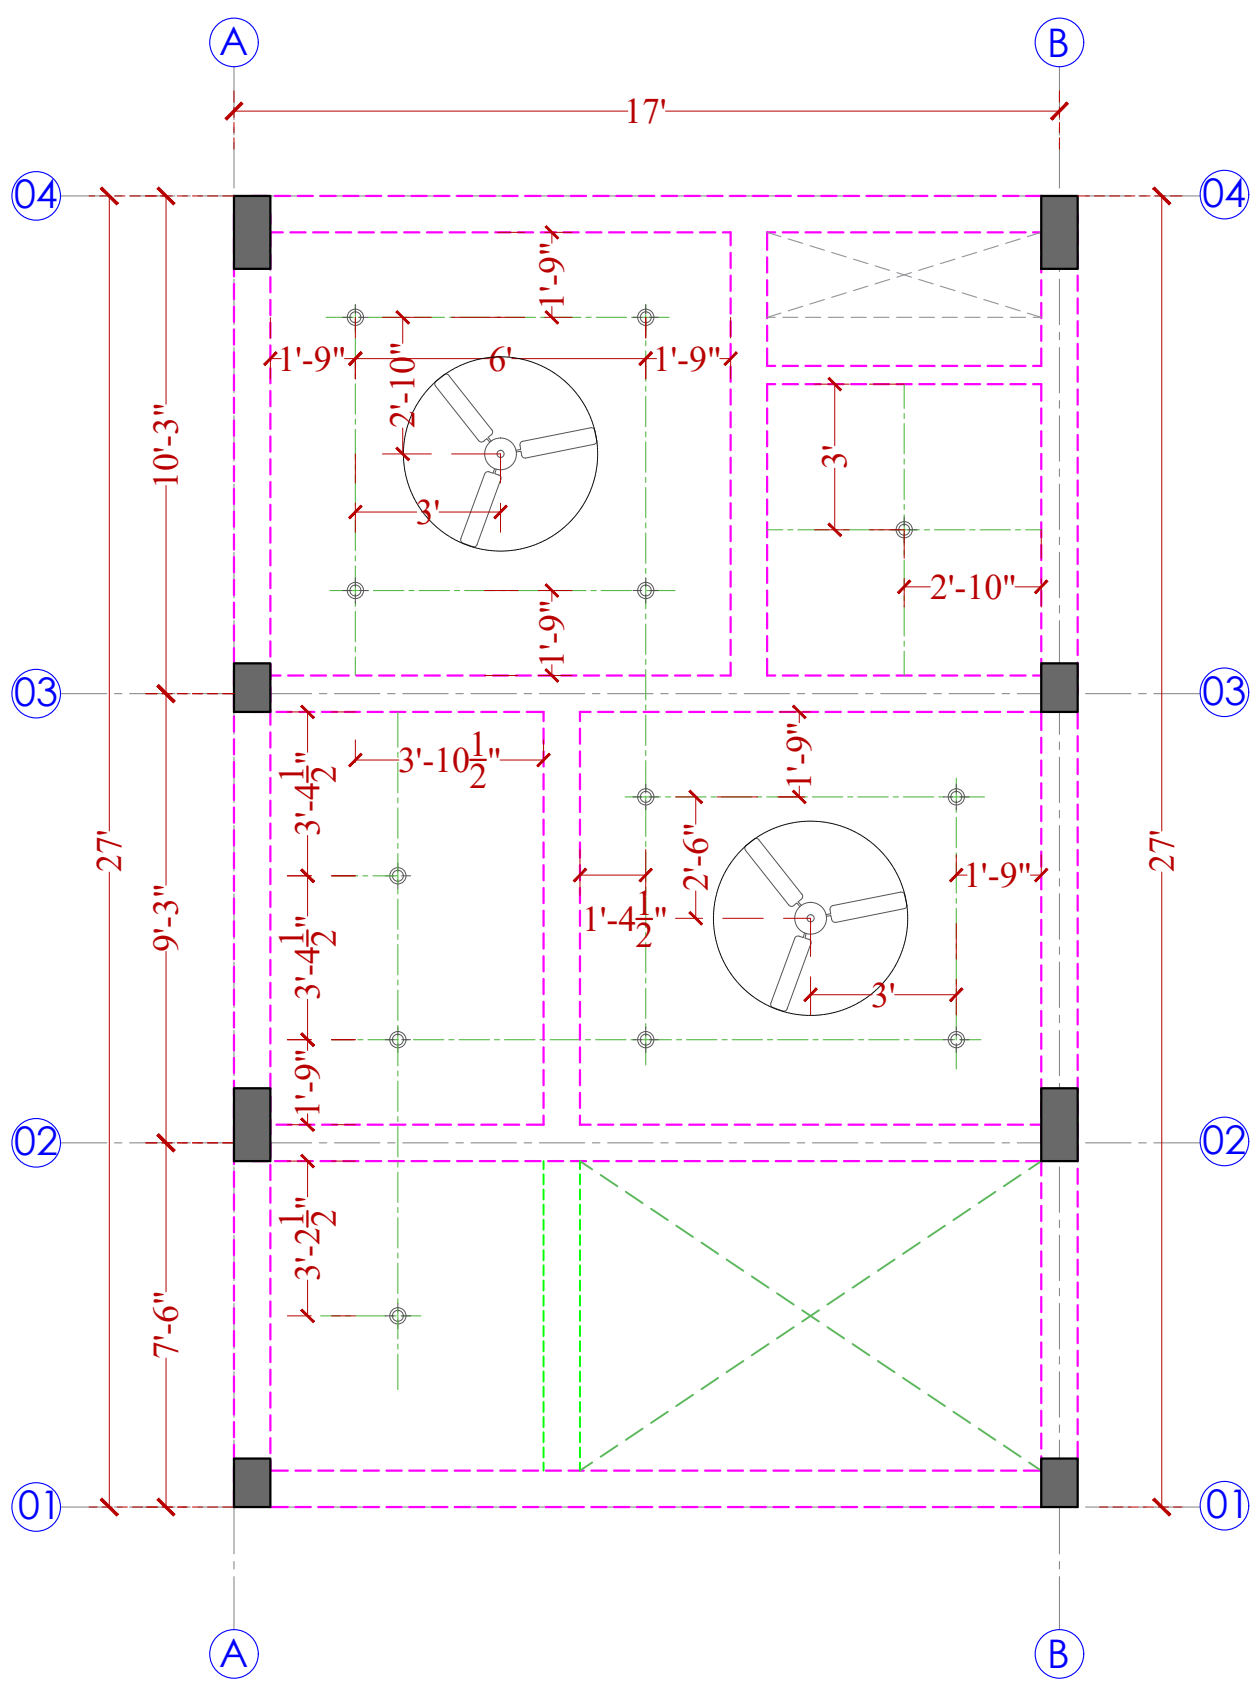

SPECIFICATION:-

1. THIS DRAWING IS THE PROPERTY OF **CARYATID ARCHITECTS** AND SHALL NOT BE USED OR PRODUCE IN ANY MANNER WITHOUT HIS WRITTEN PERMISSION.
2. DIMENSIONS ON THE DRAWINGS ARE TO BE READ NOT SCALED.
3. THE EXECUTING AGENCY IS REQUIRED TO CORRELATE ALL RELEVANT DRAWINGS AND ANY ERRORS OR DISCREPANCIES ARE TO BE BROUGHT TO THE NOTICE OF **CARYATID ARCHITECTS** BEFORE COMMENCE OF WORK

SYMBOL	LEGEND
	CHANDILLIER
	CEILING FAN
	CONCEALED LIGHT
	METER BOX
	MCB BOX
	CCTV CAMERA

PROJECT TITLE:-
AFFORDABLE HOUSING SCHEME
 Khasra no. 36/2 of Village - Badgaon,
 Tehsil - Sheoganj, Distt. - Sirahi

CHECKED BY:- Rishabh Sharma	DRAWN BY:- Parmesver
SIGNATURE:-	SCALE:- N.T.S.
	DATE:- 24/04/2025
	NORTH
	SHEET:-

SHEET TITLE:-
UWS UNIT G.F. ELECTRICAL CONDUCTED PLAN

caryatid
 architects & consultants
 caryatidjaipur@gmail.com
 96020-86971

दिव्याजीत मारोठिया
 DIVYAJEET MAROTHIYA
 (IEI)
 CHARTERED ENGINEER (CIVIL)
 AM 3007165

SPECIFICATION:-

1. THIS DRAWING IS THE PROPERTY OF **CARYATID ARCHITECTS** AND SHALL NOT BE USED OR PRODUCE IN ANY MANNER WITHOUT HIS WRITTEN PERMISSION.
2. DIMENSIONS ON THE DRAWINGS ARE TO BE READ NOT SCALED.
3. THE EXECUTING AGENCY IS REQUIRED TO CORRELATE ALL RELEVANT DRAWINGS AND ANY ERRORS OR DISCREPANCIES ARE TO BE BROUGHT TO THE NOTICE OF **CARYATID ARCHITECTS** BEFORE COMMENCE OF WORK


SYMBOL	LEGEND
	CHANDILLIER
	CEILING FAN
	CONCEALED LIGHT
	METER BOX
	MCB BOX
	CCTV CAMERA

PROJECT TITLE:-
AFFORDABLE HOUSING SCHEME
 Kharsa no. 36/2 of Village - Badgaon,
 Tehsil - Sheoganj, Distt. - Sirahi
CONSULTANTS:-

CHECKED BY:- Rishabh Sharma	DRAWN BY:- Parmesver
SIGNATURE:-	SCALE:- N.T.S.
	DATE:- 14/08/2025
	NORTH 
	SHEET:-

SHEET TITLE:-
 EWS UNIT FIRST FLOOR ELECTRICAL
 CONDUCTED PLAN

caryatid
 architects & consultants
 caryatidjaipur@gmail.com
 96020-86971

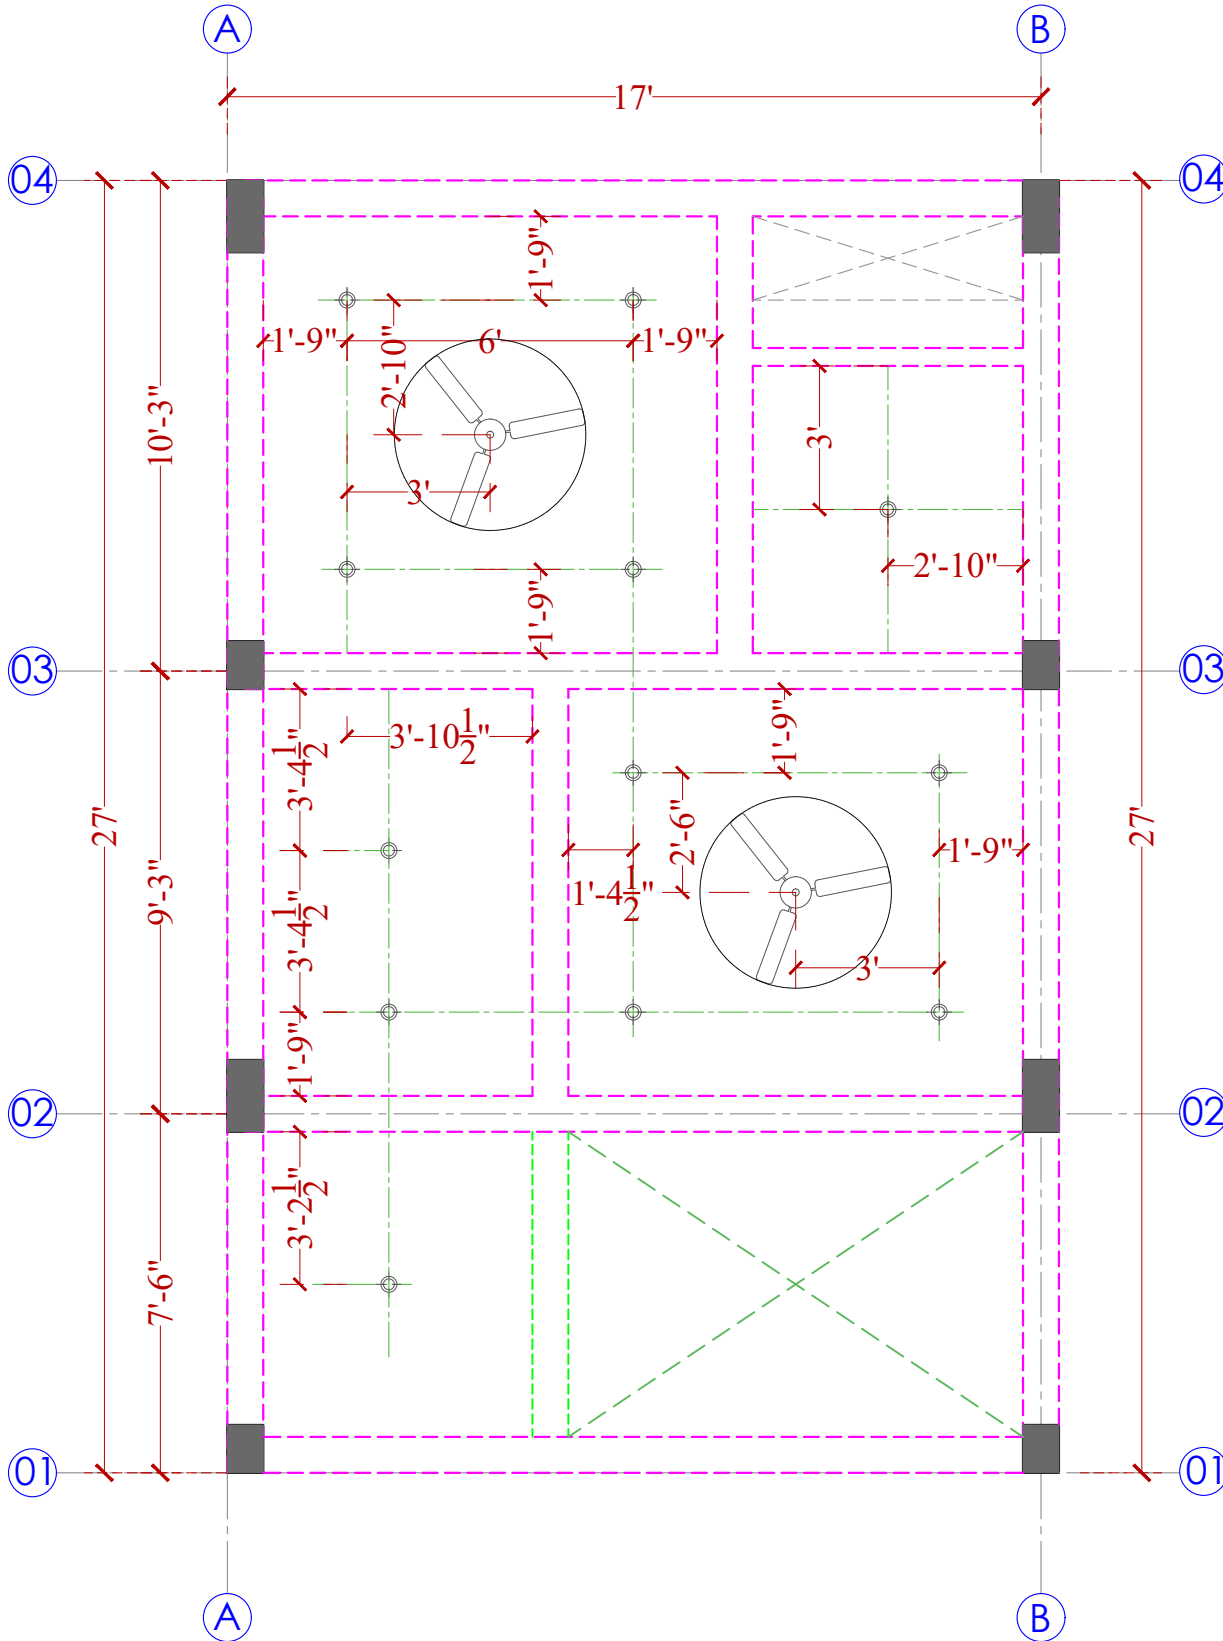

दिव्याजीत मारीडिया
 DIVYAJEET MAROTHIYA
 (IEI)
 CHARTERED ENGINEER (CIVIL)
 AM 3007165

SPECIFICATION:-

1. THIS DRAWING IS THE PROPERTY OF **CARYATID ARCHITECTS** AND SHALL NOT BE USED OR PRODUCE IN ANY MANNER WITHOUT HIS WRITTEN PERMISSION.
2. DIMENSIONS ON THE DRAWINGS ARE TO BE READ NOT SCALED.
3. THE EXECUTING AGENCY IS REQUIRED TO CORRELATE ALL RELEVANT DRAWINGS AND ANY ERRORS OR DISCREPANCIES ARE TO BE BROUGHT TO THE NOTICE OF **CARYATID ARCHITECTS** BEFORE COMMENCE OF WORK

Mounting Height	ID	SYMBOL	DESCRIPTION
IN RCC SLAB	CONDUIT		Rigid PVC Conduit 25mm/1.0 sqmm wire for Light points
IN RCC SLAB	CONDUIT		Rigid PVC Conduit 25mm/2.5 sqmm wire for Light Circuits
IN RCC SLAB	CONDUIT		Rigid PVC Conduit 25mm/4.00 sqmm wire for POWER Circuits
IN RCC SLAB	CONDUIT		Submain wire to Common & Flats DB from Main Panel on Ground Floor in 1 nos. 32 mm dia conduits.
CEILING	FAN 48"		CEILING FAN 48"
CEILING	FAN 30"		CEILING FAN 30"
CEILING	CHI		CHANDELIER
CEILING	CL		LED DOWNLIGHTER 20W SURFACE MOUNTED MAKE SYNSKA LED CAT NO. SKG-20W GLD & SK-4K LED WALL TUBE LIGHT MAKE SYNSKA LED CAT NO. SKG-4K-20W
+90"	TL/W		LED TUBE LIGHT 20W MAKE SYNSKA LED CAT NO. SKG-20W
+90"	CFL		MAKE SYNSKA LED CAT NO. SKG-20W
+90"	GL		WALL BRACKETS GANESH LIGHT AS PER DESIGN
+24"	SB (BS)		SWITCH BOARD (BED SIDE)
+42"	SB		SWITCH BOARD
+78"	ML		DOWN LIGHT MAKE SYNSKA LED CAT NO. SKG-20W
VENTILATOR HT.	CR		CEILING ROSE
VENTILATOR HT.	EXF		9" DIA FRESH AIR FAN
+24"	TEL		TELEPHONE POINT
+48"	TV		TV COAXIAL POINT.
+24"	LP		6 A PLUG POINT
+48"	LP TV		6 A PLUG POINT FOR TV
+72"	LP-CH		6 A PLUG POINT FOR CHIMNEY
+42"	PP-MIX		15 A POWER POINT FOR MIXER
+42"	PP-MIC		15 A POWER POINT FOR MICROWAVE
+78"	PP-G		15 A POWER POINT FOR GEYSER
+54"	PP-F		15 A POWER POINT FOR FRIDGE
+78"	PP-WP		15 A POWER POINT FOR WATER PURIFIER
+48"	PP-WM		15 A POWER POINT FOR WASHING MACHINE
+18"	PP-INV.		15 A POWER POINT FOR INVERTER
+24"	LP		6 A PLUG POINT
+90"	SP		SPLIT AC INDOOR UNIT
+60"	BP		6 A BELL PUSH
+90"	BZ		BUZZER FOR CALL BELL
+60"	MCB DB		MCB DISTRIBUTION BOARD

PROJECT TITLE:-

AFFORDABLE HOUSING SCHEME
Khasra no. 36/2 of Village - Badgaon,
Tehsil - Sheoganj, Distt. - Sirahi
CONSULTANTS:-

CHECKED BY:-

Rishabh Sharma

DRAWN BY:-

Parnesver

SIGNATURE:-

N.T.S.

DATE:- 18/08/2025


NORTH

SHEET:-

SHEET TITLE:-

EWS UNIT G.F. ELECTRICAL DRAWING

caryatid
architects & consultants
caryatidjaipur@gmail.com
96020-86971

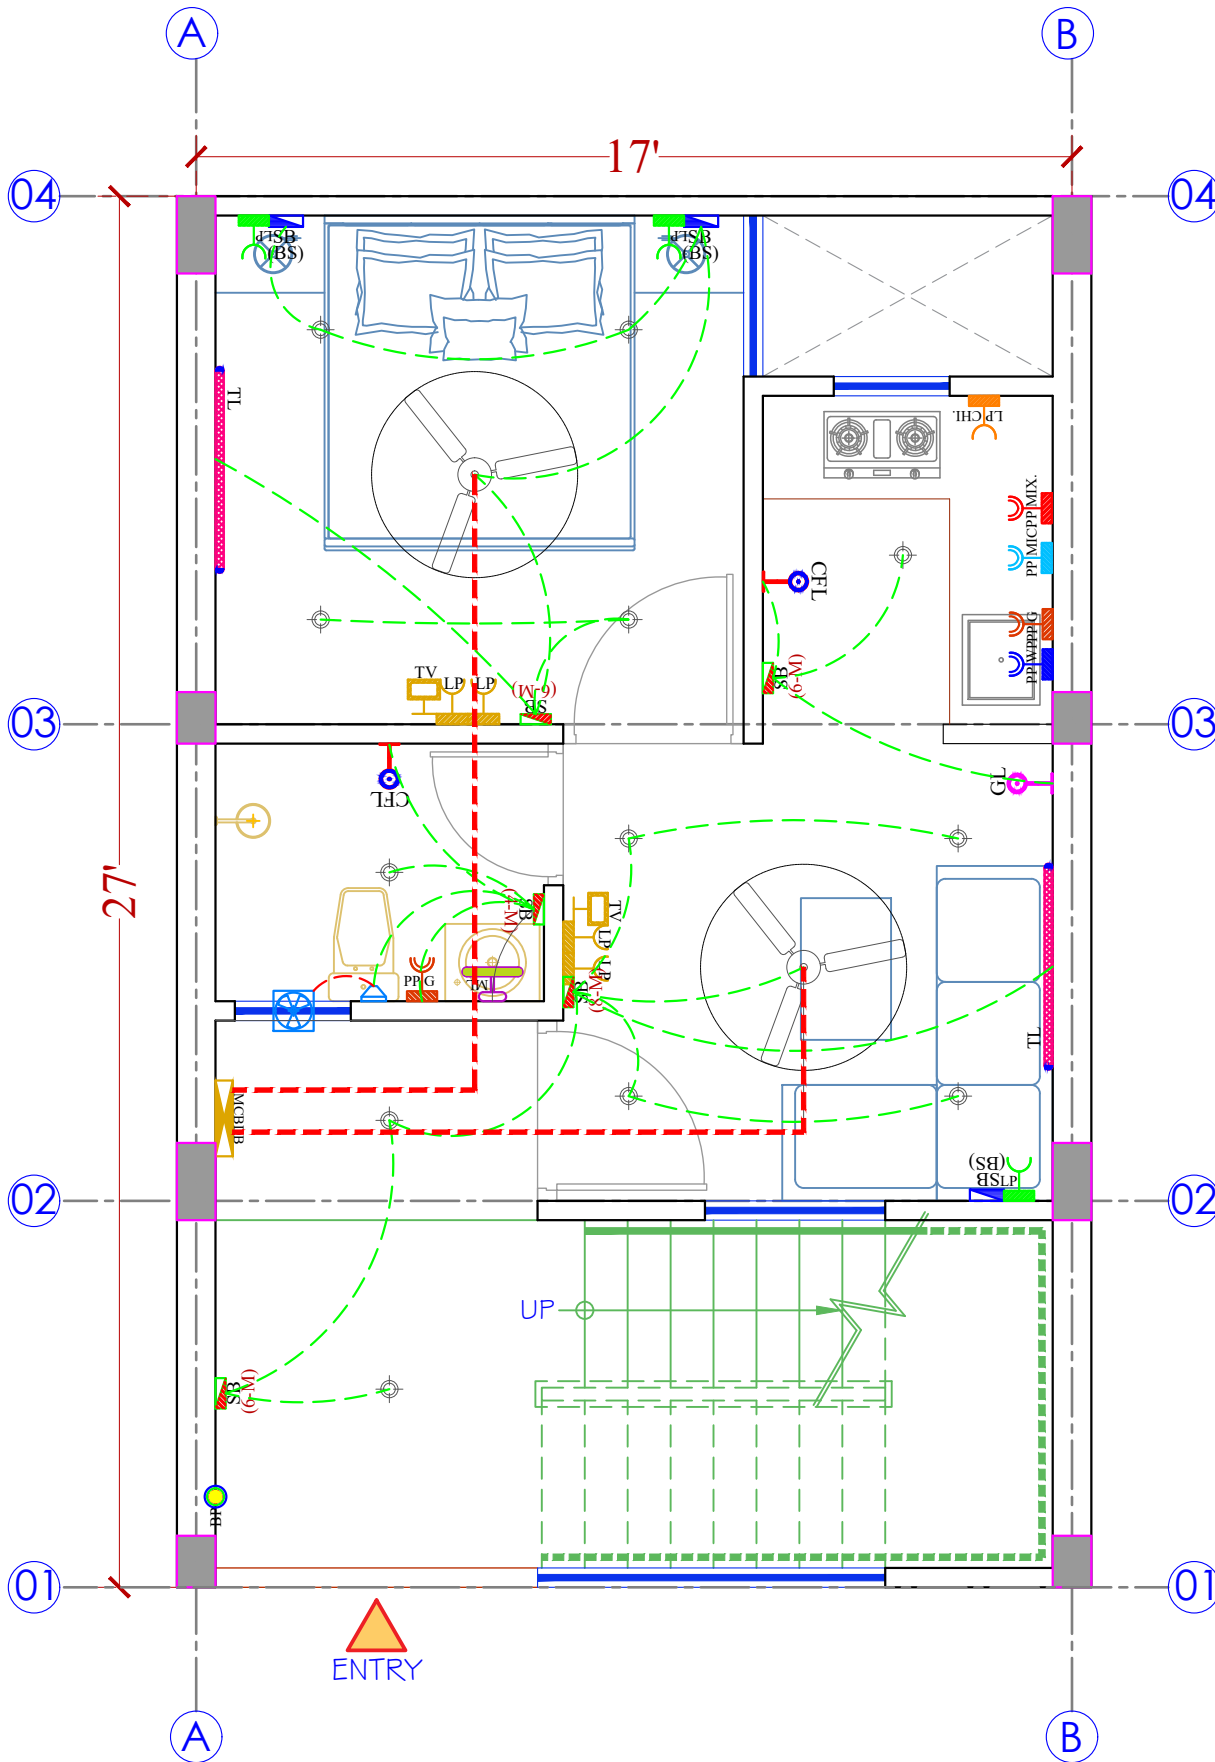

दिव्यजीत मारीथिया
DIVYAJEET MAROTHIYA
(IEI)
CHARTERED ENGINEER (CIVIL)
AM 3007165

SPECIFICATION:-

- THIS DRAWING IS THE PROPERTY OF **CARYATID ARCHITECTS** AND SHALL NOT BE USED OR PRODUCE IN ANY MANNER WITHOUT HIS WRITTEN PERMISSION.
- DIMENSIONS ON THE DRAWINGS ARE TO BE READ NOT SCALED.
- THE EXECUTING AGENCY IS REQUIRED TO CORRELATE ALL RELEVANT DRAWINGS AND ANY ERRORS OR DISCREPANCIES ARE TO BE BROUGHT TO THE NOTICE OF **CARYATID ARCHITECTS** BEFORE COMMENCE OF WORK

Mounting Height	ID	SYMBOL	DESCRIPTION
IN RCC SLAB	CONDUIT		Rigid PVC Conduit 25mm/1.0 sqmm wire for Light points
IN RCC SLAB	CONDUIT		Rigid PVC Conduit 25mm/2.5 sqmm wire for Light Circuits
IN RCC SLAB	CONDUIT		Rigid PVC Conduit 25mm/4.00 sqmm wire for POWER Circuits
IN RCC SLAB	CONDUIT		Submain wire to Common & Flats DB from Main Panel on Ground Floor in 1 nos. 12 mm dia conduits
CEILING	FAN 48"		CEILING FAN 48"
CEILING	FAN 30"		CEILING FAN 30"
CEILING	CH1		CHANDIEER
CEILING	CL		LEFT DOWNLIGHTER 20W (SURFACE MOUNTED) MAKE SYSKA LED CAT NO. SSK-LED-20W-48-30-30K
+90°	TLW		LED WALL TUBE LIGHT MAKE SYSKA LED CAT NO. SSK-LED-20W-48-30-30K
+90°	CFL		MAKE SYSKA LED CAT NO. SSK-LED-20W-48-30-30K
+90°	GL		WALL BRACKET'S GANESH LIGHT AS PER DESIGN
+24"	SB (BS)		SWITCH BOARD (BED SIDE)
+42"	SB		SWITCH BOARD
+78"	ML		1002 LED MIRROR LIGHT MAKE SYSKA LED CAT NO. SSK-LED-20W-48-30-30K
VENTILATOR HT.	CR		CEILING ROSE
VENTILATOR HT.	EXF		9" DIA FRESH AIR FAN
+24"	TEL		TELEPHONE POINT
+48"	TV		TV COAXIAL POINT
+24"	LP		6 A PLUG POINT
+48"	LP TV		6 A PLUG POINT FOR TV
+72"	LP-CH		6 A PLUG POINT FOR CHIMNEY
+42"	PP-MIX		15 A POWER POINT FOR MIXER
+42"	PP-MIC		15 A POWER POINT FOR MICROWAVE
+78"	PP-G		15 A POWER POINT FOR GEYSER
+54"	PP-F		15 A POWER POINT FOR FRIDGE
+78"	PP-WP		15 A POWER POINT FOR WATER PURIFIER
+48"	PP-WM		15 A POWER POINT FOR WASHING MACHINE
+18"	PP-INV.		15 A POWER POINT FOR INVERTER
+24"	LP		6 A PLUG POINT
+90°	SP		SPLIT AC INDOOR UNIT
+60"	BP		6 A BELL PUSH
+90"	BZ		BELL FOR CALL BELL
+60"	MCB DB		MCB DISTRIBUTION BOARD

PROJECT TITLE:-

AFFORDABLE HOUSING SCHEME
Khasra no. 36/2 of Village - Badgaon,
Tehsil - Sheoganj, Distt. - Sirahi
CONSULTANTS:-

CHECKED BY:-

Rishabh Sharma

DRAWN BY:-

Parnesver

SIGNATURE:-

SCALE:-

N.T.S.

DATE:-

18/08/2025


NORTH

SHEET:-


SHEET TITLE:-

EWS UNIT FIRST FLOOR ELECTRICAL DRAWING

caryatid
architects & consultants
caryatidjaipur@gmail.com
96020-86971

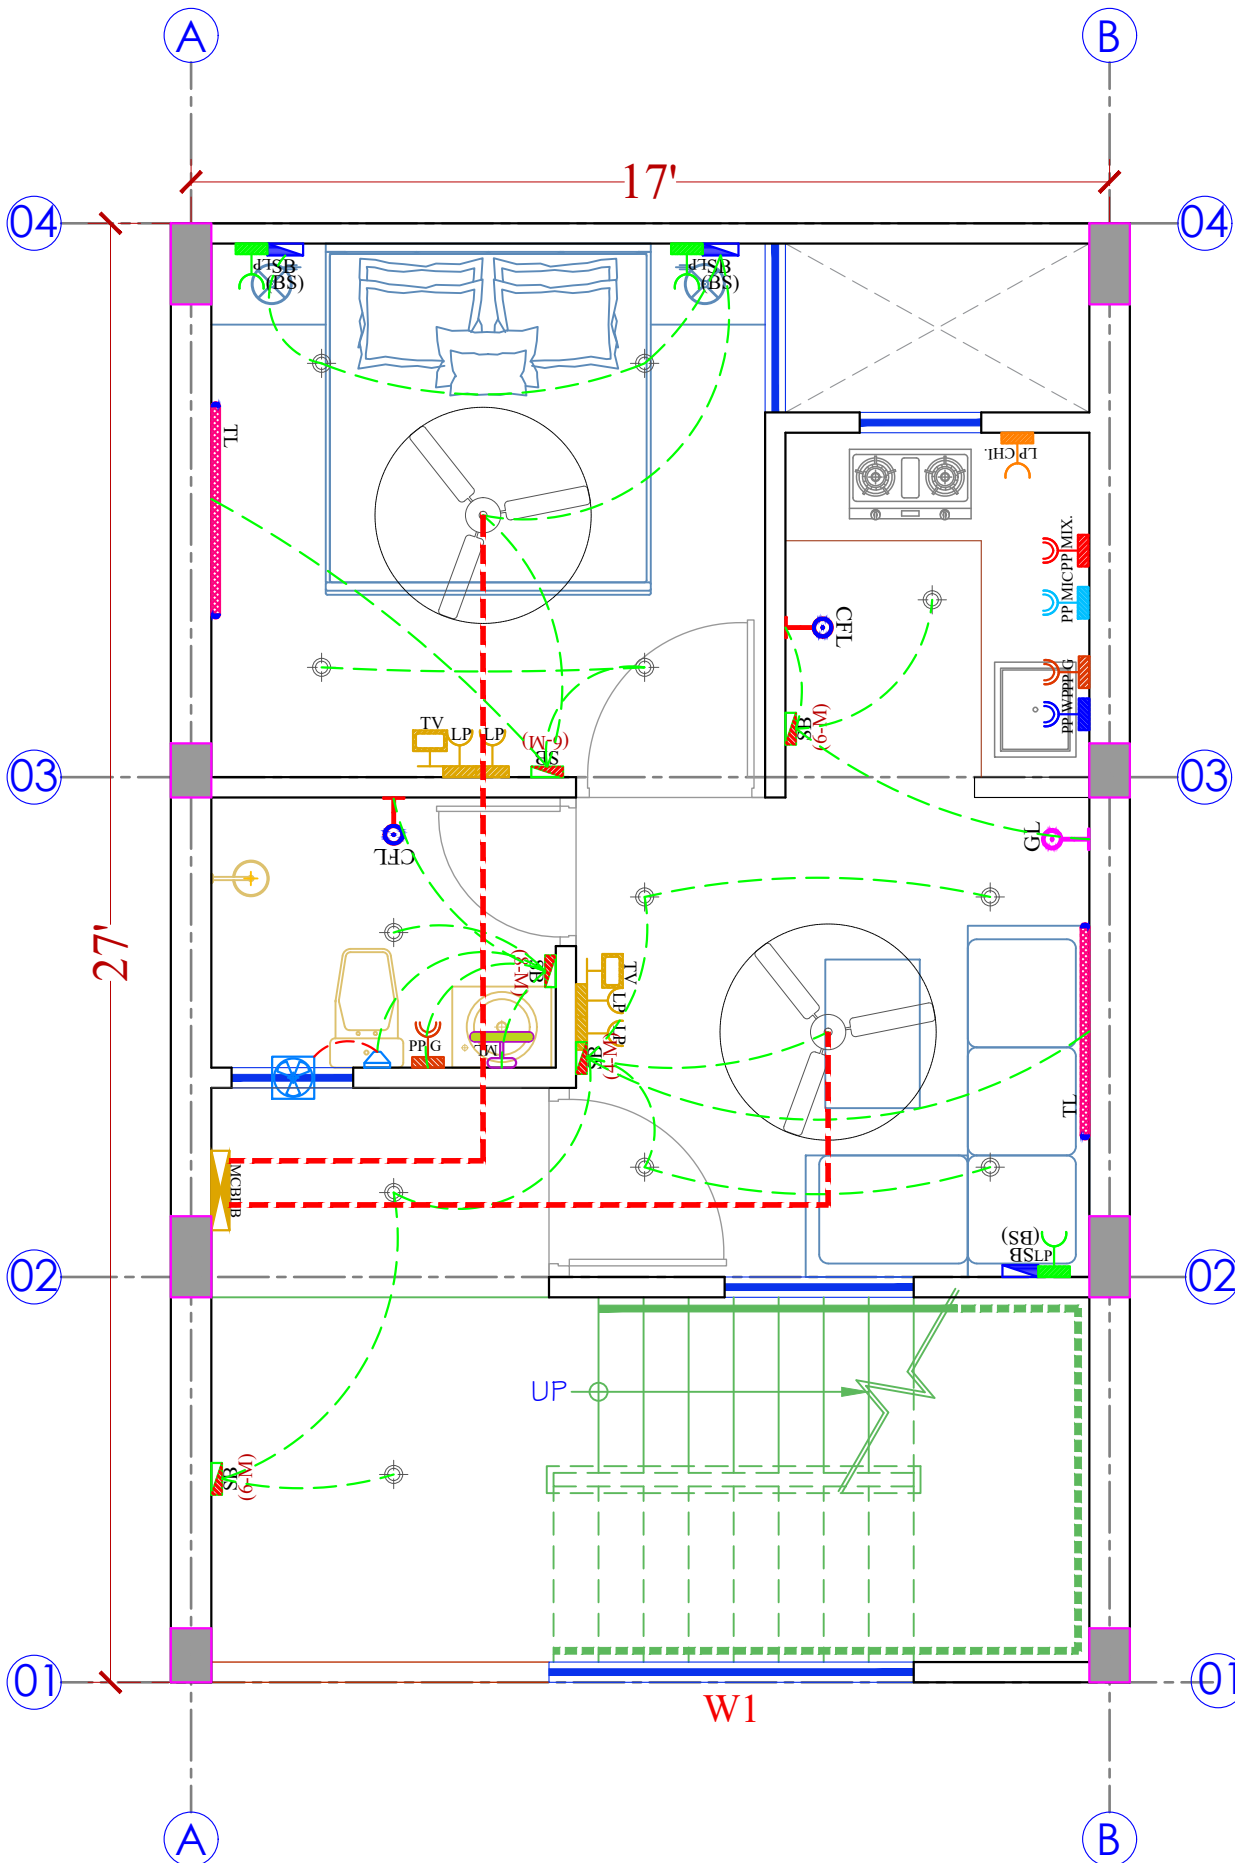

दिव्याजीत मारीठिया
DIVYAJEET MAROTHIYA
(IEI)
CHARTERED ENGINEER (CIVIL)
AM 3007165

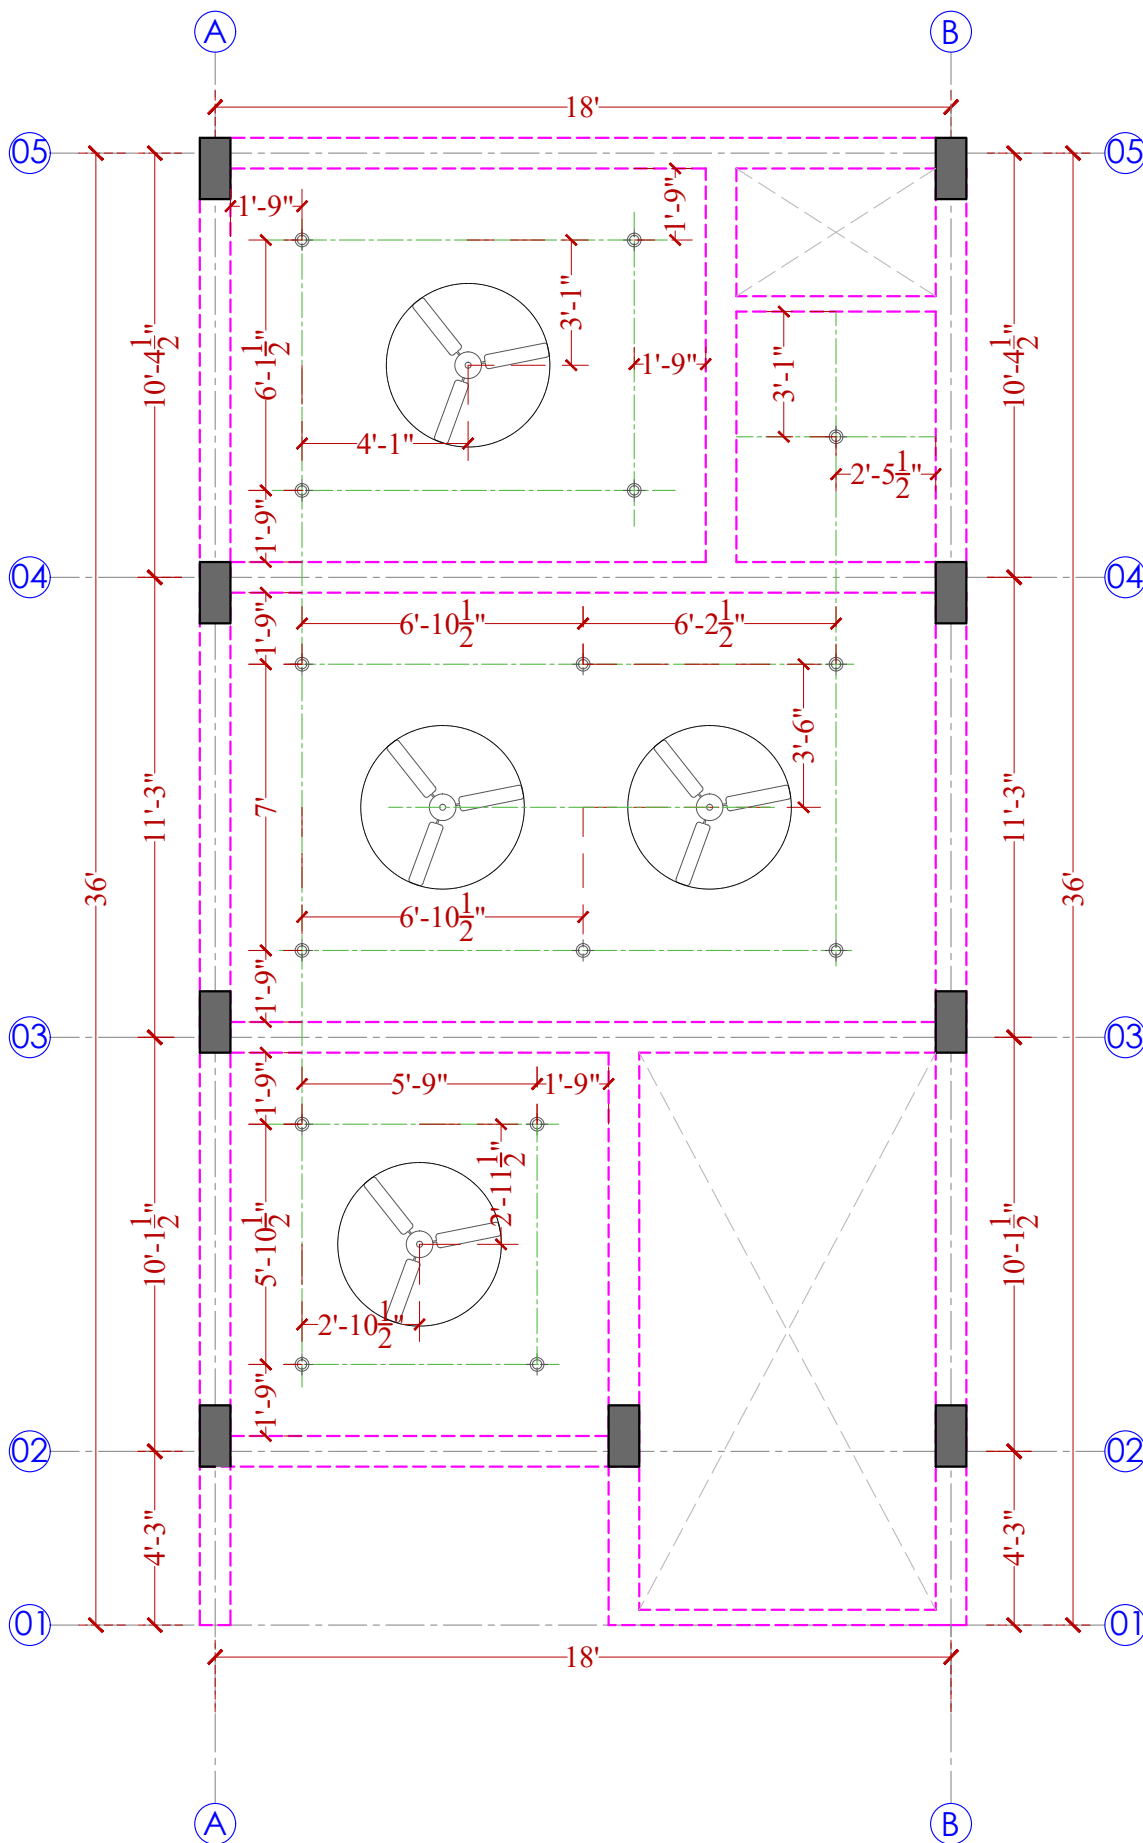

SPECIFICATION:-

- THIS DRAWING IS THE PROPERTY OF **CARYATID ARCHITECTS** AND SHALL NOT BE USED OR PRODUCE IN ANY MANNER WITHOUT HIS WRITTEN PERMISSION.
- DIMENSIONS ON THE DRAWINGS ARE TO BE READ NOT SCALED.
- THE EXECUTING AGENCY IS REQUIRED TO CORRELATE ALL RELEVANT DRAWINGS AND ANY ERRORS OR DISCREPANCIES ARE TO BE BROUGHT TO THE NOTICE OF **CARYATID ARCHITECTS** BEFORE COMMENCE OF WORK

SYMBOL	LEGEND
	CHANDILLIER
	CEILING FAN
	CONCEALED LIGHT
	METER BOX
	MCB BOX
	CCTV CAMERA

दिव्यजीत मारोठिया
DIVYAJEET MAROTHIYA
(IEI)
CHARTERED ENGINEER (CIVIL)
AM 3007165

PROJECT TITLE:-

AFFORDABLE HOUSING SCHEME
Khasra no. 36/2 of Village - Badgaon,
Tehsil - Sheoganj, Distt. - Sirohi

CONSULTANTS:-

CHECKED BY:- Rishabh Sharma	DRAWN BY:- Parmeshwar
SIGNATURE:-	SCALE:- N.T.S.
	DATE:- 14/08/2025
	NORTH
	SHEET:-

SHEET TITLE:-
LIG G.F. ELECTRICAL CONDUCTED PLAN

caryatid
architects & consultants
caryatidjaipur@gmail.com
96020-86971

SPECIFICATION:-

1. THIS DRAWING IS THE PROPERTY OF **CARYATID ARCHITECTS** AND SHALL NOT BE USED OR PRODUCE IN ANY MANNER WITHOUT HIS WRITTEN PERMISSION.
2. DIMENSIONS ON THE DRAWINGS ARE TO BE READ NOT SCALED.
3. THE EXECUTING AGENCY IS REQUIRED TO CORRELATE ALL RELEVANT DRAWINGS AND ANY ERRORS OR DISCREPANCIES ARE TO BE BROUGHT TO THE NOTICE OF **CARYATID ARCHITECTS** BEFORE COMMENCE OF WORK

SYMBOL	LEGEND
	CHANDILLIER
	CEILING FAN
	CONCEALED LIGHT
	METER BOX
	MCB BOX
	CCTV CAMERA


दिव्याजीत मारोठिया
DIVYAJEET MAROTHIYA
 (IEI)
 CHARTERED ENGINEER (CIVIL)
 AM 3007165

PROJECT TITLE:-
AFFORDABLE HOUSING SCHEME
 Khasra no. 36/2 of Village - Badgaon,
 Tehsil - Sheoganj, Distt. - Sirahi
 CONSULTANTS:-

CHECKED BY:- Rishabh Sharma	DRAWN BY:- Parmeshwar
SIGNATURE:-	SCALE:- N.T.S.
	DATE:- 16/04/2025
	NORTH
	SHEET:-

SHEET TITLE:-
LIG FIRST FLOOR ELECTRICAL CONDUCTED PLAN

caryatid
 architects & consultants
 caryatidjaipur@gmail.com
 96020-86971

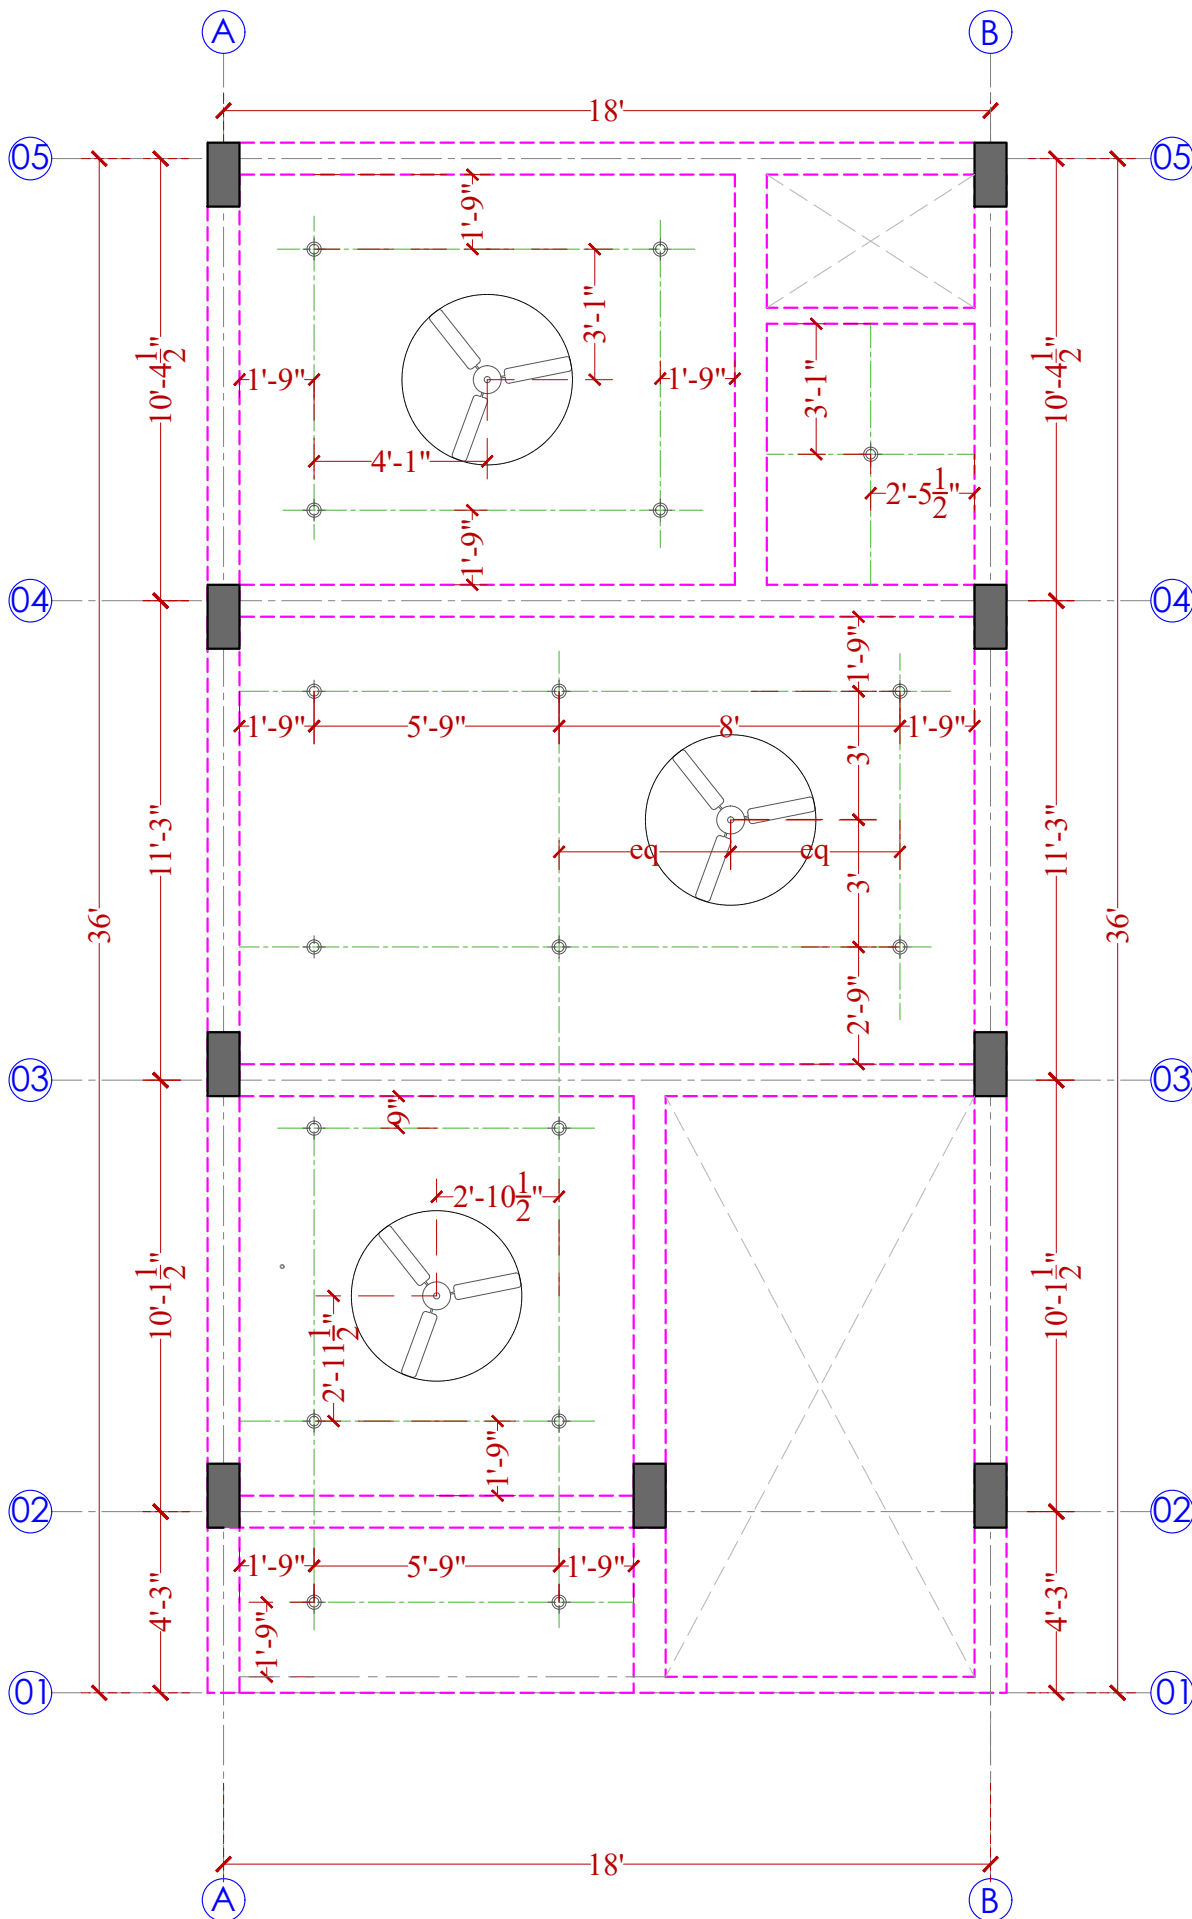

SPECIFICATION:-

1. THIS DRAWING IS THE PROPERTY OF **CARYATID ARCHITECTS** AND SHALL NOT BE USED OR PRODUCE IN ANY MANNER WITHOUT HIS WRITTEN PERMISSION.
2. DIMENSIONS ON THE DRAWINGS ARE TO BE READ NOT SCALED.
3. THE EXECUTING AGENCY IS REQUIRED TO CORRELATE ALL RELEVANT DRAWINGS AND ANY ERRORS OR DISCREPANCIES ARE TO BE BROUGHT TO THE NOTICE OF **CARYATID ARCHITECTS** BEFORE COMMENCE OF WORK

Mounting Height	ID	SYMBOL	DESCRIPTION
IN RCC SLAB	CONDUIT		Rigid PVC Conduit 25mm/1.0 sqmm wire for Light points
IN RCC SLAB	CONDUIT		Rigid PVC Conduit 25mm/2.5 sqmm wire for Light Circuits
IN RCC SLAB	CONDUIT		Rigid PVC Conduit 25mm/4.00 sqmm wire for POWER Circuits
IN RCC SLAB	CONDUIT		Submain wire to Common & Flats DB from Main Panel on Ground Floor in 1 nos. 32 mm dia conduits
CEILING	FAN48"		CEILING FAN 48"
CEILING	FAN30"		CEILING FAN 30"
CEILING	CHI		CHANDELLIER
CEILING	CL		LED 9" DOWNLIGHTER 20W (SURFACE MOUNTED) MAKE SYSCA LED CAT NO SS-20W-9"GLD & 304K
+90"	TL/W		LED WALL TUBE LIGHT MAKE SYSCA LED CAT NO SS-30W-7"30K
+90"	CFL		LED 9" DOWNLIGHTER 20W (SURFACE MOUNTED) MAKE SYSCA LED CAT NO SS-20W-9"GLD & 304K
+90"	GL		WALL BRACKETS GANESH LIGHT AS PER DESIGN
+24"	SB (BS)		SWITCH BOARD (BED SIDE)
+42"	SB		SWITCH BOARD
+78"	ML		TEST LAMPING LIGHT MAKE SYSCA LED CAT NO JBL-1002
VENTILATOR	CR		CEILING ROSE
VENTILATOR	EXF		9" DIA FRESH AIR FAN
+24"	TEL		TELEPHONE POINT
+48"	TV		TV COAXIAL POINT
+24"	LP		6 A PLUG POINT
+48"	LP TV		6 A PLUG POINT FOR TV
+72"	LP-CH		6 A PLUG POINT FOR CHIMNEY
+42"	PP-MIX		15 A POWER POINT FOR MIXER
+42"	PP-MIC		15 A POWER POINT FOR MICROWAVE
+78"	PP-G		15 A POWER POINT FOR GEYSER
+54"	PP-F		15 A POWER POINT FOR FRIDGE
+78"	PP-WP		15 A POWER POINT FOR WATER PURIFIER
+48"	PP-WM		15 A POWER POINT FOR WASHING MACHINE
+18"	PP-INV.		15 A POWER POINT FOR INVERTER
+24"	LP		6 A PLUG POINT
+90"	SP		SPLIT AC INDOOR UNIT
+60"	BP		6 A BELL PUSH
+90"	BZ		BUZZER FOR CALL BELL
+60"	MCB DB		MCB DISTRIBUTION BOARD

दिव्यजीत मरोठिया
DIVYAJEET MAROTHIYA
(IEI)
CHARTERED ENGINEER (CIVIL)
AM 3007165


PROJECT TITLE:-
AFFORDABLE HOUSING SCHEME
Khasra no. 36/2 of Village - Badgaon,
Tehsil - Sheoganji, Distt. - Sirahi

CONSULTANTS:-

CHECKED BY:- Rishabh Sharma	DRAWN BY:- Parmeshwar
SIGNATURE:-	SCALE:- N.T.S.
	DATE:- 14/08/2025
	NORTH
	SHEET:-

SHEET TITLE:-
LIG G.F. ELECTRICAL DRAWING

caryatid
architects & consultants
caryatidjaipur@gmail.com
96020-86971

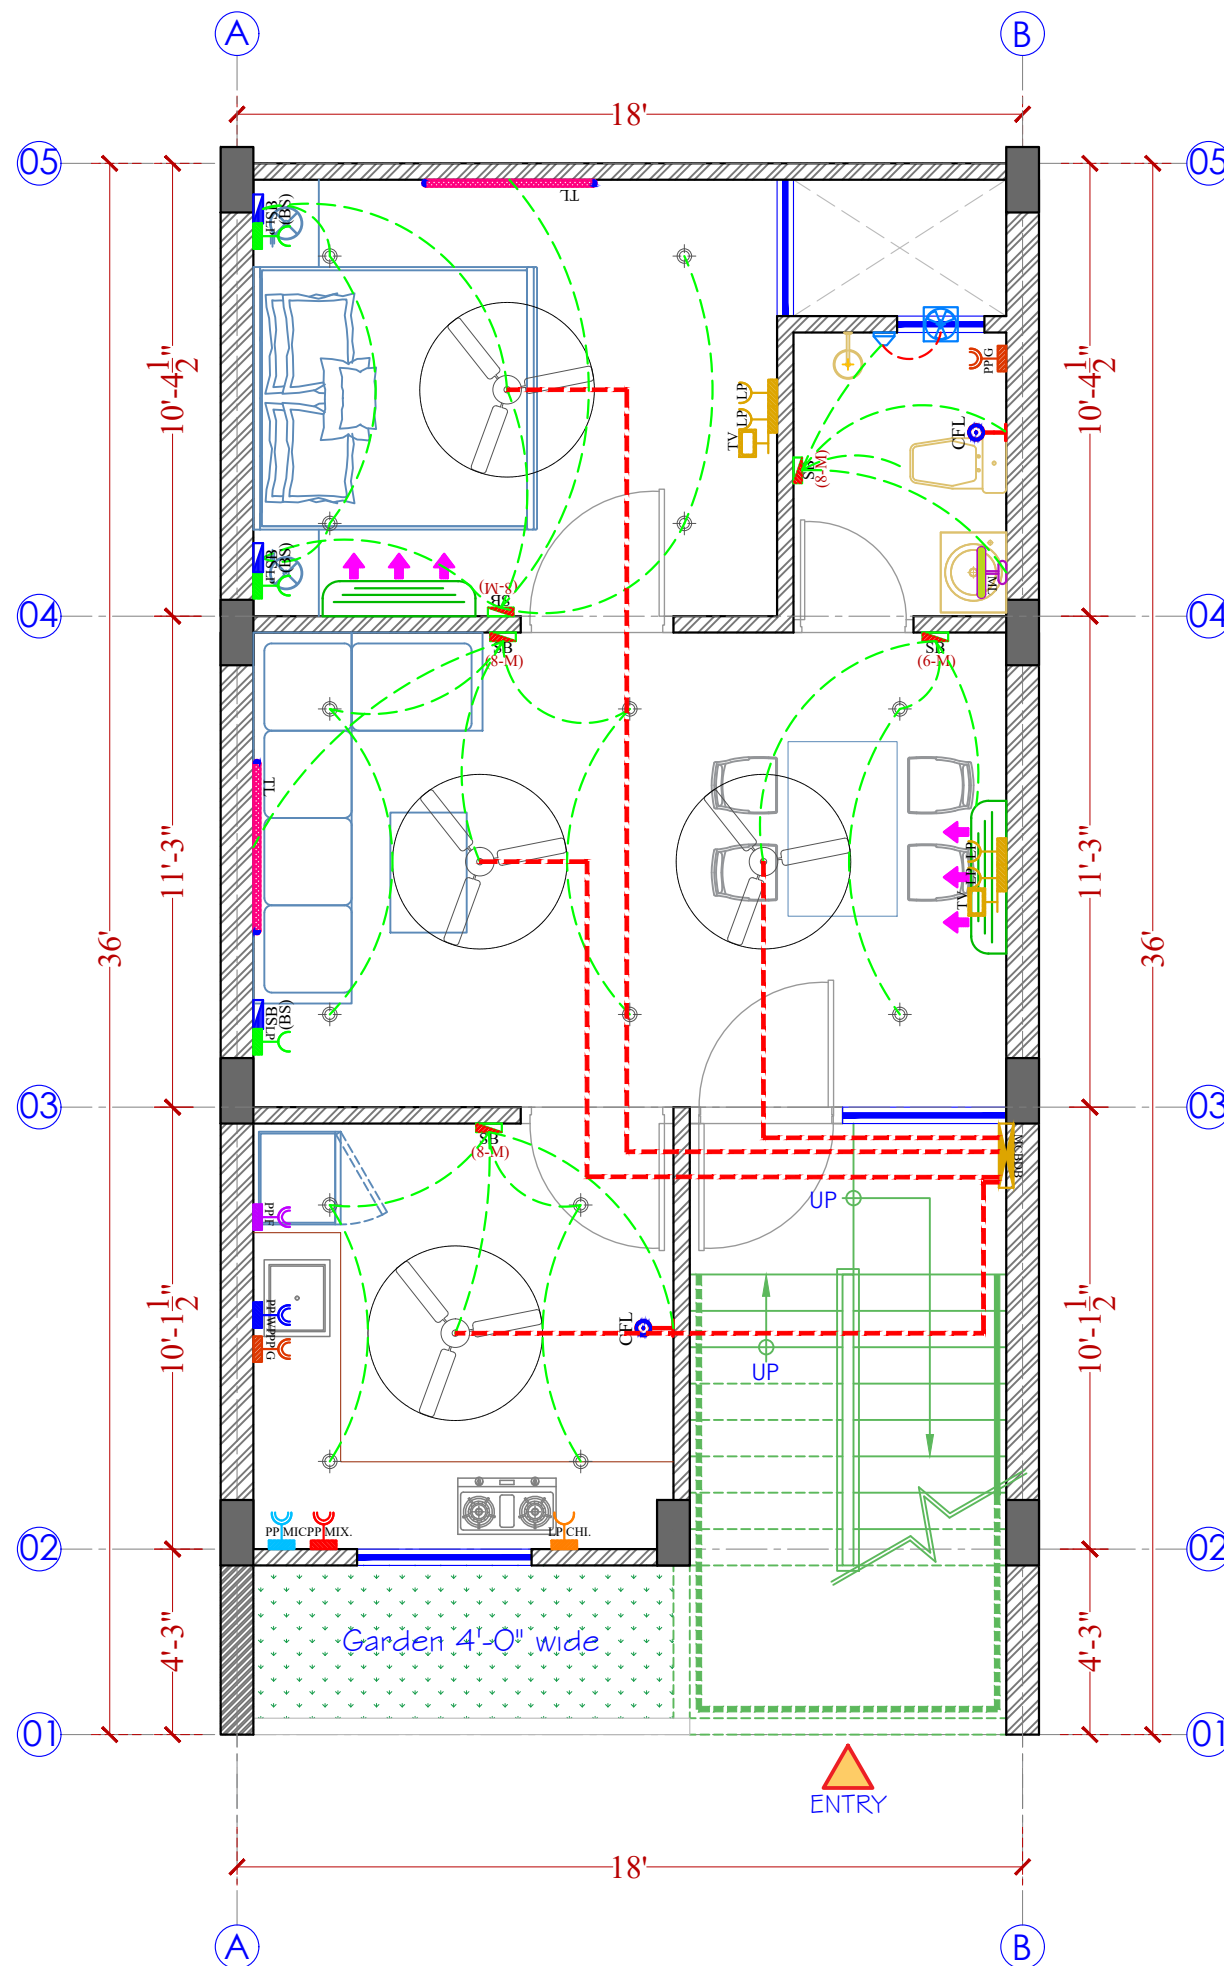

SPECIFICATION:-

1. THIS DRAWING IS THE PROPERTY OF **CARYATID ARCHITECTS** AND SHALL NOT BE USED OR PRODUCE IN ANY MANNER WITHOUT HIS WRITTEN PERMISSION.
2. DIMENSIONS ON THE DRAWINGS ARE TO BE READ NOT SCALED.
3. THE EXECUTING AGENCY IS REQUIRED TO CORRELATE ALL RELEVANT DRAWINGS AND ANY ERRORS OR DISCREPANCIES ARE TO BE BROUGHT TO THE NOTICE OF **CARYATID ARCHITECTS** BEFORE COMMENCE OF WORK

Mounting Height	ID	SYMBOL	DESCRIPTION
IN RCC SLAB	CONDUIT		Rigid PVC Conduit 25mm/1.0 sqmm wire for Light points
IN RCC SLAB	CONDUIT		Rigid PVC Conduit 25mm/2.5 sqmm wire for Light Circuits
IN RCC SLAB	CONDUIT		Rigid PVC Conduit 25mm/4.00 sqmm wire for POWER Circuits
IN RCC SLAB	CONDUIT		Submain wire to Common & Flats DB from Main Panel on Ground Floor in 1 nos. 32 mm dia conduits
CEILING	FAN48"		CEILING FAN 48"
CEILING	FAN30"		CEILING FAN 30"
CEILING	CH1		CHANDELIER
CEILING	CL		LED 9" DOWNLIGHTER 20W (SURFACE MOUNTED) MAKE SYSKA LED CAT NO. SSC-150 GLD 6 7K-3K
+90"	TL/W		LED WALL TUBE LIGHT MAKE SYSKA LED CAT NO. SSC-150 3K-3K
+90"	CFL		LED BULB 20W MAKE SYSKA LED CAT NO. SSC-150 3K-3K
+90"	GL		WALL BRACKET'S GANESH LIGHT AS PER DESIGN
+24"	SB (BS)		SWITCH BOARD (BED SIDE)
+42"	SB		SWITCH BOARD
+78"	ML		12X2 LED MIRROR LIGHT MAKE SYSKA LED CAT NO. -TFL-12X2
VENTILATOR HT.	CR		CEILING ROSE
VENTILATOR IIT.	EXF		9" DIA FRESH AIR FAN
+24"	TEL		TELEPHONE POINT
+48"	TV		TV COAXIAL POINT
+24"	LP		6 A PLUG POINT
+48"	LP TV		6 A PLUG POINT FOR TV
+72"	LP-CH		6 A PLUG POINT FOR CHIMNEY
+42"	PP-MIX		15 A POWER POINT FOR MIXER
+42"	PP-MIC		15 A POWER POINT FOR MICROWAVE
+78"	PP-G		15 A POWER POINT FOR GEYSER
+54"	PP-F		15 A POWER POINT FOR FRIDGE
+78"	PP-WP		15 A POWER POINT FOR WATER PURIFIER
+48"	PP-WM		15 A POWER POINT FOR WASHING MACHINE
+18"	PP-INV.		15 A POWER POINT FOR INVERTER
+24"	LP		6 A PLUG POINT
+90"	SP		SPLIT AC INDOOR UNIT
+60"	BP		6 A BELL PUSH
+90"	BZ		Buzzer for CALL BELL
+60"	MCB DB		MCB DISTRIBUTION BOARD

दिव्याजीव मारोथिया
DIVYAJEET MAROTHIYA

(IEI)
CHARTERED ENGINEER (CIVIL)
AM 3007165


PROJECT TITLE:-
AFFORDABLE HOUSING SCHEME
Khasra no. 36/2 of Village - Badgaon,
Tehsil - Sheoganj, Distt. - Sirahi

CONSULTANTS:-

CHECKED BY:- Rishabh Sharma	DRAWN BY:- Parmeshwar
SIGNATURE:-	SCALE:- N.T.S.
	DATE:- 24/06/2025
	NORTH SHEET:-

SHEET TITLE:-
LIG FIRST FLOOR ELECTRICAL DRAWING

caryatid
architects & consultants
caryatidjaipur@gmail.com
96020-86971

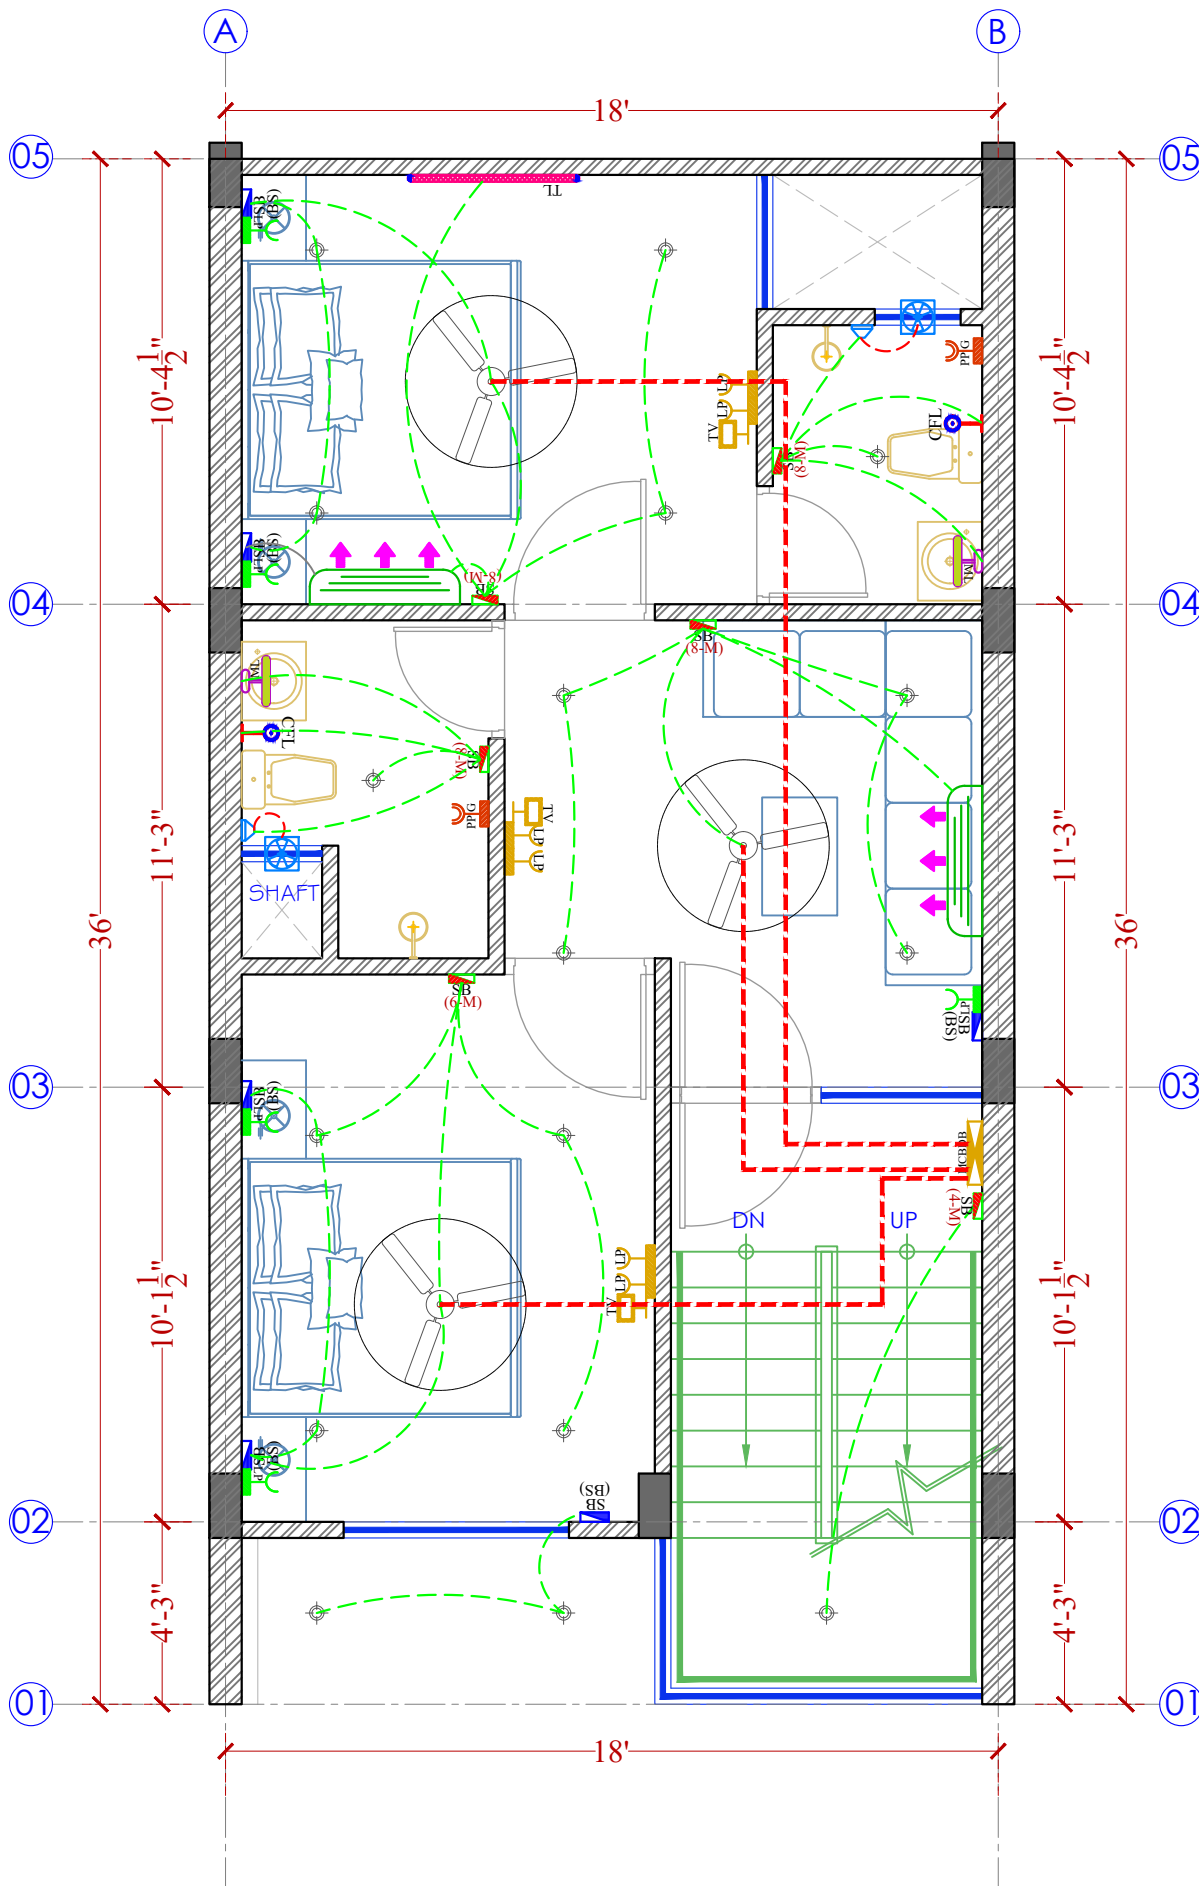

SPECIFICATION:-

1. THIS DRAWING IS THE PROPERTY OF **CARYATID ARCHITECTS** AND SHALL NOT BE USED OR PRODUCE IN ANY MANNER WITHOUT HIS WRITTEN PERMISSION.
2. DIMENSIONS ON THE DRAWINGS ARE TO BE READ NOT SCALED.
3. THE EXECUTING AGENCY IS REQUIRED TO CORRELATE ALL RELEVANT DRAWINGS AND ANY ERRORS OR DISCREPANCIES ARE TO BE BROUGHT TO THE NOTICE OF **CARYATID ARCHITECTS** BEFORE COMMENCE OF WORK

SYMBOL	LEGEND
	CHANDILLIER
	CEILING FAN
	CONCEALED LIGHT
	METER BOX
	MCB BOX
	CCTV CAMERA


दिव्याजीत मारोडिया
DIVYAJEET MARODIYA
 (IEI)
 CHARTERED ENGINEER (CIVIL)
 AM 3007165

PROJECT TITLE:-
AFFORDABLE HOUSING SCHEME
 Khasra no. 36/2 of Village - Badgaon,
 Tehsil - Sheoganj, Distt. - Sirahi
 CONSULTANTS:-

CHECKED BY:- Rishabh Sharma	DRAWN BY:- Parmesver
SIGNATURE:-	SCALE:- N.T.S.
	DATE:- 24/08/2025
	NORTH 
	SHEET:-

SHEET TITLE:-
MIG UNIT G.F. ELECTRICAL CONDUCTED PLAN


 architects & consultants
 caryatidjaipur@gmail.com
 96020-86971

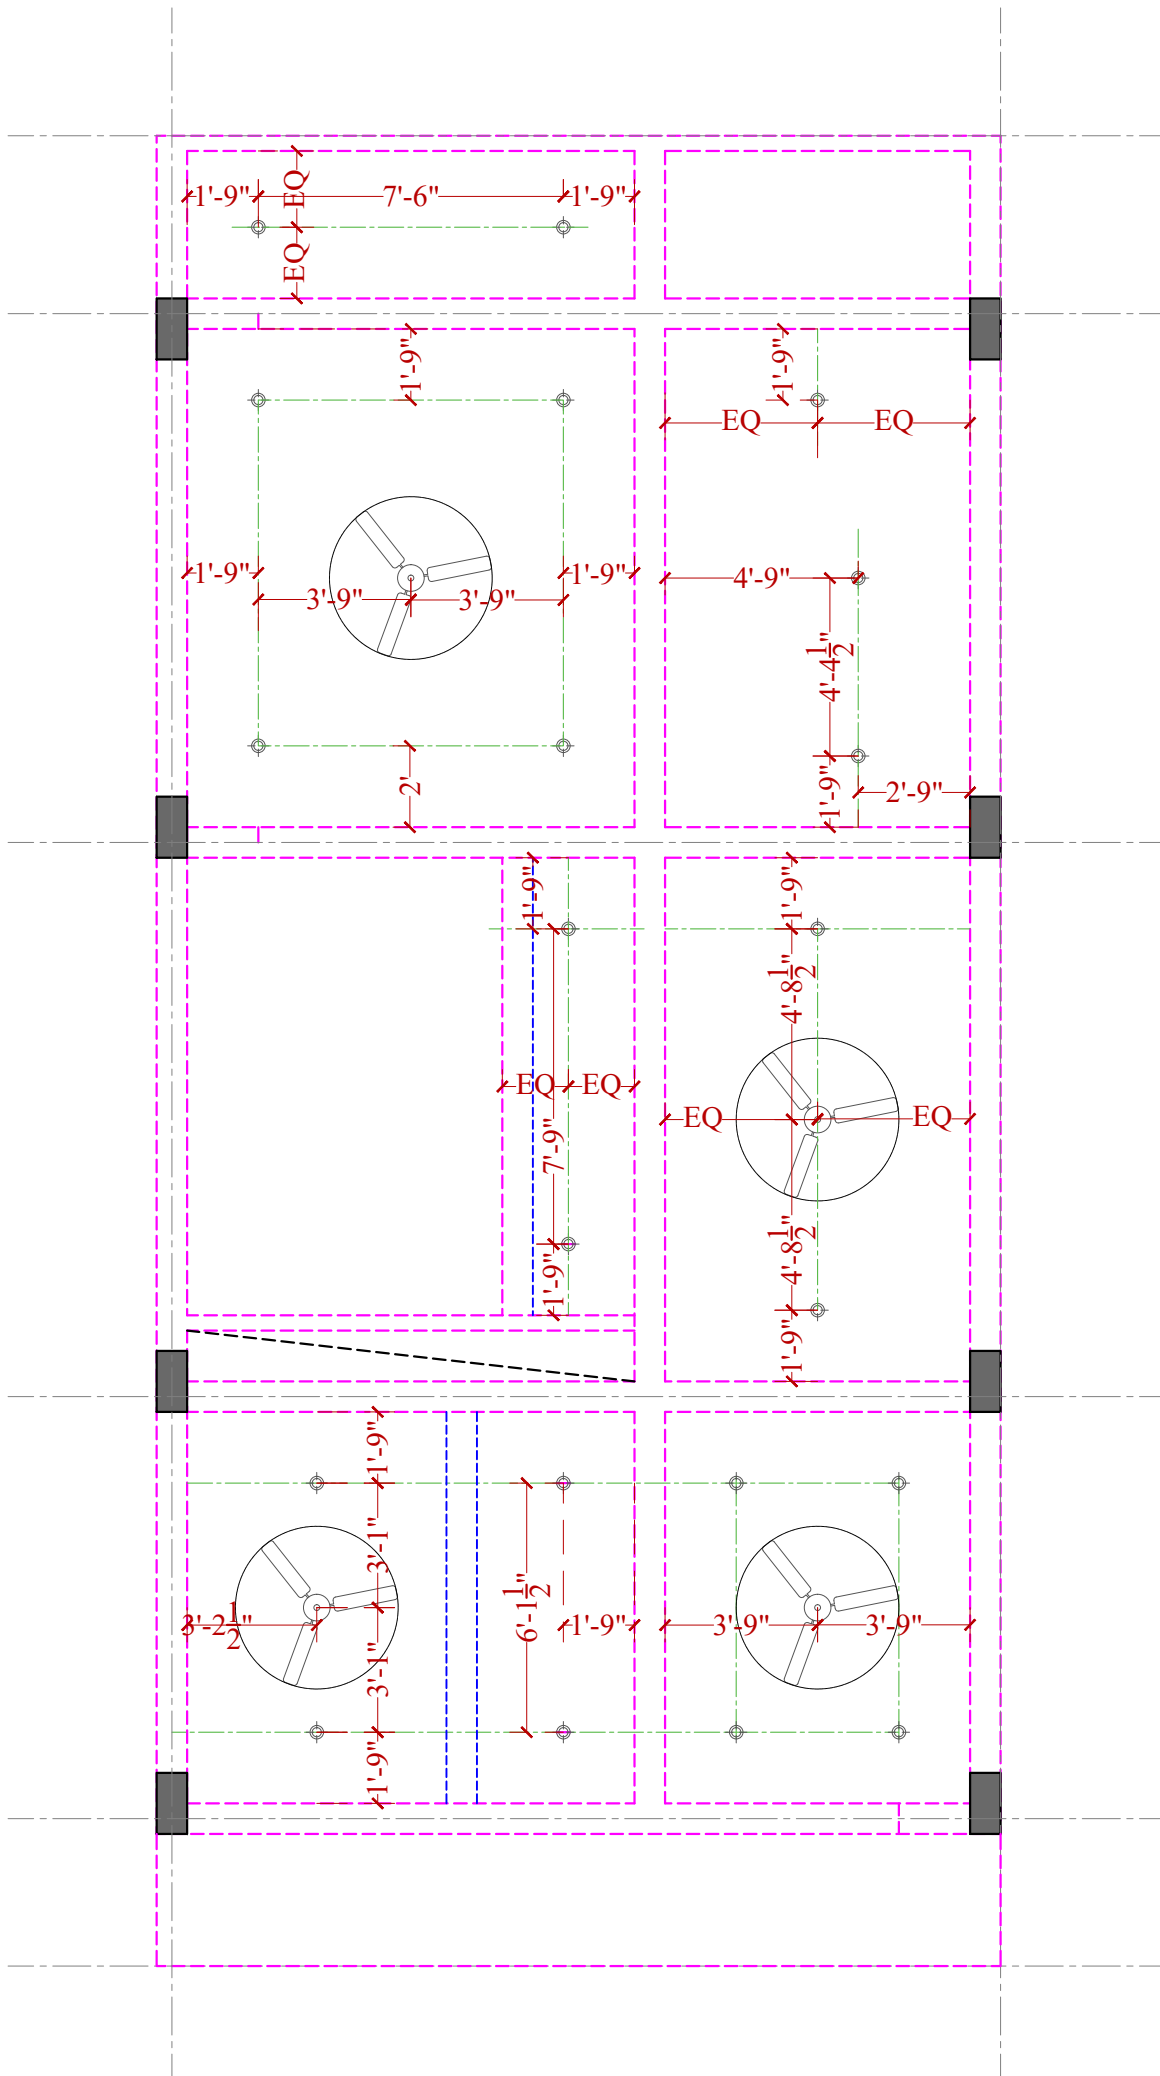

SPECIFICATION:-

1. THIS DRAWING IS THE PROPERTY OF **CARYATID ARCHITECTS** AND SHALL NOT BE USED OR PRODUCE IN ANY MANNER WITHOUT HIS WRITTEN PERMISSION.
2. DIMENSIONS ON THE DRAWINGS ARE TO BE READ NOT SCALED.
3. THE EXECUTING AGENCY IS REQUIRED TO CORRELATE ALL RELEVANT DRAWINGS AND ANY ERRORS OR DISCREPANCIES ARE TO BE BROUGHT TO THE NOTICE OF **CARYATID ARCHITECTS** BEFORE COMMENCE OF WORK

SYMBOL	LEGEND
	CHANDILLIER
	CEILING FAN
	CONCEALED LIGHT
	METER BOX
	MCB BOX
	CCTV CAMERA

दिव्याजीत मारोठिया
DIVYAJEET MAROTHIYA
 (IEI)
 CHARTERED ENGINEER (CIVIL)
 AM 3007165

PROJECT TITLE:-

AFFORDABLE HOUSING SCHEME
 Khasra no. 36/2 of Village - Badgaon,
 Tehsil - Sheoganj, Dist. - Sirahi

CONSULTANTS:-

CHECKED BY:-

Rishabh Sharma

DRAWN BY:-

Parmesver

SIGNATURE:-

SCALE:-

N.T.S.

DATE:- 2025


SHEET:-



SHEET TITLE:-


**MIG FIRST FLOOR ELECTRICAL CONDUCTED
 PLAN**


architects & consultants
 caryatidjaipur@gmail.com
 96020-86971

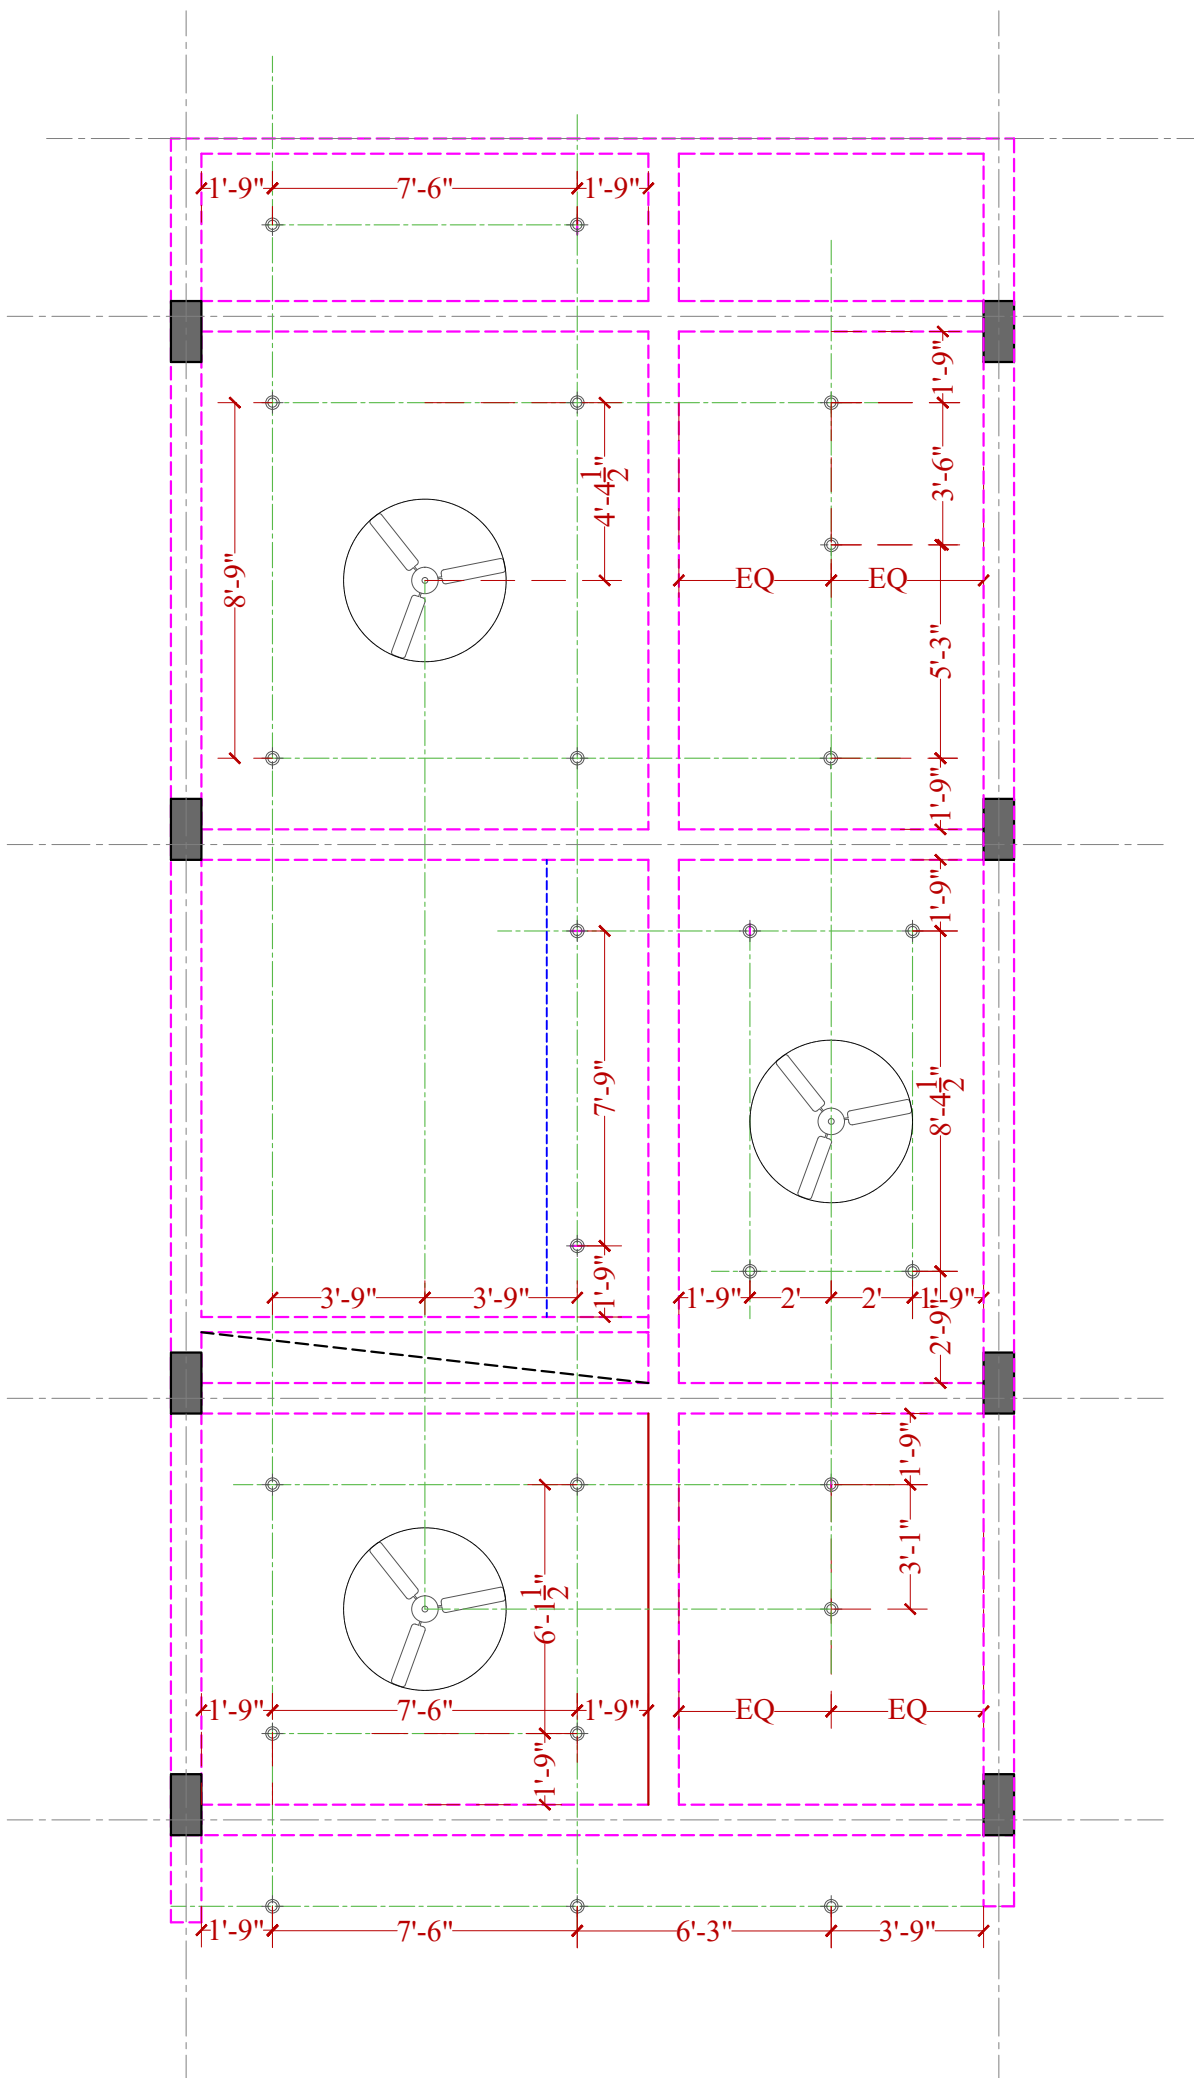

SPECIFICATION:-

1. THIS DRAWING IS THE PROPERTY OF **CARYATID ARCHITECTS** AND SHALL NOT BE USED OR PRODUCE IN ANY MANNER WITHOUT HIS WRITTEN PERMISSION.
2. DIMENSIONS ON THE DRAWINGS ARE TO BE READ NOT SCALED.
3. THE EXECUTING AGENCY IS REQUIRED TO CORRELATE ALL RELEVANT DRAWINGS AND ANY ERRORS OR DISCREPANCIES ARE TO BE BROUGHT TO THE NOTICE OF **CARYATID ARCHITECTS** BEFORE COMMENCE OF WORK

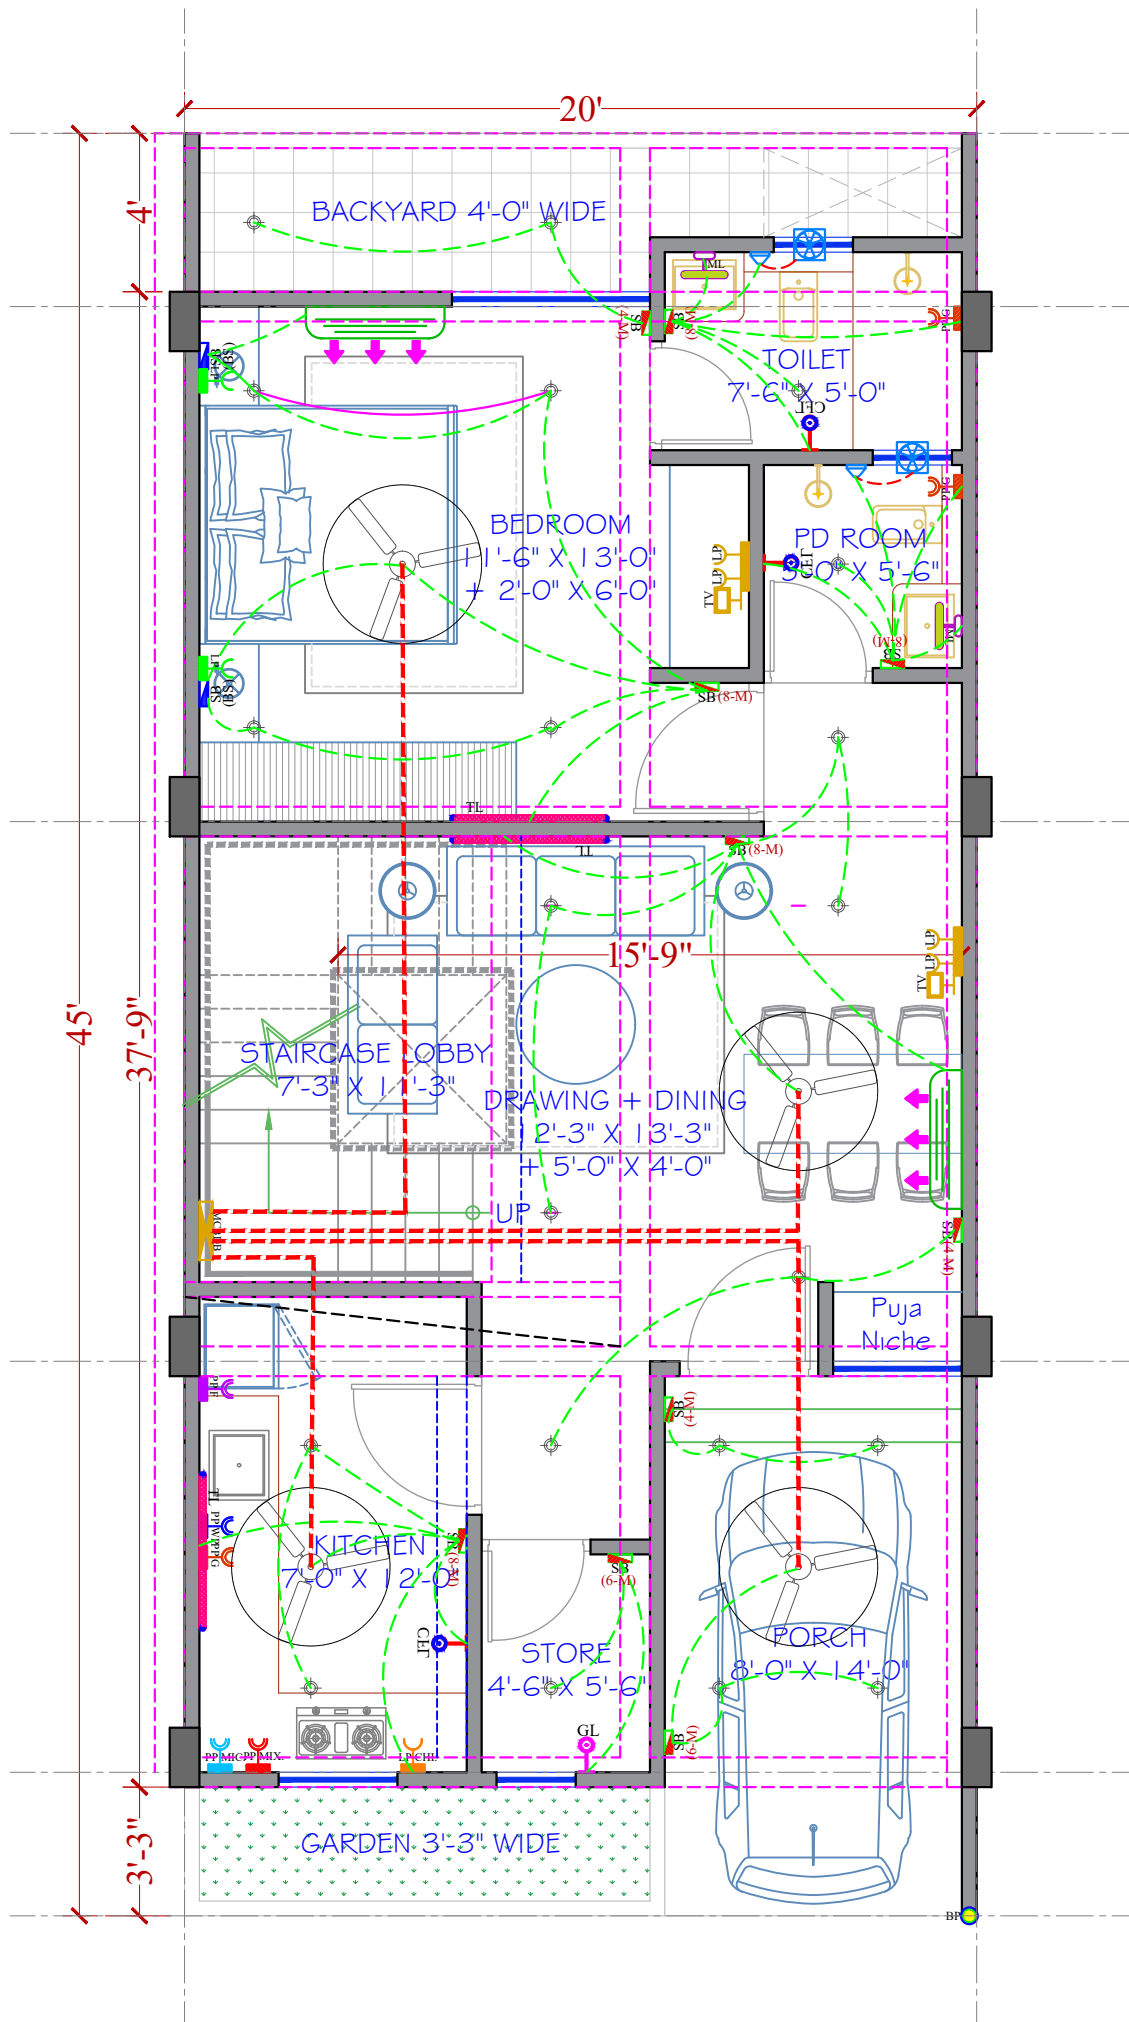

Mounting Height	ID	SYMBOL	DESCRIPTION
IN RCC SLAB	CONDUIT		Rigid PVC Conduit 25mm/1.0 sqmm wire for Light points
IN RCC SLAB	CONDUIT		Rigid PVC Conduit 25mm/2.5 sqmm wire for Light Circuits
IN RCC SLAB	CONDUIT		Rigid PVC Conduit 25mm/4.00 sqmm wire for POWER Circuits
IN RCC SLAB	CONDUIT		Submain wire to Common & Flats DB from Main Panel on Ground Floor in 1 nos. 32 mm dia conduits
CEILING	FAN/48"		CEILING FAN 48"
CEILING	FAN/30"		CEILING FAN 30"
CEILING	CHI		CHANDELIER
CEILING	CL		LED 6" DOWNLIGHTER 20W (SURFACE MOUNTED) MAKE SYSCA LED CAT NO. SKG-15W GLD 6.5K/4K
+90"	TL/W		LED WALL TUBE LIGHT MAKE SYSCA LED CAT NO. SKG-T5-20W
+90"	CFL		LED BULB 20W MAKE SYSCA LED CAT NO. SKG-20W 5.7K/3K
+90"	GL		WALL BRACKET'S GANESH LIGHT AS PER DESIGN
+24"	SB (BS)		SWITCH BOARD (BED SIDE)
+42"	SB		SWITCH BOARD
+78"	ML		12X12" MIRROR LIGHT MAKE SYSCA LED CAT NO. - FPL - 12X2
VENTILATOR HT.	CR		CEILING ROSE
VENTILATOR HT.	EXF		9" DIA FRESH AIR FAN
+24"	TEL		TELEPHONE POINT
+48"	TV		TV COAXIAL POINT.
+24"	LP		6 A PLUG POINT
+48"	LP TV		6 A PLUG POINT FOR TV
+72"	LP-CH		6 A PLUG POINT FOR CHIMNEY
+42"	PP-MIX		15 A POWER POINT FOR MIXER
+42"	PP-MIC		15 A POWER POINT FOR MICROWAVE
+78"	PP-G		15 A POWER POINT FOR GEYSER
+54"	PP-F		15 A POWER POINT FOR FRIDGE
+78"	PP-WP		15 A POWER POINT FOR WATER PURIFIER
+48"	PP-WM		15 A POWER POINT FOR WASHING MACHINE
+18"	PP-INV.		15 A POWER POINT FOR INVERTER
+24"	LP		6 A PLUG POINT
+90"	SP		SPLIT AC INDOOR UNIT
+60"	BP		6 A BELL PUSH
+90"	BZ		BUZZER FOR CALL BELL
+60"	MCB DB		MCB DISTRIBUTION BOARD

दिव्याजीत मारीठिया
DIVYAJEET MAROTHIYA
(IEI)
CHARTERED ENGINEER (CIVIL)
AM 3007165

PROJECT TITLE:-
AFFORDABLE HOUSING SCHEME
Khasra no. 36/2 of Village - Badgaon,
Tehsil - Sheoganj, Distt. - Sirohi
CONSULTANTS:-

CHECKED BY:- Rishabh Sharma	DRAWN BY:- Parmesver
SIGNATURE:-	SCALE:- N.T.S.
	DATE:- 14/08/2025
	NORTH
	SHEET:-

SHEET TITLE:-
MIG UNIT G.F. ELECTRICAL DRAWING

caryatid
architects & consultants
caryatidjaipur@gmail.com
96020-86971

SPECIFICATION:-

- THIS DRAWING IS THE PROPERTY OF **CARYATID ARCHITECTS** AND SHALL NOT BE USED OR PRODUCE IN ANY MANNER WITHOUT HIS WRITTEN PERMISSION.
- DIMENSIONS ON THE DRAWINGS ARE TO BE READ NOT SCALED.
- THE EXECUTING AGENCY IS REQUIRED TO CORRELATE ALL RELEVANT DRAWINGS AND ANY ERRORS OR DISCREPANCIES ARE TO BE BROUGHT TO THE NOTICE OF **CARYATID ARCHITECTS** BEFORE COMMENCE OF WORK

Mounting Height	ID	SYMBOL	DESCRIPTION
IN RCC SLAB	CONDUIT		Rigid PVC Conduit 25mm/1.0 sqmm wire for Light points
IN RCC SLAB	CONDUIT		Rigid PVC Conduit 25mm/2.5 sqmm wire for Light Circuits
IN RCC SLAB	CONDUIT		Rigid PVC Conduit 25mm/4.00 sqmm wire for POWER Circuits
IN RCC SLAB	CONDUIT		Submain wire to Common & Flats DB from Main Panel on Ground Floor in 1 nos. 32 mm dia conduits
CEILING	FAN/48"		CEILING FAN 48"
CEILING	FAN/30"		CEILING FAN 30"
CEILING	CHI		CHANDELIER
CEILING	CL		LED 8" DOWNLIGHTER 20W (SURFACE MOUNTED) MAKE SYSCA LED CAT NO. SSC-15W GLD 6.5K/4K
+90"	TL/W		LED WALL TUBE LIGHT MAKE SYSCA LED CAT NO. SSC-15-20W
+90"	CFL		LED BULB 20W MAKE SYSCA LED CAT NO. SSC-20W 5.7K/3K
+90"	GL		WALL BRACKETS GANESH LIGHT AS PER DESIGN
+24"	SB (BS)		SWITCH BOARD (BED SIDE)
+42"	SB		SWITCH BOARD
+78"	ML		12X2 LED MIRROR LIGHT MAKE SYSCA LED CAT NO. - FPL - 12X2
VENTILATOR HT	CR		CEILING ROSE
VENTILATOR HT	EXF		9" DIA FRESH AIR FAN
+24"	TEL		TELEPHONE POINT
+48"	TV		TV COAXIAL POINT.
+24"	LP		6 A PLUG POINT
+48"	LP TV		6 A PLUG POINT FOR TV
+72"	LP-CH		6 A PLUG POINT FOR CHIMNEY
+42"	PP-MIX		15 A POWER POINT FOR MIXER
+42"	PP-MIC		15 A POWER POINT FOR MICROWAVE
+78"	PP-G		15 A POWER POINT FOR GEYSER
+54"	PP-F		15 A POWER POINT FOR FRIDGE
+78"	PP-WP		15 A POWER POINT FOR WATER PURIFIER
+48"	PP-WM		15 A POWER POINT FOR WASHING MACHINE
+18"	PP-INV.		15 A POWER POINT FOR INVERTER
+24"	LP		6 A PLUG POINT
+90"	SP		SPLIT AC INDOOR UNIT
+60"	BP		6 A BELL PUSH
+90"	BZ		BUZZER FOR CALL BELL
+60"	MCB DB		MCB DISTRIBUTION BOARD

दिव्याजीत मारोठिया
DIVYAJEET MAROTHIYA
(IEI)
CHARTERED ENGINEER (CIVIL)
AM 3007165

PROJECT TITLE:-

AFFORDABLE HOUSING SCHEME
Khasra no. 36/2 of Village - Badgaon,
Tehsil - Sheoganj, Distt. - Sirahi
CONSULTANTS:-

CHECKED BY:-

Rishabh Sharma Parmesver

SIGNATURE:-


N.T.S. 14 06 2025

NORTH

SHEET:-

SHEET TITLE:-
MIG UNIT FRIST FLOOR ELECTRICAL
DRAWING

caryatid
architects & consultants
caryatidjaipur@gmail.com
96020-86971

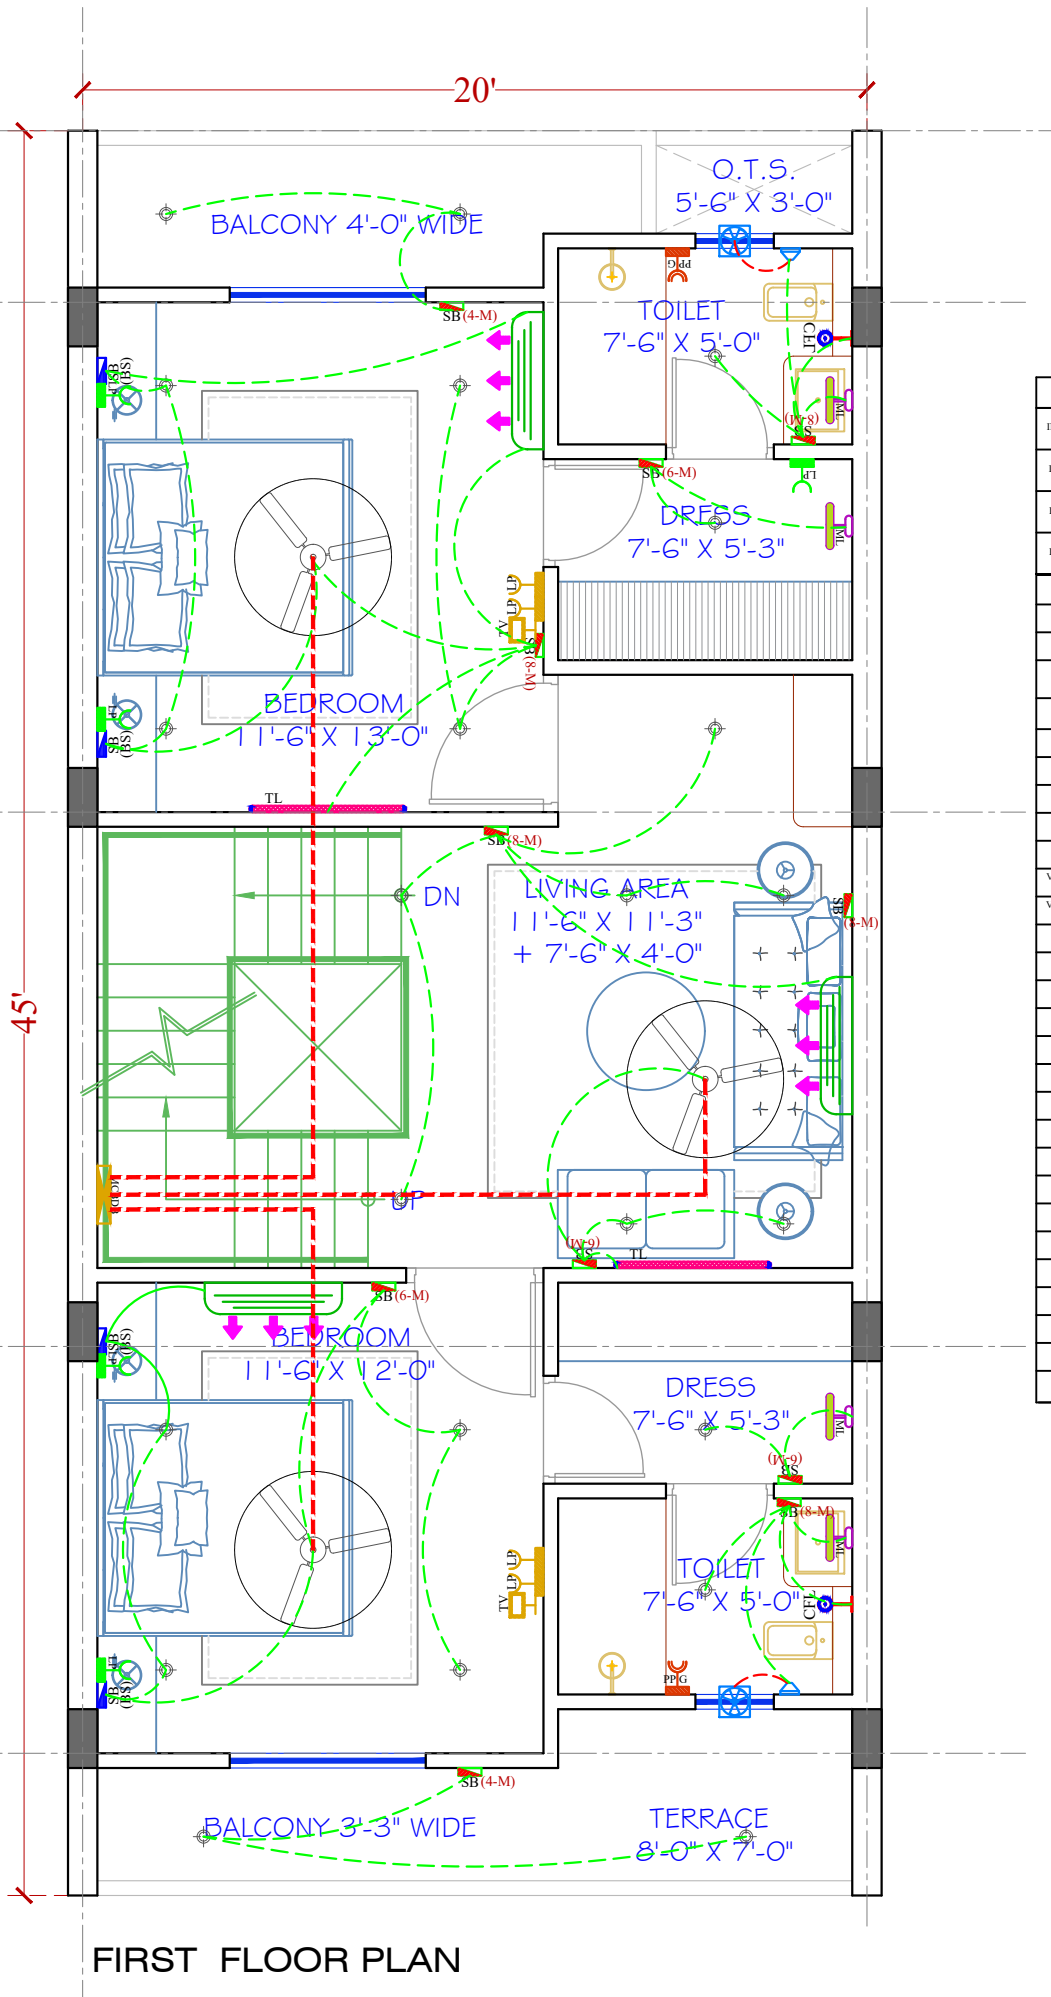

FIRST FLOOR PLAN