


SPECIFICATION:-

1. THIS DRAWING IS THE PROPERTY OF **CARYATID ARCHITECTS** AND SHALL NOT BE USED OR PRODUCE IN ANY MANNER WITHOUT HIS WRITTEN PERMISSION.
2. DIMENSIONS ON THE DRAWINGS ARE TO BE READ NOT SCALED.
3. THE EXECUTING AGENCY IS REQUIRED TO CORRELATE ALL RELEVANT DRAWINGS AND ANY ERRORS OR DISCREPANCIES ARE TO BE BROUGHT TO THE NOTICE OF **CARYATID ARCHITECTS** BEFORE COMMENCE OF WORK.

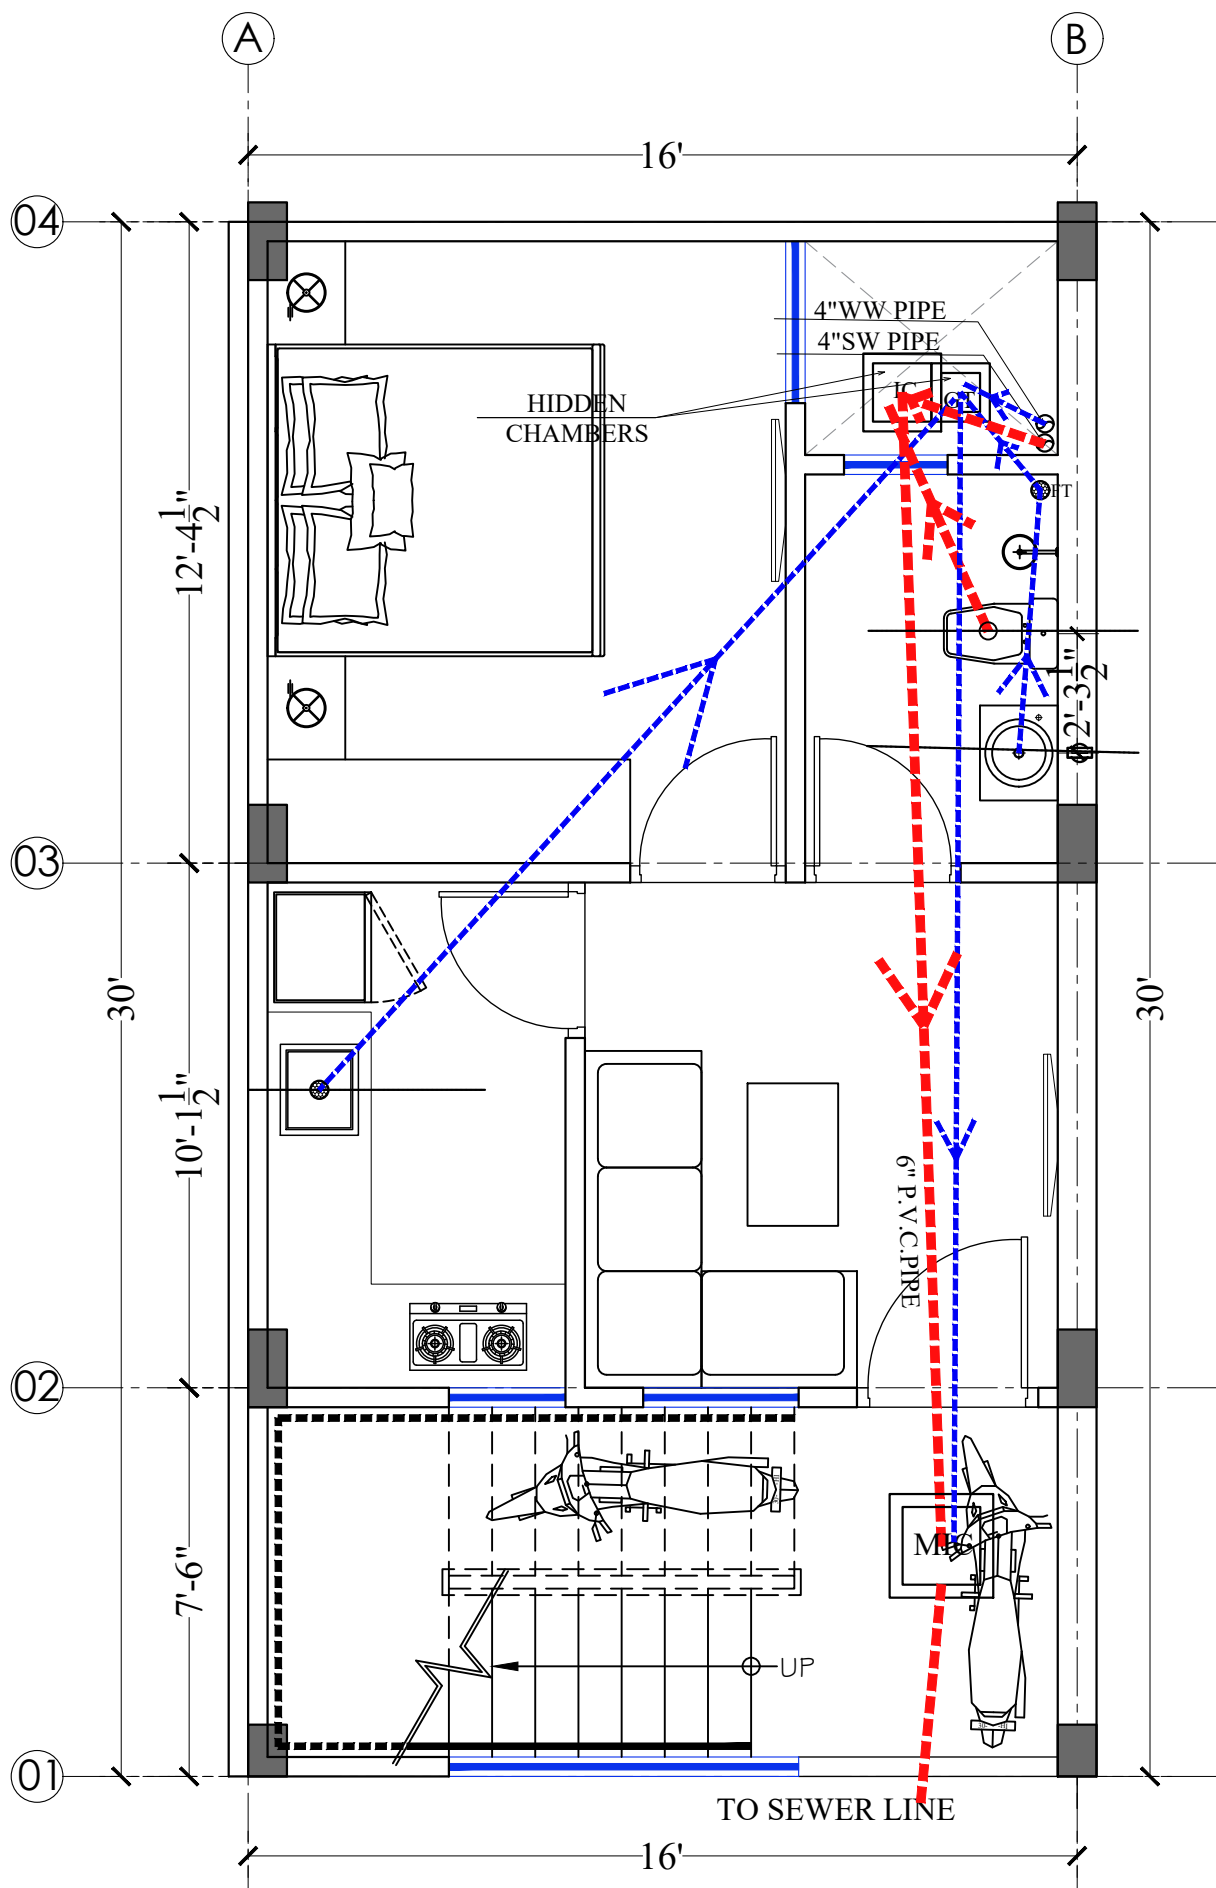


दिव्याजीत मरोठिया
DIVYAJEET MAROTHIYA
(IEI)
CHARTERED ENGINEER (CIVIL)
AM 3007165

PROJECT TITLE:- AFFORDABLE HOUSING SCHEME Khasra no. 36/2 of Village - Badgaon, Tehsil - Sheoganj, Distt. - Sirahi		
CONSULTANTS:-		
CHECKED BY:- Rishabh Sharma	DRAWN BY:- Parmesver	
SIGNATURE:-	SCALE:- N.T.S.	DATE:- 14/04/2025
	NORTH ↑	SHEET:-
SHEET TITLE:- EWS UNIT G.F. TOILET PIPE DETAILS		
 caryatid architects & consultants caryatidjaipur@gmail.com 96020-86971		


SPECIFICATION:-

1. THIS DRAWING IS THE PROPERTY OF **CARYATID ARCHITECTS** AND SHALL NOT BE USED OR PRODUCE IN ANY MANNER WITHOUT HIS WRITTEN PERMISSION.
2. DIMENSIONS ON THE DRAWINGS ARE TO BE READ NOT SCALED.
3. THE EXECUTING AGENCY IS REQUIRED TO CORRELATE ALL RELEVANT DRAWINGS AND ANY ERRORS OR DISCREPANCIES ARE TO BE BROUGHT TO THE NOTICE OF **CARYATID ARCHITECTS** BEFORE COMMENCE OF WORK

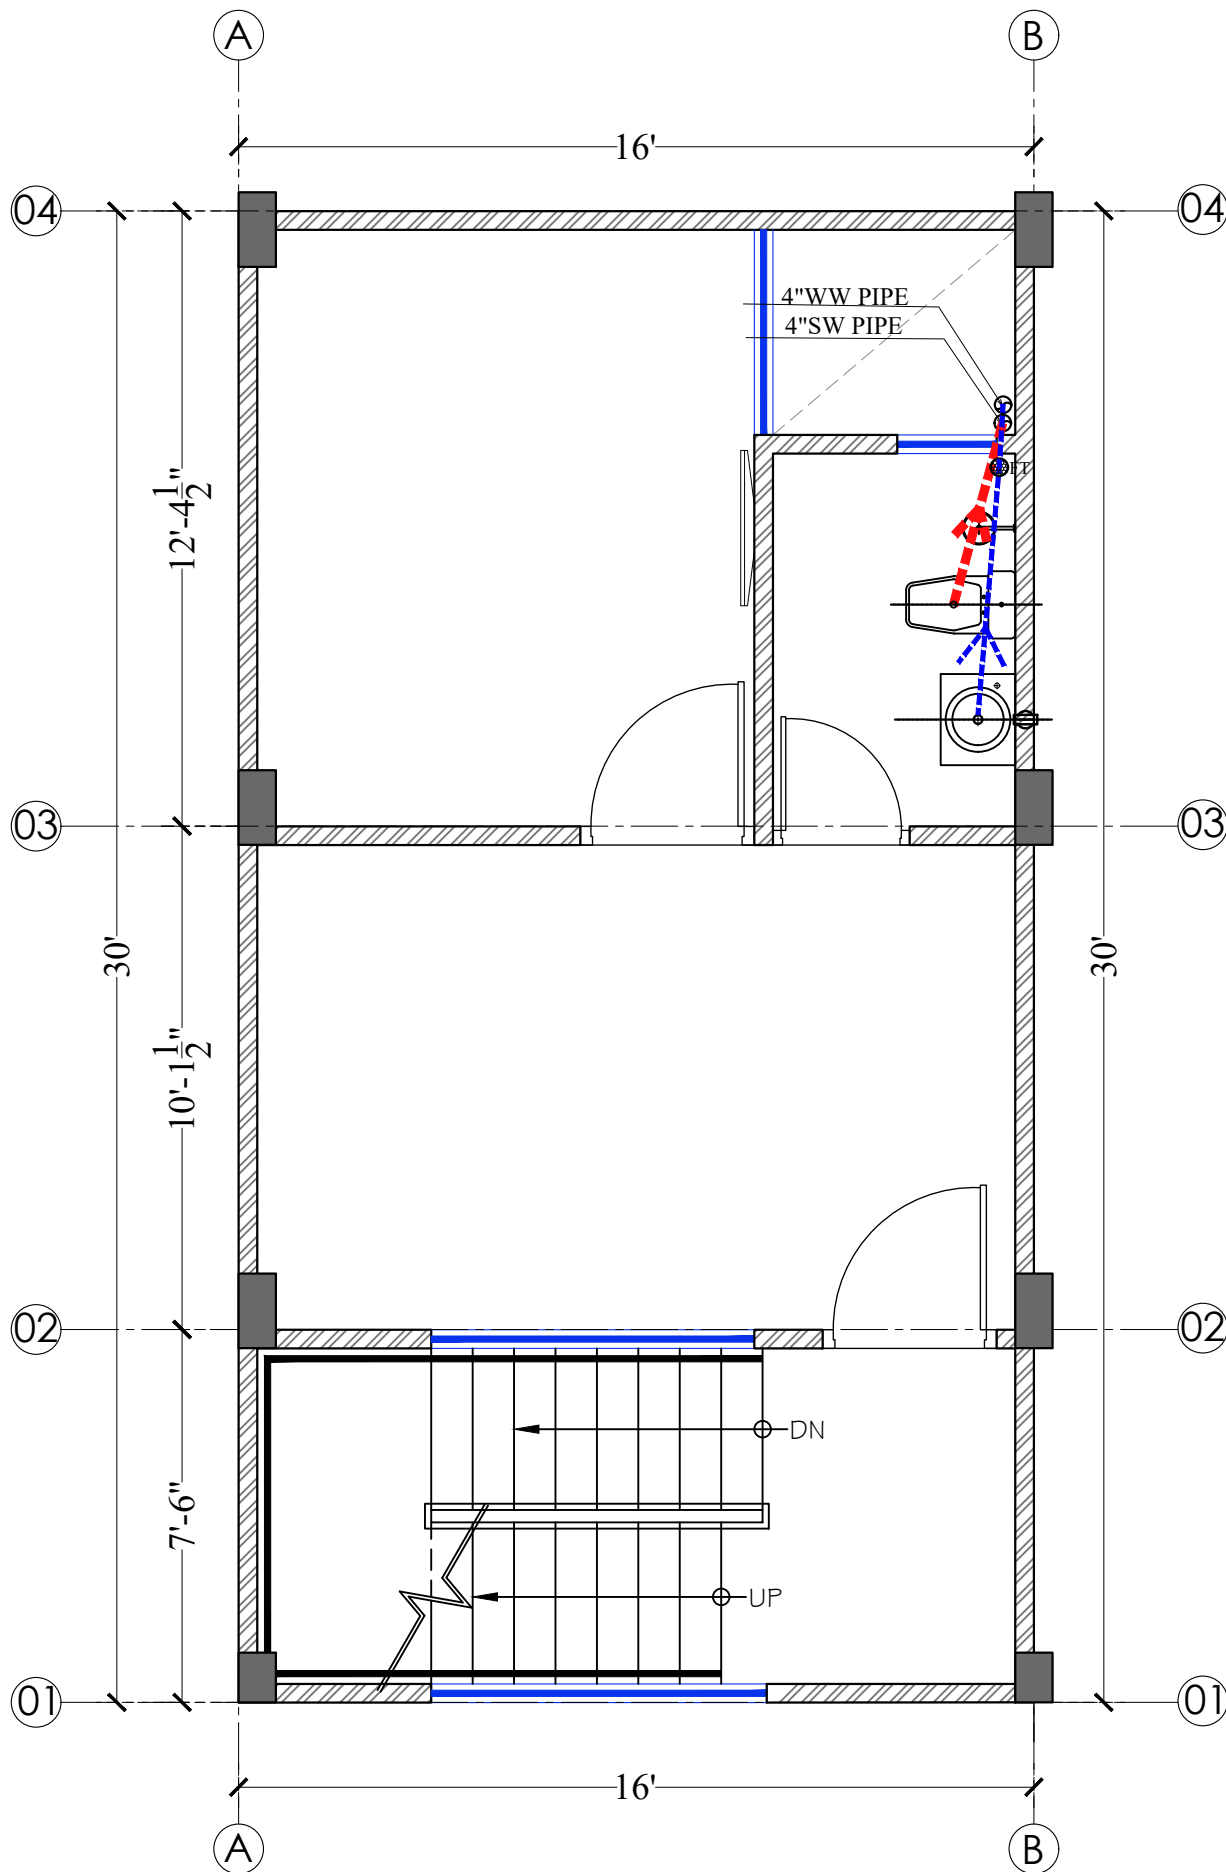

दिव्यजीत मरोठिया
DIVYAJEET MAROTHIYA
(IEI)
CHARTERED ENGINEER (CIVIL)
AM 3007165

PROJECT TITLE:- AFFORDABLE HOUSING SCHEME Khasra no. 36/2 of Village - Badgaon, Tehsil - Sheoganj, Distt. - Sirahi		
CONSULTANTS:-		
CHECKED BY:- Rishabh Sharma	DRAWN BY:- Parmesver	
SIGNATURE:-	SCALE:- N.T.S.	DATE:- 16/08/2025
	NORTH ↑	SHEET:-
SHEET TITLE:- EWS FIRST FLOOR TOILET PIPE DETAILS		
 caryatid architects & consultants caryatidjaipur@gmail.com 96020-86971		

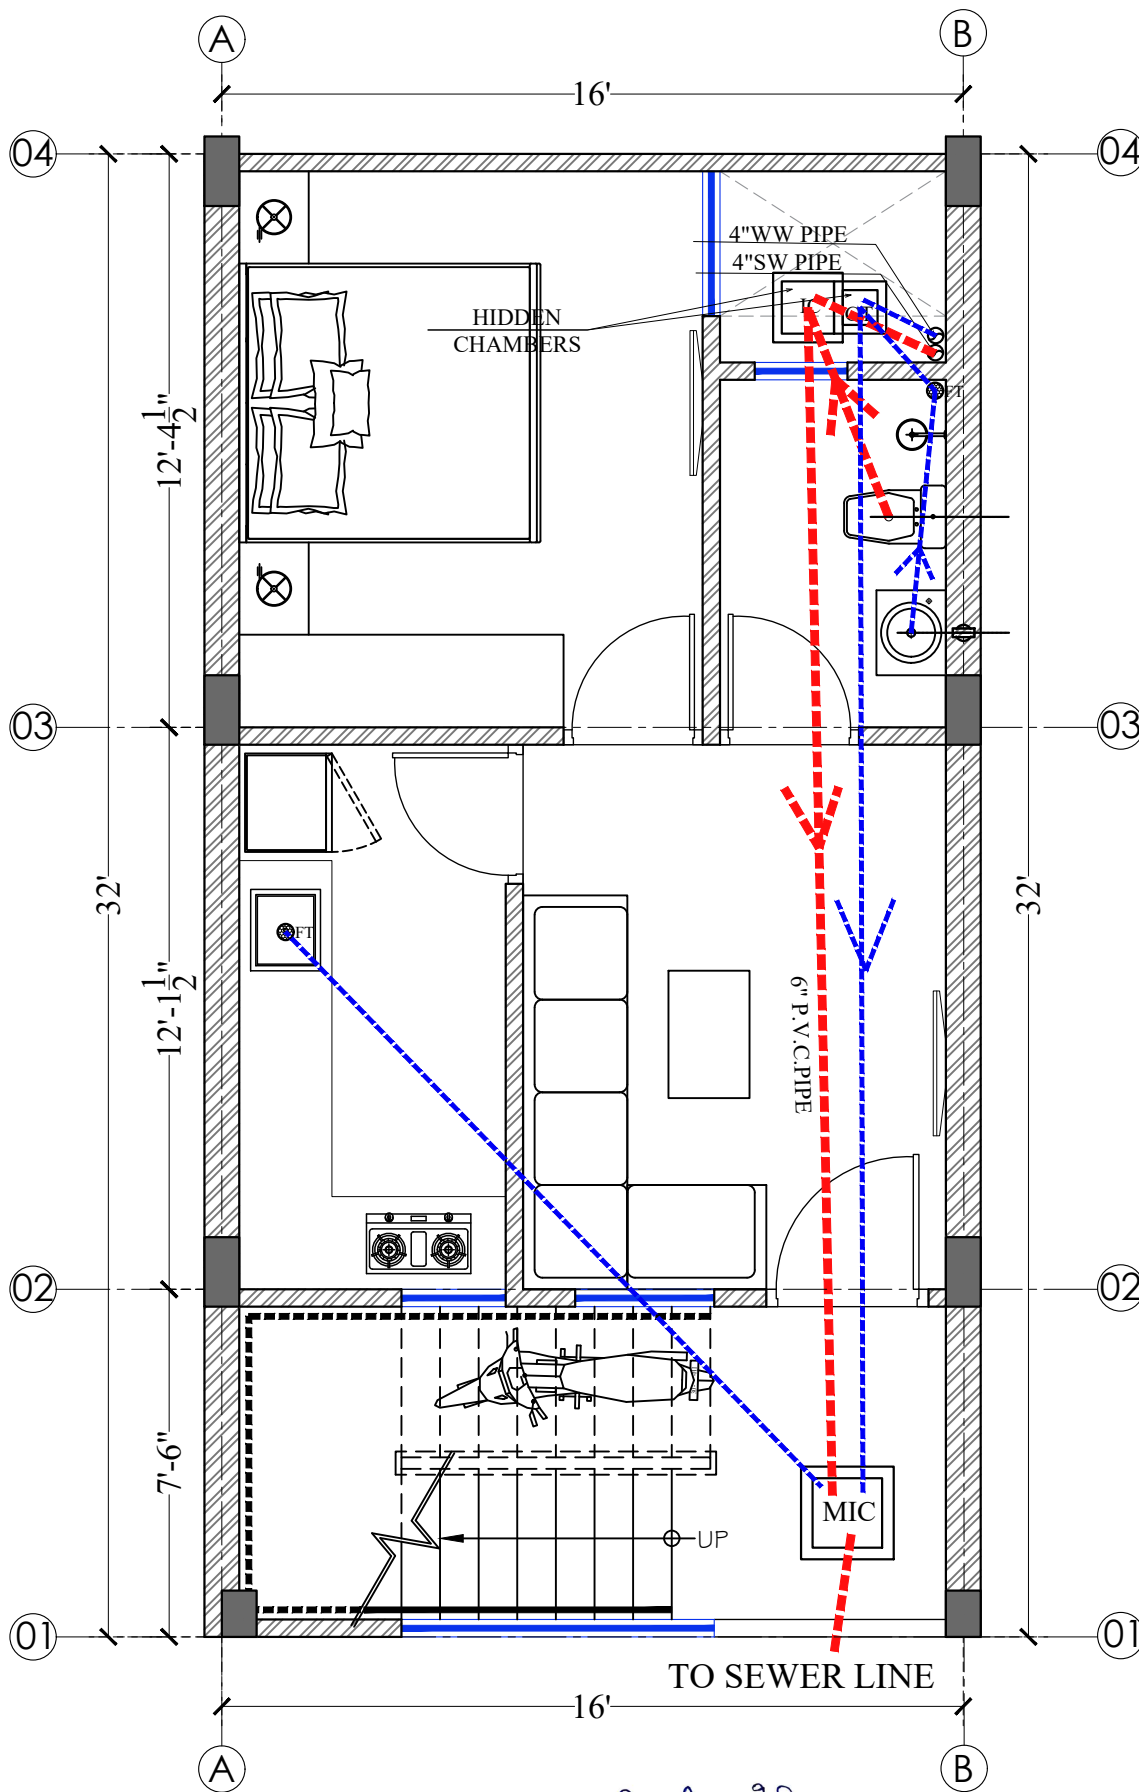

दिव्याजीत मारोथिया
DIVYAJEET MAROTHIYA
(IEI)
CHARTERED ENGINEER (CIVIL)
AM 3007165

SPECIFICATION:-

1. THIS DRAWING IS THE PROPERTY OF **CARYATID ARCHITECTS** AND SHALL NOT BE USED OR PRODUCE IN ANY MANNER WITHOUT HIS WRITTEN PERMISSION.
2. DIMENSIONS ON THE DRAWINGS ARE TO BE READ NOT SCALED.
3. THE EXECUTING AGENCY IS REQUIRED TO CORRELATE ALL RELEVANT DRAWINGS AND ANY ERRORS OR DISCREPANCIES ARE TO BE BROUGHT TO THE NOTICE OF **CARYATID ARCHITECTS** BEFORE COMMENCE OF WORK

PROJECT TITLE:-
AFFORDABLE HOUSING SCHEME
Khasra no. 36/2 of Village - Badgaon,
Tehsil - Sheoganj, Distt. - Sirahi

CONSULTANTS:-


CHECKED BY:- Rishabh Sharma	DRAWN BY:- Parmesver
SIGNATURE:-	SCALE:- N.T.S.
	DATE:- # 2025
	NORTH SHEET:-

SHEET TITLE:-
EWS UNIT G.F. TOILET PIPE DETAILS

caryatid
architects & consultants
caryatidjaipur@gmail.com
96020-86971

SPECIFICATION:-

1. THIS DRAWING IS THE PROPERTY OF **CARYATID ARCHITECTS** AND SHALL NOT BE USED OR PRODUCE IN ANY MANNER WITHOUT HIS WRITTEN PERMISSION.
2. DIMENSIONS ON THE DRAWINGS ARE TO BE READ NOT SCALED.
3. THE EXECUTING AGENCY IS REQUIRED TO CORRELATE ALL RELEVANT DRAWINGS AND ANY ERRORS OR DISCREPANCIES ARE TO BE BROUGHT TO THE NOTICE OF **CARYATID ARCHITECTS** BEFORE COMMENCE OF WORK

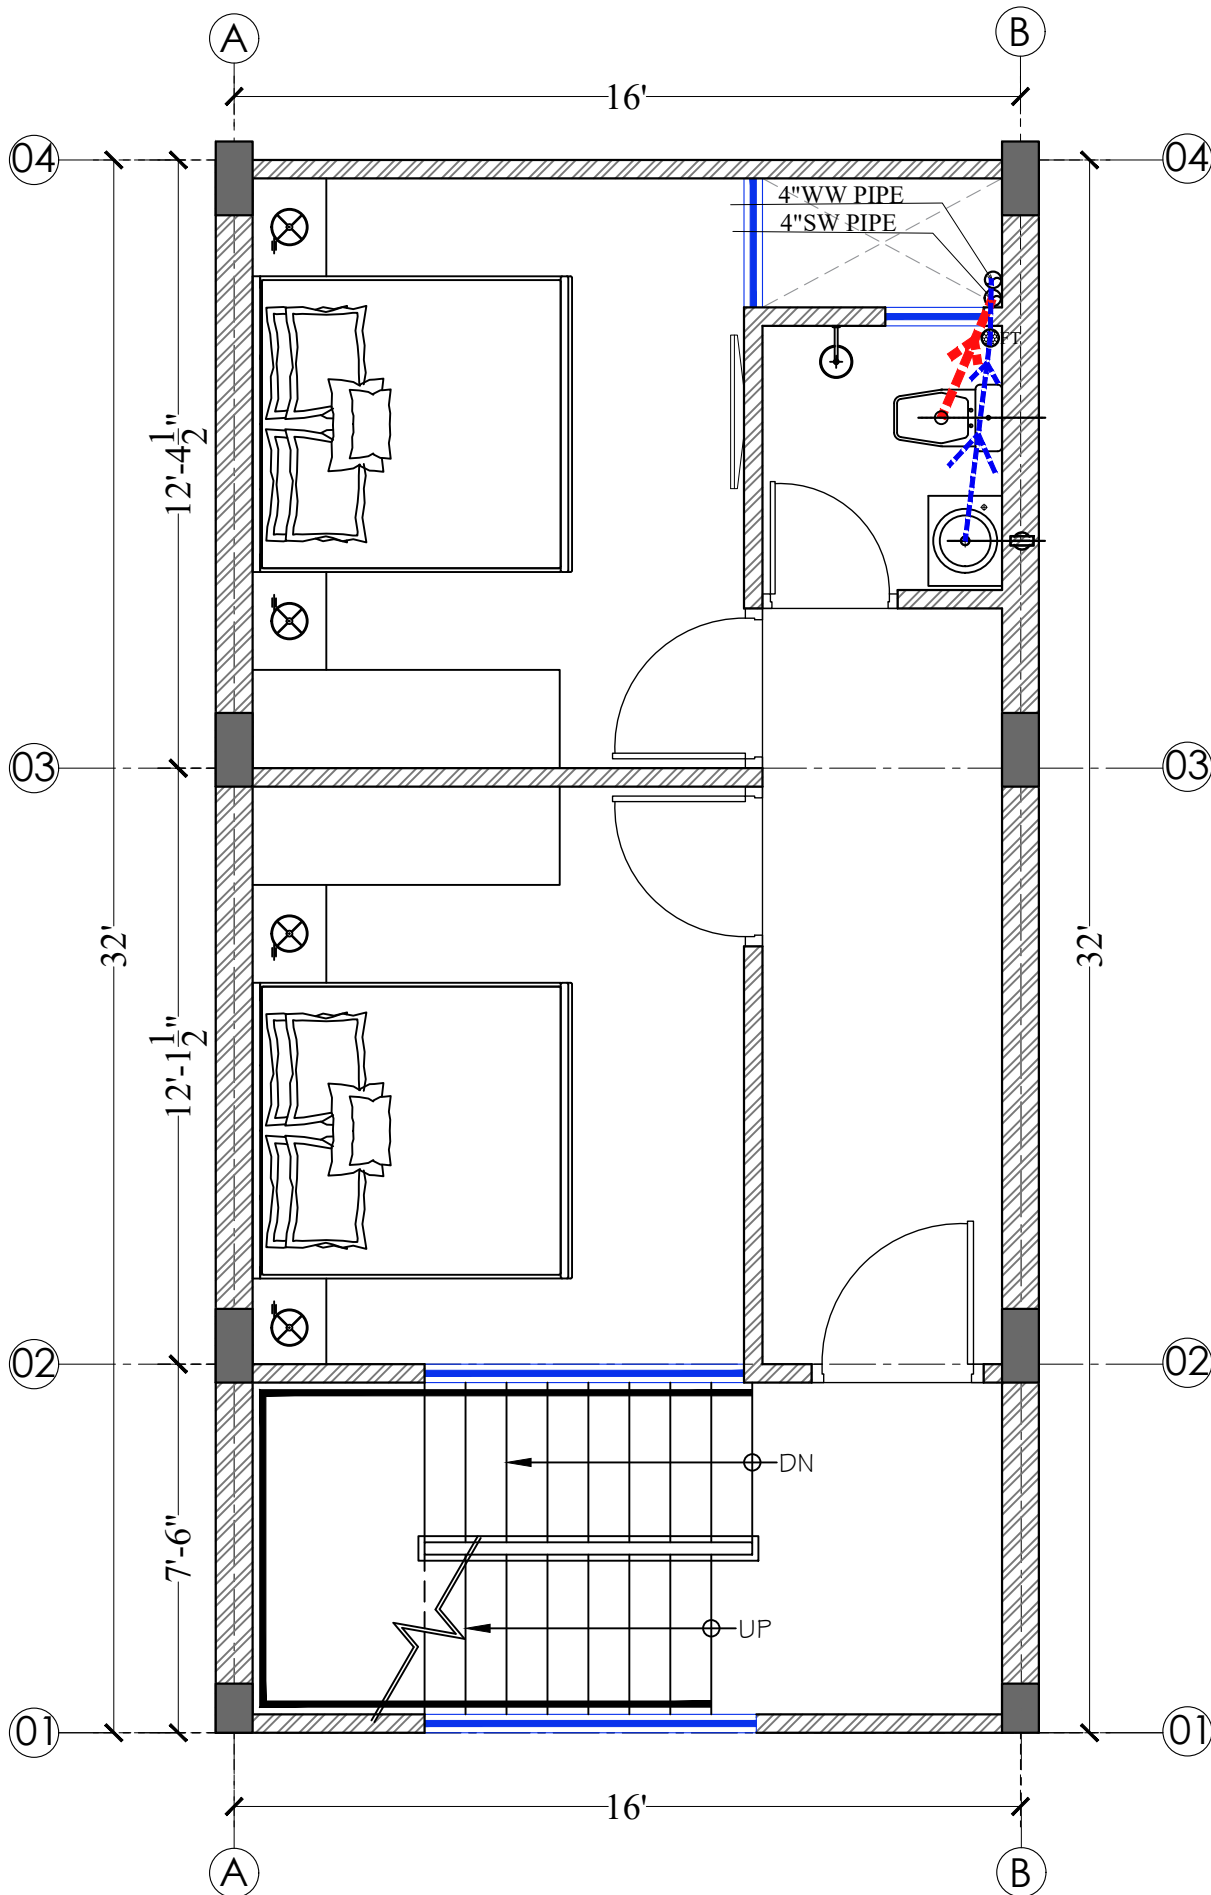

दिव्यजीत मारीठिया
DIVYAJEET MAROTHIYA
(IEI)
CHARTERED ENGINEER (CIVIL)
AM 3007165


PROJECT TITLE:-
AFFORDABLE HOUSING SCHEME
Khasra no. 36/2 of Village - Badgaon,
Tehsil - Sheoganj, Distt. - Sirahi

CONSULTANTS:-

CHECKED BY:- Rishabh Sharma	DRAWN BY:- Parmesver
SIGNATURE:-	SCALE:- N.T.S.
	DATE:- 16/04/2025
	NORTH SHEET:-

SHEET TITLE:-
EWS UNIT FIRST FLOOR TOILET PIPE DETAILS

caryatid
architects & consultants
caryatidjaipur@gmail.com
96020-86971

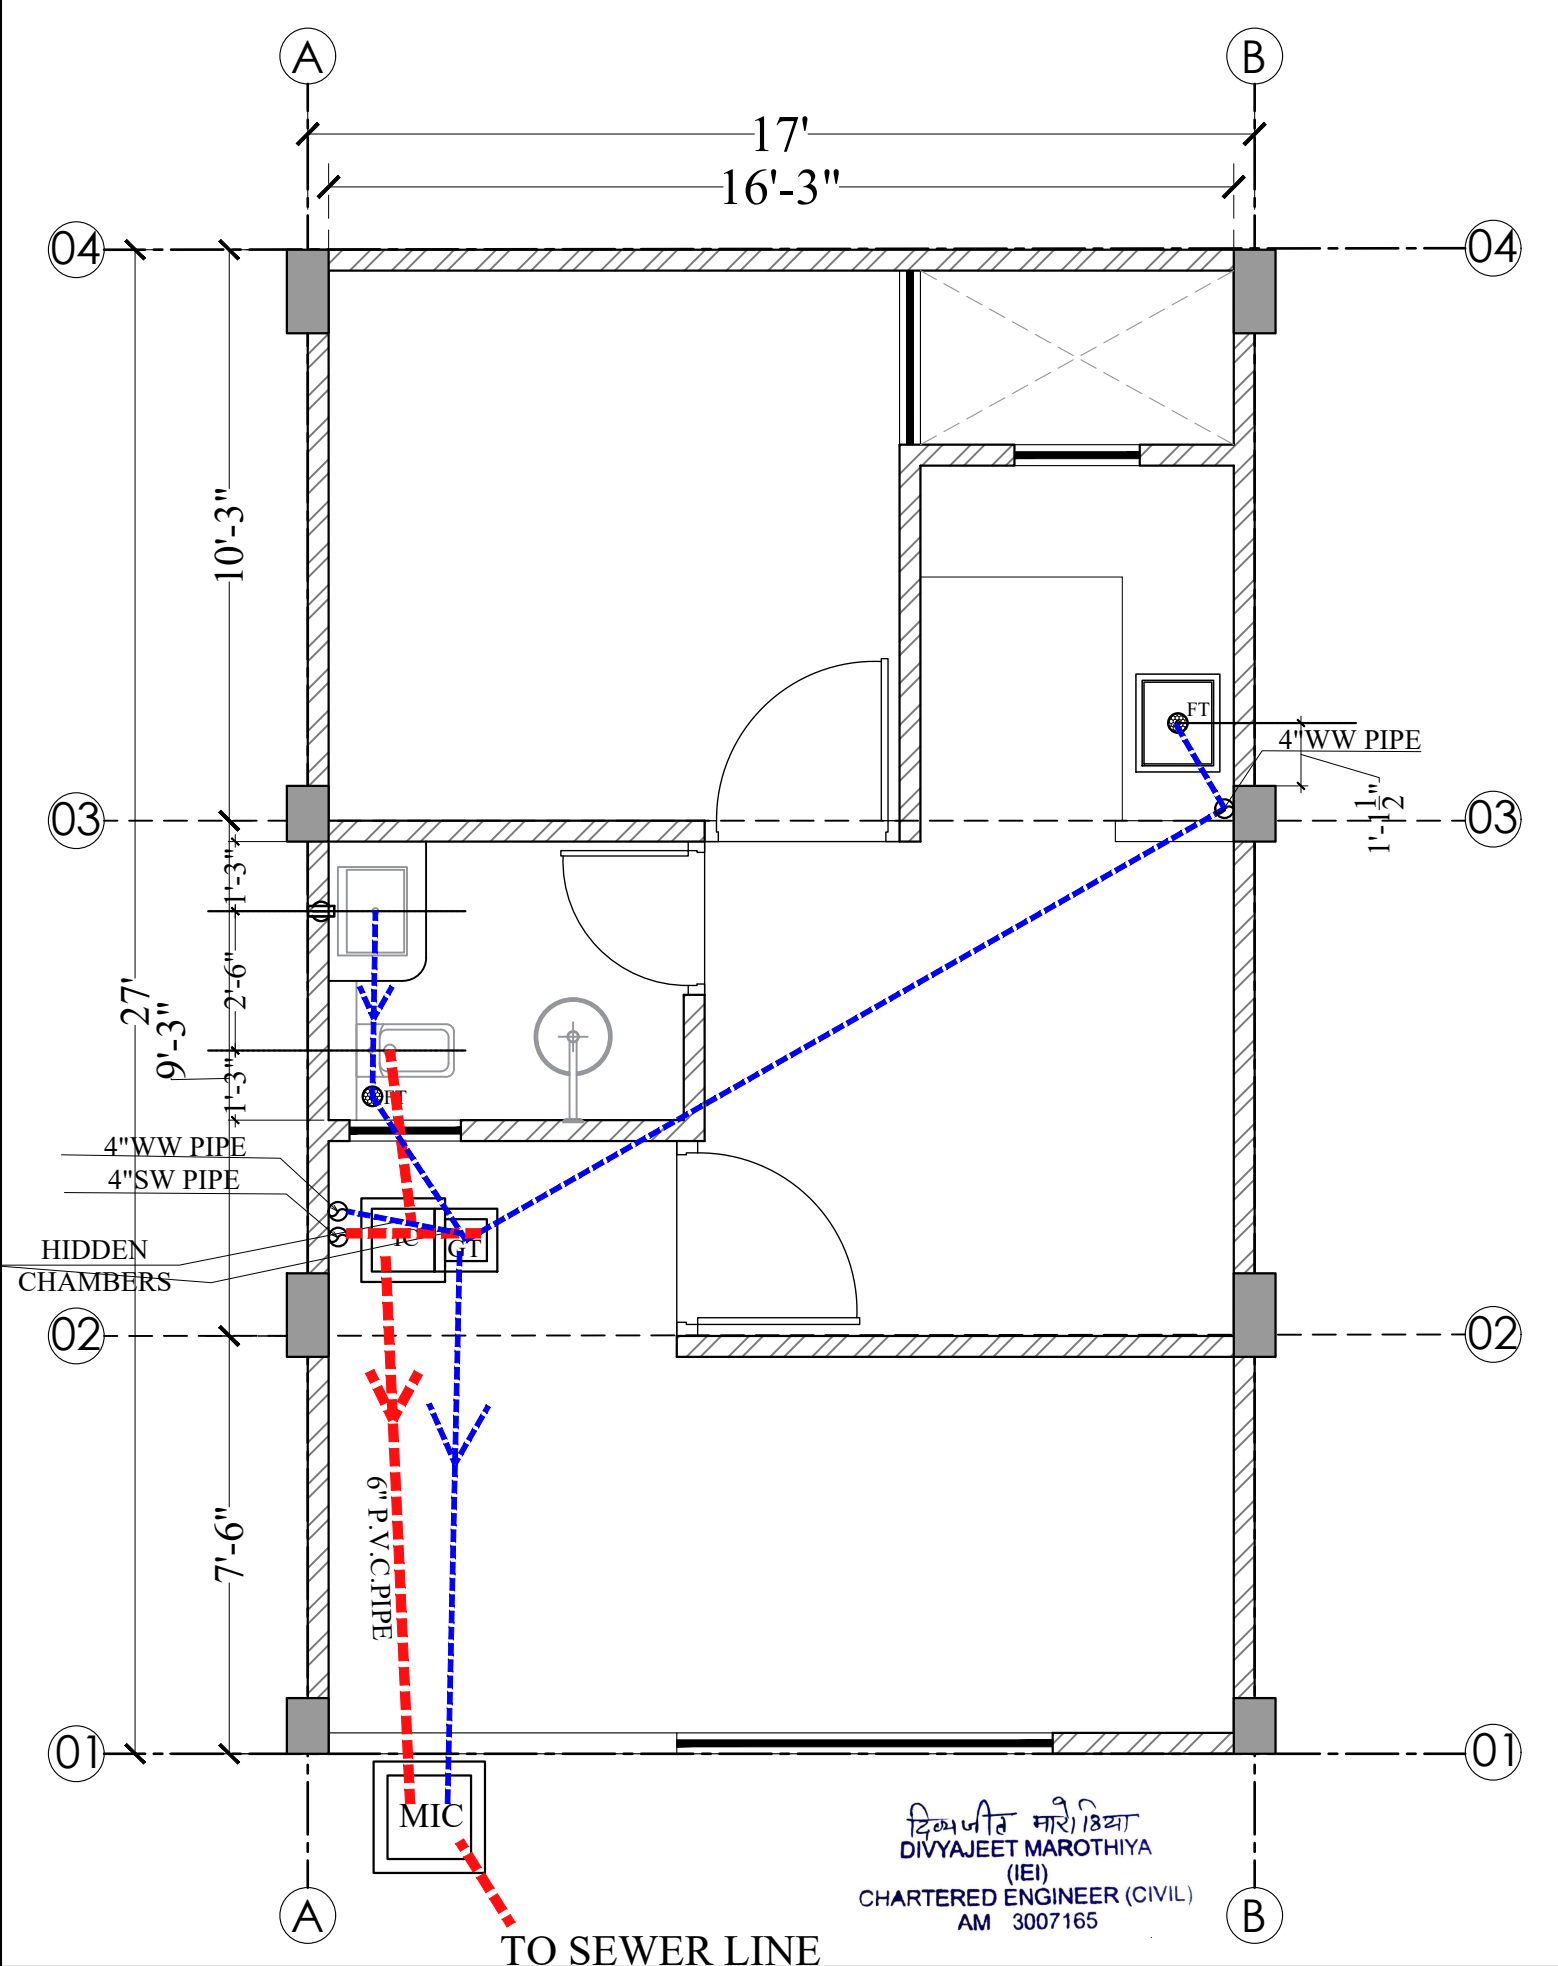


दिव्यजीत मारीठिया
DIVYAJEET MAROTHIYA
(IEI)
CHARTERED ENGINEER (CIVIL)
AM 3007165

TO SEWER LINE

SPECIFICATION 1. THIS DRAWING IS THE PROPERTY OF CARYATID ARCHITECTS AND SHALL NOT BE USED OR PRODUCE IN ANY MANNER WITHOUT HIS WRITTEN PERMISSION. 2. DIMENSIONS ON THE DRAWINGS ARE TO BE READ NOT SCALED. 3. THE EXECUTING AGENCY IS REQUIRED TO CORRELATE ALL RELEVANT DRAWINGS AND ANY ERRORS OR DISCREPANCIES ARE TO BE BROUGHT TO THE NOTICE OF CARYATID ARCHITECTS BEFORE COMMENCE OF WORK	PROJECT TITLE:- AFFORDABLE HOUSING SCHEME Khasra no. 36/2 of Village - Badgaon, Tehsil - Sheoganj, Distt. - Sirahi CONSULTANTS:- RAMESH JANGID (Structure Consultant)	CHECKED BY:- Rishabh Sharma SIGNATURE:- DRAWING NO:-	DRAWN BY:- Parmesver SCALE:- N.T.S. DATE:- 14/04/2025 NORTH 	SHEET TITLE:- EWS UNIT G.F. PLAMING PLAN  architects & consultants caryatidjaipur@gmail.com 96020-86971
--	--	--	--	--

SPECIFICATION:-

1. THIS DRAWING IS THE PROPERTY OF **CARYATID ARCHITECTS** AND SHALL NOT BE USED OR PRODUCE IN ANY MANNER WITHOUT HIS WRITTEN PERMISSION.
2. DIMENSIONS ON THE DRAWINGS ARE TO BE READ NOT SCALED.
3. THE EXECUTING AGENCY IS REQUIRED TO CORRELATE ALL RELEVANT DRAWINGS AND ANY ERRORS OR DISCREPANCIES ARE TO BE BROUGHT TO THE NOTICE OF **CARYATID ARCHITECTS** BEFORE COMMENCE OF WORK

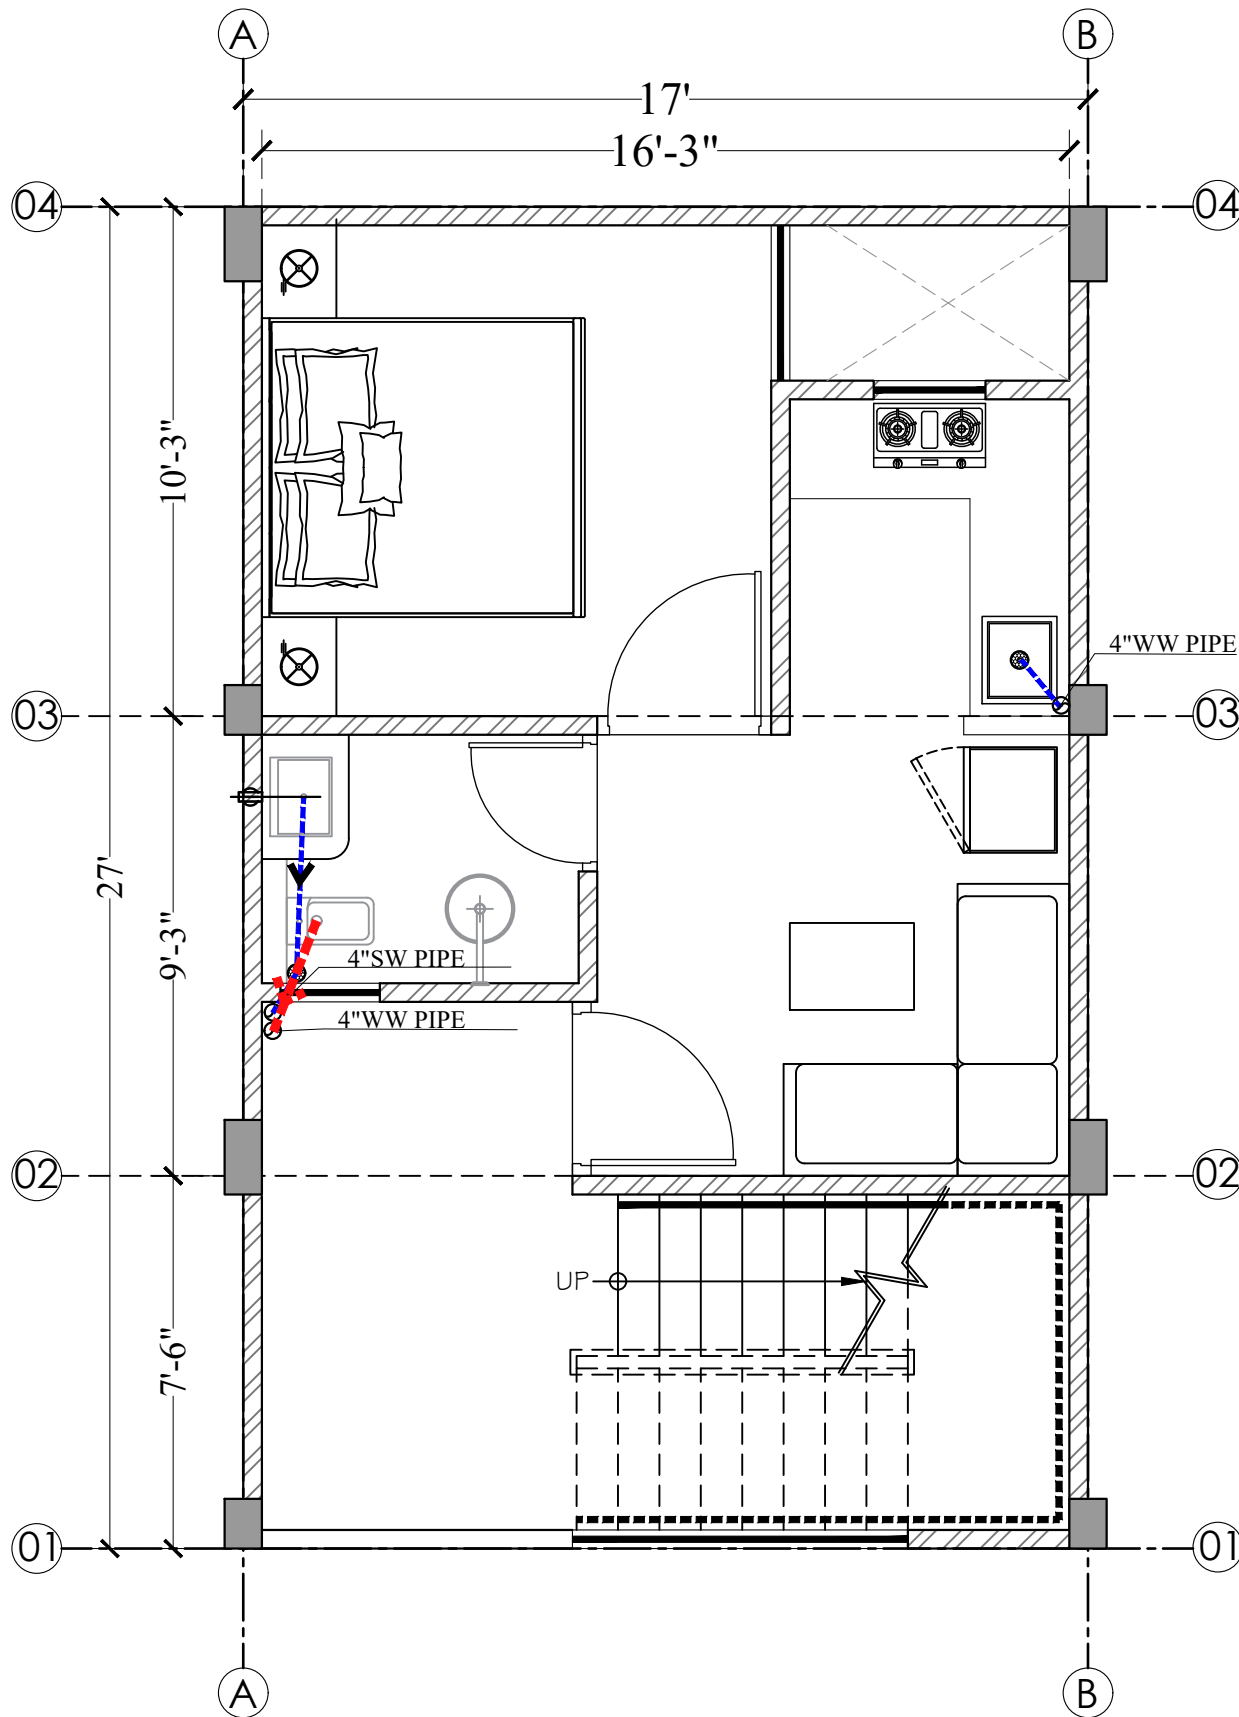

दिव्यजीत मरोथिया
DIVYAJEET MAROTHIYA
(IEI)
CHARTERED ENGINEER (CIVIL)
AM 3007165

PROJECT TITLE:- AFFORDABLE HOUSING SCHEME Khasra no. 36/2 of Village - Badgaon, Tehsil - Sheoganj, Distt. - Sirahi	
CONSULTANTS: -	
CHECKED BY:- Rishabh Sharma	DRAWN BY:- Parmesver
SIGNATURE:-	SCALE:- N.T.S.
	DATE:- 18/08/2025
	NORTH SHEET:-
SHEET TITLE:- EWS UNIT FIRST FLOOR TOILET PIPE DETAILS	
 caryatid architects & consultants caryatidjaipur@gmail.com 96020-86971	

1. THIS DRAWING IS THE PROPERTY OF CARYATID ARCHITECTS AND SHALL NOT BE USED OR PRODUCE IN ANY MANNER WITHOUT HIS WRITTEN PERMISSION.
2. DIMENSIONS ON THE DRAWINGS ARE TO BE READ NOT SCALED.
3. THE EXECUTING AGENCY IS REQUIRED TO CORRELATE ALL RELEVANT DRAWINGS AND ANY ERRORS OR DISCREPANCIES ARE TO BE BROUGHT TO THE NOTICE OF CARYATID ARCHITECTS BEFORE COMMENCE OF WORK

1. THIS DRAWING IS THE PROPERTY OF CARYATID ARCHITECTS AND SHALL NOT BE USED OR PRODUCE IN ANY MANNER WITHOUT HIS WRITTEN PERMISSION.
2. DIMENSIONS ON THE DRAWINGS ARE TO BE READ NOT SCALED.
3. THE EXECUTING AGENCY IS REQUIRED TO CORRELATE ALL RELEVANT DRAWINGS AND ANY ERRORS OR DISCREPANCIES ARE TO BE BROUGHT TO THE NOTICE OF CARYATID ARCHITECTS BEFORE COMMENCE OF WORK



CONSULTANTS: -

CHECKED BY:- Rishabh Sharma	DRAWN BY:- Parmeshwar
------------------------------------	------------------------------


SIGNATURE:-	SCALE:-	DATE:-
	N.T.S.	16 04 2025
	NORTH	SHEET:-
		

SHEET TITLE:-
LIG G.F. TOILET PIPE DETAILS

caryatid
architects & consultants
caryatidjaipur@gmail.com
96020-86971

SPECIFICATION:-

1. THIS DRAWING IS THE PROPERTY OF **CARYATID ARCHITECTS** AND SHALL NOT BE USED OR PRODUCE IN ANY MANNER WITHOUT HIS WRITTEN PERMISSION.
2. DIMENSIONS ON THE DRAWINGS ARE TO BE READ NOT SCALED.
3. THE EXECUTING AGENCY IS REQUIRED TO CORRELATE ALL RELEVANT DRAWINGS AND ANY ERRORS OR DISCREPANCIES ARE TO BE BROUGHT TO THE NOTICE OF **CARYATID ARCHITECTS** BEFORE COMMENCE OF WORK

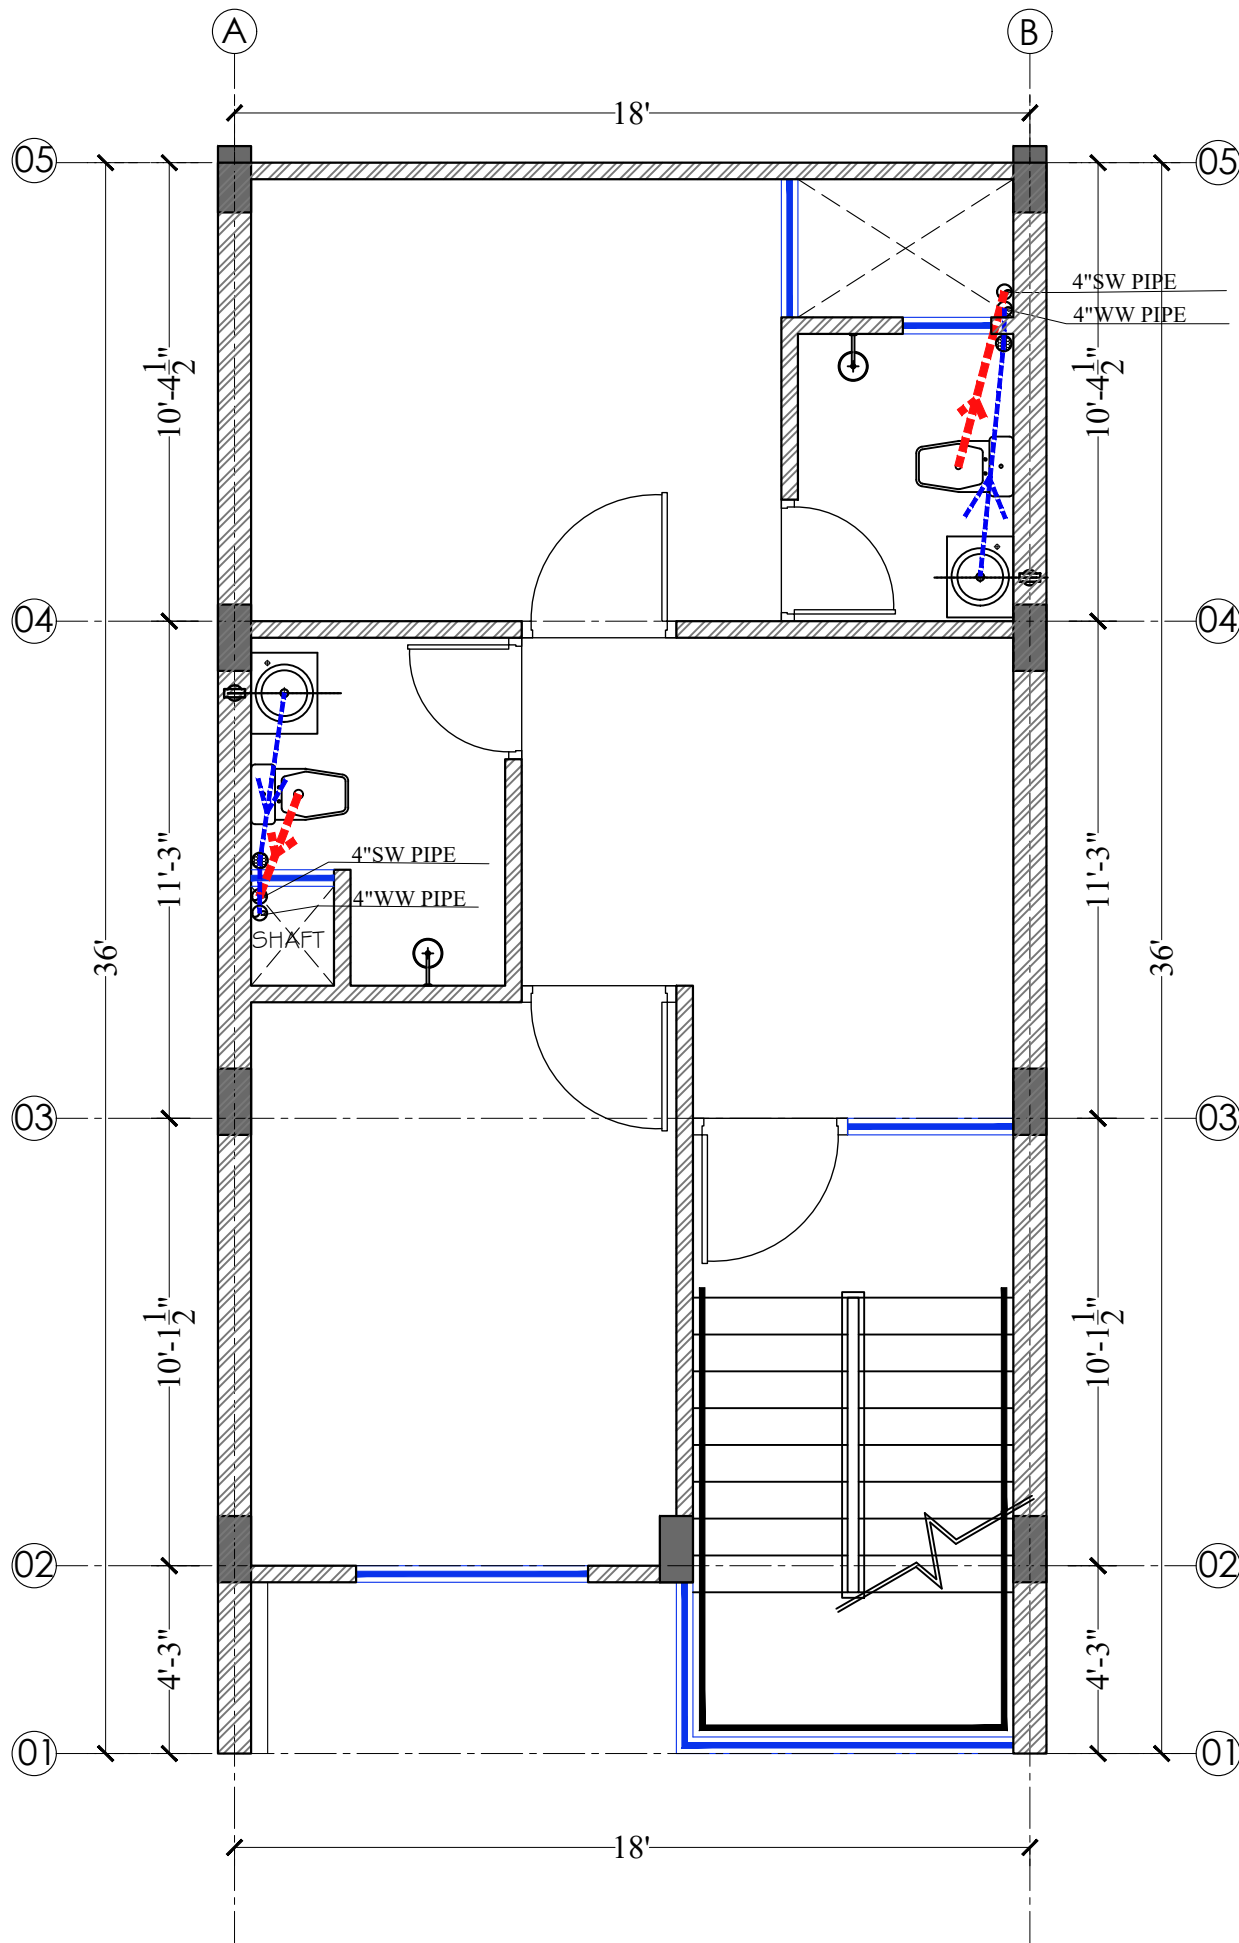

दिव्यजीत मरोठिया
DIVYAJEET MAROTHIYA
(IEI)
CHARTERED ENGINEER (CIVIL)
AM 3007165


PROJECT TITLE:-
AFFORDABLE HOUSING SCHEME
Khasra no. 36/2 of Village - Badgaon,
Tehsil - Sheoganj, Distt. - Sirahi

CONSULTANTS:-

CHECKED BY:- Rishabh Sharma	DRAWN BY:- Parmeshwar
SIGNATURE:-	SCALE:- N.T.S.
	DATE:- 14/04/2025
	NORTH SHEET:-

SHEET TITLE:-
LIG FIRST FLOOR TOILET PIPE DETAILS

caryatid
architects & consultants
caryatidjaipur@gmail.com
96020-86971

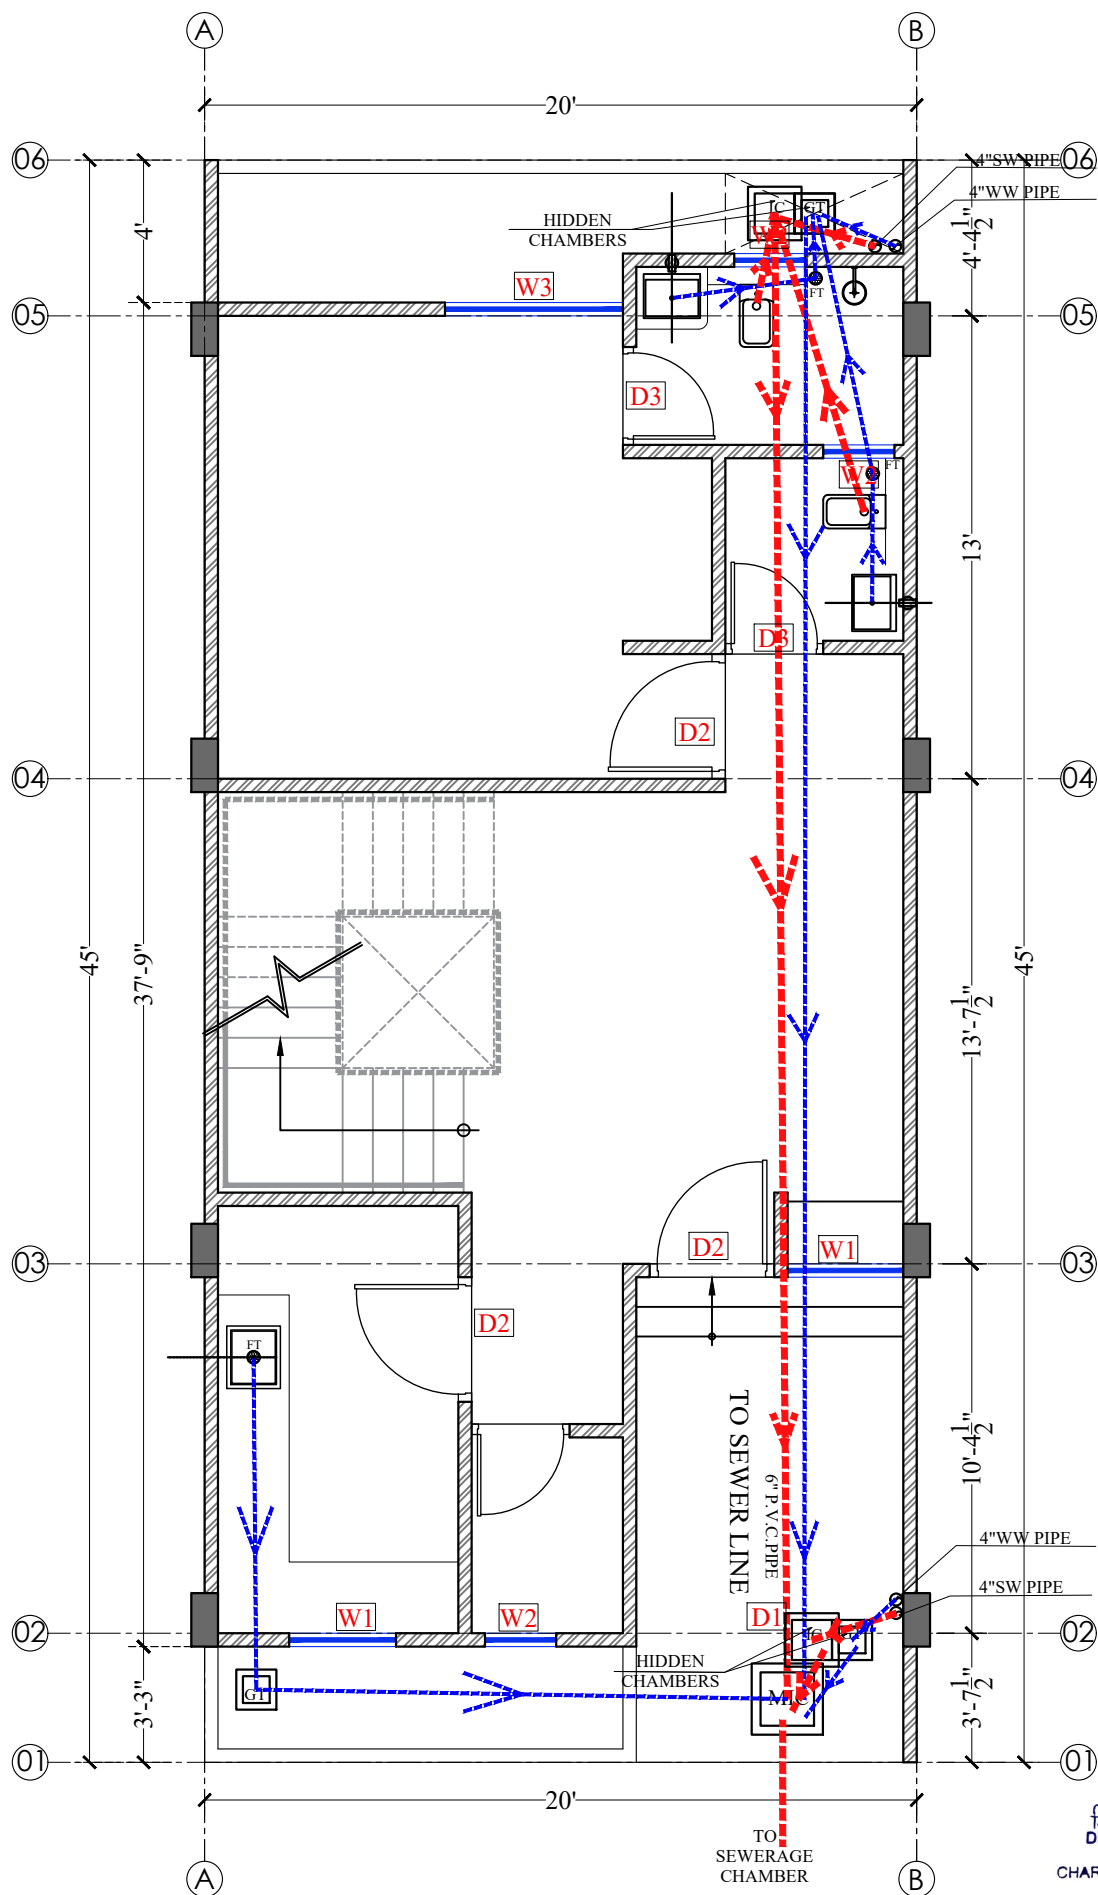

दिव्याजीत मारीठिया
 DIVYAJEET MAROTHIYA
 (IEI)
 CHARTERED ENGINEER (CIVIL)
 AM 3007165

SPECIFICATION

1. THIS DRAWING IS THE PROPERTY OF **CARYATID ARCHITECTS** AND SHALL NOT BE USED OR PRODUCE IN ANY MANNER WITHOUT HIS WRITTEN PERMISSION.
2. DIMENSIONS ON THE DRAWINGS ARE TO BE READ NOT SCALED.
3. THE EXECUTING AGENCY IS REQUIRED TO CORRELATE ALL RELEVANT DRAWINGS AND ANY ERRORS OR DISCREPANCIES ARE TO BE BROUGHT TO THE NOTICE OF **CARYATID ARCHITECTS** BEFORE COMMENCE OF WORK


PROJECT TITLE:-
AFFORDABLE HOUSING SCHEME
 Khasra no. 36/2 of Village - Badgaon,
 Tehsil - Sheoganj, Distt. - Sirahi
CONSULTANTS:- RAMESH JANGID
 (Structure Consultant)

CHECKED BY:-
 Rishabh Sharma
SIGNATURE:-
DRAWING NO:-

DRAWN BY:-
 Parmesver
SCALE:-
 N.T.S.
DATE:-
 16/04/2025
NORTH

SHEET TITLE:-
MIG UNIT G.F. PLUMBING PLAN

 architects & consultants
 caryatidjaipur@gmail.com
 96020-86971

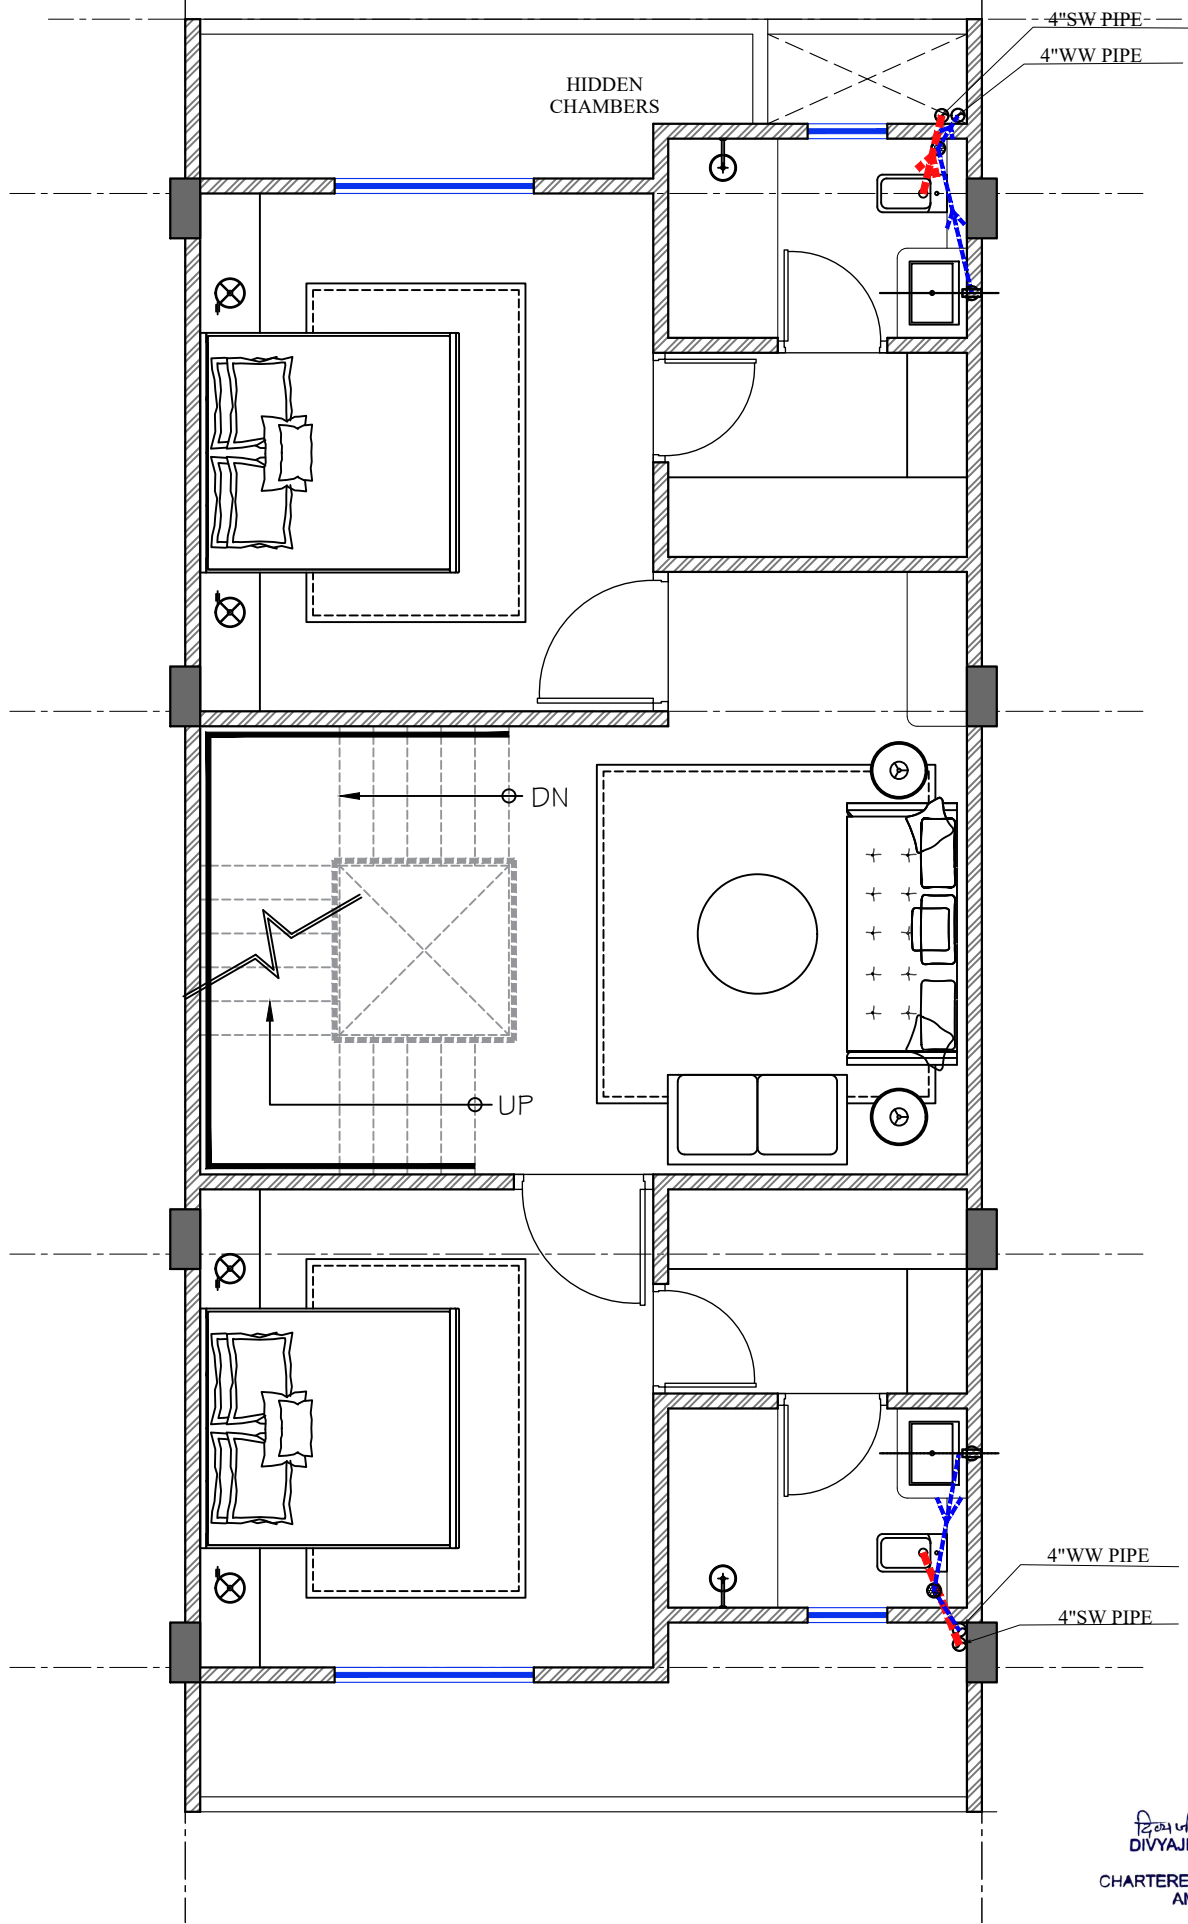

दिव्याजीत मारोठिया
 DIVYAJEET MAROTHIYA
 (IEI)
 CHARTERED ENGINEER (CIVIL)
 AM 3007165

SPECIFICATION 1. THIS DRAWING IS THE PROPERTY OF CARYATID ARCHITECTS AND SHALL NOT BE USED OR PRODUCE IN ANY MANNER WITHOUT HIS WRITTEN PERMISSION. 2. DIMENSIONS ON THE DRAWINGS ARE TO BE READ NOT SCALED. 3. THE EXECUTING AGENCY IS REQUIRED TO CORRELATE ALL RELEVANT DRAWINGS AND ANY ERRORS OR DISCREPANCIES ARE TO BE BROUGHT TO THE NOTICE OF CARYATID ARCHITECTS BEFORE COMMENCE OF WORK	PROJECT TITLE:- AFFORDABLE HOUSING SCHEME Khasra no. 36/2 of Village - Badgaon, Tehsil - Sheoganj, Distt. - Sirohi CONSULTANTS:- RAMESH JANGID (Structure Consultant)	CHECKED BY:- Rishabh Sharma SIGNATURE:- DRAWING NO:-	DRAWN BY:- Parmesver SCALE:- N.T.S. DATE:- 16/04/2025 NORTH 	SHEET TITLE:- MIG UNIT FIRST FLOOR PLUMBING PLAN  architects & consultants caryatidjaipur@gmail.com 96020-86971
--	---	--	--	---