
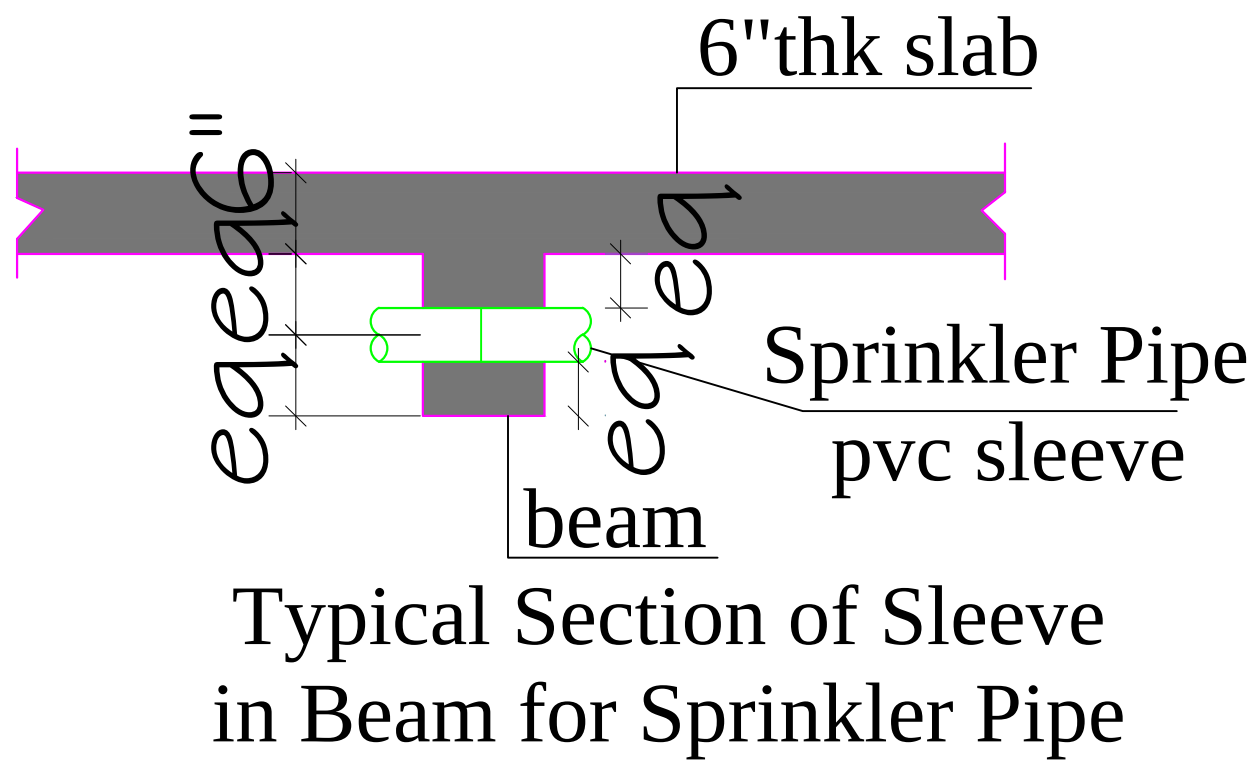


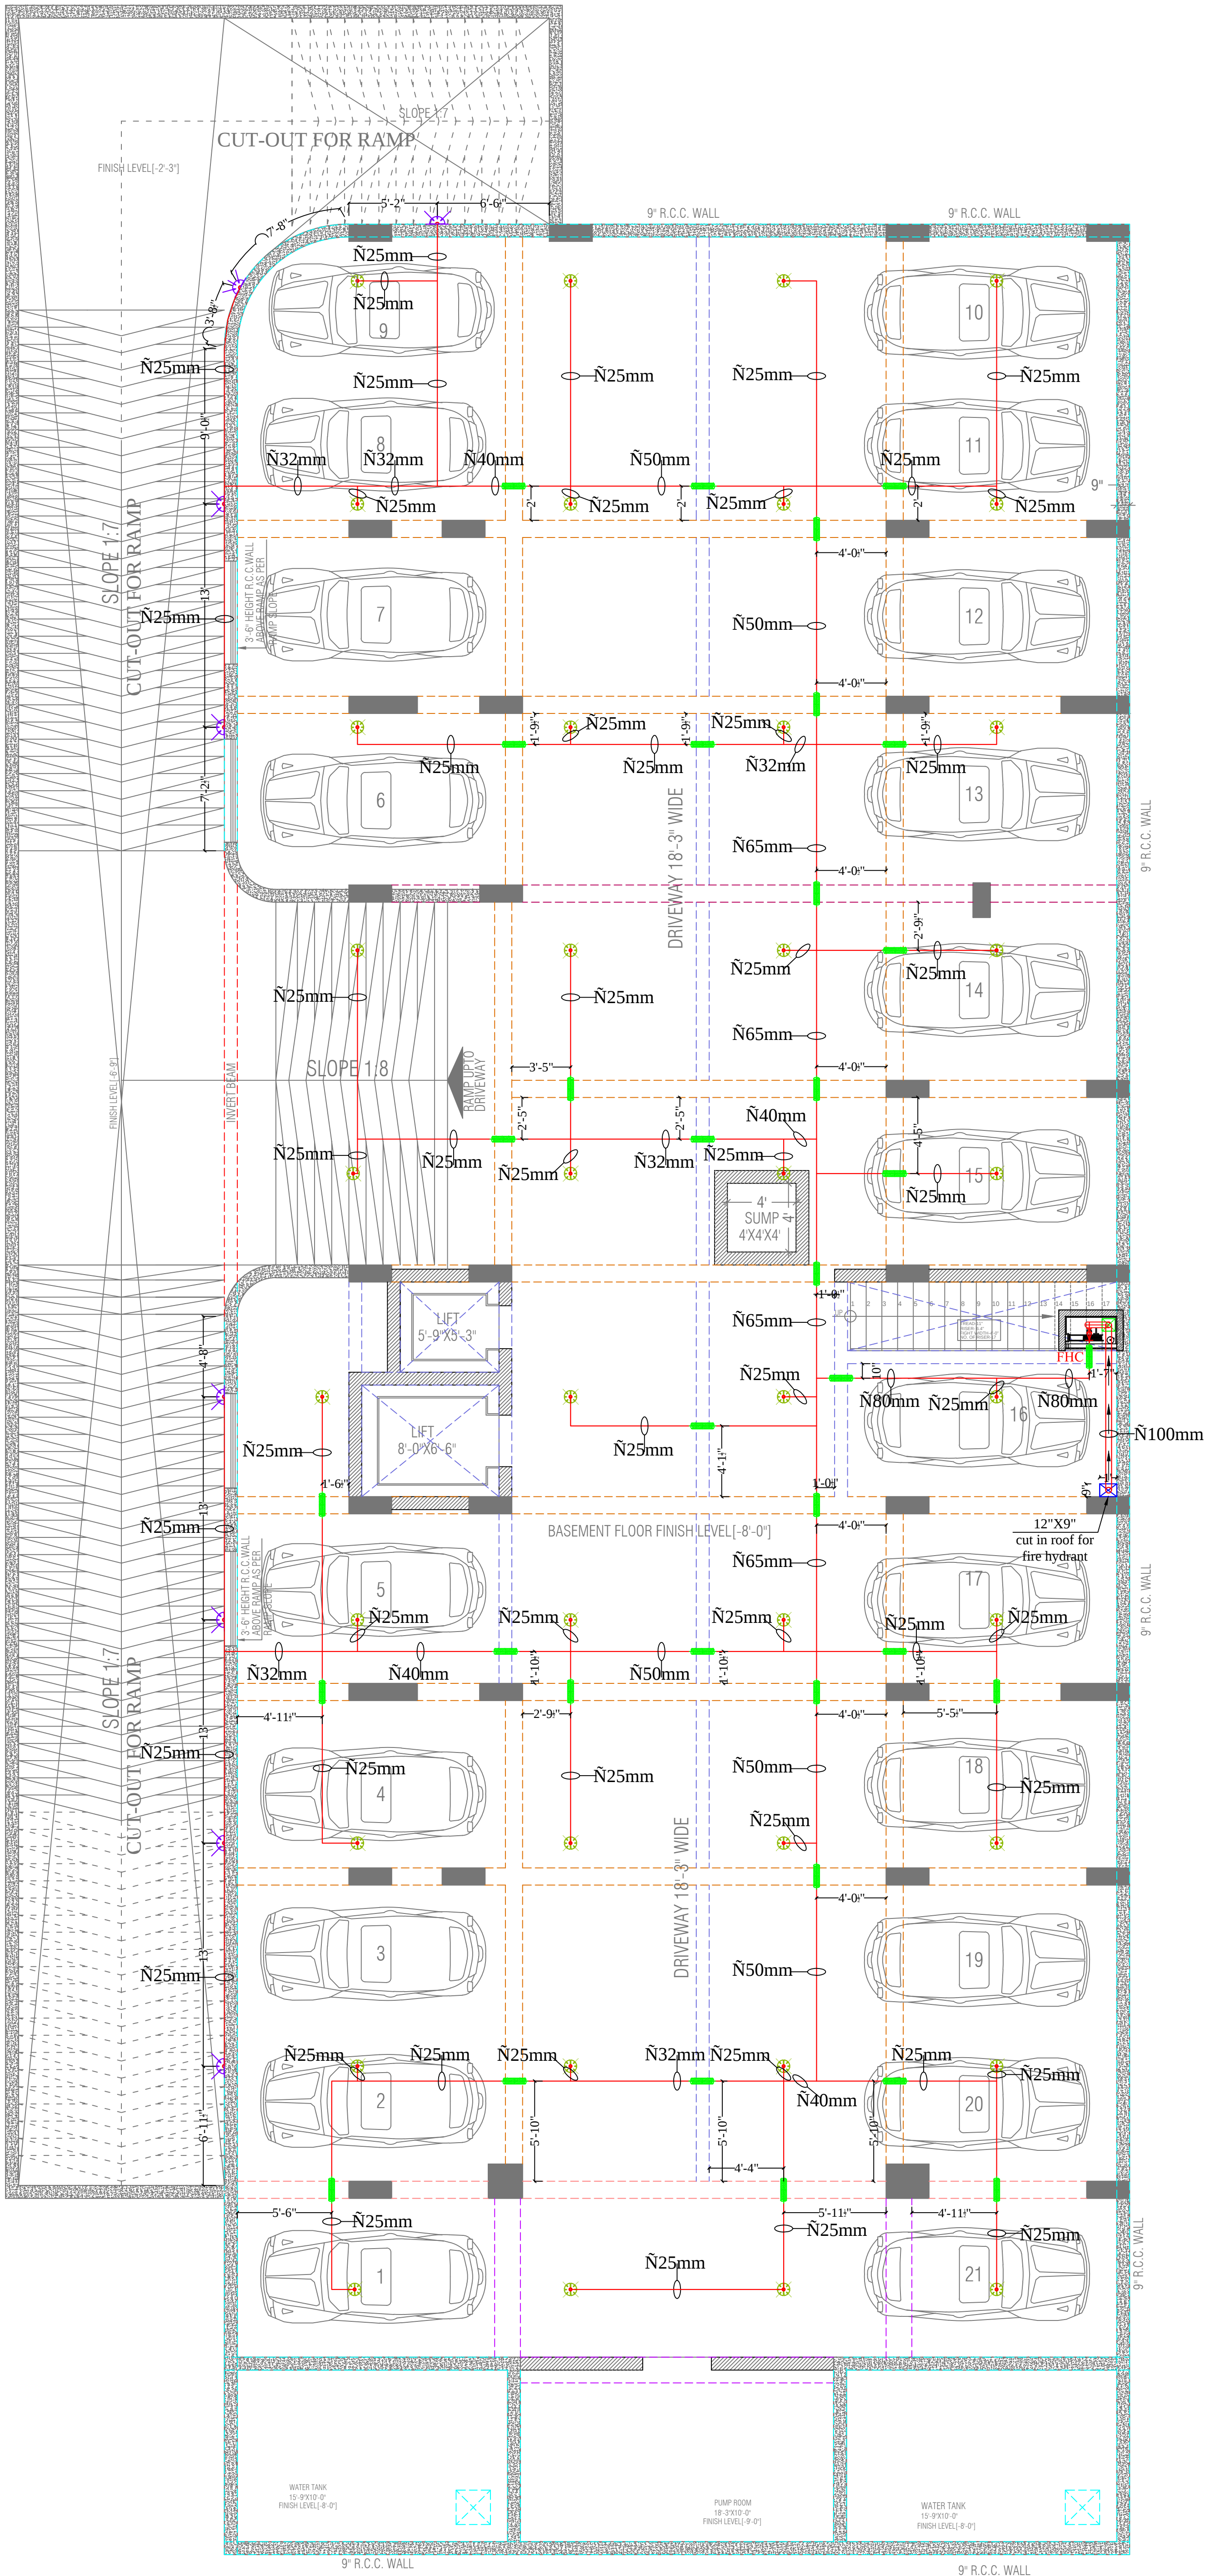

LEGENDS:

Mounting Ht.	Qty.	Symbol	Description
CEILING	40		SPRINKLER POINT
WALL	08		SPRINKLER POINT
CEILING	120mtr		25 MM DIA. MS PIPE
CEILING	14mtr		32 MM DIA. MS PIPE
CEILING	08mtr		40 MM DIA. MS PIPE
CEILING	21mtr		50 MM DIA. MS PIPE
CEILING	15mtr		65 MM DIA. MS PIPE
CEILING	06mtr		80 MM DIA. MS PIPE
CEILING	03mtr		100 MM DIA. MS PIPE
			100 MM DIA. SLEEVE
	01		CONTROL VALVE

SERVICES CONSULTANT:
VIPUL CONSULTING,
F 9 / 440 , Keshav Marg Chitrakut Scheme,Jaipur
PH:91-0-93146-10438 ,0141-2440946 Mail:vipul8599@yahoo.com
REV. NO. 000 DATE: 30-07-2016

Project:

Proposed Residential Building
At Plot - Flats -E In Surya City
N.H.-11 Fatehpur Sikri Road,
Bharatpur Rajasthan.


Owner:

Surya Builders & Developers

Drawing:

BASEMENT FLOOR
SPRINKLER PLAN

North:	DATE: 30-07-17
Drawn.by:- PAWAN	Appd. By:- SANJAY
	Location: :\mainserver-pc\E\drawings\Bharatpur\Manoj ji\ WORKING\WORKING PLAN
	name :- Shyam
	File no: 495

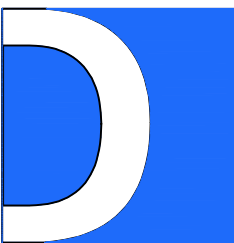

**Design
Space**
Consultants

ADDRESS:

Architects & Interior Designer

Plot no. 65, Acme Heights, Visheswaria Nagar,
Behind D.C. Hospital, Triveni nagar,
Gopalpura bye-pass Jaipur, Rajasthan
ph: 0141-2763533, 9828117586
E-mail: sunil@designspaceconsultants.com
Website: www.designspaceconsultants.com