


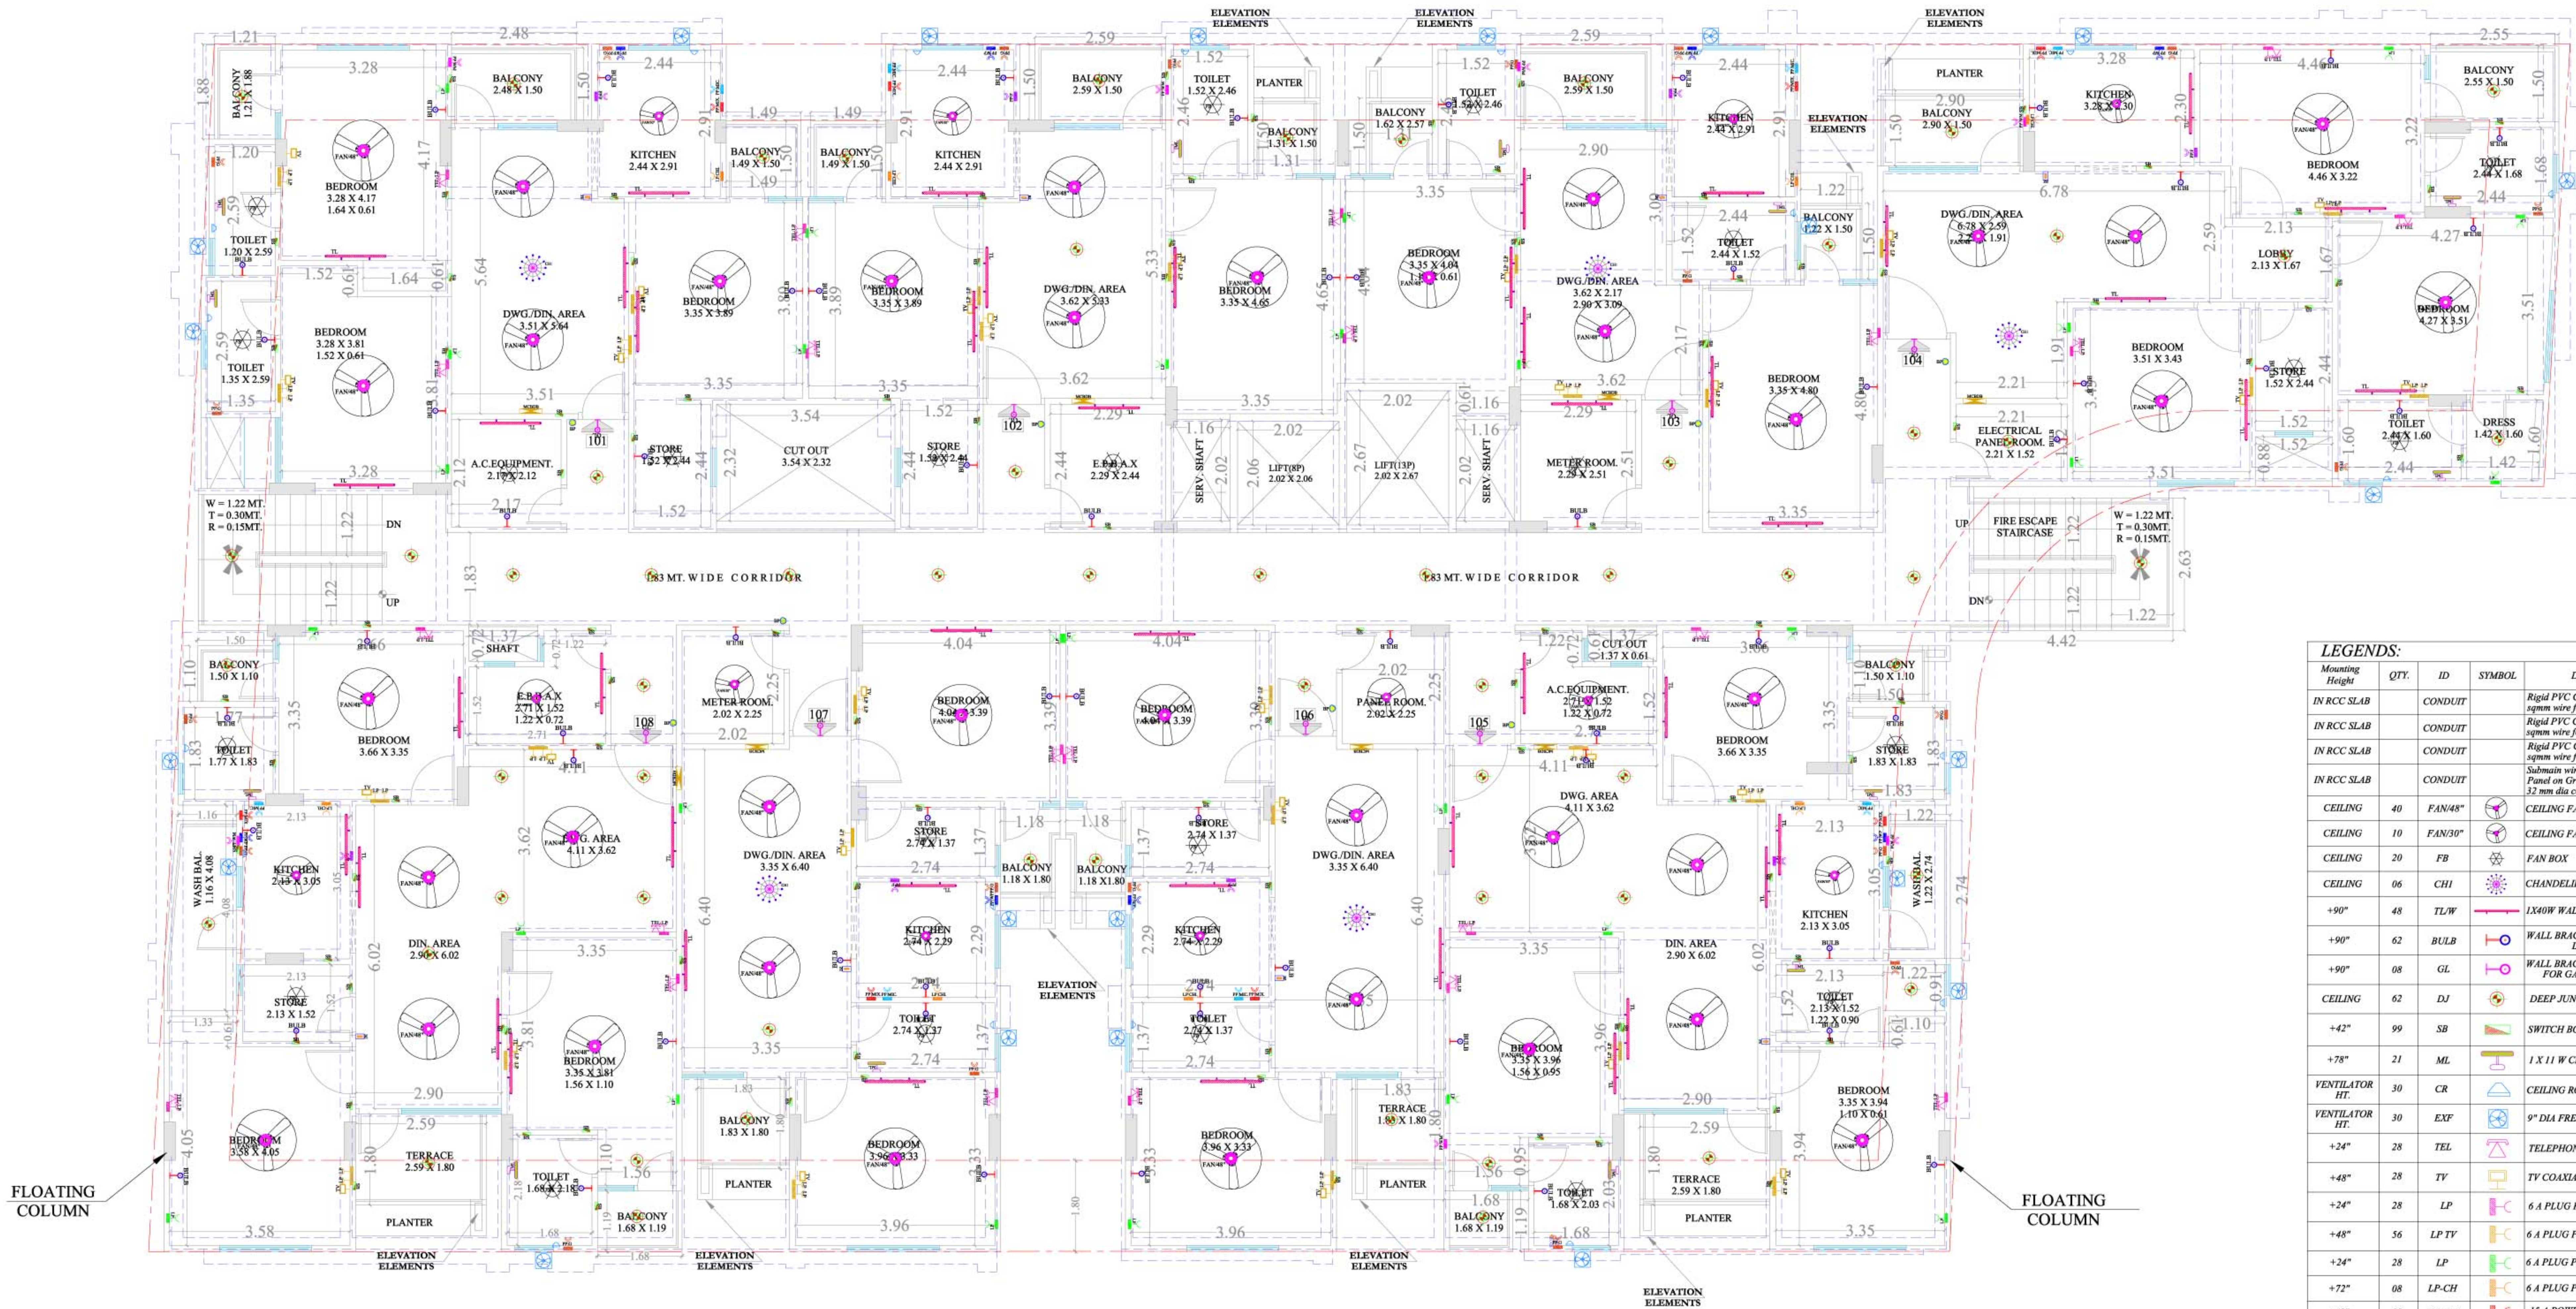

LEGENDS:				
Mounting Height	QTY.	ID	SYMBOL	DESCRIPTION
IN RCC SLAB		CONDUIT		Rigid PVC Conduit 25mm/1.0 sqmm wire for Light points
IN RCC SLAB		CONDUIT		Rigid PVC Conduit 25mm/2.5 sqmm wire for Light Circuits
IN RCC SLAB		CONDUIT		Rigid PVC Conduit 25mm/4.00 sqmm wire for POWER Circuits
IN RCC SLAB		CONDUIT		Submain wire to DB from Main Panel on Ground Floor in 1 nos. 32 mm dia conduits
CEILING	40	FAN/48"		CEILING FAN 48"
CEILING	10	FAN/30"		CEILING FAN 30"
CEILING	20	FB		FAN BOX
CEILING	06	CHI		CHANDELIER
+90"	48	TL/W		1X40W WALL TUBELIGHT
+90"	62	BULB		WALL BRACKETS AS DESIGN LIGHT
+90"	08	GL		WALL BRACKETS AS DESIGN FOR GANESH LIGHT
CEILING	62	DJ		DEEP JUNCTION 4 WAY
+42"	99	SB		SWITCH BOARD
+78"	21	ML		1 X 11 W CFL MIRROR LIGHT
VENTILATOR HT.	30	CR		CEILING ROSE
VENTILATOR HT.	30	EXF		9" DIA FRESH AIR FAN
+24"	28	TEL		TELEPHONE POINT
+48"	28	TV		TV COAXIAL POINT.
+24"	28	LP		6 A PLUG POINT
+48"	56	LP TV		6 A PLUG POINT FOR TV
+24"	28	LP		6 A PLUG POINT
+72"	08	LP-CH		6 A PLUG POINT FOR CHIMNEY
+42"	08	PP-MIX		15 A POWER POINT FOR MIXER
+42"	08	PP-MIC		15 A POWER POINT FOR MICROWAVE
+78"	28	PP-G		15 A POWER POINT FOR GEYSER
+54"	08	PP-F		15 A POWER POINT FOR FRIDGE
+78"	08	PP-WP		15 A POWER POINT FOR WATER PURIFIER
+48"	08	PP-WM		15 A POWER POINT FOR WASHING MACHINE
+12"	16	PP-INV.		15 A POWER POINT FOR INVERTOR
+60"	08	BP		6 A BELL PUSH
+90"	08	BZ		BUZZER FOR CALL BELL
+60"	08	MCB DB		MCB DISTRIBUTION BOARD

DRAWING TITLE:-
TYPICAL FLOOR ELECTRICAL PLAN

SITE ADDRESS:-
**PROPOSED RESIDENTIAL APARTMENT
"THE ELEGANCE AT P.NO.111/148 - 161
PRATAP NAGAR, SANGANER JAIPUR**

PROJECT CONSULTANTS:



ideas
ARCHITECTURE URBAN PLANNING INTERIORS
124, HEMMAT NAGAR, TONK ROAD, JAIPUR
PHONE - 0141-2795980

SCALE 1:100 NORTH POINT

OWNER ARCHITECT