
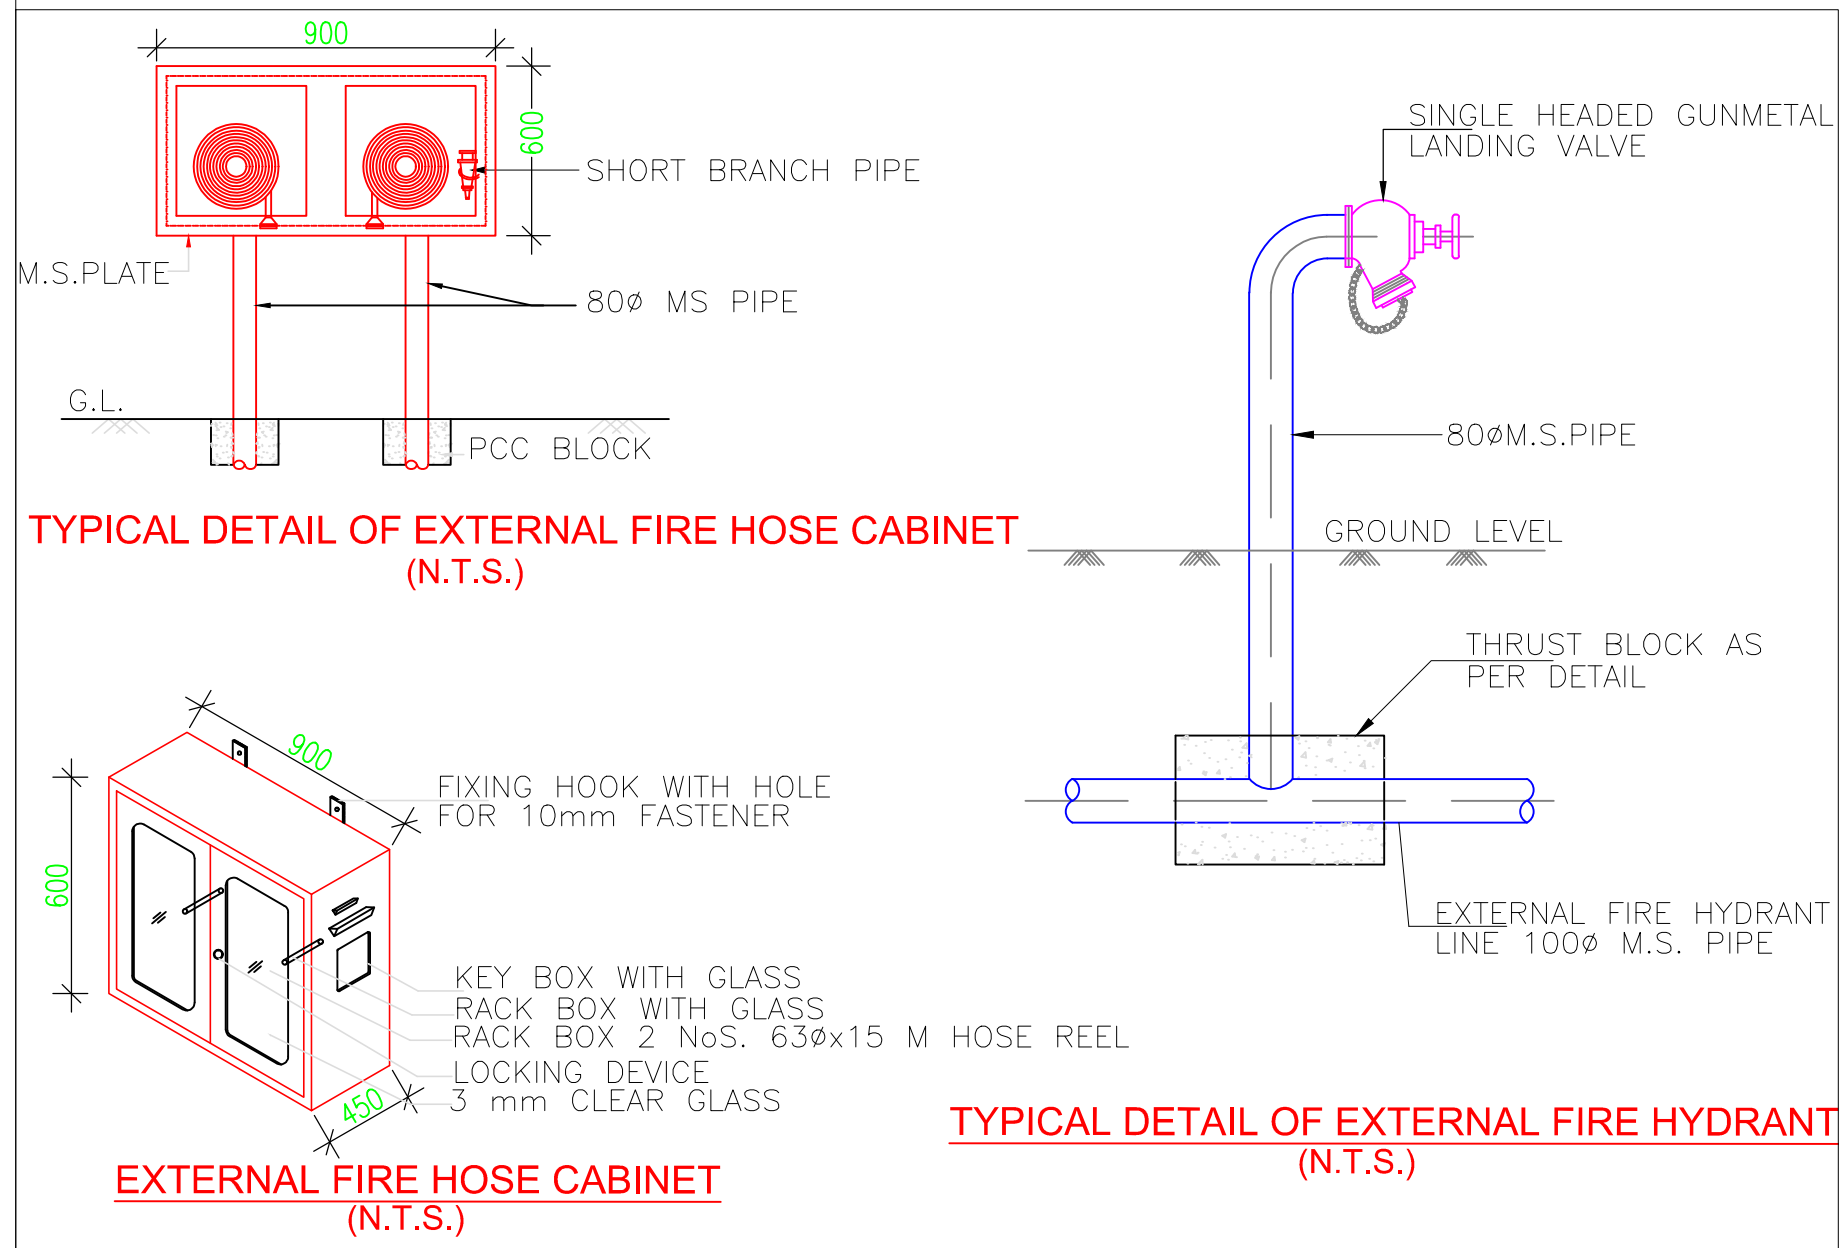


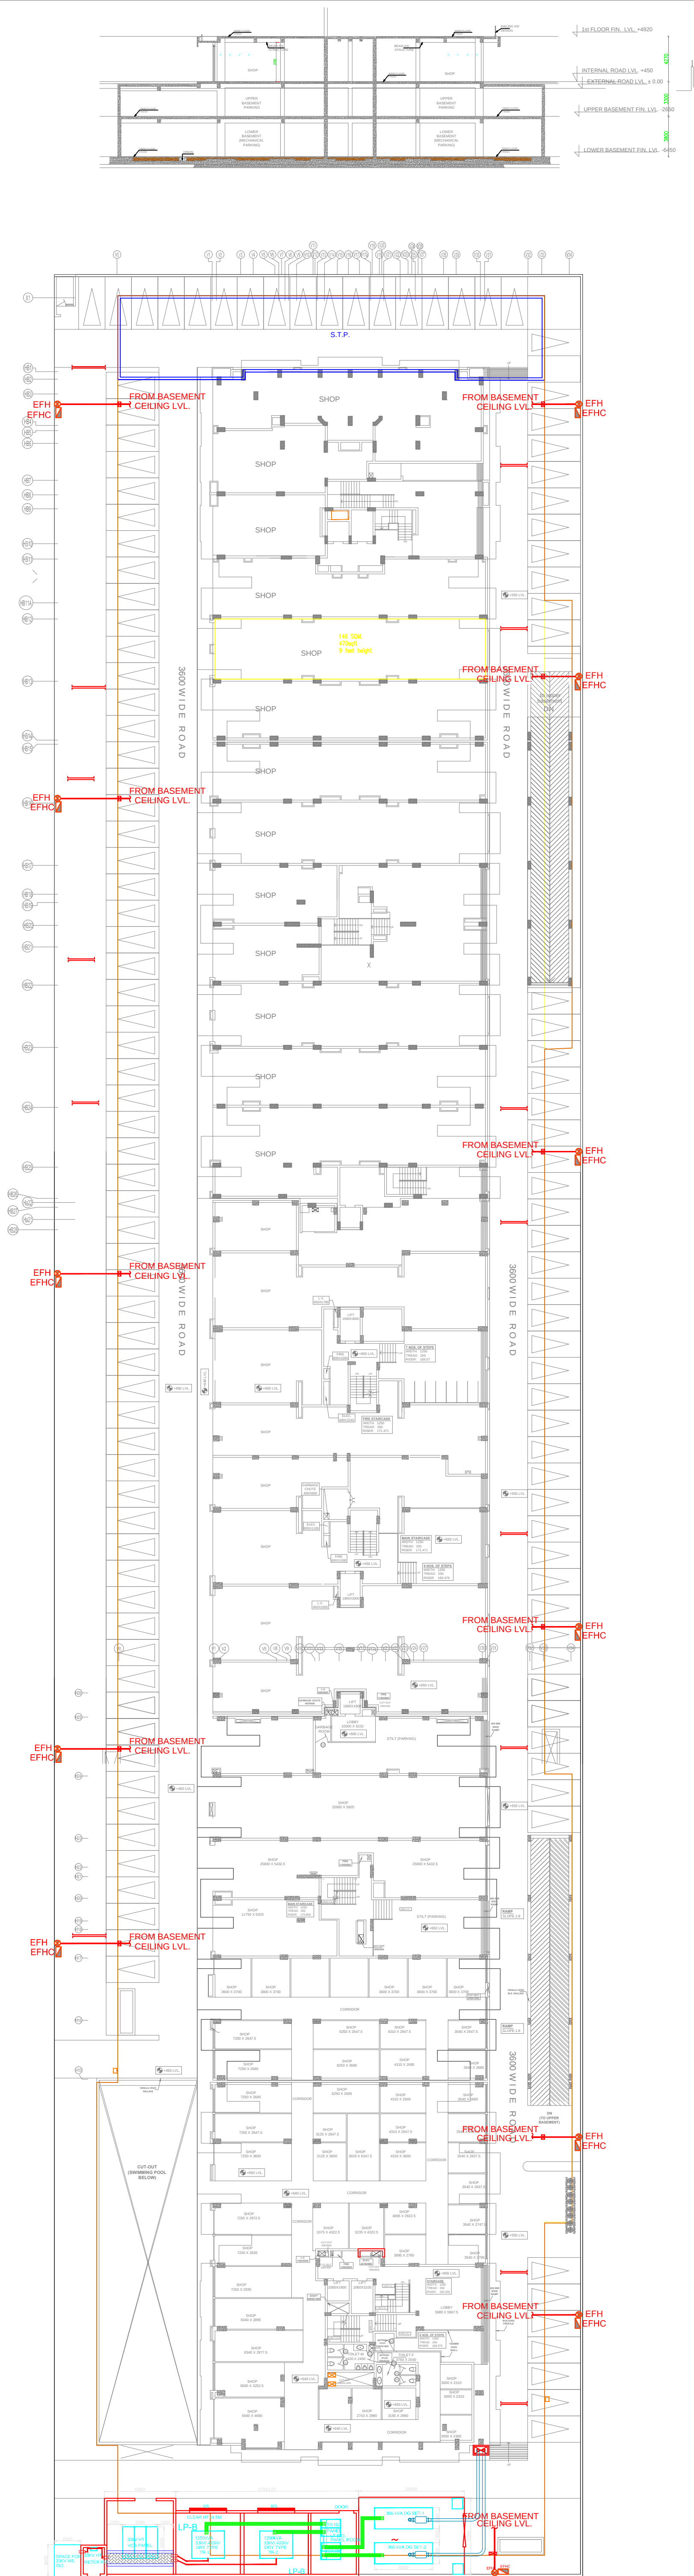

FIRE LEGEND:-	
	FIRE HYDRANT PIPE
	EXTERNAL FIRE HYDRANT CABINATE
	EXTERNAL FIRE HYDRANT

CLIENT :-		
PROJECT :-		
PROPOSED BUILDING AT PLOT NO.1,2,3,4 AT DAKANYA RAILWAY STATION ROAD, RAJEEV GANDHI NAGAR EXT, KOTA		
ARCHITECTS :-		
R.K. & ASSOCIATES Architects, Engineers & Planners E-31, GREEN PARK MAIN, NEW DELHI - 110016, INDIA Tel. : 0886-21584, 2653-0754, 2655-7357 Fax: (011) 2686-2540 E-mail : rka.architects@gmail.com		
CONSULTANTS :-		
ACROBAT ENGINEERS PVT.LTD. H.No. 19/18, Basement Lvl. Spring Field Colony Faridabad (Haryana) Tel. : 0129-4056009 customerservice@acrobateengineers.com		
SHEET TITLE		
EXTERNAL SITE PLAN FIRE FIGHTING LAYOUT		
DRG. NO.		
AEA/RSR/ESP/FF-01		
DATE :- 03-06-2016	REV. NO	NORTH
SCALE :- A1/8.3.300	R1	
DETAIL BY :- VIRENDRA KANDARI		
CHECK CELL :- VIRENDRA		