


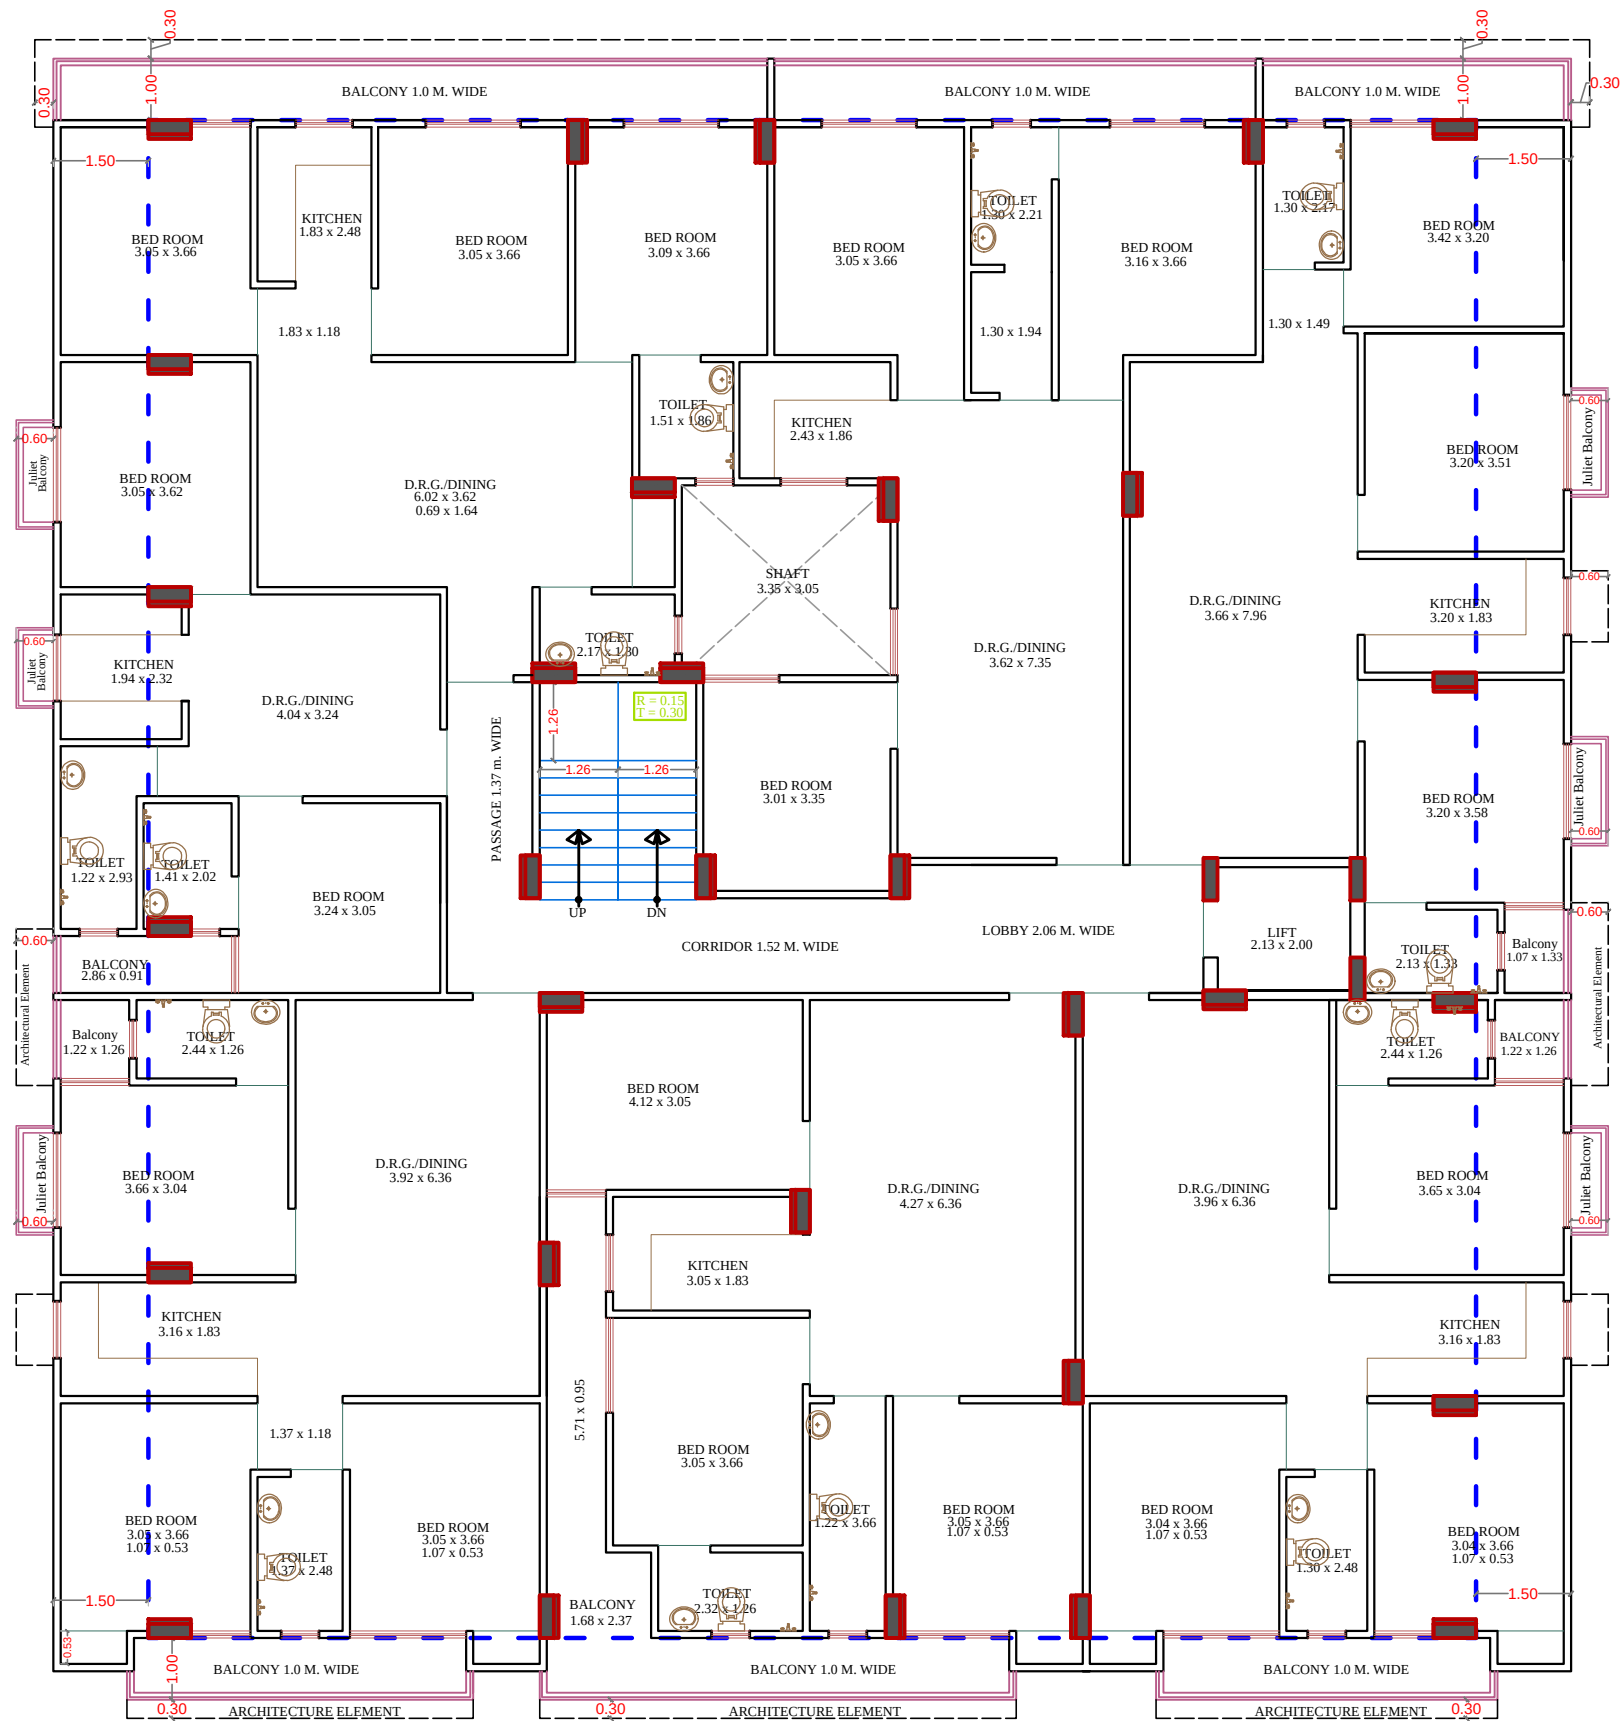

GROUND, 1st TO 5th FLOOR PLAN

All Heights For Finish Floor Lvl	SYMBOL	SYMBOL	DESCRIPTION
+1000MM			Ø 20MM CWS PIPE THRU WALL CHASE TO SINK
			Ø 20MM HWS PIPE THRU WALL CHASE TO SINK
+1950MM			Ø 20MM CWS PIPE THRU WALL CHASE TO GEYSER
			Ø 20MM HWS PIPE THRU WALL CHASE FROM GEYSER
+1500MM			Ø 20MM CWS PIPE THRU WALL CHASE TO AQUAGUARD
+450MM			Ø 20MM CWS PIPE THRU WALL CHASE TO BASIN ANGLE VALVE
+800MM			Ø 20MM HWS PIPE THRU WALL CHASE TO BASIN ANGLE VALVE
+2100MM			Ø 20MM CWS PIPE THRU WALL CHASE TO CONCELED STOP COCK
+300MM			Ø 20MM CWS PIPE THRU WALL CHASE TO FAUCET
+1000MM			Ø 20MM CWS PIPE THRU WALL CHASE TO WALL MIXER / DIVERTOR
+2025MM			Ø 20MM HWS PIPE THRU WALL CHASE TO WALL MIXER / DIVERTOR
+600MM			Ø 20MM CWS PIPE THRU WALL CHASE TO TAP
+1000MM	AS PER/ARCHI.		SOAP DISH
+1500MM	AS PER/ARCHI.		TOWEL RAIL
+450MM	AS PER/ARCHI.		PAPER HOLDER
			COLD WATER SUPPLY LINE
			HOT WATER SUPPLY LINE
			FLUSHING WATER SUPPLY LINE

RAMESH KUMAWAT
M.E.P. CONSULTANT
B.E. CIVIL

For B D BUILDERS
Proprietor

PROJECT TITLE :-

PROPOSED BUILDING AT PLOT NO.
A102, A-103, A-104, A-105, A-122,
A-123, A-124 & A-125, NARAYAN
VATIKA, AT VILLAGE-DHAWAS,
HEERAPURA AJMER ROAD, JAIPUR

BUILDING NAME

ANANTAM UTSAV NARAYAN VATIKA

DEVELOPER NAME

BD BUILDERS

DRAWING TITLE :-

TYPICAL FLOOR
PLUMBING PLAN

SPACE CONSULTANT

PLOT-A-173, JAGDAMBA NAGAR, HEERAPURA
POWER HOWER, JAIPUR (RAJ) 302024

DRN. BY


APPD. BY

SCALE

DATE

REVISION

NORTH

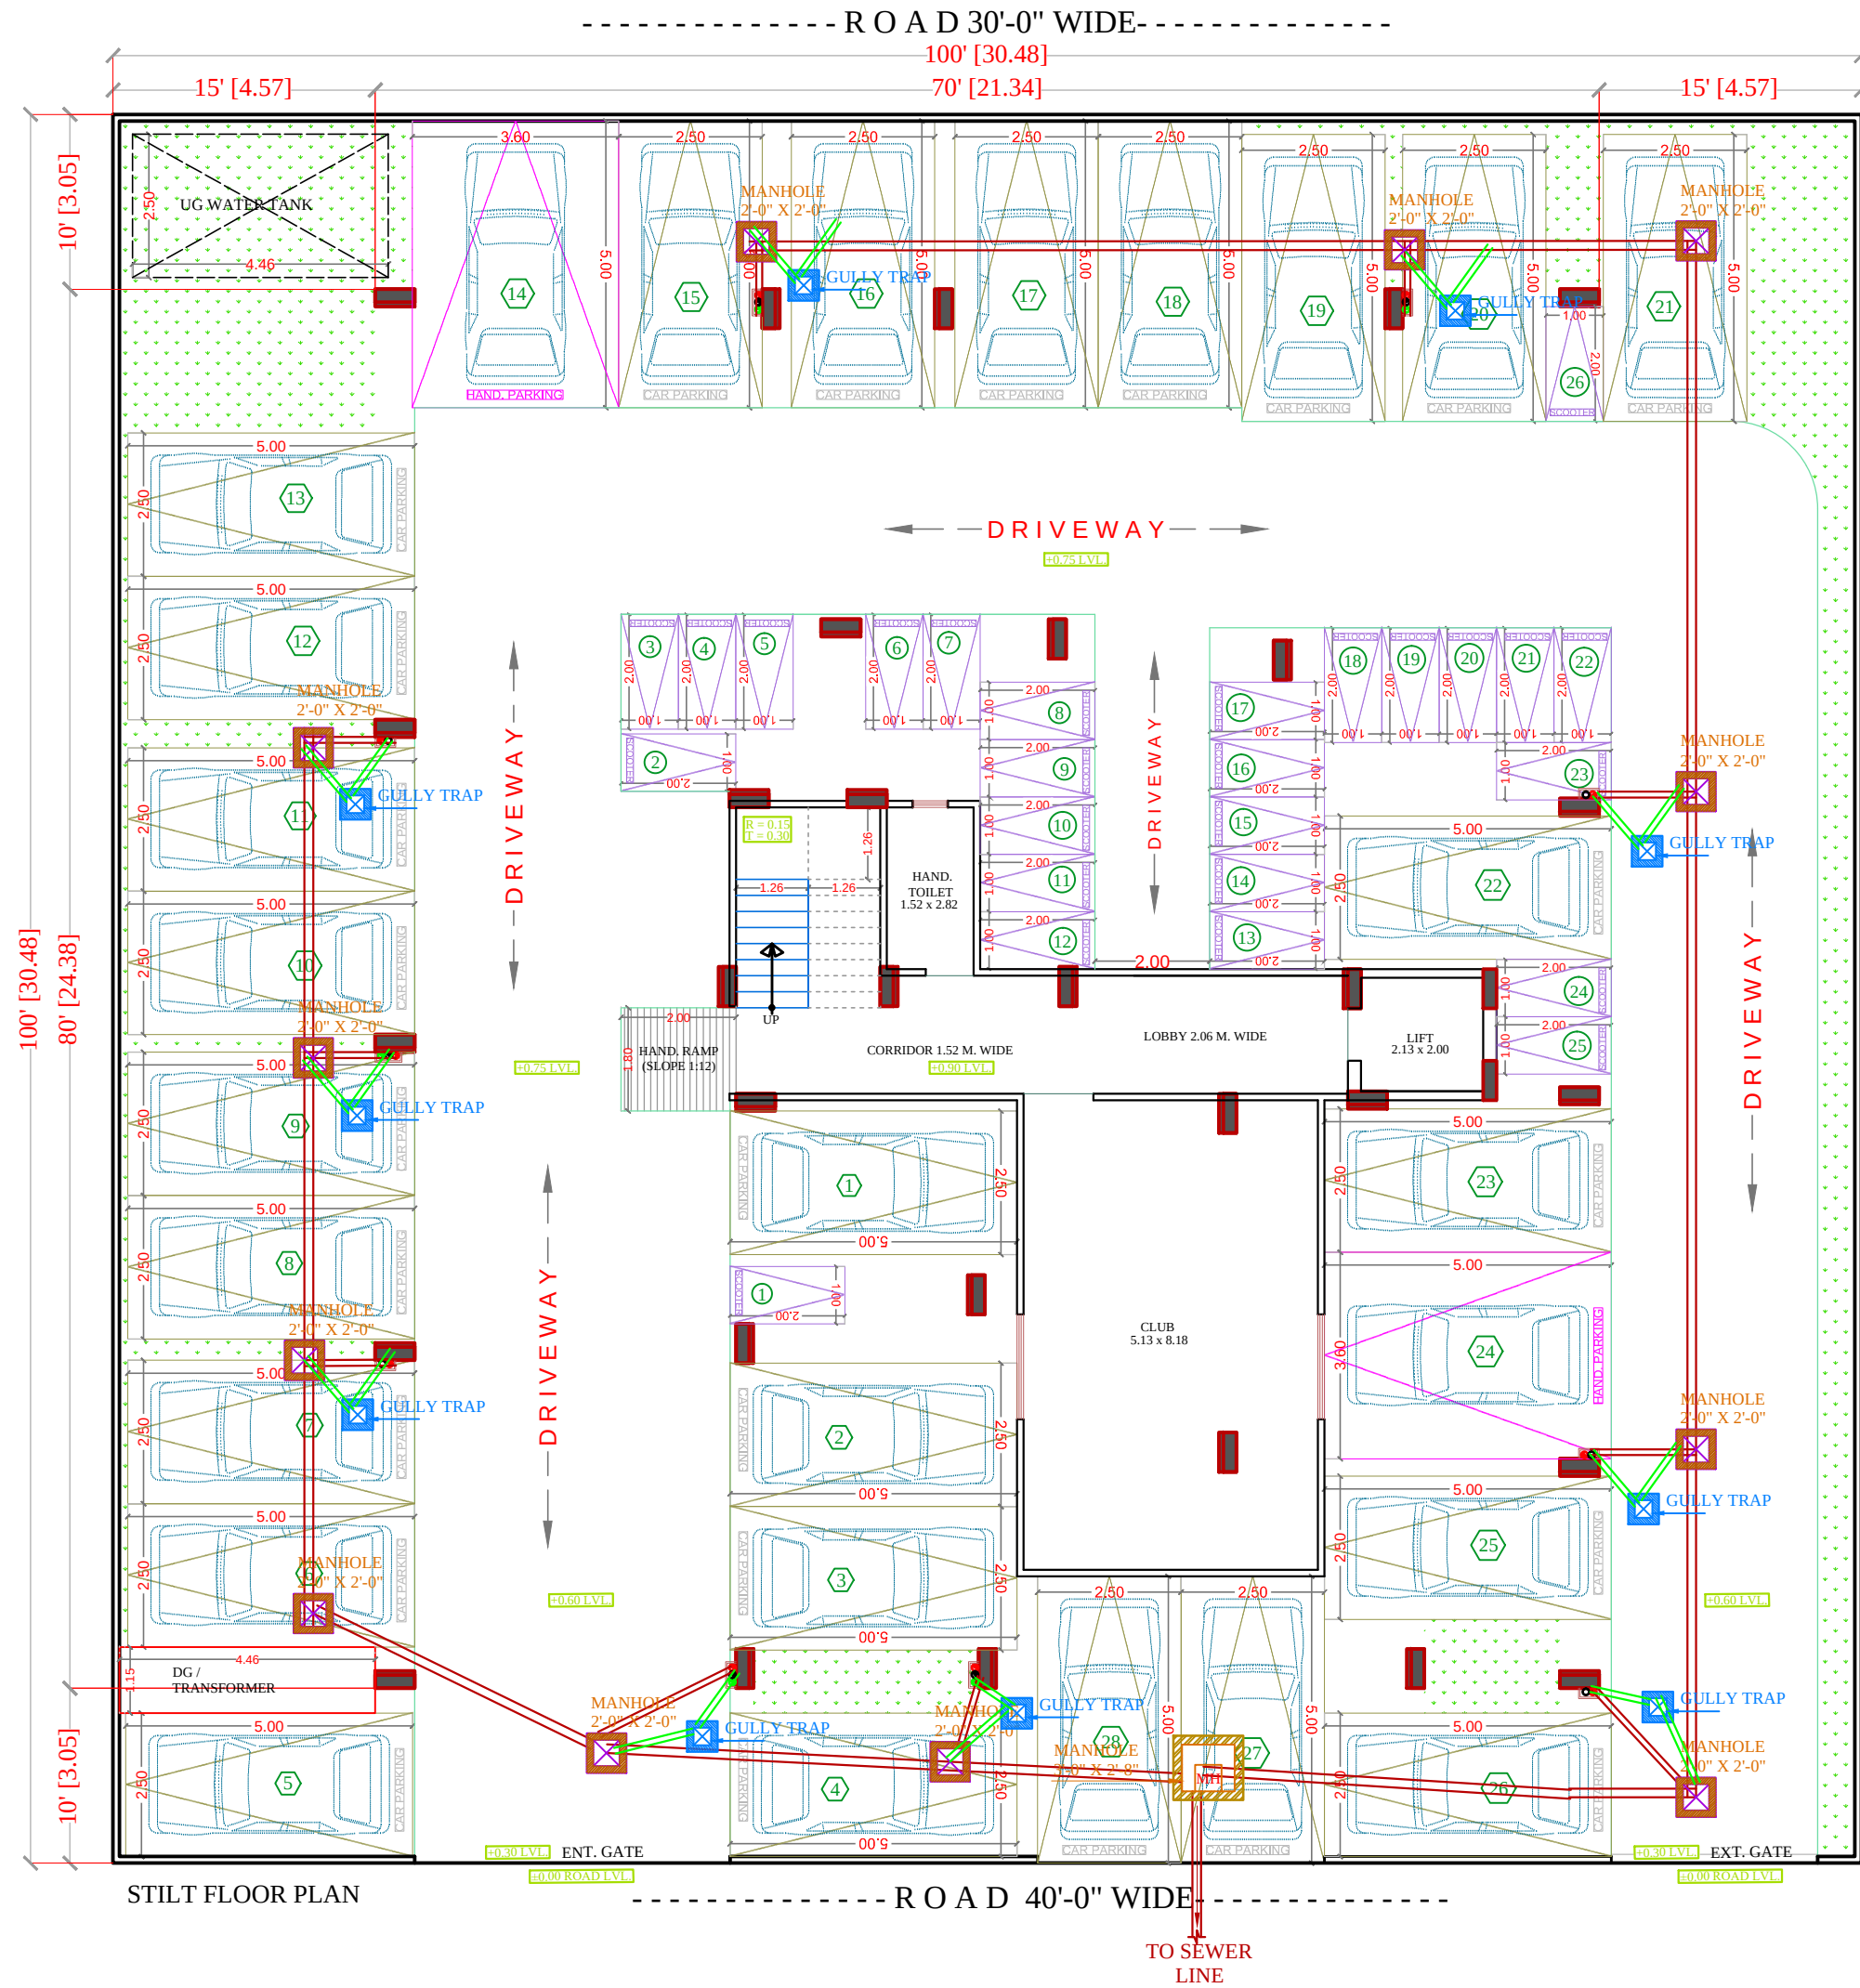

SYMBOL	DESCRIPTION
	Ø 110 mm Soil Waste Water Pipe
	Ø 110 mm Waste Water Pipe
	Ø 110 mm Rain Water Pipe
	Ø 160 mm Soil Waste Water Pipe Slope 1:150
	Ø 110 mm Soil Waste Water Pipe Slope 1:150
	Ø 110 mm Waste Water Pipe Slope 1:150
	Ø 75 mm Waste Water Pipe Slope 1:150
	50mm Waste Water Pipe Bottle Trap
	Floor Trap
	P-Trap Required
	Gully Trap-12"x12" Depth According to Slope
	Main Hole-18"x18" Depth According to Slope
	Main Hole-24"x24" Depth According to Slope
	Main Hole-36"x32" Depth According to Slope
	Flow Direction

SIGN:-



RAMESH KUMAWAT
M.E.P. CONSULTANT
B.E. CIVIL



For B D BUILDERS
Proprietor

SPACE CONSULTANT
PLOT-A-173, JAGDAMBA NAGAR, HEERAPURA
POWER HOWER, JAIPUR (RAJ) 302024

ARCHITECT :-
 **FRANK SQUARE**
ARCHITECTURE | PLANNER | DESIGNER
C-49 VIDYA APARTMENT PARAS MARG,
BAPU NAGAR JAIPUR, (RAJ.)
Email-afranksquare@gmail.com
Mobile-9461302542

PROJECT :-
PROPOSED BUILDING AT PLOT NO.
A102, A-103, A-104, A-105, A-122,
A-123, A-124 & A-125, NARAYAN
VATIKA, AT VILLAGE-DHAWAS,
HEERAPURA AJMER ROAD, JAIPUR

BUILDING NAME
ANANTAM UTSAV NARAYAN VATIKA

DEVELOPER NAME
BD BUILDERS

DRAWING:
STILT FLOOR
EXTERNAL SEWERAGE
CHAMBER & PIPE ROUTE FOR
RERA SUBMISSION PLAN

DATE	
SCALE:-	N.T.S.

