


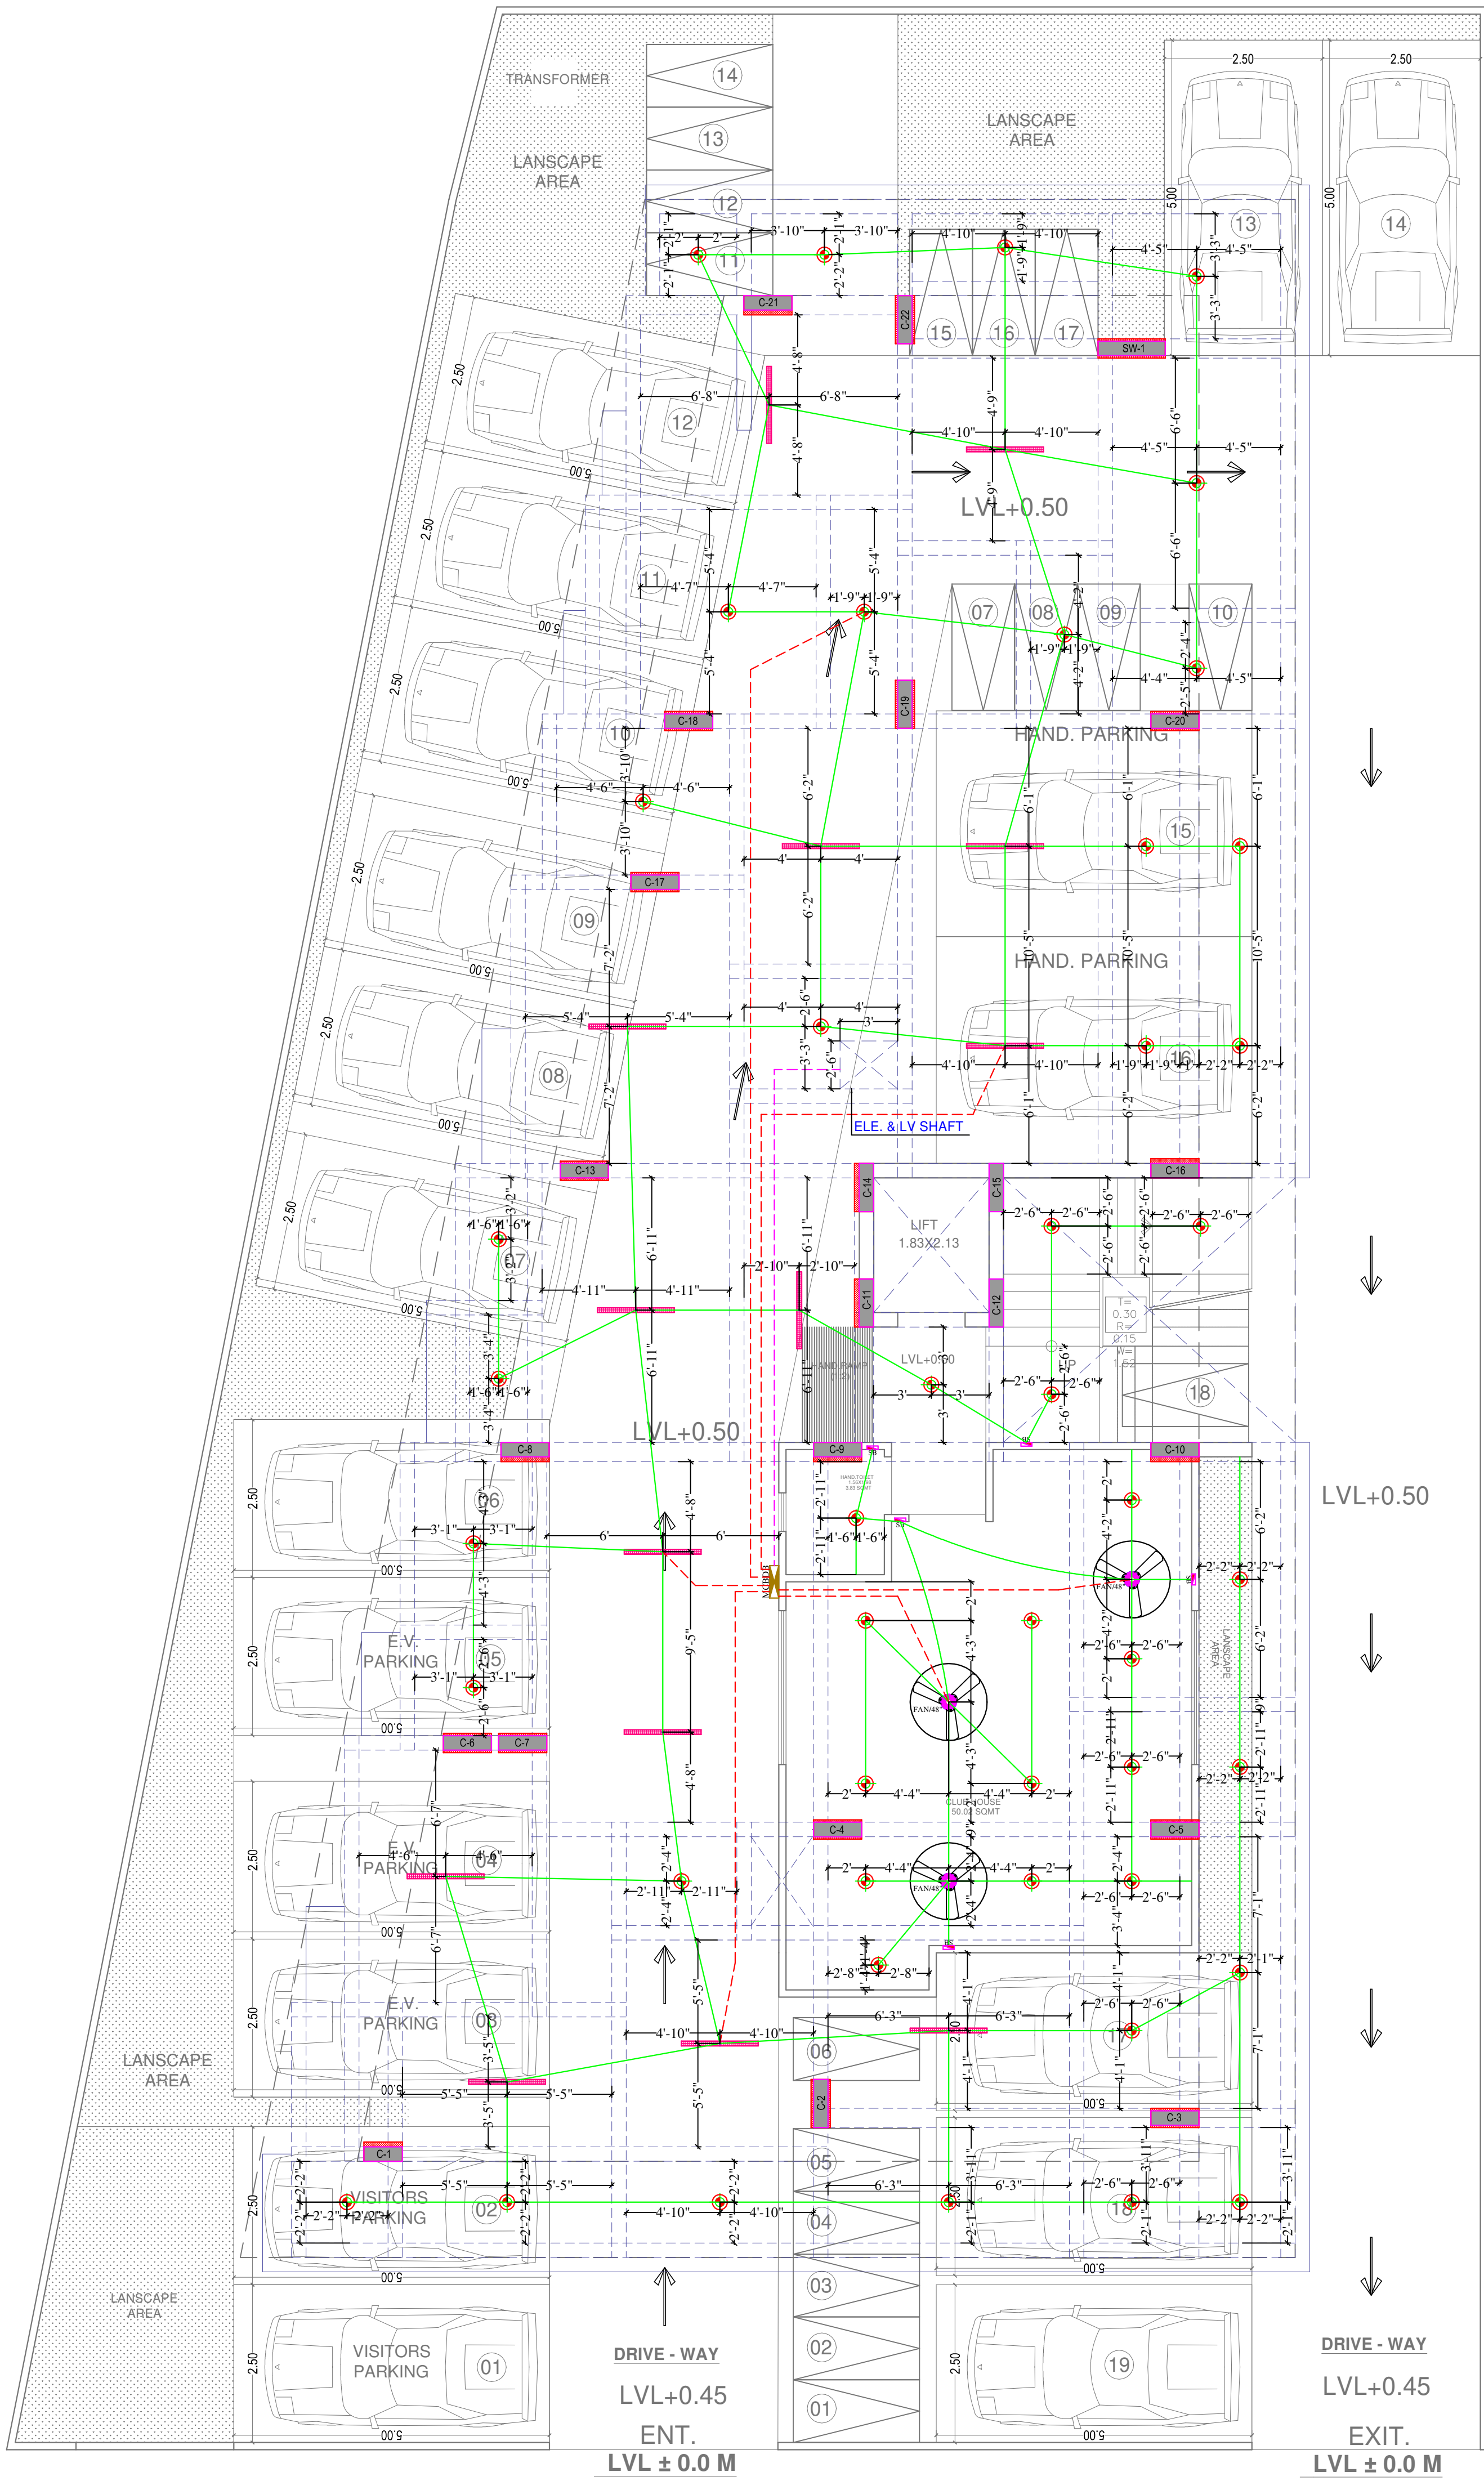

STILT FLOOR PLAN

60'-0" WIDE ROAD

Vipul
VIPUL AGARWAL
M.E.P. CONSULTANT
B.E. ELECTRICAL


LEGENDS:				
Mounting Height	No.	ID	Symbol	Description
IN RCC SLAB		CONDUIT		Rigid PVC Conduit 25mm/1.5 sqmm wire for Light points
IN RCC SLAB		CONDUIT		Rigid PVC Conduit 25mm/2.5 sqmm wire for Light Circuits
IN RCC SLAB		CONDUIT		Submain wire to DB from Main Panel on Ground Floor in 1 nos. 32mm dia conduits
CEILING	03	FAN/48"		CEILING FAN 48"
CEILING	12	TL		LED CEILING TUBE LIGHT MAKE:- SYSKA LED CAT NO:- SSK-T5-20W
CEILING	46	DL		Led 6" Down Lighter 20W (Surface Mounted) Make:- Syska Led Cat no:- SDL-15W GLD 6.5K/4K
+42"	05	SB		SWITCH BOARD
+60"	01	MCB DB		MCB DISTRIBUTION BOARD

SERVICES CONSULTANT:
ASHI ASSOCIATES
F9/440,Keshav Marg Chitrakut Scheme,Jaipur
PH:91-0-93146-10438 ,0141-2440946 Mail:vipul8599@yahoo.com

DRAWN. BY: —	CHKD. BY: —
HIMANSHU	SANJAY
APPD. BY: —	
VIPUL AGARWAL	
DATE: —	REV.: —
12-06-2024	00

PROJECT ADDRESS:-
PROPOSED BUILDING AT PLOT NO.- 04 (RES.),
IN SCHEME :- SHIV SHAKTI NAGAR
VISTAR (NIJI KHATEDARI), JAIPUR


PROJECT NAME:
MJB ATHULYAM- II
PROMOTERS :-
MJB BUILD DEVELOPERS

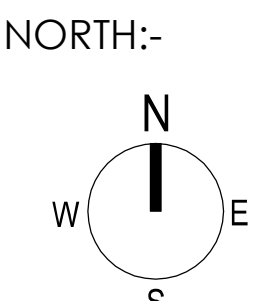

ARCHITECT:-

B-6, GANESH KRIPA, MOTI MARG,
BAPU NAGAR JAIPUR - 302015.
TEL. 9314510603, 0141-4062903

STILT FLOOR ELECTRICAL
CONDUIT PLAN

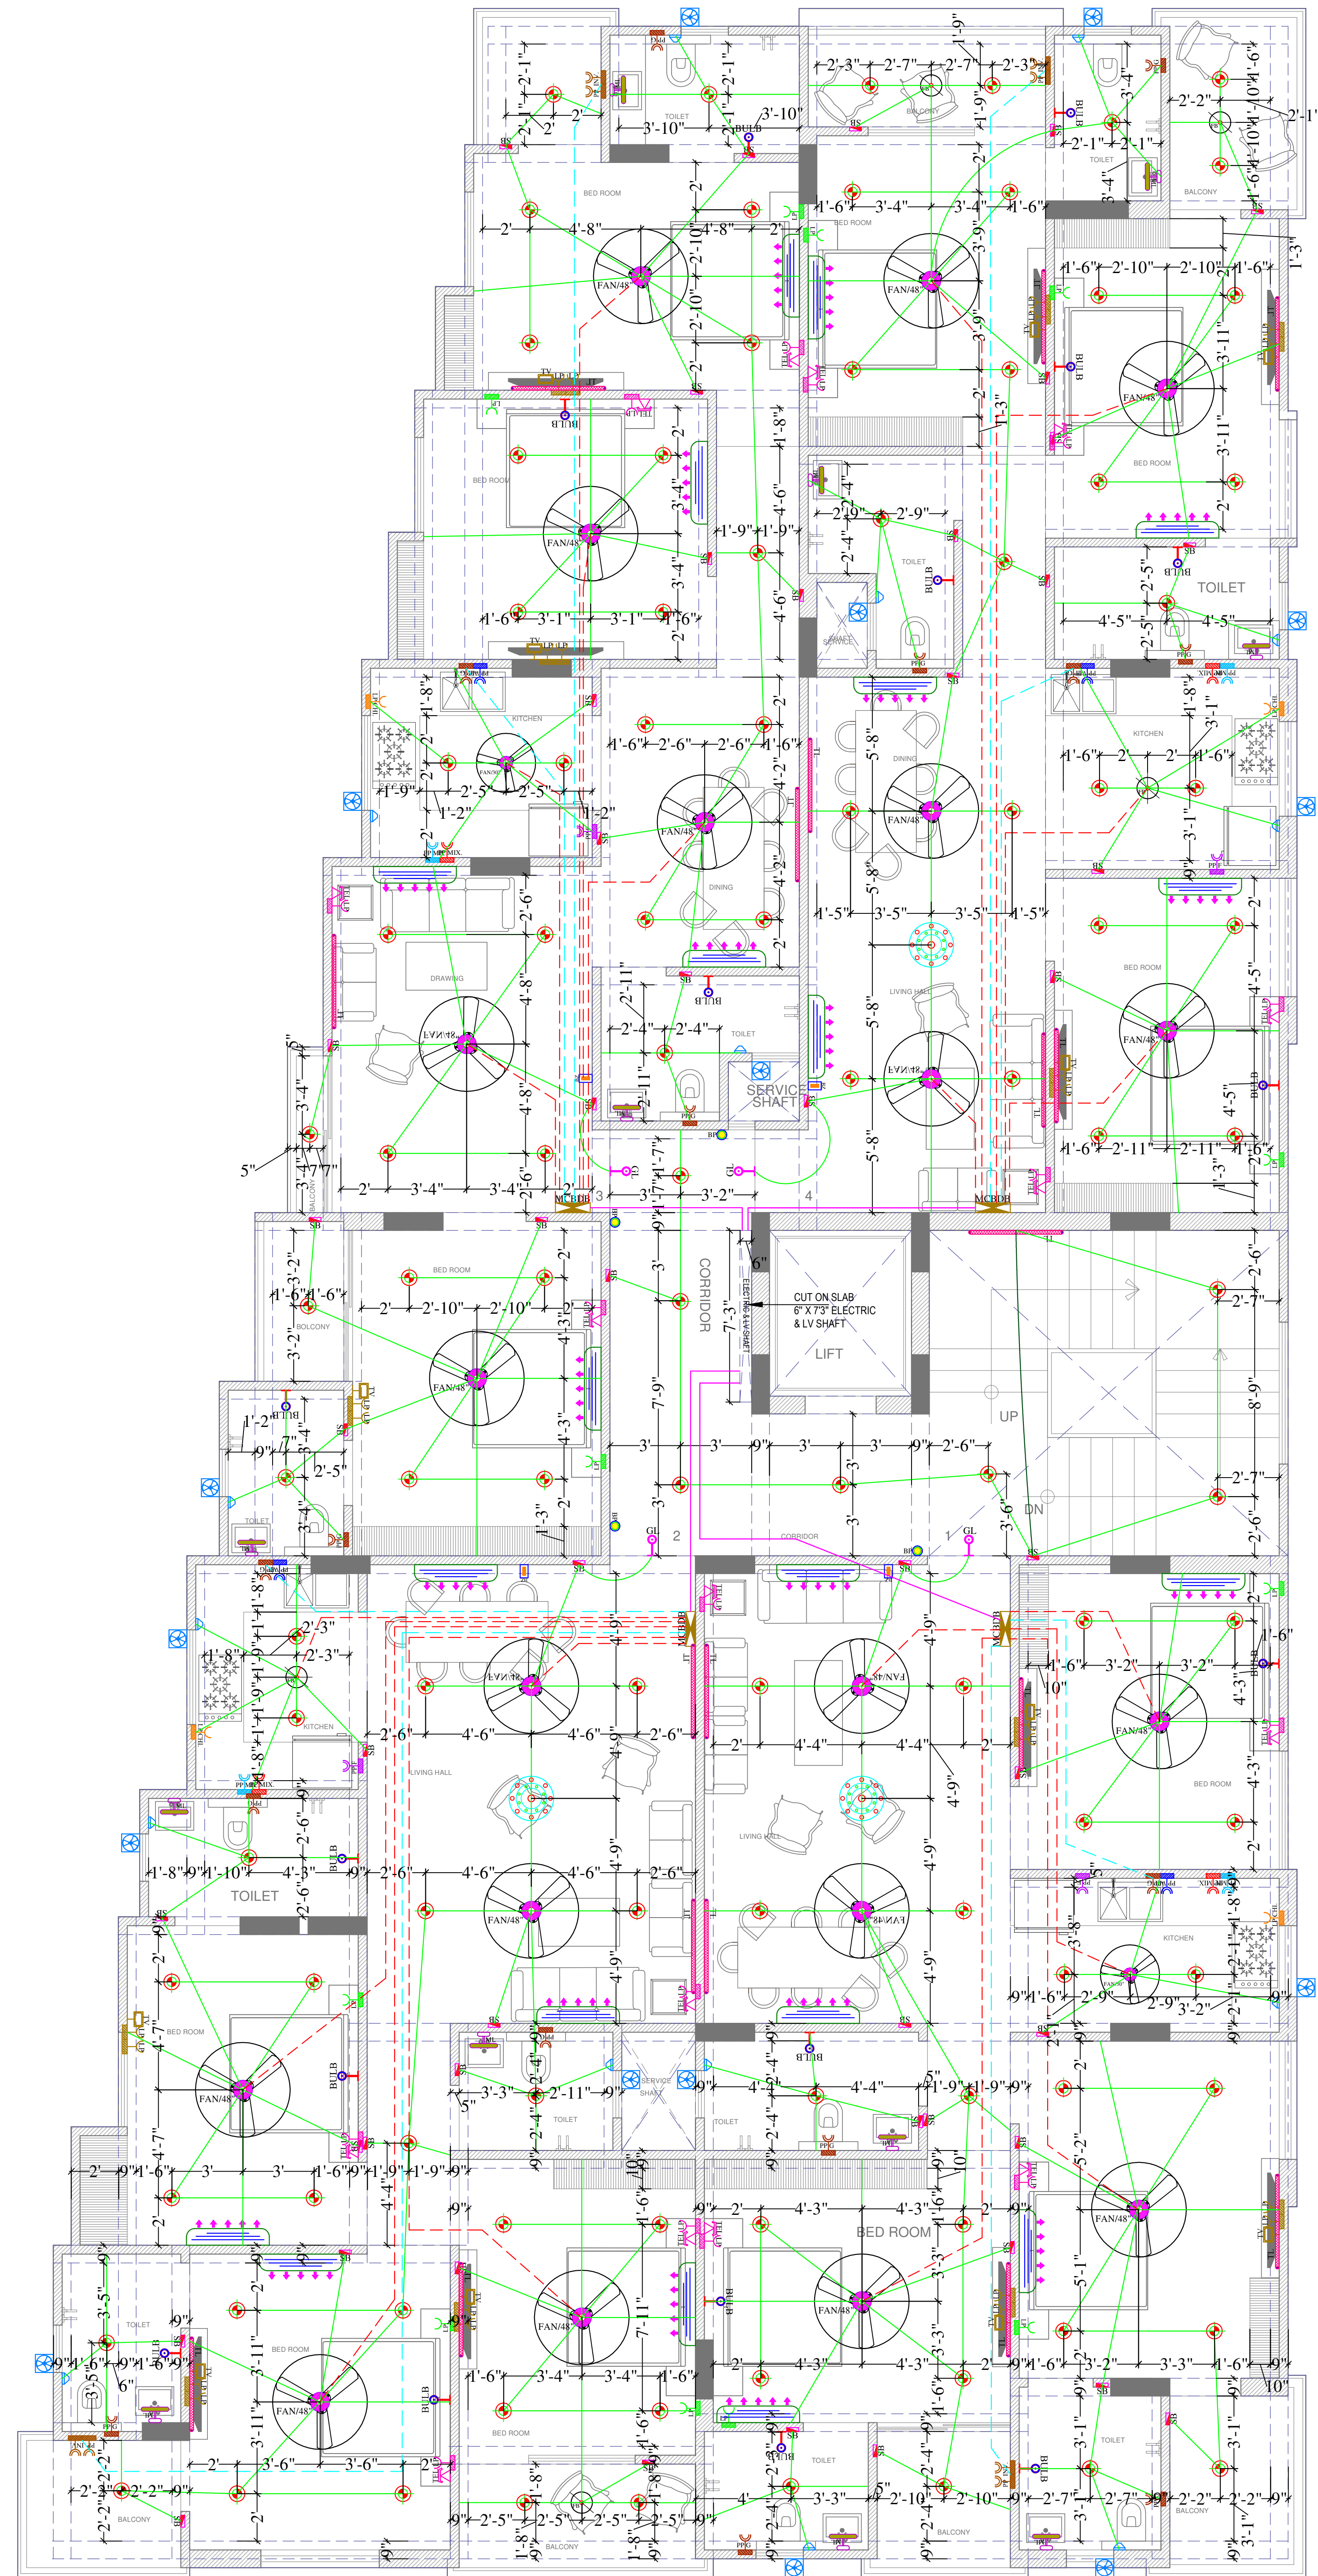

GROUND FLOOR WORKING PLAN

VIPUL AGARWAL
M.E.P. CONSULTANT
B.E. ELECTRICAL

LEGENDS:				
Mounting Height	No.	I D	Symbol	Description
IN RCC SLAB		CONDUIT		Rigid PVC 25mm dia. Conduit /1.5 sqmm Wire For Light Points
IN FLOOR		CONDUIT		Rigid PVC 25mm dia. Conduit /1.5 sqmm Wire For Light Points
IN RCC SLAB		CONDUIT		Rigid PVC 25mm dia. Conduit /2.5 sqmm Wire For Light Circuits
IN RCC SLAB		CONDUIT		Rigid PVC 25mm dia. Conduit / 4.00 sqmm Wire For Power Circuits
IN RCC SLAB		CONDUIT		Submain Wire to DB From Main Panel on Ground Floor in 1nos. 32mm dia Conduits
CEILING	20	FAN/48"		CEILING FAN 48"
CEILING	02	FAN/30"		CEILING FAN 30"
CEILING	05	FB		FAN BOX
CEILING	03	CH1		CHANDELIER
+90"	18	TL/W		LED WALL TUBE LIGHT MAKE:- SYSKA LED CAT NO.- SSK-TS-20W
+90"	18	BULB		LED BULB 20W MAKE:- SYSKA LED CAT NO.- SKC-20W 5.7K/3K
+90"	04	GL		WALL BRACKETS AS DESIGN FOR GANESH LIGHT
+78"	12	ML		12X2 LED MIRROR LIGHT MAKE:- SYSKA LED CAT NO.- FPL-12X2
CEILING	111	DL		LED 6" DOWN LIGHTER 20W (SURFACE MOUNTED) MAKE:- SYSKA LED CAT NO.- SDL-15W GLD 6.5K/4K
VENTILATOR HT.	16	CR		CEILING ROSE
VENTILATOR HT.	16	EXP		9" DIA FRESH AIR FAN
+42"	51	SB		SWITCH BOARD
+24"	16	TEL		TELEPHONE POINT
+24"	16	LP TEL		6 A PLUG POINT FOR TELEPHONE
+48"	12	TV		TV COAXIAL POINT
+48"	24	LP TV		6 A PLUG POINT FOR TV
+24"	12	LP		6 A PLUG POINT FOR SIDE TABLE
+72"	04	LP-CH		6 A PLUG POINT FOR CHIMNEY
+90"	20	SAC		SPLIT AC INDOOR UNIT
+42"	04	PP-MIX		16 A POWER POINT FOR MIXER
+42"	04	PP-MIC		16 A POWER POINT FOR MICROWAVE
+78"	16	PP-G		16 A POWER POINT FOR GEYSER
+54"	04	PP-F		16 A POWER POINT FOR FRIDGE
+78"	04	PP-WP		16 A POWER POINT FOR WATER PURIFIER
+48"	00	PP-WM		16 A POWER POINT FOR WASHING MACHINE
+12"	08	PP-INV.		16 A POWER POINT FOR INVERTOR
+60"	04	BP		6 A BELL PUSH
+90"	04	BZ		BUZZER FOR CALL BELL
+60"	04	MCB DB		MCB DISTRIBUTION BOARD

SERVICES CONSULTANT:
ASHI ASSOCIATES
F 9 / 440 , Keshav Marg Chitrakut Scheme,Jaipur
PH:91-0-93146-10438 ,0141-2440946 Mail:vipul8599@yahoo.com
REV. NO. 00 DATE: 18-07-2024

DRN BY:- KEDAR	CKD BY:- SANJAY	APPD.:- VIPUL AGARWAL
-------------------	--------------------	--------------------------

PROJECT ADDRESS:

PROPOSED BUILDING AT
PLOT NO.- 04 (RES.),
IN SCHEME :- SHIV SHAKTI NAGAR
VISTAR (NIJI KHATEDARI), JAIPUR


PROJECT NAME:
MJB ATHULYAM- II
PROMOTERS :-
MJB BUILD DEVELOPERS

DRAWING:
**GROUND FLOOR ROOF
ELECTRIC CONDUIT PLAN**
ARCHITECT:



ARCHITECTS, INTERIOR DESIGNERS AND ENGINEERS

B-6, Moti Marg, Bapu Nagar, Jaipur.
Ph.: 9314510603
E-Mail: spaceedgejpr@gmail.com

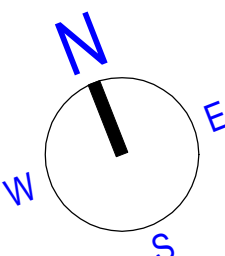WORKING DRAWING	
DATE : 08/07/2024	
SCALE: NTS 01	