


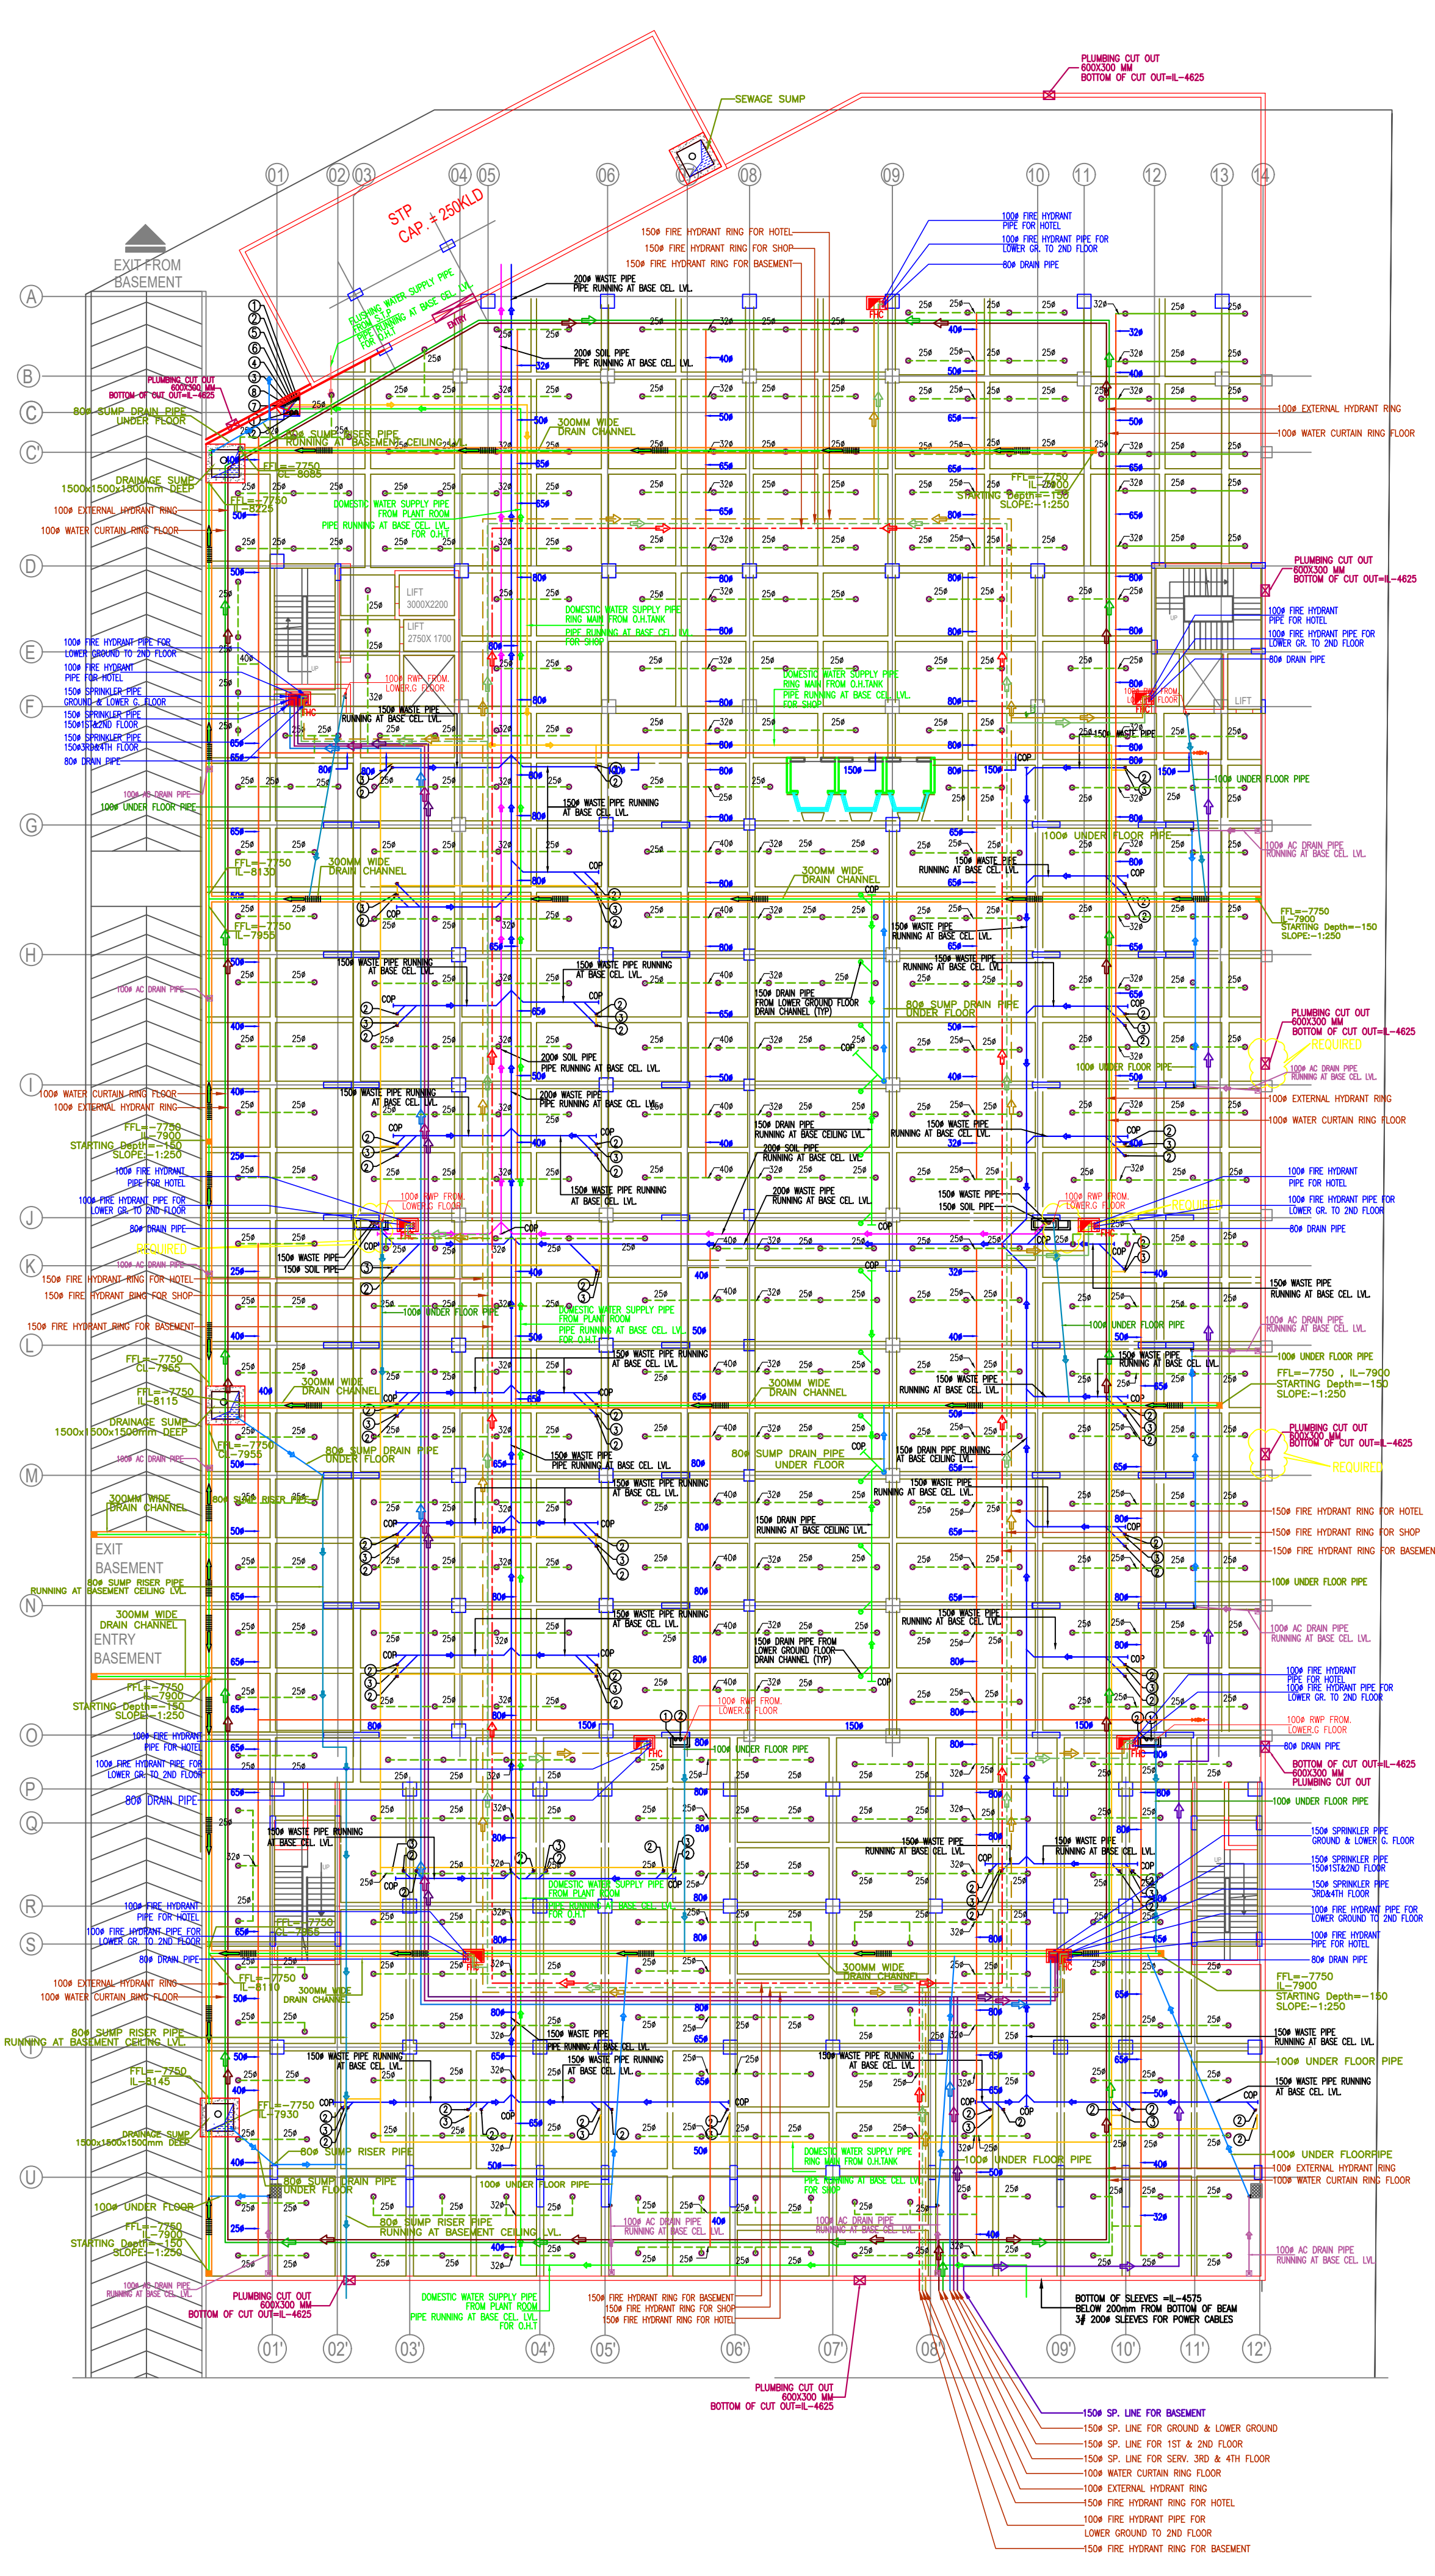

NOTES

SL

SPECIFICATION

1

DRAWING AND DIMENSIONS ARE ONLY TO BE READ AND NOT SCALED.

2

UNLESS OTHERWISE MENTIONED, ALL DIMENSIONS ARE GIVEN IN MILLIMETER.

3

THIS DRAWING SHALL BE READ IN CONJUNCTION WITH RELEVANT ARCHITECTURAL, STRUCTURAL, AND SERVICES DRAWINGS.

4

ALL LEVELS GIVEN IN DRAWING ARE WITH REFERENCE TO THE N.G.L. AS BENCHMARKED AT SITE.

5

ANY DISCREPANCY BETWEEN THE ARCHITECTURAL/STRUCTURAL OR SERVICES DRAWINGS MUST BE BROUGHT TO THE ATTENTION OF THE ARCHITECT BY THE CONTRACTOR OR PROJECT MANAGER, BEFORE EXECUTION OF THE SAME.

CONSULTANTS

NAME

PHONE. NO.

PROJECT MANAGER

STRUCTURE

PLUMBING

ELECTRICAL

HVAC

LANDSCAPE

LEGEND

S.NO.

SYMBOL

DESCRIPTION

1.

110mm SOIL PIPE.

1A.

150mm SOIL PIPE.

2.

110mm WASTE PIPE.

2A.

150mm WASTE PIPE.

3.

DOMESTIC WATER SUPPLY (DWS.)

4.

FLUSHING WATER SUPPLY (FWS.)

5.

HOT WATER SUPPLY (HWS.)

6.

DOMESTIC WATER SUPPLY (DWS.) BASEMENT RING

7.

DOMESTIC WATER RISER (DWR.)

8.

FLUSHING WATER RISER (FWR.)

9.

FLOOR TRAP

10.

BALL VALVE

FIRE LEGEND:-

UP-RIGHT SPRINKLER

PENDENT SPRINKLER

SIDE WALL SPRINKLER

FHC

BALL VALVE

FLOW SWITCH

KEY PLAN

REV.NO.

REVISION

DATE

PURPOSE OF DRAWING

G.F.C

F.I.O

TENDER

THIS DRAWING HAS TO BE READ IN CONJUNCTION WITH DRG. NO.

CLIENT :-

M/S R-Tech Developers

SERVICES CONSULTANT

SARTHAK BUILDING ENGINEERING

C-24 Ganesh Nager Pandav Nager Complex

Ground Floor, New Delhi-110092

Telephone :- 011-65000445

website :- www.sbmep.com

e-mail :- info@sbmep.com

PROJECT :-

REVISED EXISTING & PROPOSED COMMERCIAL BUILDING PLANS ON PLOT NO. CC-01 AT RICCO INDUSTRIAL AREA NEEMRANA (RAJASTHAN)

SHEET TITLE

BASEMENT FLOOR PLAN CO-ORDINATED SYSTEM LAYOUT

DRG. NO.

SBE-PL-FF-01

DATE

05-11-2016

SHEET SIZE

A1

REV. NO

R0

NORTH

ARCHITECTS

RASS ARCHITECTS

RE-FRAMED ARCHITECTURAL SOLUTIONS AND SERVICES.

ARCHITECTS ENGINEERS & INTERIOR DESIGNERS

46, JACARANDA MARG, DLF PH-II, GGN, HARYANA -122002

PHONE: 0124-2387001, 9990337996, 9990406886