
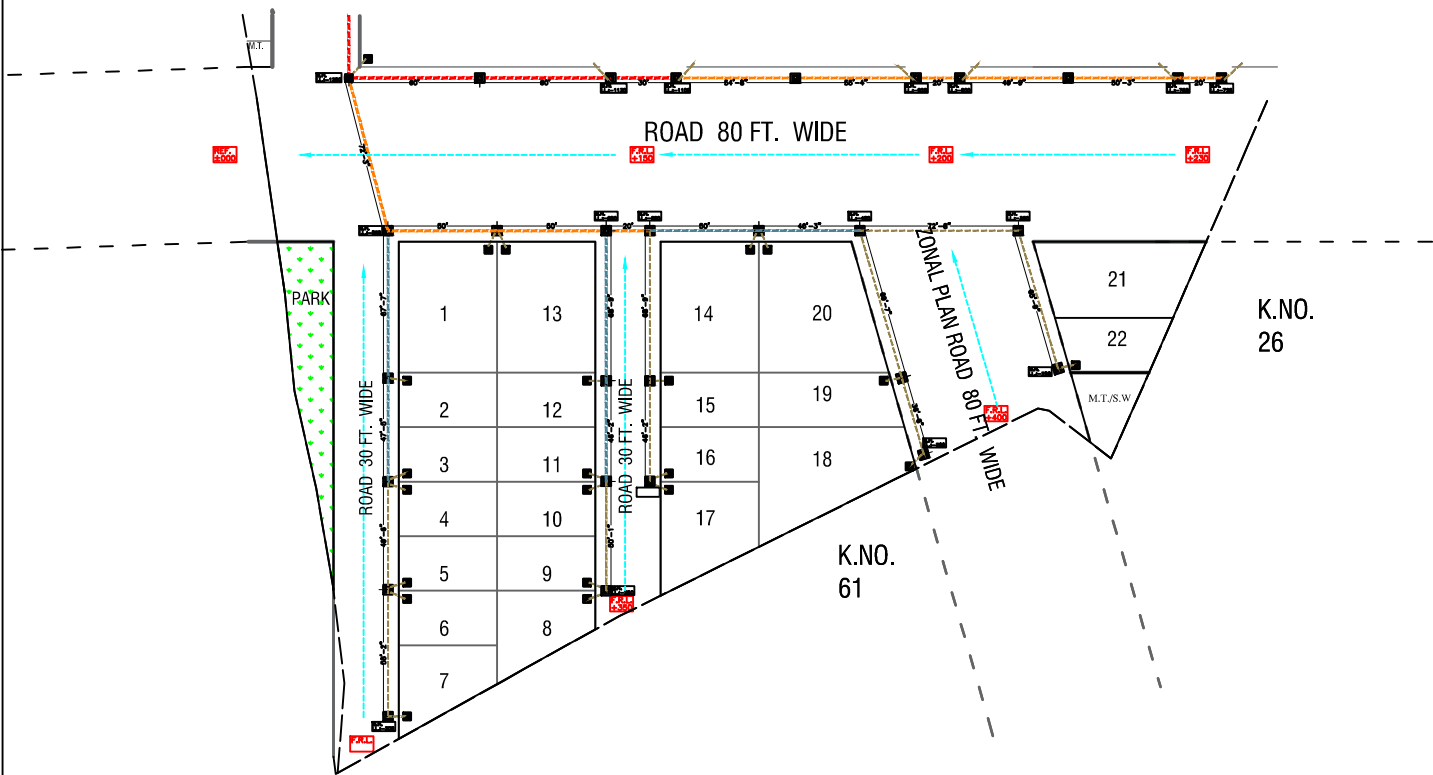


ASHAPURNA VALLEY ORCHARD III AT JODHPUR KHASRA NO. 27 / 1

DRAINAGE PLUMBING PLAN

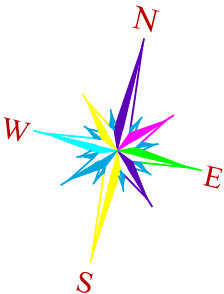

NOTE : THAT THIS PLAN IS ONLY TENTATIVE
SOME CHANGES MIGHT HAPPEN AS PER SITE
CONDITION

- DRAINAGE PLUMBING LEGEND:-**
- 160MM Ø DRAINAGE LINE - PVC SDR SN8 PIPE
 - 200MM Ø DRAINAGE LINE - PVC SDR SN8 PIPE
 - 250MM Ø DRAINAGE LINE - PVC SDR SN8 PIPE
 - 300MM Ø DRAINAGE LINE - PVC SDR SN8 PIPE
 - I.L. : INVERT LEVEL OF PIPE BOTTOM
 - F.R.L. : FINISHED ROAD LEVEL
 - M.H. : MANHOLE SIZE AS PER DETAIL DRAWING

PROJECT : KHARA NO. 27/1	SIGN AND STAMP : <i>Gaurav Joshi</i> GAURAV JOSHI CIVIL ENGINEER 12, Near Maheshwari Nagar Nohra, Masuriya, Jodhpur		DRG. TITLE : DRAINAGE PLUMBING PLAN		MEPF CONSULTANT KARMA MEPF CONSULTANTS B404, ARISE ICON, NEAR UMIYA CAMPUS, BEHIND- SG BUSINESS HUB, SG HIGHWAY, AHMEDABAD, GUJARAT, INDIA, M- 09727745869, Email Id : vivekpriya@karmamepf.com, vivekpriya4509@gmail.com																	
			<table><tr><td>PREP. BY</td><td>NAME</td><td>SDN</td><td>DATE</td><td>SCALE</td><td colspan="2">SUBMITTED FOR</td></tr><tr><td>CHKD. BY</td><td>MAHESH</td><td>JARWAR</td><td>13-05-21</td><td>NTS</td><td>PRELIMINARY</td><td>APPROVAL</td></tr><tr><td>APP. BY</td><td></td><td></td><td></td><td>DWG. NO.</td><td>MEP 03</td><td>REV. R1</td></tr></table>			PREP. BY	NAME	SDN	DATE	SCALE	SUBMITTED FOR		CHKD. BY	MAHESH	JARWAR	13-05-21	NTS	PRELIMINARY	APPROVAL	APP. BY		
PREP. BY	NAME	SDN	DATE	SCALE	SUBMITTED FOR																	
CHKD. BY	MAHESH	JARWAR	13-05-21	NTS	PRELIMINARY	APPROVAL																
APP. BY				DWG. NO.	MEP 03	REV. R1																
<table><tr><td>REV. NO.</td><td>DATE</td><td>DESCRIPTION</td></tr><tr><td>R2</td><td>13-05-24</td><td>APPROVAL</td></tr><tr><td>R1</td><td>26.02.24</td><td>APPROVAL</td></tr><tr><td>R0</td><td>29.01.24</td><td>PRELIMINARY</td></tr></table>			REV. NO.	DATE	DESCRIPTION	R2	13-05-24	APPROVAL	R1	26.02.24	APPROVAL	R0	29.01.24	PRELIMINARY								
REV. NO.	DATE	DESCRIPTION																				
R2	13-05-24	APPROVAL																				
R1	26.02.24	APPROVAL																				
R0	29.01.24	PRELIMINARY																				