


PRODUCED BY AN AUTODESK EDUCATIONAL PRODUCT

PRODUCED BY AN AUTODESK EDUCATIONAL PRODUCT

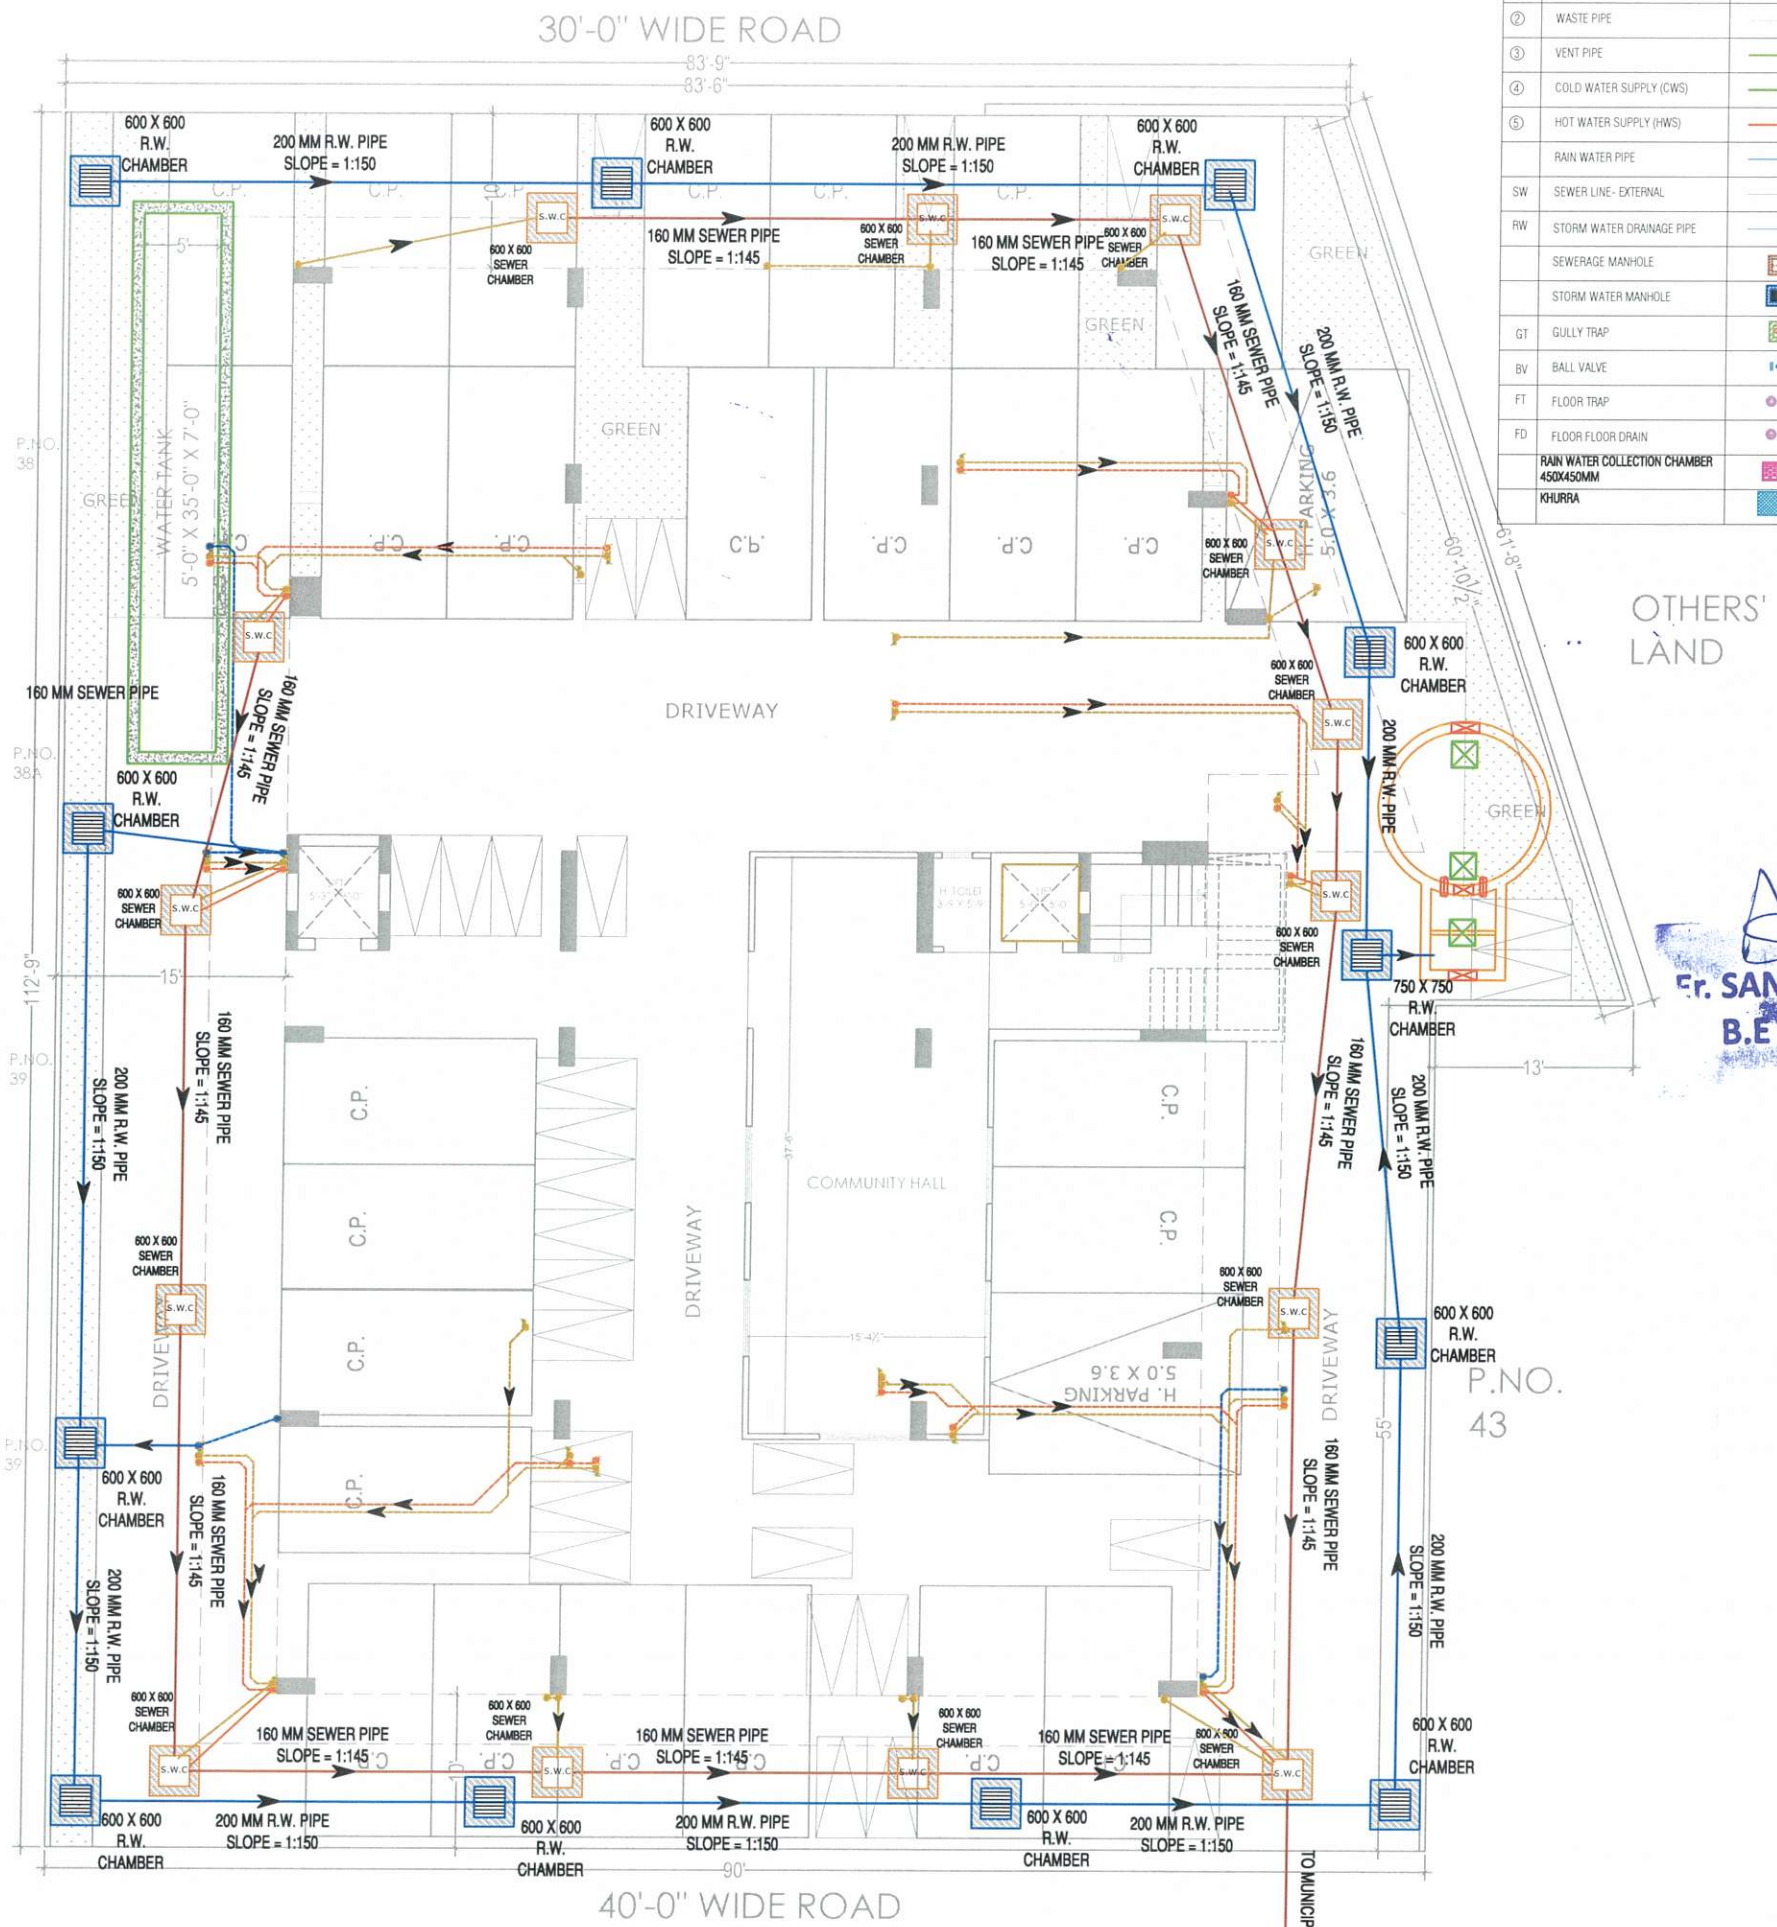

LEGEND:-

①	SOIL PIPE	
②	WASTE PIPE	
③	VENT PIPE	
④	COLD WATER SUPPLY (CWS)	
⑤	HOT WATER SUPPLY (HWS)	
	RAIN WATER PIPE	
SW	SEWER LINE- EXTERNAL	
RW	STORM WATER DRAINAGE PIPE	
	SEWERAGE MANHOLE	M.H.
	STORM WATER MANHOLE	M.H.
GT	GULLY TRAP	
BV	BALL VALVE	
FT	FLOOR TRAP	
FD	FLOOR FLOOR DRAIN	
	RAIN WATER COLLECTION CHAMBER 450X450MM	
	KHURRA	

CLIENT :

Mr. NATHU JI

ARCHITECTS :
4 INSIDE
ARCHITECTURE N INTERIORS
Plot no. 72, S.P. Marg, C- Scheme
jaipur, rajasthan, India
cont: +91 9950595991, 91 9982812777
e.mail: jeets.arch@gmail.com

STRUCTURAL CONSULTANTS:

MEP CONSULTANT : --
SHRI SHYAM CONSULTANT
PLUMBING | FIRE | ELECTRICAL | STP | WTP
JAIPUR-302006
PH.NO. +91 9785427711

DEALT BY
RAMESH

REVISION
R-1

DATE:
22.11.2023

Sharm
Fr. SANJEEV SHARM
B.E (Electrical)

- GENERAL NOTES:
- All dimension on this drawing are in MKS System. Only written dimensions are to be followed. drawing should not be scaled.
 - All measurements must be checked and verified by the contractors prior to execution of work at the site.
 - This drawing is to be read in conjunction with all relevant structural, services & facility planning drawings.
 - Architectural drawings are to be followed for the location of all structural members & masonry walls. for sizes & reinforcement details of structural members, relevant structural drawings are to be referred.
 - Any discrepancies between architectural, structural and services drawings must be brought to the notice of the architects immediately & prior to execution at site.
 - Coordinate with services such as fire, plumbing & electrical, etc. as the responsibility of the contractor.
 - All masonry walls should be aligned with the columns as indicated on the plan, irrespective of the position as calculated with the dimensions.
 - For details, refer relevant large scale detail, as indicated.

PROJECT:
SIDDHI VINAYAK HOME S
PROPOSED RESIDENTIAL
BUILDING ON P. NO.-
35,36,37,40,41&42 HANUMAN
VIHAR, (BALRAMPURA URF
KHEJARO KA BAS), JAIPUR

NAME OF DRAWING:
**STILT FLOOR
DRAINAGE LAYOUT PLAN**

DRAWN BY: Banwari Lal	APPROVED BY: JITENDRA SHARMA
DRAWING: WORKING DRAWING	NORTH:
PROJECT NO.:	DATE: 02. Nov. - 2023
SCALE: NTS	REV NO. : R-0
DRAWING NO. : A-202	

STILT FLOOR
DRAINAGE LAYOUT PLAN

PRODUCED BY AN AUTODESK EDUCATIONAL PRODUCT