



LEGEND	
SYMBOL	DESCRIPTION
	MANUAL CALL POINT @4'-0"
	HOOTER @8'-0"
	L&P DB Light & Power DB @5'-6"
	Conduit For Electrical Cable

[illegible]

GRAPHITE

design *graphite*
studio

GRAPHITE DESIGN STUDIO
ARCHITECTS, INTERIOR DESIGNERS, PLANNERS

88, Jansak Puri -1st, Indirivilla phatak, Opp Jain Mandir, Jaipur
CONTACT NO +91-9928334414, 0141-2594414
email: studiographite@gmail.com
Website : www.graphitedesignstudio.com

STRUCTURAL CONSULTANT



TEXEL CONSULTING ENGINEERS (P) LTD.
Plot No. 8, Block-C, Narayan Vilhar,
Jaipur-302020, Rajasthan, India.
+91-9929309333, 9413811106 | www.texelgroup.com

```

graph TD
    BG[BARDIYA GROUP] --- GTBLVU1[GT BLVU]
    GTBLVU1 --- GTBLVU2[GT BLVU]
    GTBLVU1 --- GTBLVU3[GT BLVU]
    GTBLVU2 --- GTBLVU4[GT BLVU]
    GTBLVU3 --- GTBLVU5[GT BLVU]
  
```


COVER SHEET

LOWER BESEMENT
ELECTRICAL PLAN

COVER SHEET




FOR RERA SUBMISSION

MEET CONSUMERS

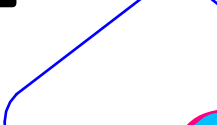

SHRESHTHA
the heartbeat of your building

DEALT BY: DEVENDRA		CHECKED BY: SACHIN		DIRECTION:
DRAWN NO.:	SCALE: NTS	SHEET SIZE: A1	DATE: 18.12.2024	

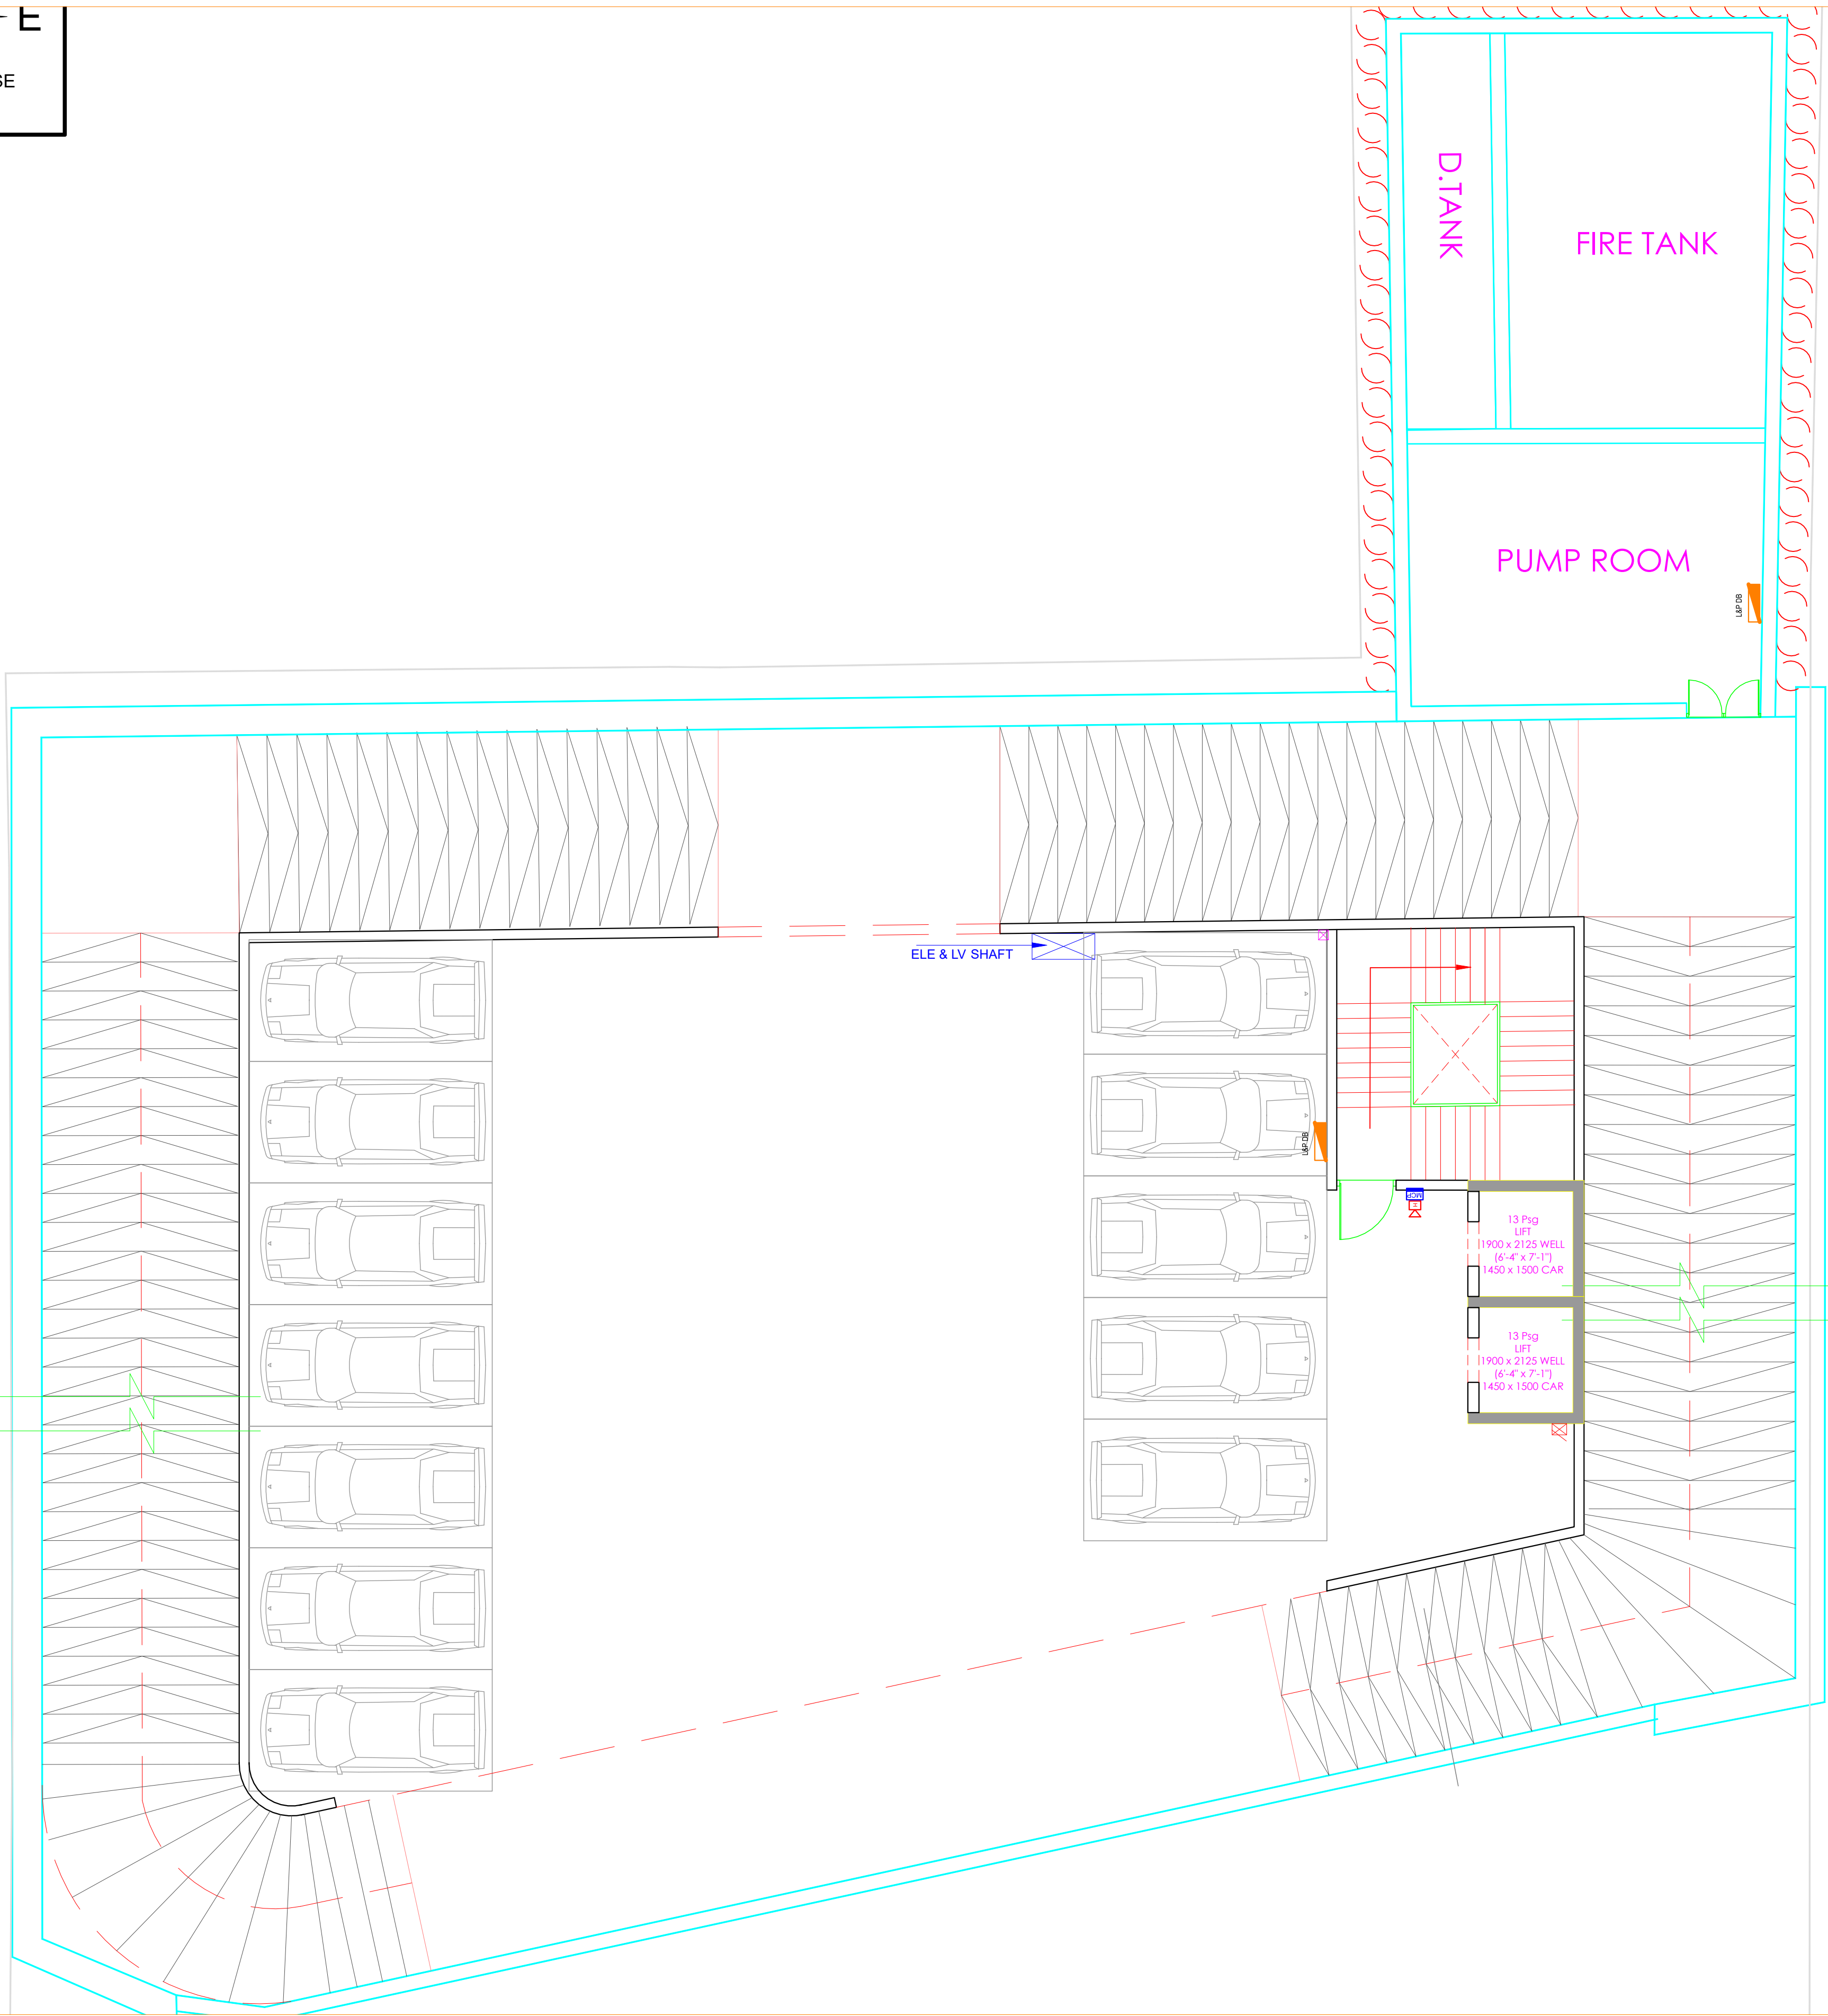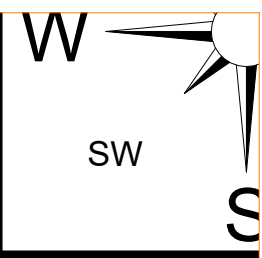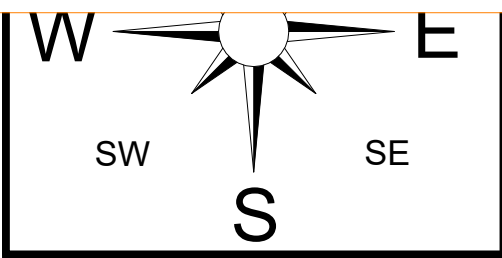

LEGEND	
SYMBOL	DESCRIPTION
	MANUAL CALL POINT @4'-0"
	HOOTER @8'-0"
	Light & Power DB @S'-6"
	Conduit For Electrical Cable

REV. NO.	DESCRIPTION TO REVISION	REV. BY	DATE
-	-	-	-
-	-	-	-
ARCHITECT

GRAPHITE DESIGN STUDIO
ARCHITECTS, INTERIOR DESIGNERS, PLANNERS
66, Janak Puri -1st, Indrawala phatak, Opp Jain Mandir, Jaipur
CONTACT NO. +91-9929309333 & 0141-2594114
email: studiosgraphite@gmail.com
Website : www.graphitedesignstudio.com

STRUCTURAL CONSULTANT

TEXEL CONSULTING ENGINEERS (P) LTD.
Plot No. 8, Block-C, Narayan Vihar,
Jaipur-302020, Rajasthan, India.
+91-9929309333, 9413811106 II www.texelgroup.com

CLIENT

BARDIYA GROUP

GT BLVU

PROJECT



UPPER BESEMENT ELECTRICAL PLAN

FOR RERA SUBMISSION

DESIGNER

SHRESHTHA
the heartbeat of your building

DEALT BY:		CHECKED BY:		DIRECTION:
DEVENDRA		SACHIN		
DRAWN NO.:	SCALE:	SHEET SIZE:	DATE:	
	NTS	A1	18.12.2024	

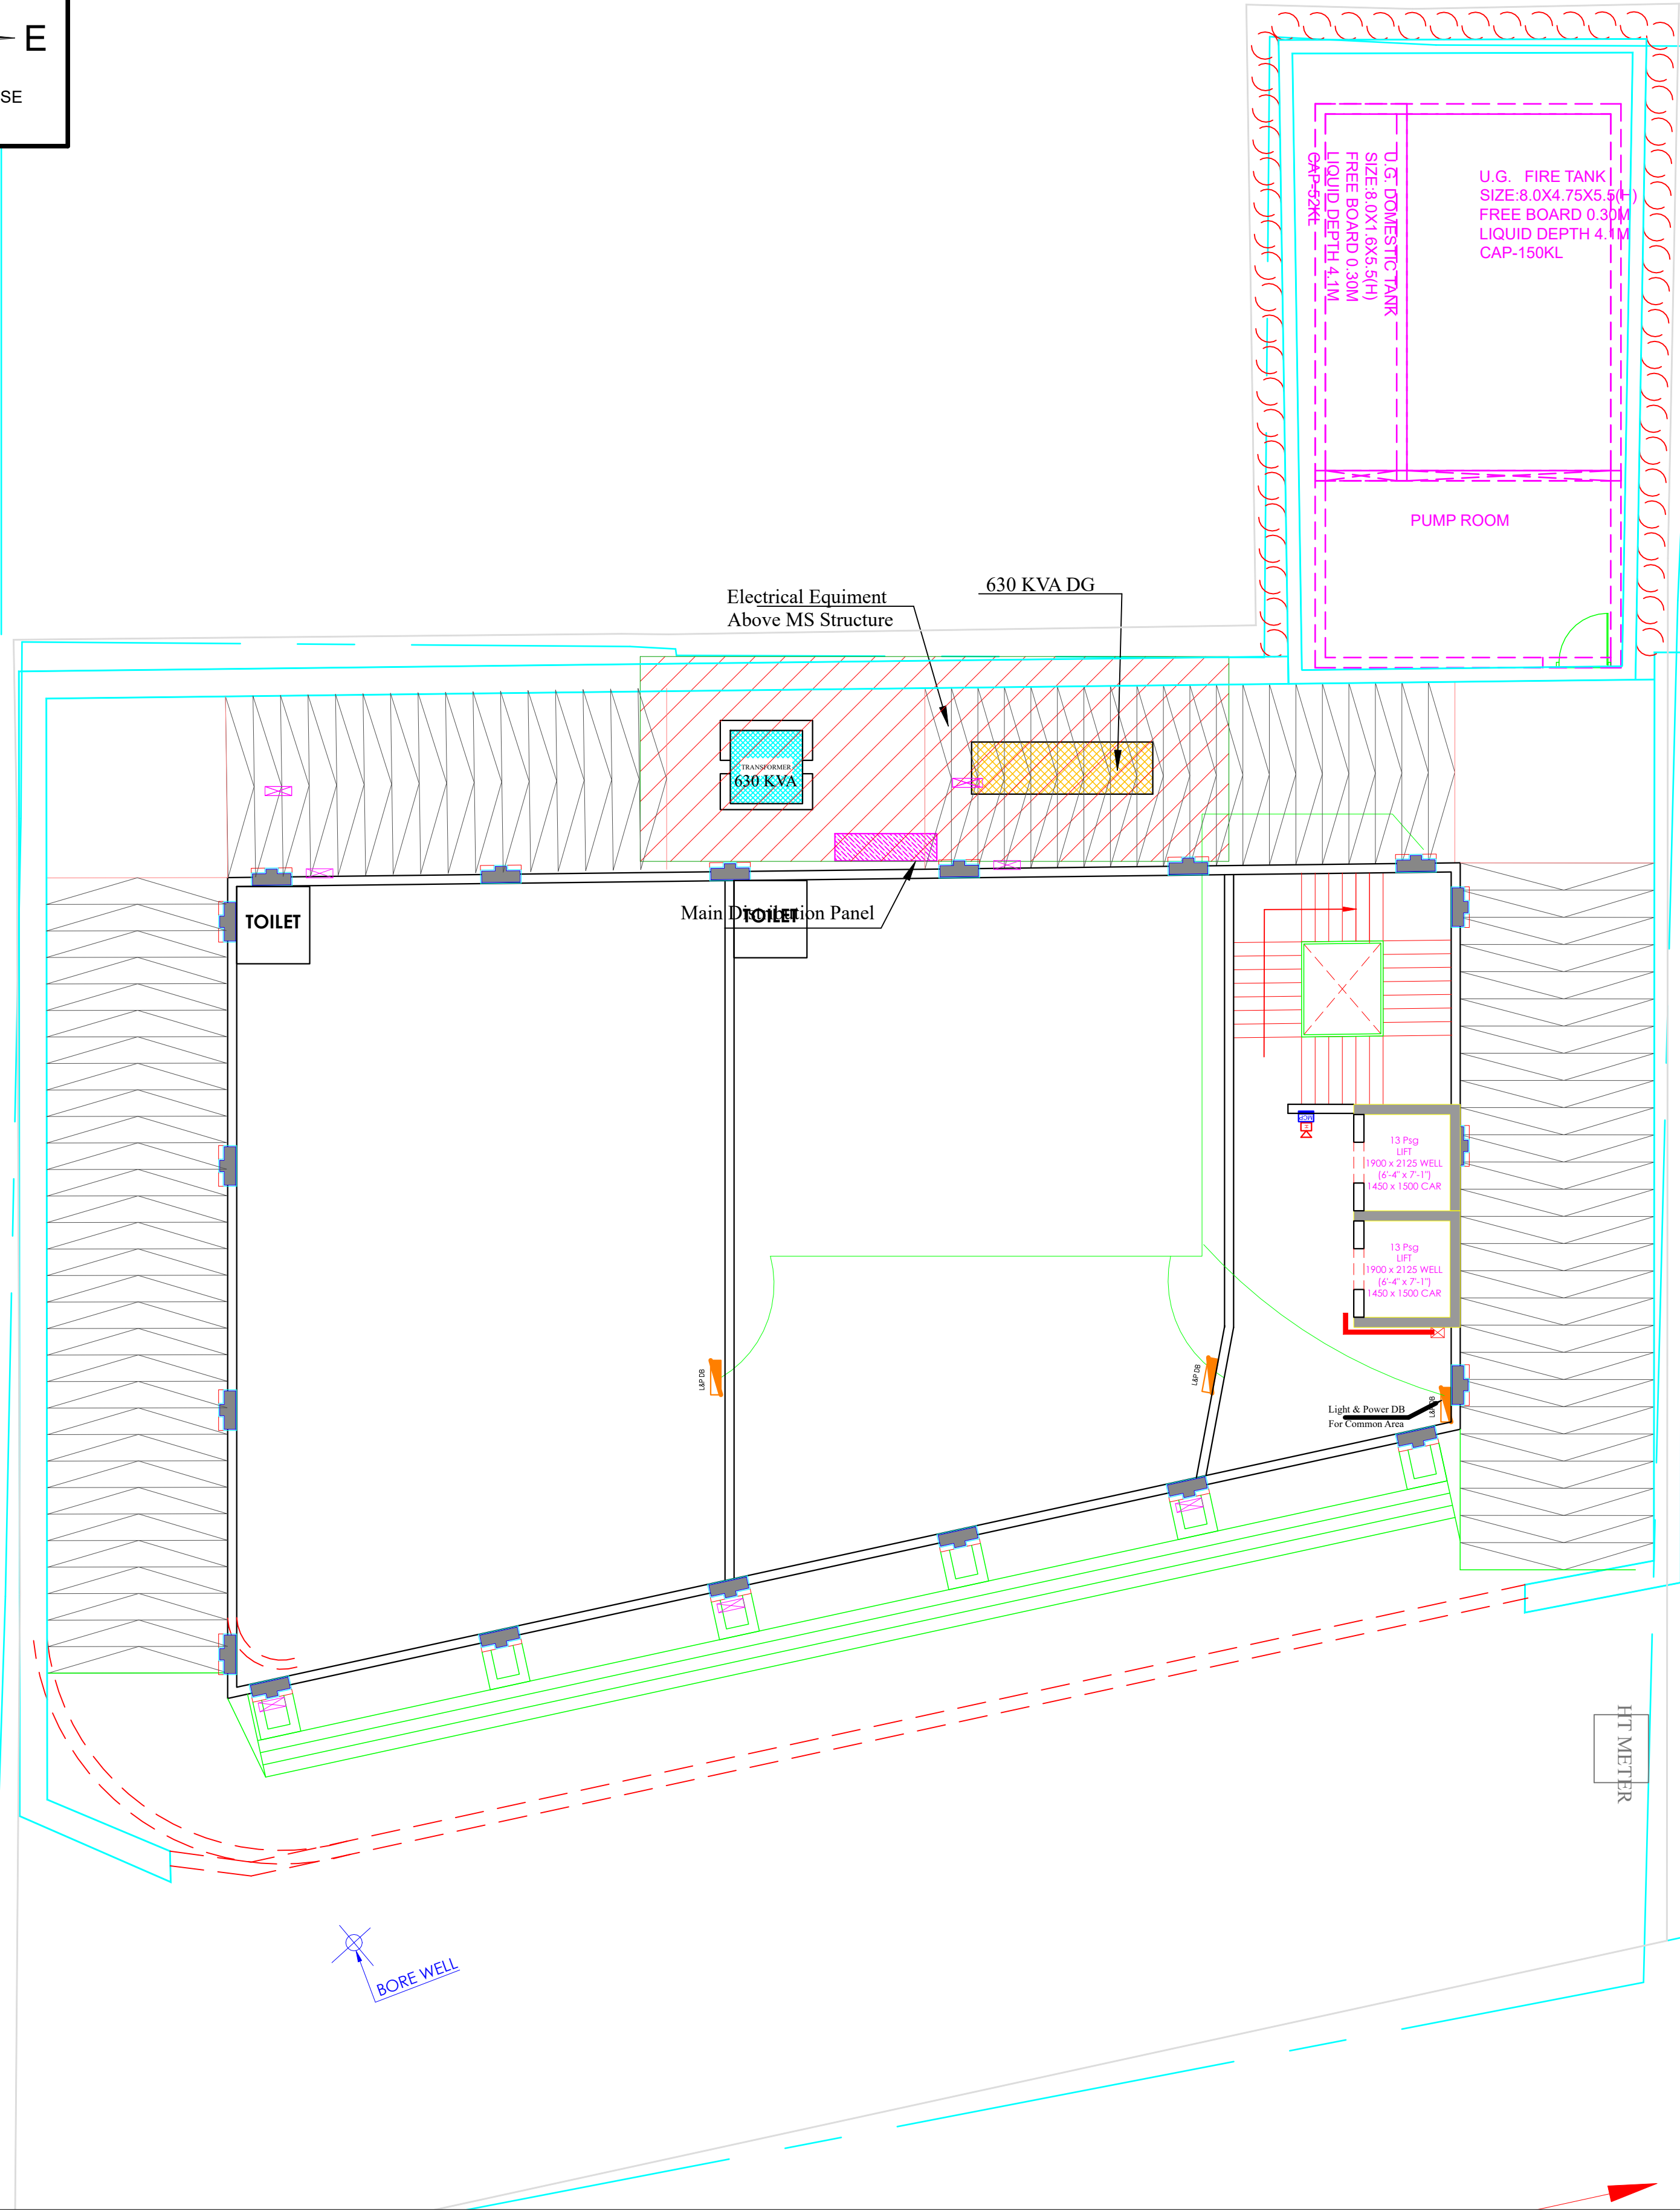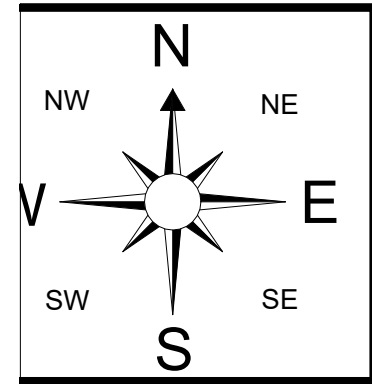

SUDHIR MATHUR
M.E.P.F. CONSULTANT
B.E. MECHANICAL

LEGEND

SYMBOL	DESCRIPTION
	MANUAL CALL POINT @4'-0"
	HOOTER @8'-0"
	Light & Power DB @5'-6"
	Conduit For Electrical Cable

REV. NO.	DESCRIPTION TO REVISION	REV. BY	DATE
-	-	-	-
-	-	-	-
ARCHITECT

GRAPHITE DESIGN STUDIO
ARCHITECTS, INTERIOR DESIGNERS, PLANNERS
68, Janak Puri - 1st, Indira Park, Opp. Jain Mandir, Jaipur
CONTACT NO. +91-992933414, 0141-2594414
email: studio@graphitedesignstudio.com
Website: www.graphitedesignstudio.com

STRUCTURAL CONSULTANT

TEXEL CONSULTING ENGINEERS (P) LTD.
Plot No. 8, Block-C, Narayan Vihar,
Jaipur-302020, Rajasthan, India.
+91-9929309333, 9413811106 || www.texelgroup.com

CLIENT

BARDIYA GROUP

PROJECT NAME

GT BLVU

PROJECT

GROUND FLOOR ELECTRICAL PLAN


PROJECT STATUS

FOR RERA SUBMISSION

PROJECT MANAGER

SHRESHTHA
the heartbeat of your building

DEALT BY: DEVENDRA		CHECKED BY: SACHIN		DIRECTION:
DRAWING NO.:	SCALE: NTS	SHEET SIZE: A1	DATE: 18.12.2024	

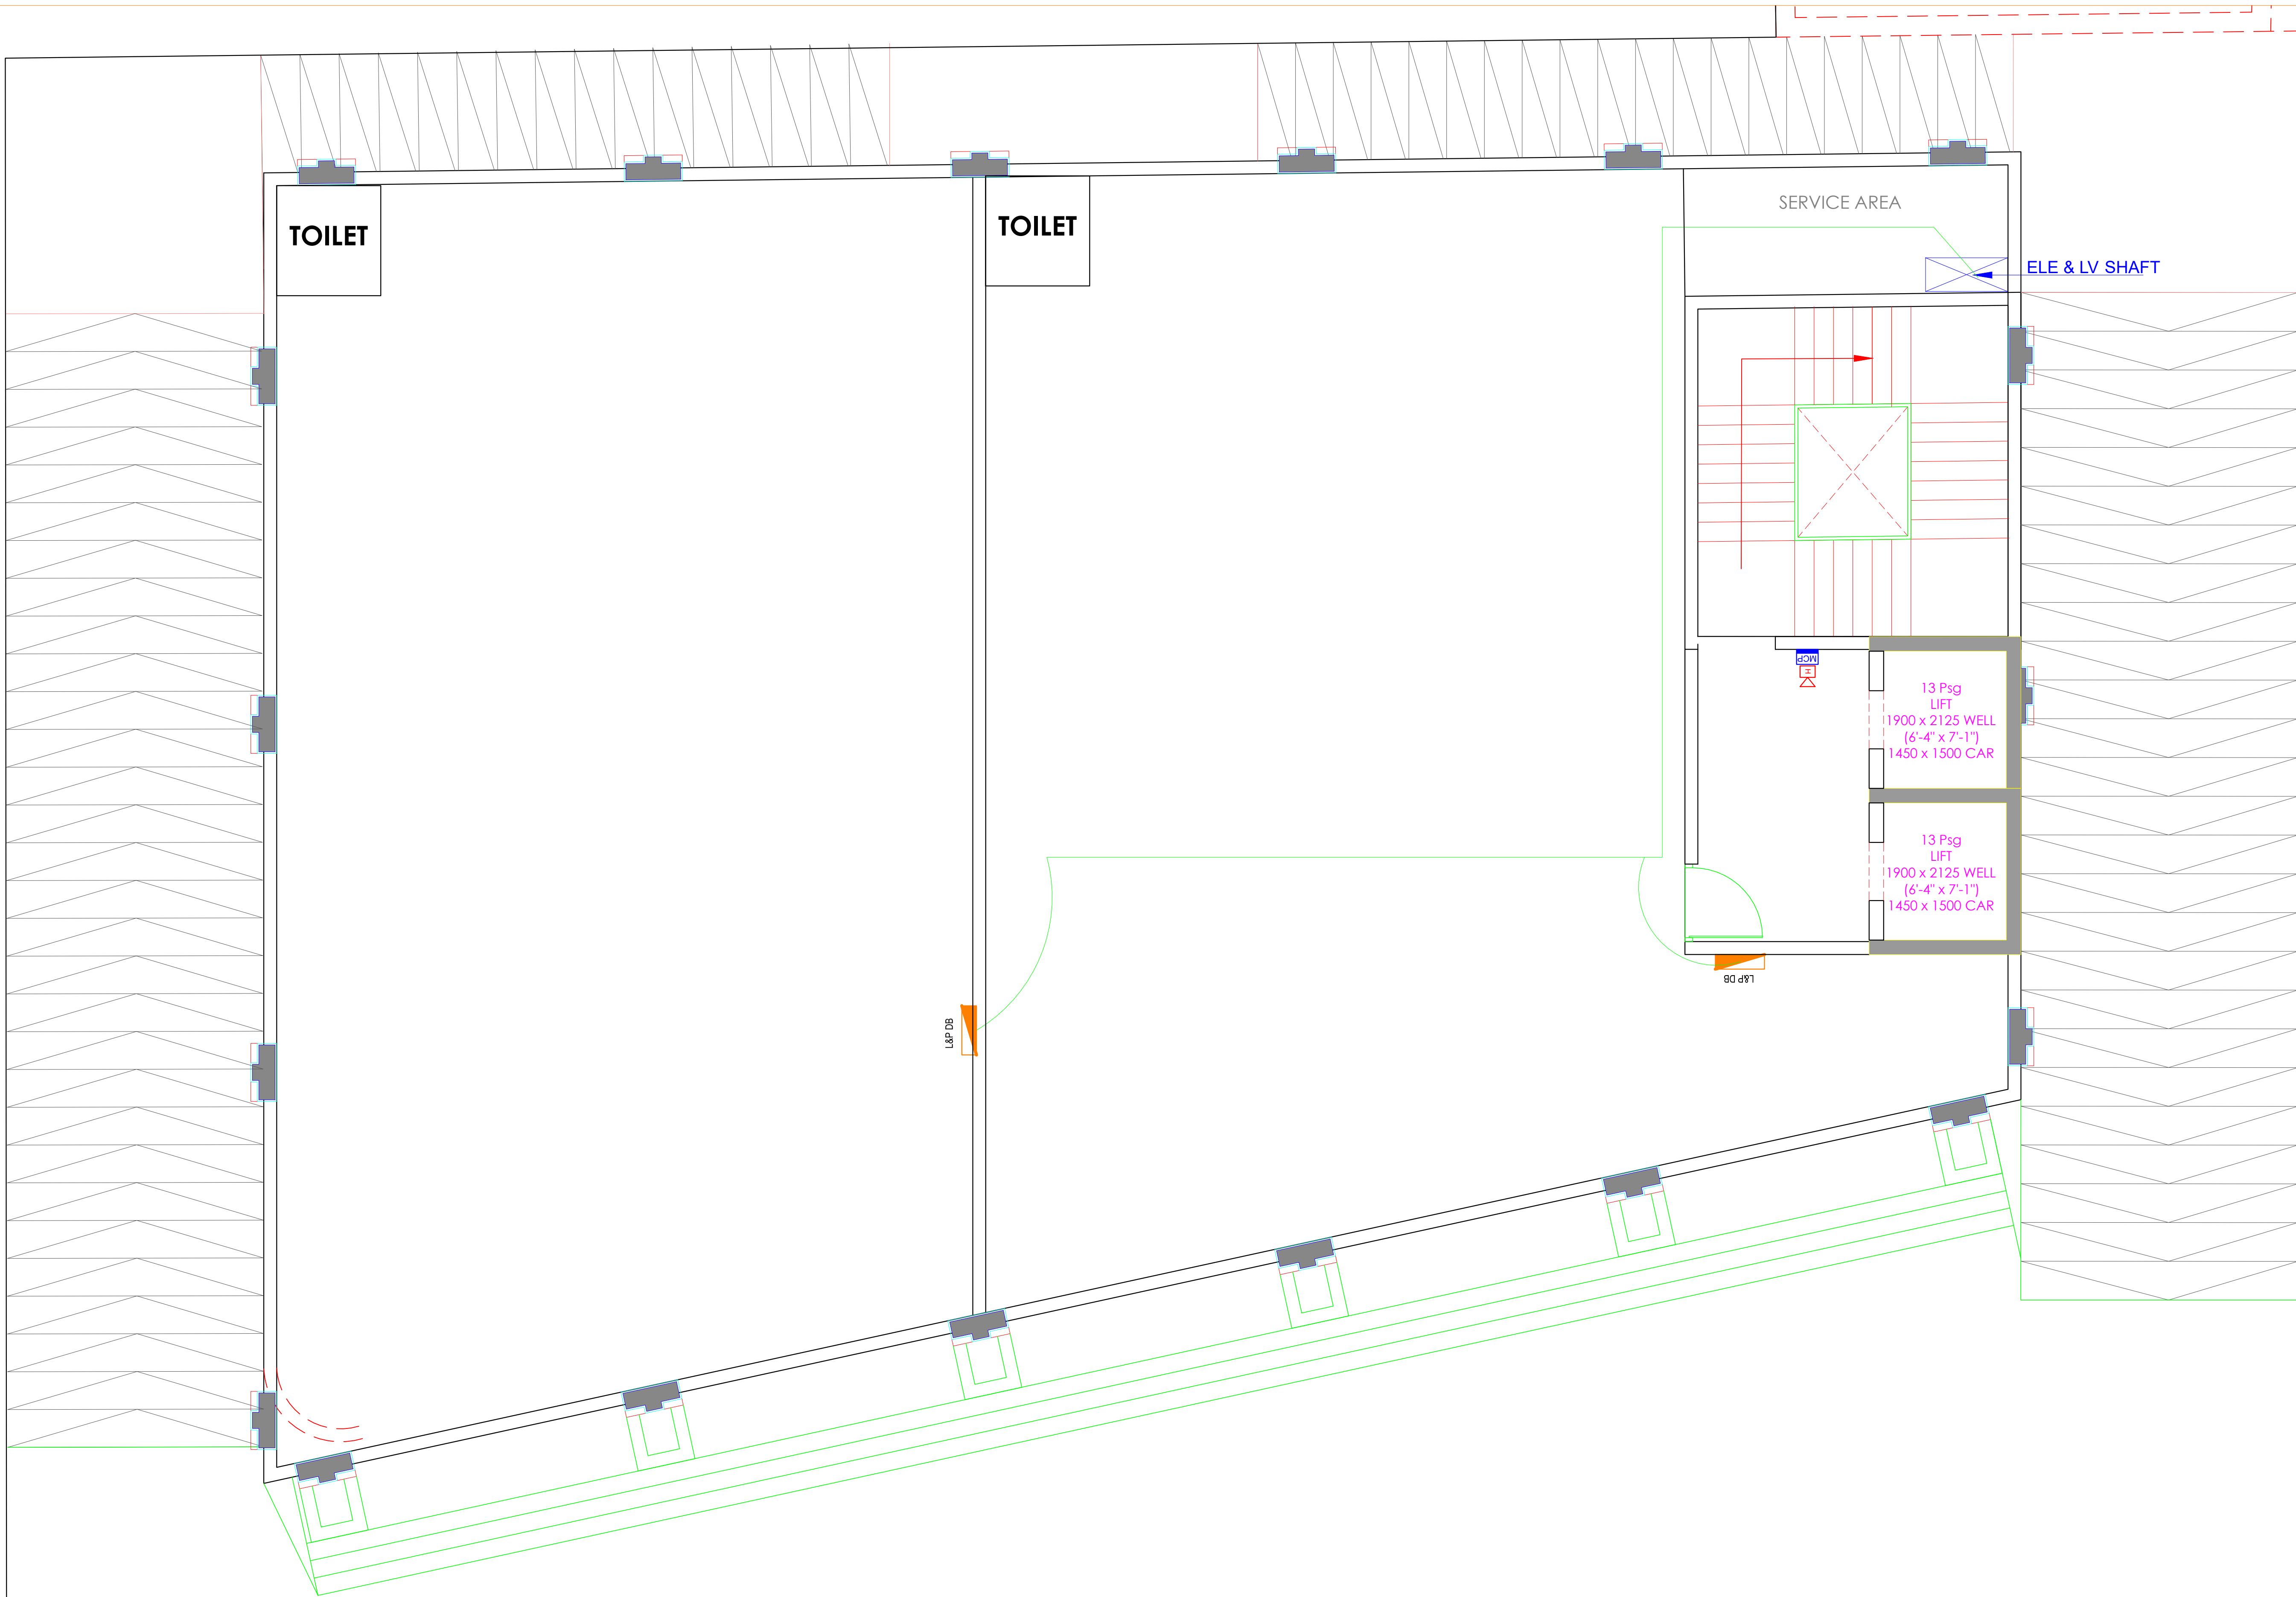

LEGEND


SYMBOL	DESCRIPTION
	MANUAL CALL POINT @4'-0"
	HOOTER @8'-0"
	Light & Power DB @5'-6"
	Conduit For Electrical Cable

REV. NO.	DESCRIPTION TO REVISION	REV. BY	DATE
-	-	-	-
-	-	-	-
ARCHITECT


GRAPHITE DESIGN STUDIO
ARCHITECTS, INTERIOR DESIGNERS, PLANNERS
68, Janak Puri -1st, Indrawala phatak, Opp Jain Mandir, Jaipur
CONTACT NO. +91-9929333414, 0141-2594414
email: studio@graphite@gmail.com
Website: www.graphitedesignstudio.com

STRUCTURAL CONSULTANT

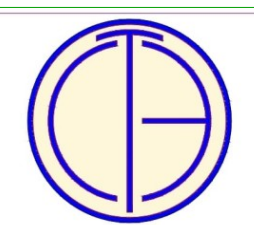
TEXEL CONSULTING ENGINEERS (P) LTD.
Plot No. 8, Block-C, Narayan Vihar,
Jaipur-302020, Rajasthan, India.
+91-9929309333, 9413811106 ll www.texelgroup.com

CLIENT

BARDIYA GROUP

PROJECT NAME

GT BLVU


DESIGNER

FIRST FLOOR ELECTRICAL PLAN


DESIGN STATUS

FOR RERA SUBMISSION

PROJECT MANAGER

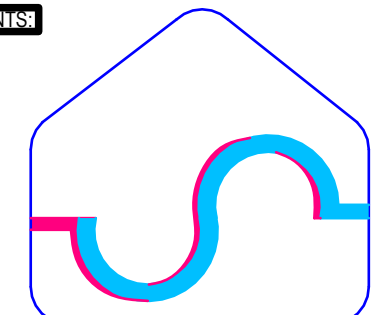
SHRESHTHA
the heartbeat of your building

DEALT BY: DEVENDRA		CHECKED BY: SACHIN		DIRECTION:
DRAWING NO.:	SCALE: NTS	SHEET SIZE: A1	DATE: 18.12.2024	

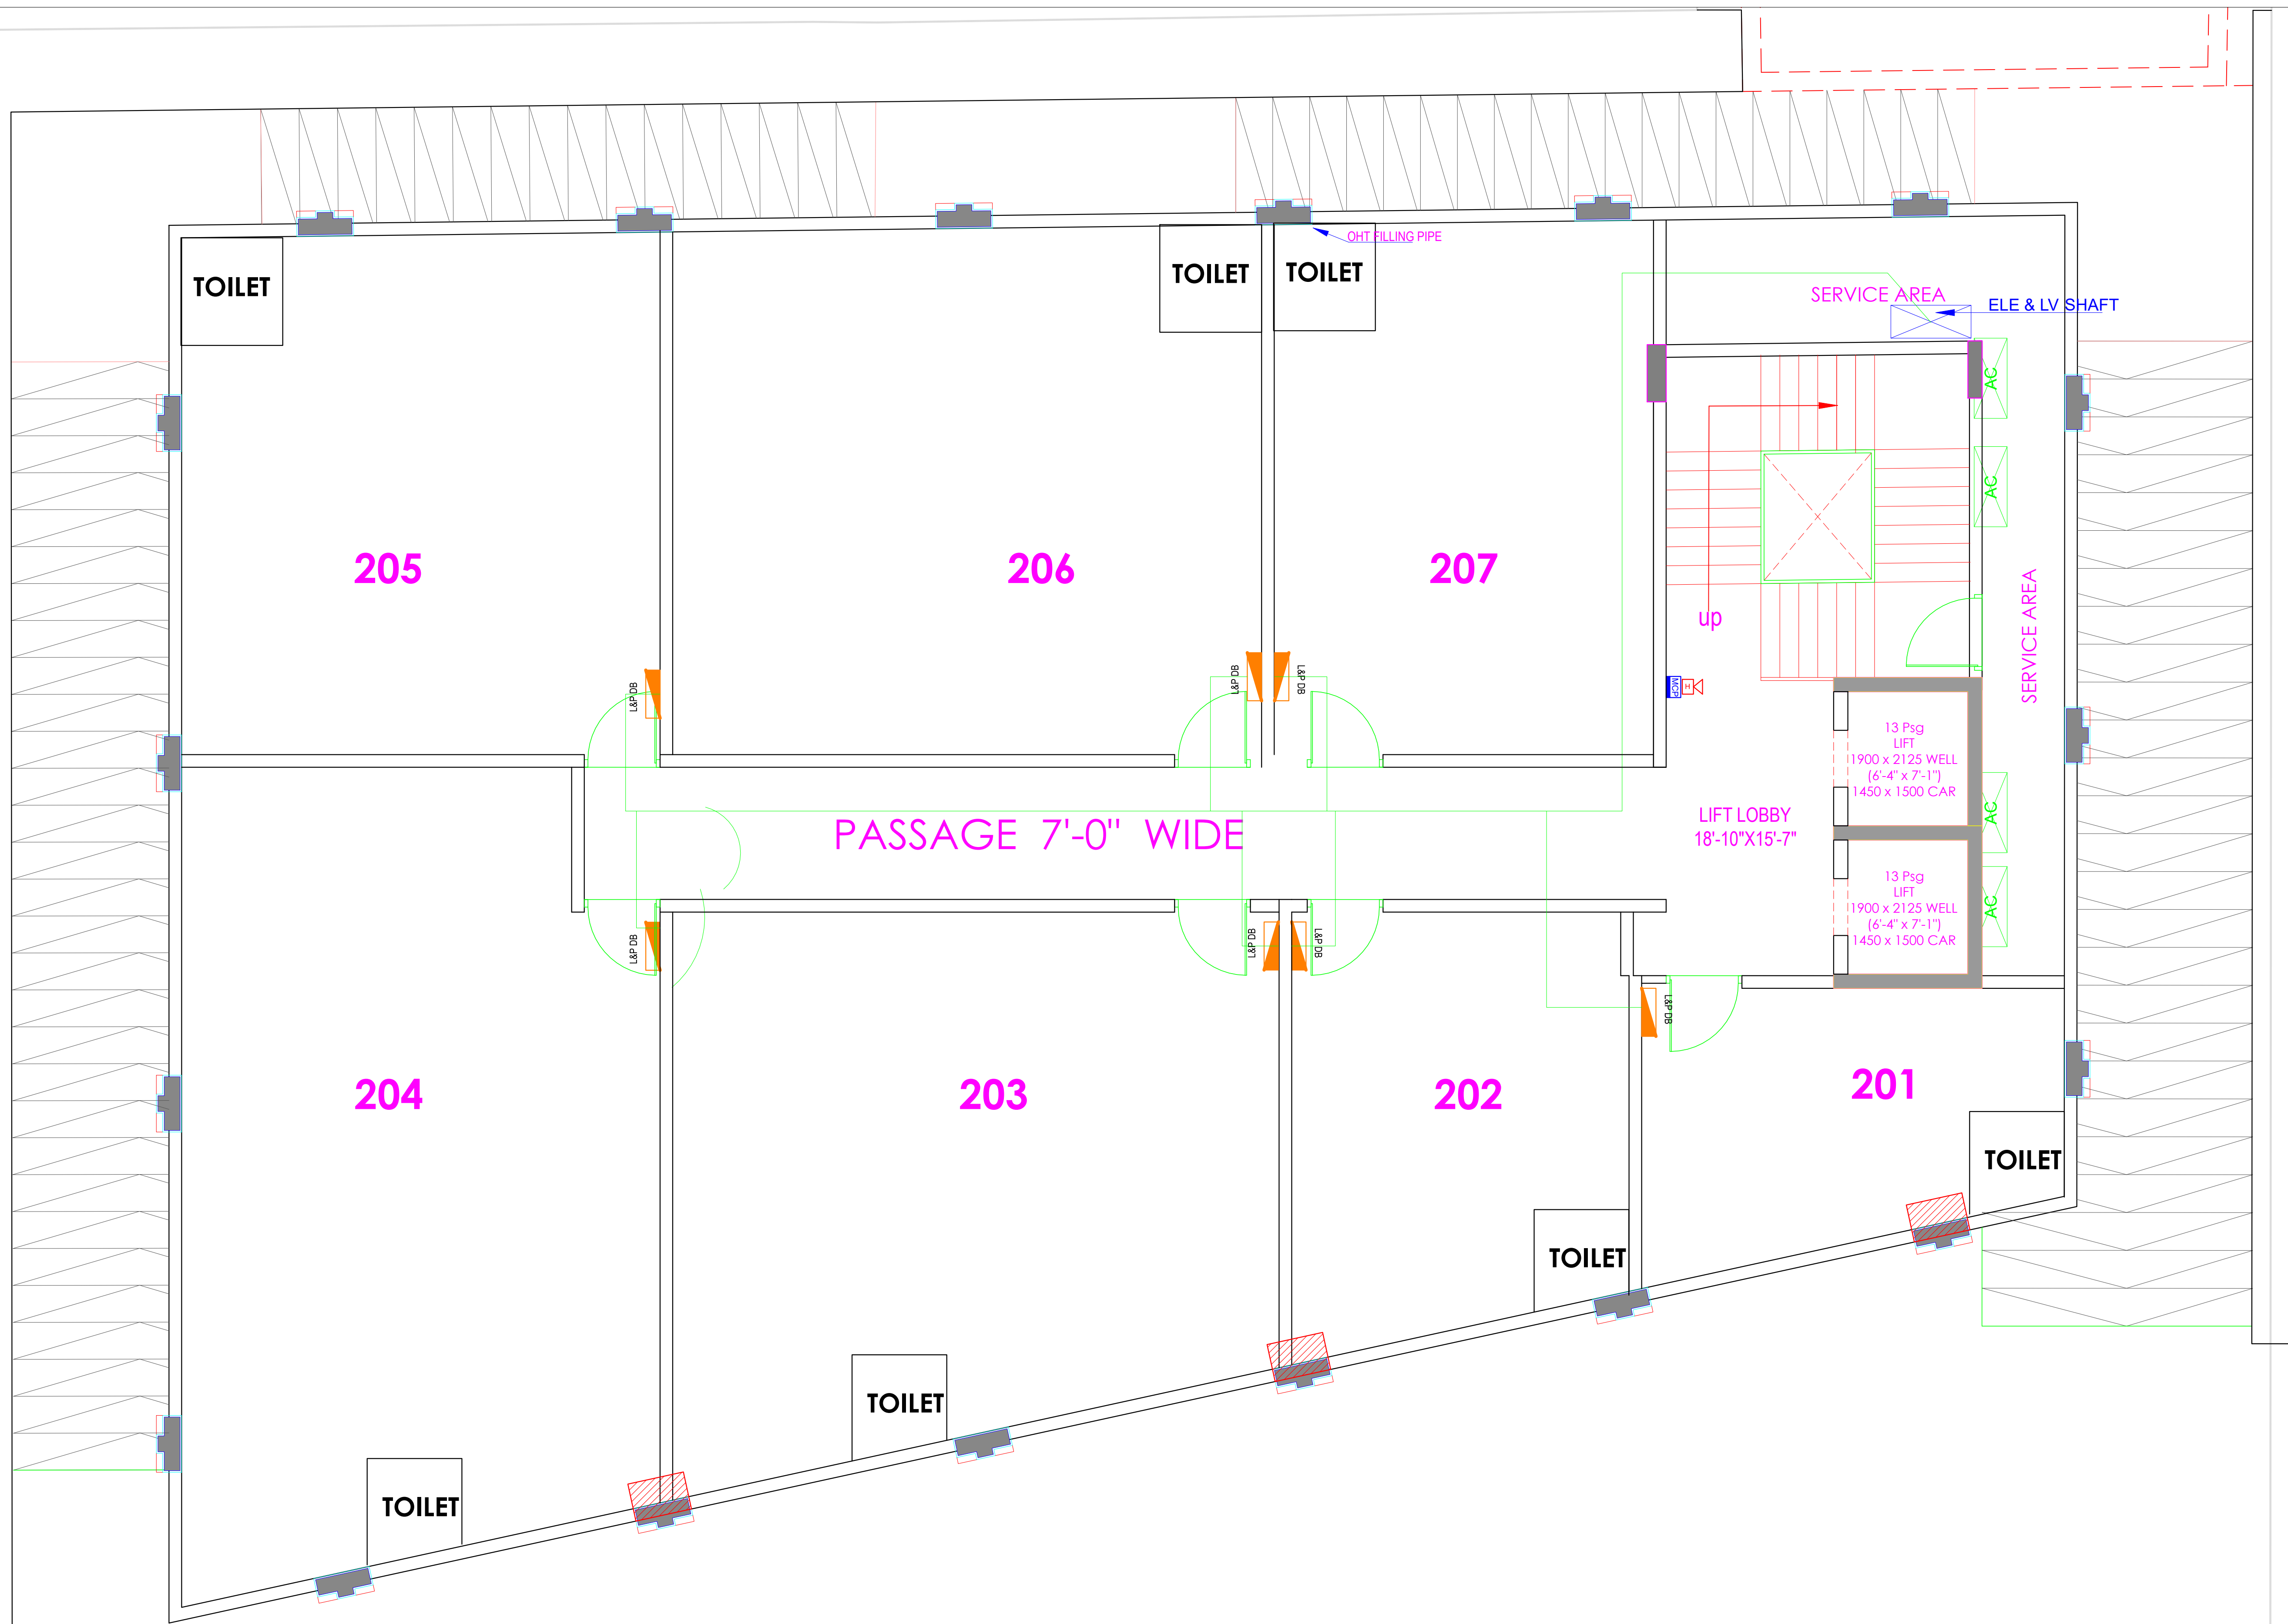

LEGEND


SYMBOL	DESCRIPTION
	MANUAL CALL POINT @4'-0"
	HOOTER @8'-0"
	Light & Power DB @5'-6"
	Conduit For Electrical Cable

REV. NO.	DESCRIPTION TO REVISION	REV. BY	DATE
-	-	-	-
-	-	-	-
ARCHITECT


GRAPHITE DESIGN STUDIO
ARCHITECTS, INTERIOR DESIGNERS, PLANNERS
68, Janak Puri - 1st, Indrawala phatak, Opp. Jain Mandir, Jaipur
CONTACT NO. +91-9929333414, 0141-2594414
email: studiographite@gmail.com
Website: www.graphitedesignstudio.com

STRUCTURAL CONSULTANT

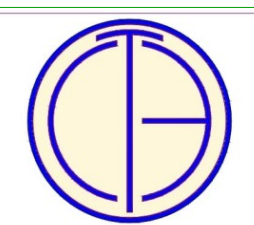
TEXEL CONSULTING ENGINEERS (P) LTD.
Plot No. 8, Block-C, Narayan Vihar,
Jaipur-302020, Rajasthan, India.
+91-9929309333, 9413811106 || www.texelgroup.com

CLIENT

BARDIYA GROUP

GRAND REPRESENTATIVE

GT BLVU

DESIGNER

**SECOND TO FOURTH FLOOR
ELECTRICAL PLAN**




DESIGN STATUS

FOR RERA SUBMISSION


VERIFICATION


SHRESHTHA
the heartbeat of your building

DEALT BY:		CHECKED BY:		DIRECTION:
DEVENDRA		SACHIN		
DRAWN NO.:	SCALE:	SHEET SIZE:	DATE:	
	NTS	A1	18.12.2024	

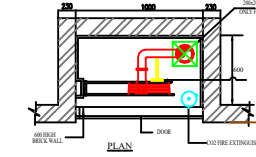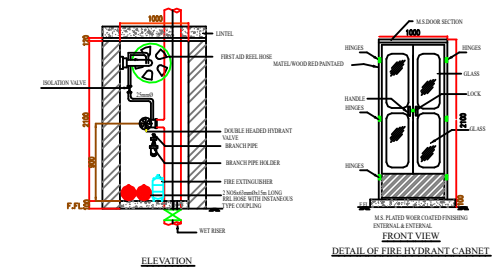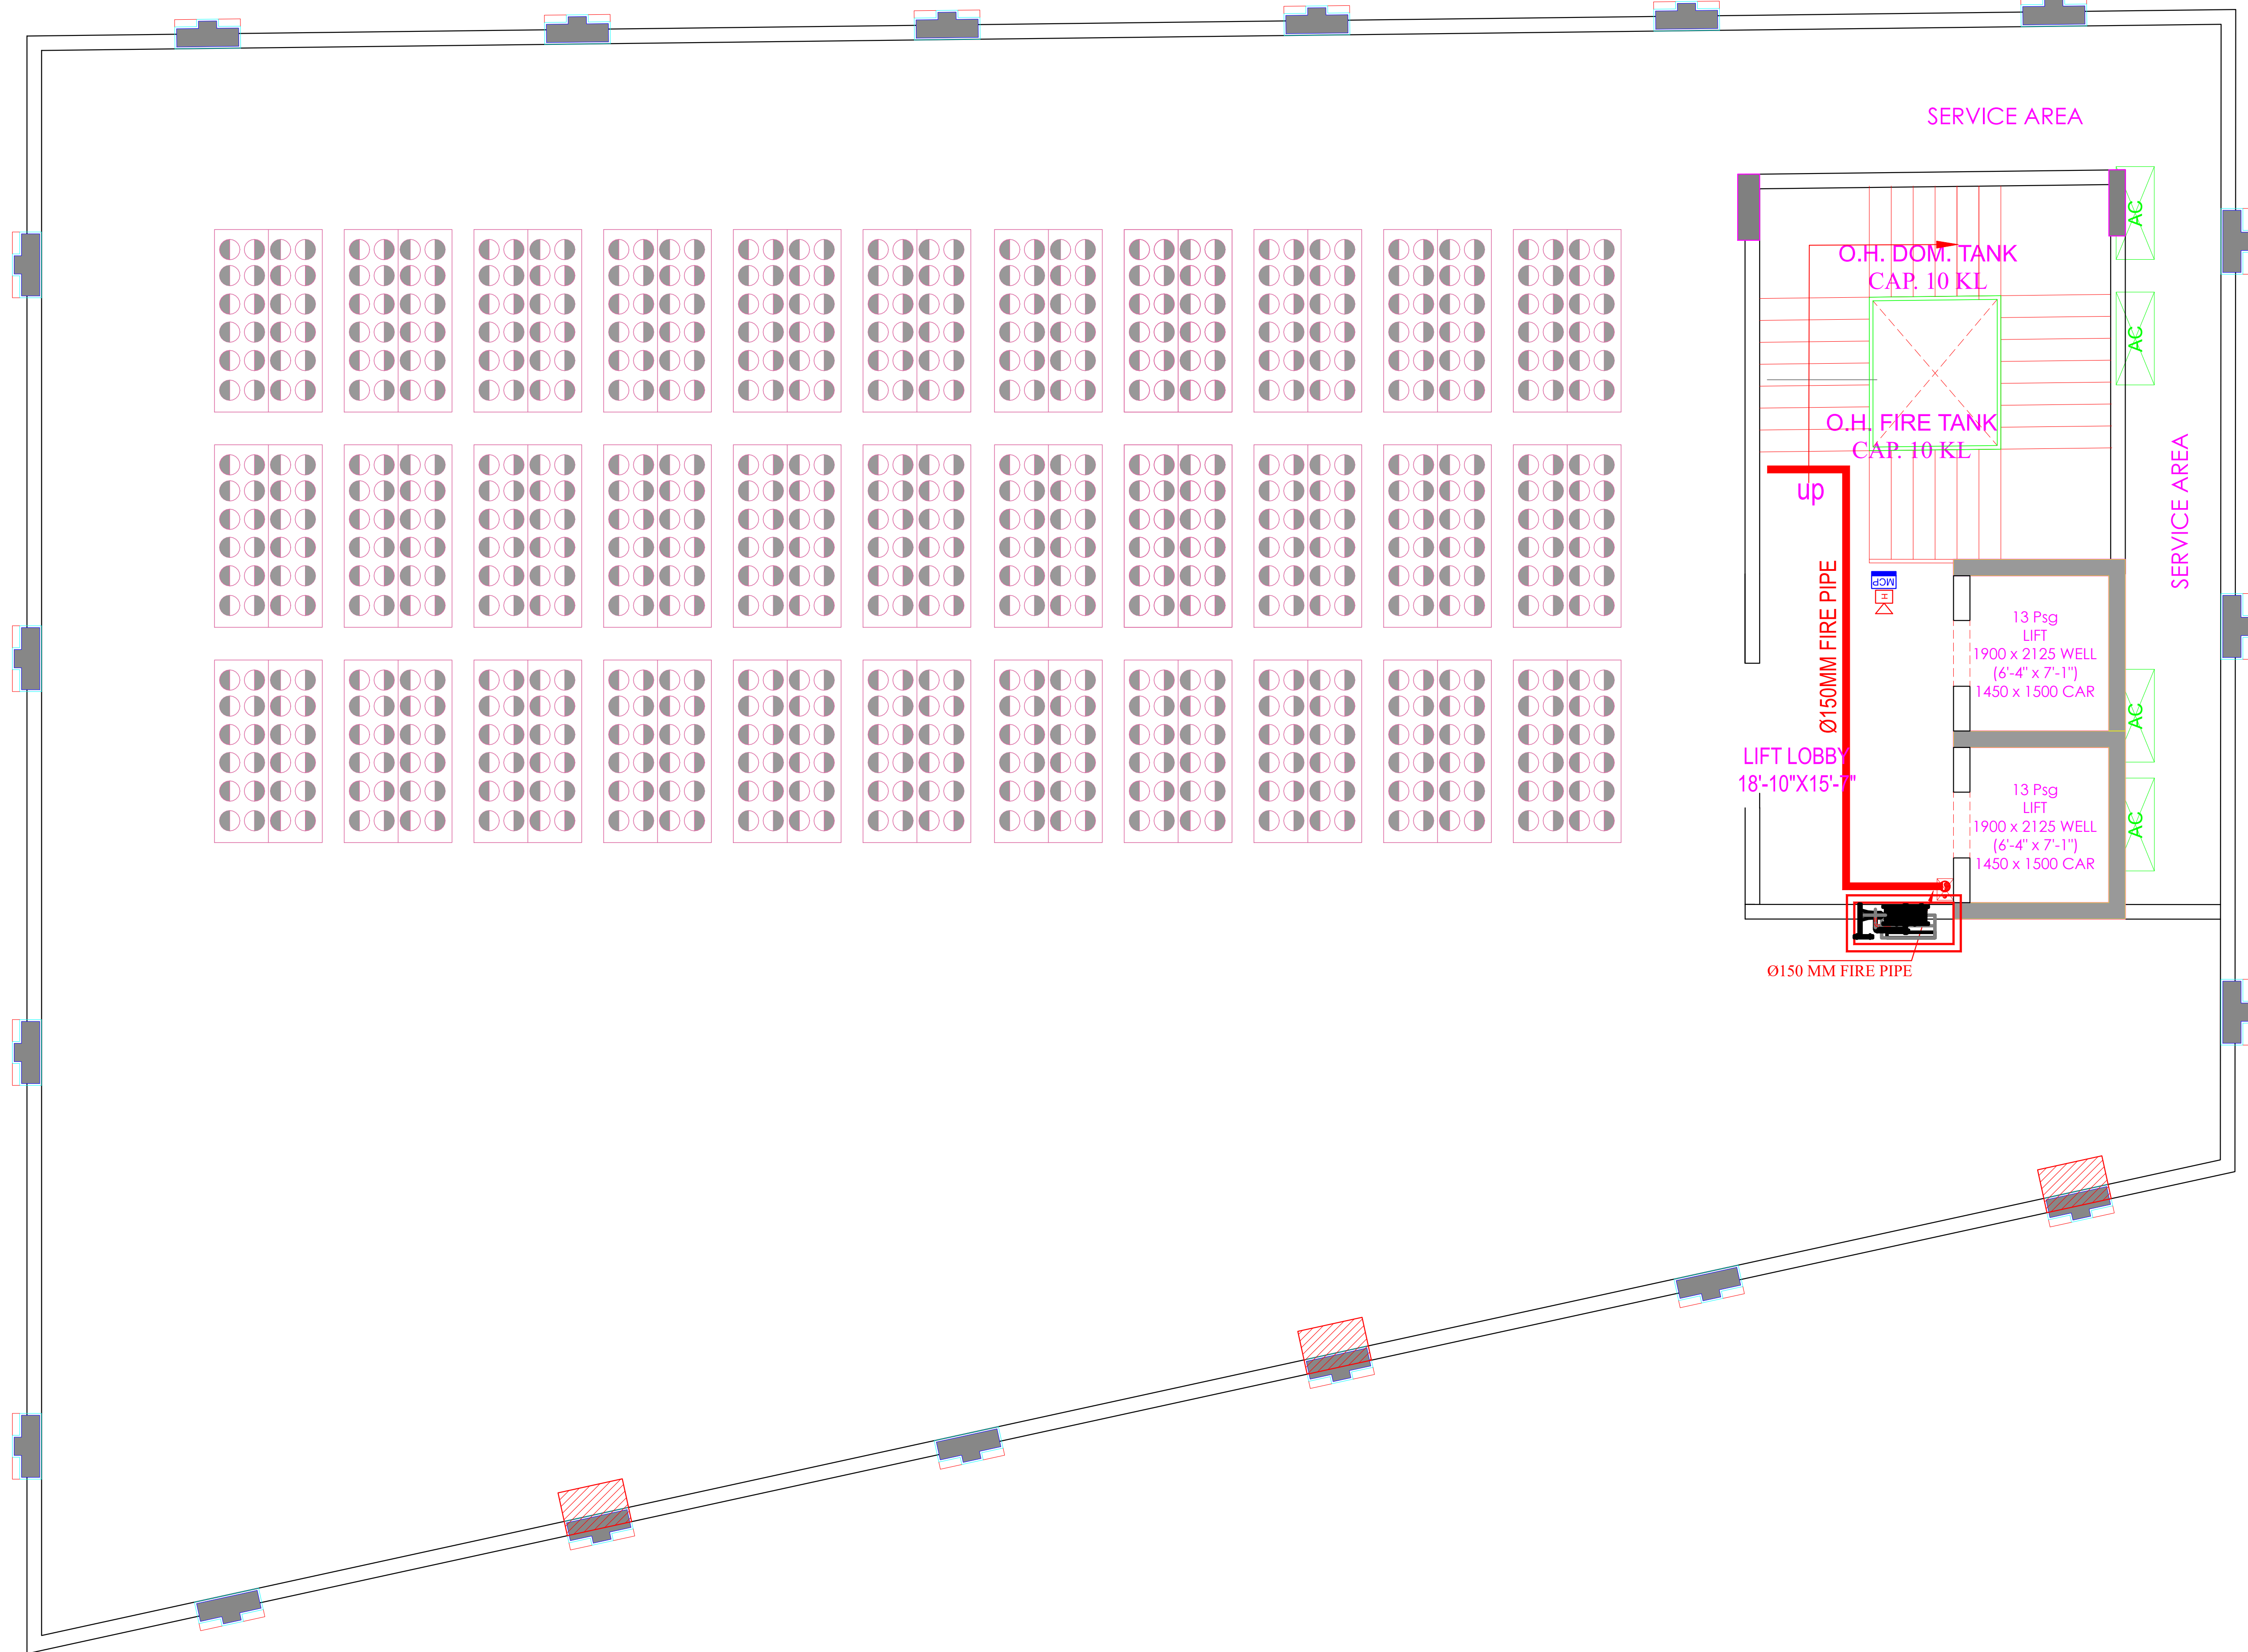

LEGEND

 SYMBOL	DESCRIPTION
	FIRE HOSE CABINET
	FIRE PIPE FOR INTERNAL FIRE HYDRANTS
	MANUAL CALL POINT @4'-0"
	HOOTER @8'-0"

REV. NO.	DESCRIPTION TO REVISION	REV. BY	DATE
-	-	-	-
-	-	-	-

ARCHITECT

GRAPHITE DESIGN STUDIO
ARCHITECTS, INTERIOR DESIGNERS, PLANNERS
66, Janak Puri - 1st, Indrawati phatak, Opp Jain Mandir, Jaipur
CONTACT NO. +91-992833414, 0141-2594414
email: studiosgraphite@gmail.com
Website : www.graphitedesignstudio.com

STRUCTURAL CONSULTANT

CLIENT
BARDIYA GROUP
REPRESENTATIVE
GT BLVU

DESIGNER
TERRACE FLOOR FIRE & ELECTRICAL PLAN
DESIGN STATUS
FOR RERA SUBMISSION

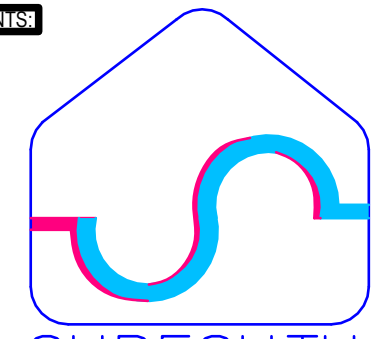VERIFICATION

SHRESHTHA
the heartbeat of your building

DEALT BY: DEVENDRA		CHECKED BY: SACHIN		DIRECTION:
DRAWN NO.: DWGNO.	SCALE: NTS	SHEET SIZE: A1	DATE: 26.11.2024	