



DOMESTIC WATER SUPPLY LEGEND -

	MUNICIPAL LINE
	DOMESTIC WATER SUPPLY
	WATER FLOW

PROJECT TITLE
PROPOSED GROUP HOUSING SCHEME AT PLOT NO. 8, KHASRA NO. 23, VILLAGE KUNHADI, TEHSIL LADPURA, DIST. KOTA, RAJASTHAN


NAME OF OWNERS
Pranay Infra Build Pvt. Ltd.
Ramesh S/o. Girraj Prasad Soodania
Director

R.K. & ASSOCIATES
PLOT NO. 19, BLOCK-18, BASEMENT LEVEL, SPRING FIELD CUSOM PARK, KOTA (RAJASTHAN)
Tel : 0129-4050009
Fax : 0129-4050009
Email : rkassociates@gmail.com

AMP CONSULTANT
Acrobat Engineers Pvt. Ltd.
H. No. 19 Block-18
Basement Level, Spring Field Cusom Park, KOTA (RAJASTHAN)
Tel : 0129-4050009
Email : acrobatengineers@gmail.com

SHEET TITLE
**RSA EXTERNAL SITE PLAN
WATER SUPPLY LAYOUT**

DATE :	31-07-2016
DEALT BY :	AMIT MAURYA
CHKD BY :	VIRENDRA
SCALE :	A1@1 : 250
DRAWING NO :	AEA/ARA/ES/PL-01b

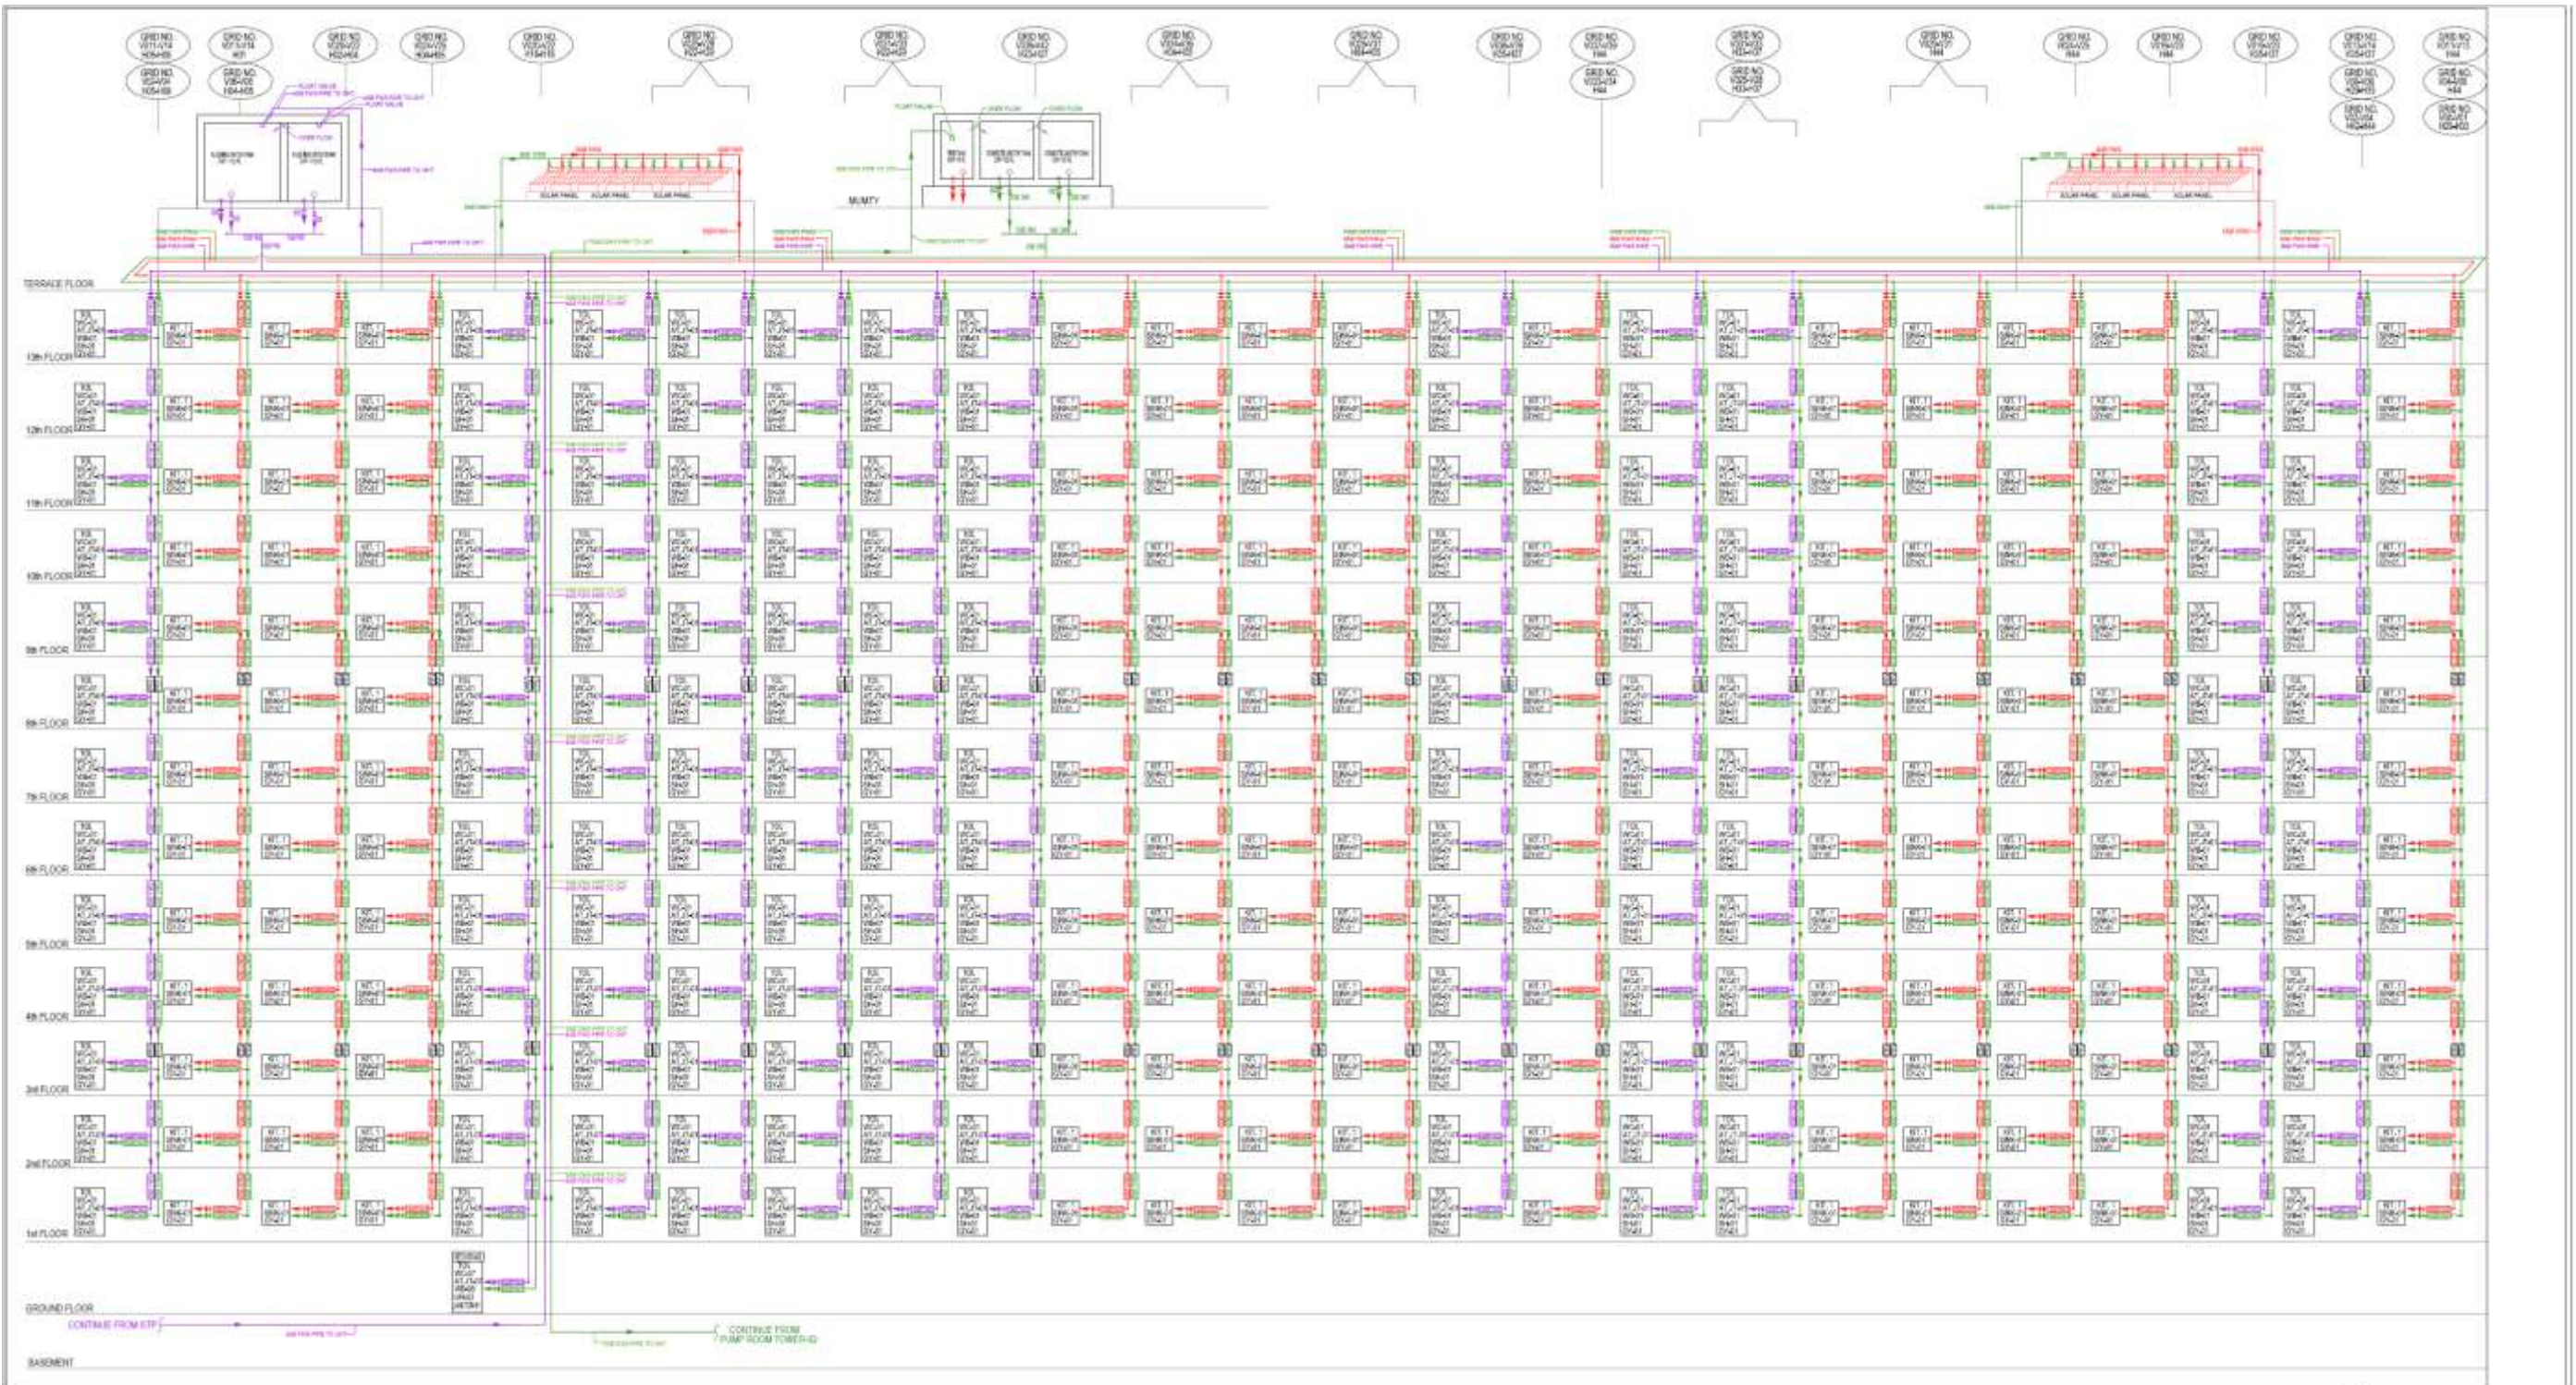

PLUMBING LEGEND

- 1- DWS - DOMESTIC WATER SUPPLY
- 2- FWS - FLUSHING WATER SUPPLY
- 3- HWS - HOT WATER SUPPLY
- 4- HDWS - HYDRO-PNEUMATIC DOMESTIC WATER SUPPLY
- 5- HDWS - HYDRO-PNEUMATIC FLUSHING WATER SUPPLY
- 6- DWS RISER PIPE
- 7- FWS RISER PIPE
- 8- HWS PIPE
- 9- HDWS PIPE
- 10- HDWS PIPE
- 11- WATER FLOW
- 12- BALL VALVE
- 13- WC - WATER CLOSET
- 14- WB - WASH BASIN
- 15- SH - SHOWER
- 16- AT - ABLUTION TAB
- 17- JT - JET CONNECTION
- 18- QY - GYSER

CLIENT -	
PROJECT -	
PROPOSED BUILDING AT PLOT NO. 123 & 4 AT OKARWA RAILWAY STATION ROAD, RAJEEV GARDH NAGAR EXT. KOTA	
WORKERS -	
R.K. & ASSOCIATES ESTABLISHED IN 1985 101, JAGDESHWAR, KOTA-324001 TEL : 074-2333333, 2333334, 2333335, 2333336 HP: 074-2333337, 2333338, 2333339	
CONSULTANTS -	
ACROBAT ENGINEERS PVT. LTD.	
R.No. 19/18, Basement Lvl.	
Spring Field Colony	
Fardabad (Haryana)	
Tel : 0129-455500	
acrobotengineers@gmail.com	
SHEET TITLE	
TOWER-1	
WATER SUPPLY SCHEMATIC DIAGRAM	
PLUMBING LAYOUT	
DRG. NO.	
AKA/RKA/T/WH/PL-06	
DATE	22-04-2017
SCALE	AS SHOWN
DRAWN BY	RAJESH K
CHECKED BY	RAJESH K