


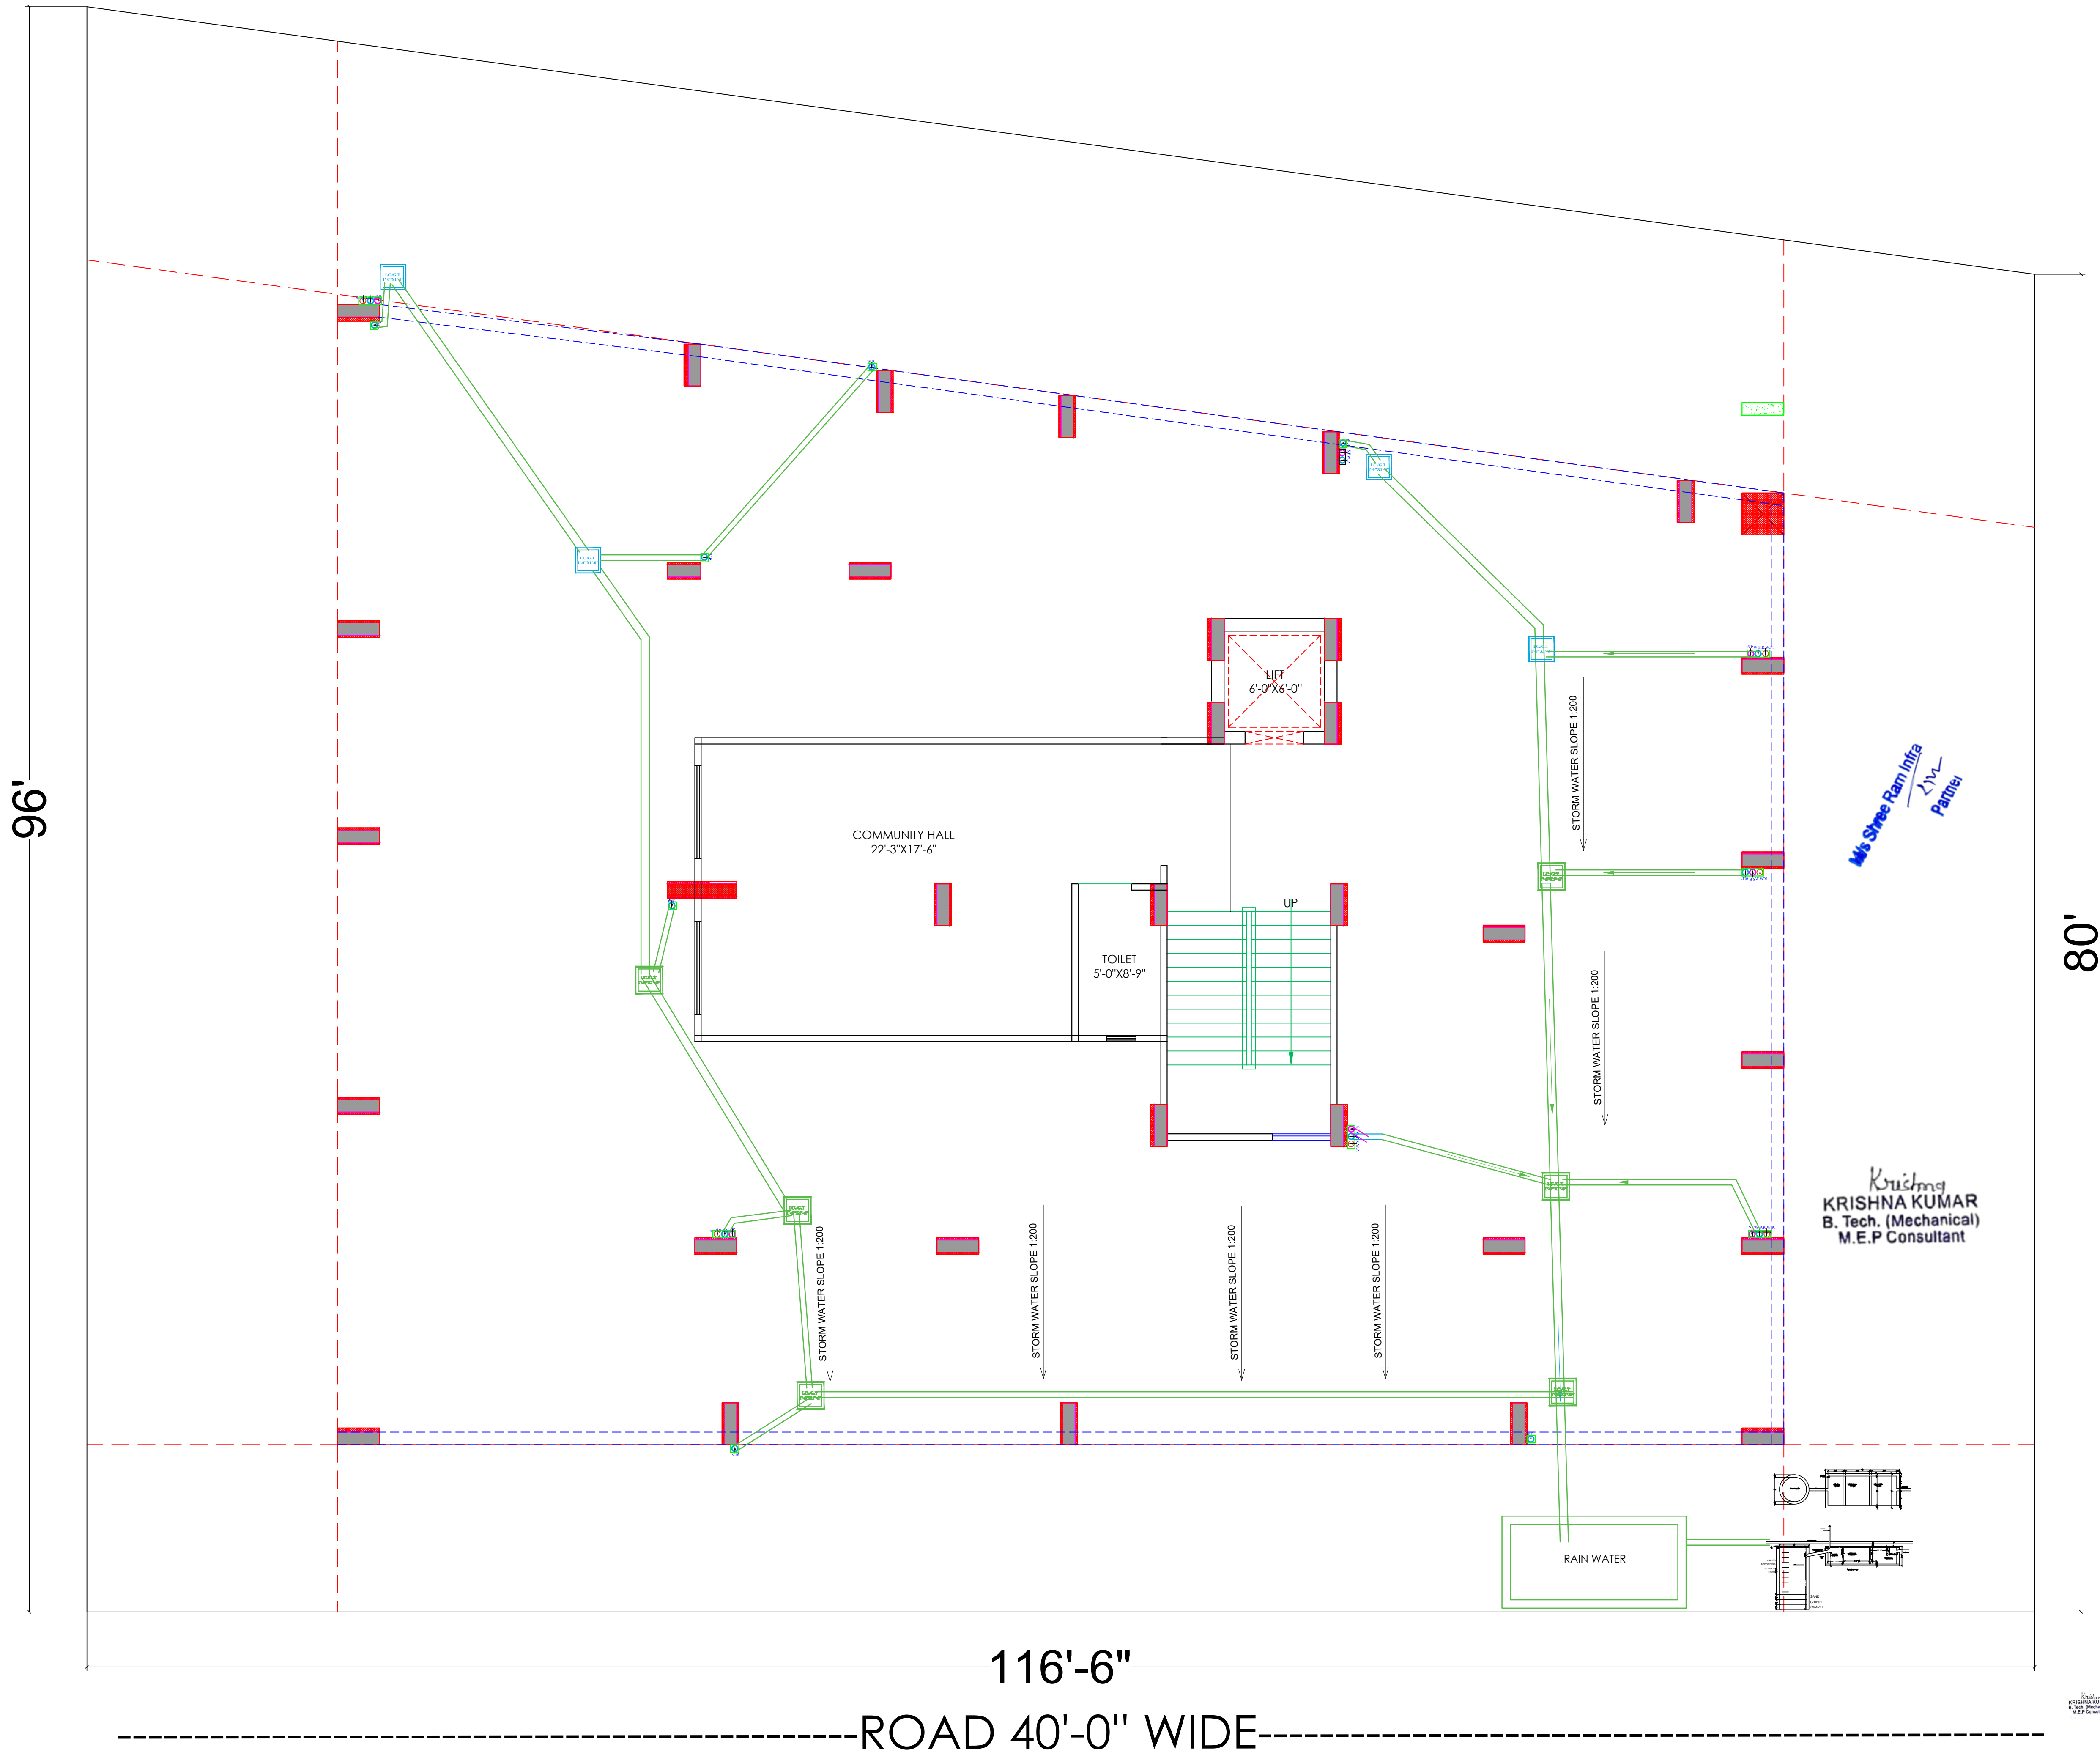

①	RAIN WATER PIPE	
②	WEST WATER PIPE	
③	SOILWATER PIPE	

LEGENDS		
S.NO.	SYMBOL	DESCRIPTION
1.		SDR-11 Fresh Water Pipe
2.		SDR-11 Solar Water Pipe
3.		Waste Water Pipe (W.P.)
4.		Soil Pipe (S.P.)
5.		Rain Water Pipe (R.W.P.)
6.		Butter Fly Valve(B.F.V.)
7.		Geyser
8.		RO
9.		Single Lever Diverter
10.		Conceled Valve
11.		Angle Valve
12.		Nahani Trap
13.		P-Trap
14.		Tap
15.		Floor Drain (F.D.)
16.		Plain Tee (P-tee)
17.		Gully Trap (G.T.)
18.		

WARNING
1. This drawing is the sole copyright of Architects **VISTAAR** and should be used for the purpose expressly issued.

GENERAL NOTES
1. All dimensions are in feets and inches.
2. Do not scale this drawing follow written dimensions only.
3. This drawing should be read in conjunction with other architectural and structural drawings.
4. Any discrepancy in the drawing should be immediately brought to the notice of architect.

PROJECT TITLE

SHREE RAM GREEN PARK
BUILDING AT PLOT-D-567,D-568,D-569
(RECONSTITUTION), JAGDAMBA NAGER-D, JAIPUR

DRAWING TITLE

STILT FLOOR PLAN
RAIN WATER HARVESTING PLAN

ARCHITECTS :
VISTAAR ARCHITECTS & PLANNERS
Architects :: Interior Designers
B-2/12, Chitrkoot scheme,
main Gandhi Path,Opp mall of jaipur,Jaipur-21
Email-Vistaararchitects.web@gmail.com
PH.- 0141-4116461,09001010366

PATH :-		NORTH
DRN.	DATE	
SACHIN	28-03-2024	
SCALE	JOB NO.	
N.T.S		