


①	RAIN WATER PIPE		
②	WEST WATER PIPE		
③	SOIL WATER PIPE		
④	INSPECTION CHAMBER / GULLY TRAP		2'6" DEPTH
⑤	MAN HOLE		2'6" DEPTH
⑥	ELECTRICAL PIPELINE		

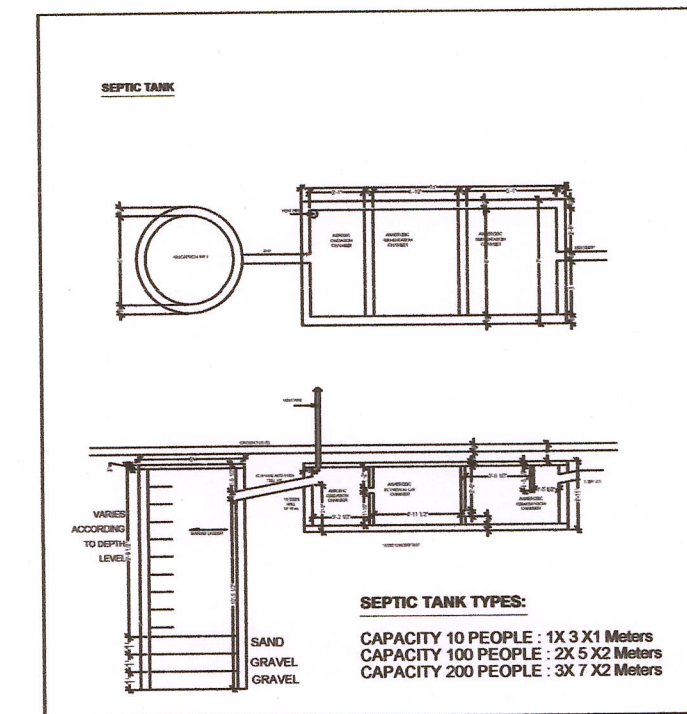

#### WARNING

1. This drawing is the sole copyright of Architects VISTAAR and should be used for the purpose expressly issued.

#### GENERAL NOTES

1. All dimensions are in feet and inches.
2. Do not scale this drawing follow written dimensions only.
3. This drawing should be read in conjunction with other architectural and structural drawings.
4. Any discrepancy in the drawing should be immediately brought to the notice of architect.

#### PROJECT TITLE

PROJECT:-  
SHREE SHYAM HOME  
BUILDING AT PLOT-637/632, &  
639/634,GANPATPURA,SANGANER  
JAIPUR

#### DRAWING TITLE

COMMON AREA WATER SUPPLY  
,SANITATION(STORM WATER  
DRAINAGE, SEWERAGE,STP,SOLID  
WATER DISPOSAL) AND  
RAIN WATER HARVESTING PLAN


#### ARCHITECTS :

VISTAAR ARCHITECTS &  
PLANNERS  
Architects :: Interior Designers  
B-2/12, Chitrkoot scheme,  
main Gandhi Path,Opp mall of jaipur,Jaipur  
PH.- 0141-4116461,09001010366

#### PATH :-

DRN	DATE	REV	NORTH
MANGU KUMAWAT	30-05-2024		
SCALE	JOB NO		
N.T.S			



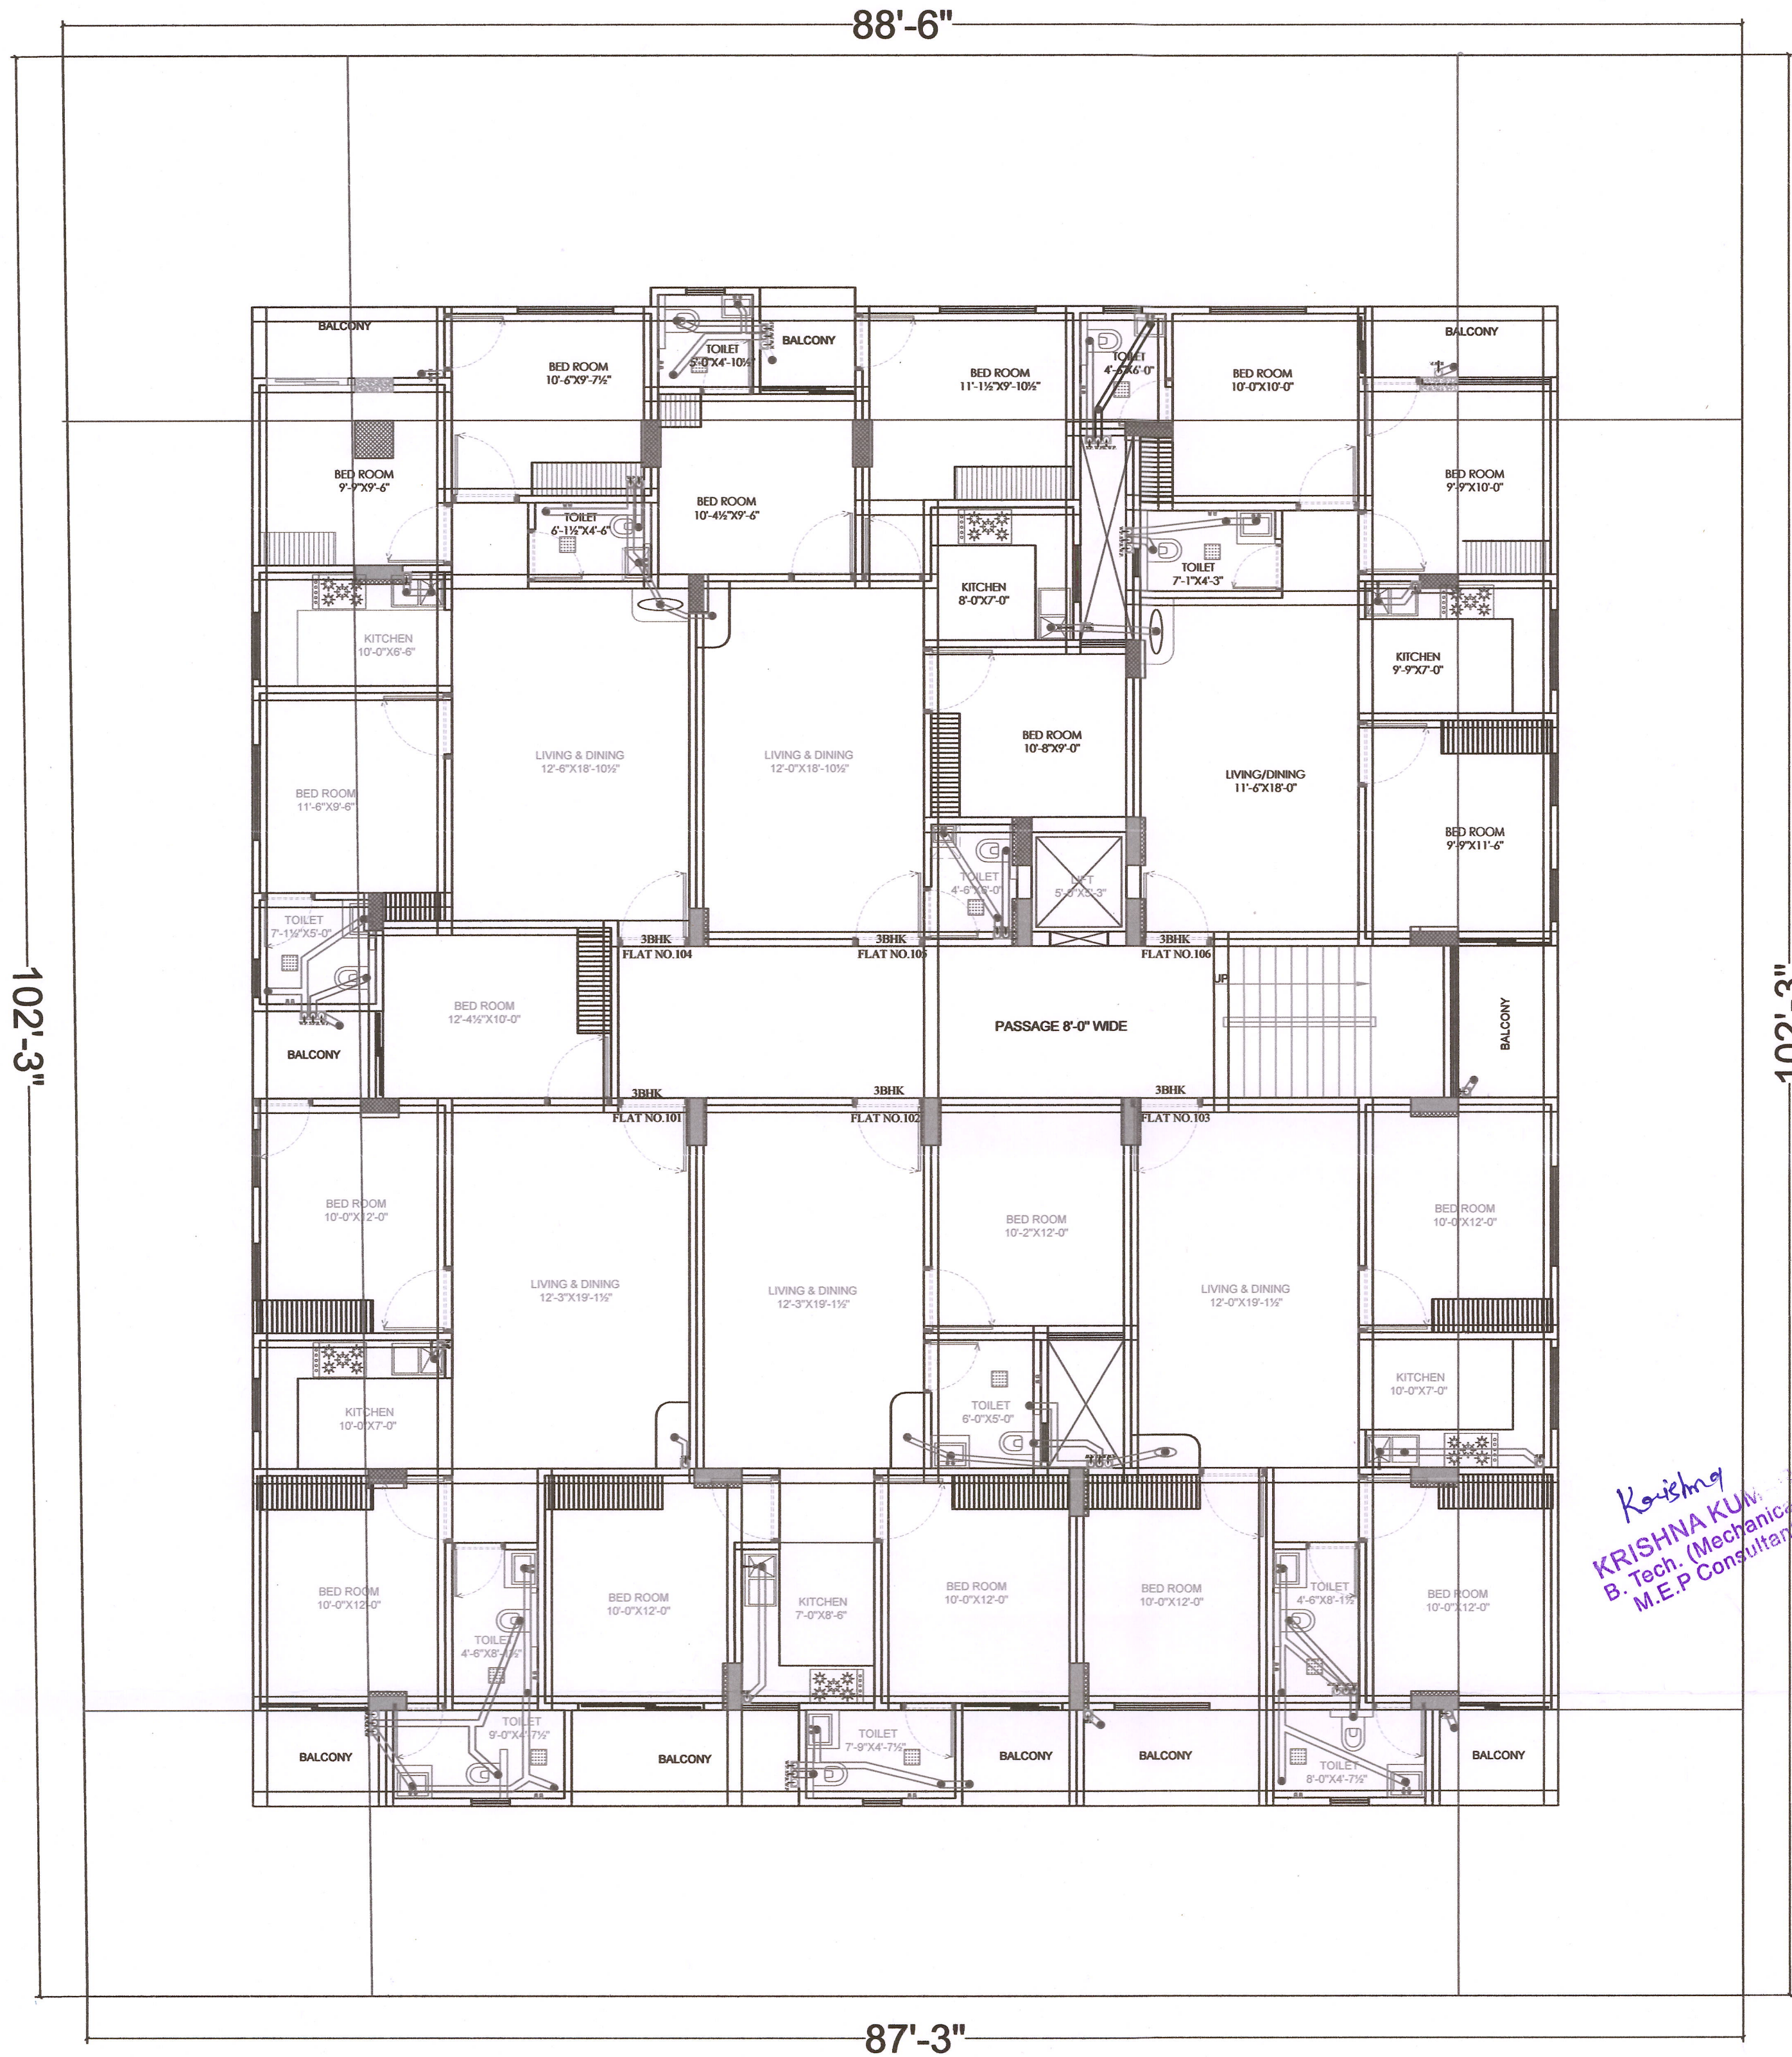

LEGENDS		
S.NO.	SYMBOL	DESCRIPTION
1.		SDR-11 Fresh Water Pipe
2.		SDR-11 Solar Water Pipe
3.		Waste Water Pipe (W.P.)
4.		Soil Pipe (S.P.)
5.		Rain Water Pipe (R.W.P.)
6.		Butter Fly Valve (B.F.V.)
7.		Geyser
8.		RO
9.		Single Lever Diverter
10.		Concealed Valve
11.		Angle Valve
12.		Nahani Trap
13.		P-Trap
14.		Tap
15.		Floor Drain (F.D.)
16.		Plain Tee (P-tee)
17.		Gully Trap (G.T.)
18.		

KRISHNA KUMAR  
B. Tech. (Mechanical)  
M.E.P Consultant

#### WARNING

1. This drawing is the sole copyright of Architects VISTAAR and should be used for the purpose expressly issued.

#### GENERAL NOTES

1. All dimensions are in feet and inches.
2. Do not scale this drawing follow written dimensions only.
3. This drawing should be read in conjunction with other architectural and structural drawings.
4. Any discrepancy in the drawing should be immediately brought to the notice of architect.

#### PROJECT TITLE

PROJECT:-  
SHREE SHYAM HOME  
BUILDING AT PLOT-637/632, &  
639/634, GANPATPURA, SANGANER  
JAIPUR


#### DRAWING TITLE

TYPICAL FLOOR DRAINAGE PLAN


#### ARCHITECTS:

VISTAAR ARCHITECTS &  
PLANNERS  
Architects :: Interior Designers  
B-2/12, Chitrkoot scheme,  
main Gandhi Path, Opp mall of jaipur, Jaipur  
PH. - 0141-4116461, 09001010366

PRJ. NO.	DATE	REV.	NORTH
DRN	30-05-2024		
MANUJ KUMAR			
SCALE	JOB NO.		
N.T.S			

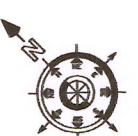



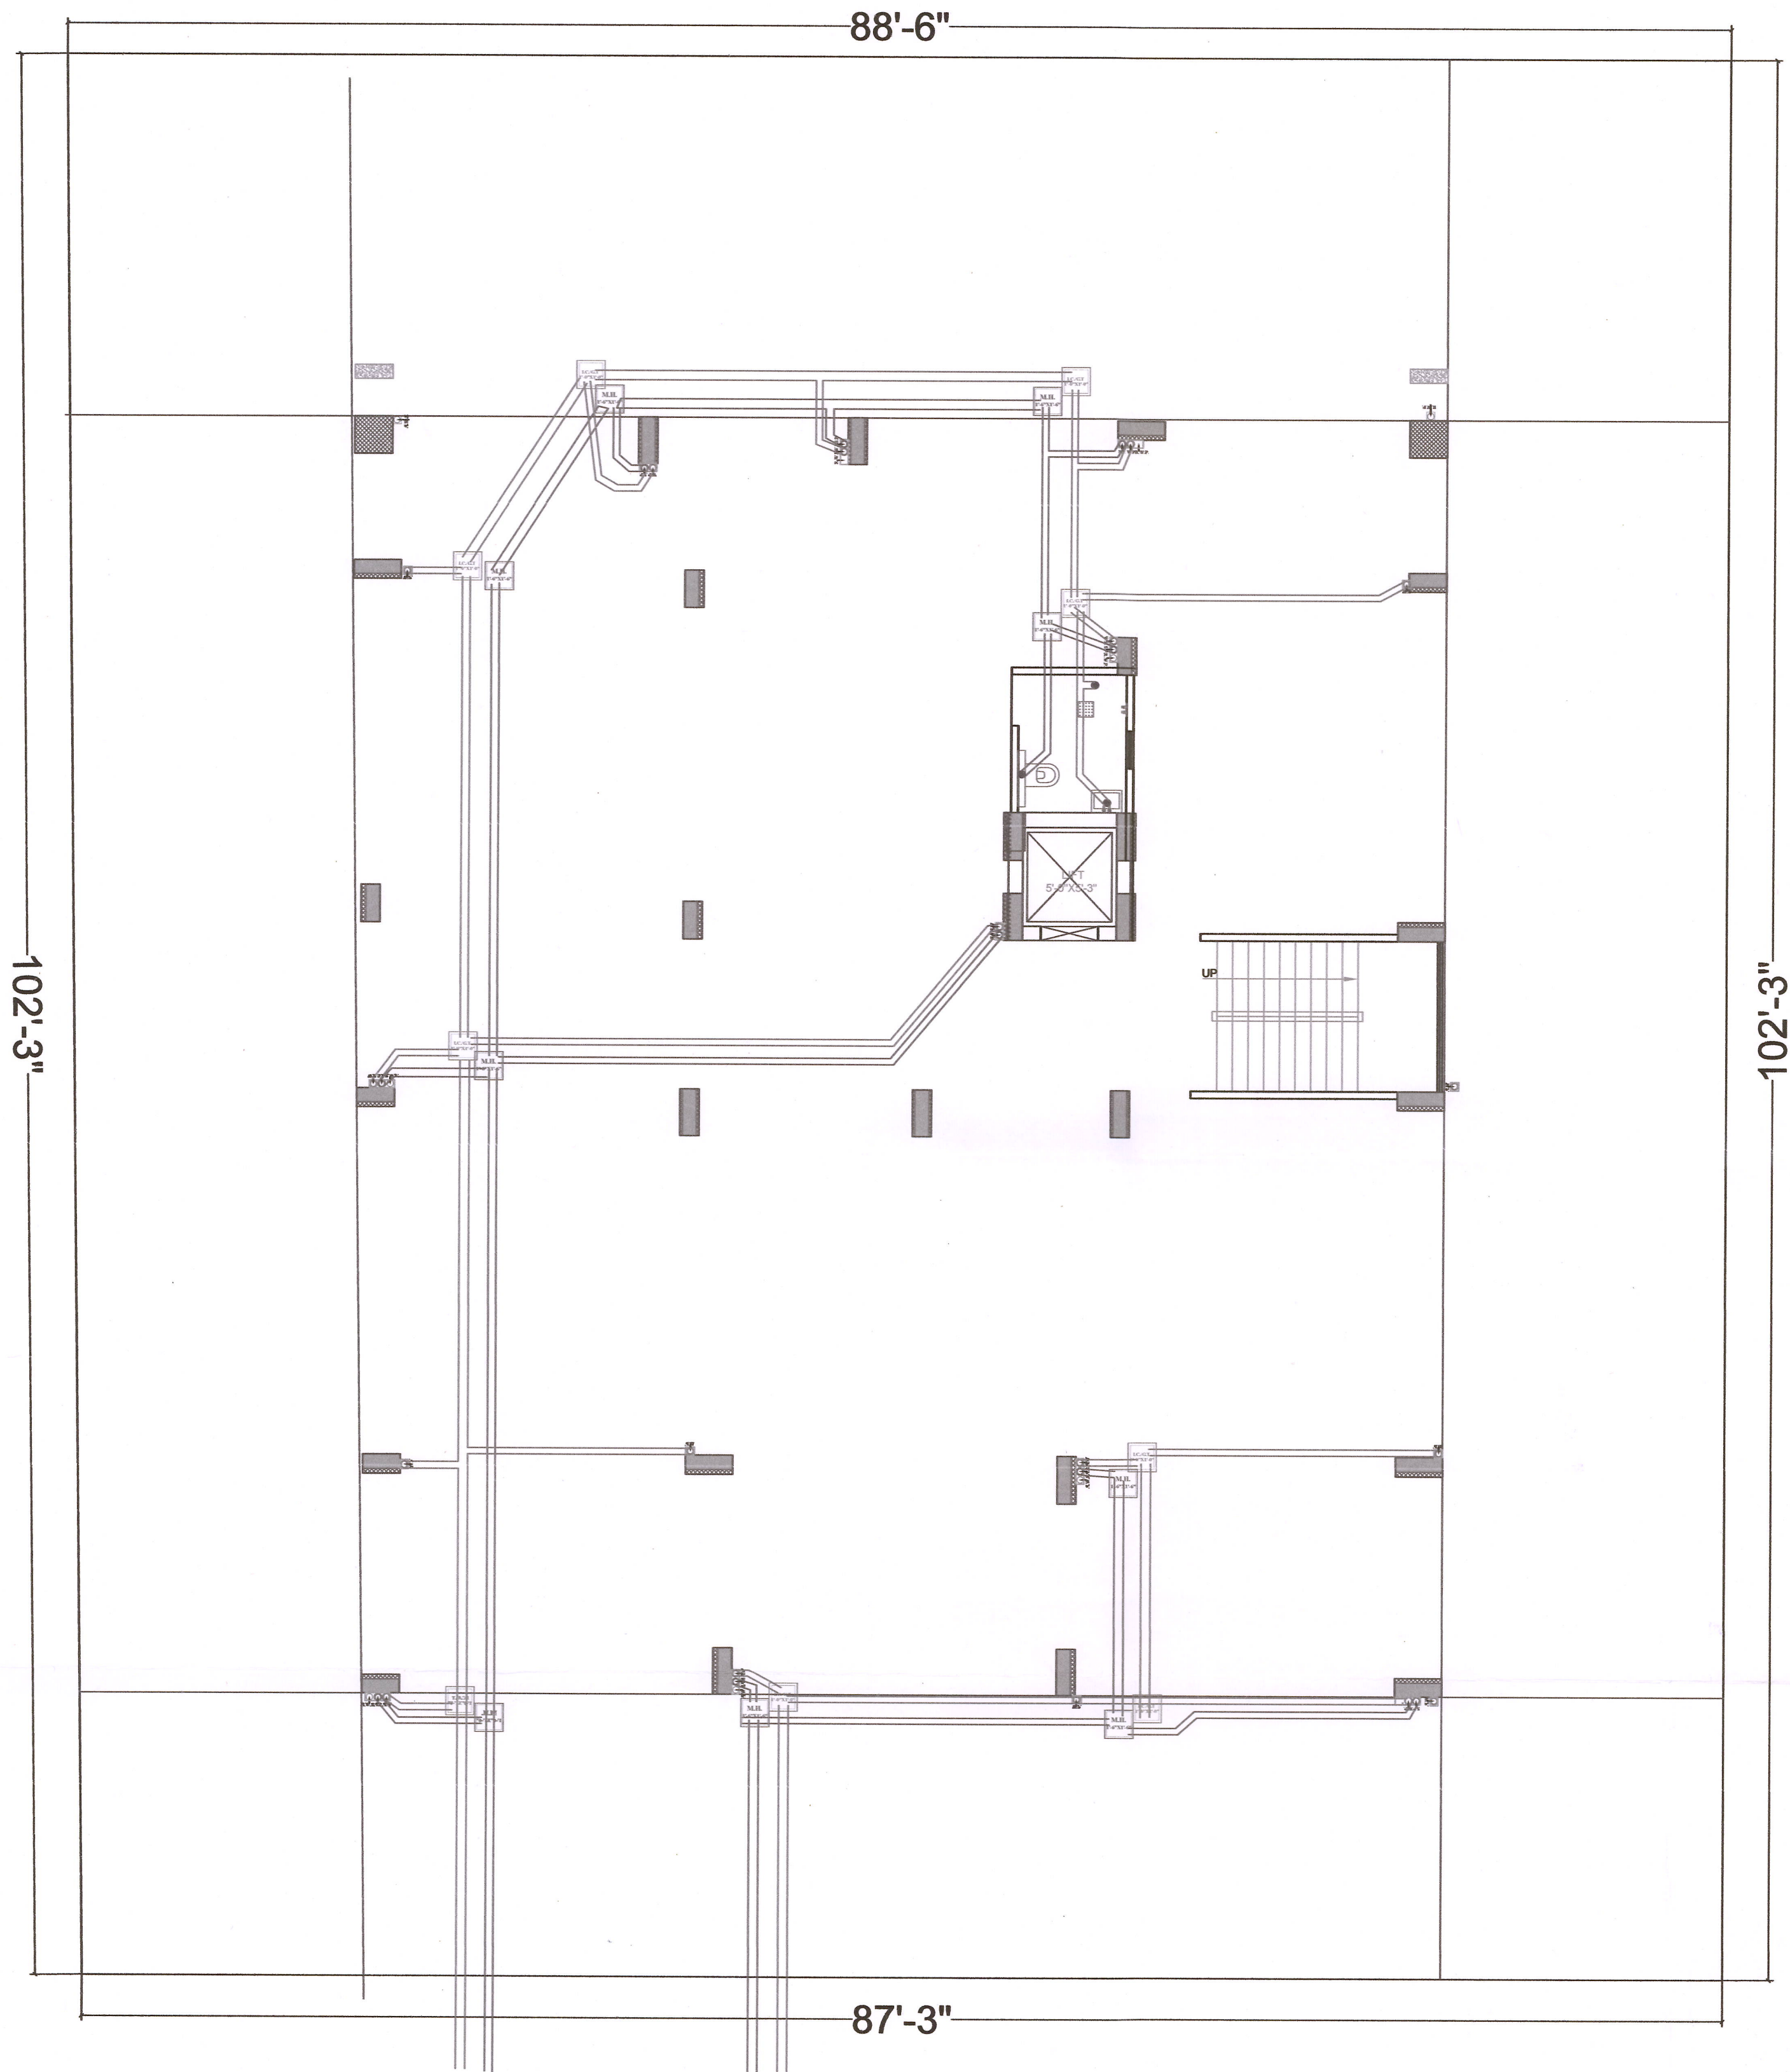

LEGENDS		
S.NO.	SYMBOL	DESCRIPTION
1.		SDR-11 Fresh Water Pipe
2.		SDR-11 Solar Water Pipe
3.		Waste Water Pipe (W.P.)
4.		Soil Pipe (S.P.)
5.		Rain Water Pipe (R.W.P.)
6.		Butter Fly Valve(B.F.V.)
7.		Geyser
8.		RO
9.		Single Lever Diverter
10.		Concealed Valve
11.		Angle Valve
12.		Nahani Trap
13.		P-Trap
14.		Tap
15.		Floor Drain (F.D.)
16.		Plain Tee (P-tee)
17.		Gully Trap (G.T.)
18.		

Krishna  
KRISHNA KUMAR  
B. Tech. (Mechanical)  
M.E.P Consultant

WARNING

1. This drawing is the sole copyright of Architects VISTAAR and should be used for the purpose expressly issued.

GENERAL NOTES

1. All dimensions are in feet and inches.
2. Do not scale this drawing follow written dimensions only.
3. This drawing should be read in conjunction with other architectural and structural drawings.
4. Any discrepancy in the drawing should be immediately brought to the notice of architect.

PROJECT TITLE

PROJECT:-  
SHREE SHYAM HOME  
BUILDING AT PLOT-637/632, &  
639/634, GANPATPURA, SANGANER  
JAIPUR

DRAWING TITLE

STILT FLOOR DRAINAGE PLAN

ARCHITECTS :

VISTAAR ARCHITECTS &  
PLANNERS  
Architects :: Interior Designers  
B-2/12, Chitrkoot scheme,  
main Gandhi Path, Opp mall of jaipur, Jaipur  
PH.- 0141-4116461, 09001010366

DATE		REV.	NORTH
DRN.	30-05-2024		
SCALE	JOB NO.		
N.T.S			

