



ASHAPURNA MOHANBAGH X KHASRA NO. 263

EXTERNAL SEWERAGE DRAWING

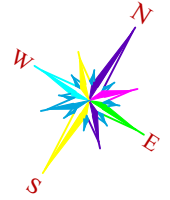

SCALE :- 1" = 50'

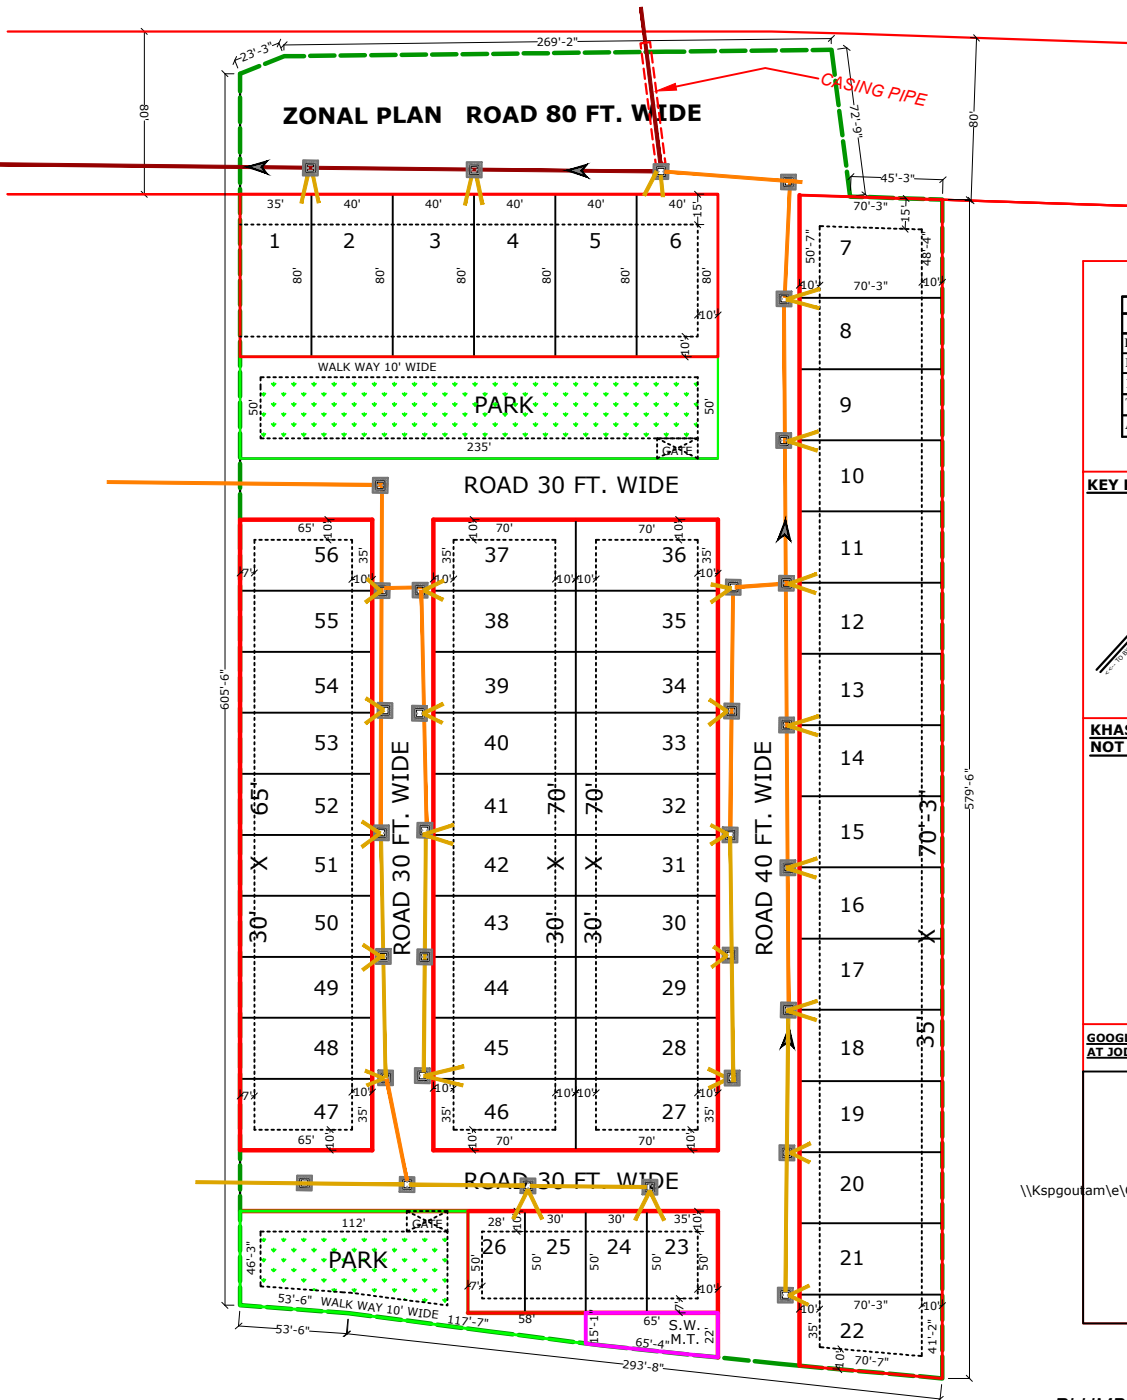


LAND USES ANALYSIS


PLOTS	AREA in Sq.yd.	AREA OF %
PLOT AREA	14343.80	59.99 %
PARK AREA	2016.99	08.44 %
M.T./S.W.D. AREA	134.43	00.56 %
ROAD AREA	7414.38	31.01 %
TOTAL SCHEME AREA	23909.60	100.00 %

Area in Bigha = 12 Bigha, 7 Bishwa


KEY PLAN

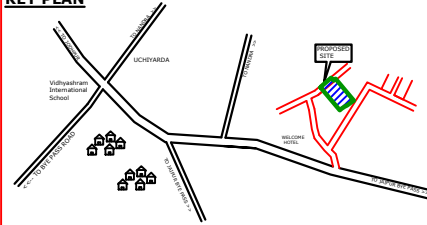

KHASRA MAP NOT TO SCALE

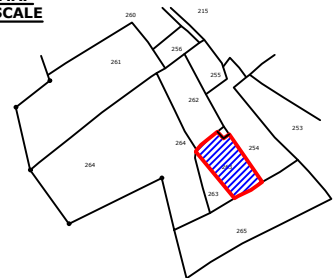

GOOGLE MAP OF KHASRA NO. 263 OF VILLAGE NANDRA KALLAN AT JODHPUR

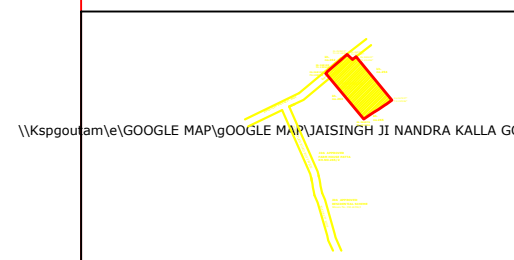

PLUMBING DETAILS

- 6"Ø R.C.C. OR FORM CORE PIPE
- 9"Ø R.C.C. OR FORM CORE PIPE
- 12"Ø R.C.C. OR FORM CORE PIPE
- INSPECTION CHAMBER
SIZE: 24" X 30" X AS DEPTH
- MANHOLE CHAMBER
SIZE: 30" X 36" X AS DEPTH

PLOT NO. 1 TO 56
ASHAPURNA MOHANBAGH X
KHARA NO. 263 OF VILLAGE
NANDRA KALLAN
AT JODHPUR

Gaurav Joshi
GAURAV JOSHI
CIVIL ENGINEER

12, Near Maheshwari Nayati Nohra
Masuriya, Jodhpur

NOTE : THAT THIS PLAN IS ONLY TENTATIVE
SOME CHANGES MIGHT HAPPEN AS PER SITE
CONDITION