


PROPOSED LAY-OUT PLAN OF RESIDENTIAL COLONY

HAPPY AEROCITY


KHASRA NO 731/224 = 11485.75 SQ MTR.
KHASRA NO 722/404 = 8090.00 SQ MTR.
AT VILLAGE :- FARASIYA, TEH.- KISHANGARH , DIST. AJMER

ELECTRICAL LAYOUT PLAN

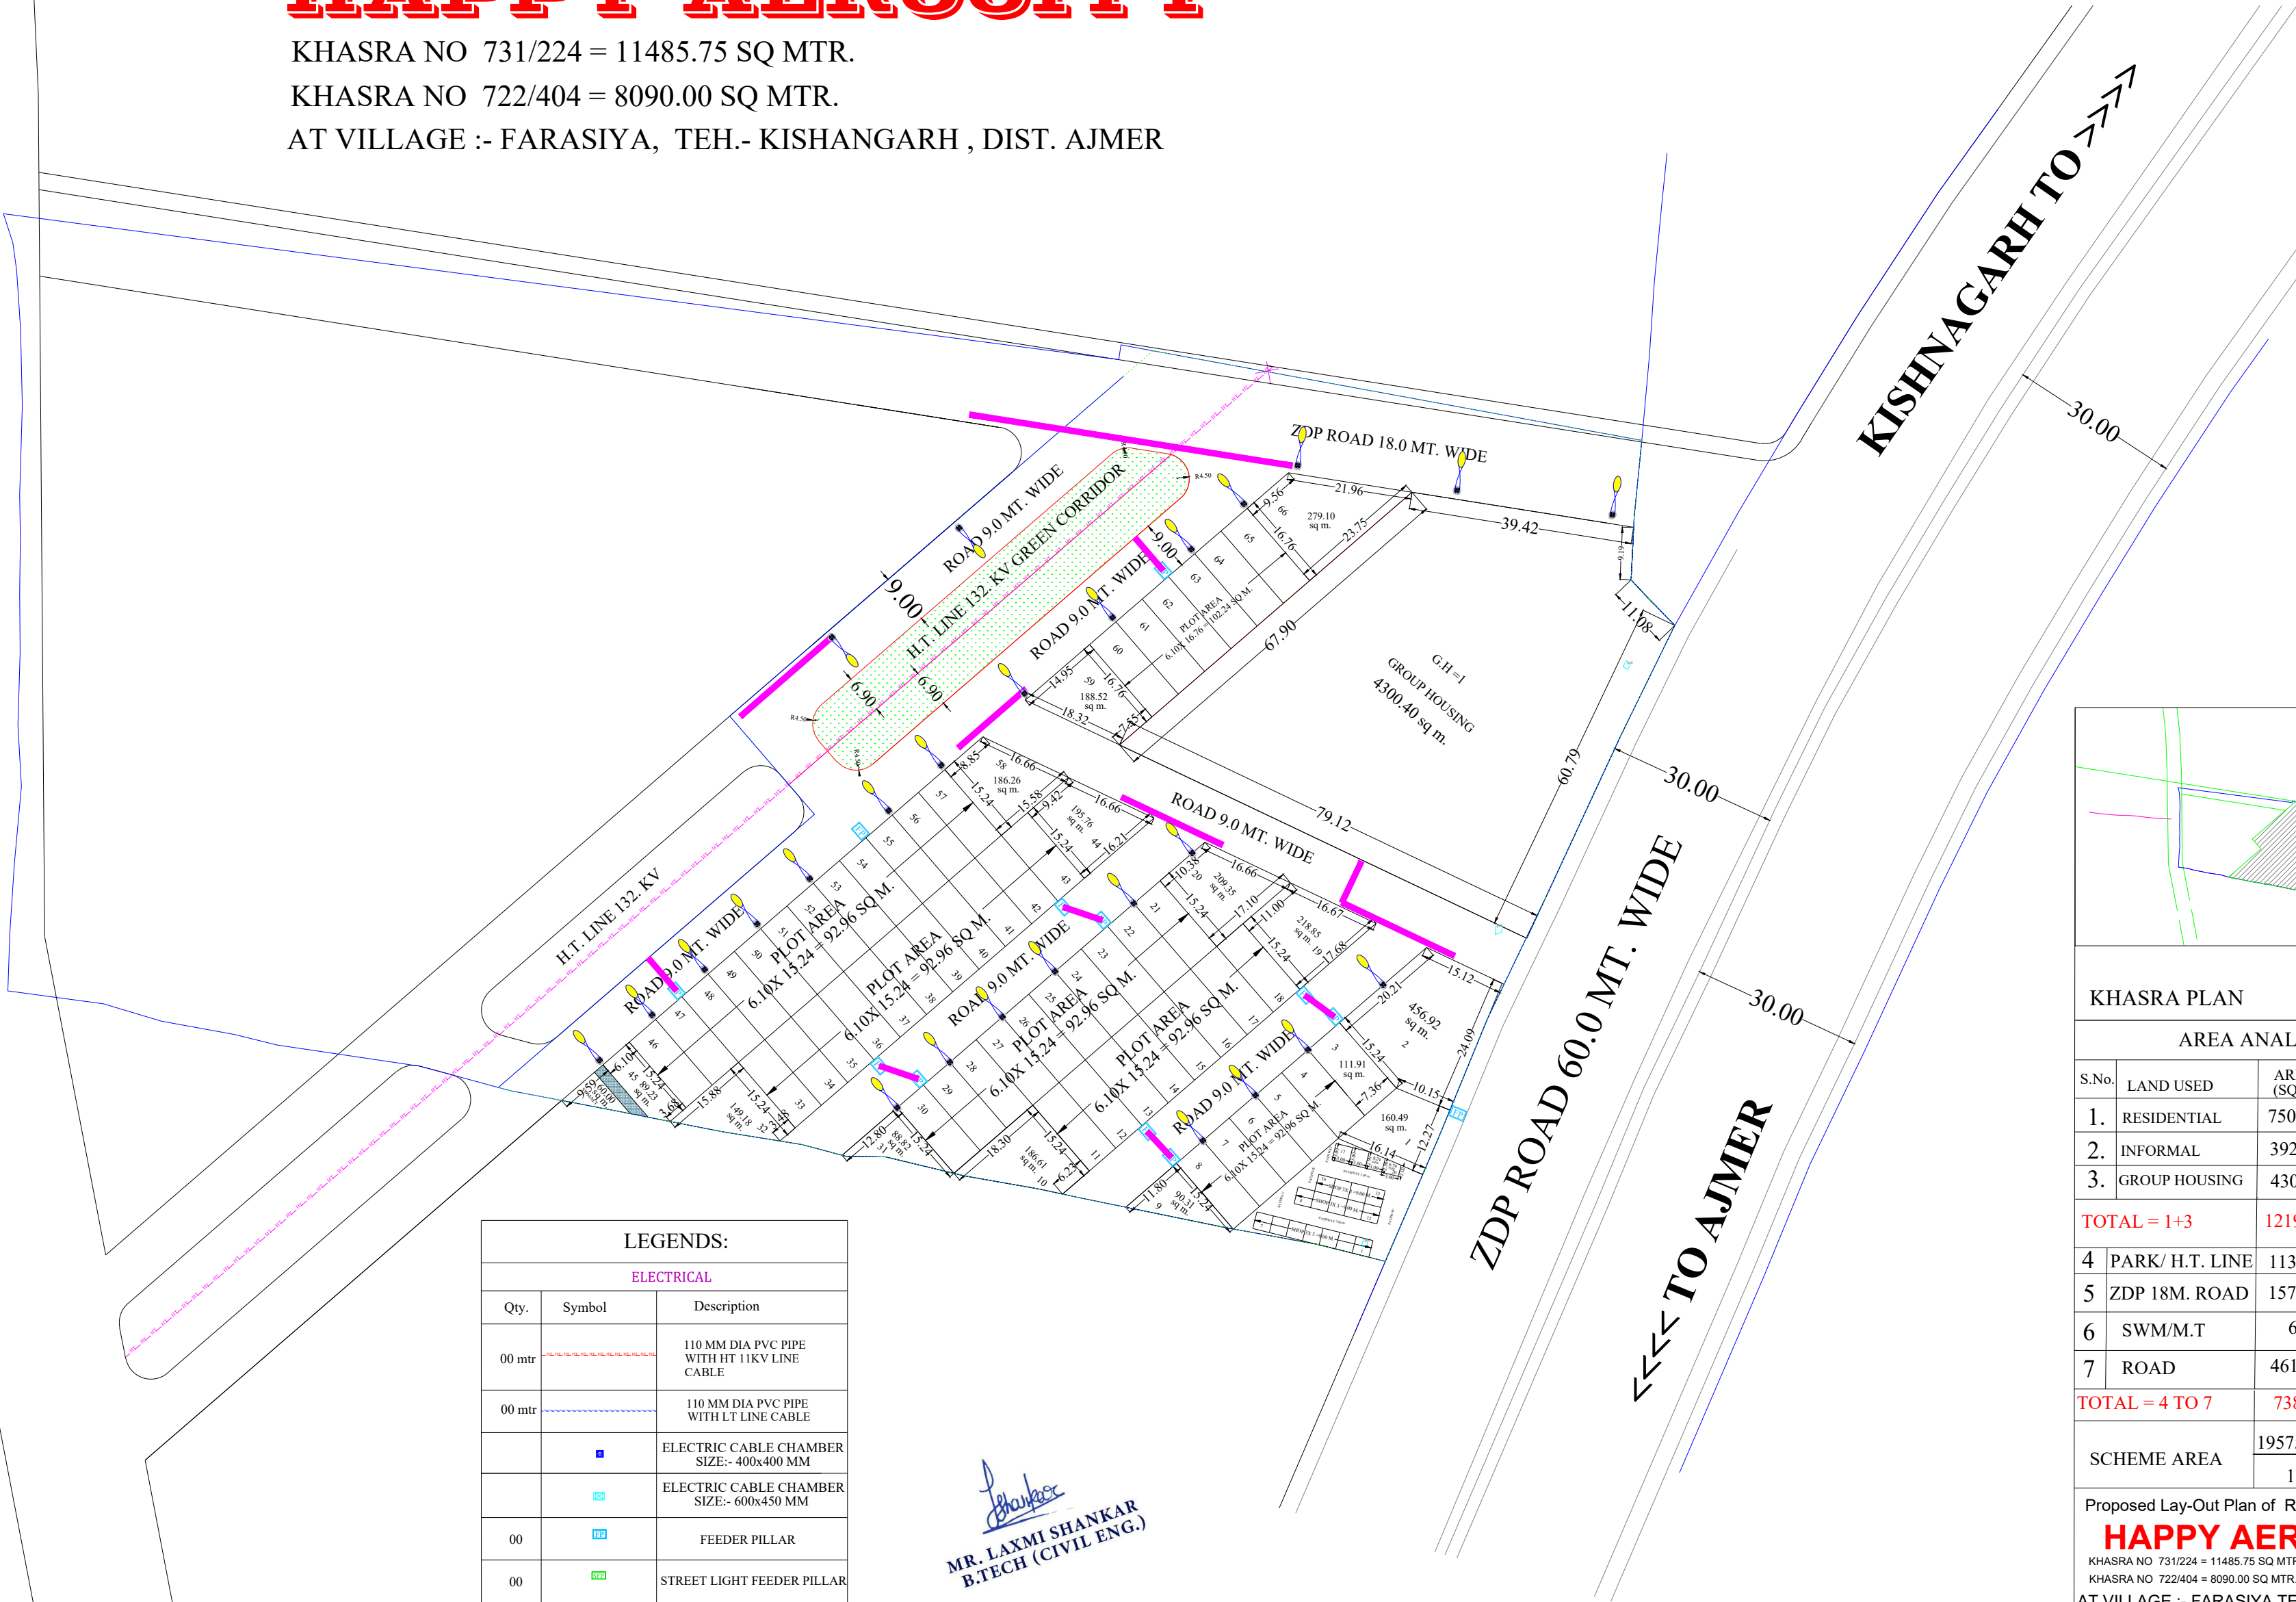

LEGENDS:		
ELECTRICAL		
Qty.	Symbol	Description
00 mtr		110 MM DIA PVC PIPE WITH HT 11KV LINE CABLE
00 mtr		110 MM DIA PVC PIPE WITH LT LINE CABLE
		ELECTRIC CABLE CHAMBER SIZE:- 400x400 MM
		ELECTRIC CABLE CHAMBER SIZE:- 600x450 MM
00		FEEDER PILLAR
00		STREET LIGHT FEEDER PILLAR
00 Nos		11/0.433KV, 2x100 + 1x160 KVA TRANSFORMER ON 4-POLE STRUCTURE WITH 3WAY RMU
00 Nos		STREET LIGHT SINGLE ARM
00 Nos		11/0.433KV, EXTRA 4-POLE STRUCTURE

MR. LAXMI SHANKAR
B.TECH (CIVIL ENG.)

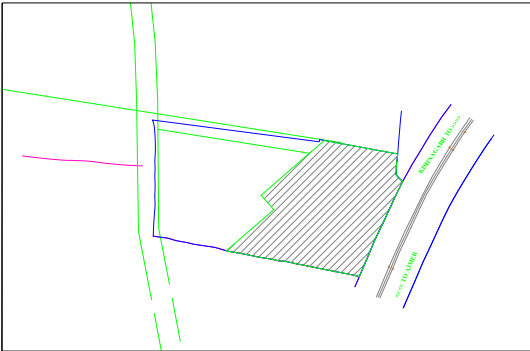

KHASRA PLAN			
AREA ANALYSIS :-			
S.No.	LAND USED	AREA IN (SQ.MTR.)	(%)
1.	RESIDENTIAL	7500.92	38.31 %
2.	INFORMAL	392.69	02.00 %
3.	GROUP HOUSING	4300.40	21.96 %
TOTAL = 1+3		12194.01	62.29 %
4	PARK/ H.T. LINE	1137.40	05.84%
5	ZDP 18M. ROAD	1570.76	08.00%
6	SWM/M.T	60.00	00.3 %
7	ROAD	4613.58	23.57 %
TOTAL = 4 TO 7		7381.74	37.71%
SCHEME AREA		19575.75	100.00 %
		1.95 HECT.	

Proposed Lay-Out Plan of Residential Colony
HAPPY AEROCITY
KHASRA NO 731/224 = 11485.75 SQ MTR.
KHASRA NO 722/404 = 8090.00 SQ MTR.
AT VILLAGE :- FARASIYA, TEH.- KISHANGARH
DIST. AJMER

योजना का नाम :-हैप्पी एरोसिटी		
NORTH :- 	SCALE :- 1"=50'	APPLICANT :-