


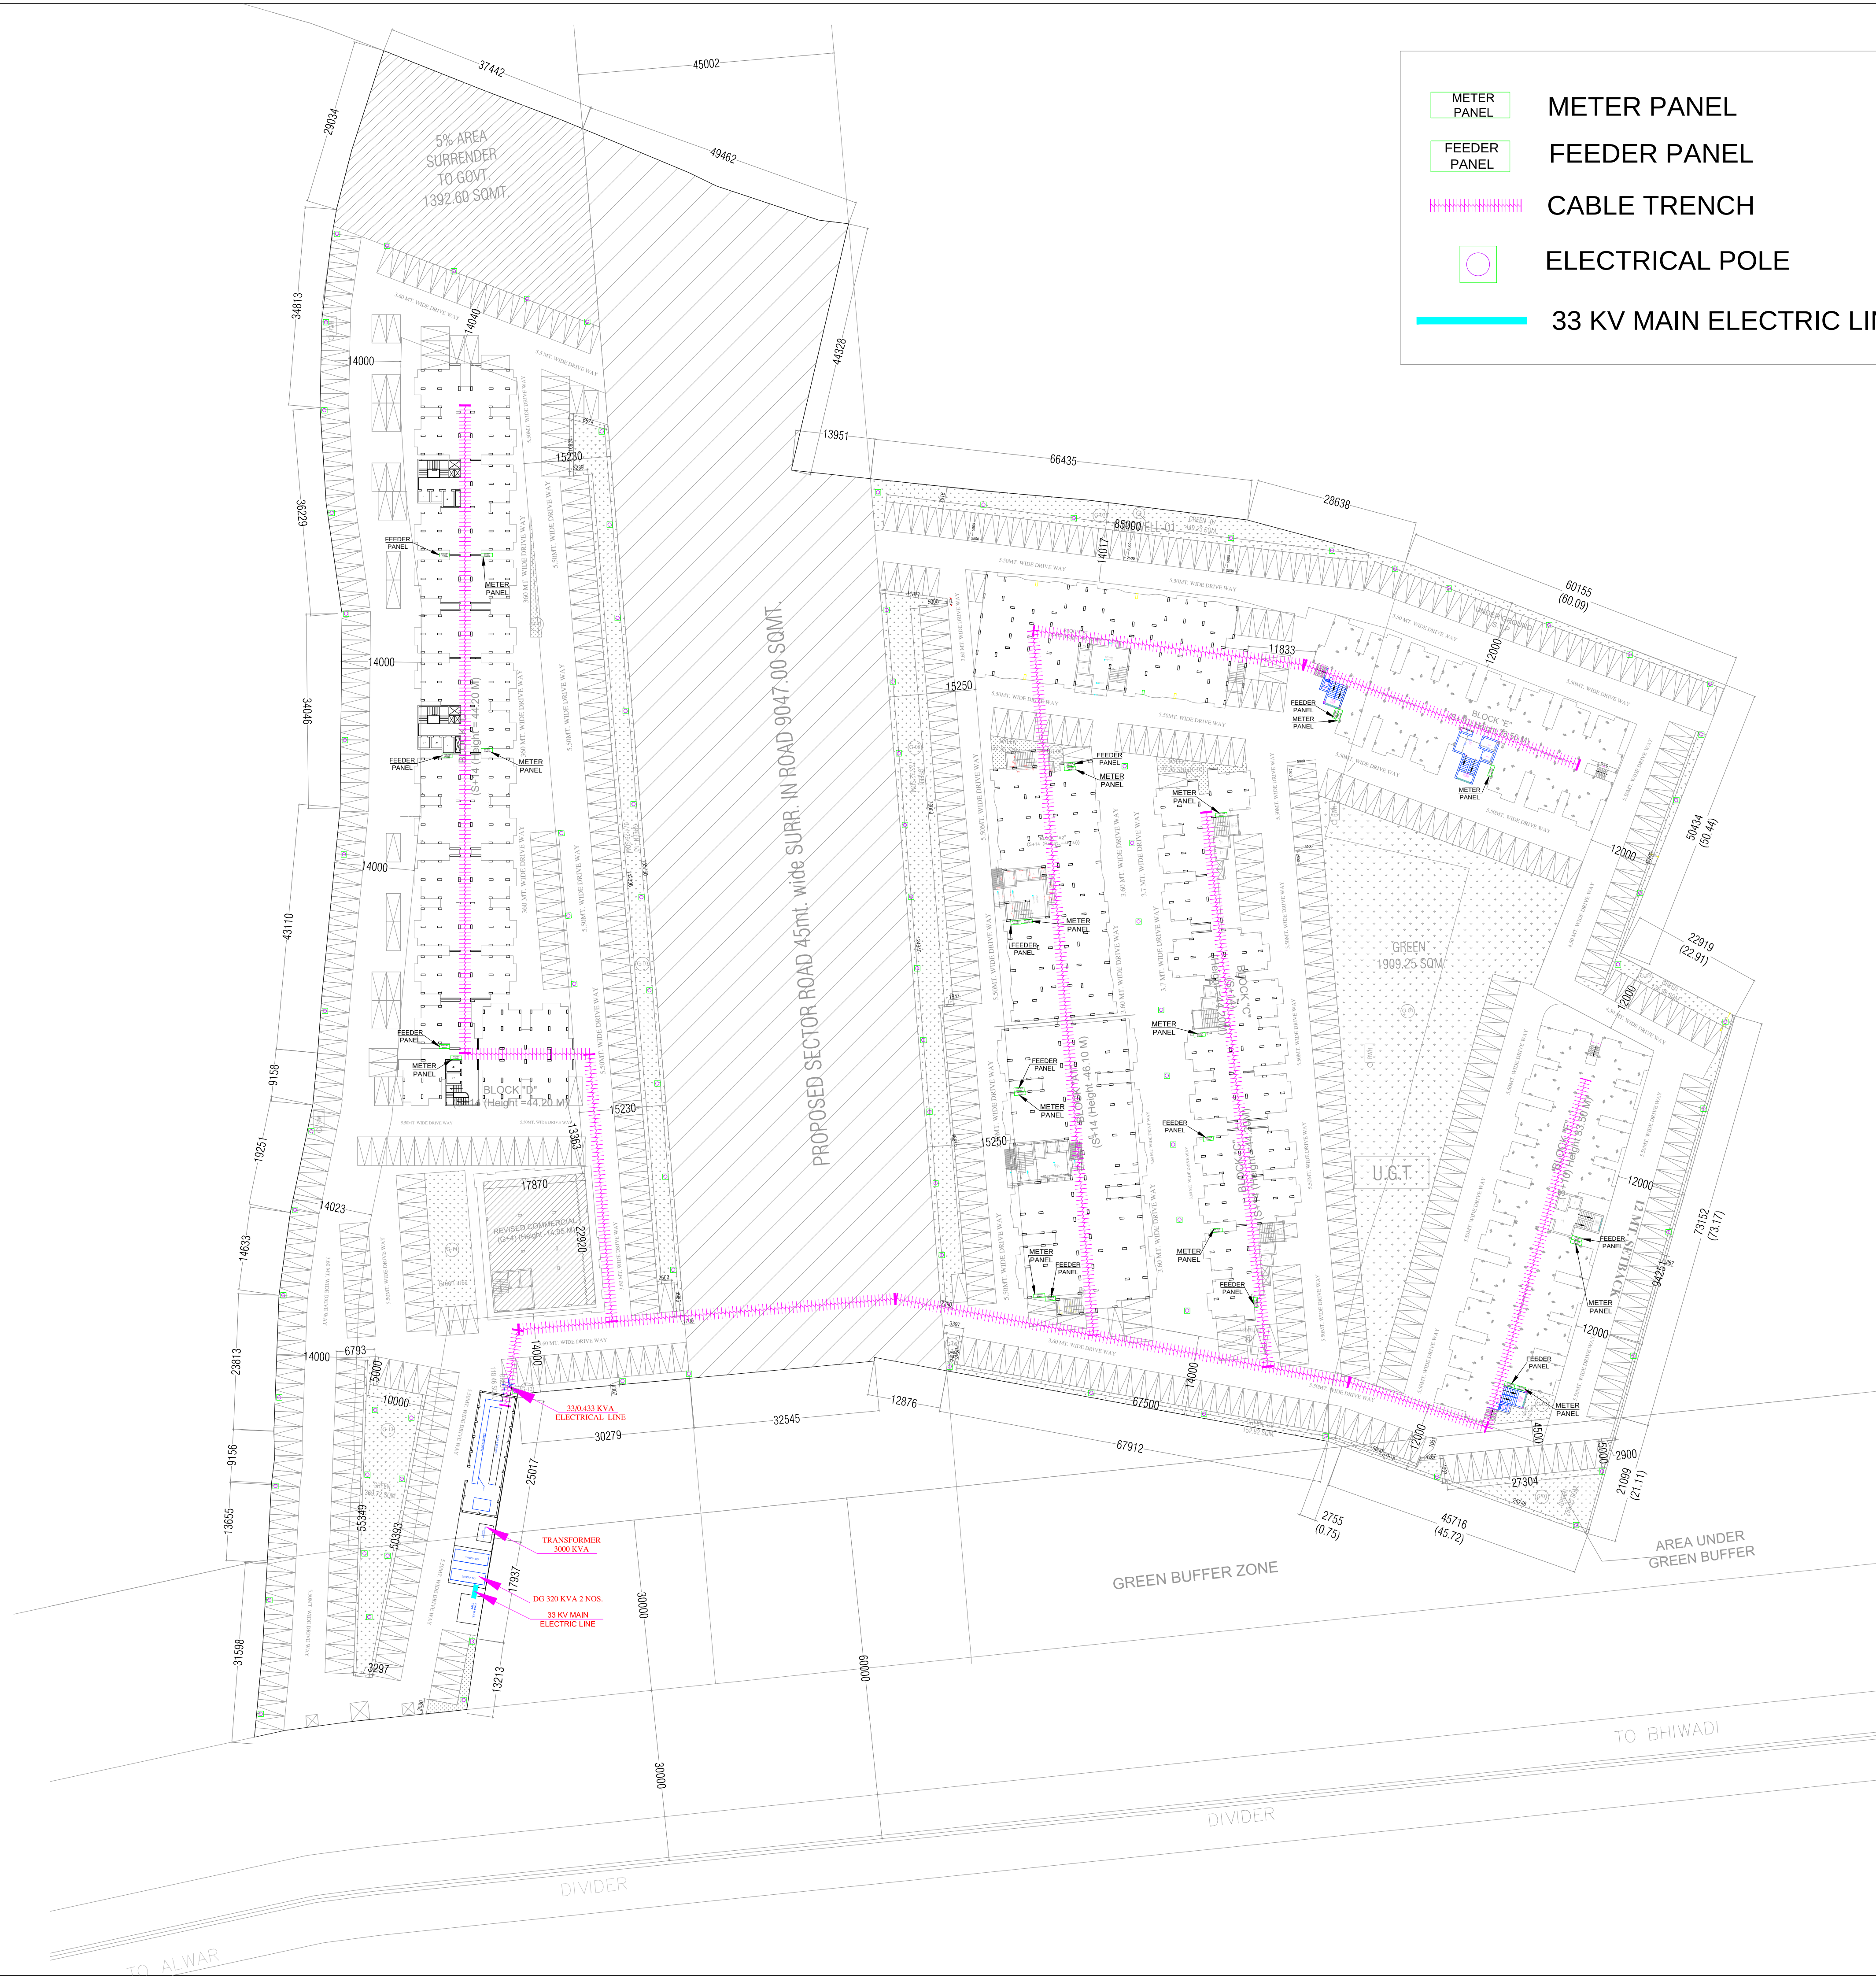

Karan Kamra
B.Tech (Service Consultant)

CONSULTANT:-

KASHVI
BUILDING SERVICES CONSULTANTS
B-101, II Floor side Ganesh Nagar, New
Delhi-110018
Engg : KARAN KAMRA (B.Tech, CIVIL)
Email-kk.241338@gmail.com

DRAWING TITLE:-

ELECTRICAL LAYOUT PLAN

CLIENT:-

TREHAN APNA GHAR PVT. LTD.
290, NAYA-BASS, ALWAR. RAJASTHAN
Alwar Office: C/O PHOOL BAGH SERVICE STATION
NEAR CIRCUIT HOUSE, ALWAR. Tel. 0144-3241400

PROJECT:-

TREHAN HEIGHTS

KHASRA NO :- **205,206,207,208,209, 679/210,**
216,217,218,693/215, 215/699 AT VILLAGE
TAPUKARA,TEH.-TIJARA, DISTT.-ALWAR (RAJ.)

DATE:-

10/02/2025

SCALE:-

N.T.S