
















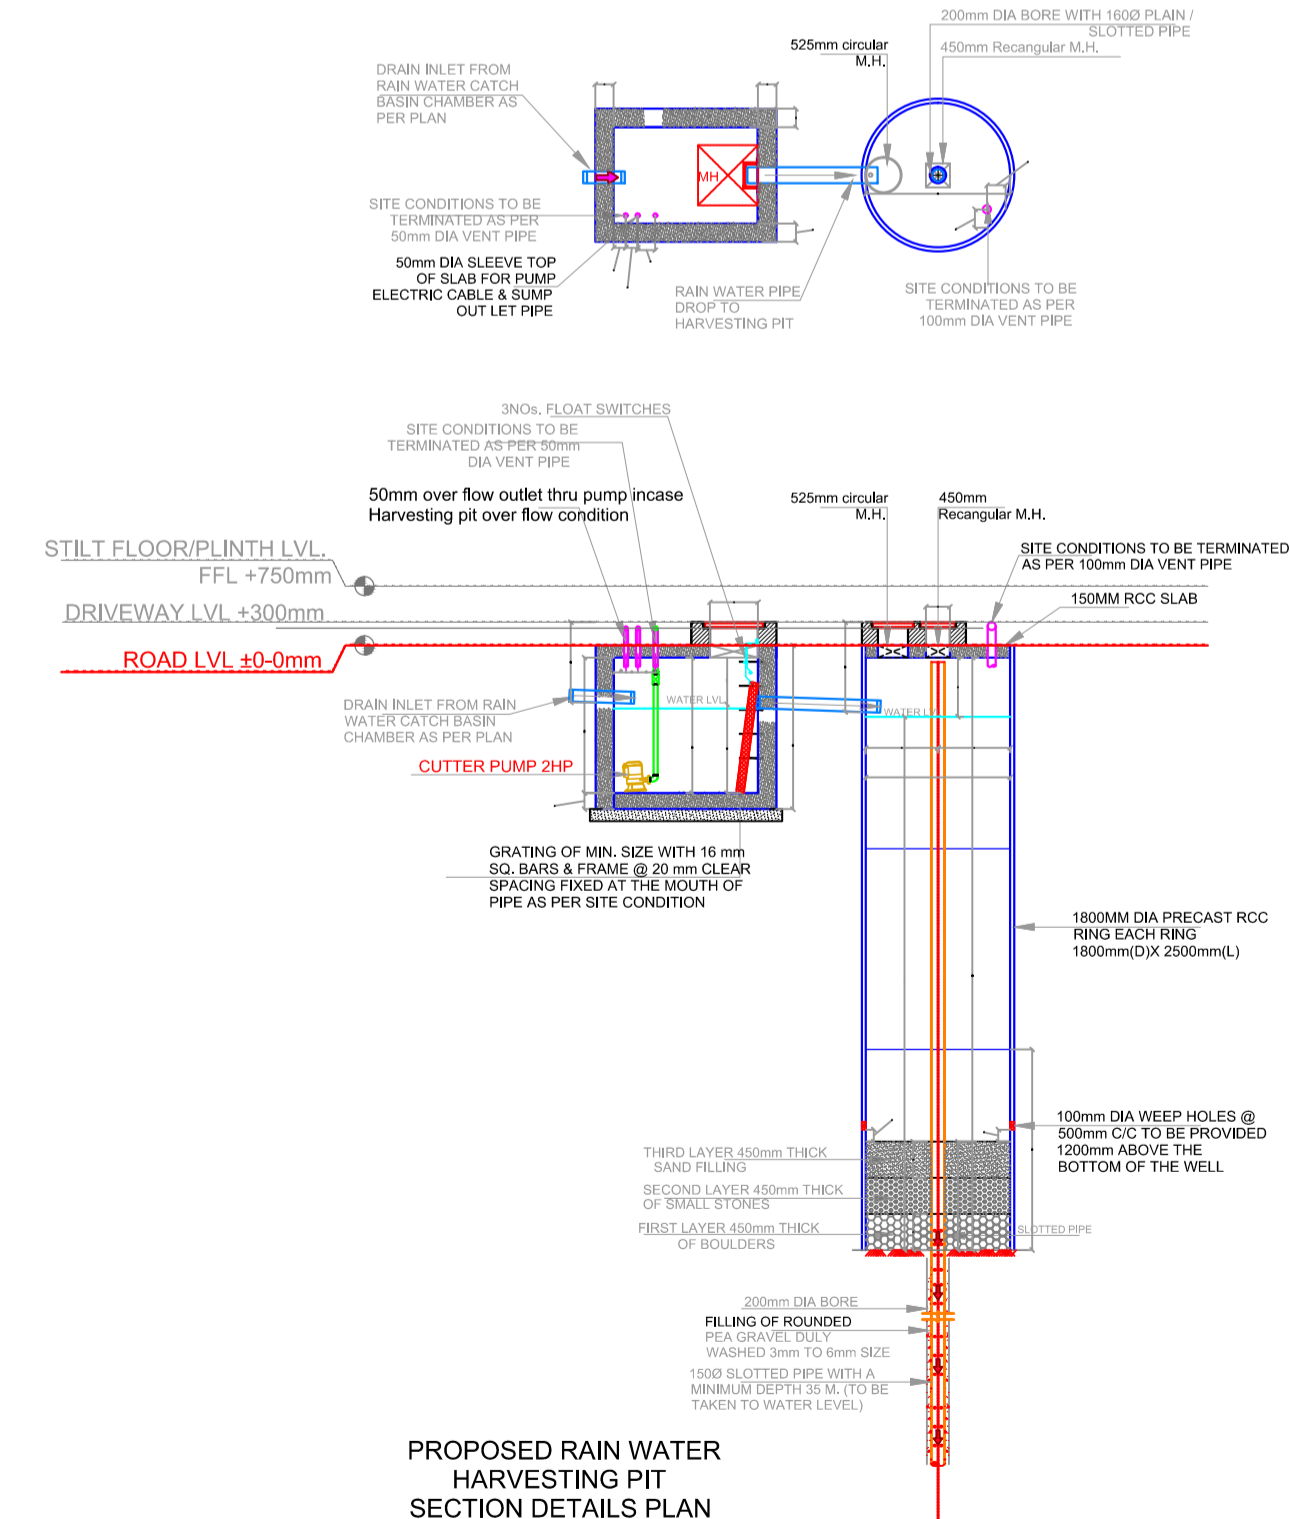


LEGENDS		
S.NO.	SYMBOL	DESCRIPTION
1.		SDR-11 Fresh Water Pipe
2.		SDR-11 Solar Water Pipe
3.		Waste Water Pipe (W.P.)
4.		Soil Pipe (S.P.)
5.		Rain Water Pipe (R.W.P.)
6.		Butter Fly Valve(B.F.V.)
7.		Geysers
8.		RO
9.		Single Lever Diverter
10.		Concocted Valve
11.		Angle Valve
12.		Naham Trap
13.		P-Trap
14.		Tap
15.		Floor Drain (F.D.)
16.		Plain Tee (P.Tee)
17.		Gully Trap (G.T.)
18.		

PROPOSED RAIN WATER
HARVESTING PIT
SECTION DETAILS PLAN



Shree Genukripa Motra
Patne

Krishna
KRISHNA KUMA
B. Tech. (Mechanics)
M.E.P. Consultant

1. This drawing is the sole copyright of Architects VISTAAR and should be used for the purpose expressly issued.

1. All dimensions are in feet and inches.
2. Do not scale this drawing follow written dimensions only.
3. This drawing should be read in conjunction with other architectural and structural drawings.
4. Any discrepancy in the drawing should be immediately brought to the notice of architect.

PROJECT TITLE


THE URBAN CREST
PLOT NO. - A-9,A-10,A-11,A-12
A-21,A-22,A-23,A-24, SHYAM VATIKA,
MANYAWAS,MANSROVAR, JAIPUR.


DRAWING TITLE

5. SANITATION (STORM WATER DRAINAGE, SEWERAGE, STP, SOLID WASTE DISPOSAL) AND RAIN WATER HARVESTING PLAN

ARCHITECTS :

VISTAAR ARCHITECTS & PLANNERS
Architects :: Interior Designers
B-2/12, Chitrkoot scheme,
main Gandhi Path, Opp mall of jaipur, Jaipur
PH.- 0141-4370233, 09001010366

PATH :-			
DRN.	DATE	REV.	NORTH
MANOJ KUMAWAT	26-08-2024		
SCALE	JOB NO.		
N.T.S			

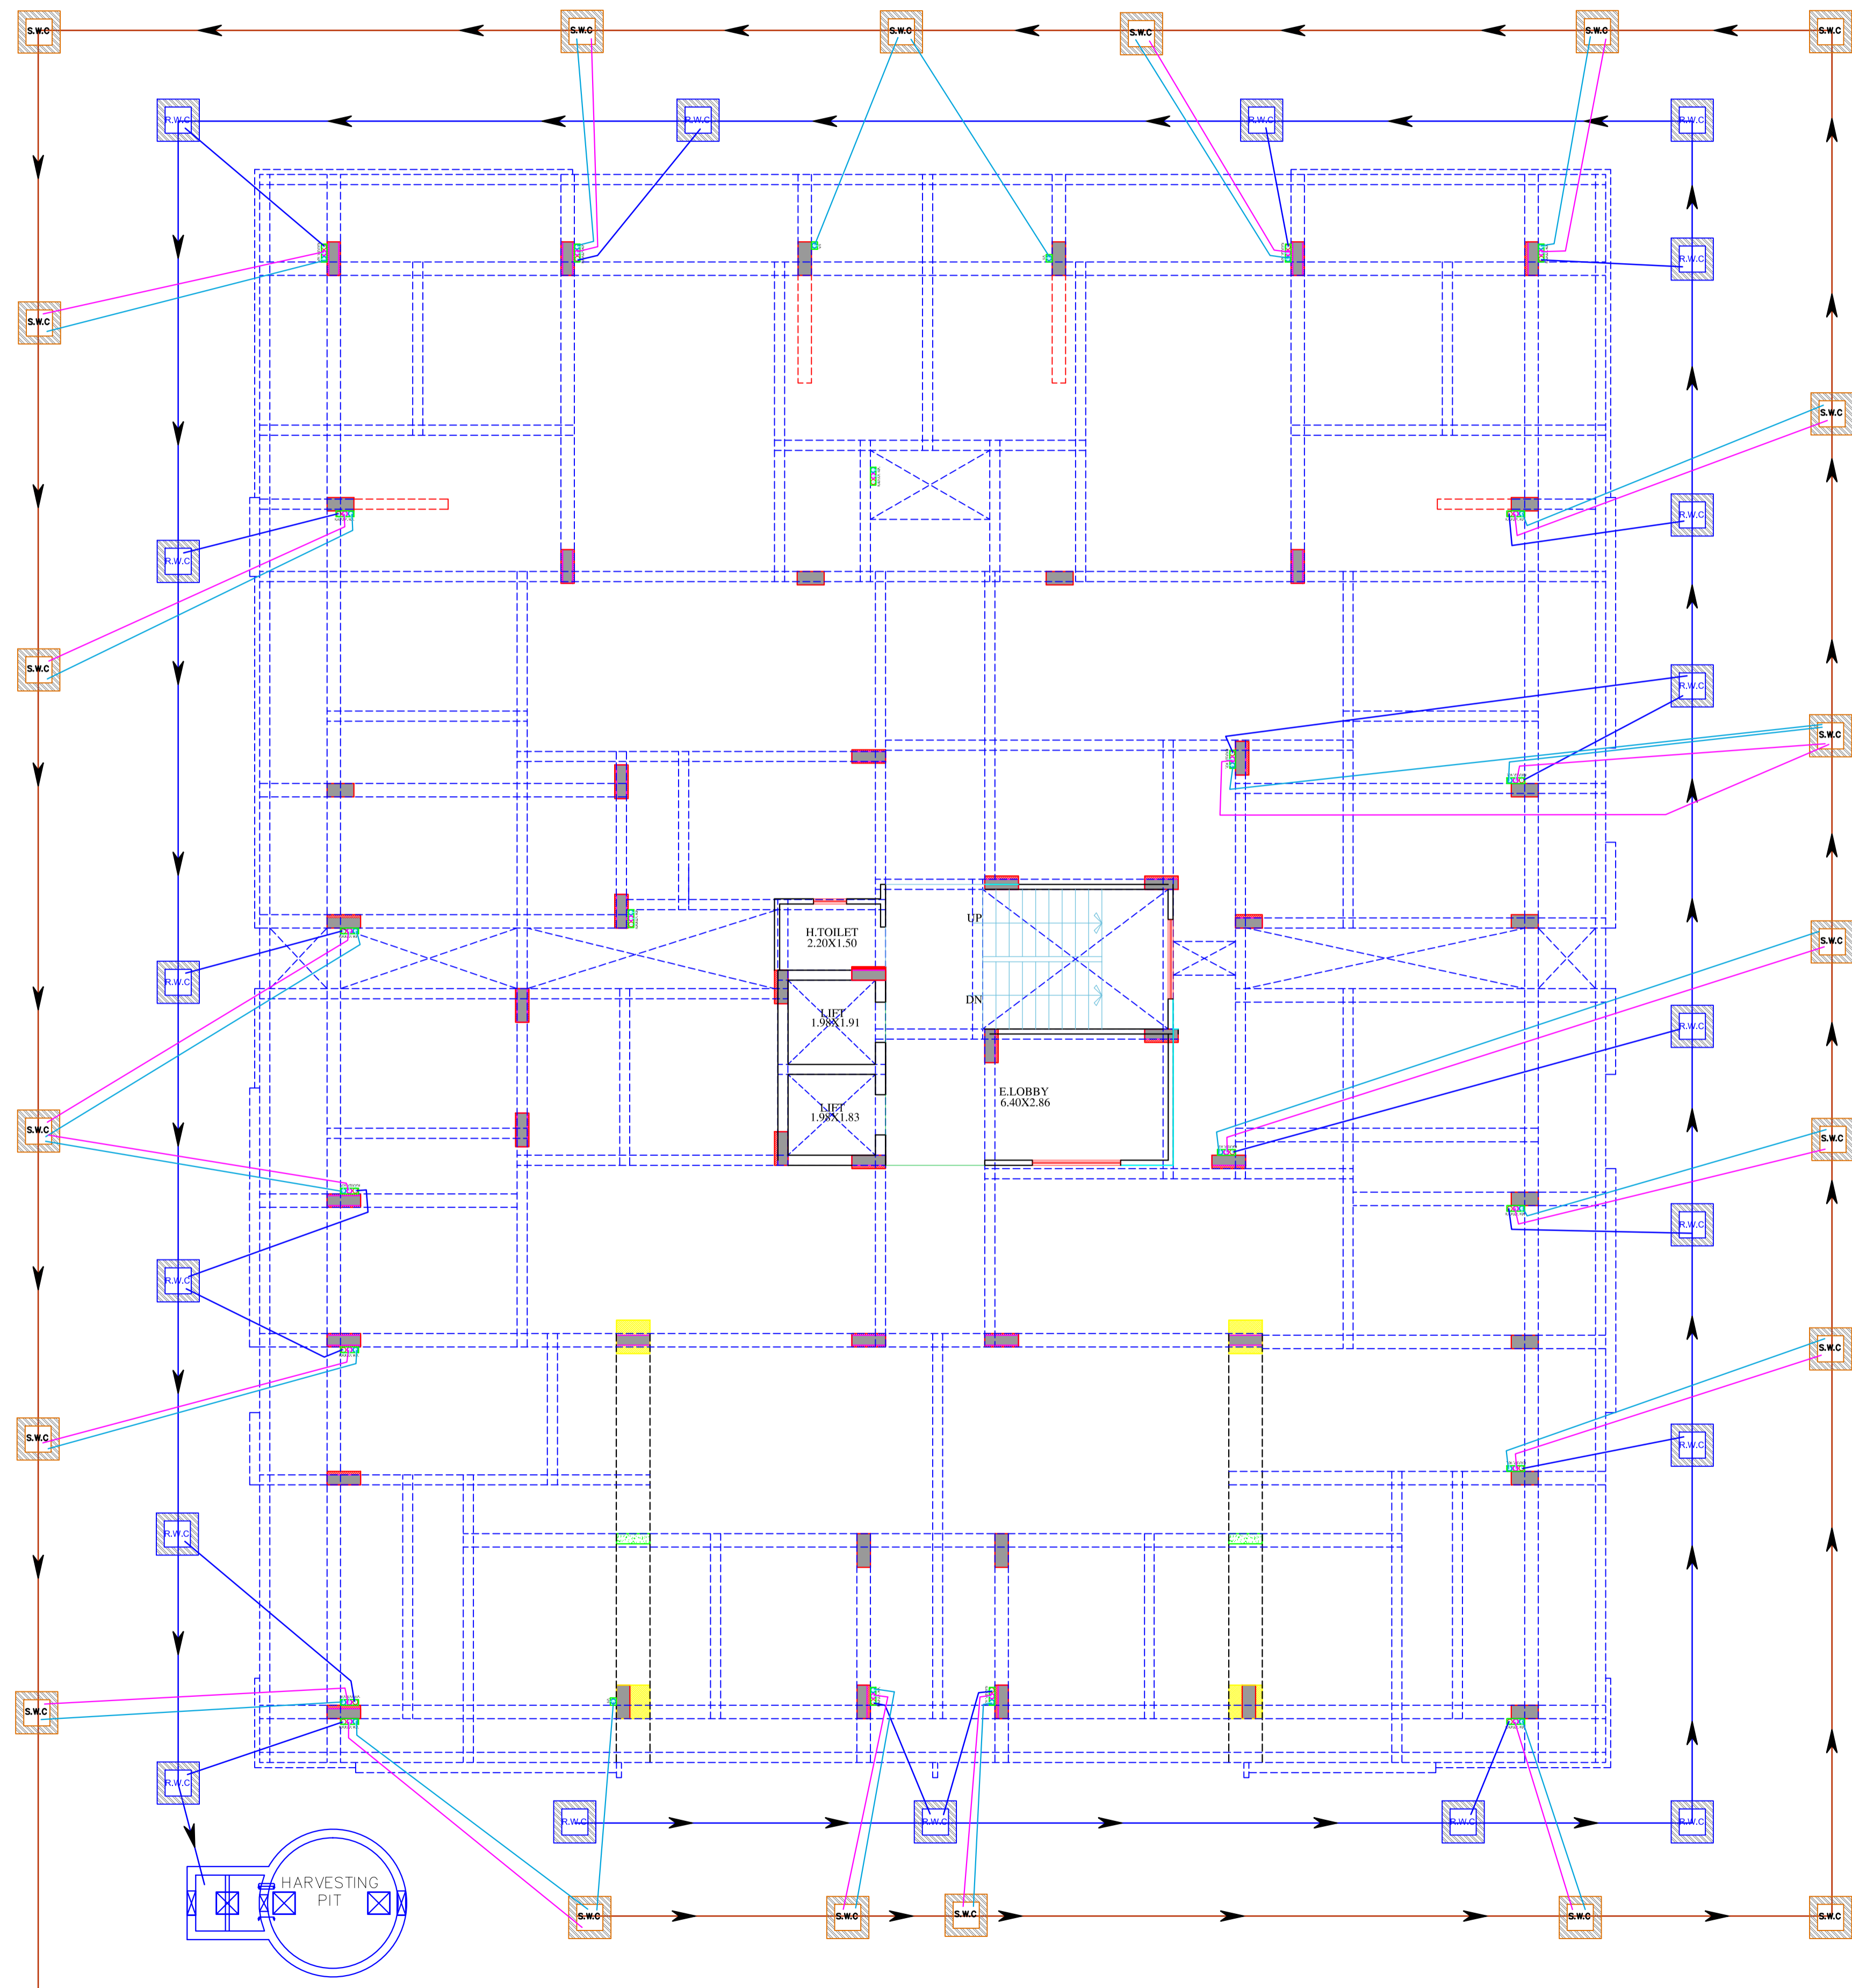

WARNING

1. This drawing is the sole copyright of Architects **VISTAAR** and should be used for the purpose expressly issued.

GENERAL NOTES

1. All dimensions are in feet and inches.
2. Do not scale this drawing follow written dimensions only.
3. This drawing should be read in conjunction with other architectural and structural drawings.
4. Any discrepancy in the drawing should be immediately brought to the notice of architect.

PROJECT TITLE

THE URBAN CREST
PLOT NO. - A-9,A-10,A-11,A-12
A-21,A-22,A-23,A-24, SHYAM VATIKA,
MANYAWAS,MANSROVAR, JAIPUR.

DRAWING TITLE

STILT FLOOR DRAINAGE PLAN

ARCHITECTS :

VISTAAR ARCHITECTS & PLANNERS
Architects :: Interior Designers
B-2/12, Chitrkoot scheme,
main Gandhi Path,Opp mall of jaipur,Jaipur
PH.- 0141-4370233,09001010366

PATH -

DRN.

MANOJ
KUMAWAT

SCALE

N.T.S


DATE


26-08-2024

JOB NO.

REV.

NORTH

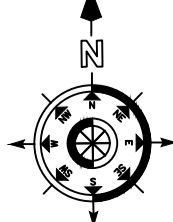

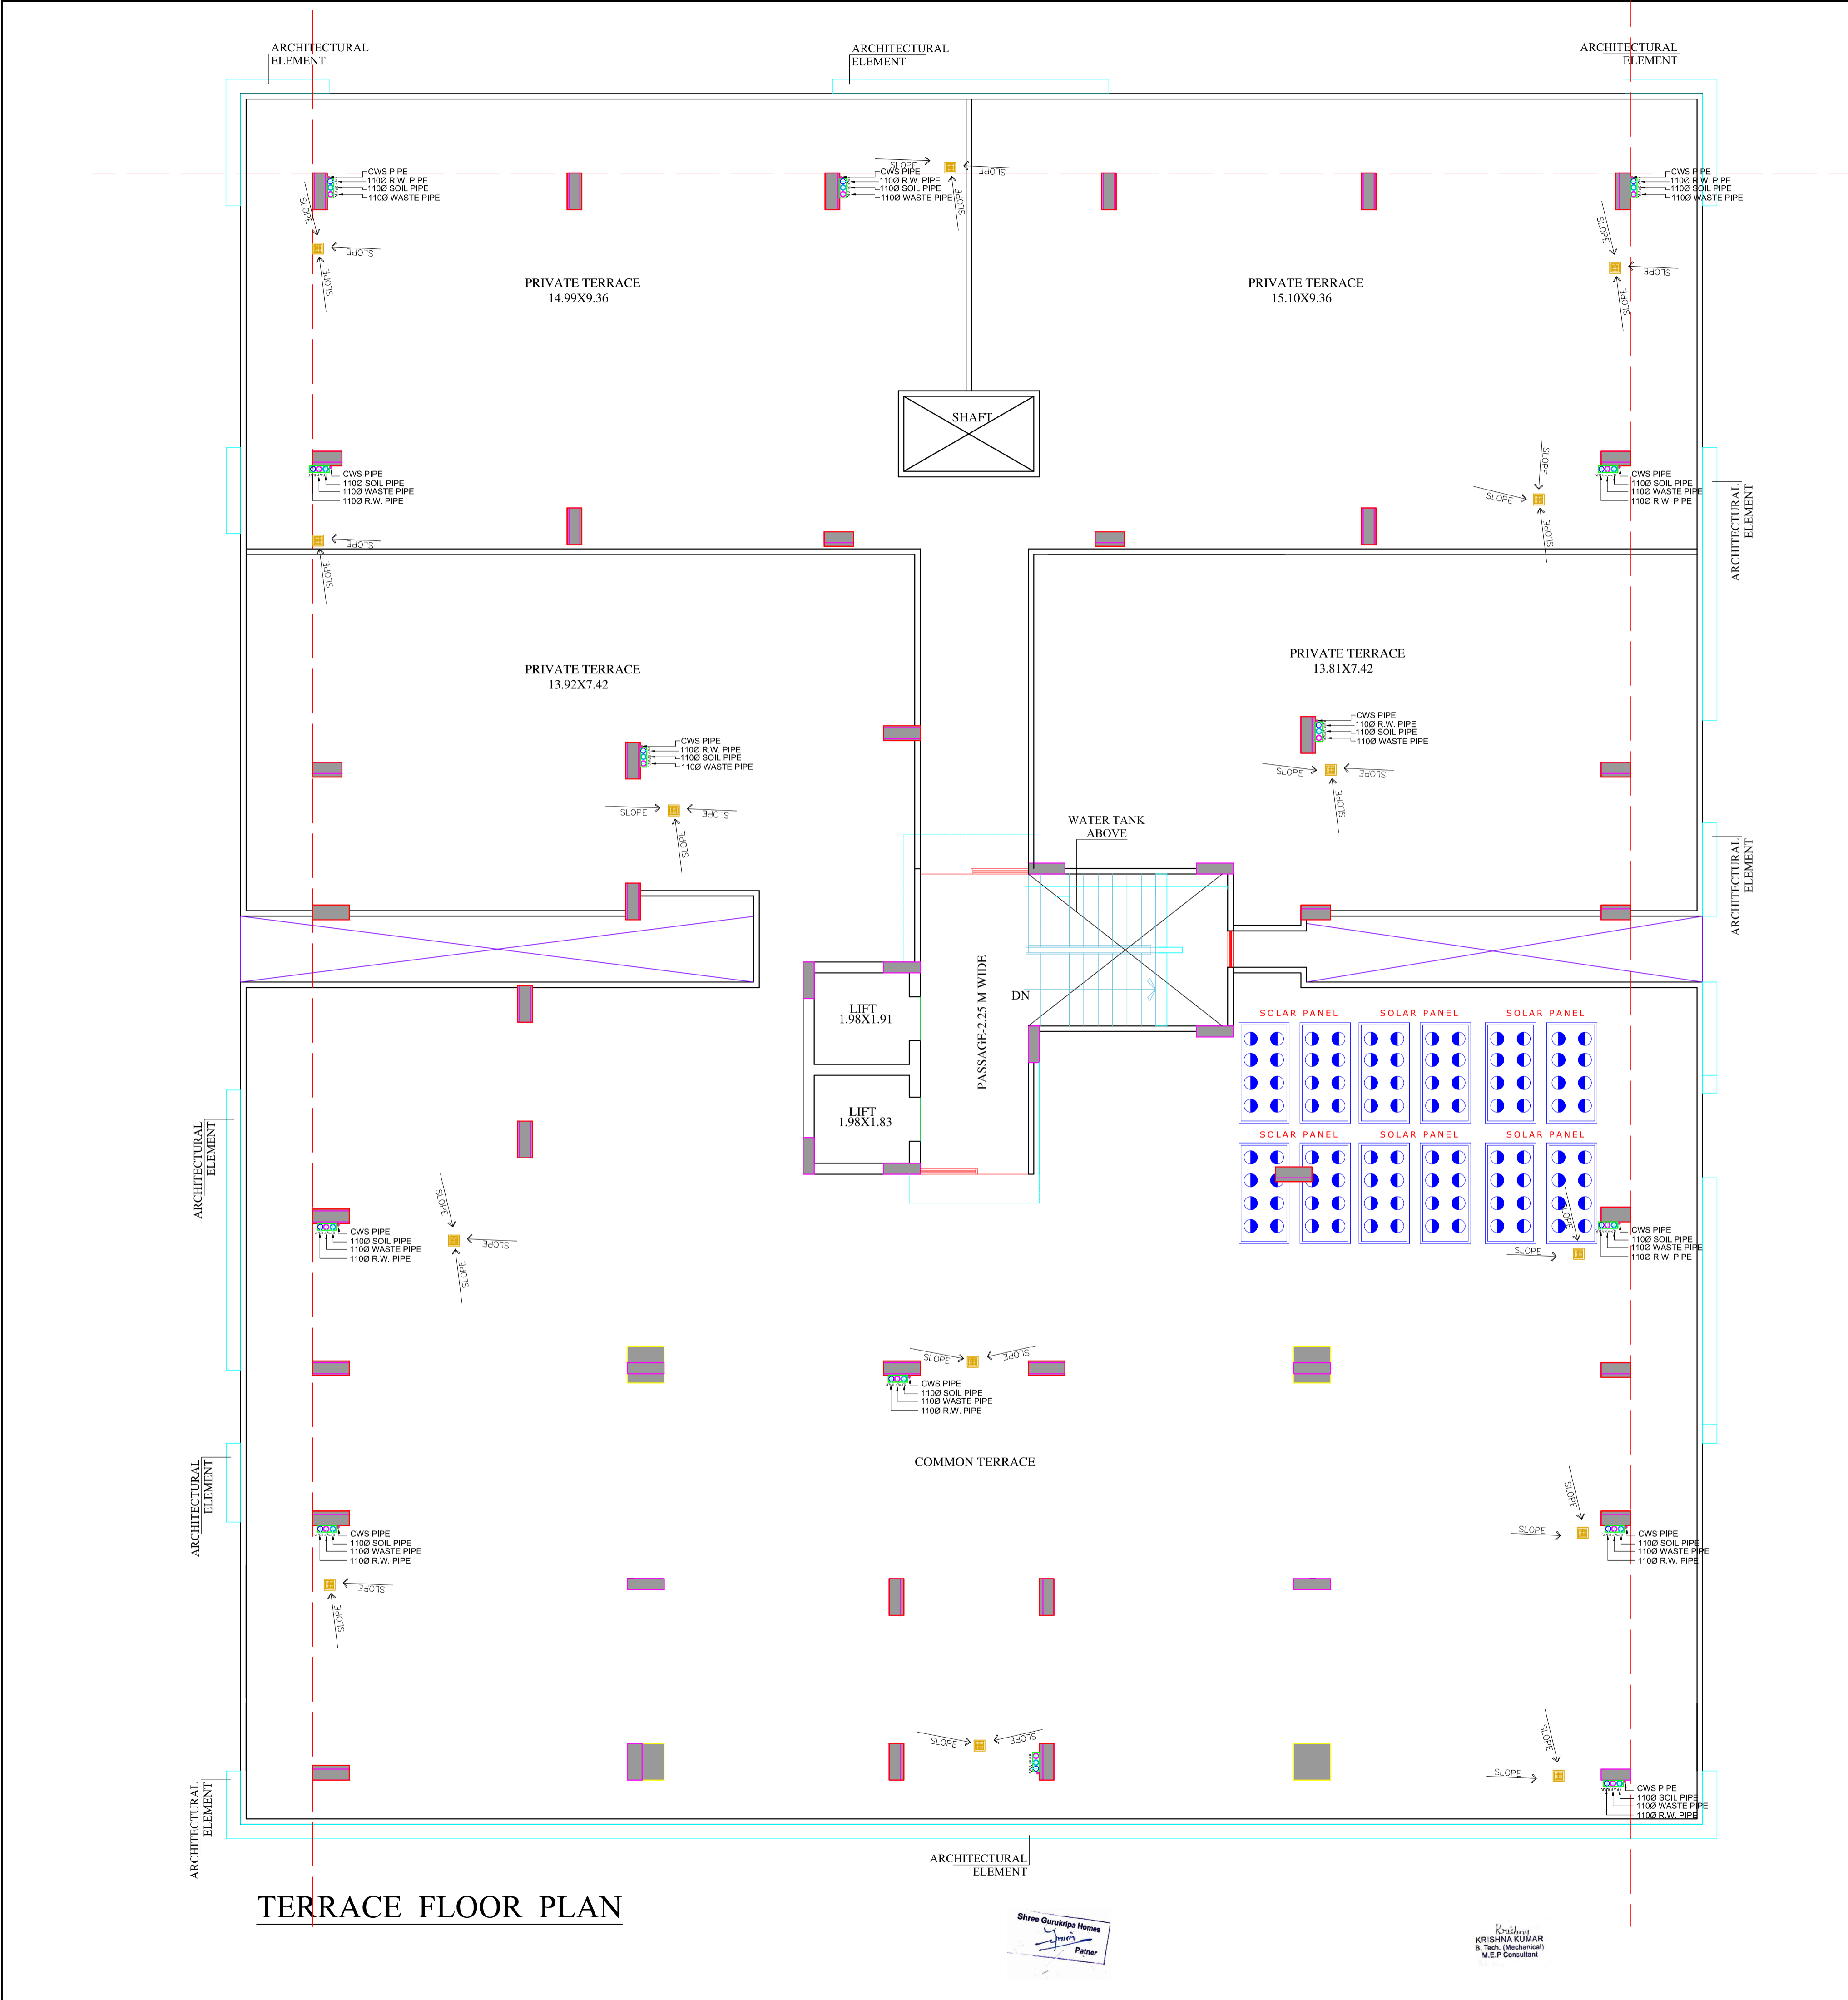

LEGENDS

S.NO.	SYMBOL	DESCRIPTION
1.		SDR-11 Fresh Water Pipe
2.		SDR-11 Solar Water Pipe
3.		Waste Water Pipe (W.P.)
4.		Soil Pipe (S.P.)
5.		Rain Water Pipe (R.W.P.)
6.		Butter Fly Valve(B.F.V.)
7.		Geyser
8.		RO
9.		Single Lever Diverter
10.		Concealed Valve
11.		Angle Valve
12.		Nahani Trap
13.		P-Trap
14.		Tap
15.		Floor Drain (F.D.)
16.		Plain Tee (P-tee)
17.		Gully Trap (G.T.)
18.		

WARNING

1. This drawing is the sole copyright of Architects **VISTAAR** and should be used for the purpose expressly issued.

GENERAL NOTES

1. All dimensions are in feet and inches.
2. Do not scale this drawing follow written dimensions only.
3. This drawing should be read in conjunction with other architectural and structural drawings.
4. Any discrepancy in the drawing should be immediately brought to the notice of architect.

PROJECT TITLE

THE URBAN CREST
PLOT NO. - A-9,A-10,A-11,A-12
A-21,A-22,A-23,A-24, SHYAM VATIKA,
MANYAWAS,MANSROVAR, JAIPUR.

DRAWING TITLE

TERRACE DRAINAGE
LAYOUT

ARCHITECTS :

VISTAAR ARCHITECTS & PLANNERS
Architects :: Interior Designers
B-2/12, Chitrkoot scheme,
main Gandhi Path,Opp mall of jaipur,Jaipur
PH.- 0141-4370233,09001010366

PATH :-

DRN.	DATE	REV.	NORTH
MANOJ KUMAWAT	26-08-2024		
SCALE	JOB NO.		
N.T.S			

