


LAYOUT PLAN OF DRAINAGE NETWORK AND RAIN WATER HARVESTING FOR RESIDENTIAL SCHEME  
HARIGARH ESTATE PHASE-II

Khasra No. 39 to 44, 742/45,744/46, 47 to 57 village Khori Ropada, Tehsil Sanganer, Jaipur, Rajasthan and Khasra No. 9 to 16, 123/17, 131/22, 137/29, 141/31, 149/8, 30 & 32 to 37 village Chakmatasula urf Badhgovindpura, Tehsil Sanganer Jaipur

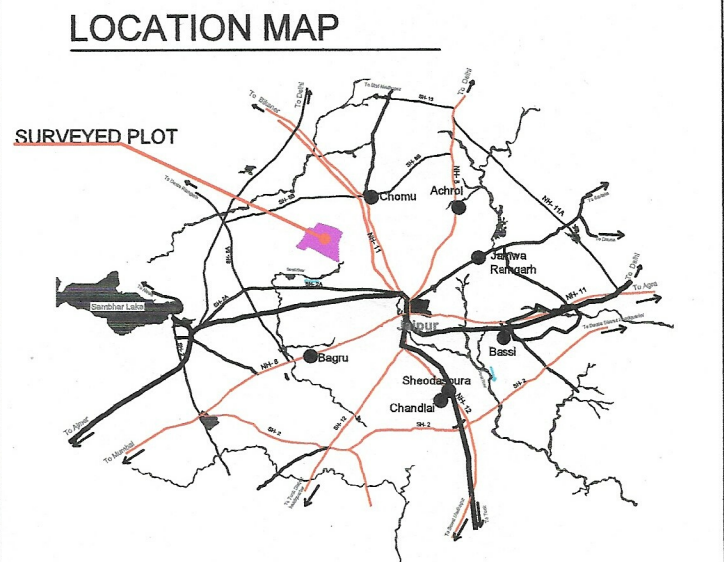

CONSULTANT:  
Triangle Atelier LLP  
S-56, Himmat Nagar, Tonk road  
302018

DEVELOPER:  
AJMER COLONIZERS  
PRIVATE LIMITED

PROJECT:  
HARIGARH ESTATE PHASE-II  
RAIN WATER HARVESTING AND  
DRAINAGE LAYOUT PLAN  
IN RESIDENTIAL TOWNSHIP

- NOTES
- DRAWINGS ARE NOT TO BE SCALED
  - ALL MEASUREMENTS ARE IN M UNLESS OTHERWISE SPECIFIED
  - DRAWINGS TO BE READ IN CONJUNCTION WITH RELEVANT STRUCTURAL DRAWINGS
  - ANY DISCREPANCIES IN THE DIMENSIONS/SPECIFICATIONS TO BE BROUGHT TO THE ATTENTION OF THE ARCHITECT PRIOR TO THE PROCEEDING OF WORK

PRINTING DATE

LEGEND:

250 MM DIA - DWG	
PIPE NUMBER	
DIA / LENGTH / SLOPE	
(mm) (m) (1 in)	
INLET	
INLET NUMBER	
RAIN WATER HARVESTING STRUCTURE	



DRAWN BY  
Ajay singh

CHECK BY  
Nikhil Chaudhary

SHEET SIZE  
S3

PROJECT NUMBER  
TRIANGLE/HARIGARH ESTATE P-II/WW/01

TITLE  
DRAINAGE  
NETWORK

DRAWING NO.

S-103

SCALE 1:100

Copyright 2021 Triangle Atelier. All rights reserved. This drawing is not to be reproduced, handed over to a third party or used for any purpose other than for which it was loaned.