


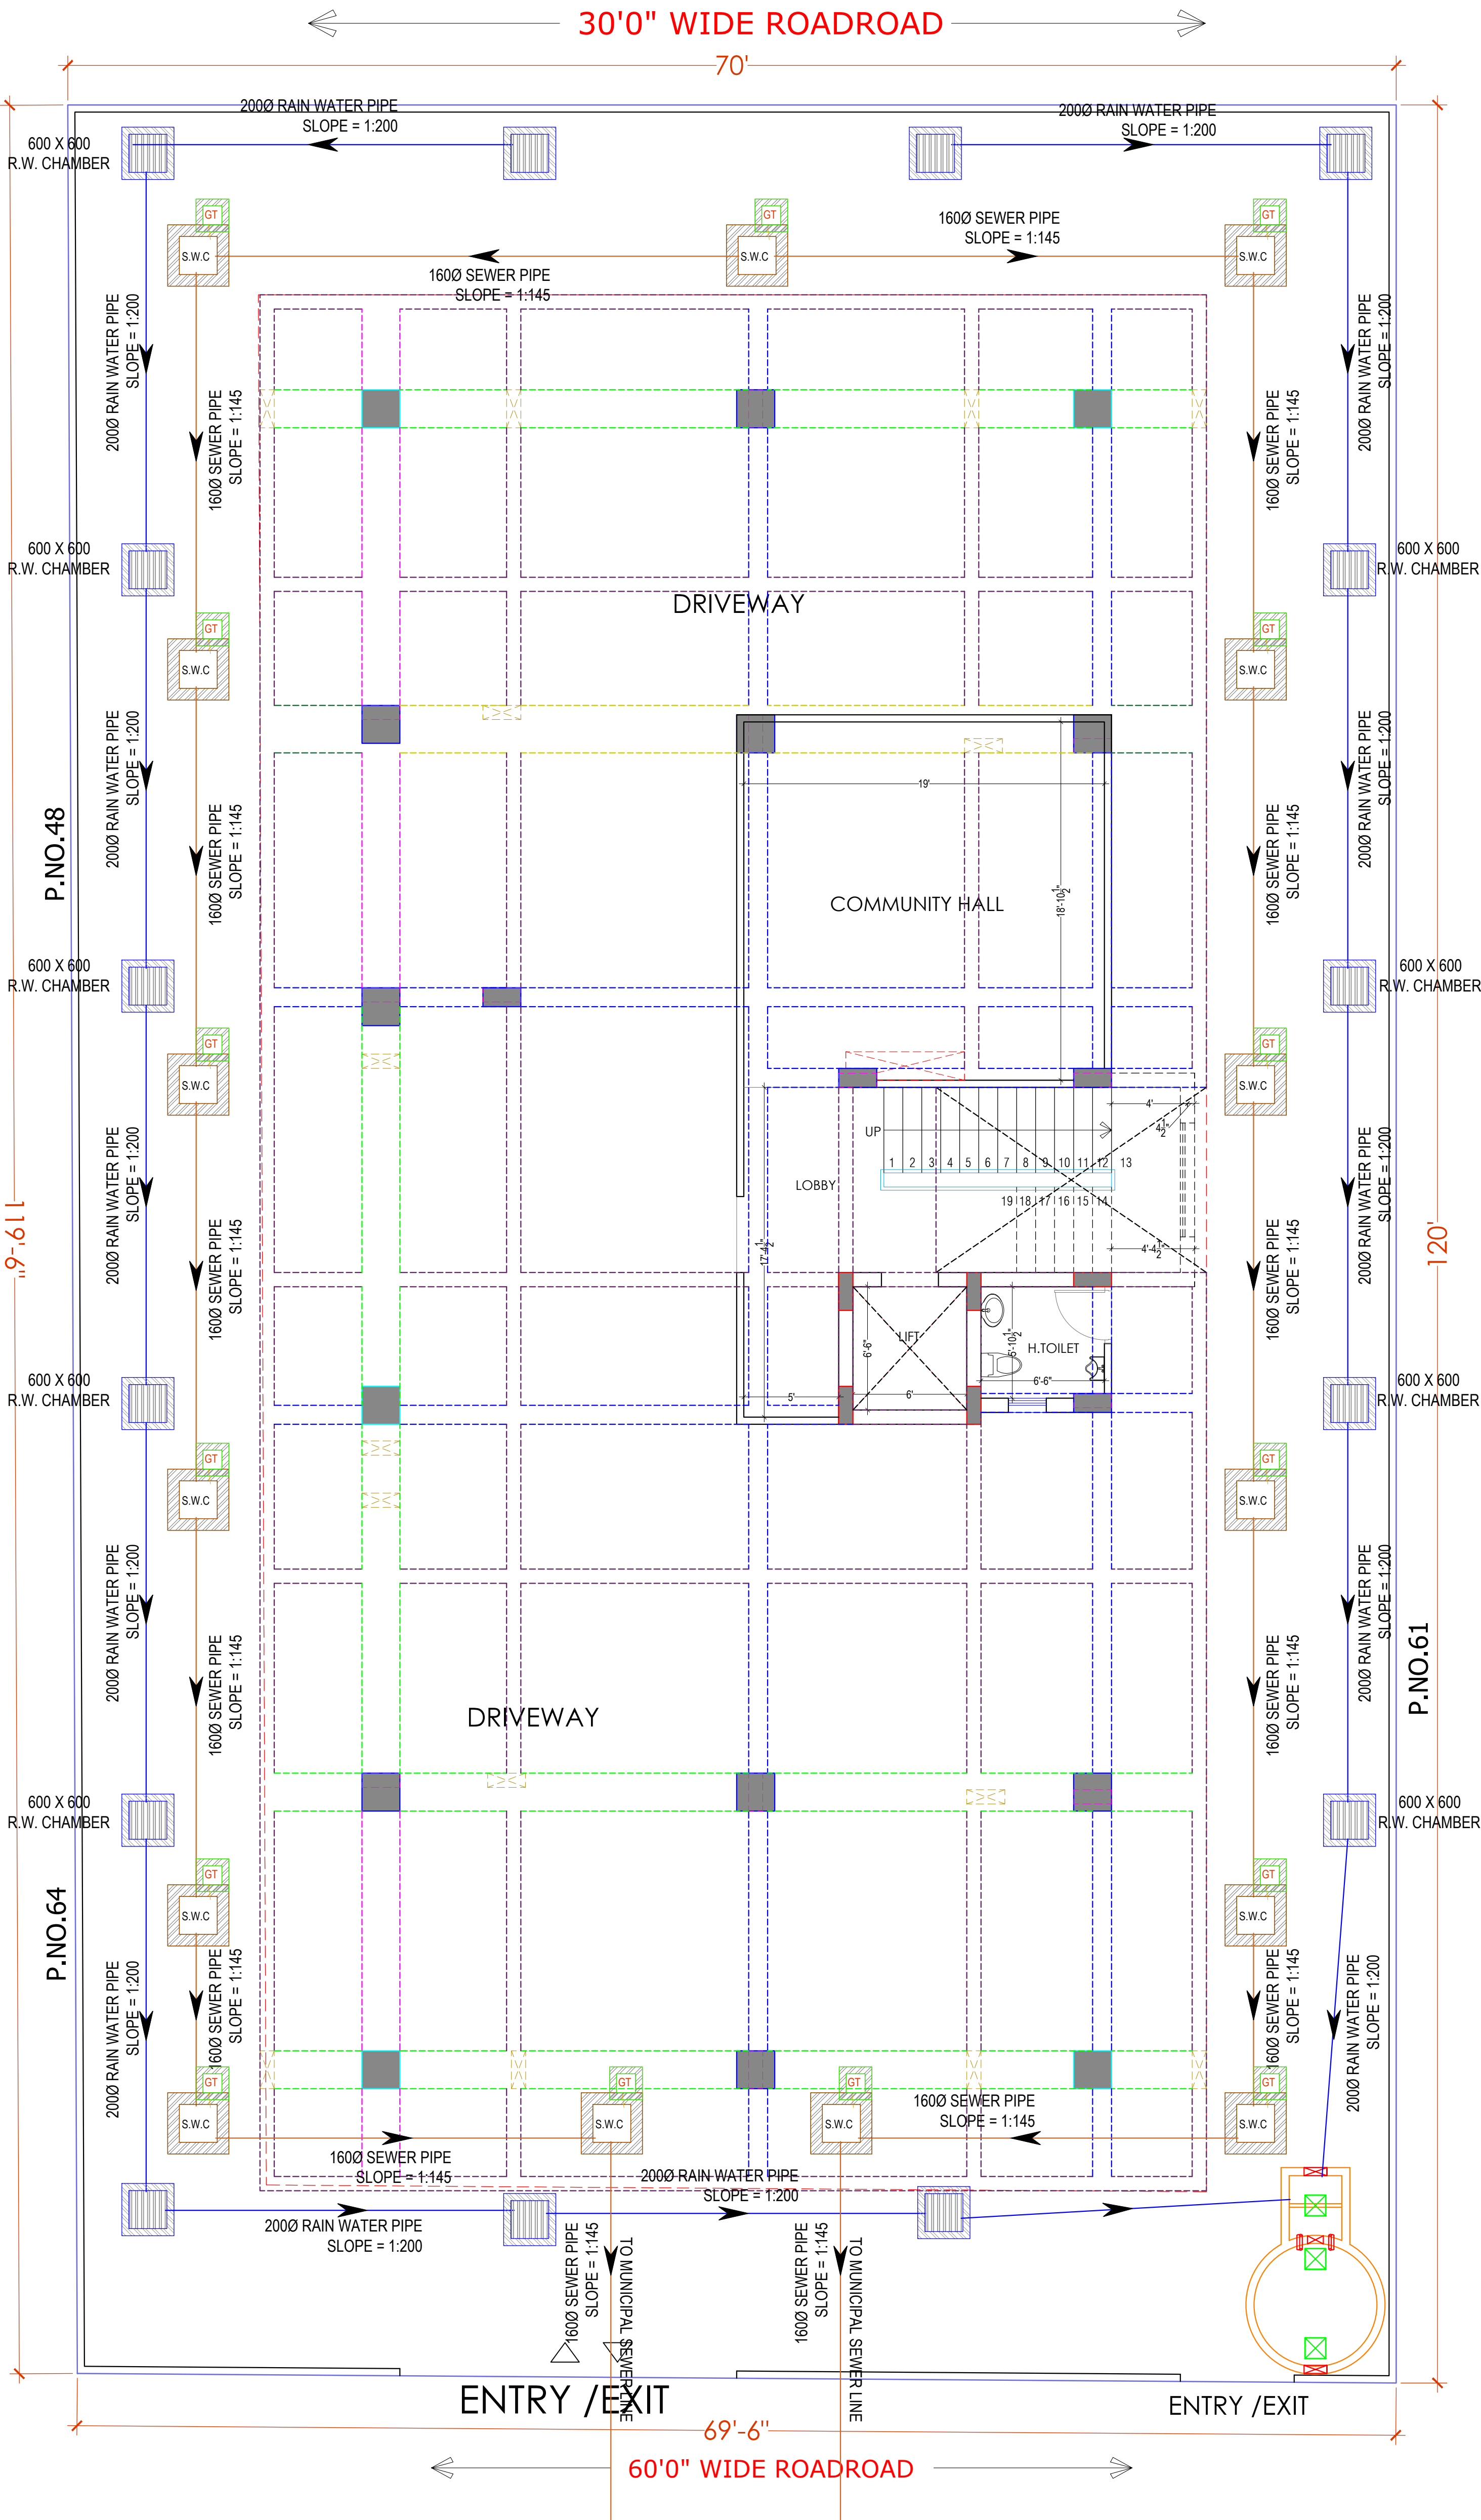

PROJECT NAME :
BALAJI AASHIYANA II

DEVELOPER NAME :
BALAJI BUILDER

ARCHITECTS :
4 INSIDE
ARCHITECTURE N INTERIORS
Plot no. 72, S.P. Marg, C- Scheme
jaipur, rajasthan, India
cont: +91 9950595991, 91
9982812777
e.mail: 4insideofficial@gmail.com

LEGEND:-		
①	SOIL PIPE	
②	WASTE PIPE	
③	VENT PIPE	
④	COLD WATER SUPPLY (CWS)	
⑤	HOT WATER SUPPLY (HWS)	
	RAIN WATER PIPE	
SW	SEWER LINE- EXTERNAL	
RW	STORM WATER DRAINAGE PIPE	
	SEWERAGE MANHOLE (2' x 2')	M.H.
	STORM WATER MANHOLE (2' x 2')	M.H.
GT	GULLY TRAP	
BV	BALL VALVE	
FT	FLOOR TRAP	
FD	FLOOR FLOOR DRAIN	
	RAIN WATER COLLECTION CHAMBER 450X450MM	
	KHURRA	

- | S.NO | DATE | REVISION DESCRIPTION |
|------|------|---|
| 1. | | GENERAL NOTES :
All dimension on this drawing are in MKS System Only written dimensions are to be followed drawing should not be scaled.
All measurements must be checked and verified by the contractors prior to execution of work at the site.
This drawing is to be read in conjunction with all relevant structural, services & facility planning drawings.
Architectural drawings are to be followed for the location of all structural members & masonry walls, for sizes & reinforcement details of structural members, relevant structural drawings are to be referred.
Any discrepancies between architectural, structural, and services drawings must be brought to the notice of the architects immediately & prior to execution at site.
Co-ordinate with services such as hvac, plumbing & electrical, etc. is the responsibility of the contractors.
All masonry walls should be aligned with the columns as indicated on the plan, irrespective of the position as calculated with the dimensions.
For details, refer relevant large scale detail drgs. as indicated. |

PROJECT:
PLOT NO. 49,50,62 & 63
SCHEME NO.17 LAXMAN REKHA
JAIPUR.


NAME OF DRAWING:

STILT FLOOR WATER SUPPLY DRAWING, STILT FLOOR EXTERNAL RAIN WATER HARVESTING AND PIPE ROUTE PLAN, STILT FLOOR EXTERNAL SEWERAGE WATER PIPE ROUT PLAN

DRAWING WORKING DRAWING	NORTH:
PROJECT NO. :	DATE : 21, Nov. - 2024
SCALE : NTS	REV NO. : R-0

DRAWING NO. :						DRAWING PATH:
PROJECT	CATEGORY	BLOCK	FLOOR	TYPE	NUMBER	
A-201						

For BALAJI BUILDERS
Er. SANJEEV SHARMA
B.E (Electrical)
Proprietor
STILT FLOOR WATER SUPPLY DRAWING, STILT FLOOR EXTERNAL RAIN WATER HARVESTING AND PIPE ROUTE PLAN, STILT FLOOR EXTERNAL SEWERAGE WATER PIPE ROUT PLAN,PIT LOCATION

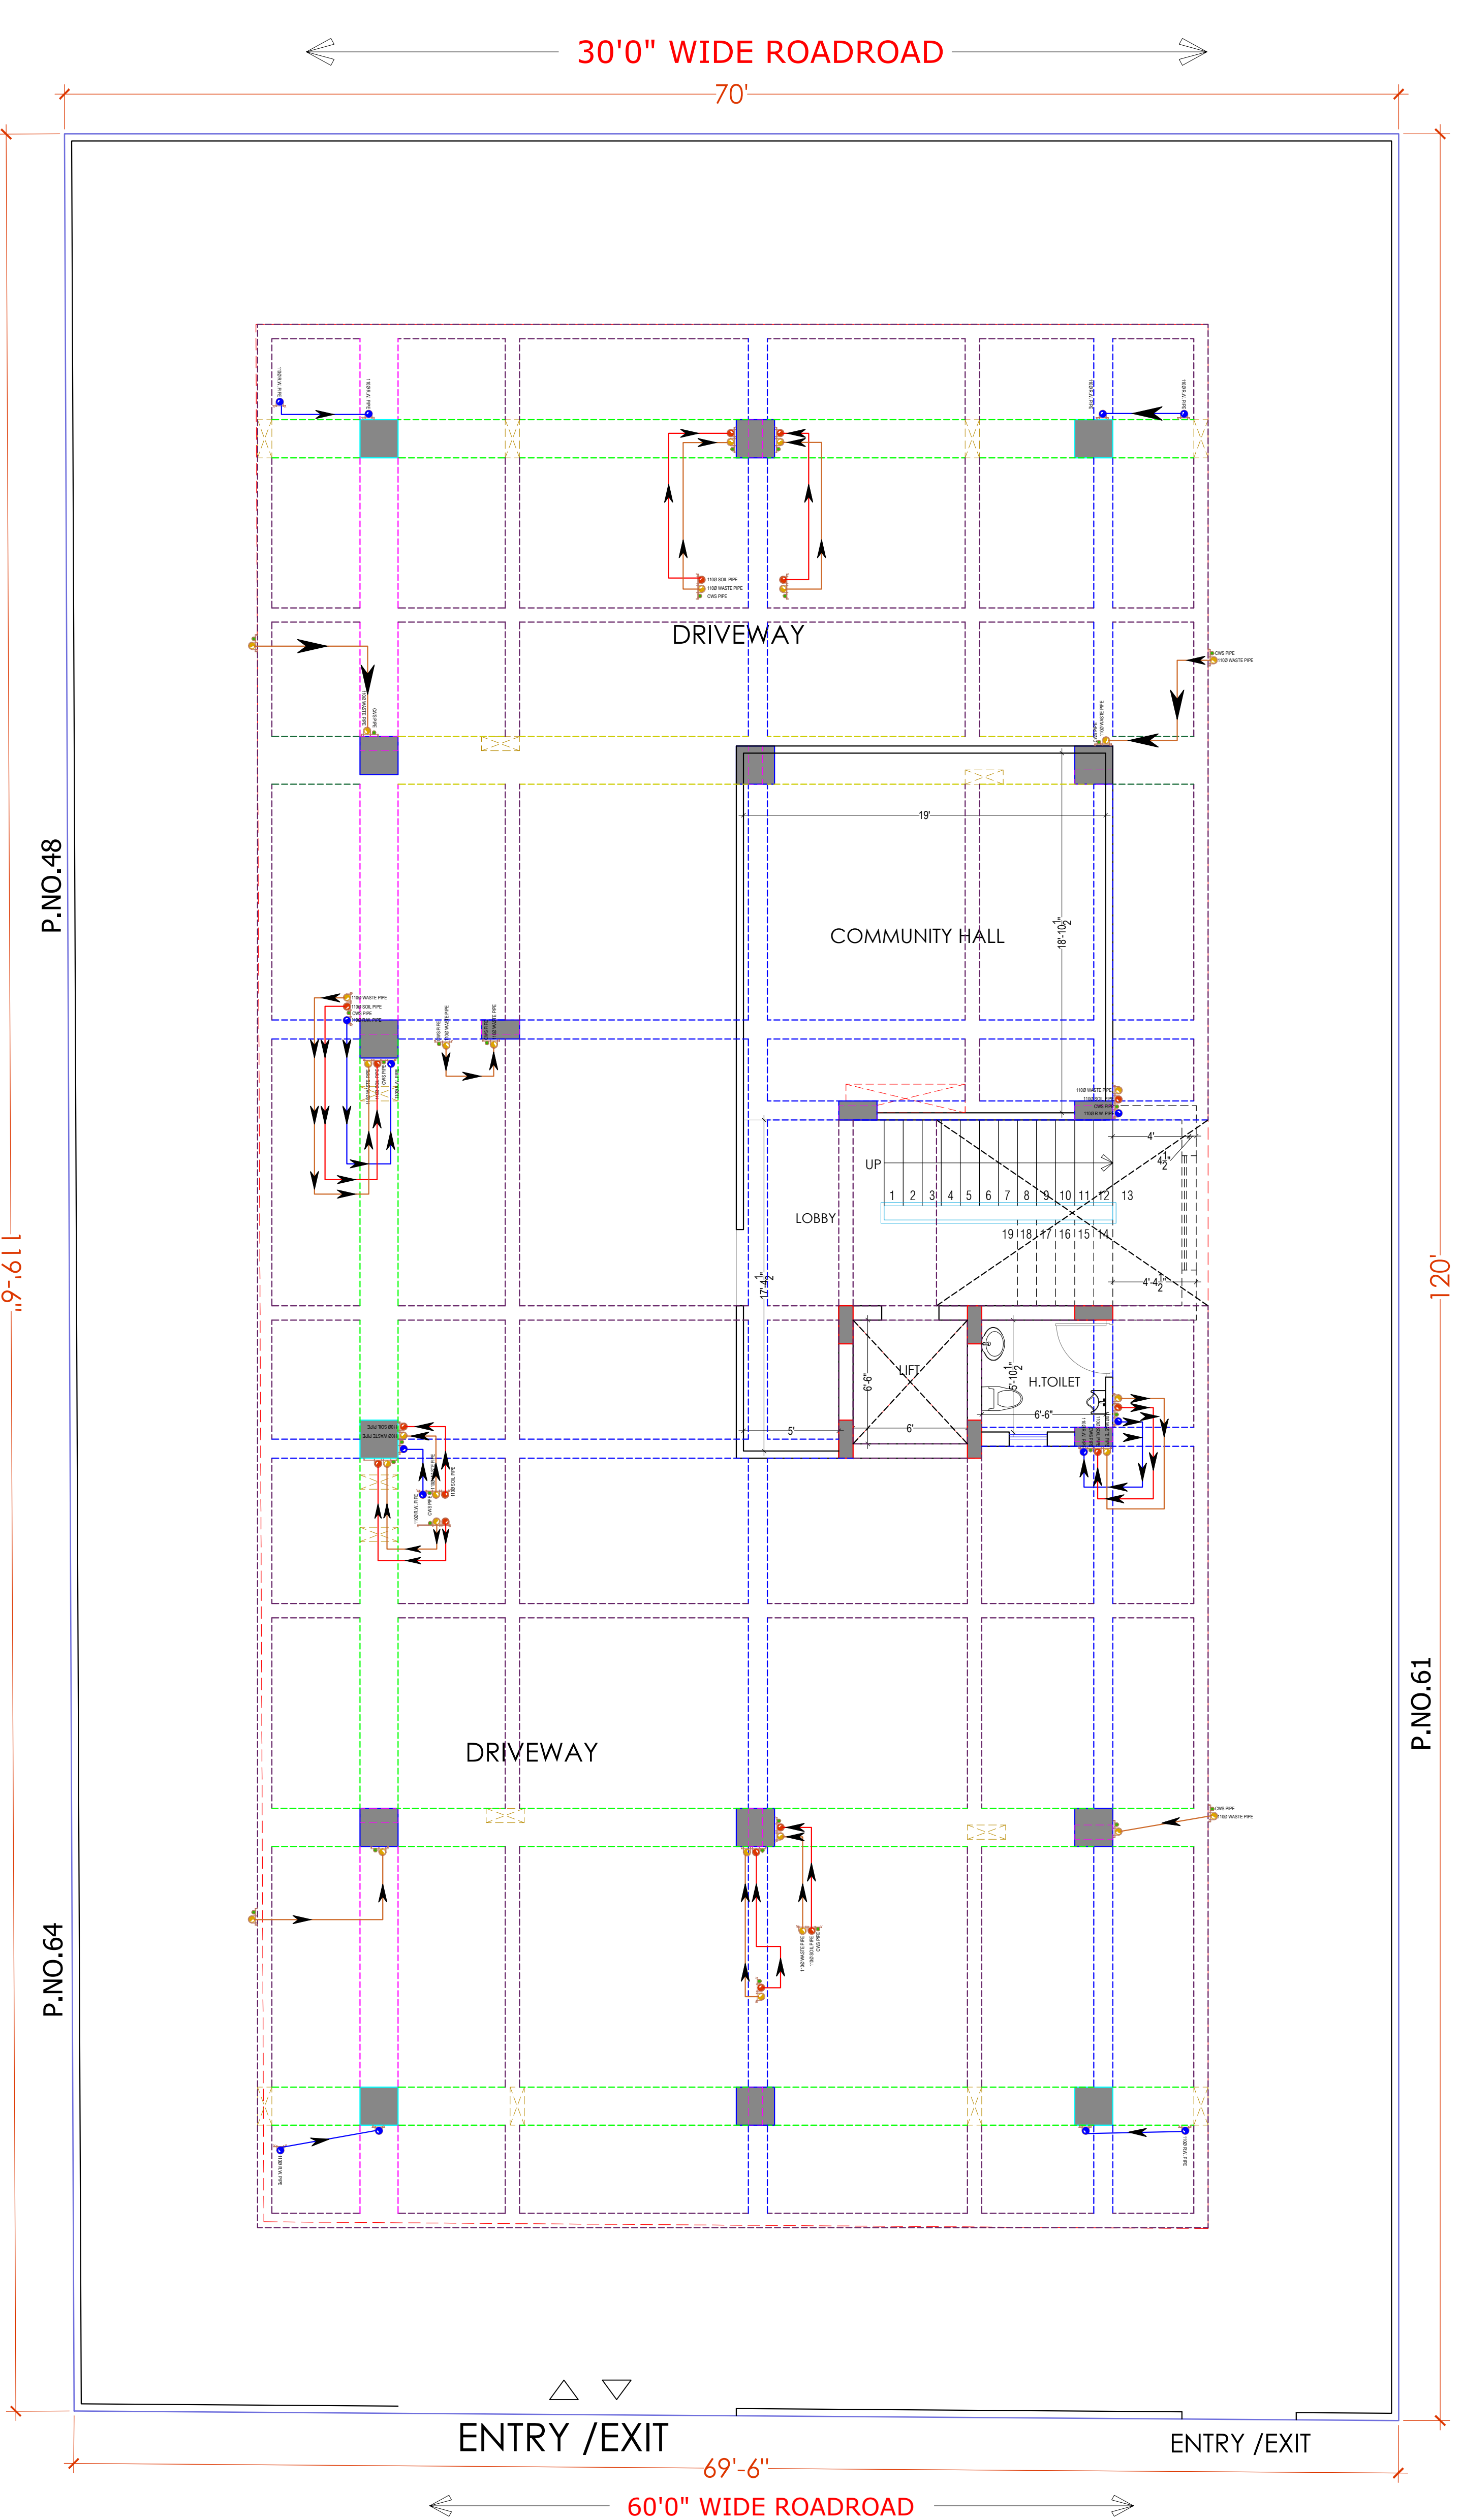

Er. SANJEEV SHARMA
B.E (Electrical)

For BALAJI BUILDERS
Proprietor

STILT FLOOR STORM WATER DRAINAGE LAYOUT & CEILING DRAINAGE LAYOUT PLAN

PROJECT NAME :
BALAJI AASHIYANA II

DEVELOPER NAME :
BALAJI BUILDER

ARCHITECTS :
4 INSIDE
ARCHITECTURE N INTERIORS
Plot no. 72, S.P. Marg , C- Scheme
jaipur, rajasthan, India
cont: +91 9950595991 , 91
9982812777
e.mail: 4insideofficial@gmail.com

LEGEND:-

①	SOIL PIPE	—
②	WASTE PIPE	—
③	VENT PIPE	—
④	COLD WATER SUPPLY (CWS)	—
⑤	HOT WATER SUPPLY (HWS)	—
	RAIN WATER PIPE	—
SW	SEWER LINE- EXTERNAL	—
RW	STORM WATER DRAINAGE PIPE	—
	SEWERAGE MANHOLE (2' x 2')	M.H.
	STORM WATER MANHOLE (2' x 2')	M.H.
GT	GULLY TRAP	
BV	BALL VALVE	
FT	FLOOR TRAP	
FD	FLOOR FLOOR DRAIN	
	RAIN WATER COLLECTION CHAMBER 450X450MM	
	KHURRA	

GENERAL NOTES :-

- All dimension on this drawing are in MKS System Only written dimensions are to be followed drawing should not be scaled.
- All measurements must be checked and verified by the contractors prior to execution of work at the site.
- This drawing is to be read in conjunction with all relevant structural, services & facility planning drawings.
- Architectural drawings are to be followed for the location of all structural members & masonry walls, for sizes & reinforcement details of structural members, relevant structural drawings are to be referred.
- Any discrepancies between architectural, structural and services drawings must be brought to the notice of the architects immediately & prior to execution at site.
- Co-ordinate with services such as hvac, plumbing & electrical, etc. is the responsibility of the contractors.
- All masonry walls should be aligned with the columns as indicated on the plan, irrespective of the position as calculated with the dimensions.
- For details, refer relevant large scale detail drgs. as indicated.

PROJECT:

PLOT NO. 49,50,62 & 63
SCHEME NO.17 LAXMAN REKHA
JAIPUR.

NAME OF DRAWING:

STILT FLOOR STORM WATER DRAINAGE LAYOUT & CEILING DRAINAGE LAYOUT PLAN

DRAWING

WORKING DRAWING

PROJECT NO. :

DATE :
21, Nov. - 2024


SCALE :
NTS

REV NO. :
R-0

DRAWING NO. :
PROJECT / CATEGORY / BLOCK / FLOOR / TYPE / NUMBER
A-201

DRAWING PATH :

NORTH:

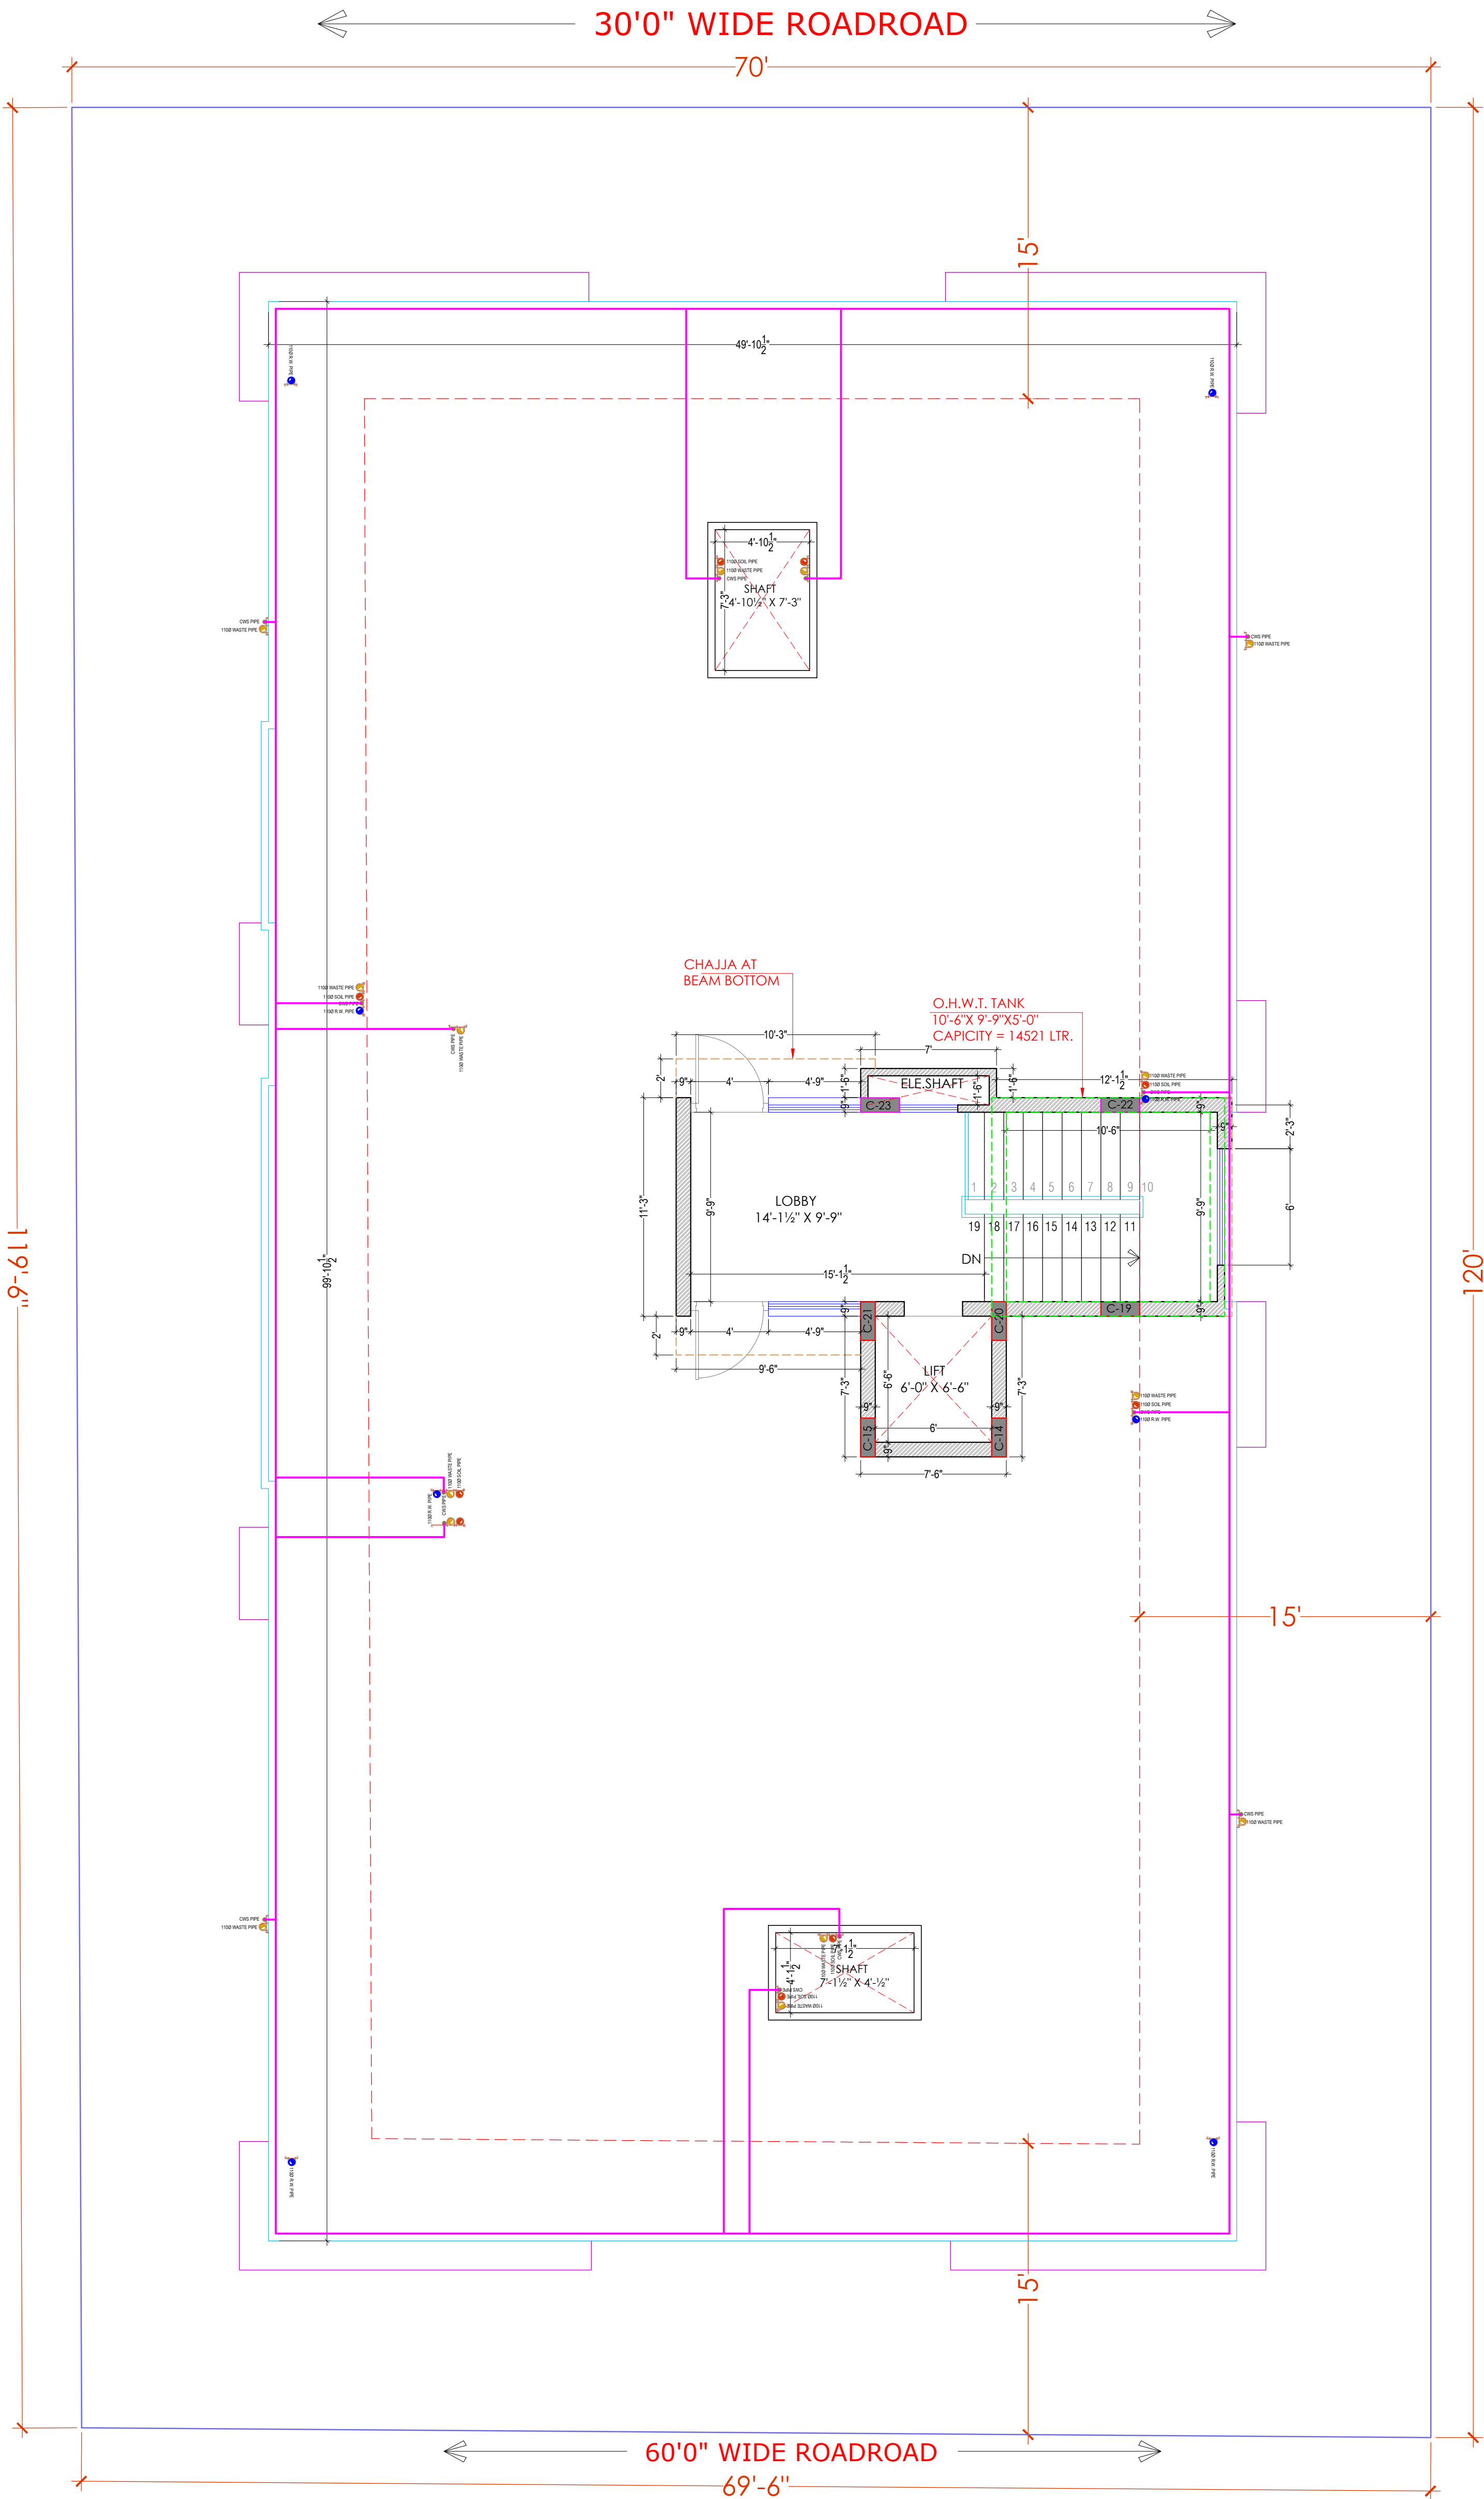

Er. SANJEEV SHARMA
B.E (Electrical)

For BALAJI BUILDERS
Proprietor

PROJECT NAME :
BALAJI AASHIYANA II

DEVELOPER NAME :
BALAJI BUILDER

ARCHITECTS :
4 INSIDE
ARCHITECTURE N INTERIORS
Plot no. 72, S.P. Marg , C- Scheme
jaipur, rajasthan, India
cont: +91 9950595991 , 91
9982812777
e.mail: 4insideofficial@gmail.com

LEGEND:-		
①	SOIL PIPE	
②	WASTE PIPE	
③	VENT PIPE	
④	COLD WATER SUPPLY (CWS)	
⑤	HOT WATER SUPPLY (HWS)	
	RAIN WATER PIPE	
SW	SEWER LINE- EXTERNAL	
RW	STORM WATER DRAINAGE PIPE	
	SEWERAGE MANHOLE (2' x 2')	M.H.
	STORM WATER MANHOLE (2' x 2')	M.H.
GT	GULLY TRAP	
BV	BALL VALVE	
FT	FLOOR TRAP	
FD	FLOOR FLOOR DRAIN	
	RAIN WATER COLLECTION CHAMBER 450X450MM	
	KHURRA	

- GENERAL NOTES :-
- All dimension on this drawing are in MKS System Only written dimensions are to be followed drawing should not be scaled.
 - All measurements must be checked and verified by the contractors prior to execution of work at the site.
 - This drawing is to be read in conjunction with all relevant structural, services & facility planning drawings.
 - Architectural drawings are to be followed for the location of all structural members & masonry walls, for sizes & reinforcement details of structural members, relevant structural drawings are to be referred.
 - Any discrepancies between architectural, structural and services drawings must be brought to the notice of the architects immediately & prior to execution at site.
 - Co-ordinate with services such as hvac, plumbing & electrical, etc. is the responsibility of the contractors.
 - All masonry walls should be aligned with the columns as indicated on the plan, irrespective of the position as calculated with the dimensions.
 - For details, refer relevant large scale detail drgs. as indicated.

PROJECT:
PLOT NO. 49,50,62 & 63
SCHEME NO.17 LAXMAN REKHA
JAIPUR.

NAME OF DRAWING:

TERRACE FLOOR FLOOR RING MAIN LAYOUT,
WATER SUPPLY SYSTEMATIC DIAGRAM ,UG WATER
TANK TO OHT FILLING ROUTE PLAN

DRAWING WORKING DRAWING	NORTH:
PROJECT NO. :	DATE : 21, Nov. - 2024
SCALE : NTS	REV NO. : R-0

DRAWING NO. :						DRAWING PATH :
PROJECT	CATEGORY	BLOCK	FLOOR	TYPE	NUMBER	
						A-201

TERRACE FLOOR FLOOR RING MAIN LAYOUT, WATER SUPPLY SYSTEMATIC DIAGRAM ,
UG WATER TANK TO OHT FILLING ROUTE PLAN