


PLOT NO. 244

25.00

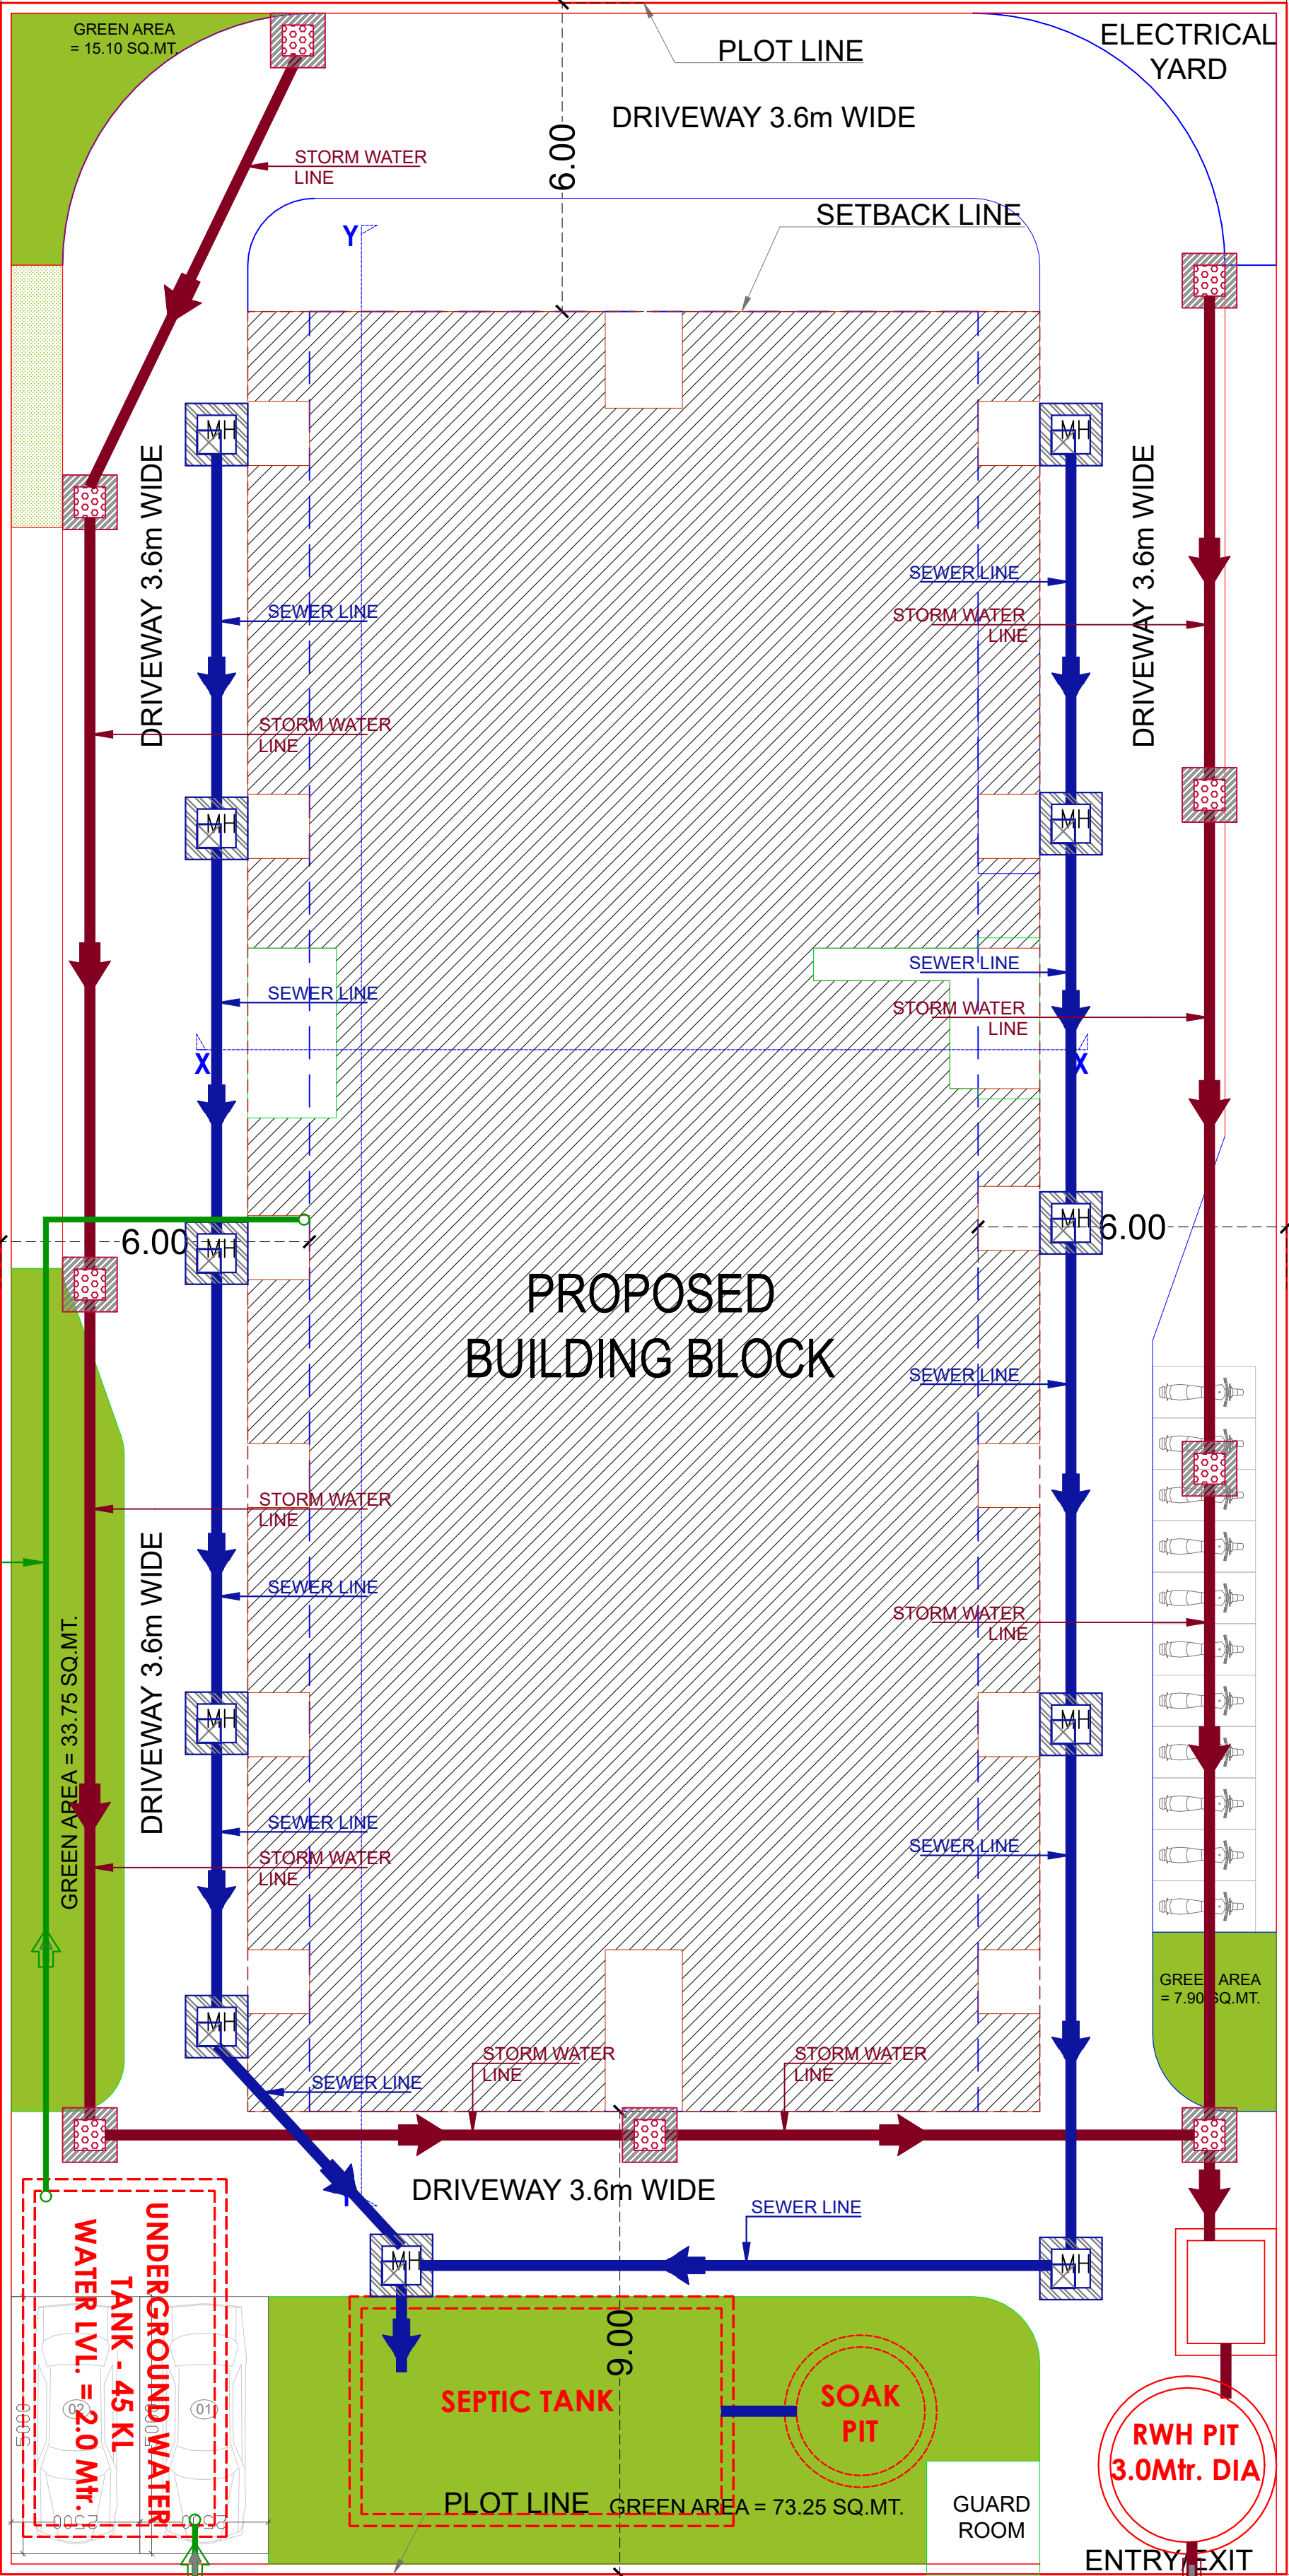

SHEET NO. - 01 /06

STILT FLOOR PLAN

SOMANATH BEHARA
BTECH (CIVIL)

TITLE:- SUBMISSION DRAWINGS
PLUMBING SITE PLAN

SCALE:- 1= 100

DATE : 14/02/2025



PROJECT:-

PLOT NO. 259, BLOCK-C, SEZ
(SETTLEMENT) SCHEME, VILLAGE
BHAMBORIYA, TEHSIL SANGANER, JAIPUR
(RAJASTHAN)

ARCHITECTS:-

PANKAJ GUPTA & ASSOCIATES
Flat no. 603 B, Golden Leaf Apartment, Tonk
Road, Near Gandhi Nagar Station, Jaipur-15

OWNER

ARCHITECTS


PLOT NO. 244

25.00

REAR

SETBACK LINE

6.00

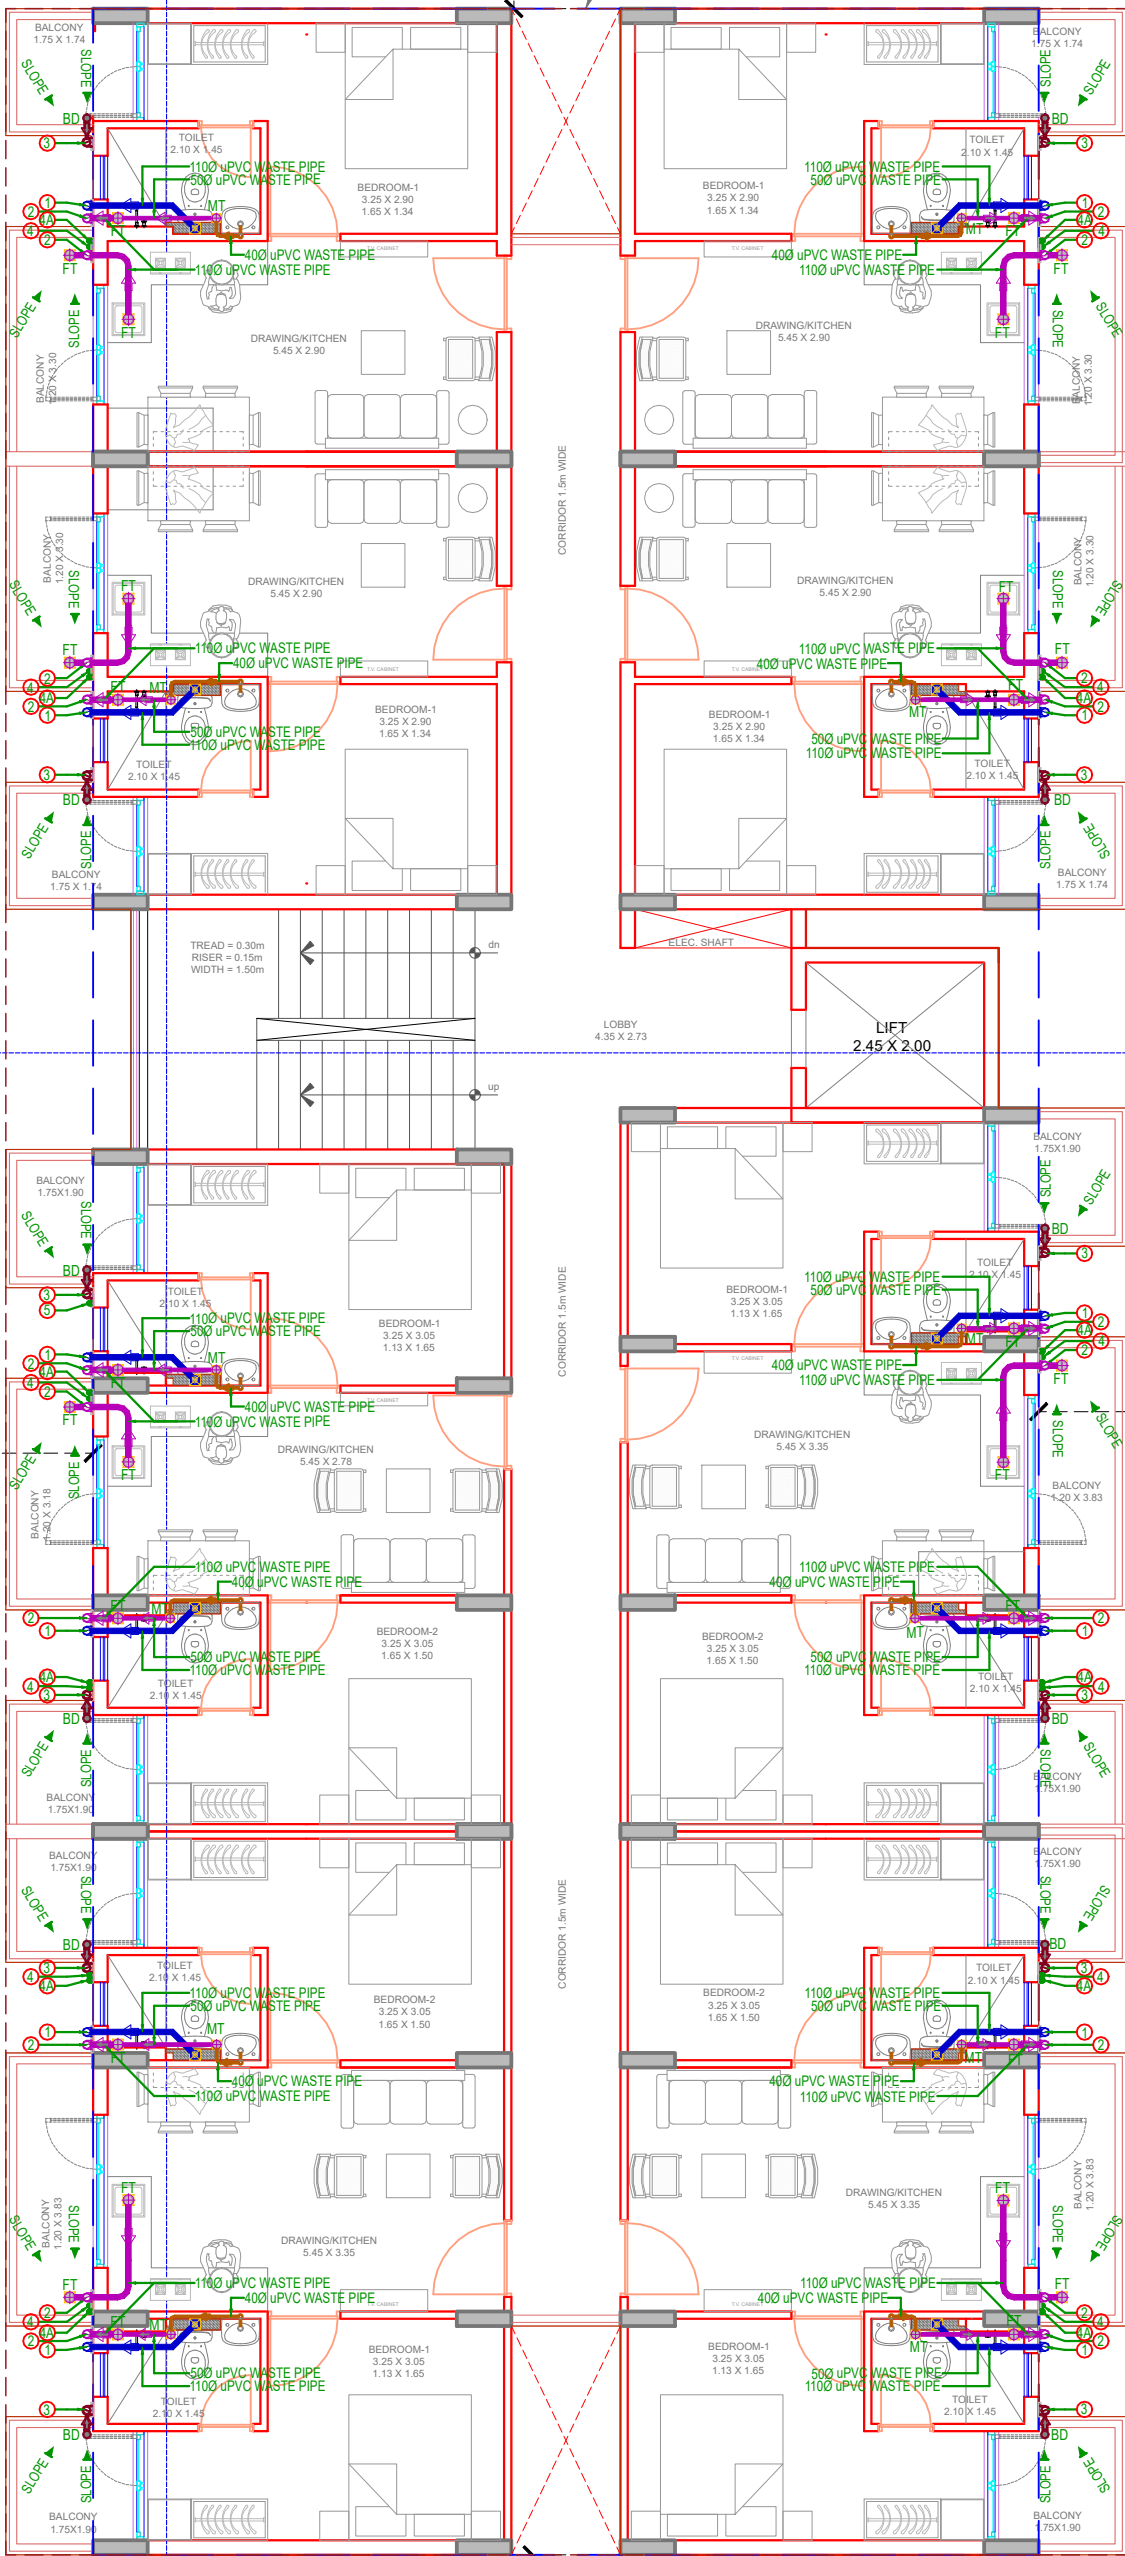

FRONT

SETBACK LINE

9.00

EAST SIDE

WEST SIDE

6.00

6.00

PLOT NO. 258

50.00

PLOT NO. 260

ROAD 18.0M WIDE

SHEET NO. - 02 /06

TYPICAL FLOOR PLAN
(1ST TO 8TH)

SOMANATH BEHARA
BTECH (CIVIL)

PLUMBING NOTES:-

- | | |
|---|---|
| 1 | WASH BASIN TO MULTI TRAP (MT) 40 OD uPVC 6 KG PIPE. |
| 2 | (MT) TO FLOOR TRAP (FT) 50 OD uPVC WASTE PIPE |
| 3 | 110 OD uPVC PIPE USED FOR SOIL & WASTE. |
| 4 | 110 OD uPVC PIPE USED FOR TERRACE RAIN WATER |

PLUMBING LEGEND:-

- | | |
|--|---------------------------|
| | FT FLOOR TRAP 110X110mm |
| | MT MULTI TRAP 110X50mm |
| | FD FLOOR DRAIN 110X63mm |
| | BD BALCONY DRAIN 110X63mm |

SCHEDULE OF PIPES

PIPE NO.	DESCRIPTION
1	110 OD uPVC SWR TYPE B SOIL PIPE
2	110 OD uPVC SWR TYPE B WASTE PIPE
3	110 OD uPVC RAIN WATER PIPE FOR TERRACE
4	DOMESTIC WATER SUPPLY D/N TAKE PIPE BELOW FLOORS
4A	DOMESTIC WATER SUPPLY D/N TAKE PIPE TOP 3 FLOORS
5	WATER SUPPLY RISER PIPE * (DOMESTIC)
6	90 OD uPVC RAIN WATER PIPE FOR BALCONY

TITLE:- SUBMISSION DRAWINGS
TYPICAL FLOOR DRAINAGE PLAN
(1ST TO 8TH)

SCALE:- 1= 100

DATE : 14/02/2025



PROJECT:-

PLOT NO. 259, BLOCK-C, SEZ
(SETTLEMENT) SCHEME, VILLAGE
BHAMBORIYA, TEHSIL SANGANER, JAIPUR
(RAJASTHAN)

ARCHITECTS:-

PANKAJ GUPTA & ASSOCIATES
Flat no. 603 B, Golden Leaf Apartment, Tonk
Road, Near Gandhi Nagar Station, Jaipur-15

OWNER

ARCHITECTS