


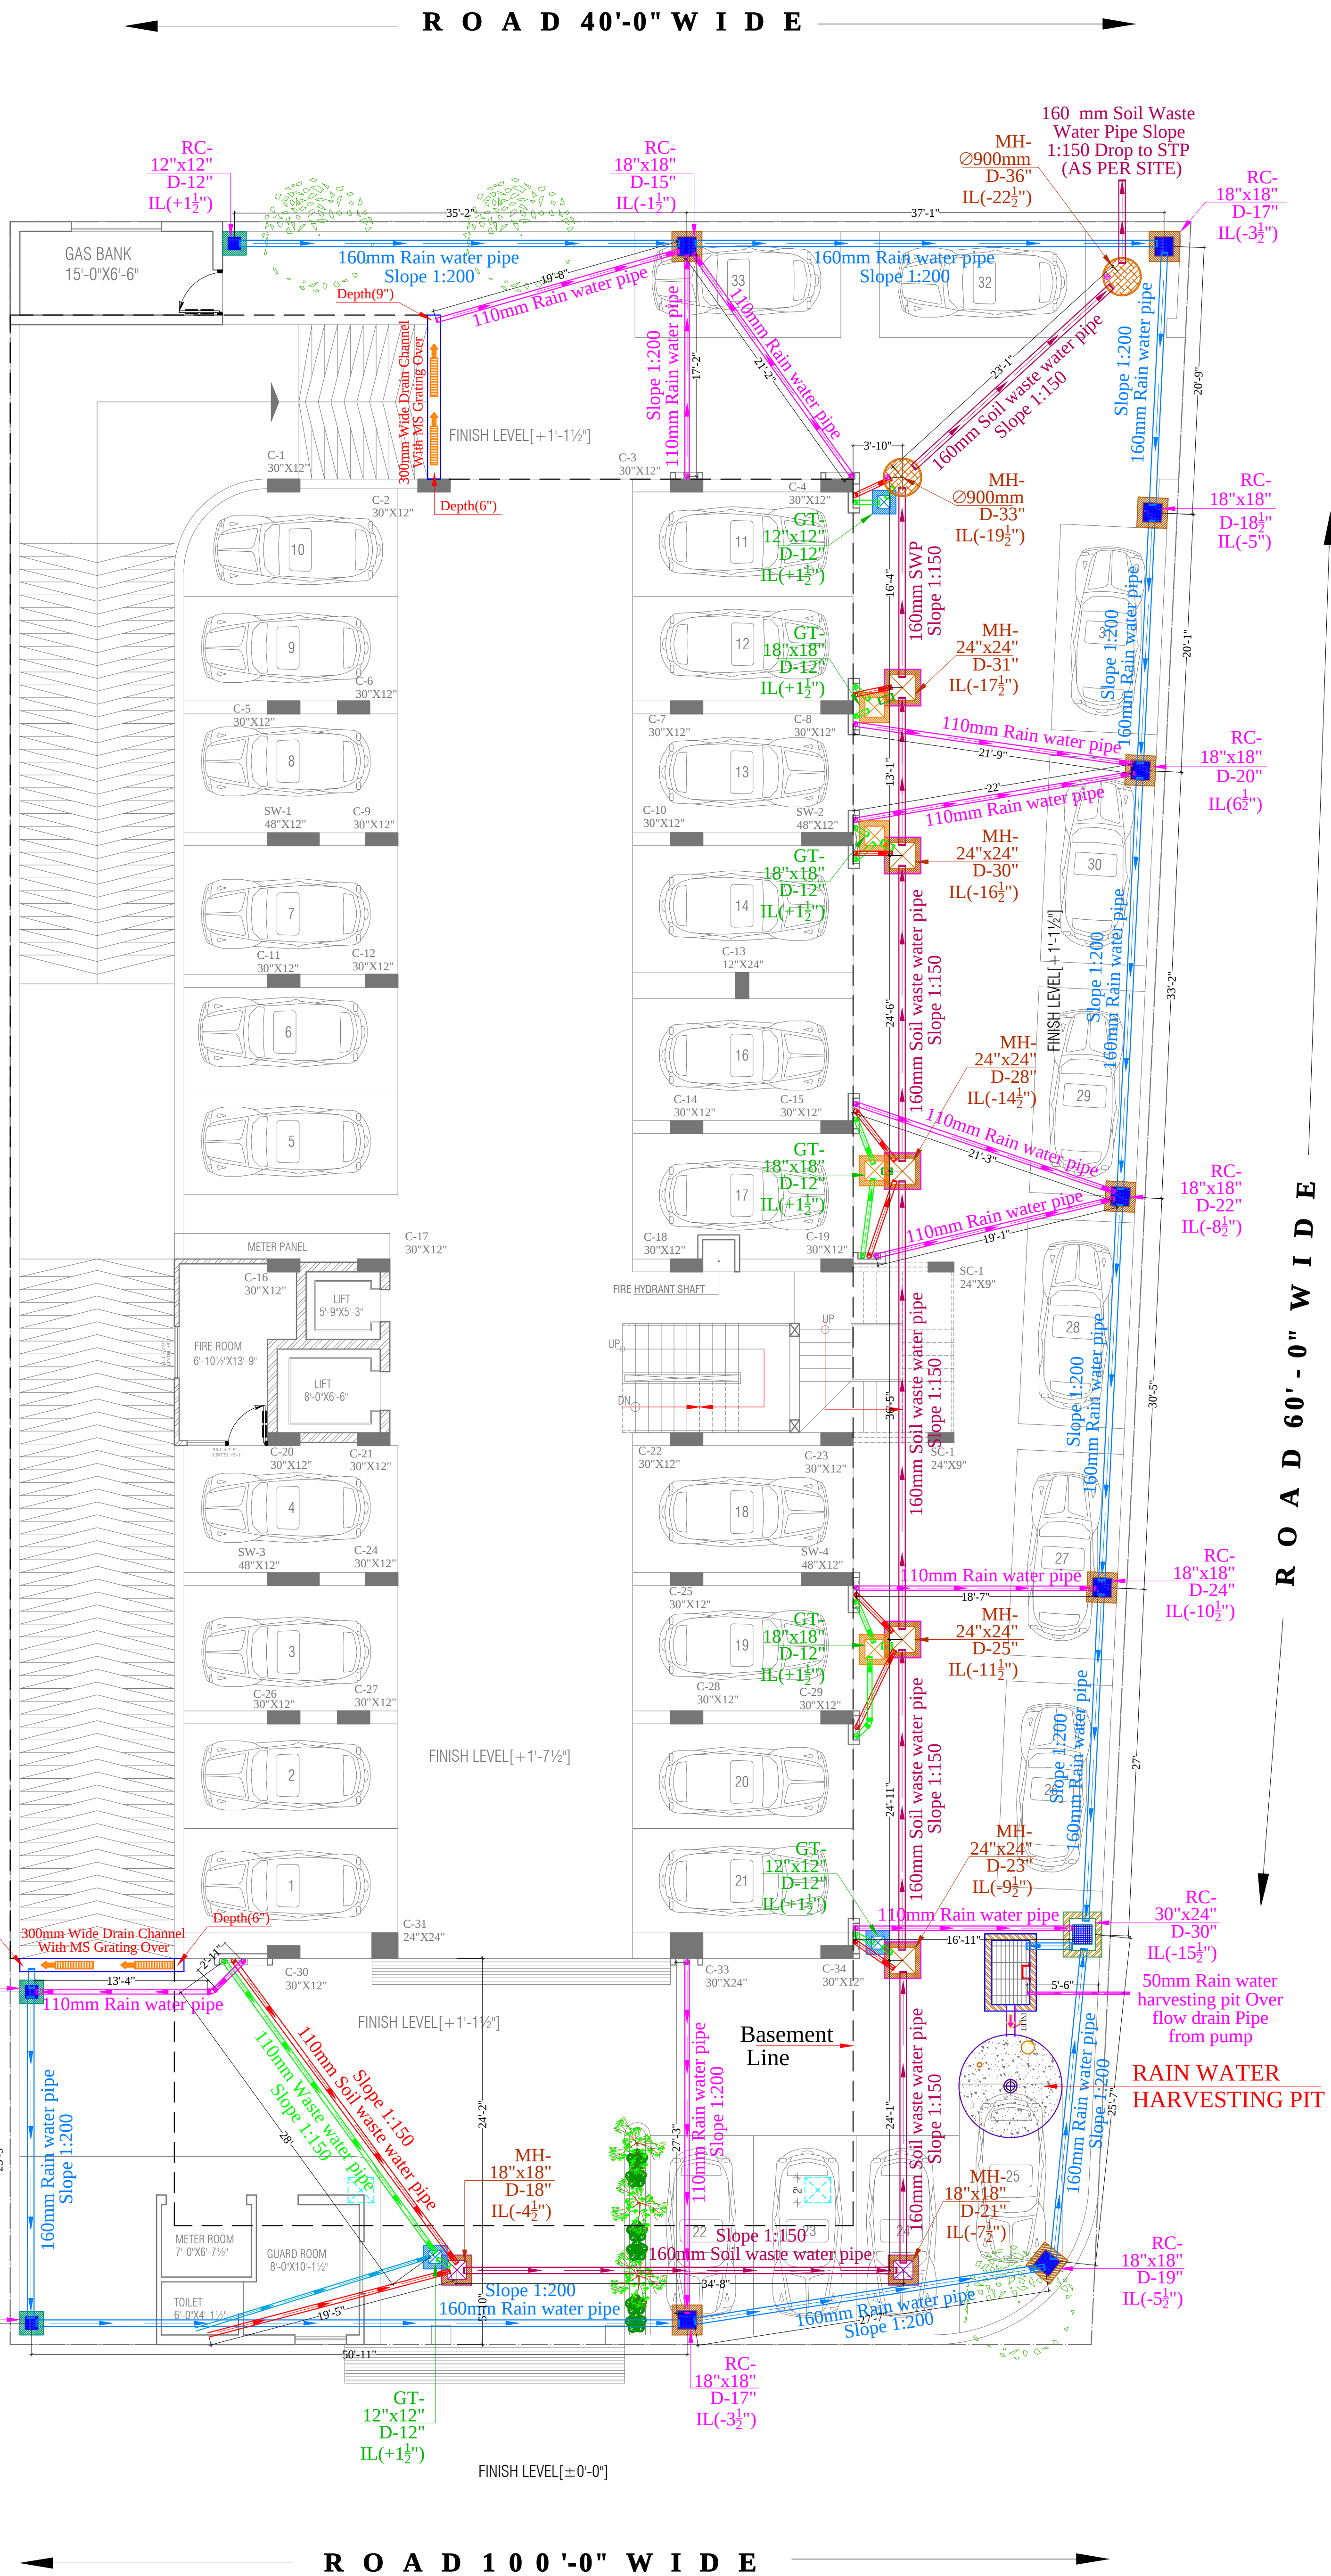

LEGENDS:-

	GULLY TRAP 300X300MM
	GULLY TRAP 450X450MM
	SEWERAGE MANHOLE 900 mm Dia
	SEWERAGE MANHOLE 600X600MM
	SEWERAGE MANHOLE 450X450MM
	RAIN WATER CHAMBER 300X300 MM
	RAIN WATER CHAMBER 450X450 MM
	RAIN WATER CHAMBER 750X600 MM
	RAIN WATER HARVESTING PIT

PIPES & SLOPE DETAIL :-

	N 160mm RAIN WATER PIPE SLOPE 1:200
	N 110mm RAIN WATER PIPE SLOPE 1:200
	N 160mm SOIL WATER PIPE SLOPE 1:150
	N 110mm SOIL WATER PIPE SLOPE 1:150
	N 160mm WASTE WATER PIPE SLOPE 1:150
	N 110mm WASTE WATER PIPE SLOPE 1:150

SERVICES CONSULTANT:
VIPUL CONSULTING,
F 9 / 440 , Keshav Marg Chitrakut Scheme,Jaipur
PH:91-0-93146-10438, 0141-2440946 Mail:vipul8599@yahoo.com
REV. NO. 00 DATE: 15-04-2017

Project:

Proposed Residential Building
At Plot - Flats -E In Surya City
N.H.-11 Fatehpur Sikri Road,
Bharatpur Rajasthan.


Owner:

Surya Builders & Developers

Drawing:

Stilt Floor External
Drainage Plan

North:

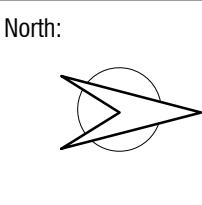

DATE: 15 APRIL 2017

Location:
Gopalpura bye-pass,Jaipur, Rajasthan
name :- Devendra
File no:



Plot no. 65, Acme Heights,Vishwaswari Nagar,
Behind D.C. Hospital, Triveni nagar,
Gopalpura bye-pass,Jaipur, Rajasthan
ph: 0141-2763533, 9828117586
E-mail: sunil@designspaceconsultants.com
Website: www.designspaceconsultants.com



SERVICES CONSULTANT:
VIPUL CONSULTING.
F 9 / 440 , Keshav Marg Chitrakut Scheme,Jaipur
PH:91-0-93146-10438 ,0141-2440946 Mail:vipul8599@yahoo.com
REV. NO. 02,DATE:-04-04-2017

Project:

Proposed Residential Building
At Plot - Flats -E In Surya City
N.H.-11 Fatehpur Sikri Road,
Bharatpur Rajasthan.

Owner:

Surya Builders & Developers

Drawing:

TYPICAL FLOOR INTERNAL
DRAINAGE PLAN

North:

DATE: 31-05-2017
Location:


Drawn.by:-
RAAJ

Appd. By:-
SANJAY

name :- Shyam
File no: 495

ADDRESS:
Architects & Interior Designer

Plot no. 65, Acme Heights, Visheshwaria Nagar,
Behind D.C. Hospital, Triveni nagar,
Gopalpura bye-pass Jaipur, Rajasthan
ph: 0141-2763533, 9828117586
E-mail: sunil@designspaceconsultants.com
Website: www.designspaceconsultants.com

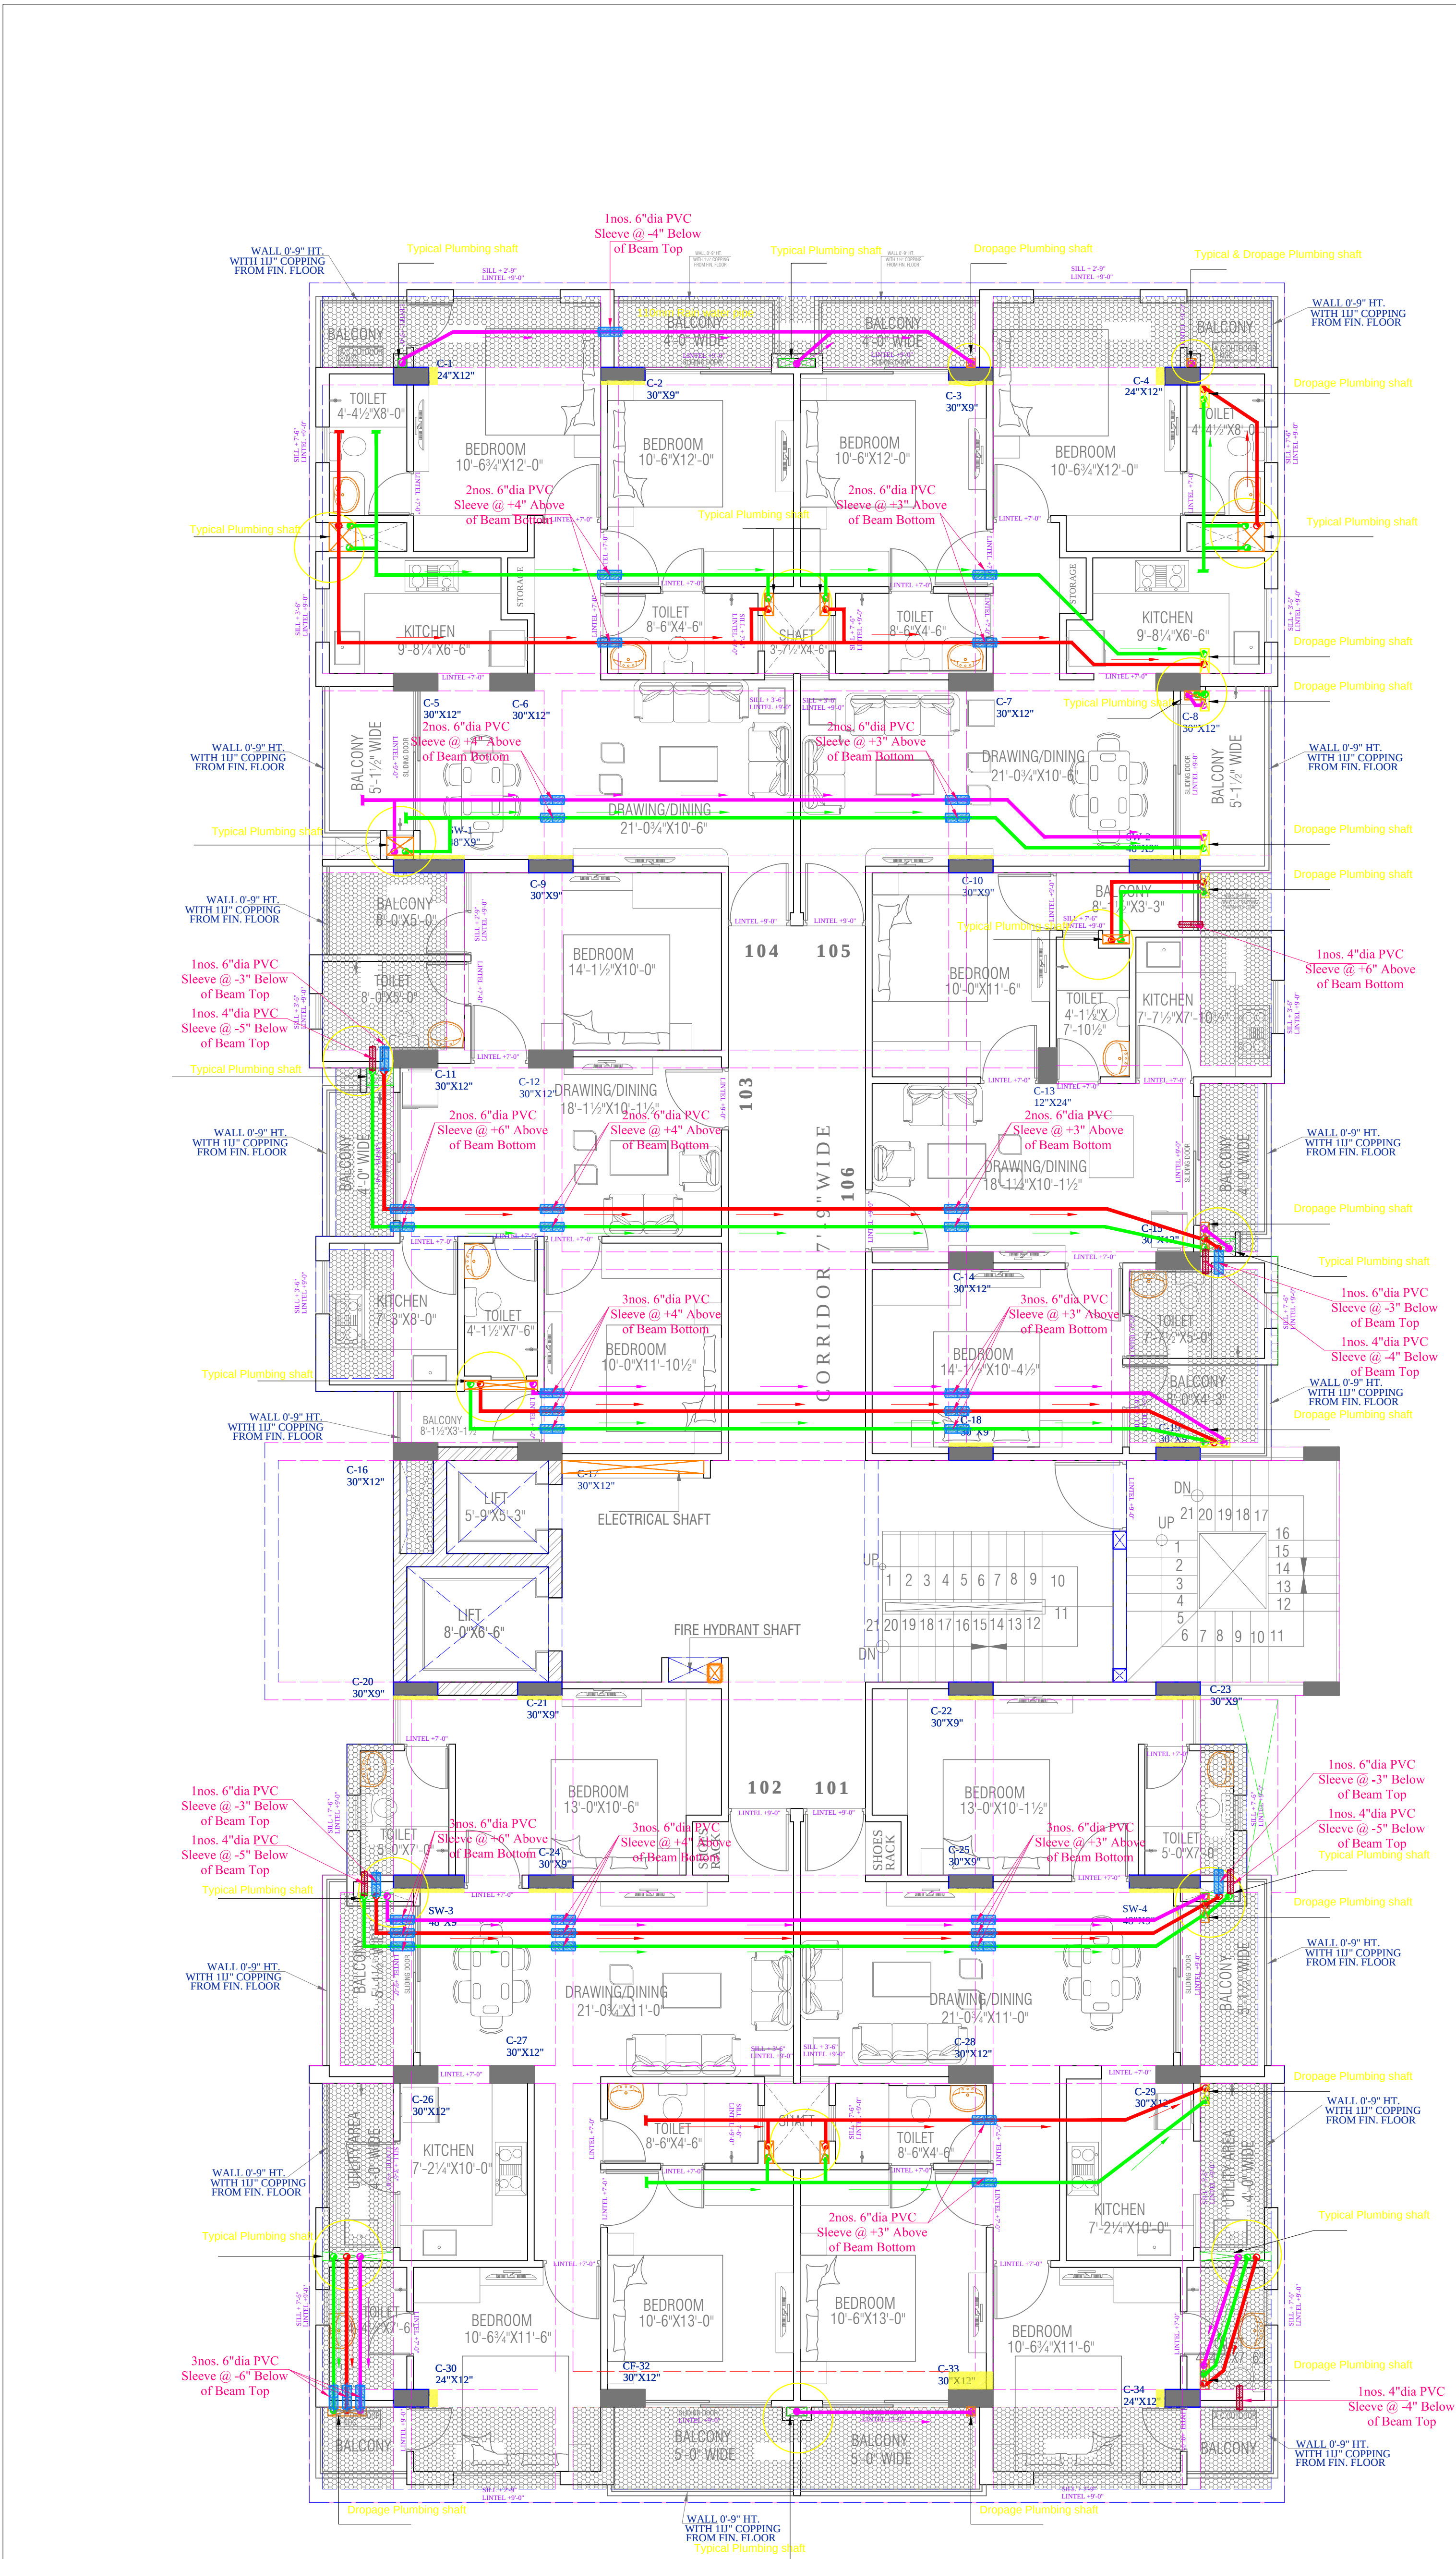

GENERAL NOTES :-

1. IN CASE OF ANY AMBIGUITY BETWEEN THE ARCHITECT AND THE STRUCTURAL DRAWING PLEASE INFORM THE ARCHITECT.

2. THIS DRAWING IS THE PROPERTY OF STUDIO AND ITS USE IN ANY MANNER BY ANY PERSON IS PROHIBITED.

NOTES :-

REVISIONS :-

NO.	DATE	REMARKS
1		
2		
3		
4		
5		

PRINTS ISSUED :-

NOS.	DATE	

SYMBOL	DESCRIPTION
	110 mm Soil Waste Water Pipe
	110 mm Waste Water Pipe
	110 mm Rain Water Pipe
	110 mm Soil Waste Water Pipe
	110 mm Waste Water Pipe
	110 mm Rain Water Pipe
	CUT IN SLAB FOR SERVICES SHAFT
	6"Dia pvc Sleeve in beam for drainage pipe
	4"Dia pvc Sleeve in beam for drainage pipe

SERVICES CONSULTANT:

VIPUL CONSULTING,

F 9 / 440 , Keshav Marg Chitrakut

Scheme,Jaipur

PH:91-0-93146-10438 ,0141-2440946

Mail:vipul8599@yahoo.com

REV. NO. 000 DATE: 04-10-2016

Project:

Proposed Residential Building

At Plot - Flats -E In Surya City

N.H.-11 Fatehpur Sikri Road,

Bharatpur Rajasthan.

Owner:

Surya Builders & Developers

Drawing:

First Floor Drainage dropage

route plan

North:

DATE: 04 oct. 2016

Location:

(\\nasirserver-pc\E\Drawings\Bharatpur\Main\j) WORKING CENTER LINE PLAN

name :- Shyam

File no: 495

Design Space Consultants

Architects & Interior Designer

Plot no. 65, Acme Heights, Vishwaswari Nagar,


Behind D.C. Hospital, Triveni nagar,

Gopalpura bye-pass Jaipur, Rajasthan

ph: 0141-2763533, 9826117586

E-mail: sunil@designspaceconsultants.com

Website: www.designspaceconsultants.com

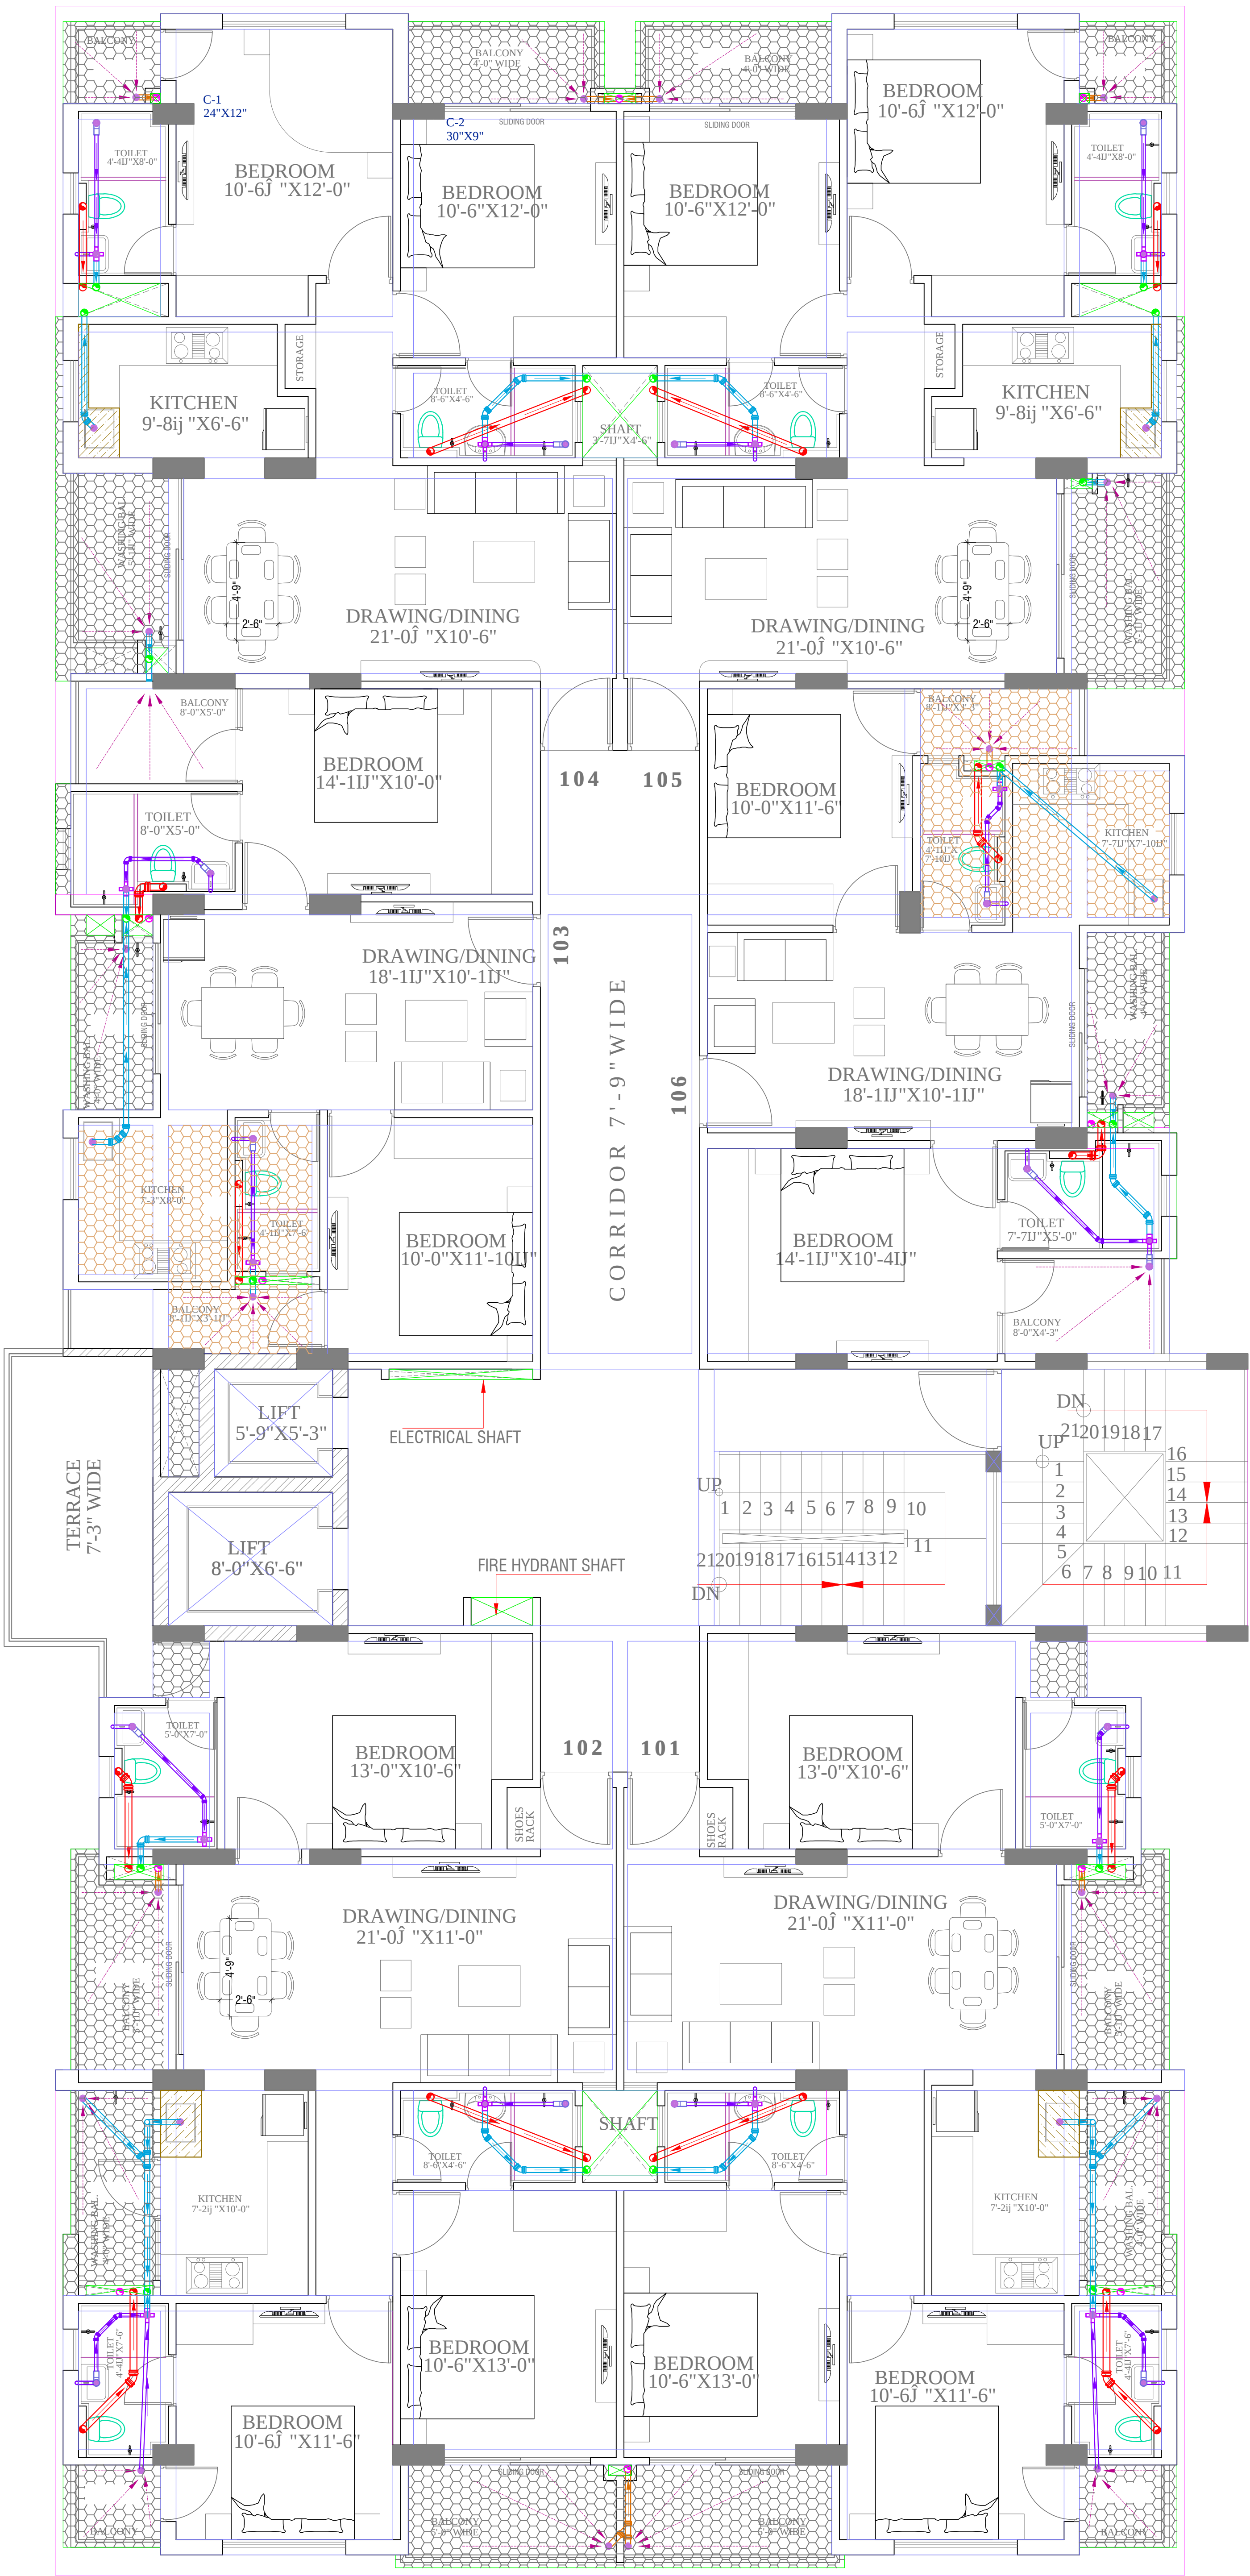

SYMBOL	DESCRIPTION
	110 mm Soil Waste Water Pipe
	110 mm Waste Water Pipe
	110 mm Rain Water Pipe
	110 mm Soil Waste Water Pipe
	110 mm Waste Water Pipe
	110 mm Rain Water Pipe
	75 mm Waste Water Pipe Internal Toilet
	75 mm Rain Water Pipe
	50mm Waste Water Pipe Bottle Trap
	Floor Trap
	Nahani Trap
	Multi Trap
	Vertical MS Grating Cover
	Flow Direction
	6" Platform Raise

SERVICES CONSULTANT:
VIPUL CONSULTING.
F 9 / 440 , Keshav Marg Chitrakut Scheme,Jaipur
PH:91-0-93146-10438 ,0141-2440946 Mail:vipul8599@yahoo.com
REV. NO. 02,DATE:-04-04-2017

Project:
**Proposed Residential Building
At Plot - Flats -E In Surya City
N.H.-11 Fatehpur Sikri Road,
Bharatpur Rajasthan.**

Owner:
Surya Builders & Developers

Drawing:
**TYPICAL FLOOR INTERNAL
DRAINAGE PLAN**

North:		DATE: 31-05-2017
Drawn.by:-	Appd. By:-	Location:
RAAJ	SANJAY	name :- Shyam
		File no: 495

**Design
Space
Consultants**
Architects & Interior Designer

Plot no. 65, Acme Heights, Visheswaria Nagar,
Behind D.C. Hospital, Triveni nagar,
Gopalpura bye-pass Jaipur, Rajasthan
ph: 0141-2763533, 9828117586
E-mail: sunil@designspaceconsultants.com
Website: www.designspaceconsultants.com