


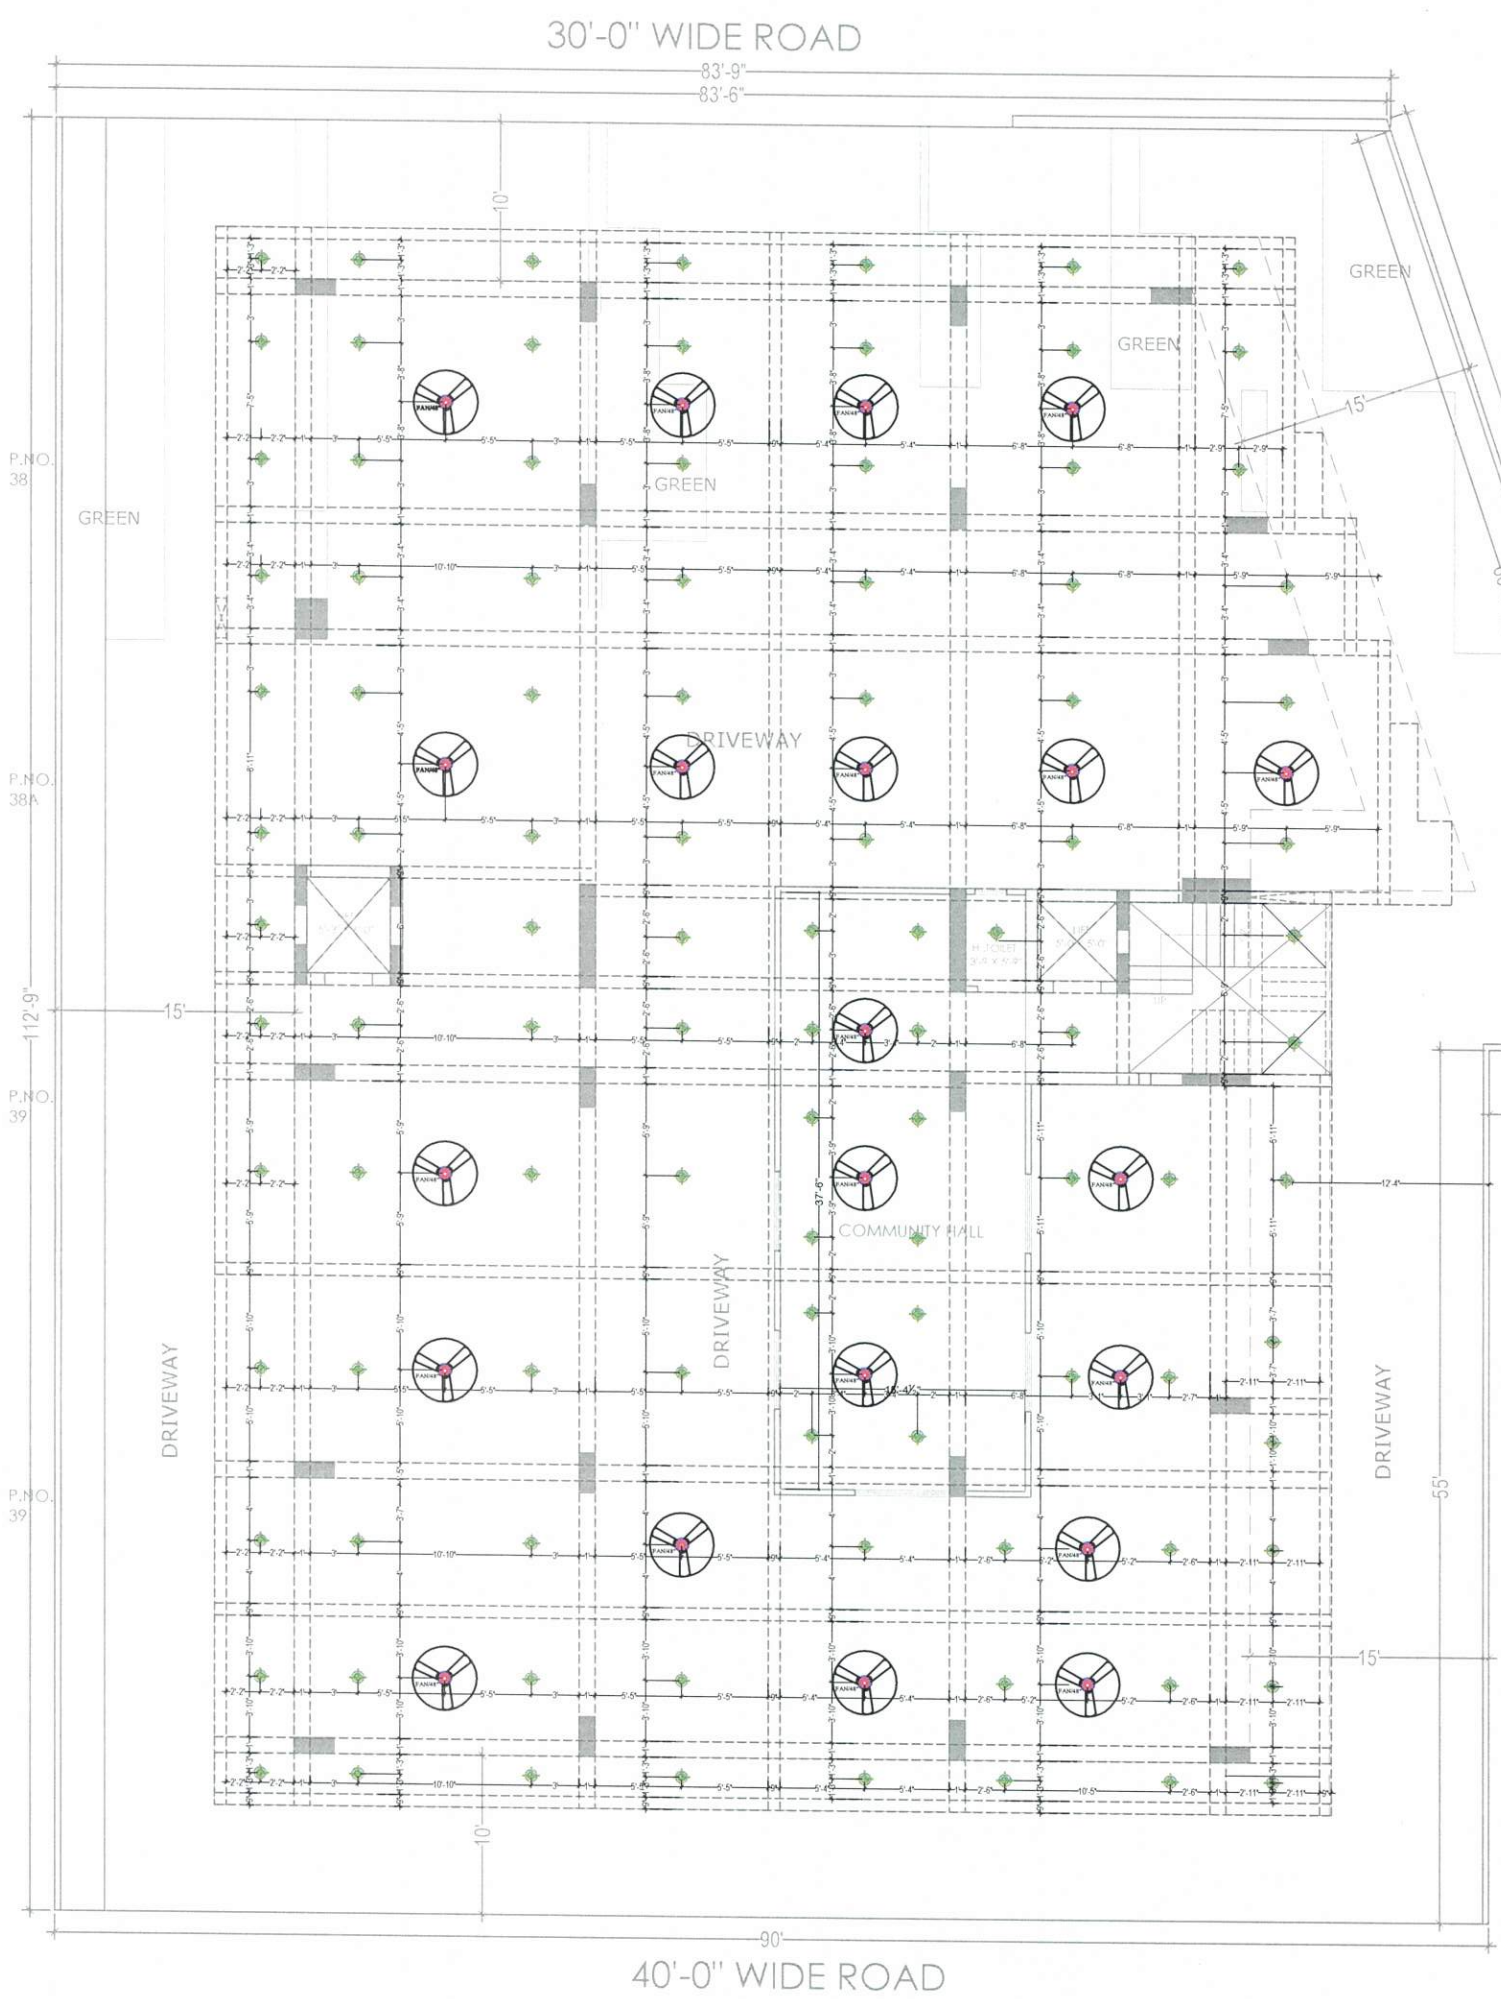

**STILT FLOOR
ELECTRICAL LAYOUT**

LEGEND	
SYMBOL	DESCRIPTION
	DISTRIBUTION BOX
	SWITCH BOARD (BA SOCKET & SWITCHES)
	16A SOCKET WITH SWITCH
	6A POWER SOCKET WITH SWITCH
	CAMERA
	SPLIT AC
	COMPUTER POINT
	TOILET MIRROR LIGHT 1x16w
	WALL FAN
	CEILING LIGHT
	TUBE LIGHT
	WALL BRACKET LED LIGHT
	1 x 14 W MIRROR LIGHT
	900 / 1200 MM SWEEP CEILING FAN
	EXHAUST FAN
	1 x 72 W CHANDELIER LIGHT
	3 x 8 W CONCEALED FOOT LIGHT
	6A SS FAN REGULATOR, TL SWITCH @ HT 2'6"
	6A SS 25A AC @ HT 2'6"
	6A 2 NOS SOCKET - 1 NOS
	16A SWITCH - TV COAXIAL SOCKET @ HT 3'6"
	16A SS FOR GEYSER & 6A SS FOR RO @ HT 5'6"
	16A SS FOR MICROWAVE & 6A SS FOR MIXER @ HT 5'6"
	6A SS FOR CHIMNEY @ HT 5'6"
	16A SS FOR FRIDGE @ HT 5'6"
	3 x 1.5 SOMM LIGHT CONTROL CU. WIRE
	3 x 1.5 SOMM 2 WAY LIGHT CONTROL WIRE
	3 x 2.5 SOMM CU. WIRE FOR AC IDU
	3 x 4.0 SOMM CU. WIRE FOR POWER CIRCUIT
	3 x 2.5 SOMM CU. WIRE FOR LIGHT CIRCUIT
	CAT-6 LAN WIRE RJ-45 JACK TO LAN SWITCH
	2 PAIR TELEPHONE WIRE RJ-11 JACK TO TTB
	RG-6 TV CABLE SETUP BOX TO TV SPLITTER
	CAT-6 CCTV CABLE CCTV CAMERA TO NVR

CLIENT :

Mr. NATHU JI

ARCHITECTS :

4 INSIDE

ARCHITECTURE N INTERIORS

Plot no. 72, S.P. Marg, C- Scheme
jaipur, rajasthan, India
cont: +91 9950595991, 91 9982812777
e.mail: jeets.arch@gmail.com

STRUCTURAL CONSULTANTS:

MEP CONSULTANT : --

SHRI SHYAM CONSULTANT

PLUMBING | FIRE | ELECTRICAL | STP | IWT/P

JAIPUR-302006

PH.NO. +91 9785427711

DEALT BY	REVISION	DATE
RAMESH	00	23.10.2023

Er. SANJAY SHARMA
B.L. Electrical

GENERAL NOTES :

- All dimensions on this drawing are in MMS System. Only written dimensions are to be followed. Drawing should not be scaled.
- All measurements should be checked and verified by the contractor prior to execution of work at the site.
- This drawing is to be read in conjunction with all relevant structural, services & facility planning drawings.
- Architectural drawings are to be followed for the location of all structural members & masonry walls, for doors & reinforcement details of structural members. Relevant structural drawings are to be referred.
- Any discrepancies between architectural, structural and services drawings must be brought to the notice of the architect immediately & prior to execution of work. Co-ordination with services such as fire, plumbing & electrical, etc. is the responsibility of the contractor.
- All masonry walls should be aligned with the columns as indicated on the plan irrespective of the position as calculated with the dimensioning.
- For details, refer relevant large scale detail drawings as indicated.

PROJECT :

SHRI VINAYAK HOMES
PROPOSED RESIDENTIAL
BUILDING ON P. NO.-
35,36,37,40,41&42 HANUMAN
VIHAR, (BALRAMPURA URF
KHEJARO KA BAS), JAIPUR

NAME OF DRAWING:

**STILT FLOOR
ELECTRICAL LAYOUT**


DRAWN BY:	Banwari Lal	APPROVED BY:	JITENDRA SHARMA
DRAWING:	WORKING DRAWING	NORTH:	
PROJECT NO. :		DATE :	02, Nov. - 2023
SCALE :	NTS	REV. NO. :	R-1

DRAWING NO. :

A-ST-01

PRODUCED BY AN AUTODESK EDUCATIONAL PRODUCT

PRODUCED BY AN AUTODESK EDUCATIONAL PRODUCT

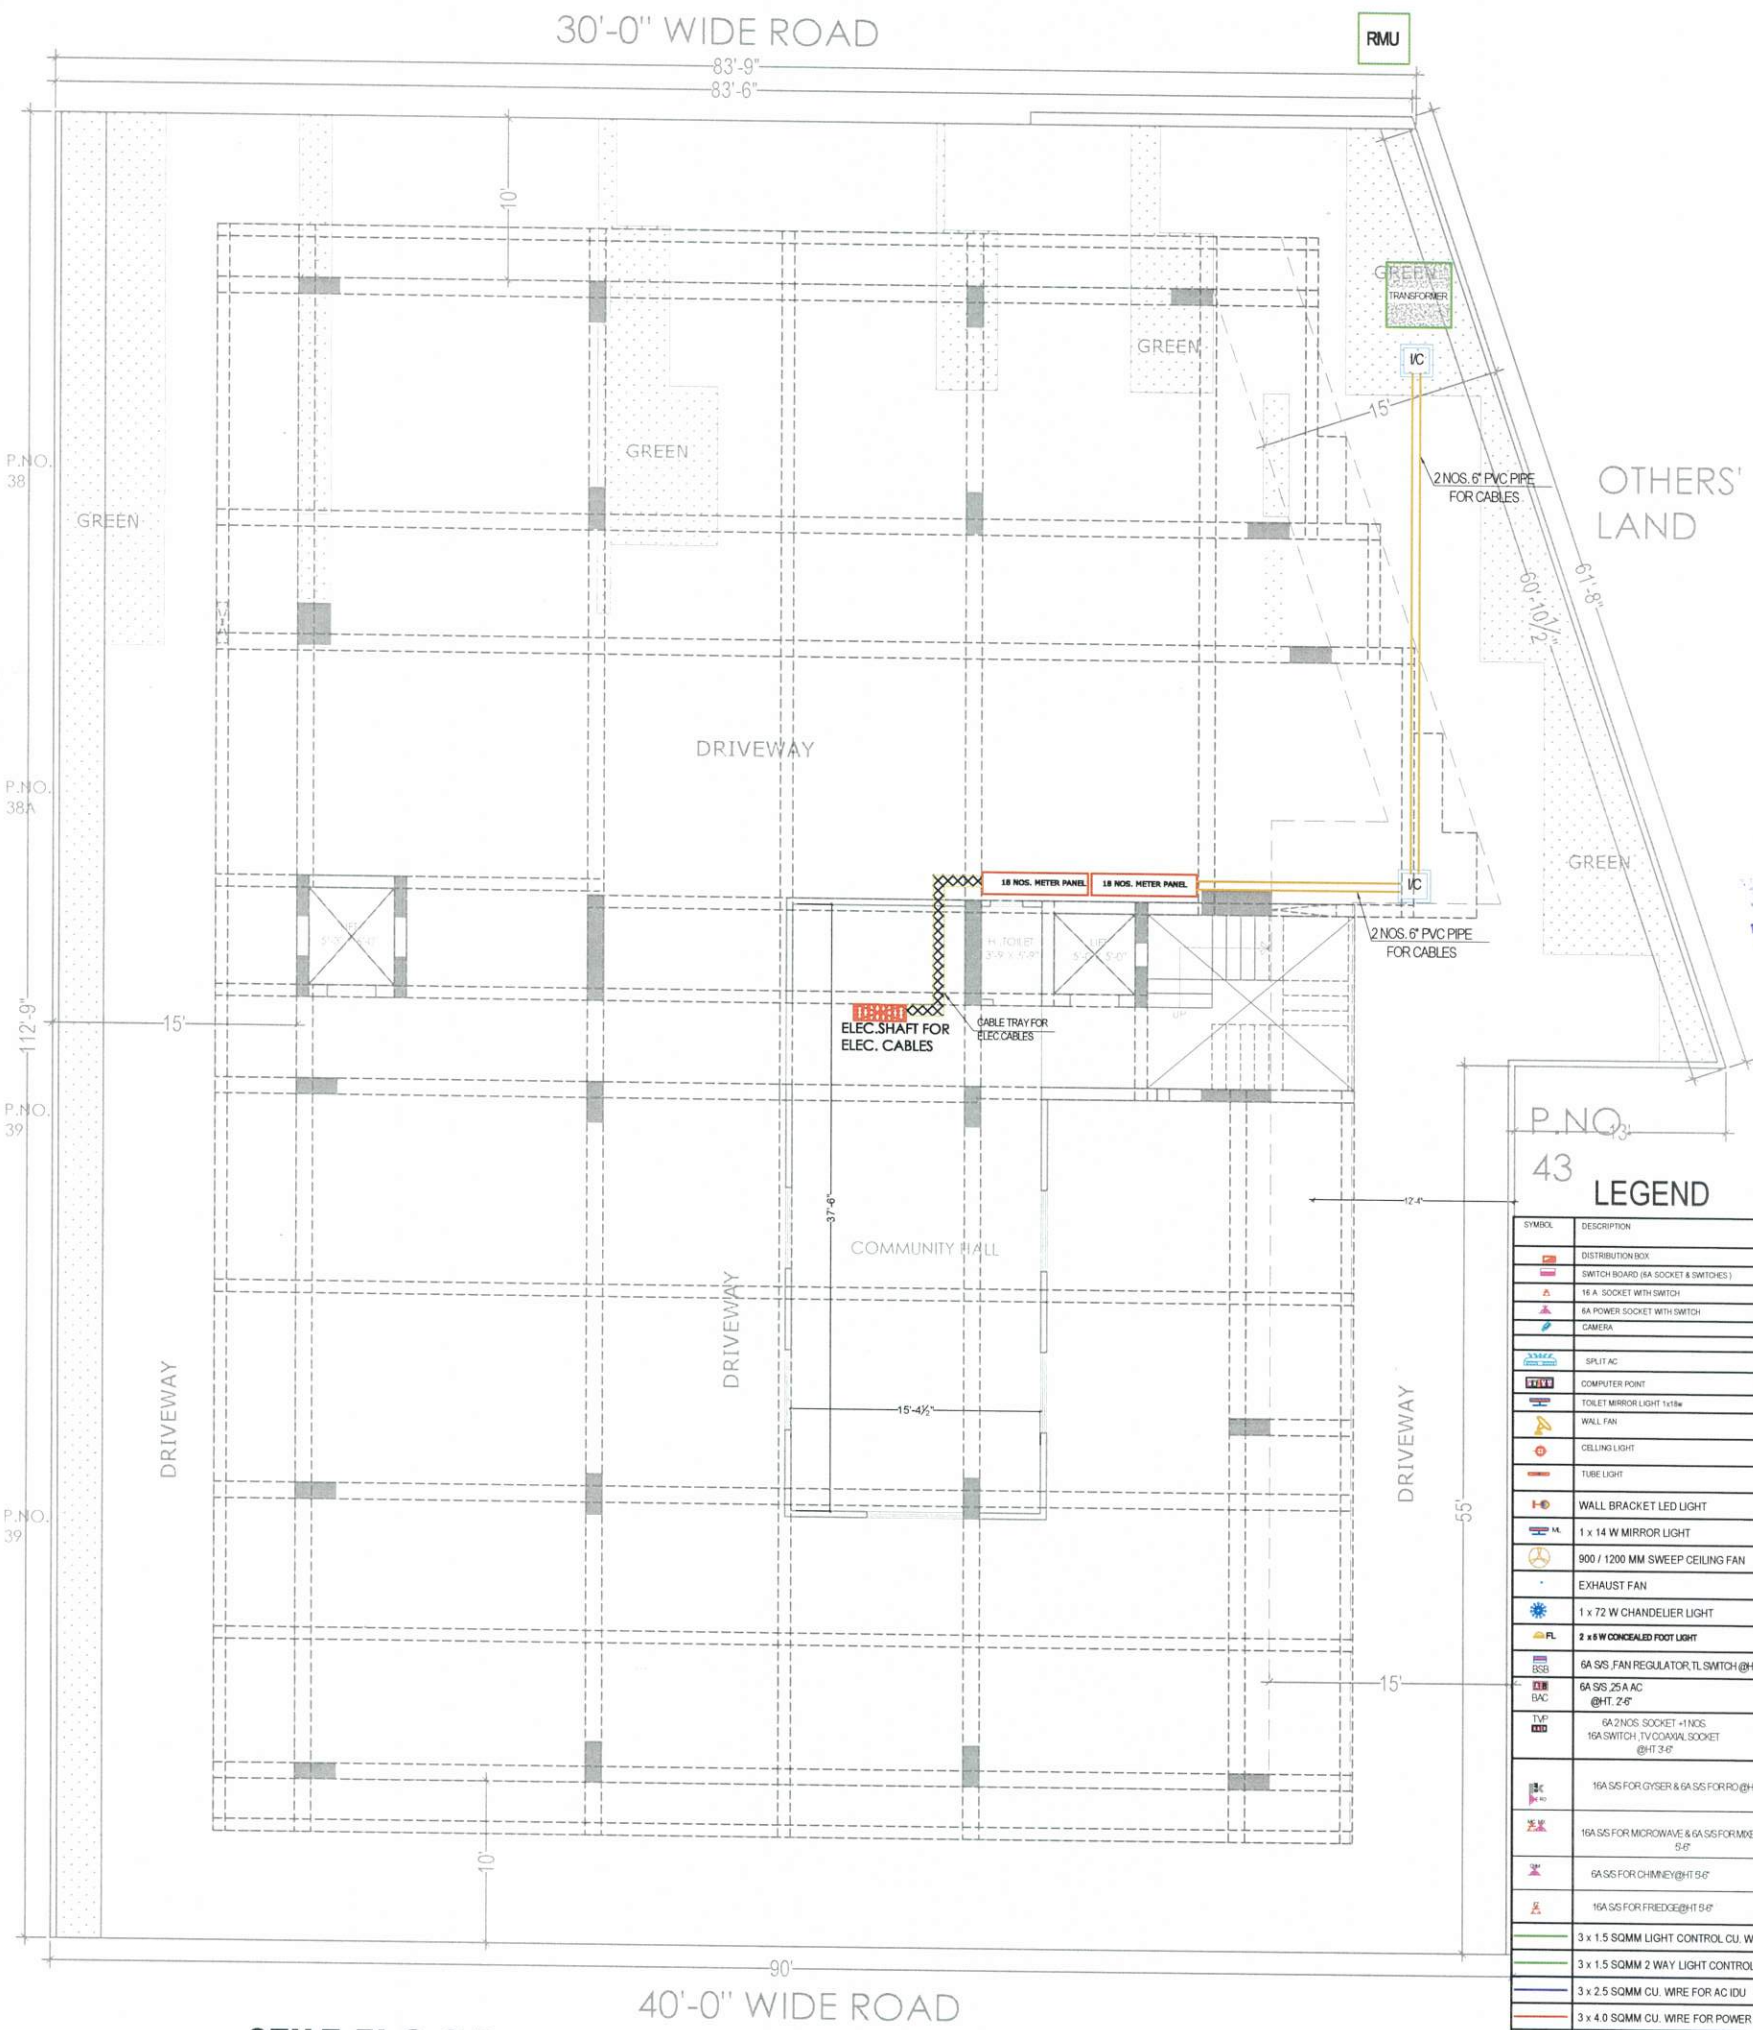

STILT FLOOR
ELECTRICAL ROUTE LAYOUT

CLIENT :

Mr. NATHU JI

ARCHITECTS :
4 INSIDE
ARCHITECTURE N INTERIORS
Plot no. 72, S.P. Marg , C- Scheme
Jaipur, Rajasthan, India
cont: +91 9950595991 , 91 9982812777
e.mail: jeets.arch@gmail.com

STRUCTURAL CONSULTANTS:

MEP CONSULTANT : --
SHRI SHYAM CONSULTANT
PLUMBING ! FIRE ! ELECTRICAL ! STP ! WTP
JAIPUR-302006
PH.NO. +91 9785427711

DEALT BY
RAMESH

REVISION
00

DATE:
23.10.2023

Shyam

Er. SANJEEV SHARMA
R.E.(Electrical)

P.N.O.
43

LEGEND

SYMBOL	DESCRIPTION
[Symbol]	DISTRIBUTION BOX
[Symbol]	SWITCH BOARD (8A SOCKET & SWITCHES)
[Symbol]	16 A SOCKET WITH SWITCH
[Symbol]	8A POWER SOCKET WITH SWITCH
[Symbol]	CAMERA
[Symbol]	SPLIT AC
[Symbol]	COMPUTER POINT
[Symbol]	TOILET MIRROR LIGHT 1x1ft
[Symbol]	WALL FAN
[Symbol]	CEILING LIGHT
[Symbol]	TUBE LIGHT
[Symbol]	WALL BRACKET LED LIGHT
[Symbol]	1 x 14 W MIRROR LIGHT
[Symbol]	900 / 1200 MM SWEEP CEILING FAN
[Symbol]	EXHAUST FAN
[Symbol]	1 x 72 W CHANDELER LIGHT
[Symbol]	2 x 8 W CONCEALED FOOT LIGHT
[Symbol]	6A SS FAN REGULATOR, TL SWITCH @ HT. 2'6"
[Symbol]	6A SS, 25A AC @ HT. 2'6"
[Symbol]	6A 2 NOS SOCKET + 1 NOS 16A SWITCH, TV COAXIAL SOCKET @ HT. 3'6"
[Symbol]	16A SS FOR GYSER & 6A SS FOR RO @ HT. 5'6"
[Symbol]	16A SS FOR MICROWAVE & 6A SS FOR MIXER @ HT. 5'6"
[Symbol]	6A SS FOR CHIMNEY @ HT. 5'6"
[Symbol]	16A SS FOR FREDGE @ HT. 5'6"
[Symbol]	3 x 1.5 SQMM LIGHT CONTROL CU. WIRE
[Symbol]	3 x 1.5 SQMM 2 WAY LIGHT CONTROL WIRE
[Symbol]	3 x 2.5 SQMM CU. WIRE FOR AC IDU
[Symbol]	3 x 4.0 SQMM CU. WIRE FOR POWER CIRCUIT
[Symbol]	3 x 2.5 SQMM CU. WIRE FOR LIGHT CIRCUIT
[Symbol]	CAT-6 LAN WIRE RJ-45 JACK TO LAN SWITCH
[Symbol]	2 PAIR TELEPHONE WIRE RJ-11 JACK TO TTB
[Symbol]	RG-6 TV CABLE SETUP BOX TO TV SPLITTER
[Symbol]	CAT-6 CCTV CABLE CCTV CAMERA TO NVR

PROJECT:
SIDDHI VINAYAK HOME'S
PROPOSED RESIDENTIAL
BUILDING ON P. NO.-
35,36,37,40,41&42 HANUMAN
VIHAR,(BALRAMPURA URF
KHEJARO KA BAS) , JAIPUR

NAME OF DRAWING:
STILT FLOOR
ELECTRICAL ROUTE LAYOUT

DRAWN BY:
Banwari Lal

APPROVED BY:
JITENDRA SHARMA

DRAWING:
WORKING DRAWING

NORTH:

PROJECT NO.:

DATE :
02. Nov. - 2023

SCALE :
NTS

REV NO. :
R-1

DRAWING NO.:

A-ST-01