


102'-3"

88'-6"

102'-3"

87'-3"

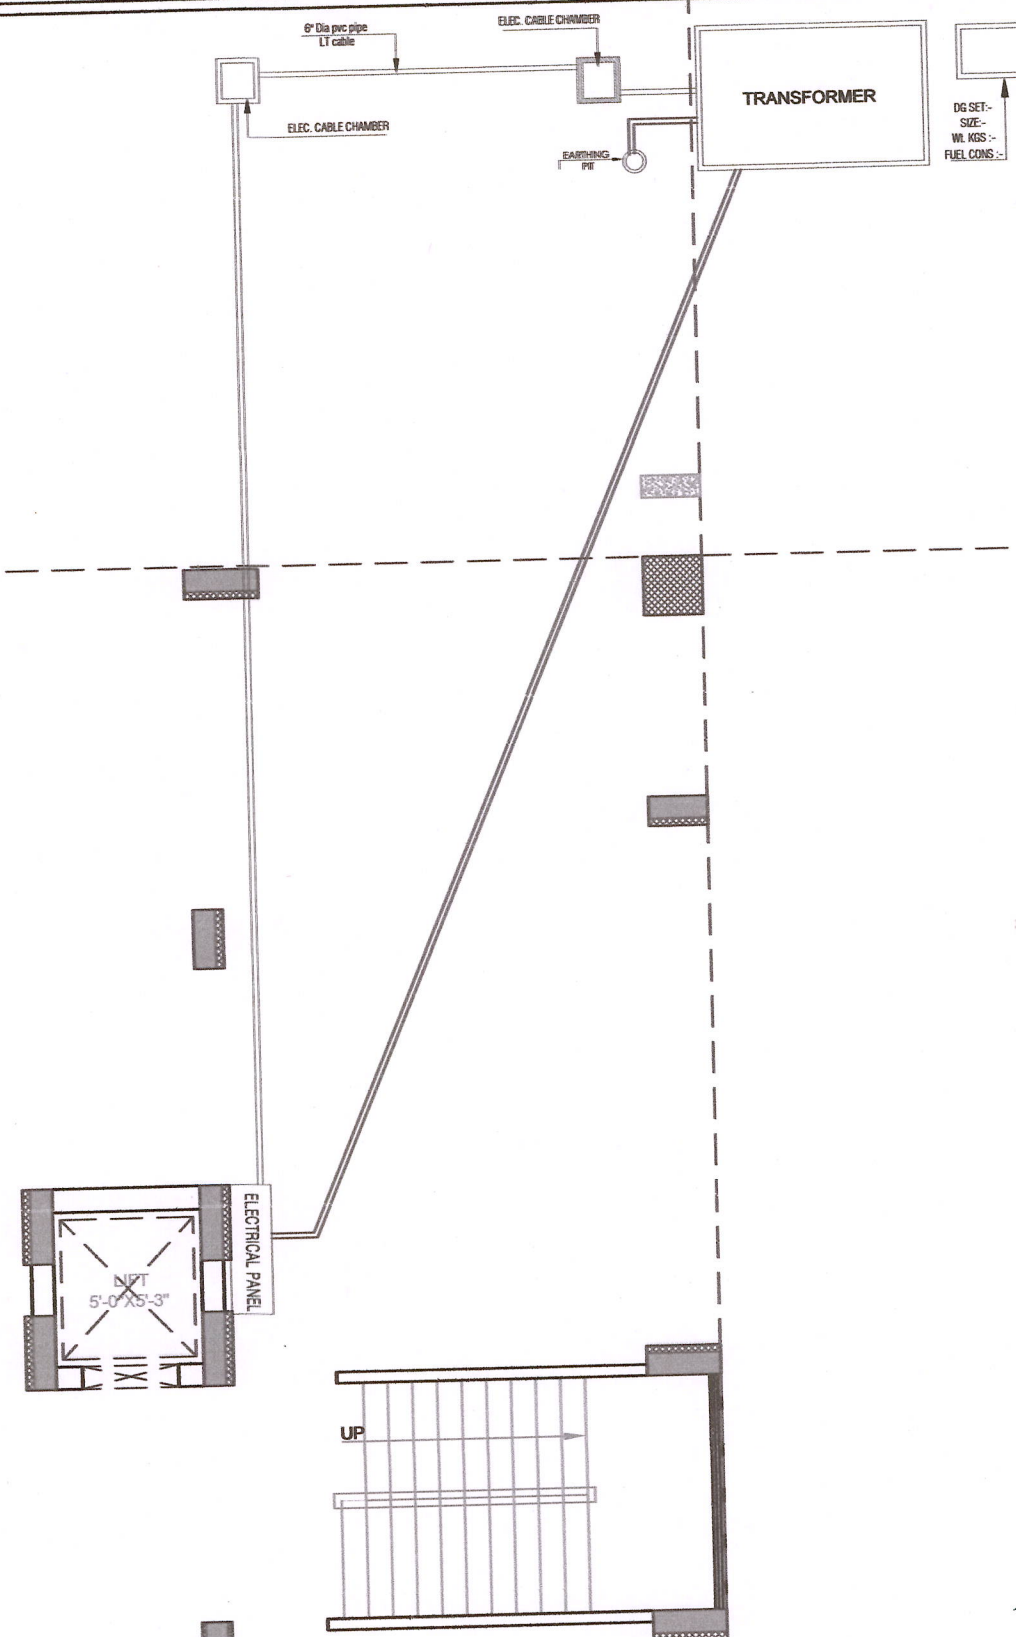

Koushik
KRISHNA KUMAR
B. Tech. (Mechanical)
M.E.P. Consultant

WARNING

1. This drawing is the sole copyright of Architects VISTAAR and should be used for the purpose expressly issued.

GENERAL NOTES

1. All dimensions are in feet and inches.
2. Do not scale this drawing follow written dimensions only.
3. This drawing should be read in conjunction with other architectural and structural drawings.
4. Any discrepancy in the drawing should be immediately brought to the notice of architect.

PROJECT TITLE

PROJECT:-
SHREE SHYAM HOME
BUILDING AT PLOT-637/632, &
639/634, GANPATPURA, SANGANER
JAIPUR

DRAWING TITLE

STILT FLOOR DISTRIBUTION AND LT PANEL
COMMON AREA TRANSFORMER PLAN

ARCHITECTS:


VISTAAR ARCHITECTS &
PLANNERS
Architects :: Interior Designers
B-2/12, Chitrkoot scheme,
main Gandhi Path, Opp mall of jaipur, Jaipur
PH. - 0141-4116461, 09001010366

DATE	REV.	NORTH
10-05-2024		
SCALE	JOB NO.	
N.T.S.		



102'-3"

88'-6"

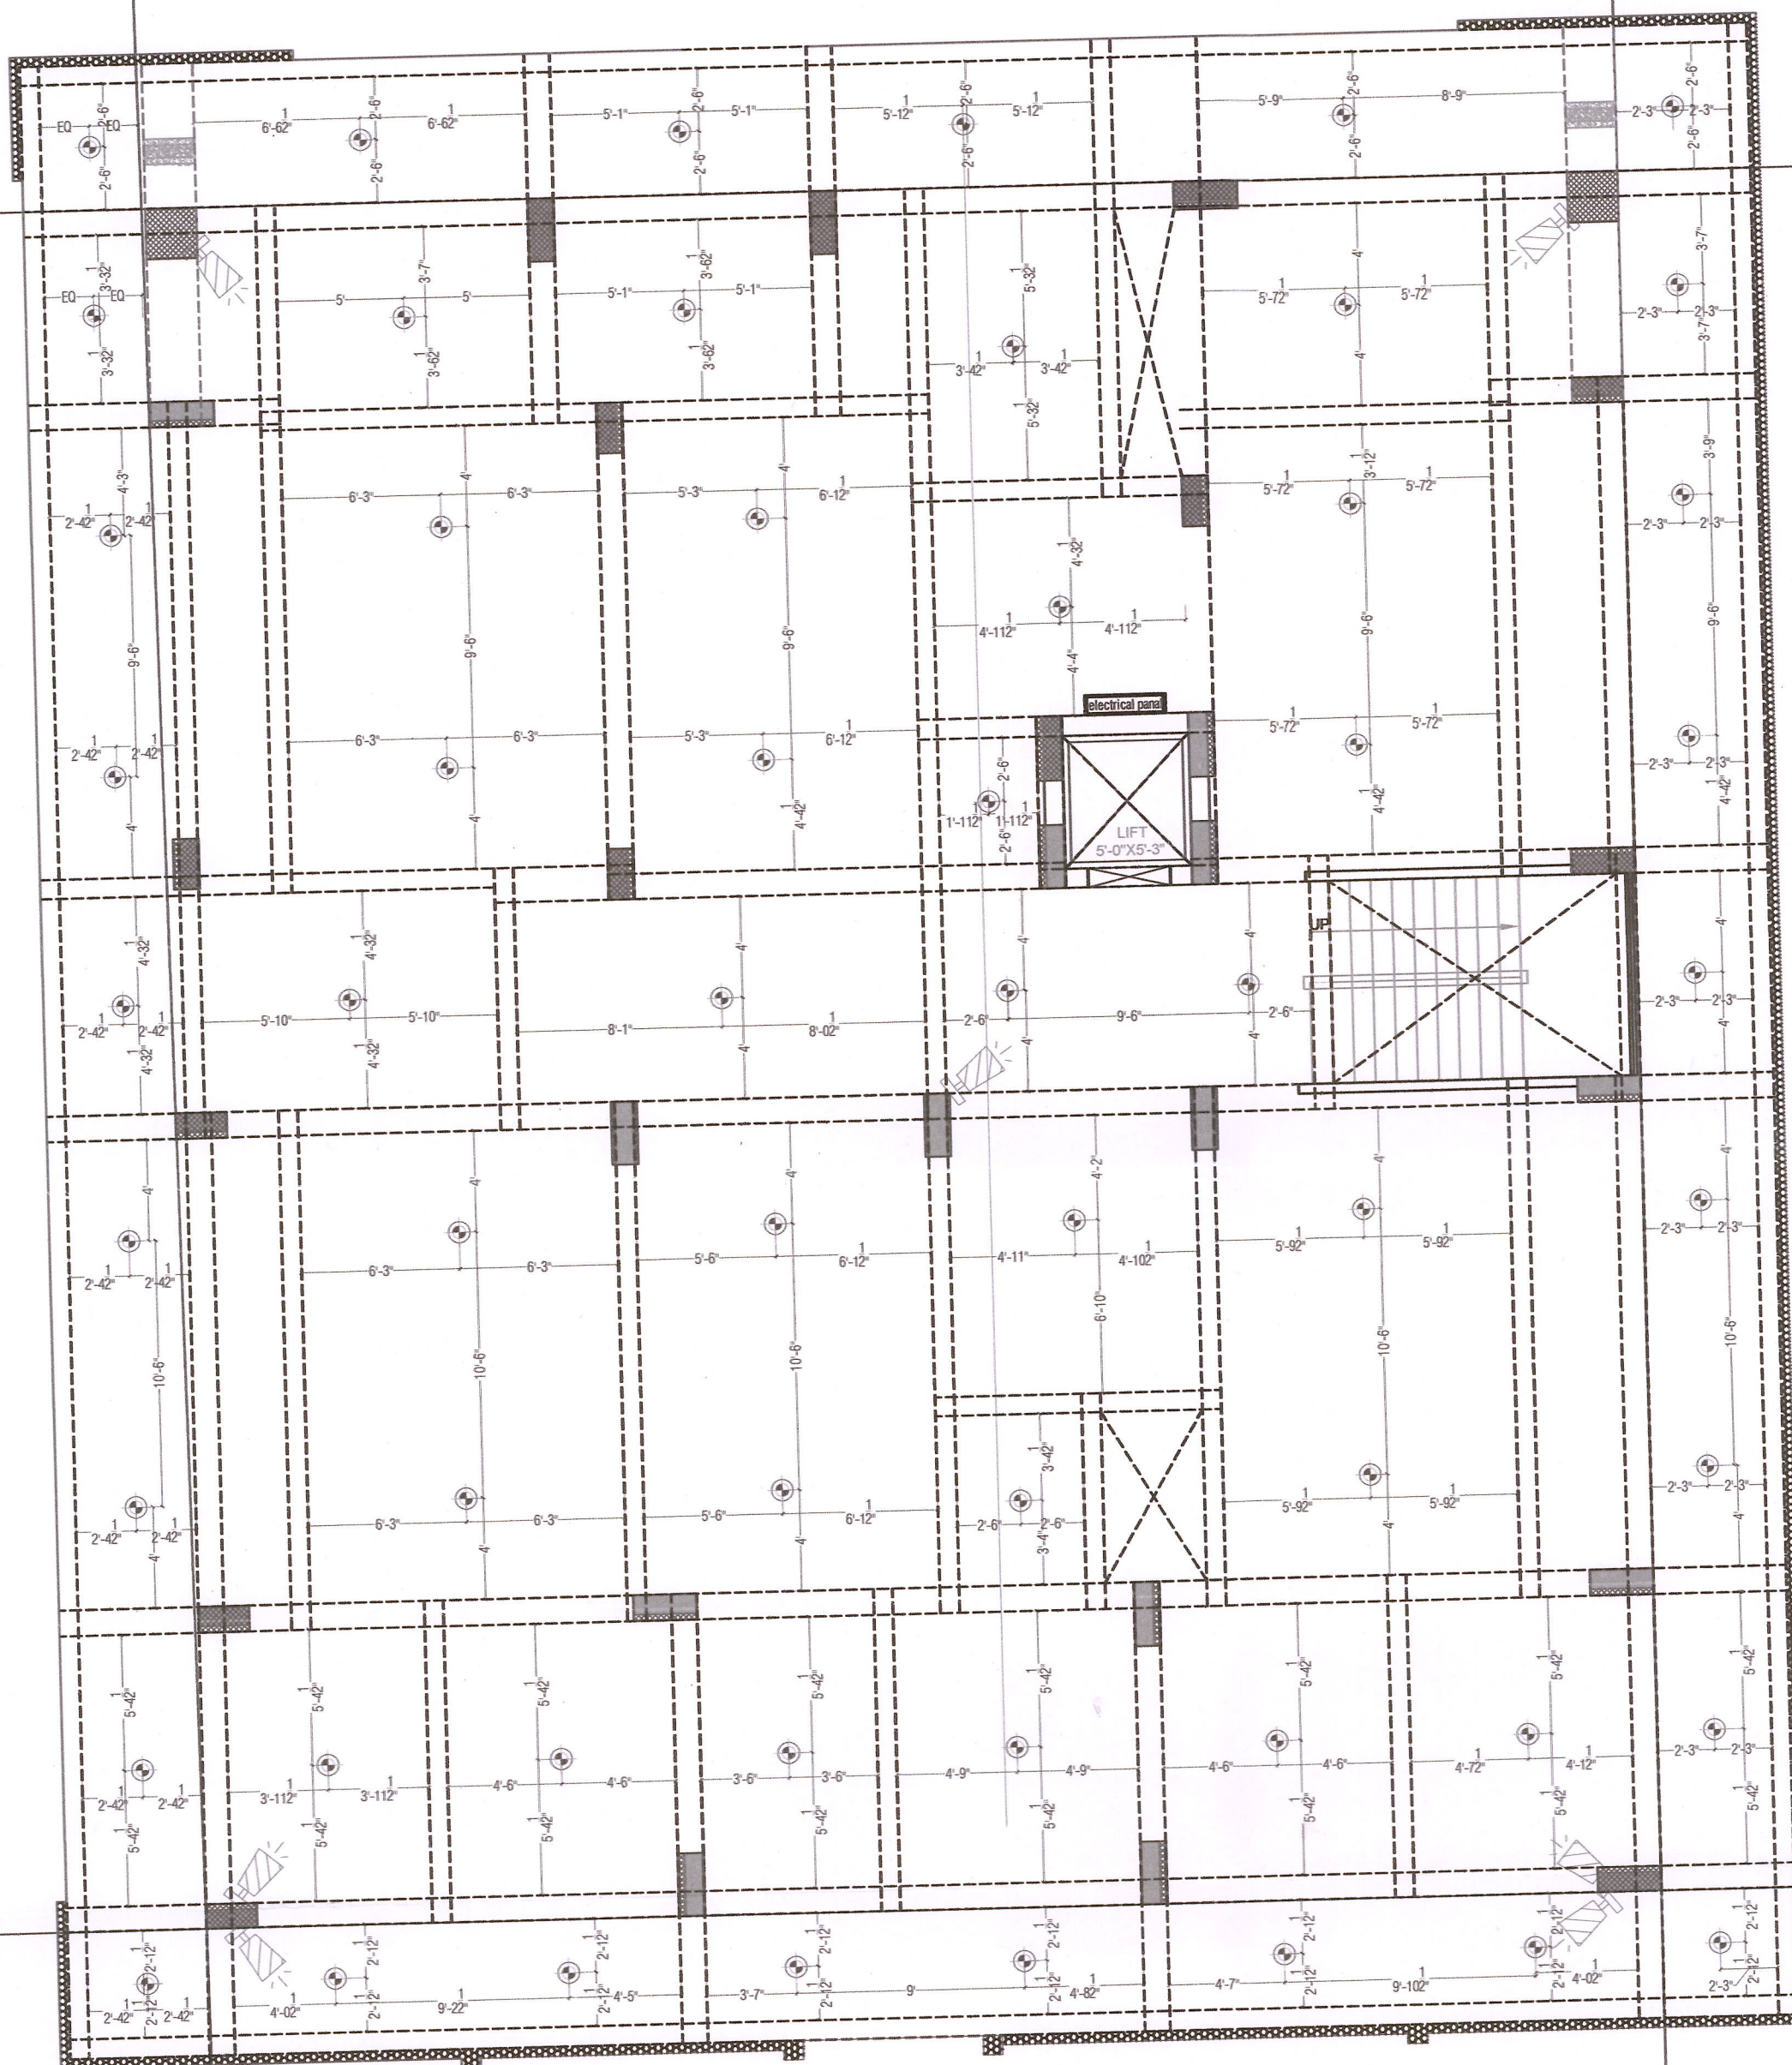

87'-3"

Koushik
KRISHNA KUMAR
B. Tech. (Mechanical)
M.E.P Consultant

102'-3"

LEGENDS:

Mounting Height	No.	ID	Symbol	Description
IN FLOOR				CONTROL WIRING
IN CONDUIT				CONTROL WIRING
IN CONDUIT				AC CONTROL WIRING
IN CONDUIT				GEYSER CONTROL WIRING
IN CONDUIT				BUIZZER CONTROL WIRING
CEILING	FAN/48"			CEILING FAN 48"
CEILING	FAN/30"			CEILING FAN 30"
+90"	TL			1X40W WALL TUBELIGHT
+90"	BULB			WALL BRACKETS AS DESIGN LIGHT
+90"	GL			WALL BRACKETS AS DESIGN FOR GANESH LIGHT
	GL			WALL BRACKETS AS DESIGN FOR GATE LIGHT
CEILING	CFL			CFL CEILING LIGHT
+21"	FL			FOOT LIGHT
+48"	SB			SWITCH BOARD
+70"	ML			1 X 11 W CFL MIRROR LIGHT
VENTILATOR HT.	CR			CEILING ROSE
VENTILATOR HT.	EXF			9" DIA FRESH AIR FAN
+24"	TEL			TELEPHONE POINT
+27"	TV			TV COAXIAL POINT
+27"	LP TV			6 A PLUG POINT FOR TV
+72"	LP-CH			6 A PLUG POINT FOR CHIMNEY
+102"	SAC			50W AC
+102"	PP-SAC			25 A POWER POINT FOR 50W AC
+42"	PP-MIX			15 A POWER POINT FOR MIXER
+78"	PP-G			15 A POWER POINT FOR GEYSER
+54"	PP-F			15 A POWER POINT FOR FRIDGE
+78"	PP-WP			15 A POWER POINT FOR WATER PURIFIER
+48"	PP-WM			15 A POWER POINT FOR WASHING MACHINE
+42"	BP			BELL PUSH SWITCH
+90"	BZ			BUIZZER POINT
+48"	AC			AC STARTER
+60"	MCB DB			MCB DISTRIBUTION BOARD

WARNING

1. This drawing is the sole copyright of Architects VISTAAR and should be used for the purpose expressly issued.

GENERAL NOTES

- All dimensions are in feet and inches.
- Do not scale this drawing follow written dimensions only.
- This drawing should be read in conjunction with other architectural and structural drawings.
- Any discrepancy in the drawing should be immediately brought to the notice of architect.

PROJECT TITLE

PROJECT:-
SHREE SHYAM HOME
BUILDING AT PLOT-637/632, &
639/634, GANPATPURA, SANGANER
JAIPUR

DRAWING TITLE

STILT(PARKING)FLOOR CEILING ELETRICAL PLAN

ARCHITECTS:

VISTAAR ARCHITECTS &
PLANNERS
Architects :: Interior Designers
B-2/12, Chitrkoot scheme,
main Gandhi Path, Opp mall of jaipur, Jaipur
PH.- 0141-4116461, 09001010366

PRJN:-

DRN

DATE

REV.

NORTH

MANOJ KUMARWAT

11-06-2024

SCALE

JOB NO.


NTS

NORTH

N

102'-3"

88'-6"

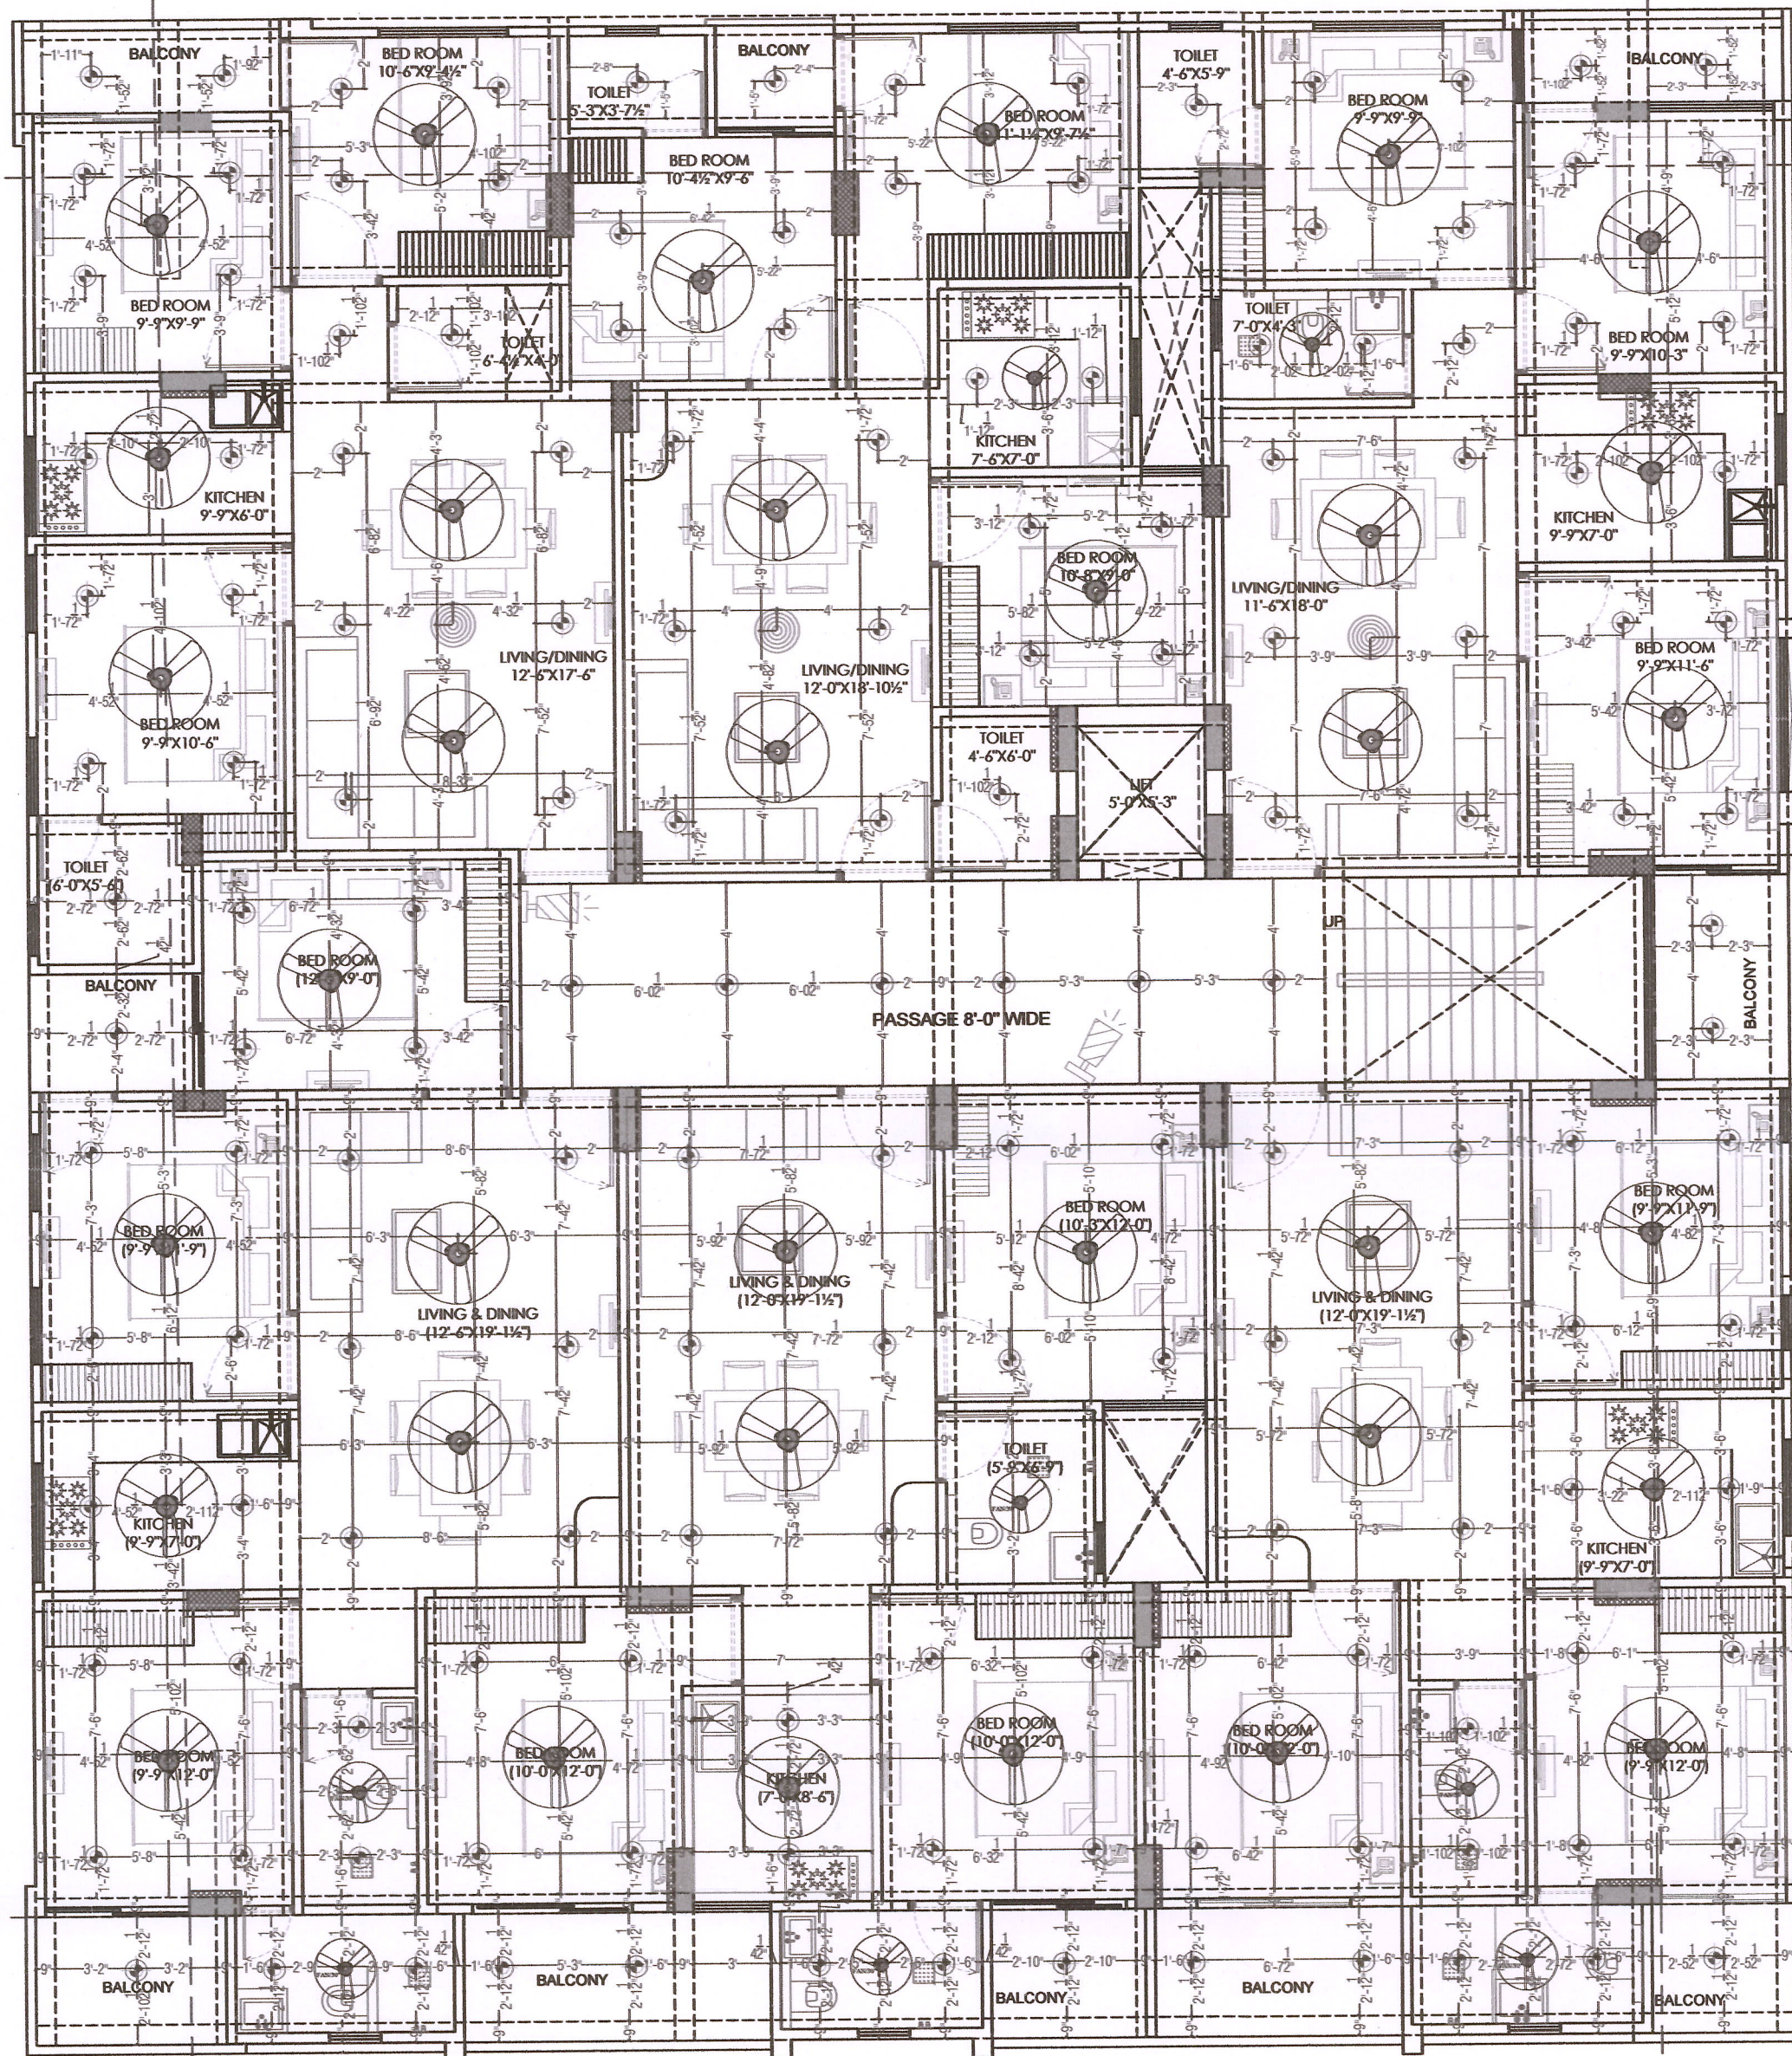

Krishna
KRISHNA KUMAR
B. Tech. (Mechanical)
M.E.P. Consultant

LEGENDS:				
Mounting Height	No.	I D	Symbol	Description
IN FLOOR				CONTROL WIRING
IN CONDUIT				CONTROL WIRING
IN CONDUIT				AC CONTROL WIRING
IN CONDUIT				GEYSER CONTROL WIRING
IN CONDUIT				BUZZER CONTROL WIRING
CEILING	FAN48"			CEILING FAN 48"
CEILING	FAN30"			CEILING FAN 30"
+90"	TL			1X40W WALL TUBELIGHT
+90"	BULB			WALL BRACKETS AS DESIGN LIGHT
+90"	GL			WALL BRACKETS AS DESIGN FOR GANESH LIGHT
	GL			WALL BRACKETS AS DESIGN FOR GATE LIGHT
CEILING	CFL			CFL CEILING LIGHT
+21"	FL			FOOT LIGHT
+48"	SB			SWITCH BOARD
+75"	ML			1X11 W CFL MIRROR LIGHT
VENTILATOR HT.	CR			CEILING ROSE
VENTILATOR HT.	EXP			9" DIA FRESH AIR FAN
+24"	TEL			TELEPHONE POINT
+27"	TV			TV COAXIAL POINT
+27"	LP TV			6 A PLUG POINT FOR TV
+72"	LP-CH			6 A PLUG POINT FOR CHIMNEY
+102"	SAC			SPLIT AC
+102"	PP-SAC			25 A POWER POINT FOR SPLIT AC
+42"	PP-MIX			15 A POWER POINT FOR MIXER
+78"	PP-G			15 A POWER POINT FOR GEYSER
+54"	PP-F			15 A POWER POINT FOR FRIDGE
+78"	PP-WP			15 A POWER POINT FOR WATER PURIFIER
+48"	PP-WM			15 A POWER POINT FOR WASHING MACHINE
+42"	BP			BELL PUSH SWITCH
+90"	BZ			BUZZER POINT
+48"	AC			AC STARTER
+60"	MCB DB			MCB DISTRIBUTION BOARD

WARNING

1. This drawing is the sole copyright of Architects VISTAAR and should be used for the purpose expressly issued.

GENERAL NOTES

- All dimensions are in feet and inches.
- Do not scale this drawing follow written dimensions only.
- This drawing should be read in conjunction with other architectural and structural drawings.
- Any discrepancy in the drawing should be immediately brought to the notice of architect.

PROJECT TITLE

PROJECT:-
SHREE SHYAM HOME
BUILDING AT PLOT-637/632, &
639/634,GANPATPURA,SANGANER
JAIPUR

DRAWING TITLE

TYPICAL FLOOR CEILING ELECTRICAL PLAN

ARCHITECTS:


VISTAAR ARCHITECTS &
PLANNERS
Architects :: Interior Designers
B-2/12, Chitrkoot scheme,
main Gandhi Path, Opp mall of jaipur, Jaipur
PH.- 0141-4116461,09001010366

PAN:-

DRN.	DATE	REV.	NORTH
MANUJ KUMAWAT	12-07-2024		
SCALE	JOB NO.		
N.T.S			

102'-3"

88'-6"

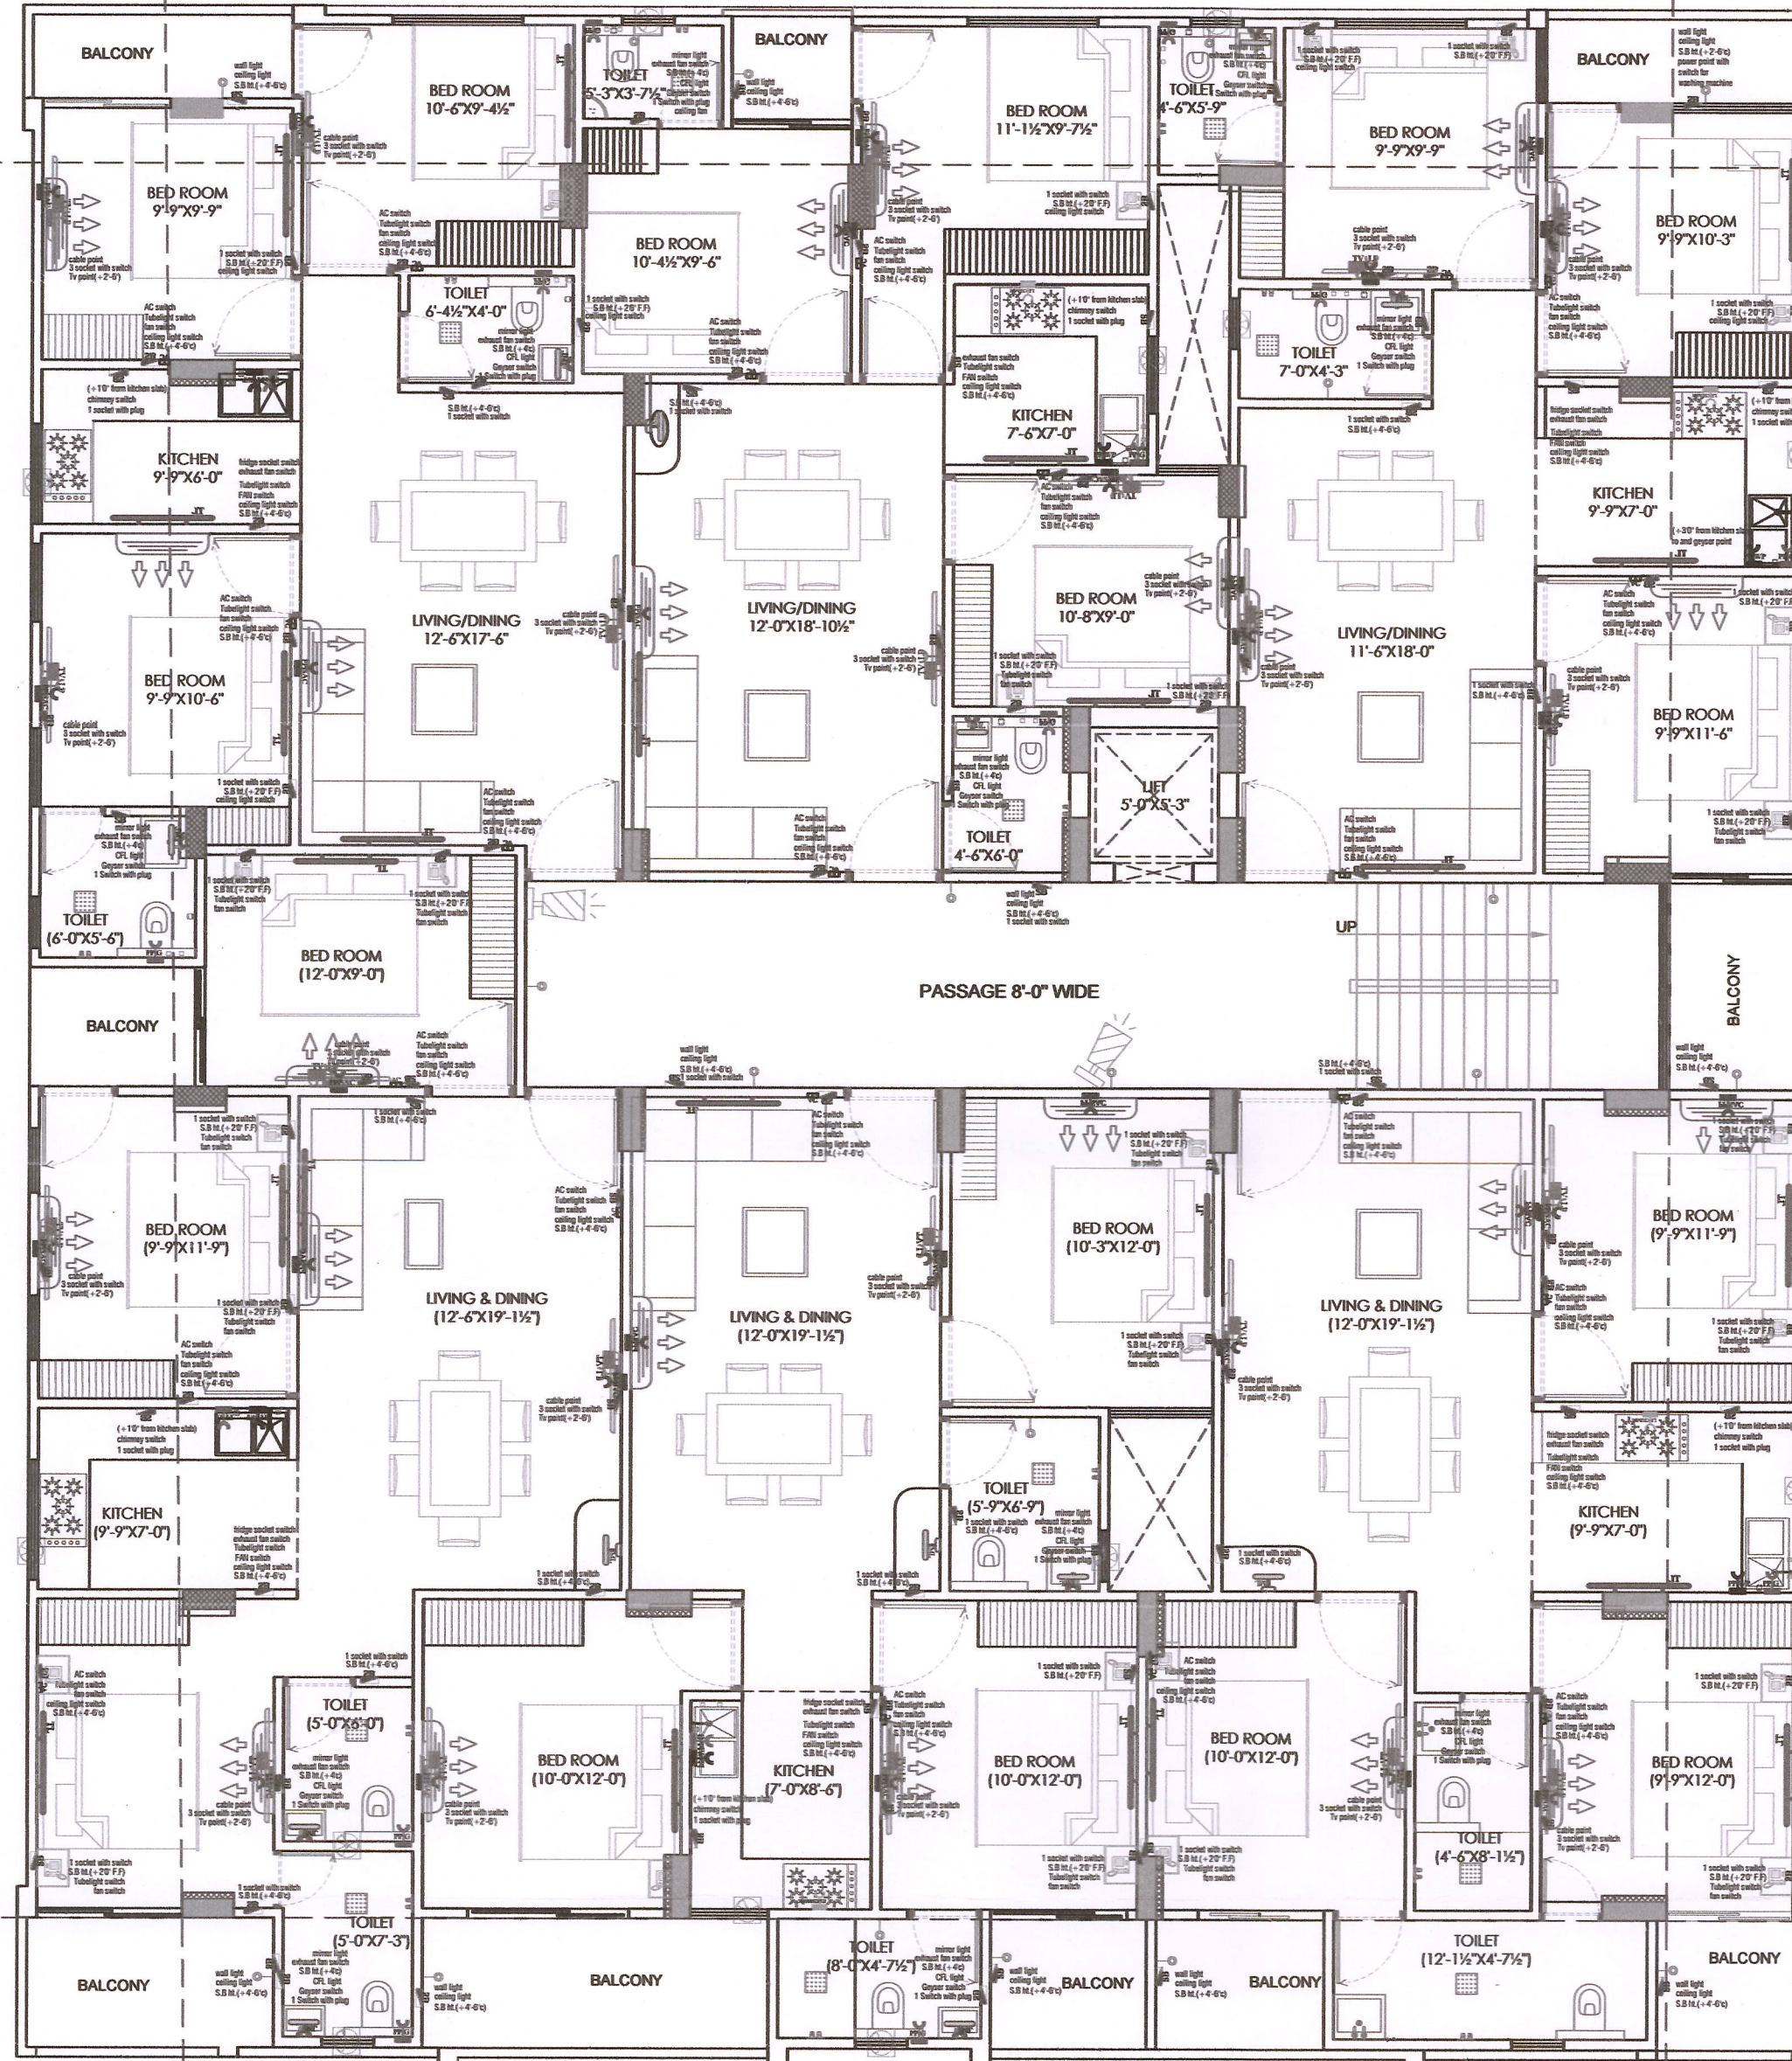

87'-3"

Krishna
KRISHNA KUMAR
B. Tech. (Mechanical)
M.E.P Consultant

LEGENDS:

Mounting Height	No.	I D	Symbol	Description
IN FLOOR				CONTROL WIRING
IN CONDUIT				CONTROL WIRING
IN CONDUIT				AC CONTROL WIRING
IN CONDUIT				GEYSER CONTROL WIRING
IN CONDUIT				BUZZER CONTROL WIRING
CEILING	FAN48"			CEILING FAN 48"
CEILING	FAN30"			CEILING FAN 30"
+90"	TL			1X40W WALL TUBELIGHT
+90"	BULB			WALL BRACKETS AS DESIGN LIGHT
+90"	GL			WALL BRACKETS AS DESIGN FOR GANESH LIGHT
	GL			WALL BRACKETS AS DESIGN FOR GATE LIGHT
CEILING	CFL			CFL CEILING LIGHT
+21"	FL			FOOT LIGHT
+48"	SB			SWITCH BOARD
+78"	ML			1 X 11 W CFL MIRROR LIGHT
VENTILATOR HT.	CR			CEILING ROSE
VENTILATOR HT.	EXP			9" DIA FRESH AIR FAN
+24"	TEL			TELEPHONE POINT
+27"	TV			TV COAXIAL POINT
+27"	LP TV			6 A PLUG POINT FOR TV
+72"	LP-CH			6 A PLUG POINT FOR CHIMNEY
+102"	SAC			SPLIT AC
+102"	PP-SAC			25 A POWER POINT FOR SPLIT AC
+42"	PP-MIX			15 A POWER POINT FOR MIXER
+78"	PP-G			15 A POWER POINT FOR GEYSER
+54"	PP-F			15 A POWER POINT FOR FRIDGE
+78"	PP-WP			15 A POWER POINT FOR WATER PURIFIER
+48"	PP-WM			15 A POWER POINT FOR WASHING MACHINE
+42"	BP			BELL PUSH SWITCH
+90"	BZ			BUZZER POINT
+48"	AC			AC STARTER
+60"	MCB DB			MCB DISTRIBUTION BOARD

WARNING

1. This drawing is the sole copyright of Architects VISTAAR and should be used for the purpose expressly issued.

GENERAL NOTES

- All dimensions are in feet and inches.
- Do not scale this drawing follow written dimensions only.
- This drawing should be read in conjunction with other architectural and structural drawings.
- Any discrepancy in the drawing should be immediately brought to the notice of architect.

PROJECT TITLE

PROJECT:-
SHREE SHYAM HOME
BUILDING AT PLOT-637/632, &
639/634, GANPATPURA, SANGANER
JAIPUR

DRAWING TITLE

TYPICAL FLOOR WALL ELECTRICAL PLAN

ARCHITECTS:

VISTAAR ARCHITECTS &
PLANNERS
Architects :: Interior Designers
B-2/12, Chitrkoot scheme,
main Gandhi Path, Opp mall of jaipur, Jaipur
PH. - 0141-4116461, 09001010366

PRIN:

DRN.	DATE	REV.	NORTH
MANOJ KUMAR	12-07-2024		
SCALE	JOB NO.		
N.T.S			