
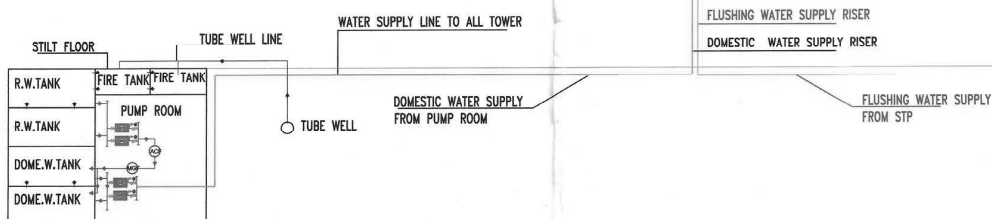
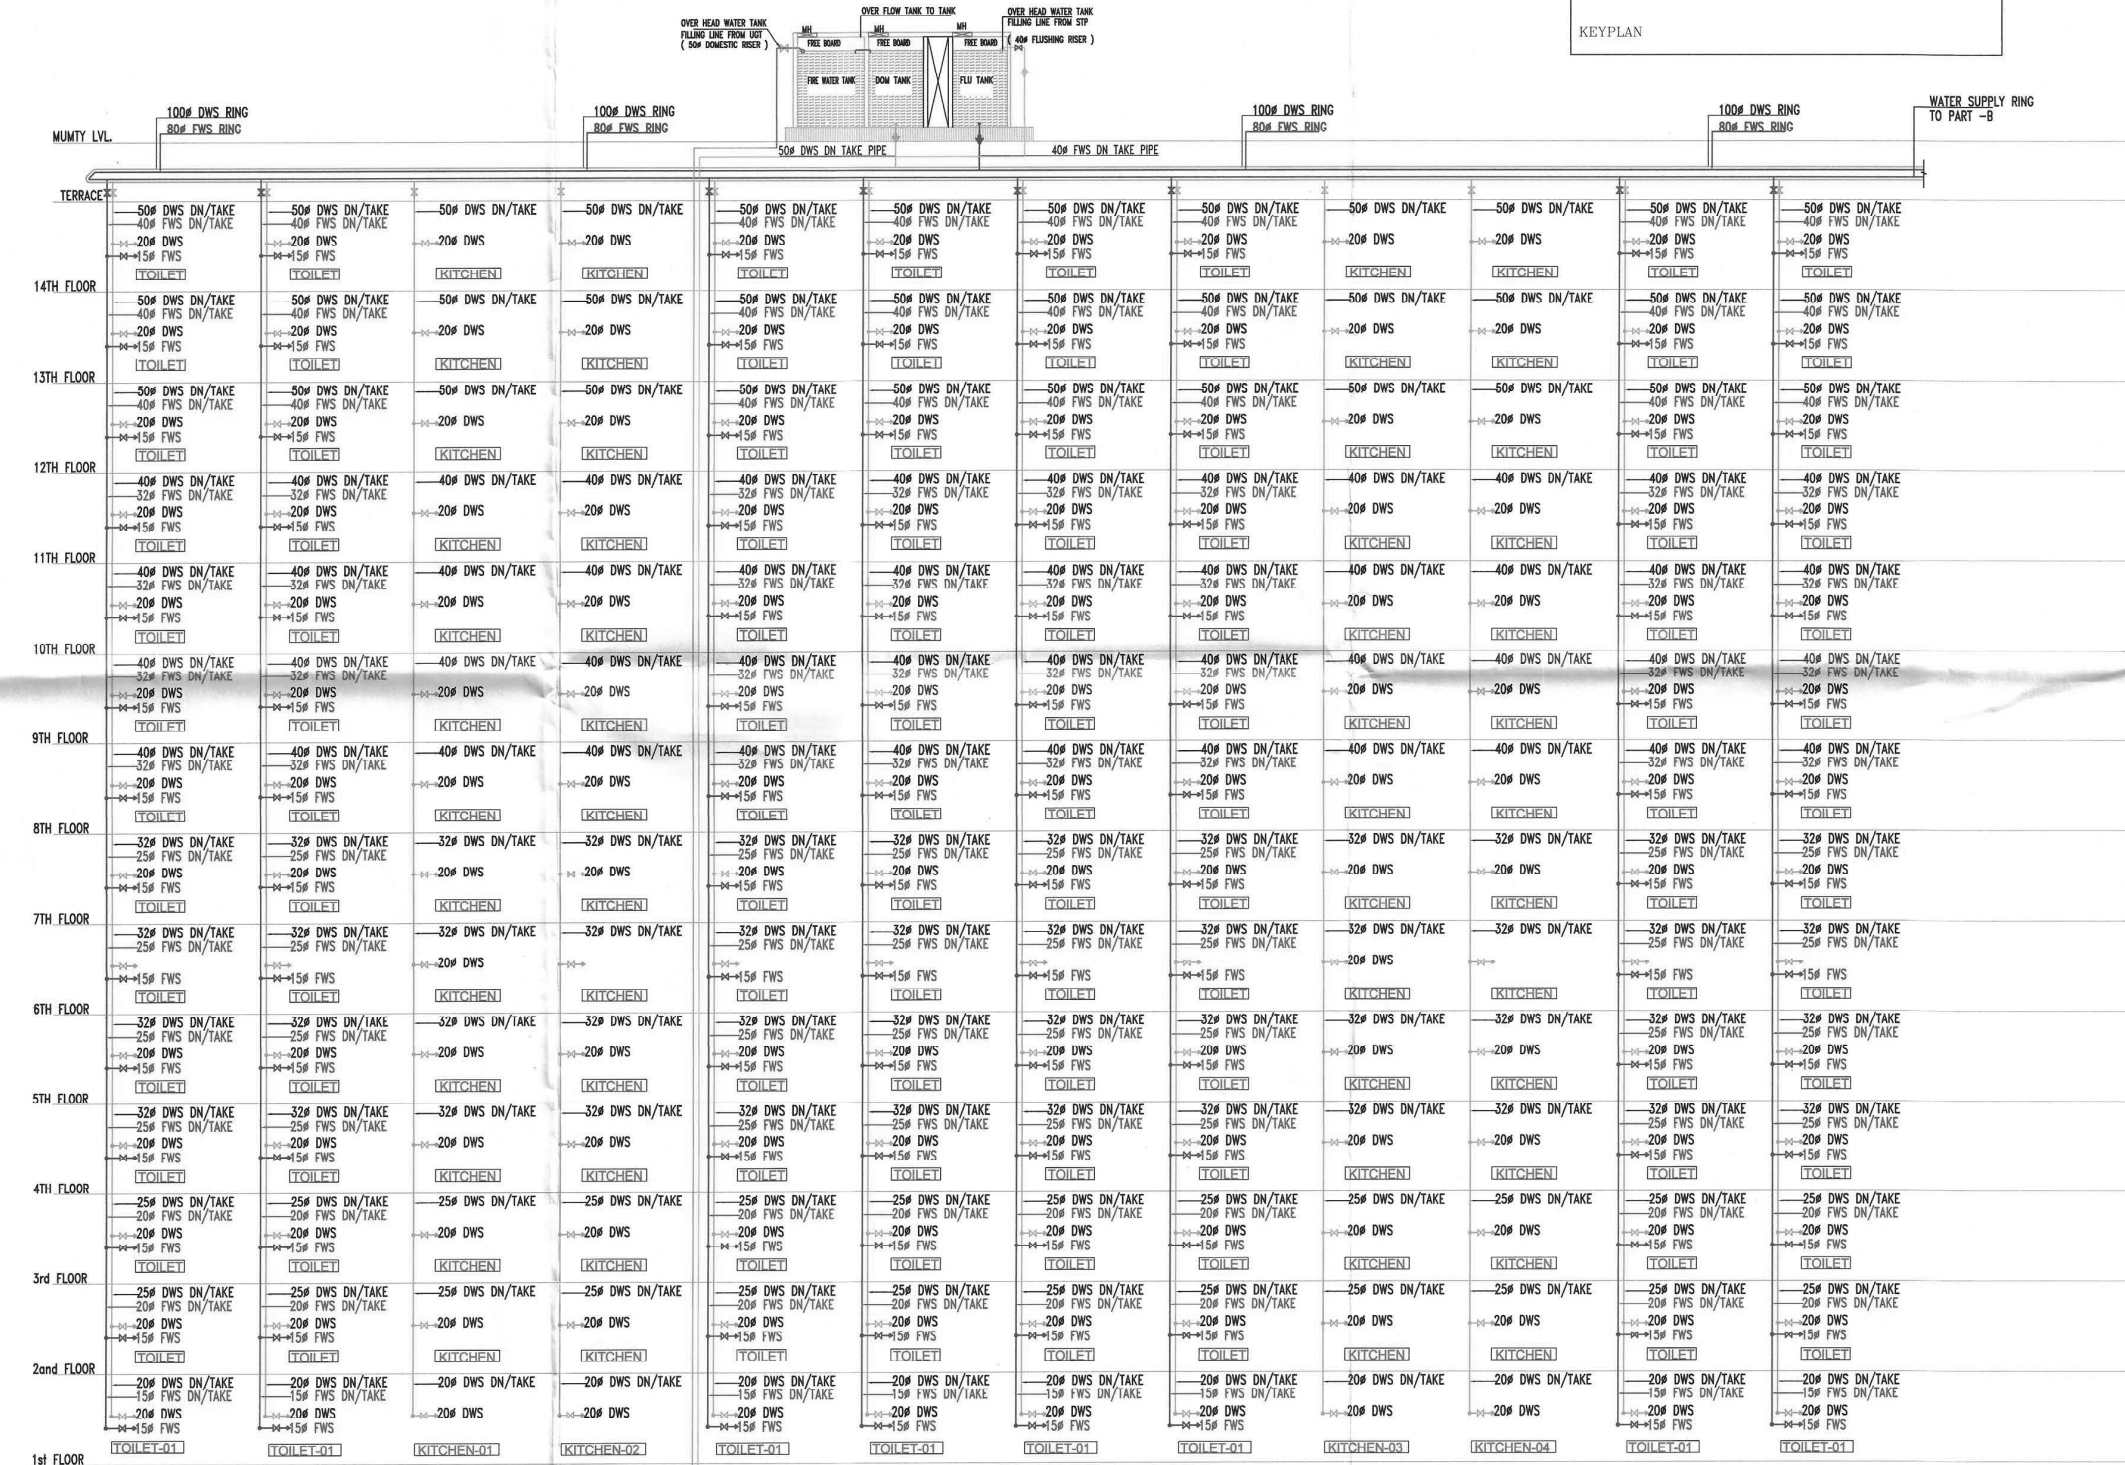


NOTE-ALL TOWER TYPICAL WATER SUPPLY SCHEMATIC DAIGRAM

LEGEND:-

----	DOMESTIC WATER SUPPLY D/N TAKE
----	FLUSHING WATER SUPPLY D/N TAKE
DWS	DOMESTIC WATER SUPPLY
FWS	FLUSHING WATER SUPPLY
⊗	 BALL VALVE

PART -A WATER SUPPLY SCHEMATIC DIAGRAM

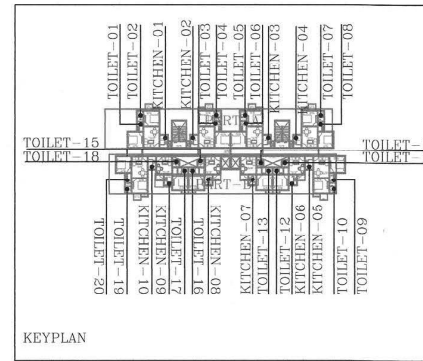

Architect Shailendra Singh Sengar
B.Arch. M.C.A., F.I.V., A.I.I.D.
Regd. Architect
COA No.: 2008/43673

PROJECT :
PROPOSE LAYOUT FOR COSMOS GREENS
AT VILL. SAIDPUR (BHIWADI DISTT. ALWAR)
ON KHASRA NO.-518-527, 534-538, 543-551


SHEET TITLE :
SUBMISSION DRAWING
ALL TOWER TYPICAL
WATER SUPPLY SCHEMATIC DAIGRAM
PLUMBING LAYOUT

ARCHITECTS :
Shilpkar Architects Pvt.
Sustainable Green Architecture
architects, engineers, valuers, project managers
Off. - 909, 911 IL Trade Centre, Sec.-47, Sohna Road, Gurgaon,
Ph. No. - 0124-4361909
Off. - Hotel Regency Complex Bhiwadi (Rajasthan)
Ph. No. - 01493-221766
Off. - 307, 308, Central Plaza, CC2, EPIP, Neemrana (Rajasthan)
e-mail - info@saplind.in, infoggn@saplind.in, infonmn@saplind.in

PLUMBING & FIRE CONSULTANT:-
BEHERA & ASSOCIATES
F-623a, BEHIND, CNG FILLING STATION,
LADO SARAI, NEW DELHI 110030
PH:- 011-40583898, 09811911853
E mail:- behera.associates@gmail.com

SCALE : NTS(A1) DRG. NO. REV. NO.
DATE 09-10-2018 PL-BA-CO-AR-101
P/C BY :
CHK BY S.BEHERA BEHERA & ASSOCIATES
(Plumbing & Fire Consultant)
DLT BY SAJJAN
FILE:

PARKING PLAN

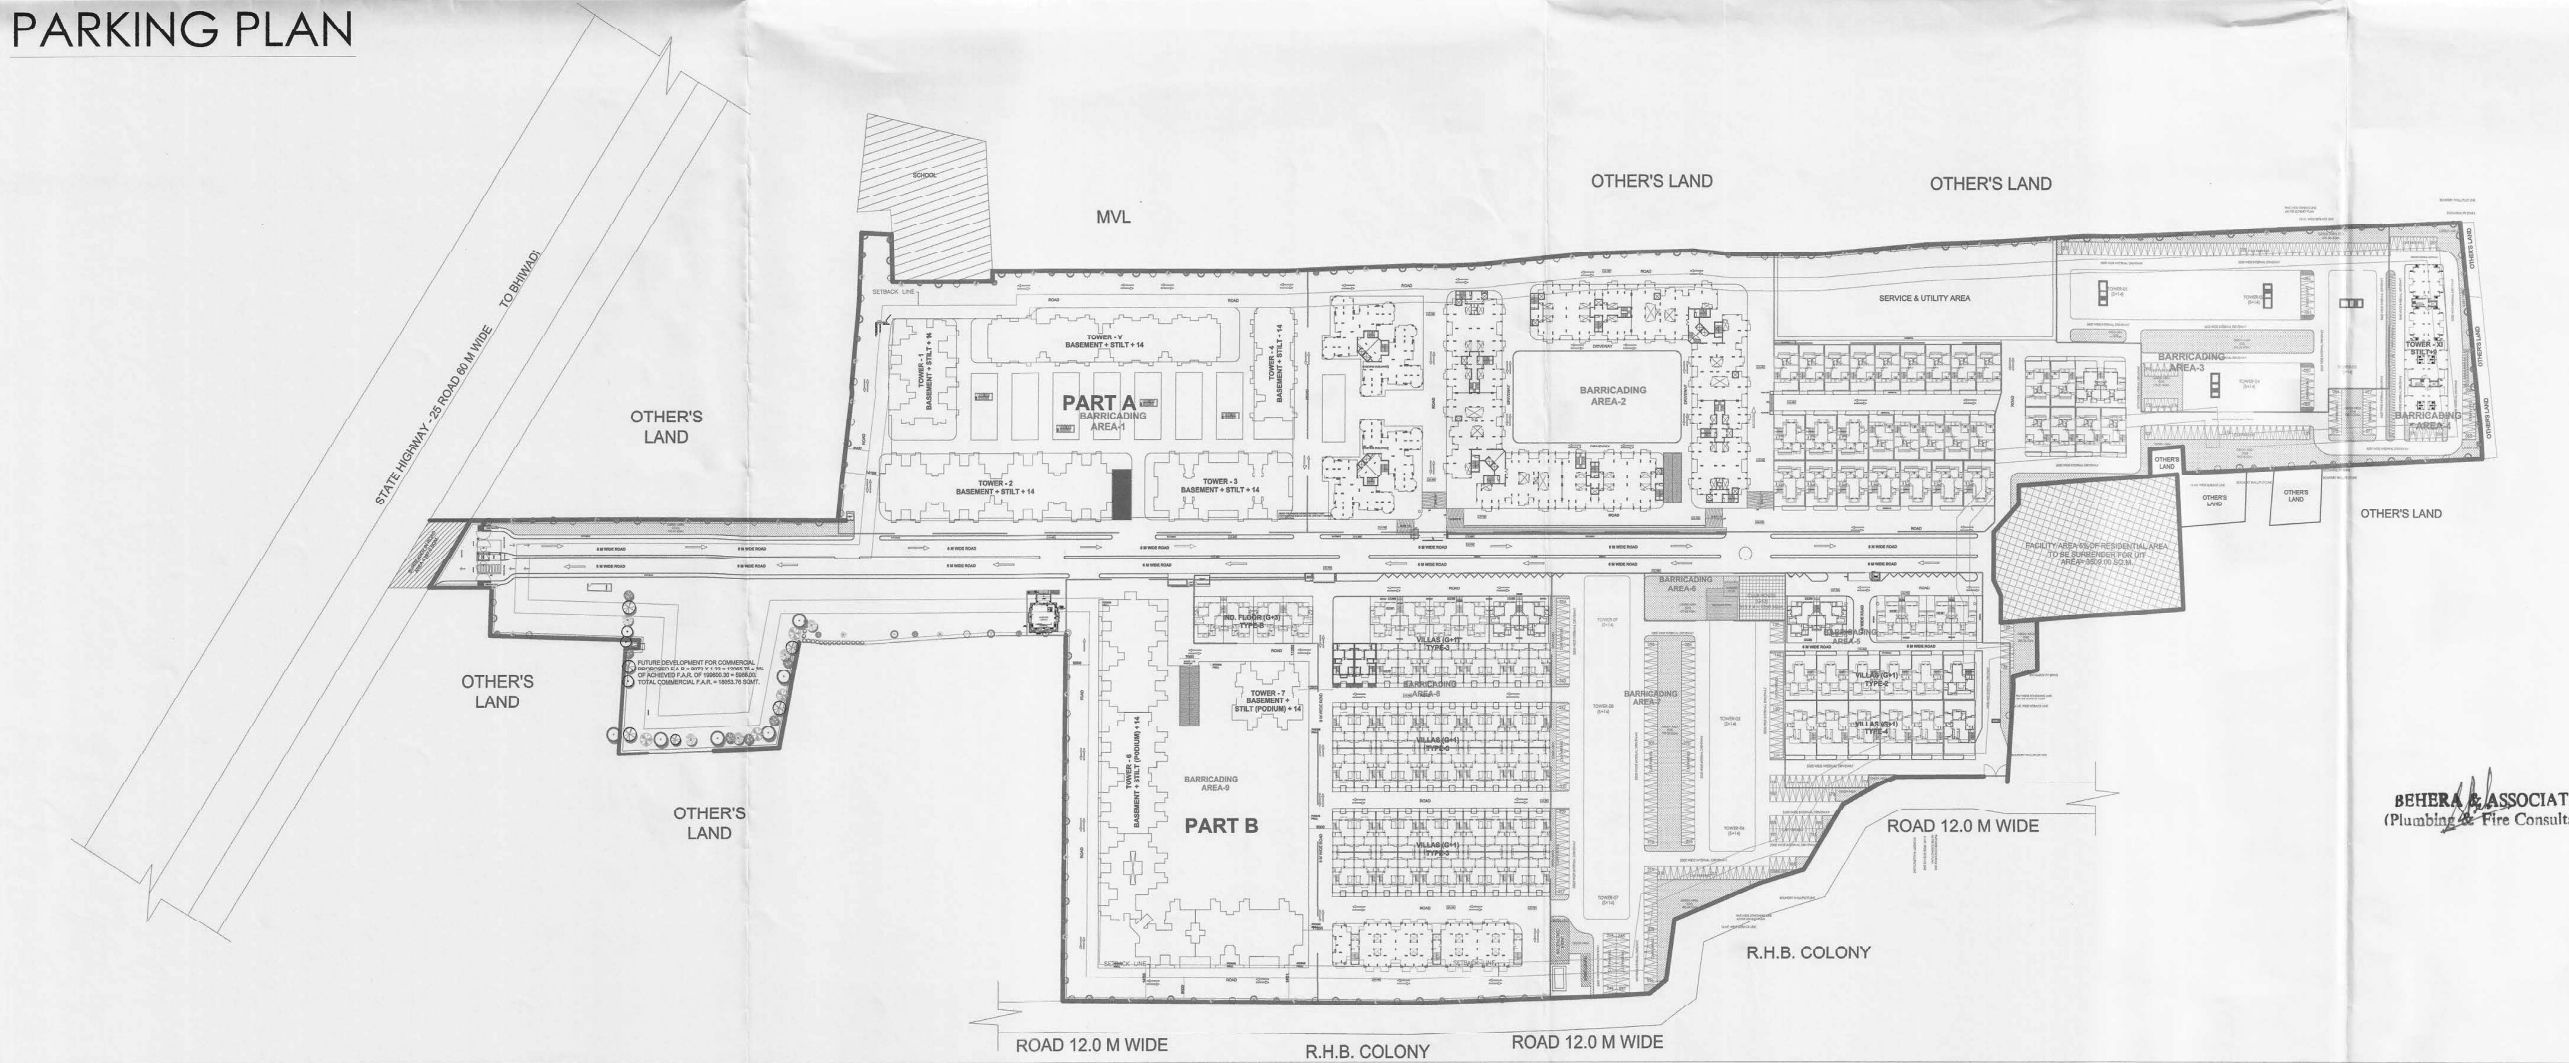

TOWER W/SC. COVERED CAR AND SCOOTER PARKING DETAILS OF PROPOSED AREA				
S.NO	TOWER NAME	COVD. CAR PARKING	COVD. SCOOTER PARKING	UNIT
1	TOWER - 1	15	75	NOX
2	TOWER - 2	15	75	NOX
3	TOWER - 3	15	75	NOX
4	TOWER - 4	15	75	NOX
5	TOWER - 5	15	75	NOX
6	TOWER - 6	15	75	NOX
7	TOWER - 7	15	75	NOX
8	TOWER - 8	15	75	NOX
9	TOWER - 9	15	75	NOX
	TOTAL	144	630	

TYPE :	DATE :	NORTH :
SITE PLAN	09-10-2018	
SHEET NO : -----	SCALE : N.T.S.	