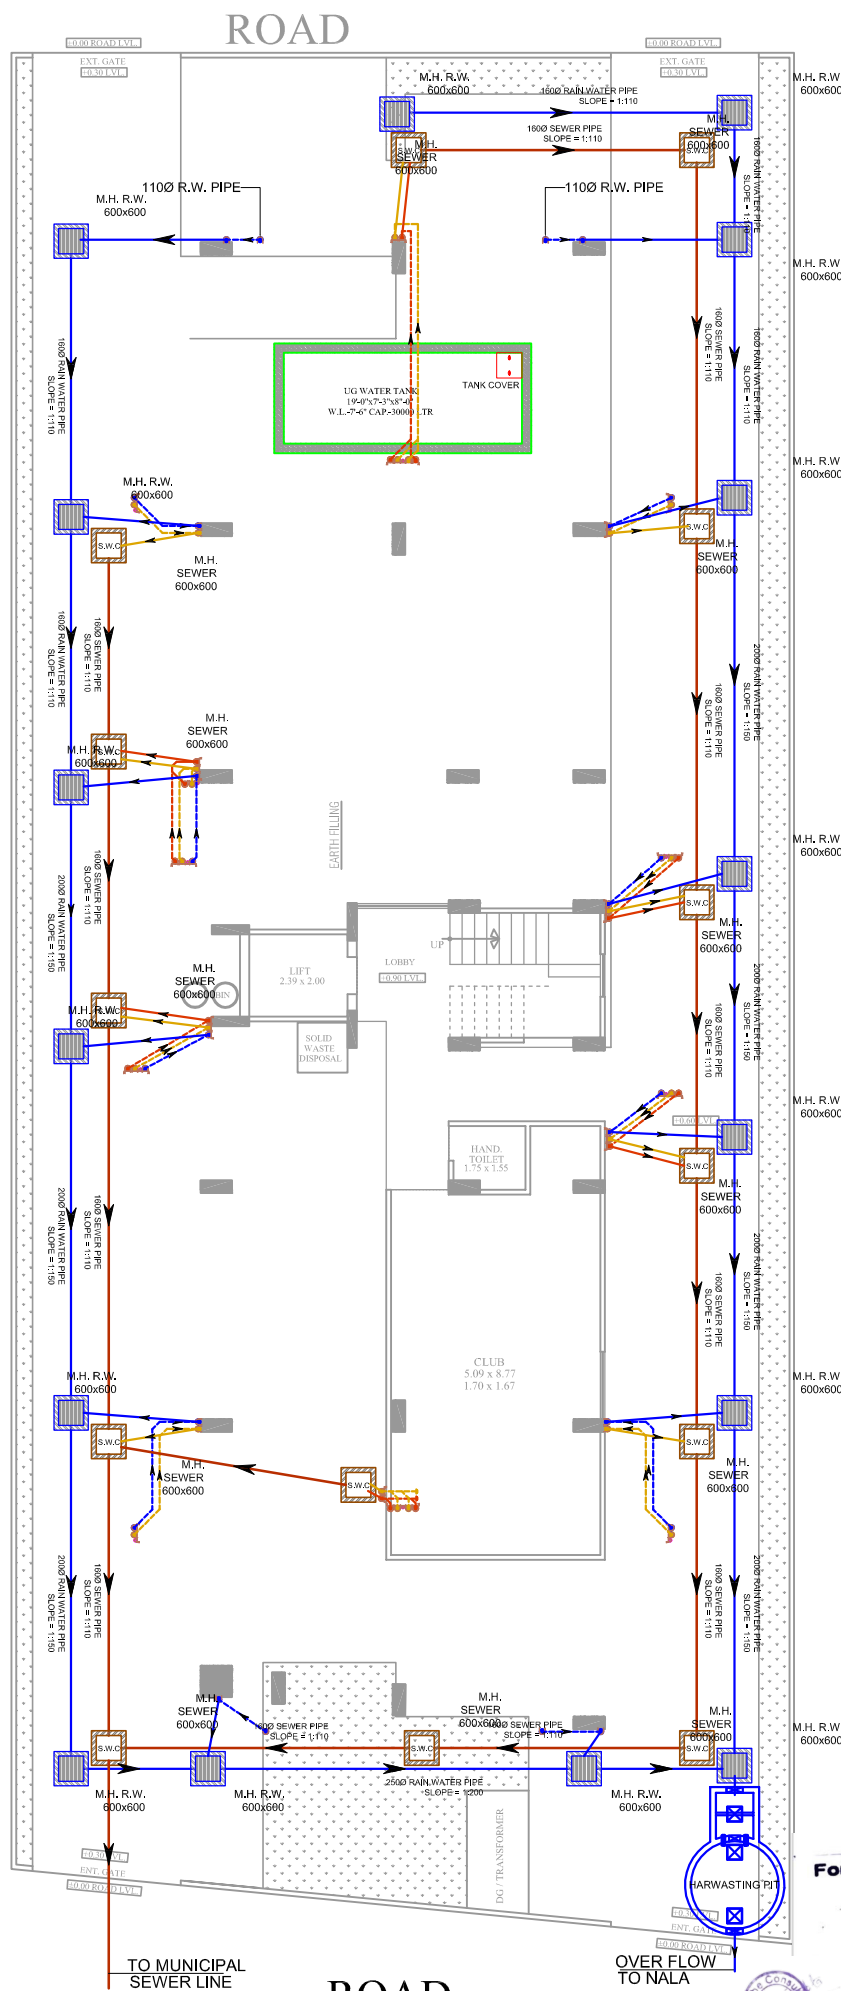




PROPOSED STILT FLOOR DRAINAGE LAYOUT

THIS DRAWING IS THE SOLE PROPERTY OF M/S AKRITI AYOJAN AND IS NOT TO BE COPIED, USED OR REPRODUCED FOR ANY PURPOSE, OTHER THAN FOR WHICH IT HAS BEEN LOANED.

LEGEND:-

1	R/W PIPE	
2	WATER PIPE	
3	VENT PIPE	
4	COLD WATER SUPPLY (CWS)	
5	HOT WATER SUPPLY (HWS)	
6	RAIN WATER PIPE	
7	SEWER LINE - EXTERNAL	
8	SEWER LINE - INTERNAL	
9	SEWER LINE - MANHOLE	
10	SEWER LINE - MANHOLE	
11	SEWER LINE - MANHOLE	
100	SEWER LINE - MANHOLE	

MEP CONSULTANT :-

cube consultant
A-8, PATH NO. 4, JAMUNA NAGAR,
SODALA, JAIPUR-302006,
MAIL:- cubemep@gmail.com,
Ph. No. 0141 2221089
Mob. No. +91 9214308430, +91 9785427711

DESIGN BY:- RAMESH KUMAR DATE:- 02-08-2024

REVISION:- R0

TITLE:-

PROPOSED STILT FLOOR DRAINAGE LAYOUT

WORKING DRAWINGS

SCALE:- 1/4" = 1' 0"

DATE:-

PROJECT:-

PROPOSED BUILDING AT PLOT NO. 51, RAILAXMI ENCLAVE-X, MANPUR DEVRI, GOLIAWAS, TEH. SANGANER, JAIPUR.

OWNER:-

ASKG HOMES
RA, Suraj Kumar Purohit (PARTNER)

ARCHITECT

M/S AKRITI AYOJAN

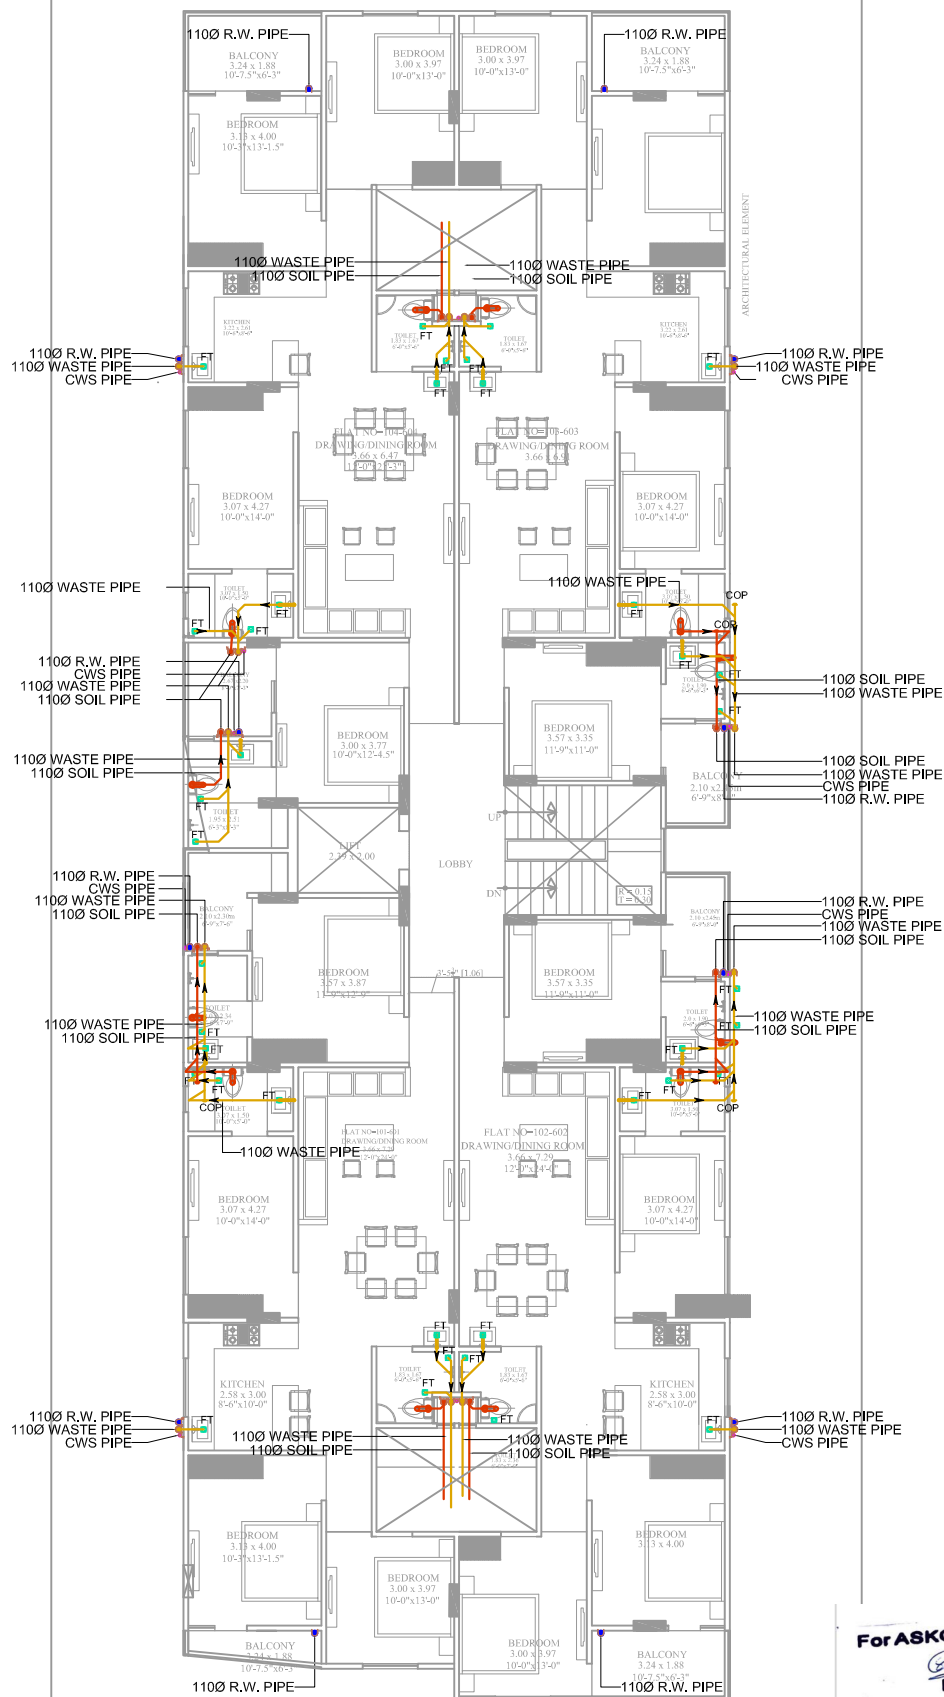
ARCHITECTS, INTERIOR DESIGNERS,

B-47, THIRD FLOOR, NARAYAN TOWER, JEM BELL, GOPALPURA, JAIPUR-302006, RAJASTHAN

9211541511
www.akritiayojan.com

DATE:-

NORTH :-



PROPOSED GROUND, 1st TO 5th FLOOR DRAINAGE LAYOUT

THIS DRAWING IS THE SOLE PROPERTY OF
M/S. AKRITI AYOJAN AND IS NOT TO BE COPIED,
USED OR REPRODUCED FOR ANY PURPOSE
OTHER THAN FOR WHICH IT HAS BEEN LOANED.

LEGEND:-

1	SOIL PIPE	
2	WASTE PIPE	
3	VENT PIPE	
4	COLD WATER SUPPLY (CWS)	
5	HOT WATER SUPPLY (HWS)	
6	RAIN WATER PIPE	
7	SEWER LINE - EXTERNAL	
8	SEWER WATER MAINLINE PIPE	
9	SEWERAGE MANHOLE	M.S.
10	SEWER WATER MANHOLE	M.S.
11	WATER TRAP	
12	WATER TRAP	
13	FLOOR DRAIN	
14	FLOOR DRAIN	
15	FLOOR DRAIN	
100	FLOOR DRAIN	

MEP CONSULTANT :-

cube consultant
A-8, PATH NO. 4, JANGRA NAGAR,
SODALA, JALPUR-302006.
MAIL:- cubemep@gmail.com
Ph. No. 0141 2221089
Mob. No. +91 9214308430 +91 9785427711

DEALT BY:-
RAMESH KUMAR
REVISION:-
R0
DATE:-
02-08-2024

TITLE:-
PROPOSED GROUND, 1st TO 5th
FLOOR DRAINAGE LAYOUT
WORKING DRAWING

SCALE:- 1=100 DATE:-

PROJECT:-

PROPOSED BUILDING AT PLOT NO. 51,
KAILASHI ENCLAVE, MANPUR DEVI,
GOLLANASTETI SANGHAN, JALPUR

OWNER:-
ASKG HOMES
Mr. Suresh Kumar Prasad(PARTNER)

ARCHITECT
M/S AKRITI AYOJAN

ARCHITECTS, INTERIOR DESIGNERS.
B-47, THIRD FLOOR, RAJASTHAN TOWER, PLOT NO. 1,
GOLLANASTETI SANGHAN, JALPUR.
SUPPLY@AKRITIAYOJAN.COM

DATE:-

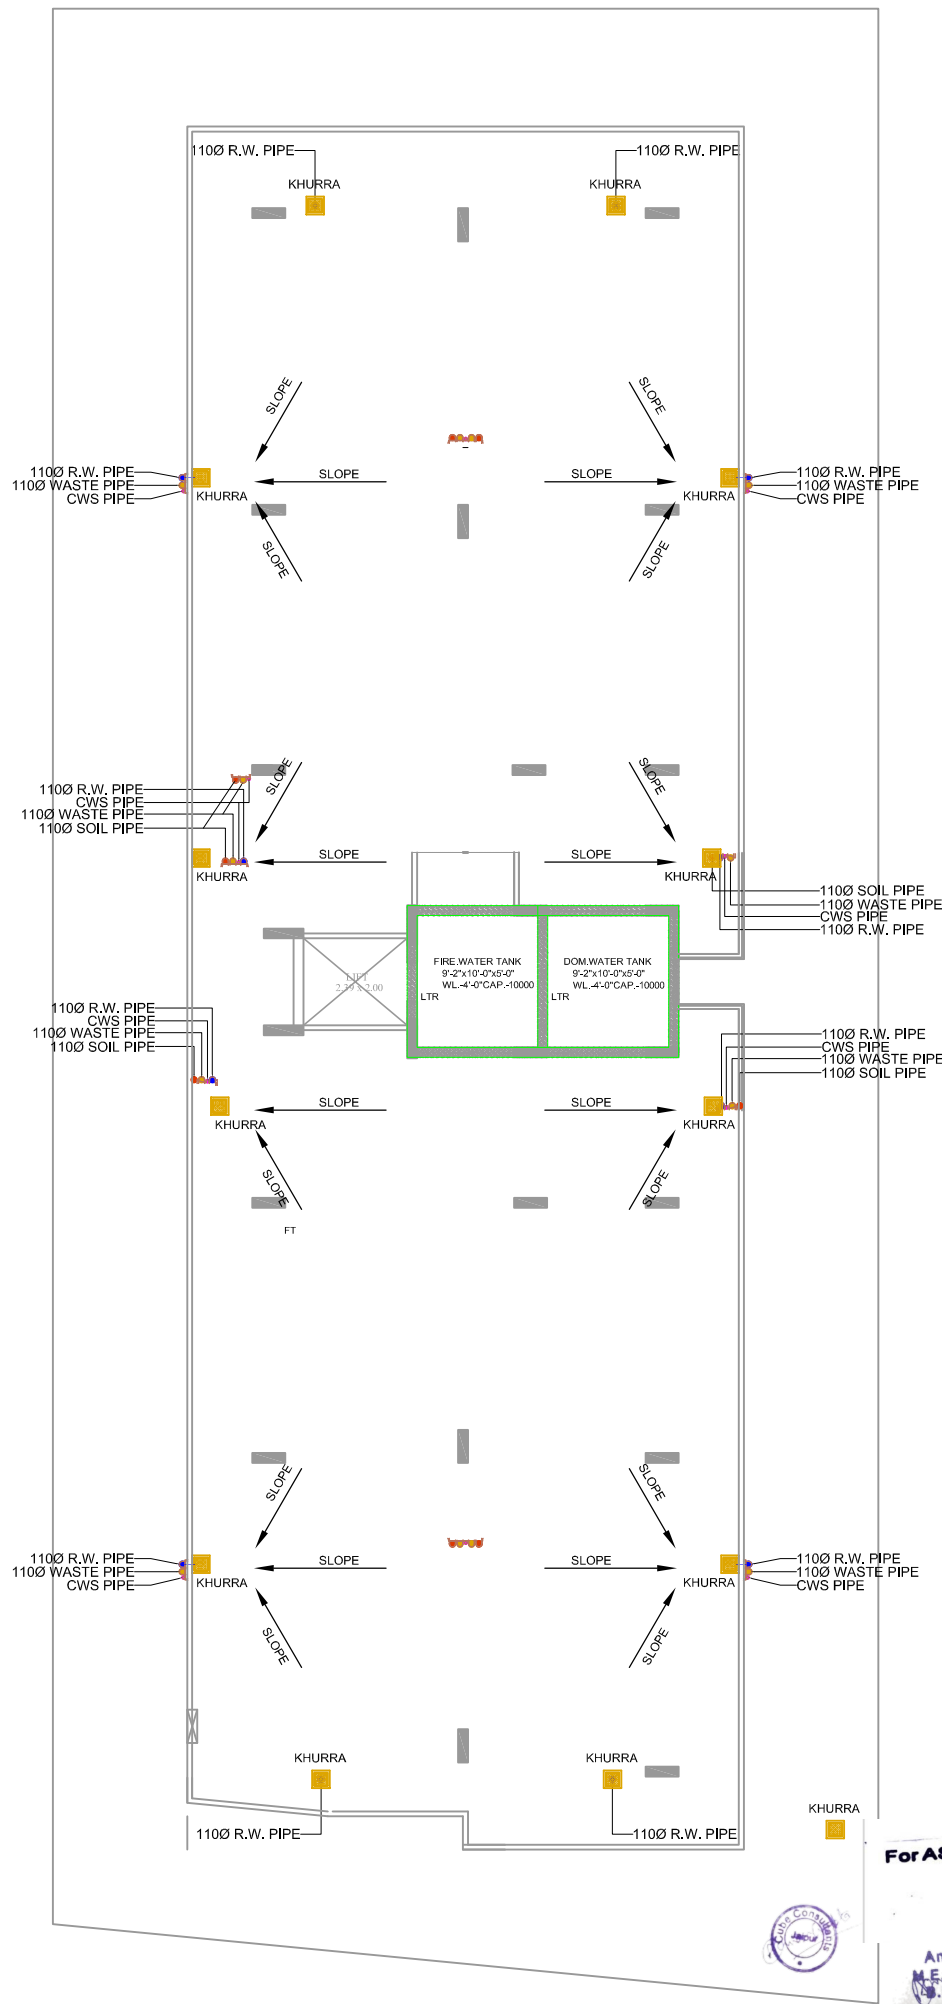
NORTH :-



For ASKG HOMES
Partner
PARTNER



Aman Gupta
M.E.P. Consultant
S.E. Electrical



PROPOSED TERRACE FLOOR DRAINAGE LAYOUT

THIS DRAWING IS THE SOLE PROPERTY OF M/S AKRITI AYOJAN AND IS NOT TO BE COPIED, USED OR REPRODUCED FOR ANY PURPOSE OTHER THAN FOR WHICH IT HAS BEEN LOANED.

LEGEND:-

1	R.W. PIPE	
2	WASTE PIPE	
3	SOIL PIPE	
4	COLD WATER SUPPLY (CWS)	
5	WATER SUPPLY (WSS)	
6	WATER SUPPLY (WSS)	
7	WATER SUPPLY (WSS)	
100	WATER SUPPLY (WSS)	

MEP CONSULTANT :-

cube consultant
A-3, PATH NO. 4, JAMUNA NAGAR,
SODILA, JAIPUR-302005,
MAIL:- cubemep@gmail.com,
Ph. No. 0141 2221089
Mob. No. +91 9214308430, +91 9785427711

DESIGNED BY :- RAMESH KUMAR
CHECKED BY :- RO
DATE :- 02-08-2024

TITLE:-

PROPOSED TERRACE FLOOR DRAINAGE LAYOUT

WORKING DRAWINGS

SCALE:- 1=100 DATE:-

PROJECT:-

PROPOSED BUILDING AT PLOT NO. 51, RAULAXMI ENCLAVE-X, MANPUR DEVRI, GOLIWAS, TEH SANGANER, JAIPUR

OWNER:-

ASG HOMES
M/S. Suresh Kumar Prasad (PARTNER)

ARCHITECT

M/S AKRITI AYOJAN

ARCHITECTS, INTERIOR DESIGNERS

B-40, THIRD FLOOR, MADHULAN TOWER, JEM BELL, GOPALPURA, JAIPUR-302016, (0141) 2221089
www.akritiayojan.com

DATE:- NORTH :-