


DRAINAGE LEGEND:-

 CWP	Ø50MM CWS O.H.T FILLING
 FWP	Ø50MM FWS.H.T FILLING
	Ø50MM CWS O.H.T FILLING
	Ø50MM FWS.H.T FILLING

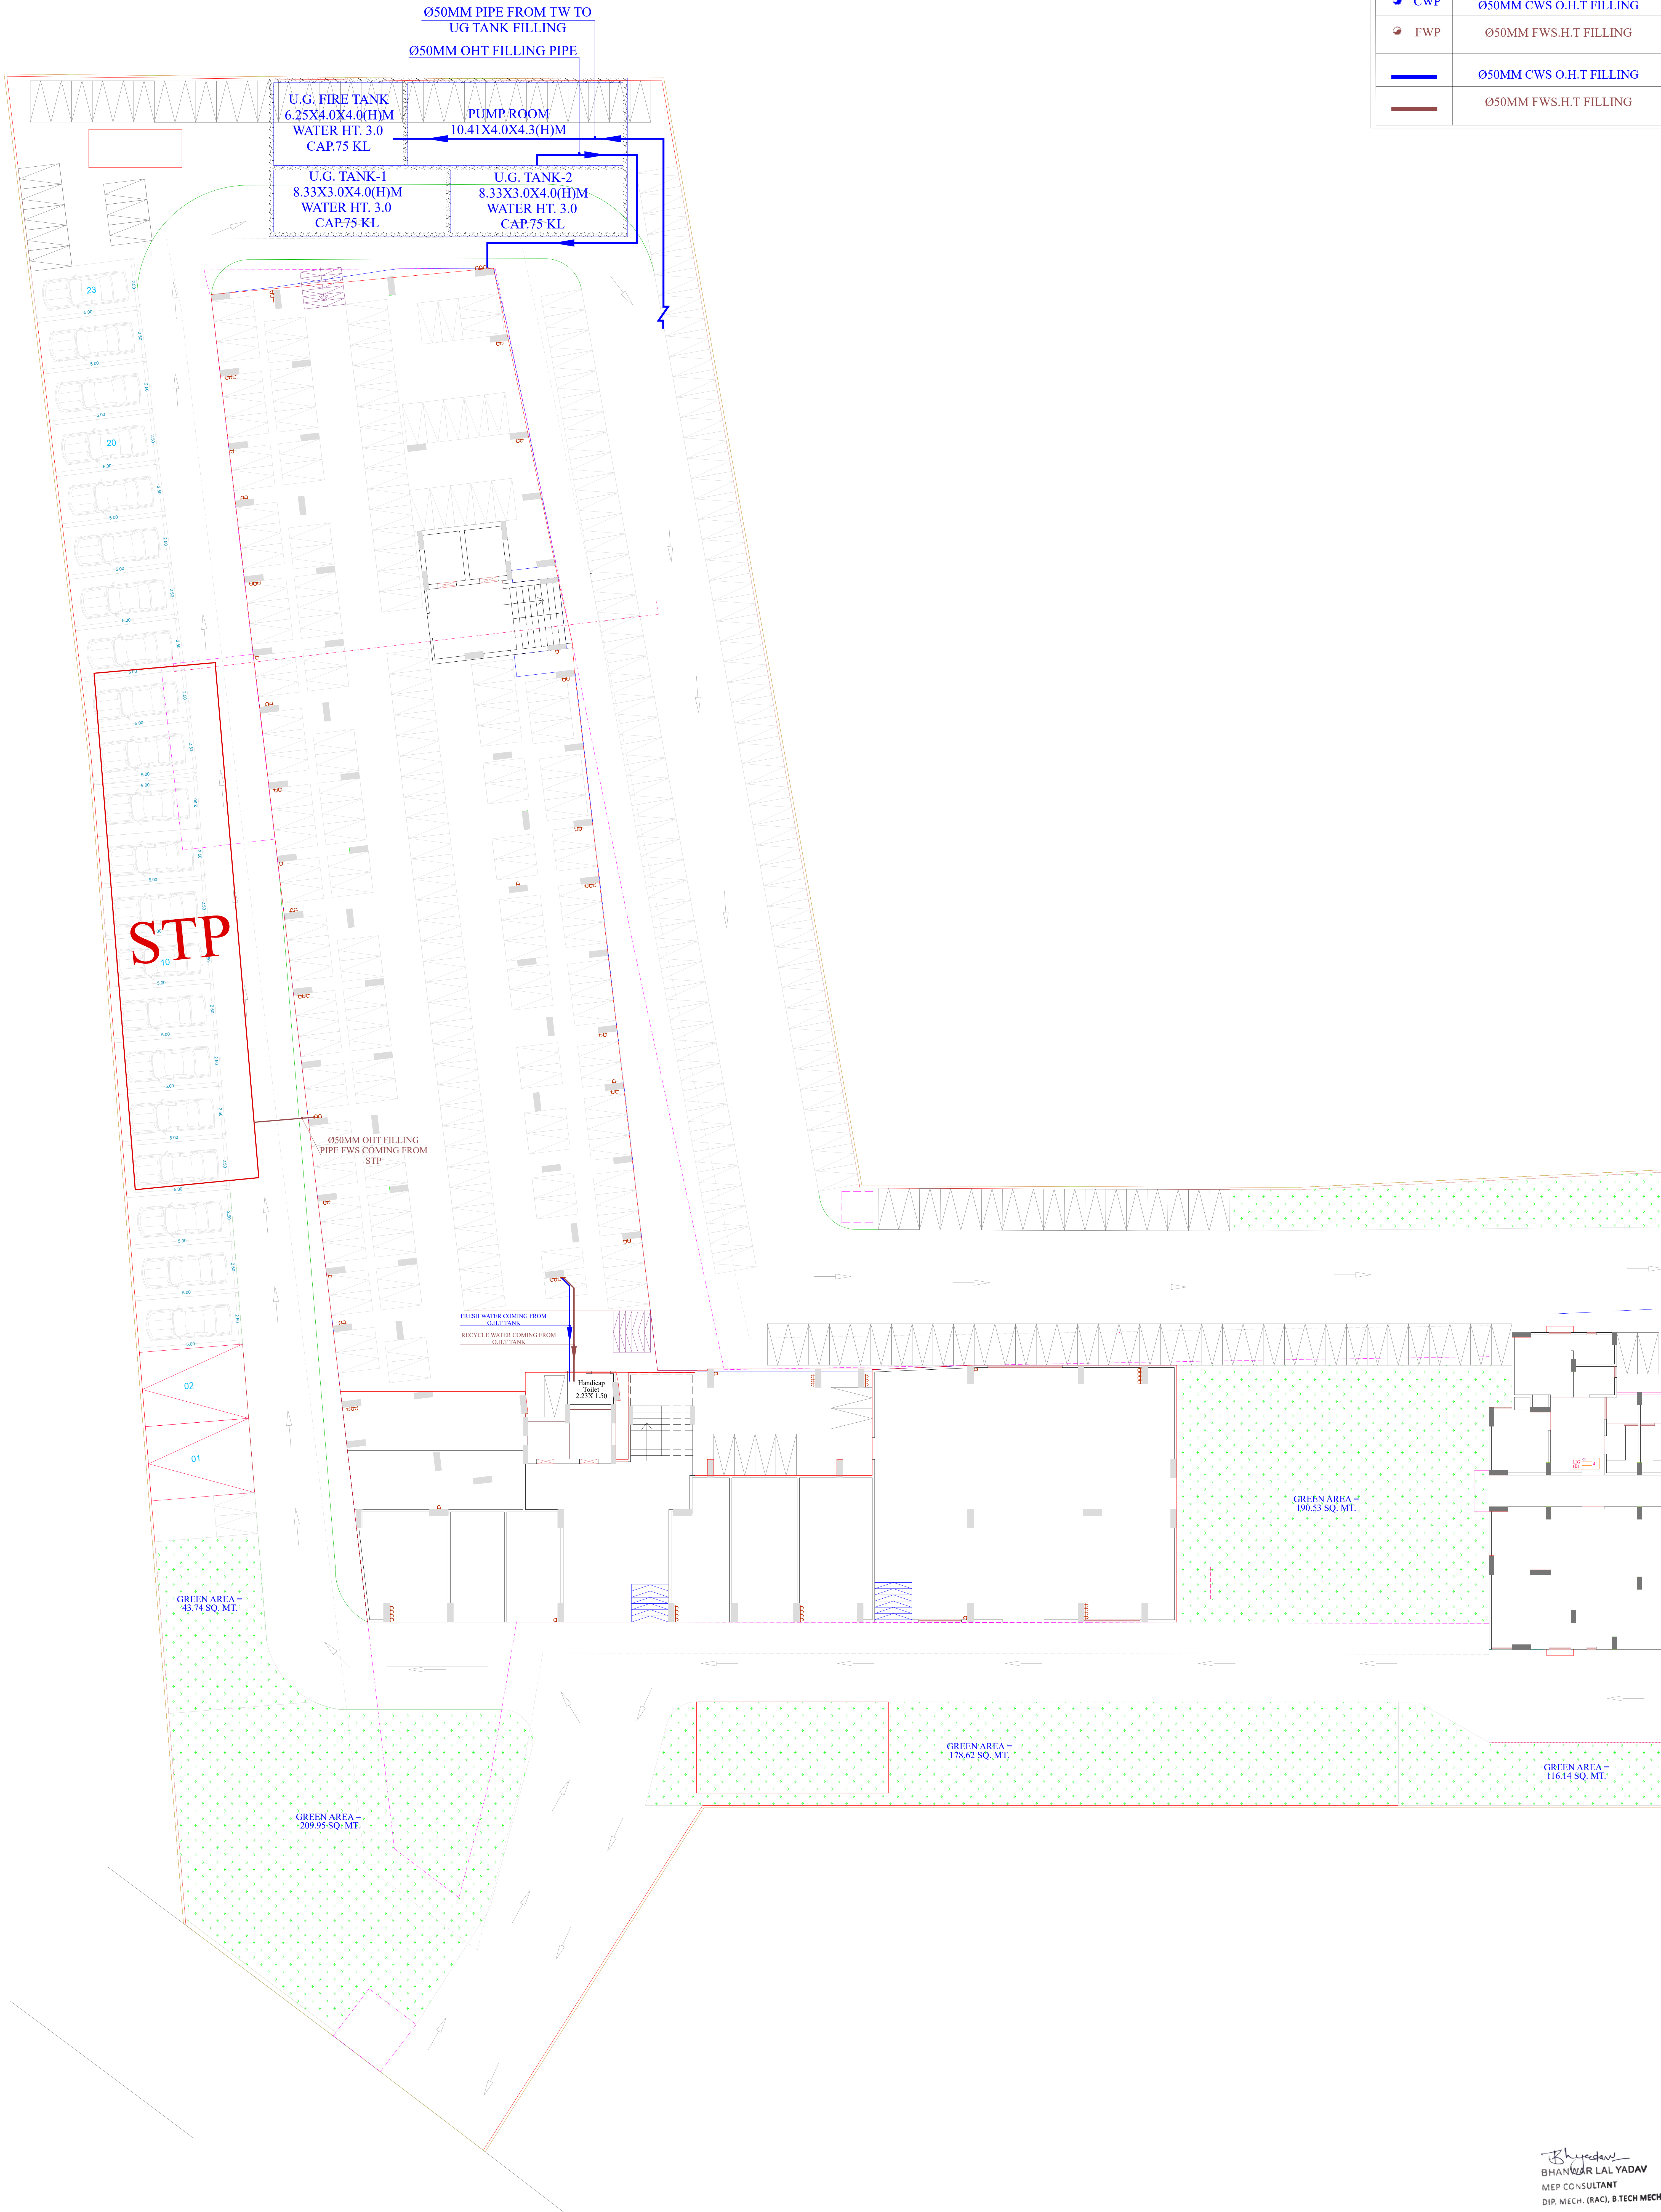

REV. NO.	DESCRIPTION TO REVISION	REV. BY	DATE
R-00	EXTERNAL FLOOR DRAINAGE PLAN	AZHAR	19.02.2025
-	-	-	-
-	-	-	-
ARCHITECT

ANKIT SHARMA

ARCHITECTS + INTERIORS + & CONSTRUCTIONS

B-4, C-46, VISHVA APARTMENT POKHRA MARG, BHUP NAGAR, JAIPUR

Phone: 0141-4090251, Mobile: (+91) 9928407365

email: arch_ankit@yahoo.com

STRUCTURAL CONSULTANT

CLIENT

PROJECT NAME

AURIC AQUA HOMES

PROPOSED RESIDENTIAL GROUP HOUSING SINGLE PORTA OF

CHIEF MINISTERS, JANAWAS YOUNA 2015 (UNDER PROVISION 3A)

IN KHASRA NO. - 2020, 2021, 2023, 2036 AT

VILLAGE - GONER, TEGOL - SANGHER, DISTT - JAIPUR

DWG TITLE

EXTERNAL_FLOOR_WATER_SUPPLY_PLAN

DWG STATUS

FOR_RERA_SUBMISSION

MEP CONSULTANTS



MEPEX

ENRICH YOUR BUILDING ANATOMY

H.O.: S.R. SPORTS COMPLEX
HATOJ MOD, SIRSI ROAD,
JAIPUR, 302012. B.O.: 401 & 402,
RAGHU SAPPHIRE CENTER,
CIVIL LINES, JAIPUR, 302006.
Mo. No.-9571758110, 7568093164
Email: mepexconsultant@gmail.com
teammepex@gmail.com


DEALT BY:

AZHAR

CHECKED BY:

AVINASH

DIRECTION:

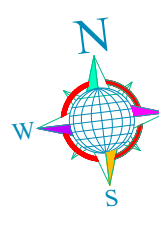

DRAWN NO.:

MPX/JUP/RES/EXT-DR/R/00

SCALE:

SHEET SIZE:

 
 
 
A1

DATE:

19.02.2025



BHANWAR LAL YADAV
MEP CONSULTANT
DIP. MECH. (RAC), B.TECH MECH.

DRAINAGE LEGEND:-

	RWP	Ø110MM&160MM RAIN WATER PIPE
	SWP	Ø110MM&160MM SOIL WATER PIPE
	WWP	Ø110MM&160MM WASTE WATER PIPE
	CWP	Ø50MM CWS O.H.T FILLING
	FWP	Ø50MM FWS.H.T FILLING
		Ø110MM&160MM RAIN WATER PIPE
		Ø110MM&160MM SOIL WATER PIPE
		Ø110 MMWASTE WATER PIPE
		Ø50MM CWS O.H.T FILLING
		Ø50MM FWS.H.T FILLING



REV. NO.	DESCRIPTION TO REVISION	REV. BY	DATE	ARCHITECT	STRUCTURAL CONSULTANT	CLIENT	DWG TITLE	MEP CONSULTANTS	DEALT BY:	CHECKED BY:	DIRECTION:		
R-00	EXTERNAL CEILING DRAINAGE PLAN	AZHAR	19.02.2025				EXTERNAL CEILING DRAINAGE PLAN	 MEPEX ENRICH YOUR BUILDING ANATOMY H.O.: S.R. SPORTS COMPLEX HATOJ MOD, SIRSI ROAD, JAIPUR, 302012. B.O.: 401 & 402, RAGHU SAPPHIRE CENTER, CIVIL LINES, JAIPUR, 302006. Mo. No.-9571758110, 7568093164 Email: mepexconsultant@gmail.com teammepex@gmail.com	AZHAR	AVINASH			
				ANKIT SHARMA ARCHITECTS + INTERIORS + & CONSTRUCTIONS B-4, C-46, VIDHYA APARTMENT PARKS MARG, BHATI NAGAR, JAIPUR Phone: 0141-4092511, Mobile: (+91) 9928407365, email: arch_ankit@yahoo.com		PROJECT NAME AURIC AQUA HOMES PROPOSED RESIDENTIAL GROUP HOUSING SINGLE PORTIN OF CHIEF MINISTERS, JANAWAS YOUNA 2015 (UNDER PROVISION 3A) IN KHASRA NO. - 2220, 2221, 2232, 2232 AT VILLAGE - CONER, TOSIL - SANGHER, DISTT - JAIPUR	FOR_RERA_SUBMISSION		DRAWN NO.: MPX/JUP/RES/EXT-CEI/R-00	SCALE: NTS	SHEET SIZE: A1	DATE: 19.02.2025	

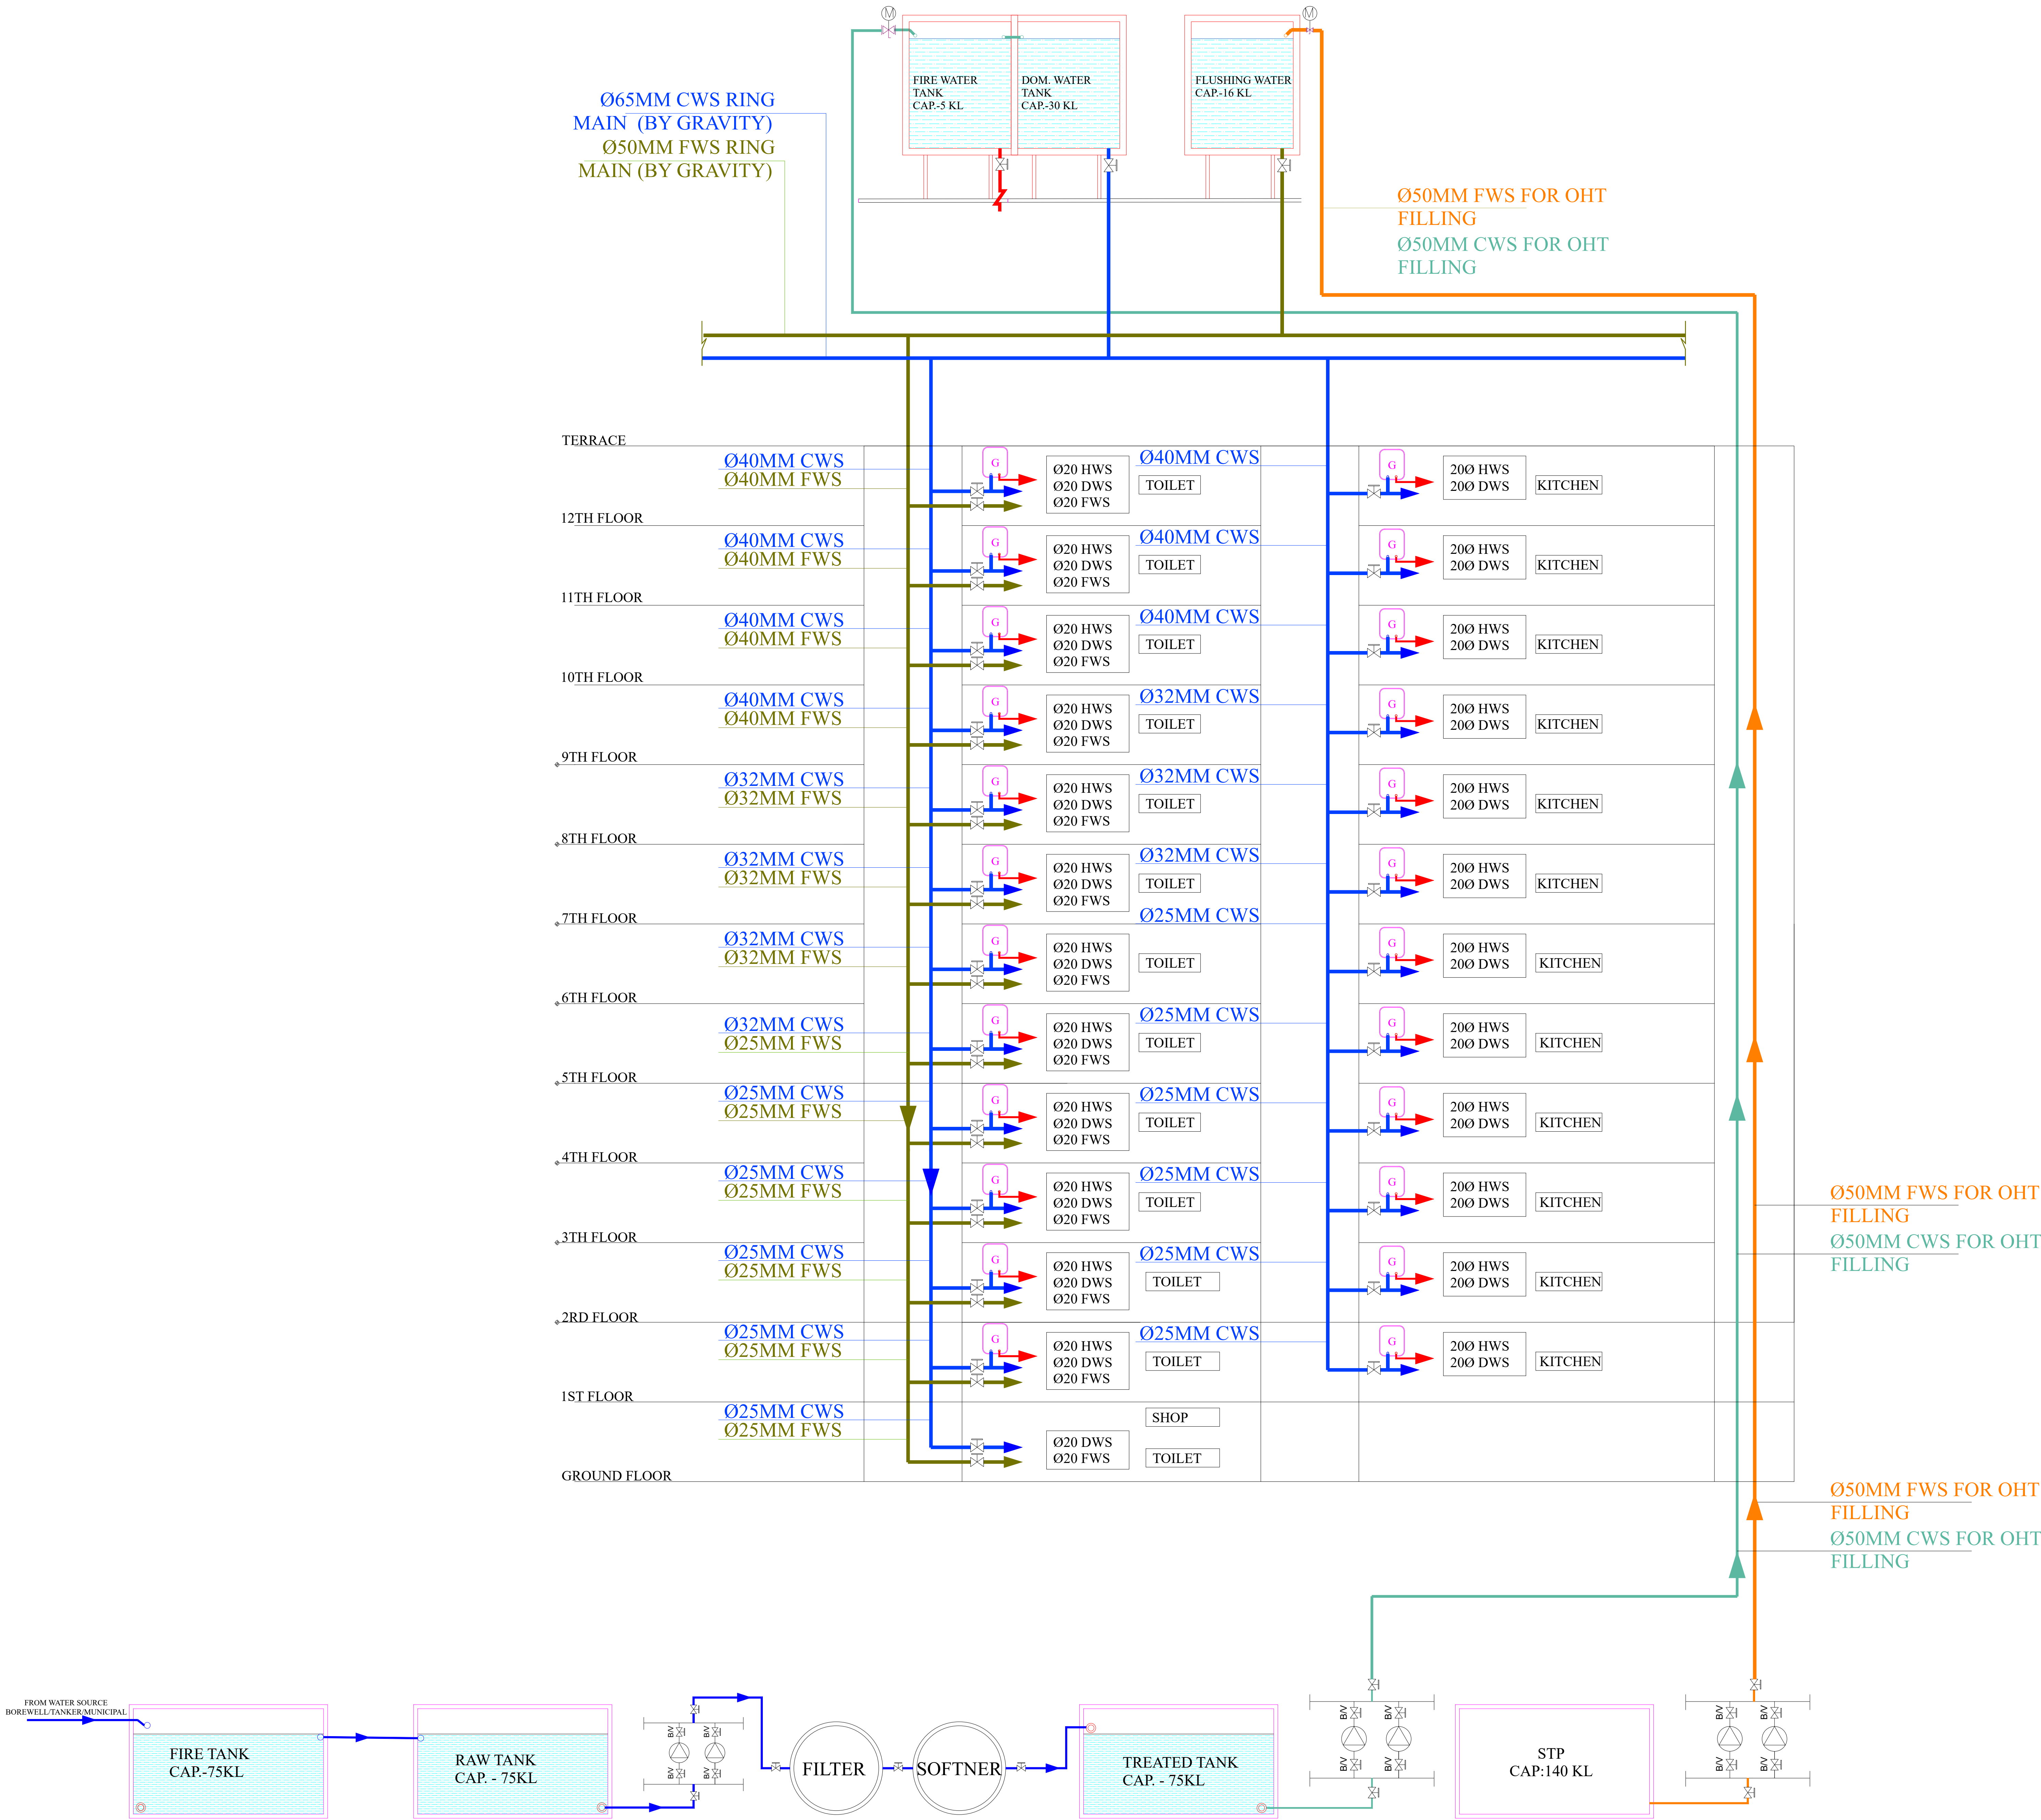

LEGEND:-

CWS	COLD WATER SUPPLY PIPE
FWS	FLUSHING WATER SUPPLY PIPE
HWS	HOT WATER SUPPLY PIPE
DWS	DOMESTIC WATER SUPPLY PIPE
	ISOLATION/ON-OFF VALVE
	ELECTRIC GEYSER
	PRESSURE PUMP
	MOTORIZED/SOLENOID VALVE

Bhupendra
BHANWAR LAL YADAV
MEP CONSULTANT
DIP. MECH. (RAC), B.TECH MECH.

S.NO.	DESCRIPTION	PROJECT :	ARCHITECT:-	PROJECT NAME:-	DRAWING TITLE:-	MEP CONSULTANT:-	DEALT BY	CHKD BY
		AURIC AQUA HOMES JAGATPURA HOUSING SINGLE PATT CHIEF MINISTER'S, JAN AWAS YOJANA-2015 UNDER PROVISION 3A) IN KHASRA NO. - 2520, 2521, 2535, 2536 AT VILLAGE - GONER, TEHSIL - SANGANER, DISTT. - JAIPUR.	ANKIT SHARMA ARCHITECTS * INTERIORS * & CONSTRUCTIONS B-4, C-49, VIDHYA APARTMENT ,PARAS MARG, BAPU NAGAR, JAIPUR Phone- 0141-4069251, Mobile: (+91) 9928407365, email:- arch_ankits@yahoo.com	AURIC AQUA HOMES PROPOSED RESIDENTIAL GROUP HOUSING SINGLE PATT OF CHIEF MINISTER, JAN AWAS YOJANA-2015 (UNDER PROVISION 3A) IN KHASRA NO. - 2520, 2521, 2535, 2536 AT VILLAGE - GONER, TEHSIL - SANGANER, DISTT. - JAIPUR.	WATER SUPPLY SCHEMATIC PLAN	 MEPEX ENRICH YOUR BUILDING ANATOMY H.O.: S.R. SPORTS COMPLEX HATOJ MOD, SIRSI ROAD, JAIPUR, 302012. B.O.: 401 & 402, RAGHU SAPPHIRE CENTER, CIVIL LINES, JAIPUR, 302006. Mo. No.-9571758110, 7568093164 Email: mepexconsultant@gmail.com teammepex@gmail.com	MONIS	AVINASH
				CLIENT NAME:-	DWG STATUS:-		SHEET A1	DIRECTION N
					FOR RERA SUBMISSION		DATE 19.02.2025	