



24.00 MT. WIDE ROAD

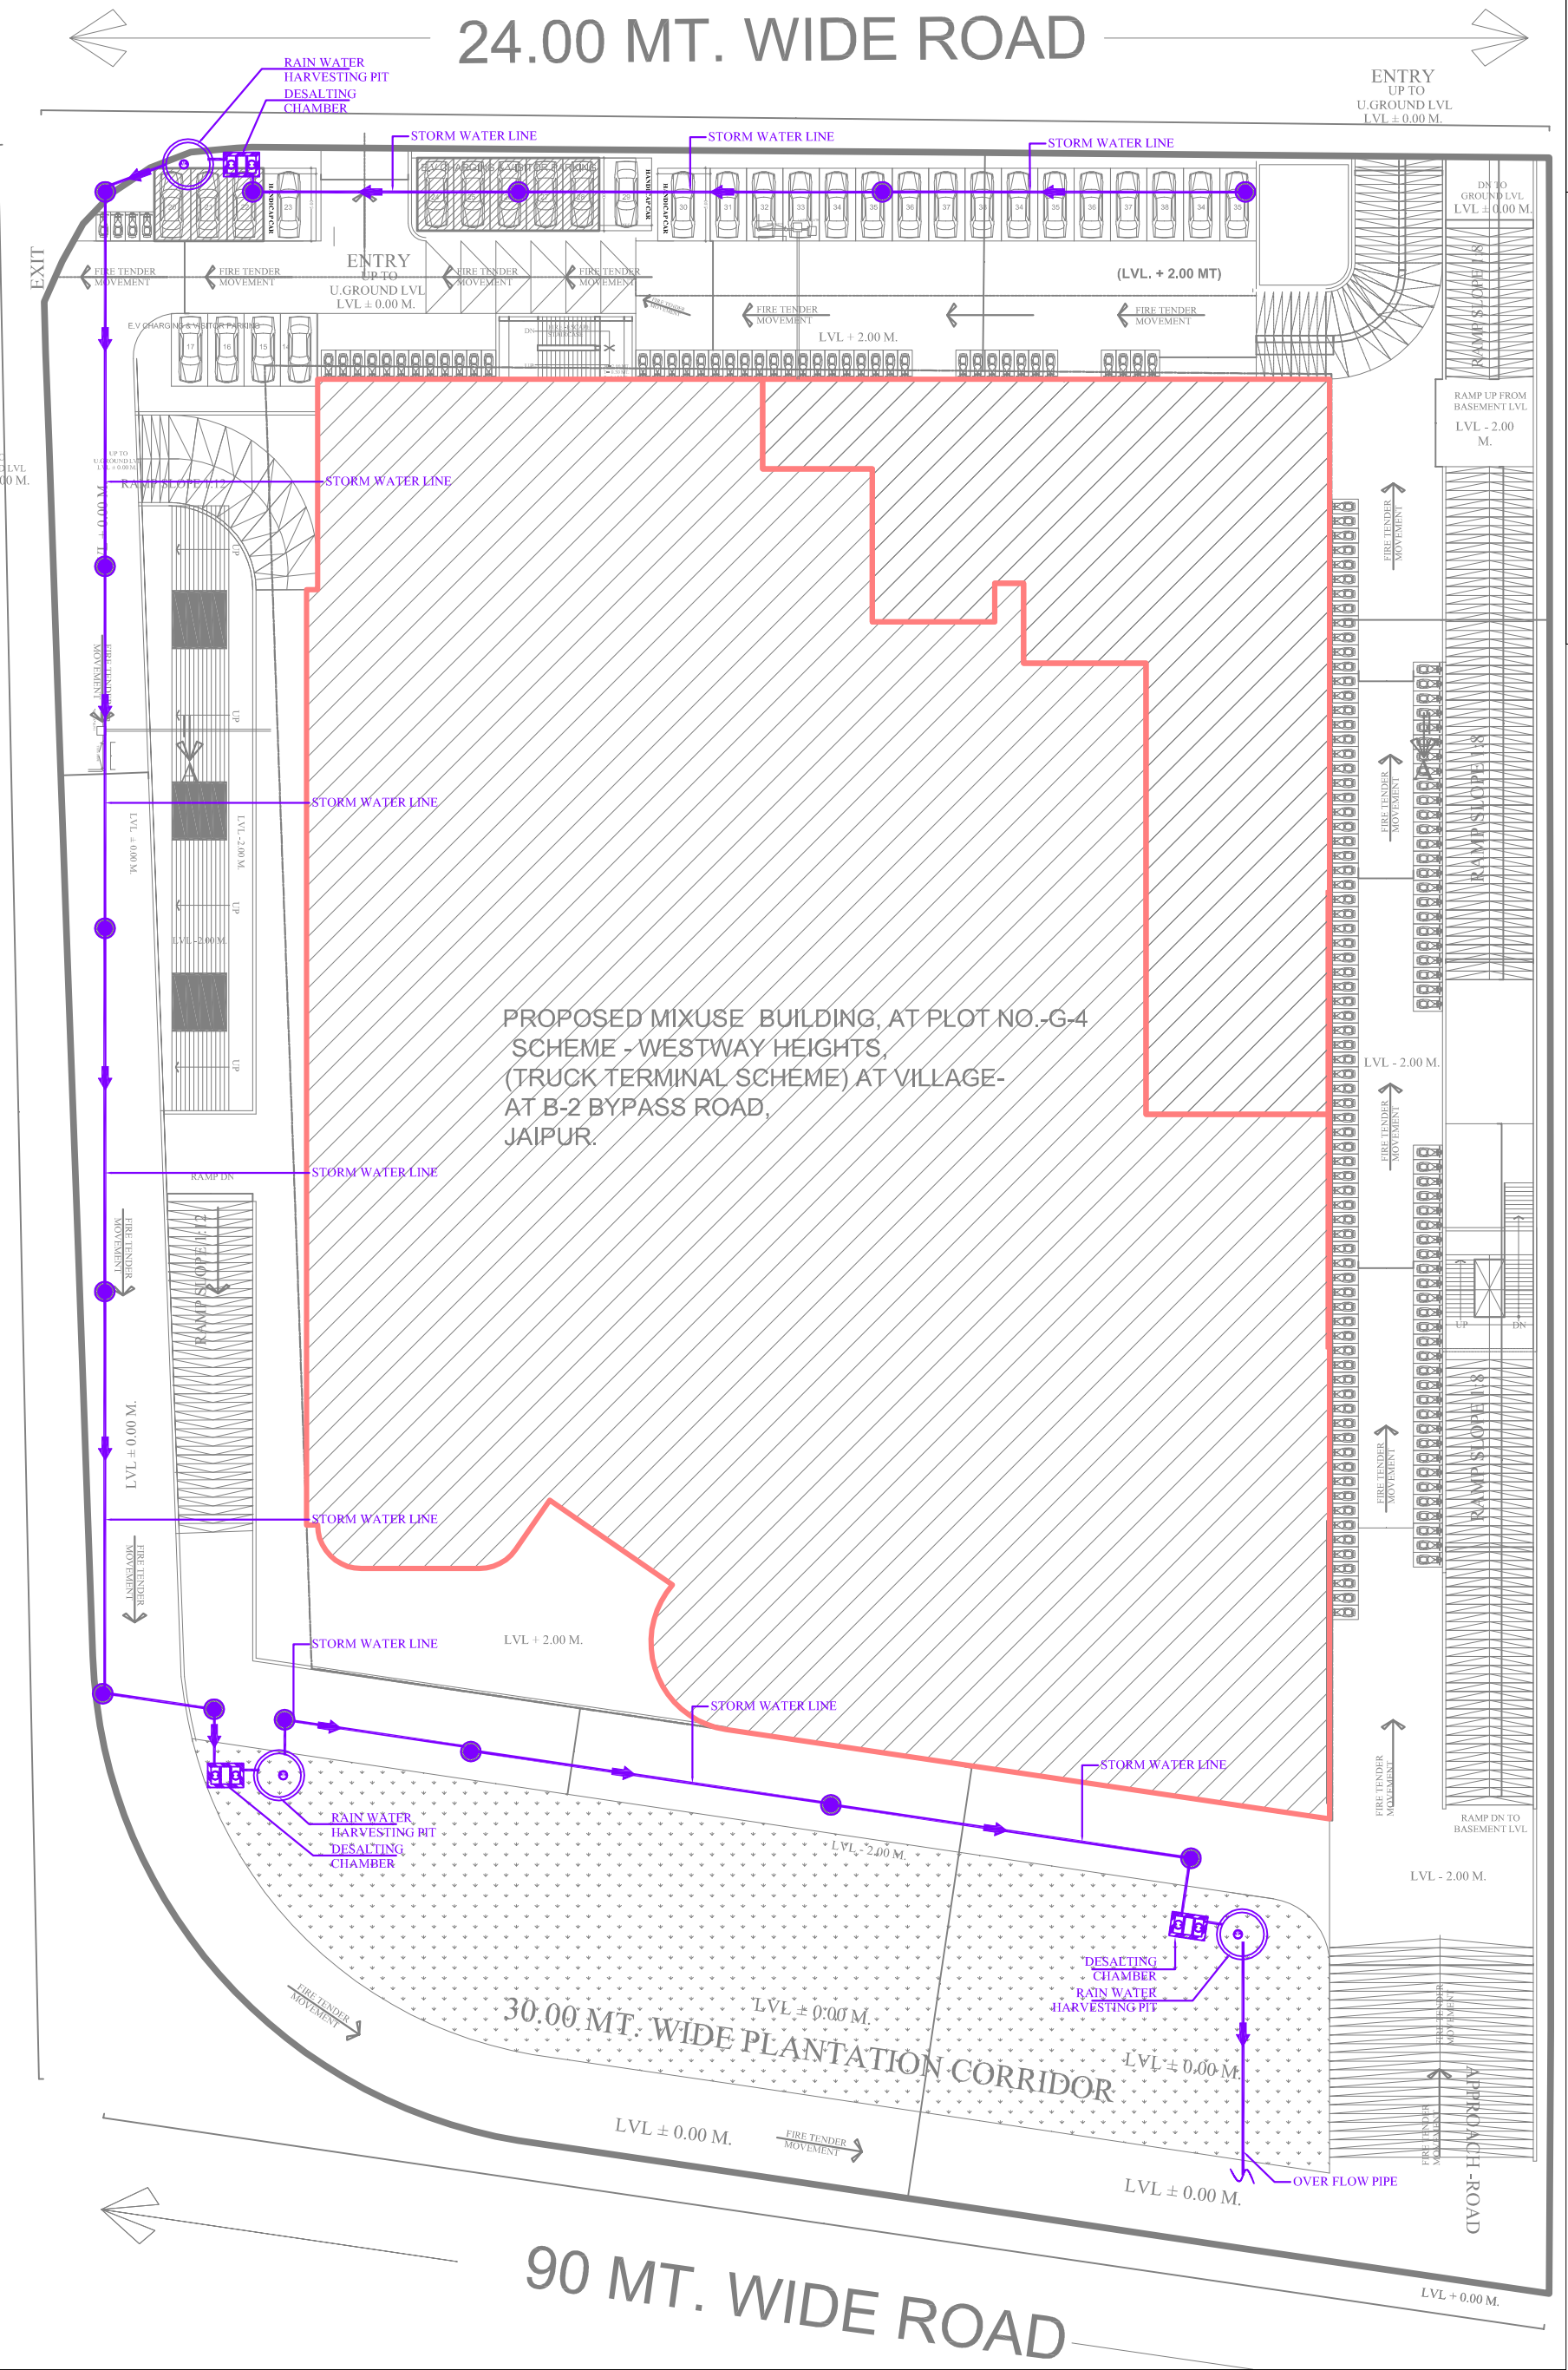

LEGEND FOR STORM:		
CB	CATCH BASIN	
SMH	SEWER MANHOLE FOR RETAIL	
DMH	STORM WATER MANHOLE	
RWH	RAIN WATER HARVESTING PIT	
DC	DESALTING CHAMBER	
SP	STORM LINE	

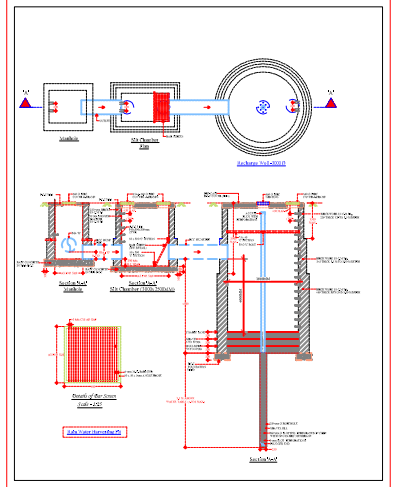

Jagjit Singh
B.Tech, M. Tech
MEP Consultant

M.J. Engineering Consultants Pvt Ltd.

NOTE:-	ARCHITECT		 ARCHITECTURE URBAN PLANNING INTERIORS	LANDSCAPE ARCHITECT:-	STRUCTURE CONSULTANT:-	MEP CONSULTANT:- M.J. ENGINEERING CONSULTANTS PVT. LTD. 606, Madhuban Building 55 Nehru Place Nehru Place New Delhi-11019 Telephone: 91-11-66274552/53/54/44 E-Mail:- mjc@mjc.co.in	REVISIONS:-			PROJECT:- F	
	SITE ADDRESS:- PROPOSED MIXUSE BUILDING, AT PLOT NO.-G-4 SCHEME - WESTWAY HEIGHTS, (TRUCK TERMINAL SCHEME) AT VILLAGE- AT B-2 BYPASS ROAD, JAIPUR.						S.No.	DATE	REMARKS	CLIENT:-	
										DRAWING TITLE	
										SITE PLAN STORM WATER LAYOUT	
										DRAWING NO. REV. NO. SCALE SHEET	
		124, HIMMAT NAGAR , TONK ROAD, JAIPUR PHONE:- +91-8770623771/2/3/7 email:- idmjanipnr@gmail.com, web:- www.idmjanipnr.com									