


SYMBOL	DESCRIPTION
	Ø20 MM WATER SUPPLY PIPE
	Ø32 MM WATER SUPPLY PIPE
	Ø50 MM WATER SUPPLY PIPE
	Ø65 MM WATER SUPPLY PIPE
	Ø80 MM WATER SUPPLY PIPE
	Ø100 MM WATER SUPPLY PIPE
	Ø150 MM WATER SUPPLY PIPE

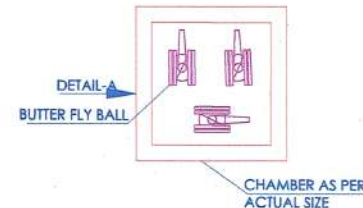


Dr. Ravi Kant Pareek
Ph.D (Environment)
M. Tech (Civil)

GENERAL NOTES : 1. ALL THE DIMENSIONS ON THE DRAWING ARE IN WRITTEN. 2. ONLY WRITTEN DIMENSIONS ARE TO BE FOLLOWED, DRAWING SHOULD NOT BE SCALED IN ANY CIRCUMSTANCES. 3. ALL MEASUREMENTS MUST BE CHECKED AND VERIFIED BY THE CONTRACTORS PRIOR TO EXECUTION OF WORK AT THE SITE. 4. THIS DRAWING IS TO BE READ IN CONJUNCTION WITH ALL RELEVANT STRUCTURAL, ARCHITECTURAL & FACILITY PLANNING DRAWINGS. 5. ANY DISCREPANCIES MUST BE BROUGHT TO THE NOTICE OF THE ENGINEER IMMEDIATELY & PRIOR TO EXECUTION AT SITE. 6. CO-ORDINATION WITH SERVICES SUCH AS HVAC, PLUMBING & ELECTRICAL, ETC. IS THE RESPONSIBILITY OF THE CONTRACTORS. 7. FOR DETAILS, REFER RELEVANT LARGE SCALE DETAIL DRGS. AS INDICATED.	DRAWING TITLE:-	ARCHITECT	MEP SERVICES CONSULTANT	PROJECT :-	SUBMITTED FOR :-			
	EXTERNAL WATER SUPPLY LAYOUT	 CREATIVE STUDIO AR. MANSINGH MEENA 317, THIRD FLOOR, KRISHN SQUARE, OPP. MODERN PUBLIC SCHOOL, BHAGAT SINGH COLONY, BHIMWADI, ALWAR (RAJ.) WEB:- WWW.CSBHIWADI.COM EMAIL ID:- INFO@CSBHIWADI.COM MOB:- 09460478315, PH.- 01493-491290	AMP INFRA SERVICES VILLA NO 16. SHUBHASIS GEETA JAISINGHPURA, BHANKROTA & CHIMANPURA.JAIPUR 302026 EMAIL ID- ampinfrajpr@gmail.com CONTACT NO. :- 9462866389	PROPOSED RESIDENTIAL LAYOUT PLAN AT,KH. 1949 TO 1958, 1960,1976 TO 1978, 1992, 1994 TO 2003, 2008, 2009, 2012 TO 2014, 2016, 2018 TO 2023, 2025 TO 2033, 2008, VILLAGE- GUNTI, TEH.- BEHROR, DISTT. KOTPUTALI-BEHROR (RAJ.)	PRELIMINARY	☐	APPROVAL	☒
					PROPOSAL	☐	GFC	☐
					DATE :- 19-09-2024		NORTH :- 	
DEVELOPER'S :-	M/S RAJENDRA PROMOTERS PVT. LTD. & MAHARAM S/O SH. GHISHARAM				DRAWN :- MO.AJARUDIN			
					APPROVED :- NARESH			
				DRAWING NO.:-	SCALE :-			

SYMBOL	DESCRIPTION
	Ø160 MM SOIL WATER PIPE(DWC)
	Ø200 MM SOIL WATER PIPE(DWC)
	Ø250 MM SOIL WATER PIPE(DWC)
	Ø300 MM SOIL WATER PIPE(DWC)
	Ø350 MM SOIL WATER PIPE(DWC)

SYMBOL	DESCRIPTION
	SOIL WATER CHAMBER (600MM)
	SOIL WATER CHAMBER (900MM)
	SOIL WATER CHAMBER (1200MM)
	SOIL WATER CHAMBER (1500MM)

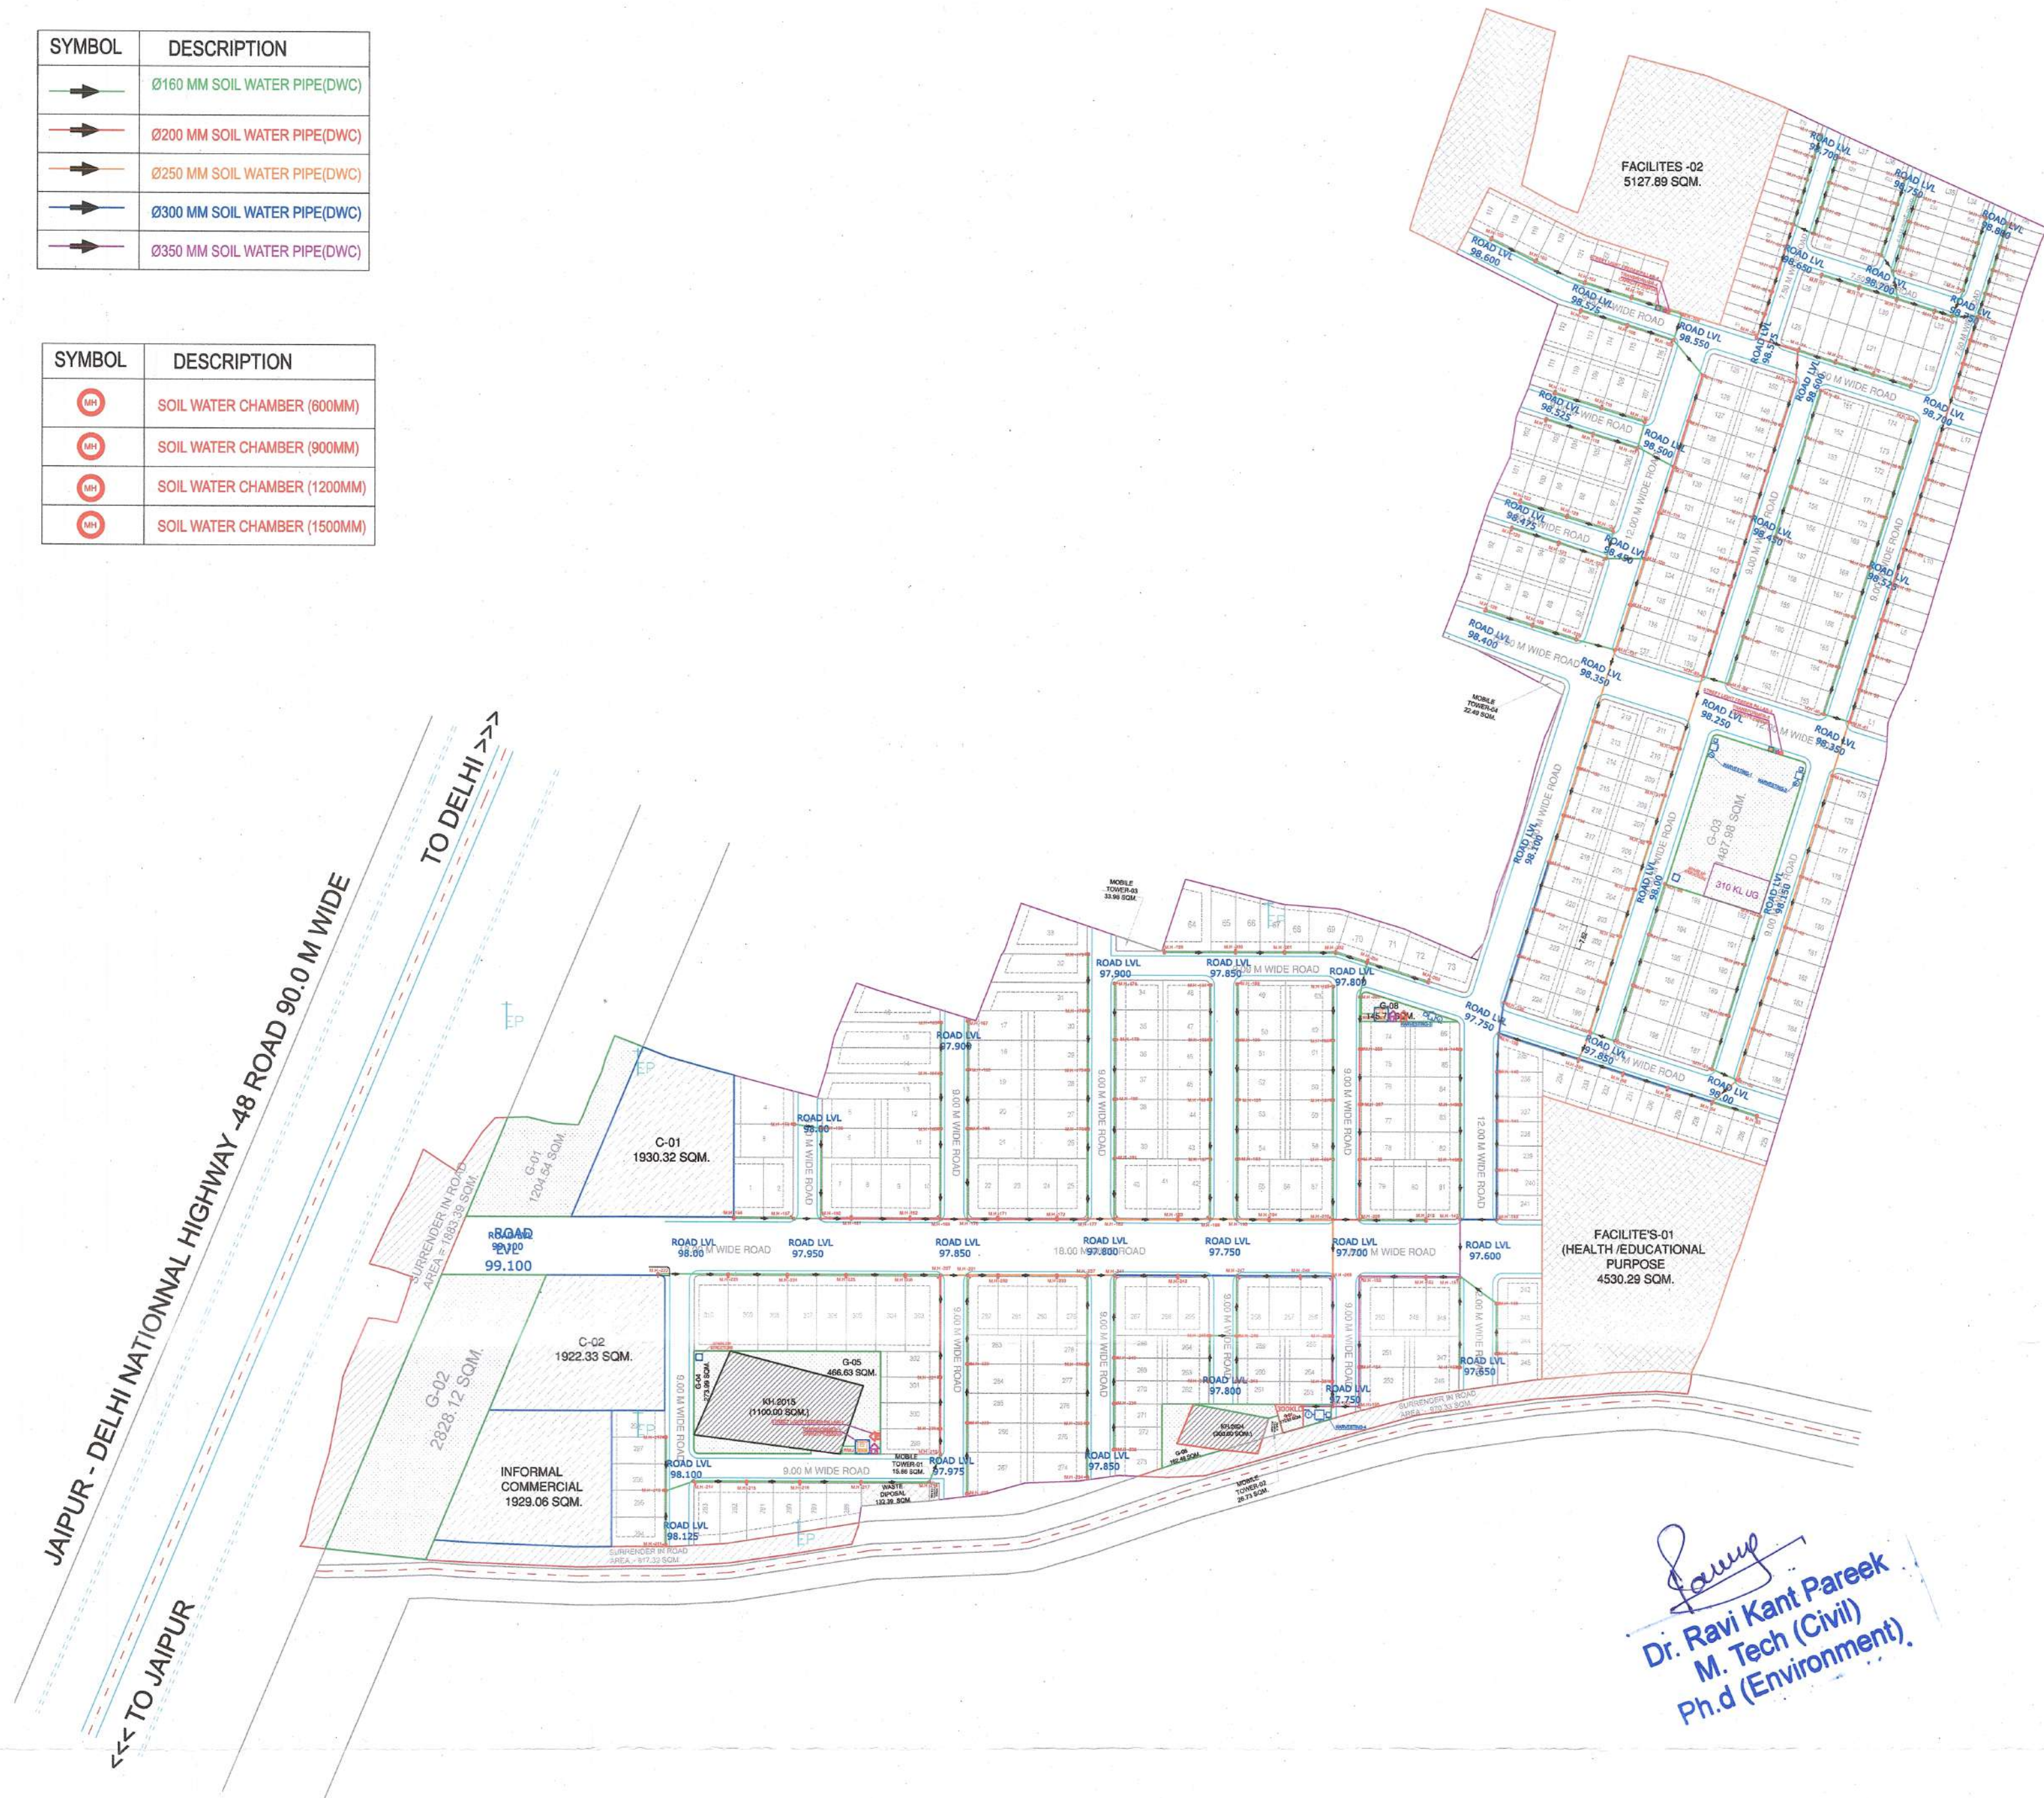

Dr. Ravi Kant Pareek
M. Tech (Civil)
Ph.d (Environment)

GENERAL NOTES : 1. ALL THE DIMENSIONS ON THE DRAWING ARE IN WRITTEN 2. ONLY WRITTEN DIMENSIONS ARE TO BE FOLLOWED, DRAWING SHOULD NOT BE SCALED IN ANY CIRCUMSTANCES 3. ALL MEASUREMENTS MUST BE CHECKED AND VERIFIED BY THE CONTRACTORS PRIOR TO EXECUTION OF WORK AT THE SITE. 4. THIS DRAWING IS TO BE READ IN CONJUNCTION WITH ALL RELEVANT STRUCTURAL, ARCHITECTURAL & FACILITY PLANNING DRAWINGS 5. ANY DISCREPANCIES MUST BE BROUGHT TO THE NOTICE OF THE ENGINEER IMMEDIATELY & PRIOR TO EXECUTION AT SITE. 6. CO-ORDINATION WITH SERVICES SUCH AS HVAC, PLUMBING & ELECTRICAL, ETC. IS THE RESPONSIBILITY OF THE CONTRACTORS 7. FOR DETAILS, REFER RELEVANT LARGE SCALE DETAIL DRGS. AS INDICATED.	DRAWING TITLE:- EXTERNAL SEWER DRAINAGE LAYOUT DEVELOPER'S :- M/S RAJENDRA PROMOTERS PVT. LTD. & MAHARAM S/O SH. GHISHARAM	ARCHITECT  CREATIVE STUDIO AR. MANSINGH MEENA 317, THIRD FLOOR, KRISH SQUARE, OPP. MODERN PUBLIC SCHOOL, BHAGAT SINGH COLONY, BHIWADI, ALWAR (RAJ.) WEB - WWW.CSBHIWADI.COM EMAIL ID - INFO@CSBHIWADI.COM MOB: - 09460478315, PH. - 01493- 491200	MEP SERVICES CONSULTANT AMP INFRA SERVICES VILLA NO 16. SHUBHASIS GEETA JAISINGHPURA, BHANKROTA & CHIMANPURA.JAIPUR 302026 EMAIL ID- ampinfrajpr@gmail.com CONTACT NO. :- 9462866389	PROJECT :- PROPOSED RESIDENTIAL LAYOUT PLAN AT,KH. 1949 TO 1958, 1960,1976 TO 1978, 1992, 1994 TO 2003, 2008, 2009, 2012 TO 2014, 2016, 2018 TO 2023, 2025 TO 2033, 2008, VILLAGE- GUNTI, TEH.- BEHROR, DISTT. KOTPUTALI-BEHROR (RAJ.) DRAWING NO.:-	SUBMITTED FOR :- PRELIMINARY ☐ APPROVAL ☒ PROPOSAL ☐ GFC ☐ DATE :- 19-09-2024 NORTH :-  DRAWN :- MO.AJARUDIN APPROVED :- NARESH SCALE :-	