


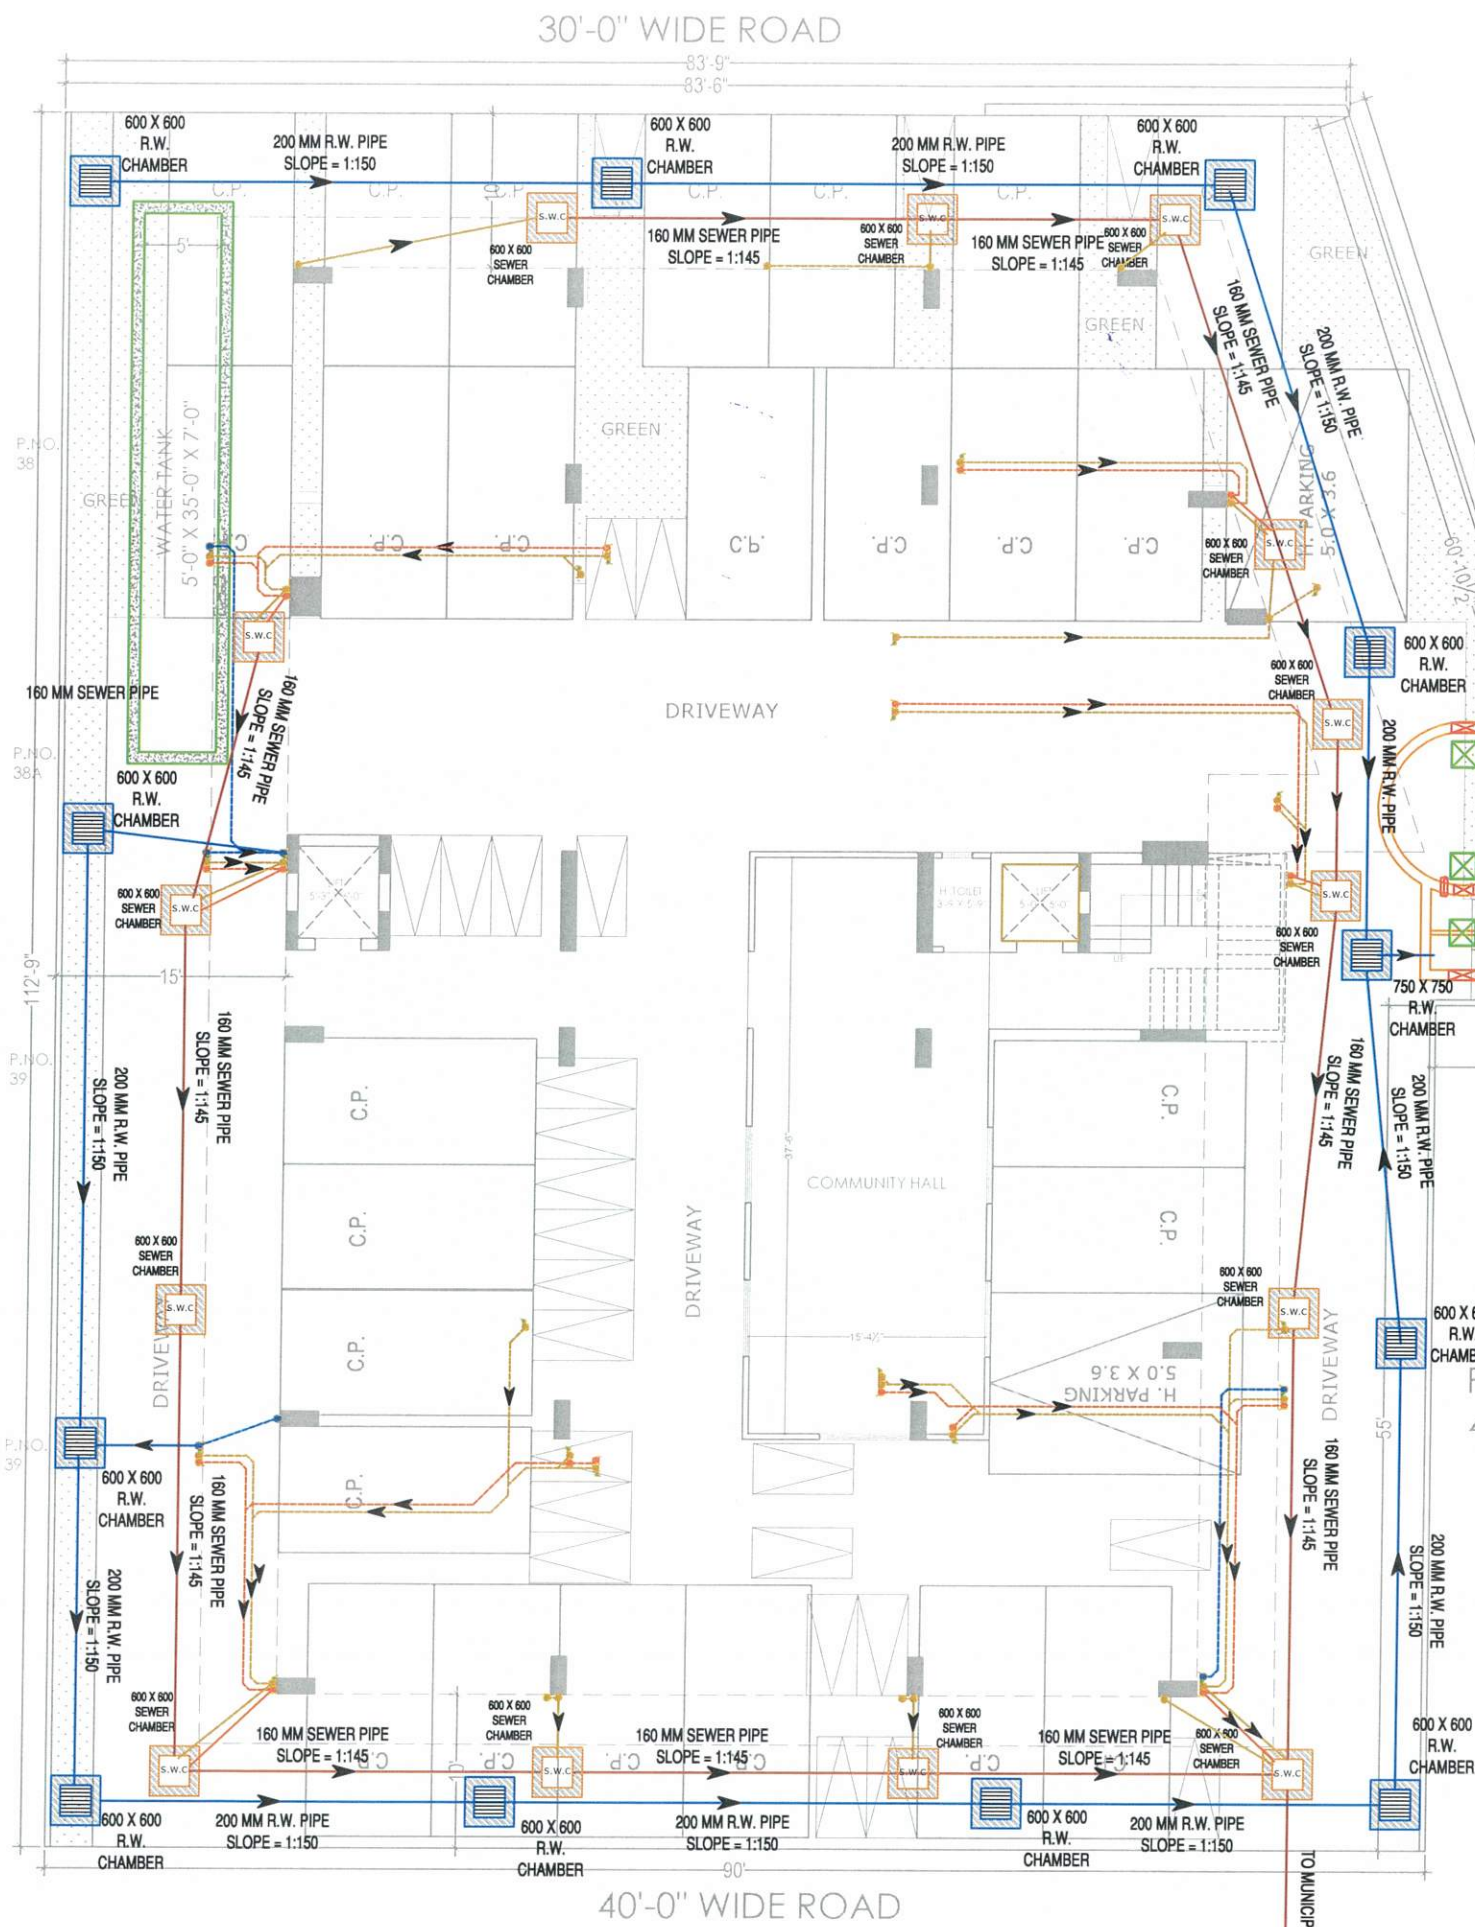

STILT FLOOR
DRAINAGE LAYOUT PLAN

LEGEND:-	
1	SOIL PIPE
2	WASTE PIPE
3	VENT PIPE
4	COLD WATER SUPPLY (CWS)
5	HOT WATER SUPPLY (HWS)
	RAIN WATER PIPE
SW	SEWER LINE- EXTERNAL
RW	STORM WATER DRAINAGE PIPE
	SEWERAGE MANHOLE
	STORM WATER MANHOLE
GT	GULLY TRAP
BV	BALL VALVE
FT	FLOOR TRAP
FD	FLOOR FLOOR DRAIN
	RAIN WATER COLLECTION CHAMBER 450X450MM
	KHURRA

CLIENT :	
Mr. NATHU JI	
ARCHITECTS :	
4 INSIDE ARCHITECTURE N INTERIORS Plot no. 72, S.P. Marg, C- Scheme jaipur, rajasthan, India cont: +91 9950595991, 91 9982812777 e.mail: jeets.arch@gmail.com	
STRUCTURAL CONSULTANTS:	
MEP CONSULTANT : -- SHRI SHYAM CONSULTANT PLUMBING I FIRE I ELECTRICAL I STP IWTP JAIPUR-302006 PH.NO. +91 9785427711	
DEALT BY RAMESH	REVISION R-1
DATE: 22.11.2023	

Sharm
Fr. SANJEEV SHARM
B.E (Electrical)


- GENERAL NOTES:
- All dimension on this drawing are in MKS System. Only written dimensions are to be followed. drawing should not be scaled.
 - All measurements must be checked and verified by the contractors prior to execution of work at the site.
 - This drawing is to be read in conjunction with all relevant structural, services & facility planning drawings.
 - Architectural drawings are to be followed for the location of all structural members & masonry walls. for sizes & reinforcement details of structural members, relevant structural drawings are to be referred.
 - Any discrepancies between architectural, structural and services drawings must be brought to the notice of the architect immediately & prior to execution at site.
 - Coordinate with services such as: plumbing & electrical, etc. as the responsibility of the contractor.
 - All masonry walls should be aligned with the columns as indicated on the plan, irrespective of the position as calculated with the dimensions.
 - For details, refer relevant large scale detail drawings, as indicated.

PROJECT:
SIDDHI VINAYAK HOME S
PROPOSED RESIDENTIAL
BUILDING ON P. NO.-
35,36,37,40,41&42 HANUMAN
VIHAR, (BALRAMPURA URF
KHEJARO KA BAS), JAIPUR

NAME OF DRAWING: STILT FLOOR DRAINAGE LAYOUT PLAN	
DRAWN BY: Banwari Lal	APPROVED BY: JITENDRA SHARMA
DRAWING: WORKING DRAWING	NORTH:
PROJECT NO.:	DATE: 02. Nov. - 2023
SCALE: NTS	REV NO. : R-0
DRAWING NO. : A-202	

PRODUCED BY AN AUTODESK EDUCATIONAL PRODUCT

PRODUCED BY AN AUTODESK EDUCATIONAL PRODUCT

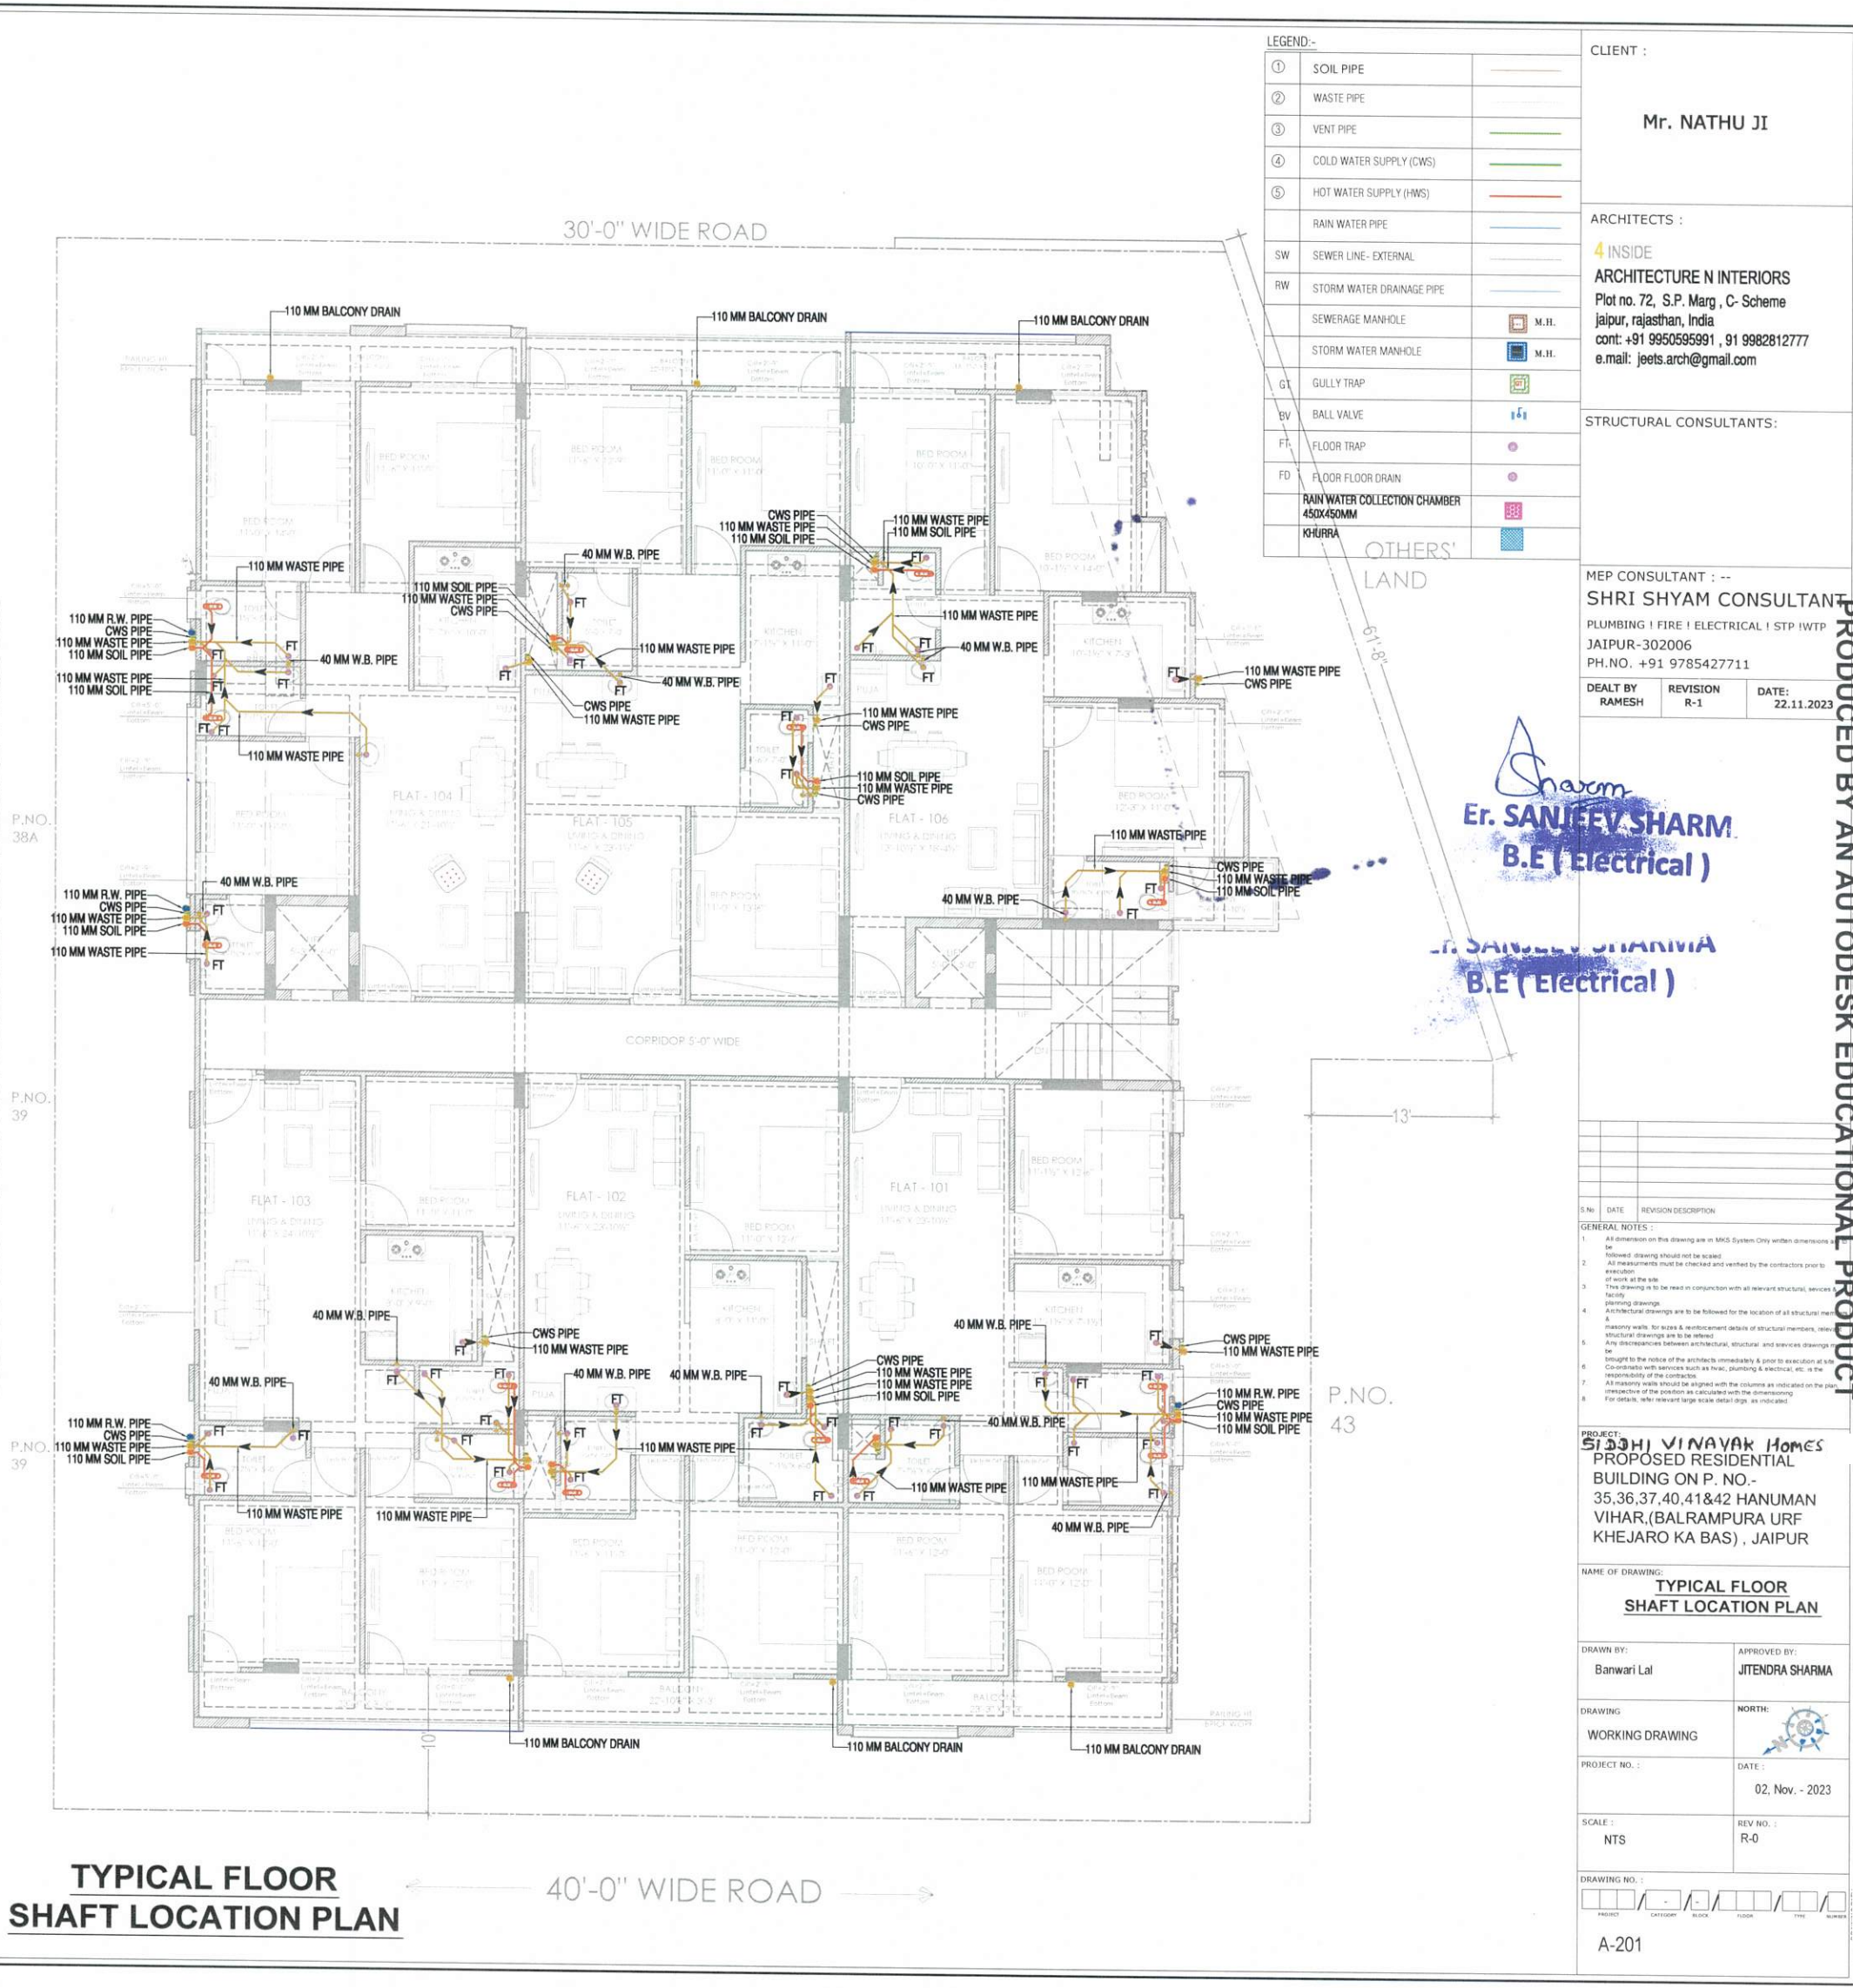

TYPICAL FLOOR SHAFT LOCATION PLAN