


SHAFT MARKING KEY PLAN

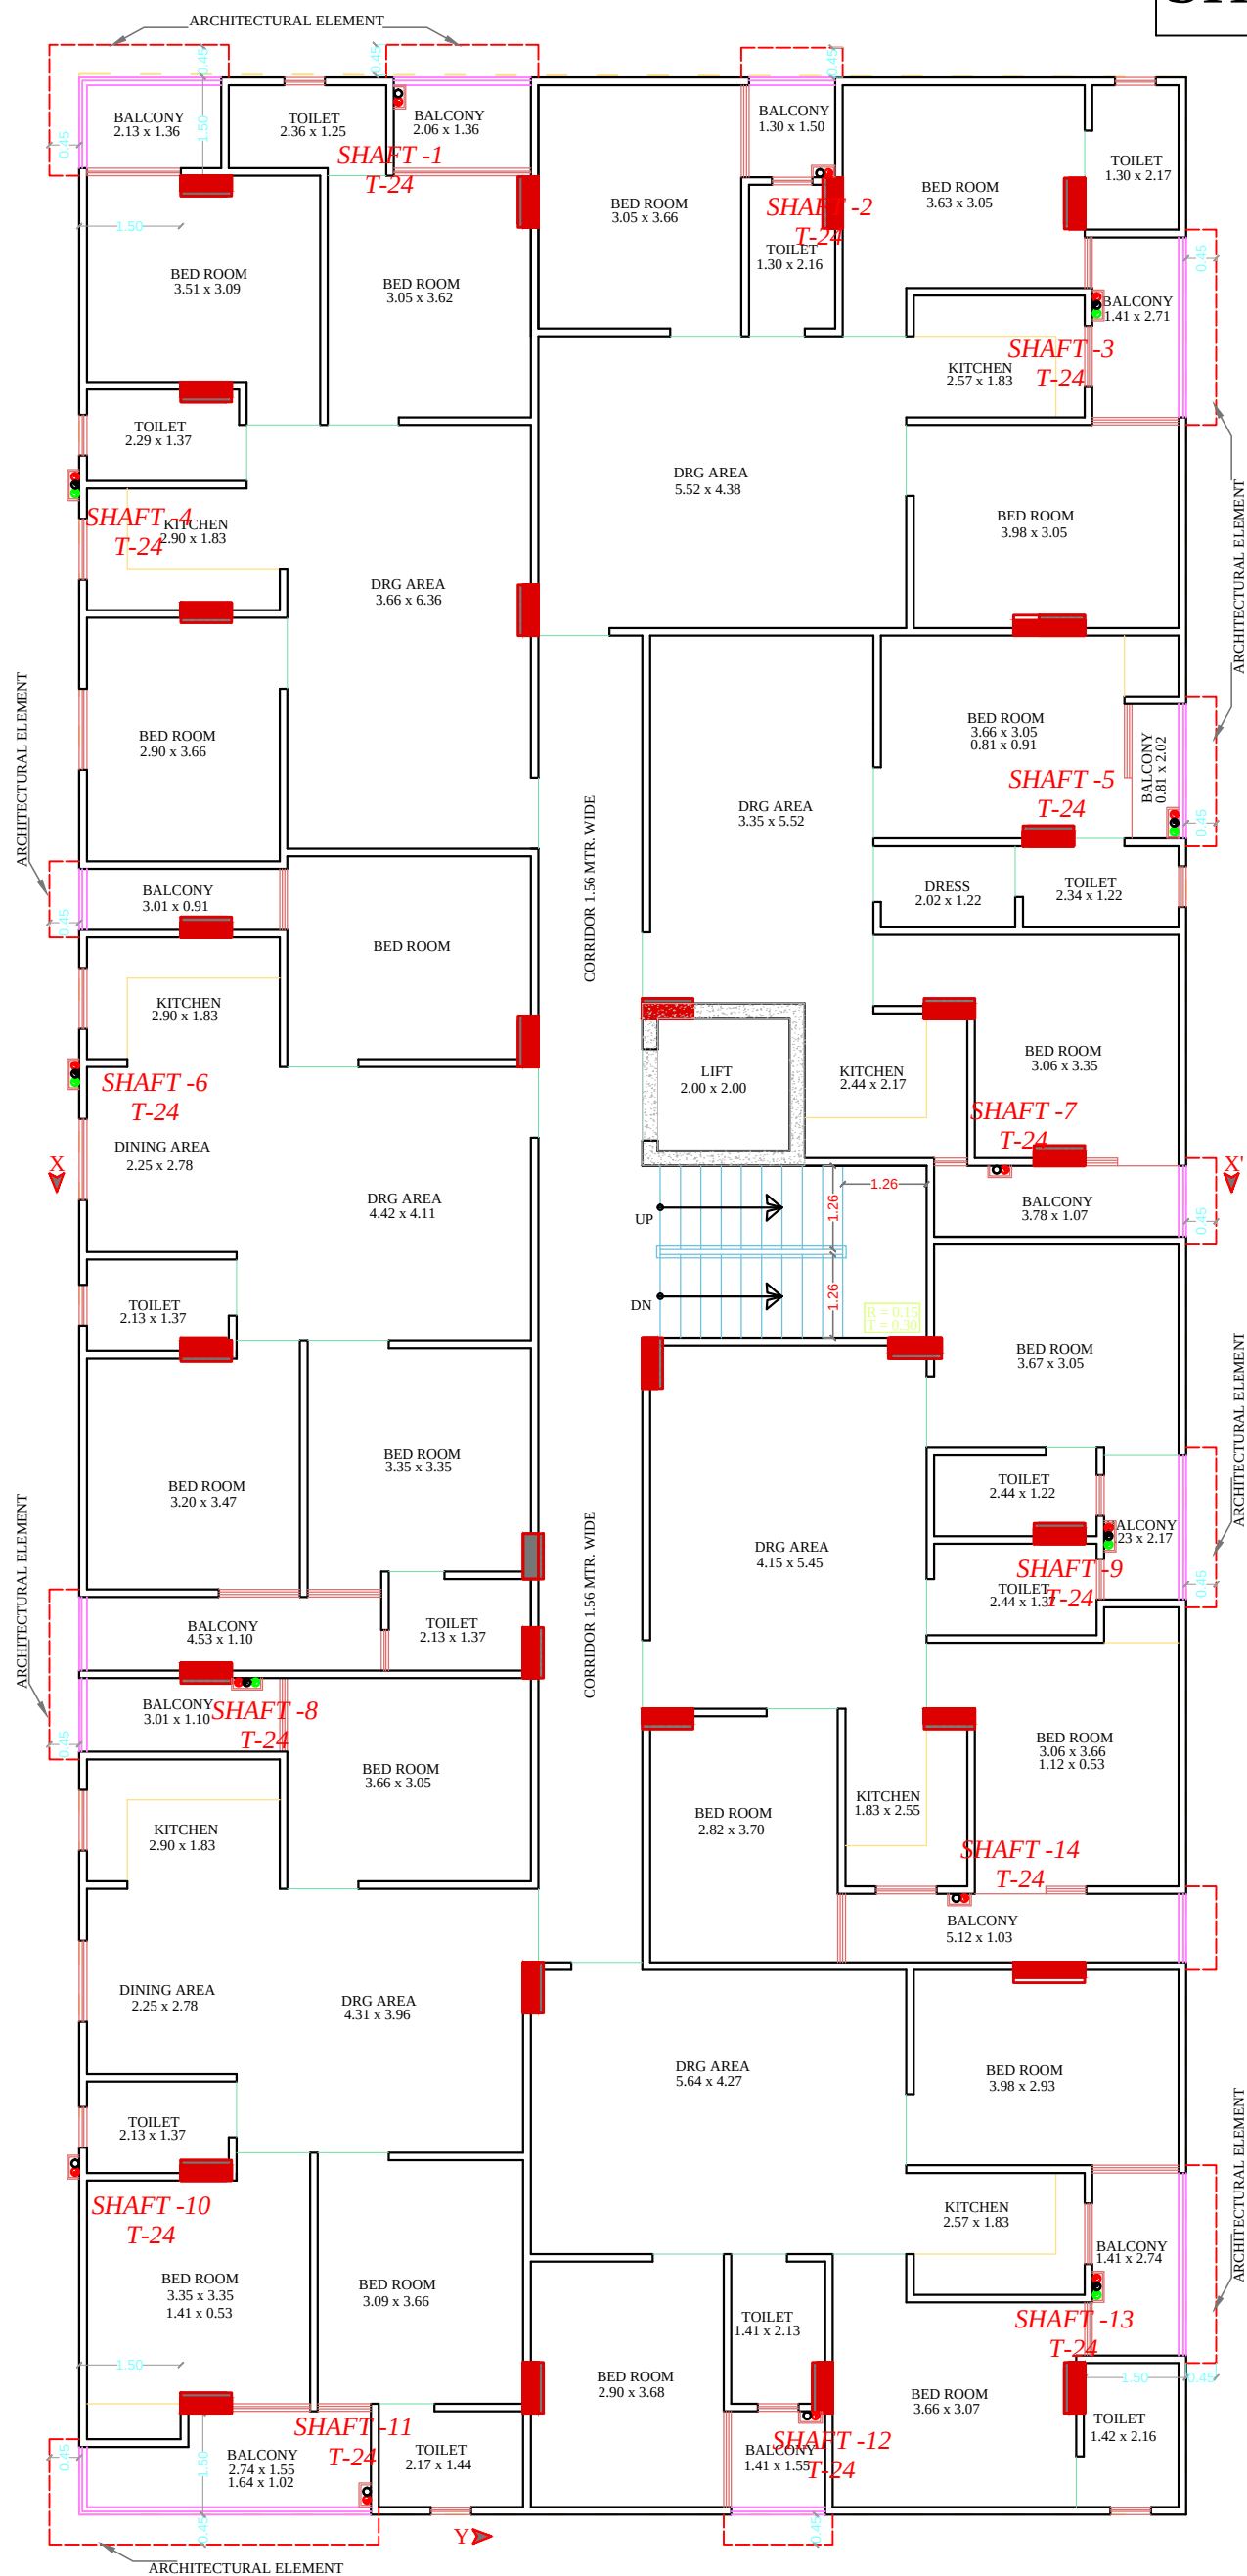

GROUND, 1st TO 5th FLOOR PLAN



SERVICES CONSULTANT:
PLOT-A-173, JAGDAMBA NAGAR ,HEERAPURA
POWER HOWER ,JAIPUR (RAJ) 302024

ARCHITECTS:-



FRANK SQUARE

ARCHITECTURE | PLANNER | DESIGNER
C-49 VIDYA APARTMENT PARAS MARG,
BAPU NAGAR JAIPUR, (RAJ.)
Email-afranksquare@gmail.com
Mobile-9461302542

Project:

PROPOSED BUILDING AT PLOT
NO.-R-17-259, CHORDIA CITY,
JAIPUR

Drawing:

WATER SUPPLY SCHEMATIC
DIAGRAM

DRN BY :

CHCKD BY :

APPRVD BY :

DATE.:-

SERVICES CONSULTANT:
PLOT-A-173, JAGDAMBA NAGAR ,HEERAPURA
POWER HOWER ,JAIPUR (RAJ) 302024

ARCHITECTS:-

 FRANK SQUARE

ARCHITECTURE | PLANNER | DESIGNER
C-49 VIDYA APARTMENT PARAS MARG,
BAPU NAGAR JAIPUR, (RAJ.)
Email-afranksquare@gmail.com
Mobile-9461302542

Project:

PROPOSED BUILDING AT PLOT
NO.-R-17-259, CHORDIA CITY,
JAIPUR

Drawing:

WATER SUPPLY SCHEMATIC DIAGRAM


DRN BY :


CHCKD BY :

APPRVD BY :

DATE:-

WATER SUPPLY SCHEMATIC DIAGRAM

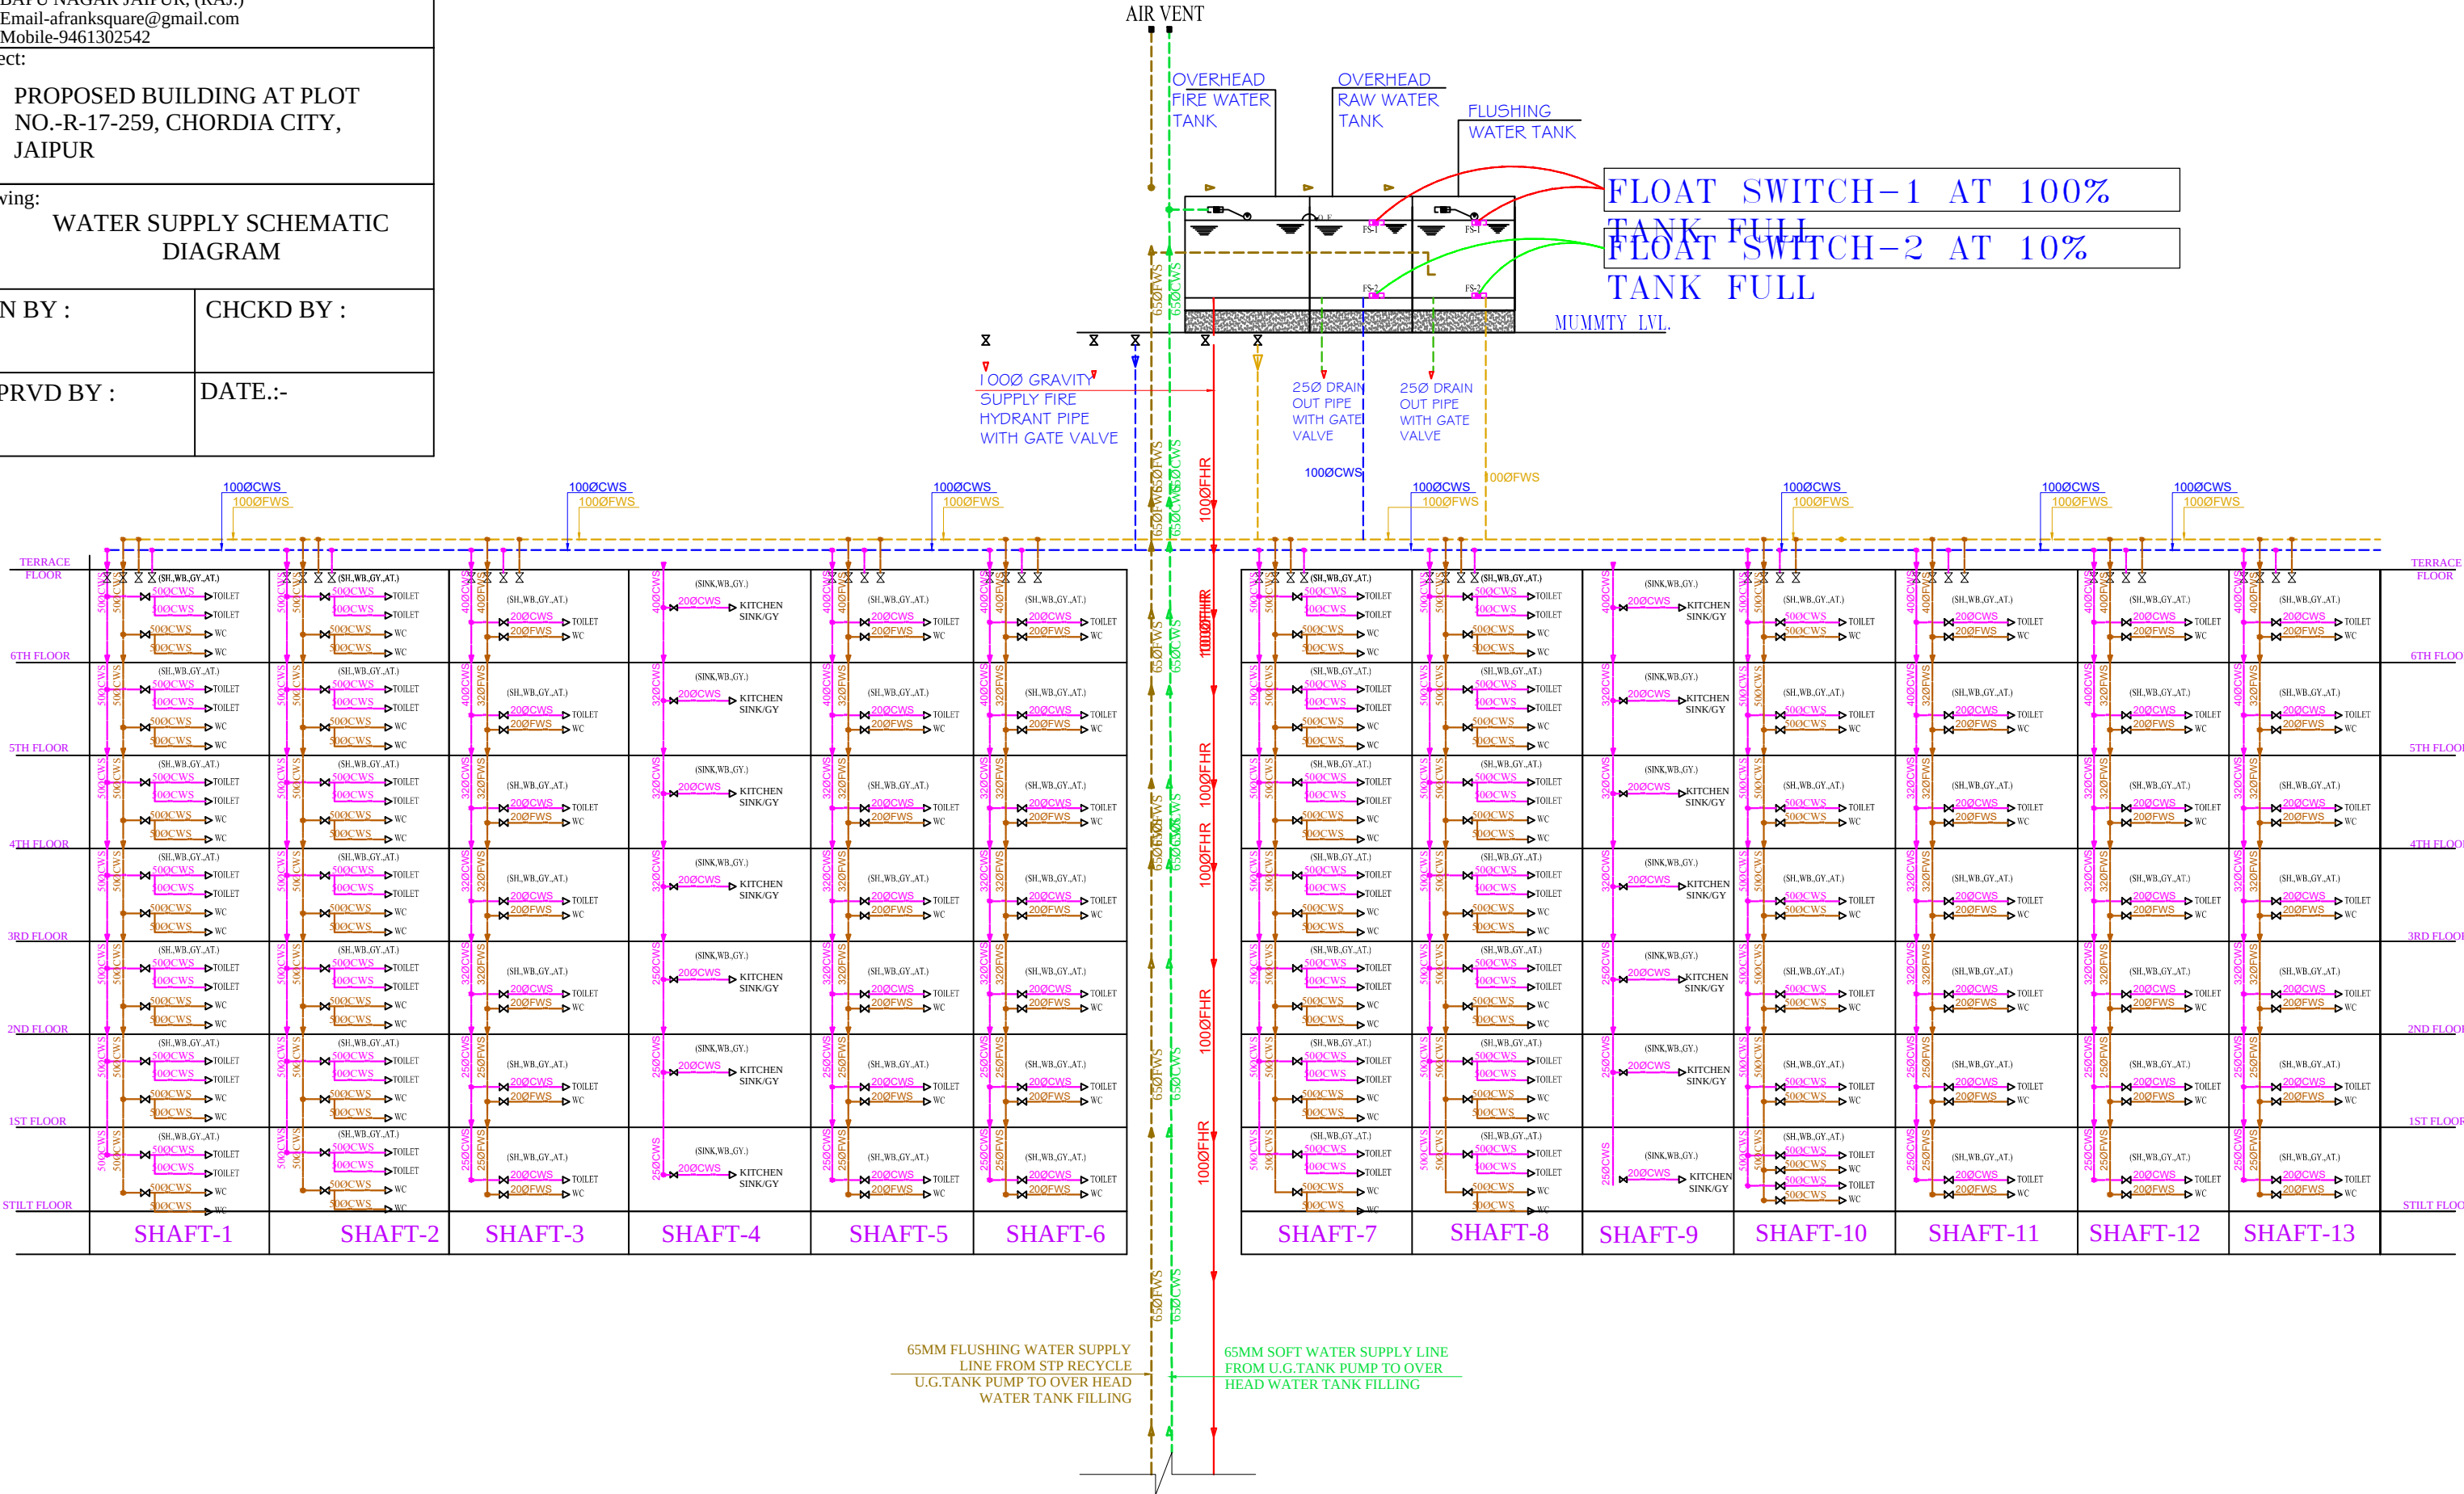

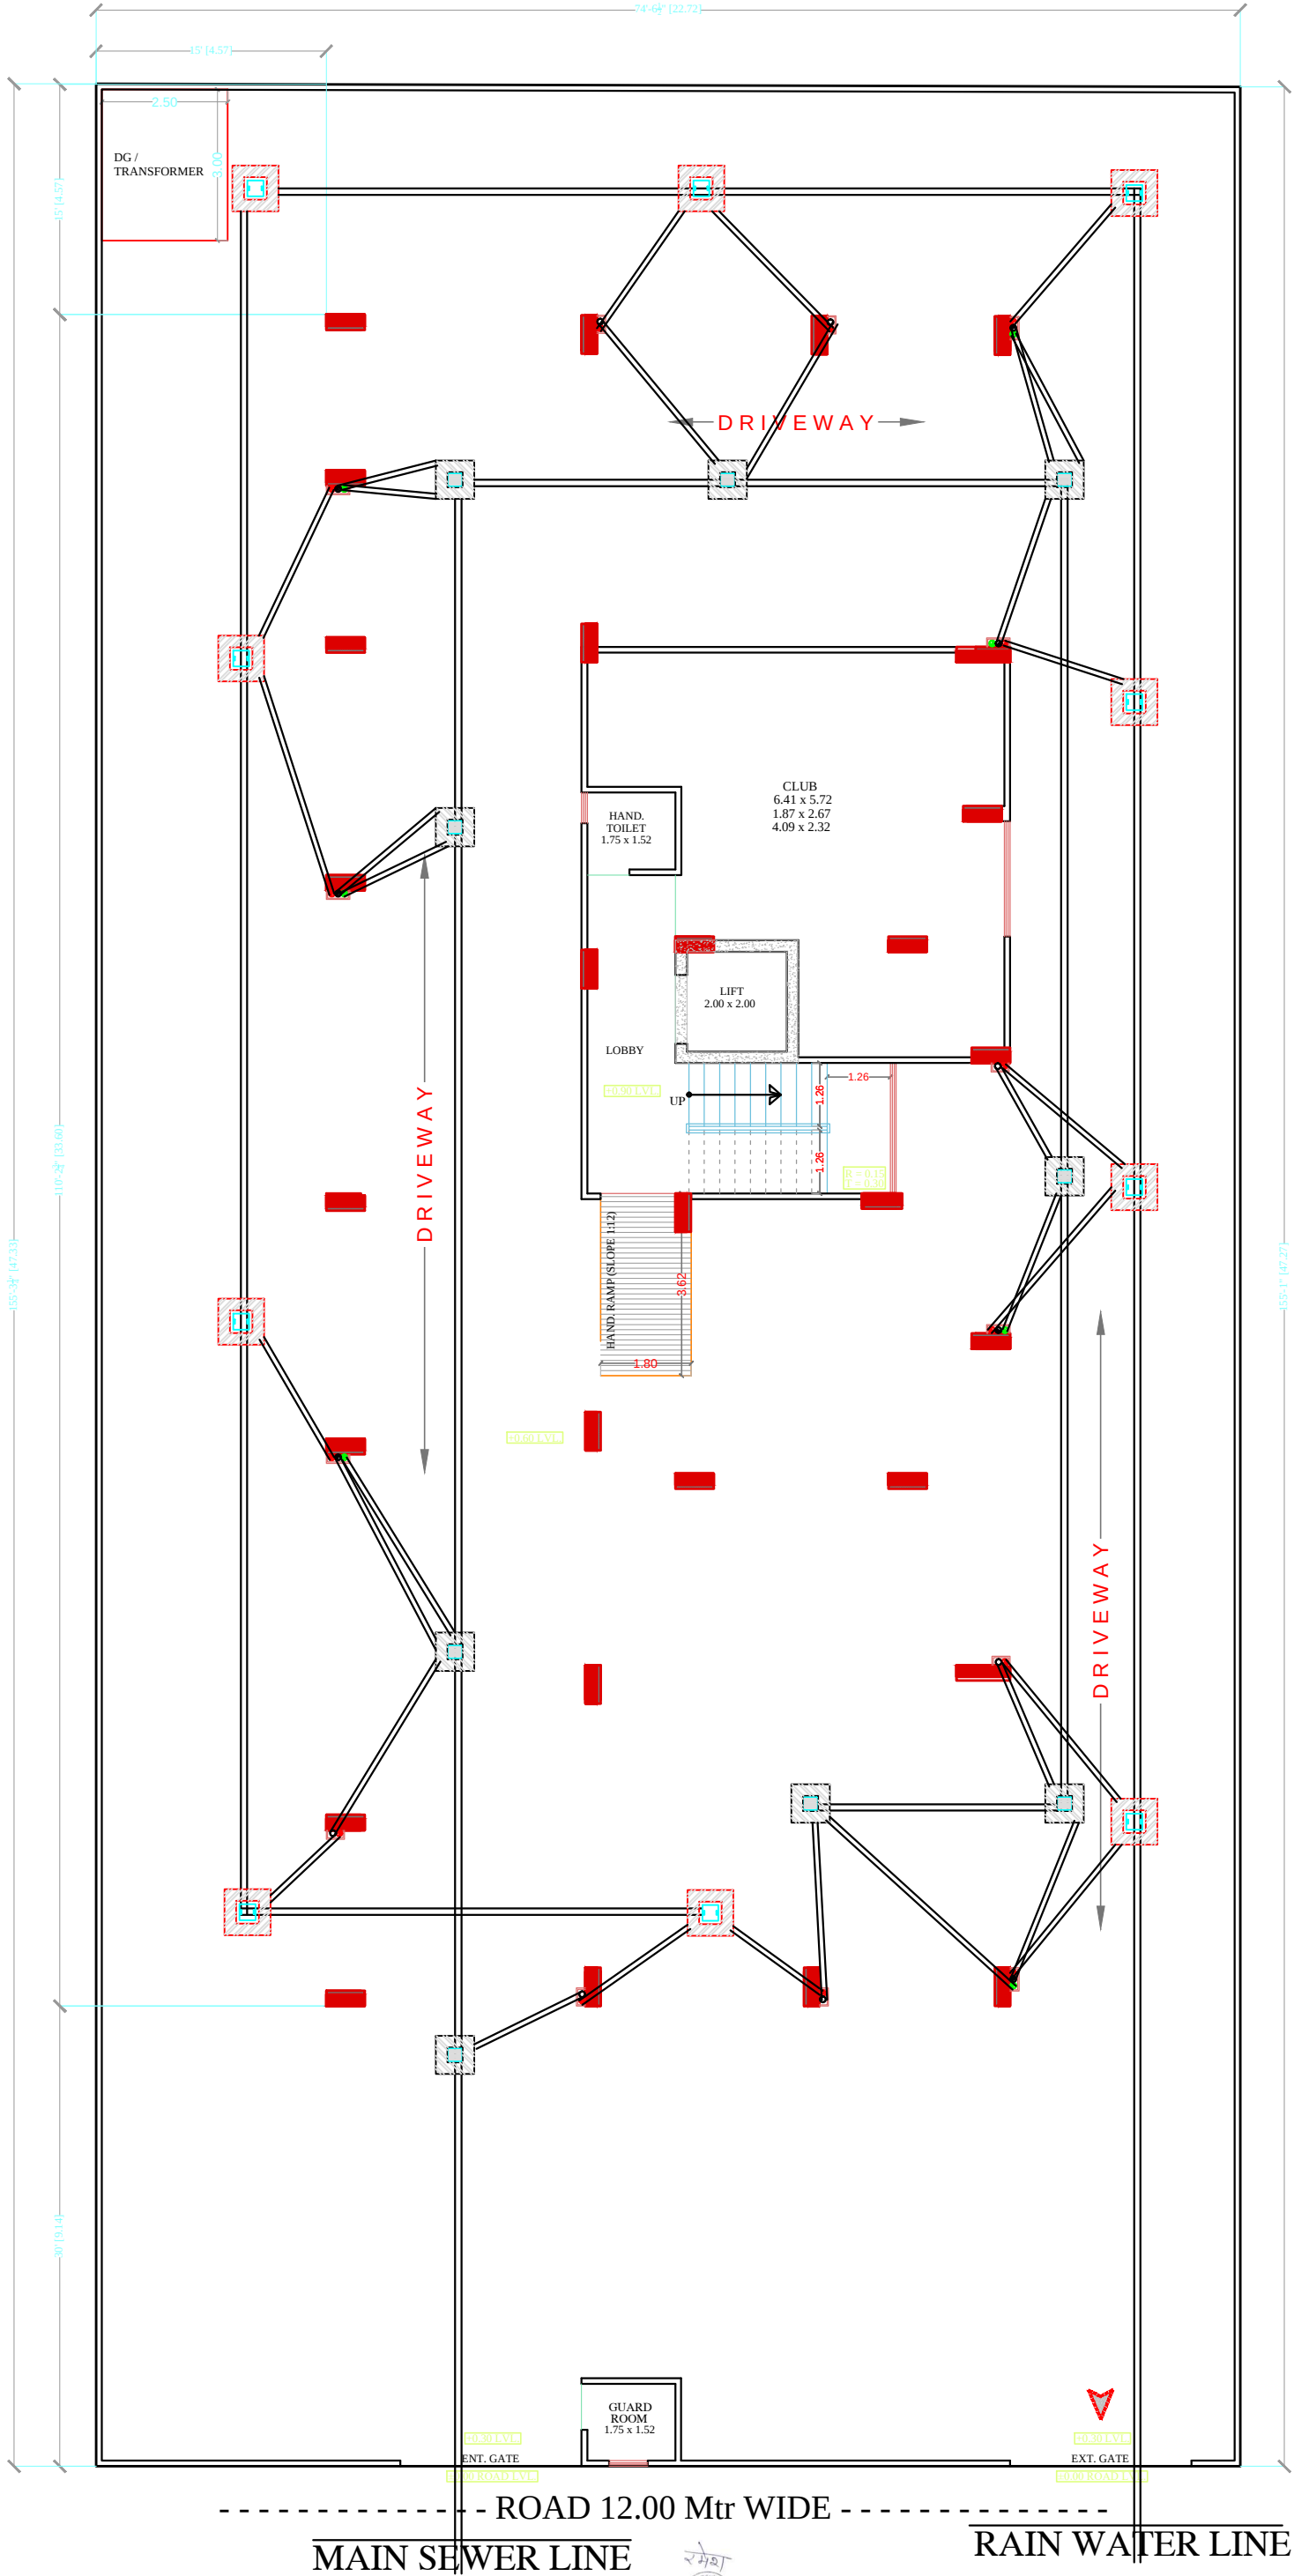

PROJECT TITLE :- PROPOSED BUILDING AT PLOT NO.-R-17-259, CHORDIA CITY, JAIPUR	DRAWING TITLE :- STILT FLOOR WATER SUPPLY	SPACE CONSULTANT PLOT-A-173, JAGDAMBA NAGAR, HEERAPURA POWER HOWER, JAIPUR (RAJ) 302024	DRN. BY		DATE	NORTH
			APPD. BY		REVISION	
			SCALE	N.T.S		