


24.00 MT. WIDE ROAD

ENTRY
UP TO
U.GROUND LVL
LVL ± 0.00 M.

LEGEND FOR WATER SUPPLY:		
D.W.S	DOMESTIC WATER SUPPLY	—
F.W.S	FLUSHING WATER SUPPLY	—
GH	GARDEN HYDRANT	—
GH	GARDEN HYDRANT PIPE	—
BW	BORE WELL	—
MS	MUNICIPAL WATER SUPPLY LINE	—

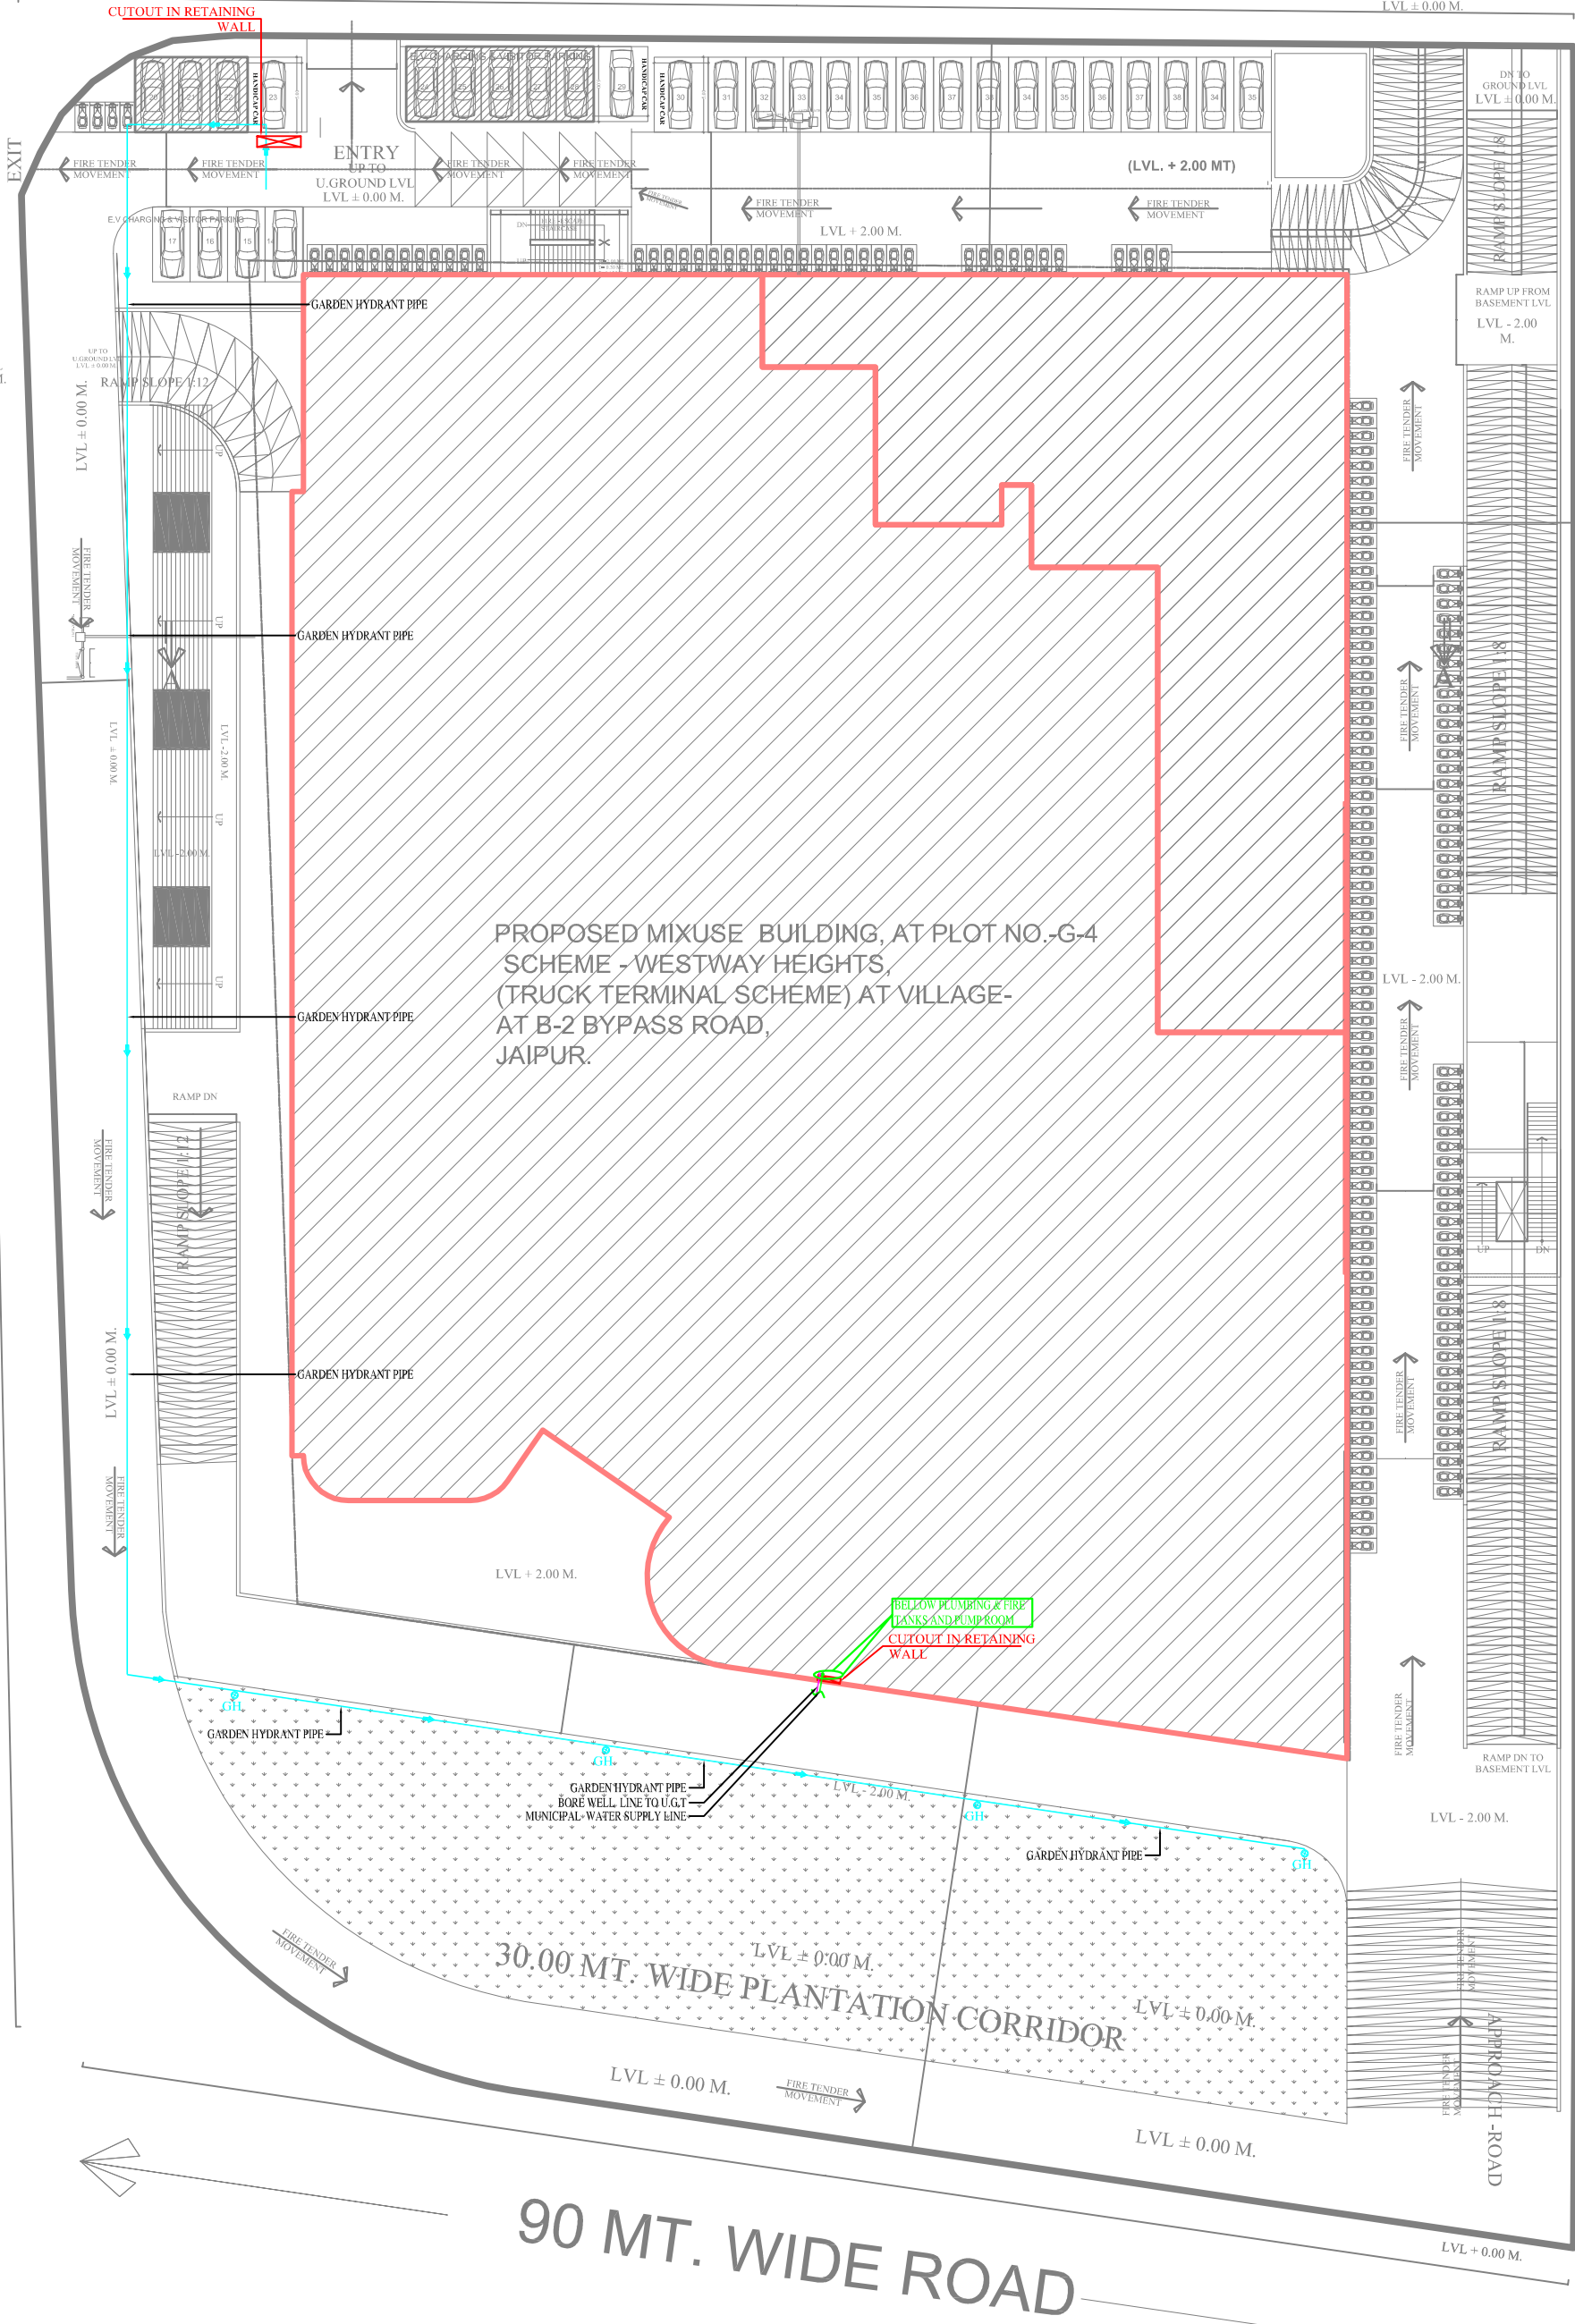

Jagjit Singh
B.Tech, M. Tech
MEP Consultant

M.J. Engineering Consultants Pvt Ltd.

NOTE:-

ARCHITECT

SITE ADDRESS:-
PROPOSED MIXUSE BUILDING, AT PLOT NO.-G-4
SCHEME - WESTWAY HEIGHTS,
(TRUCK TERMINAL SCHEME) AT VILLAGE-
AT B-2 BYPASS ROAD,
JAIPUR.



124, LIBERMAT NAGAR, TONK ROAD, JAIPUR
PHONE - 0141-2706227, 2712377
email: sldesigner@gmail.com, web: www.sldesigner.com

LANDSCAPE ARCHITECT:-

STRUCTURE CONSULTANT :

MEP CONSULTANT :

M.J. ENGINEERING CONSULTANTS
PVT. LTD.
606, Madhuban Building 55 Nehru Place
Nehru Place New Delhi-11019
Telephone: 91-11-66274552/53/54/44
E-Mail:- mjc@mjc.co.in

REVISIONS:-

S.No.	DATE	REMARKS

PROJECT:-

CLIENT:-
DRAWING TITLE
SITE PLAN
WATER SUPPLY LAYOUT

DRAWING NO.	REV. NO.	SCALE	SHEET
2024/05/04	01	1:1000	1 of 1
DRAWN BY	CHECKED	APPROVED	DATE
BDW	SV	SV	17/05/2024
RELEASED FOR			