


WATER SUPPLY SCHEMATIC DIAGRAM

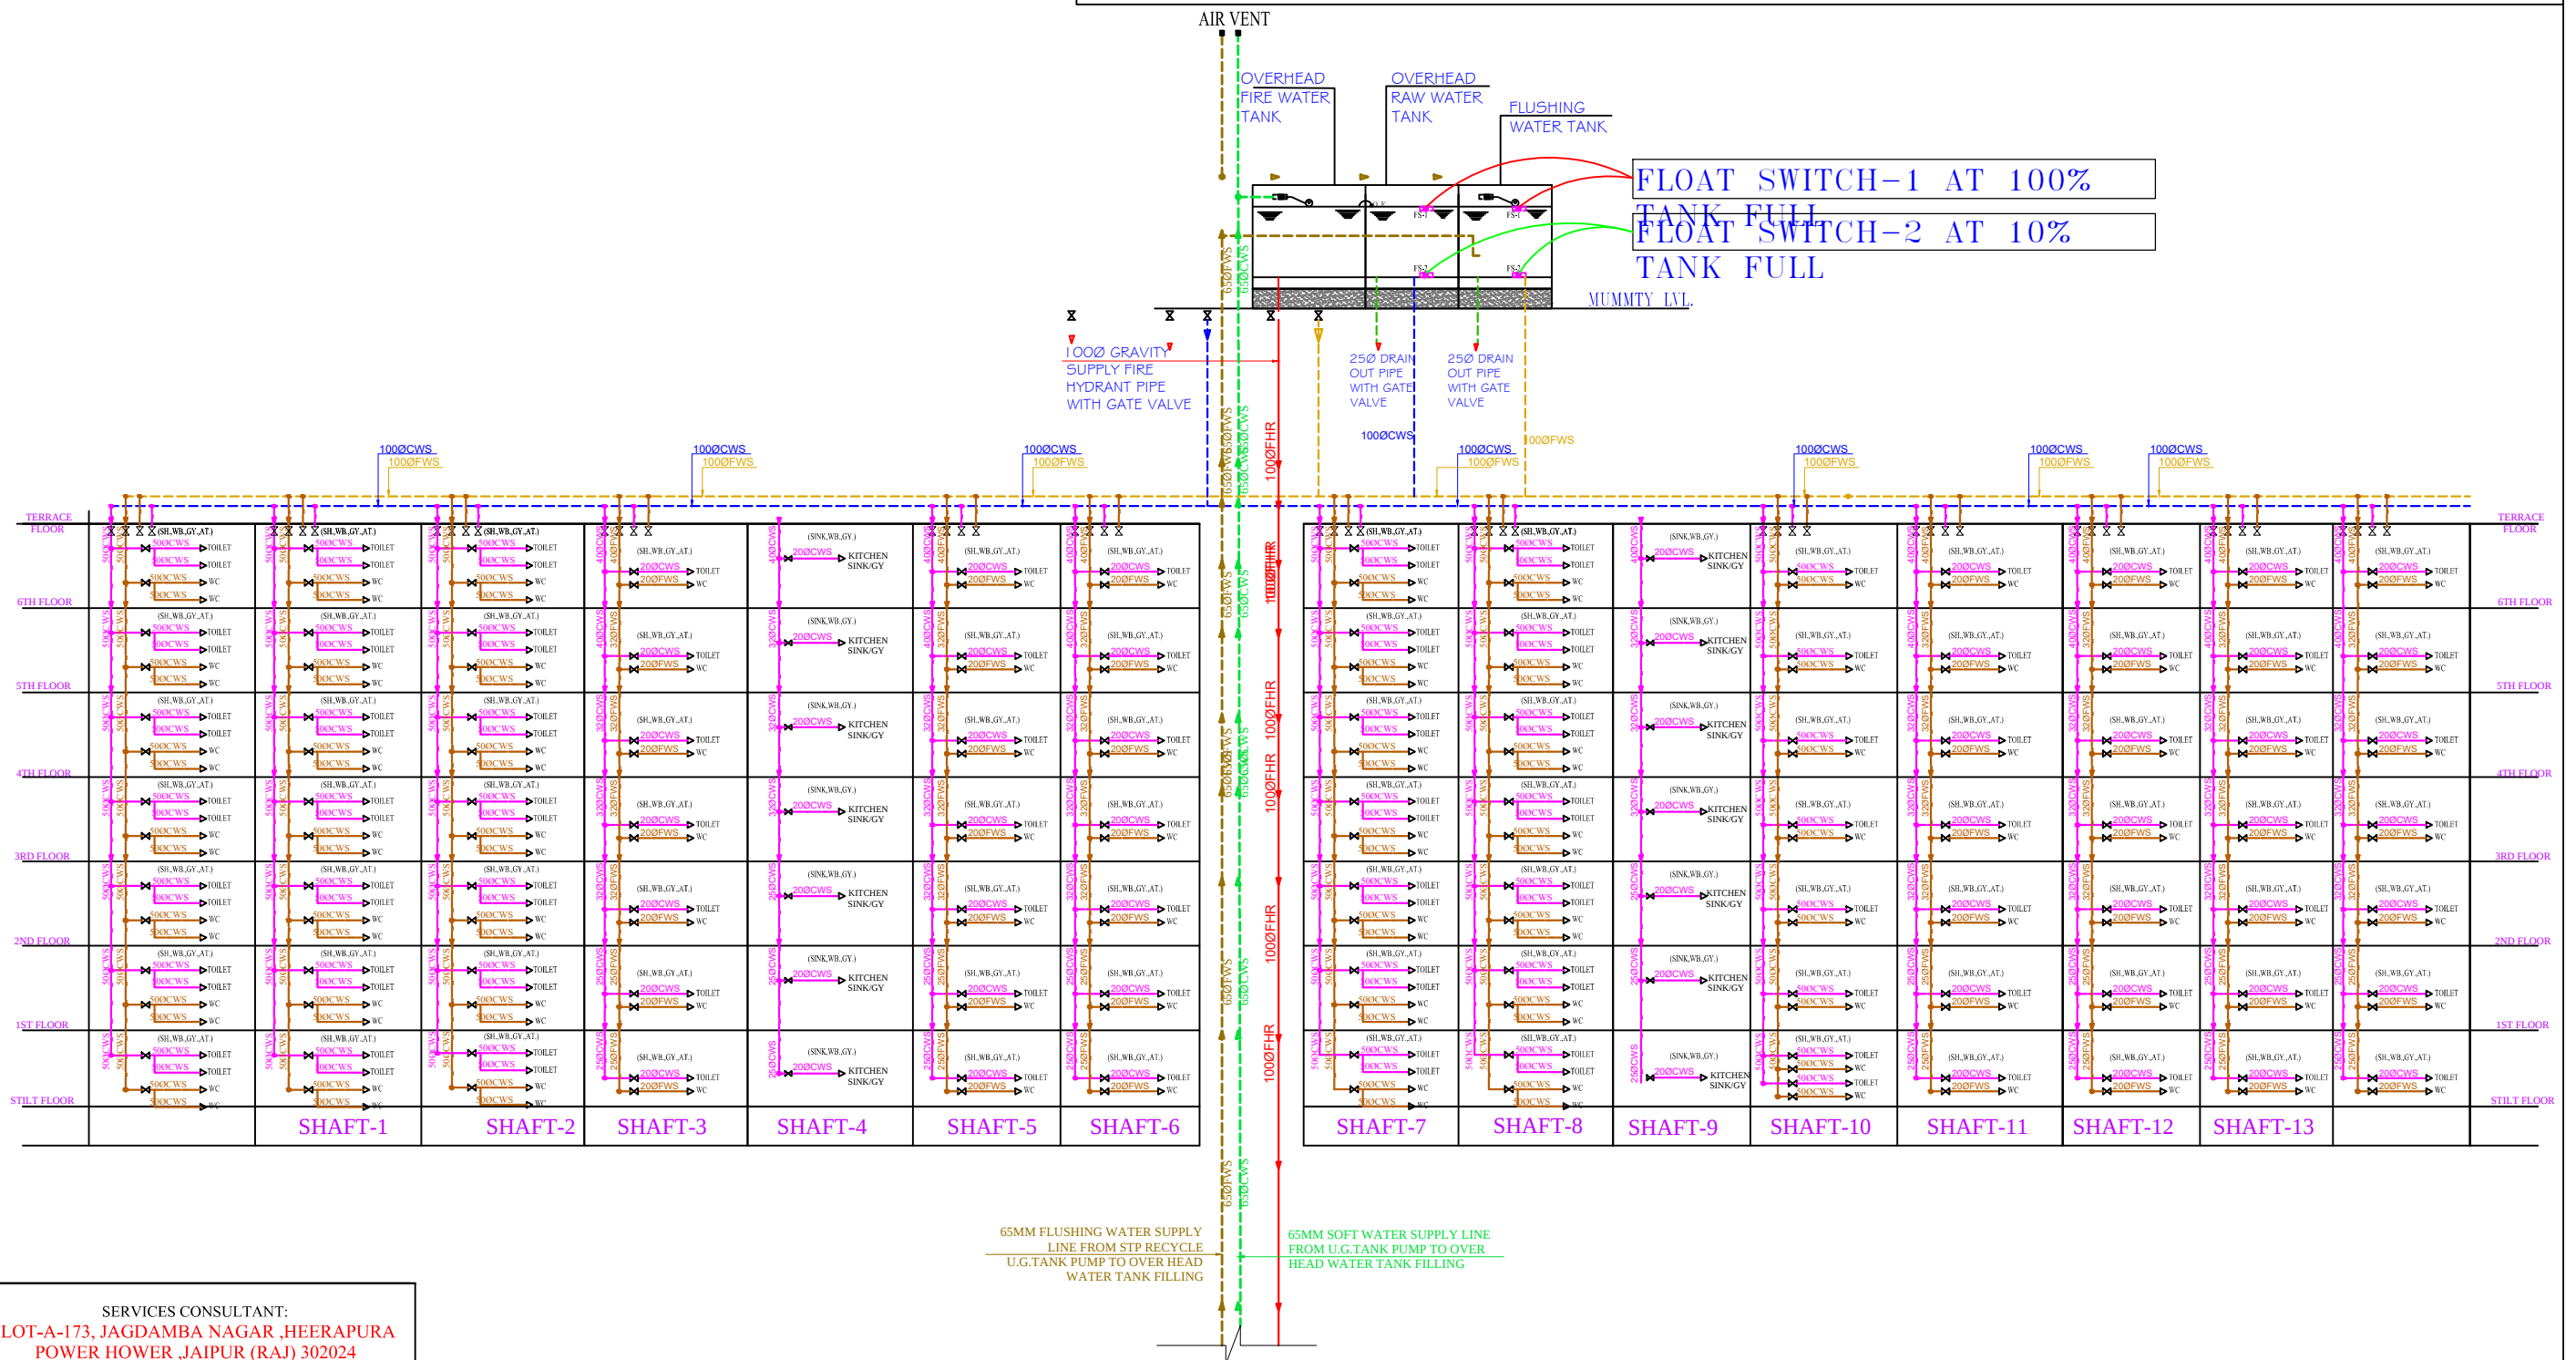

SERVICES CONSULTANT:
PLOT-A-173, JAGDAMBA NAGAR ,HEERAPURA
POWER HOWER ,JAIPUR (RAJ) 302024

ARCHITECTS:-

 **FRANK SQUARE**
ARCHITECTURE | PLANNER | DESIGNER
C-49 VIDYA APARTMENT PARAS MARG
BAPU NAGAR JAIPUR, (RAJ.)
Email-afranksquare@gmail.com
Mobile-9461302542

Mobile-9461302542	
Project:	PROPOSED BUILDING AT KHASRA NO. 3402/2403 & 3423/3399 IN VILLAGE SIROLI, TEHSIL SANGANER , JAIPUR

Drawing:

WATER SUPPLY SCHEMATIC
DIAGRAM

DRN BY :	CHCKD BY :
----------	------------

APPRVD BY :	DATE:-
-------------	--------

DATE:-


RAMESH KUMAWAT
M.E.P. CONSULTANT
B.E. CIVIL




GROUND, 1st TO 5th FLOOR PLAN

Ramesh Kumawat
RAMESH KUMAWAT
M.E.P. CONSULTANT
B.E. CIVIL

SERVICES CONSULTANT: PLOT-A-173, JAGDAMBA NAGAR ,HEERAPURA POWER HOWER ,JAIPUR (RAJ) 302024	
ARCHITECTS:-  FRANK SQUARE ARCHITECTURE PLANNER DESIGNER C-49 VIDYA APARTMENT PARAS MARG, BAPU NAGAR JAIPUR, (RAJ.) Email-afranksquare@gmail.com Mobile-9461302542	
Project: PROPOSED BUILDING AT KHASRA NO. 3402/2403 & 3423/3399 IN VILLAGE SIROLI, TEHSIL SANGANER , JAIPUR	
Drawing: WATER SUPPLY SCHEMATIC DIAGRAM	
DRN BY :	CHCKD BY :
APPRVD BY :	DATE:-

SHAFT MARKING KEY PLAN

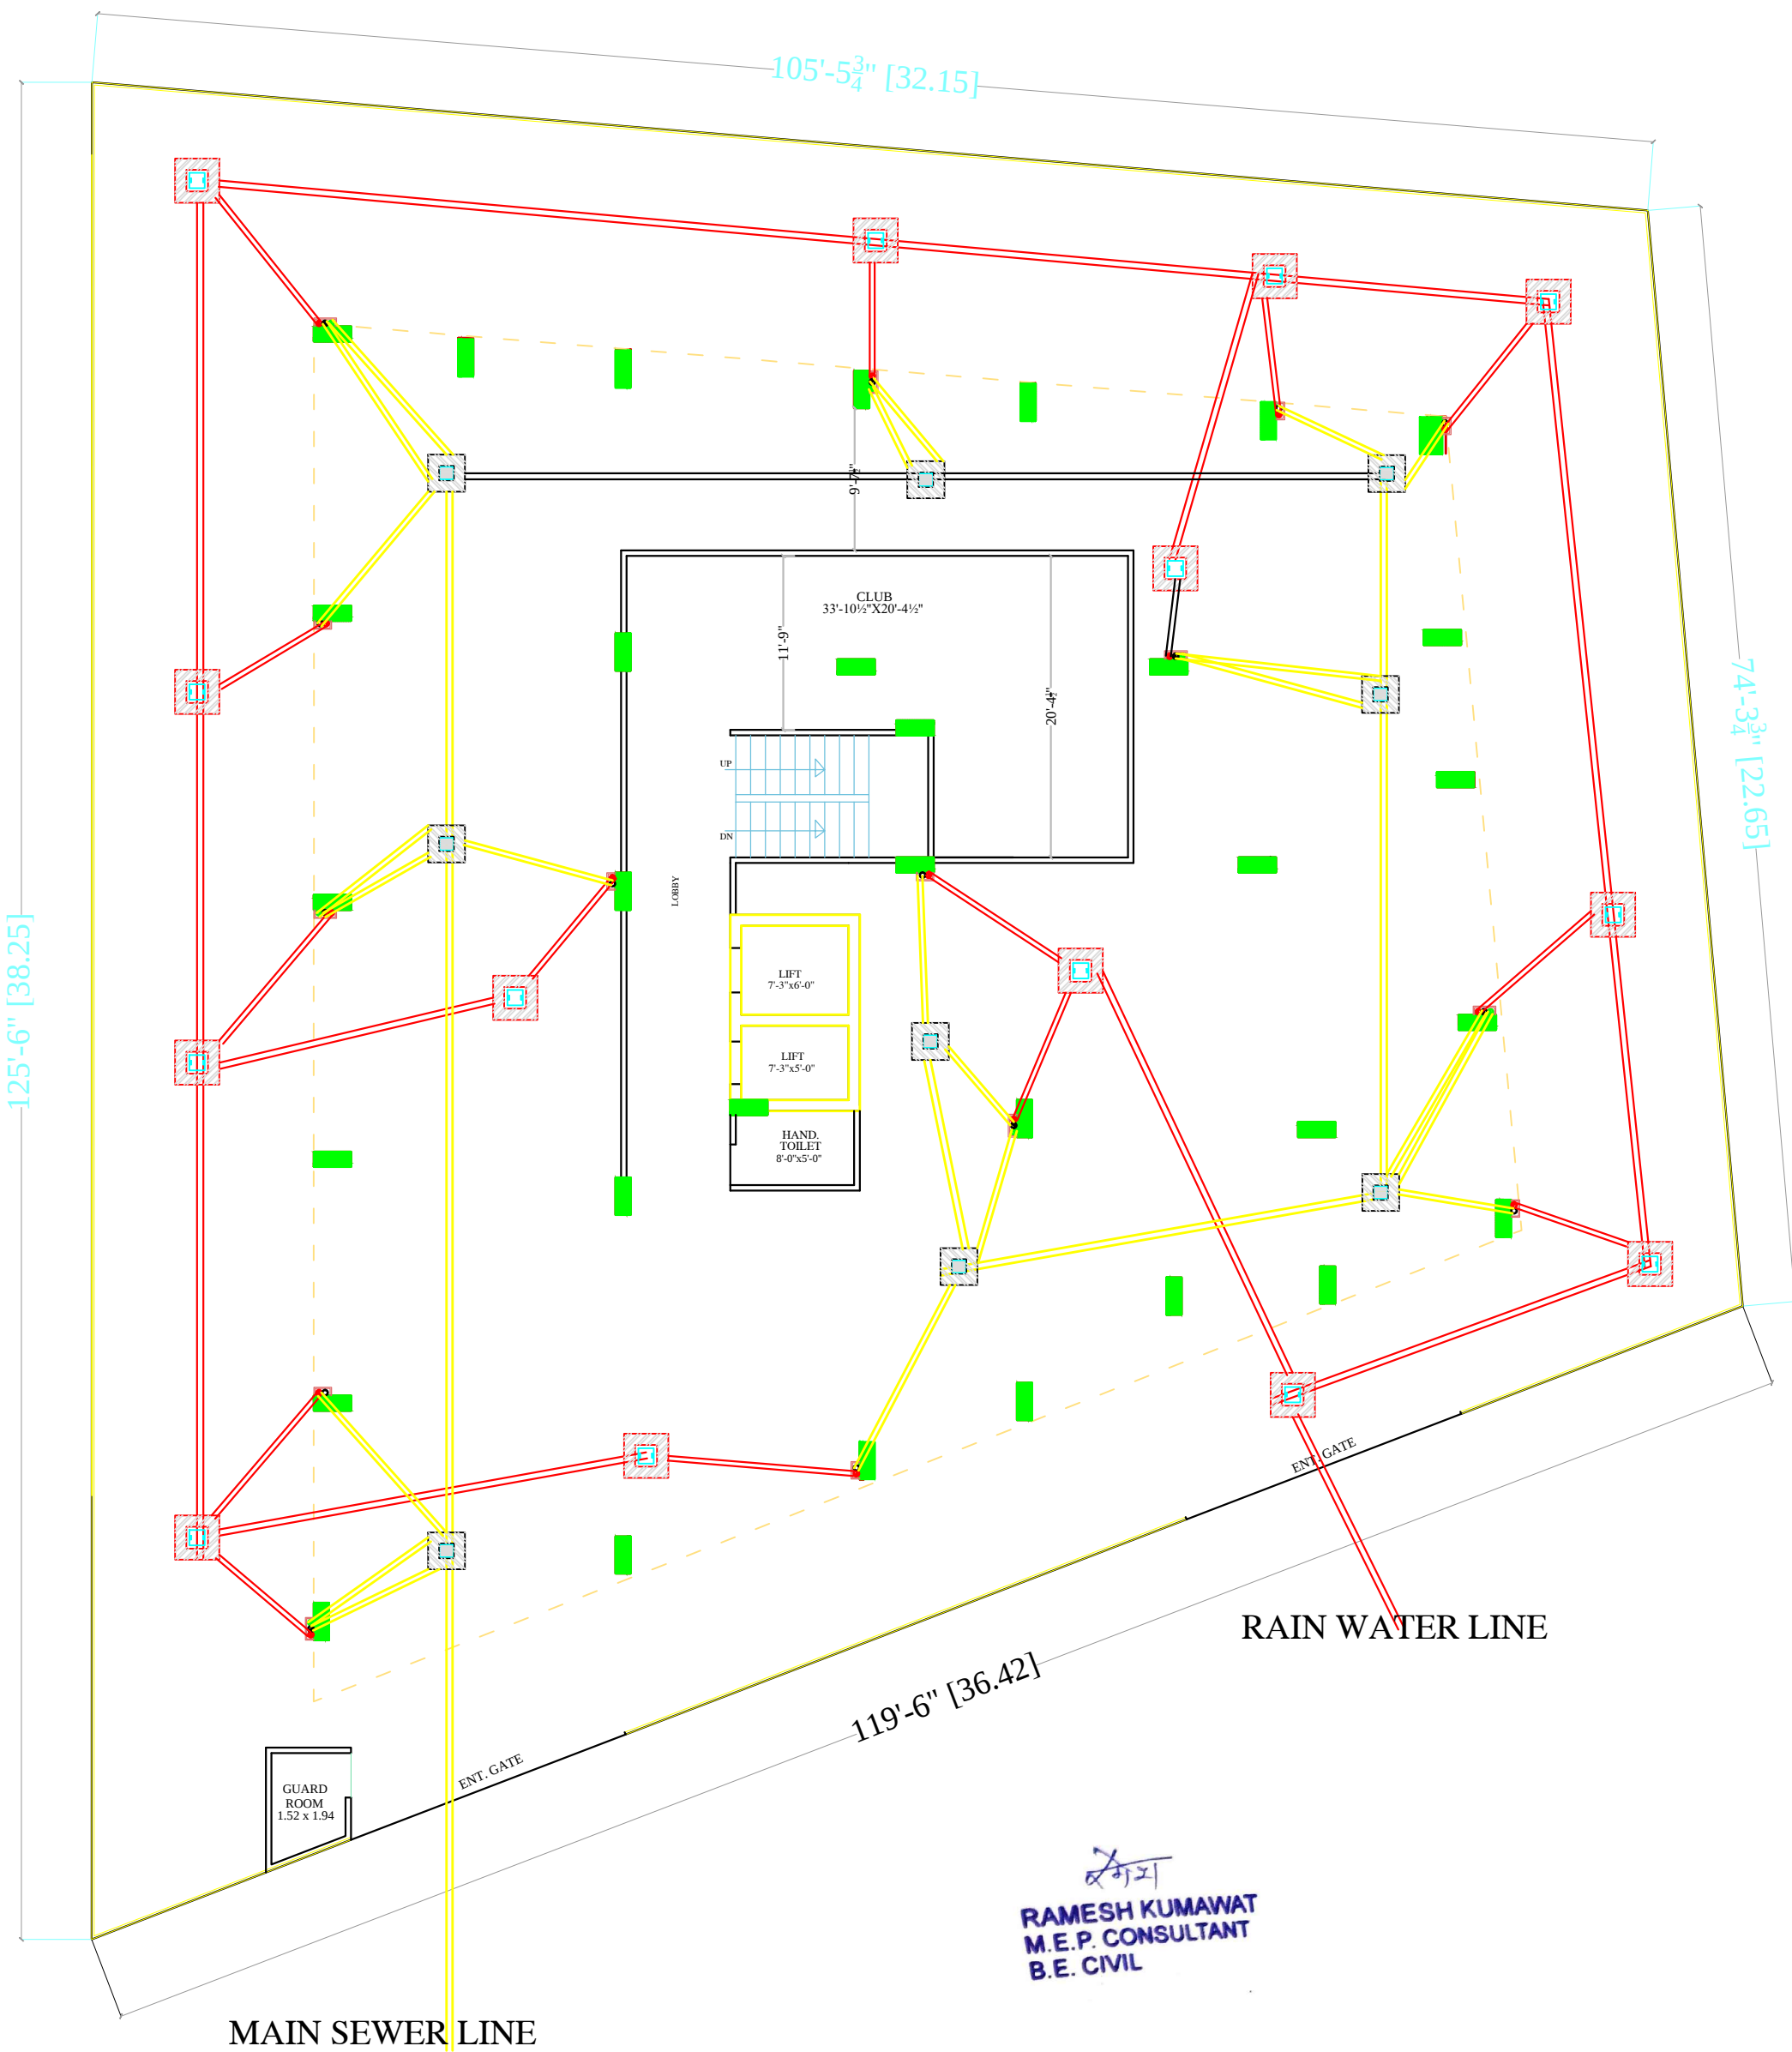

PROJECT TITLE :- PROPOSED BUILDING AT KHASRA NO. 3402/2403 & 3423/3399 IN VILLAGE SIROLI, TEHSIL SANGANER , JAIPUR	DRAWING TITLE :- STILT FLOOR WATER SUPPLY	SPACE CONSULTANT PLOT-A-173, JAGDAMBA NAGAR, HEERAPURA POWER HOWER, JAIPUR (RAJ) 302024	DRN. BY		DATE	NORTH N E S W
			APPD. BY		REVISION	
			SCALE	N.T.S		