


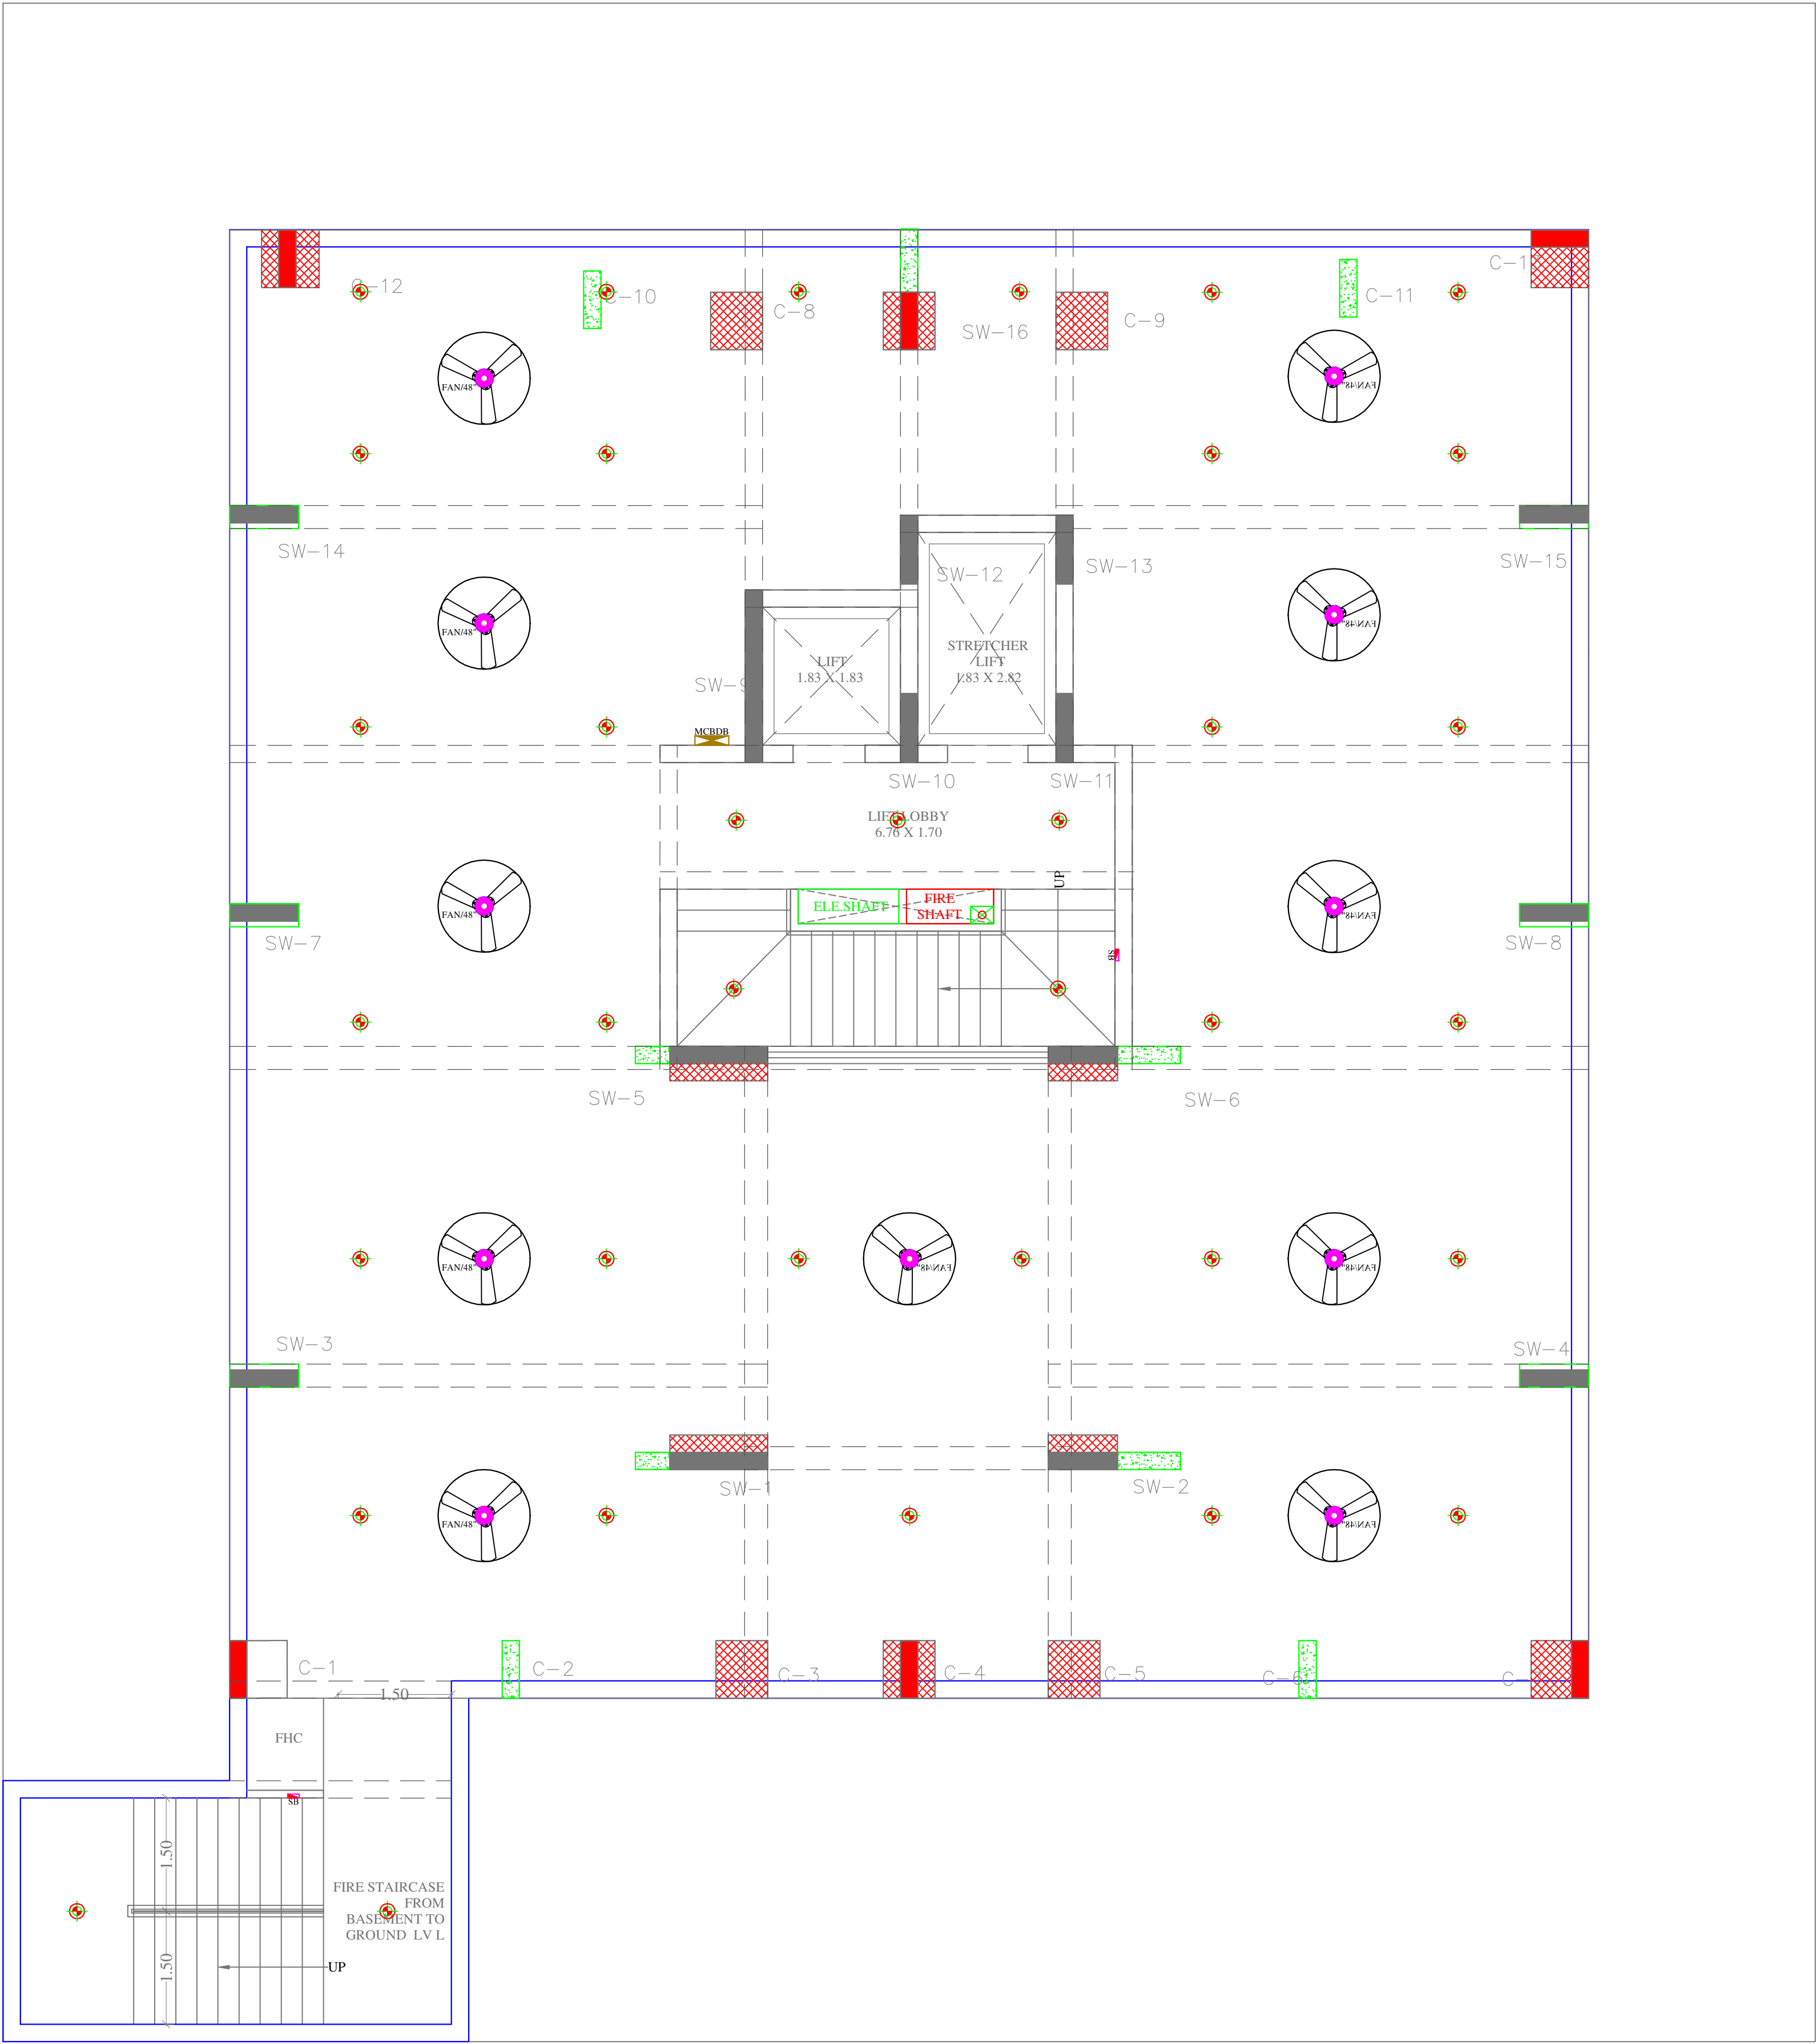


BASEMENT FLOOR

FRONT SIDE ROAD

Vipul
VIPUL AGARWAL
M.E.P. CONSULTANT
B.E. ELECTRICAL

LEGENDS:				
Mounting Height	QTY.	ID	SYMBOL	DESCRIPTION
CEILING	11	FAN48		CEILING FAN48"
CEILING	36	DL		LED 6" DOWNLIGHTER 15W (SURFACE MOUNTED) MAKE SYSKA LED CAT.NO.SDL-15W GLD 6.5K/4K
+90"		BULB		LED BULB 20W MAKE SYSKA LED CAT.NO. SKC-20W 5.7K/3K
VENTILATOR HT.		CR		CEILING ROSE
VENTILATOR HT.		EXF		9" DIA EXHAUST FAN
+42"	01	SB		SWITCH BOARD
+60"	01	MCB DB		MCB DISTRIBUTION BOARD

PROJECT TITLE :- RESIDENTIAL TOWER A KOTA, RAJASTHAN	DRAWING TITLE :- BASEMENT FLOOR ELECTRICAL POINT MARKED PLAN	SCALE OWNER :- BRIJ RAJ SINGH S/O SHRI HARI RAJ SINGH 5-G-13, MAHAVEER NAGAR -3RD, KOTA (324005)	NORTH POINT 	OWNER	ARCHITECT	SERVICE CONSULTANT ASHI ASSOCIATES F 9 / 440 , Keshav Marg Chitrakut Scheme,Jaipur PH:91-0-93146-10438 ,0141-2440946, Mail:vipul8599@yahoo.com
--	---	--	---------------------	-------	-----------	--

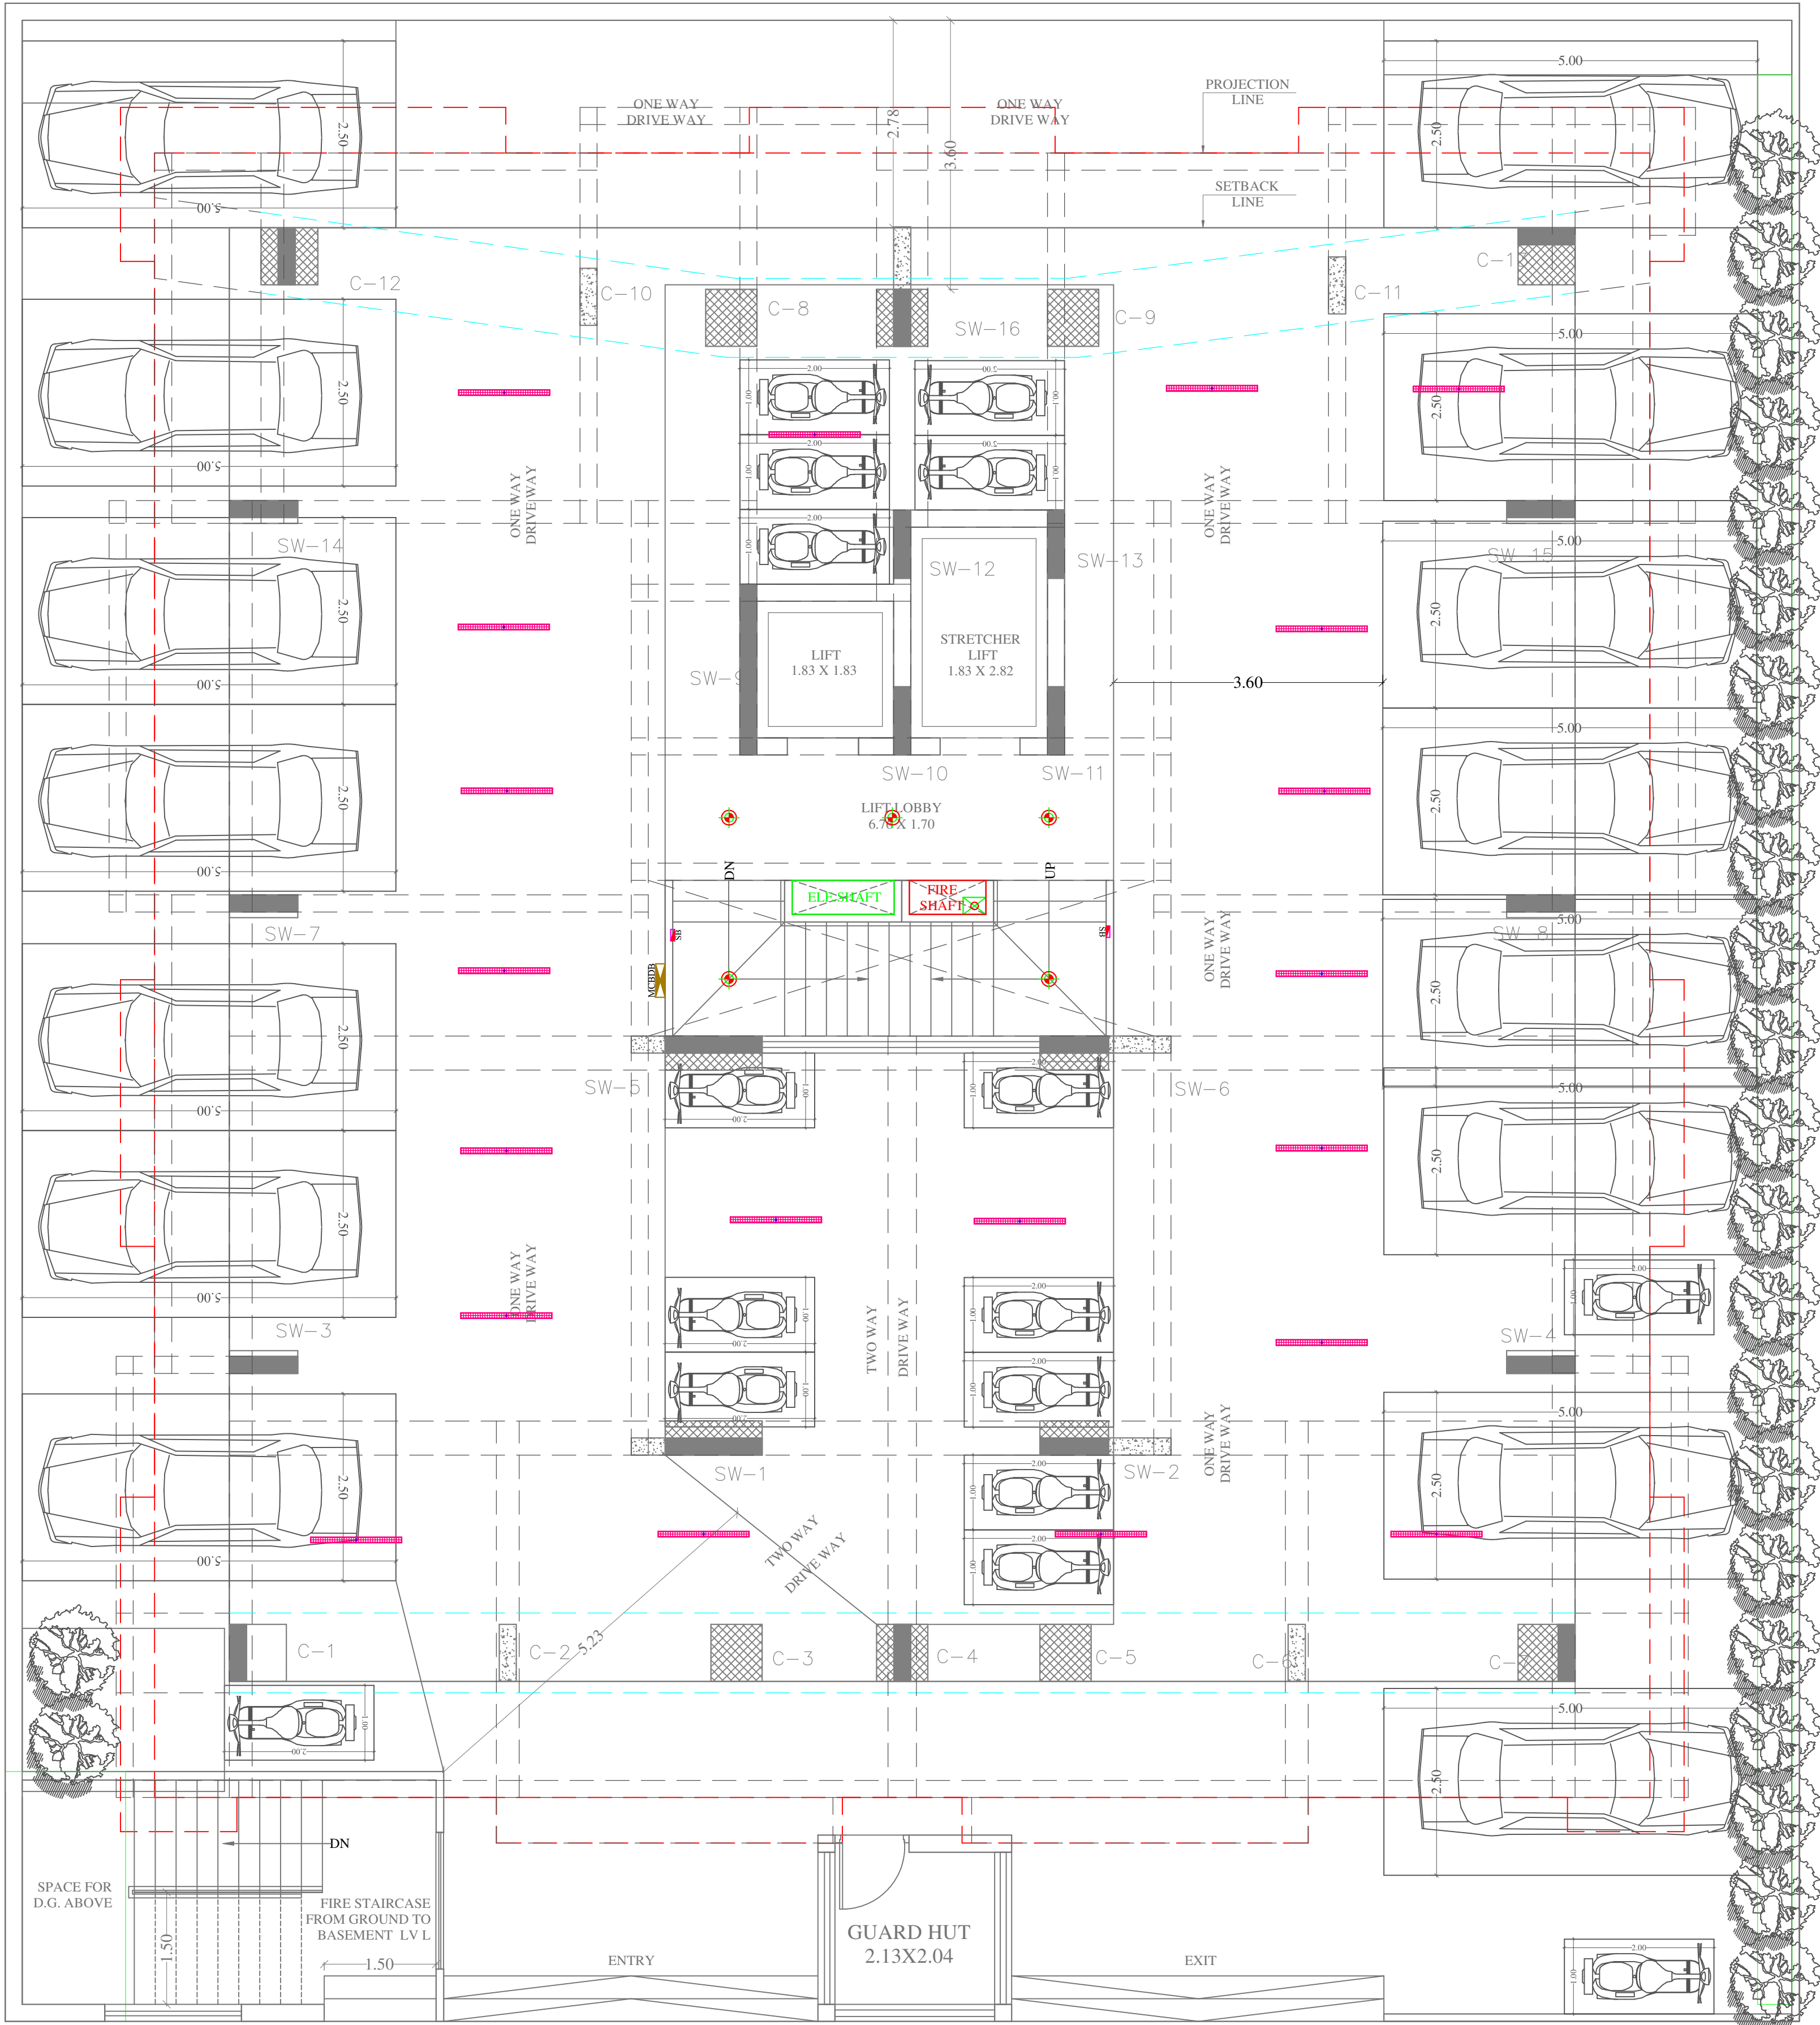


STILT FLOOR PLAN

18 M WIDE ROAD

Vipul
VIPUL AGARWAL
M.E.P. CONSULTANT
B.E. ELECTRICAL

PROJECT TITLE :- RESIDENTIAL TOWER A KOTA, RAJASTHAN	DRAWING TITLE :- STILT FLOOR ELECTRICAL POINT MARKED PLAN	SCALE 0 1 2.5 5 10 OWNER :- BRIJ RAJ SINGH S/O SHRI HARI RAJ SINGH 5-G-13, MAHAVEER NAGAR -3RD, KOTA (324005)	NORTH POINT N Nhanee DESIGN STUDIO	OWNER	ARCHITECT	SERVICE CONSULTANT ASHI ASSOCIATES F 9 / 440 , Keshav Marg Chitrakut Scheme,Jaipur PH:91-0-93146-10438 ,0141-2440946, Mail:vipul8599@yahoo.com

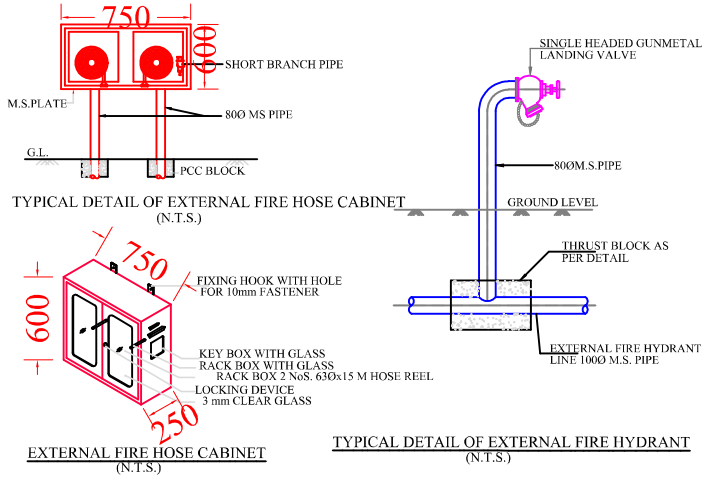

LEGENDS:				
Mounting Height	QTY.	ID	SYMBOL	DESCRIPTION
CEILING	05	DL		LED 6" DOWNLIGHTER (SW SURFACE MOUNTED) MAKE SYSKA LED CAT NO SDL-15W GLD
CEILING	20	TLAC		MAKE SYSKA LED CAT NO. SSK-15-20W
+42"	02	SB		SWITCH BOARD
+60"	01	MCB DB		MCB DISTRIBUTION BOARD